

Tourism Sector Development Project
in the Hashemite Kingdom of Jordan

The Government of
the Hashemite Kingdom of Jordan
The Ministry of Tourism and Antiquities
The Ministry of Planning

Sub-Project:
Amman Downtown
Tourist Zone Development

Note:
• The detailed design has been executed by a team of consultants as shown below in accordance with the agreement between Japan International Cooperation Agency (JICA) and JICA Study Team.
• The copyright of this drawing rests with JICA.

Designed by:
Japan International Cooperation Agency (JICA)


JICA Study Team:
Joint Venture of
Pacific Consultants International and
Yamashita Seki & Inc.

Subcontracted Local Consultant:
TIBAH Consultants
Architects, Engineers

Raghadan Bus Terminal

Drawing Title:
COLD WATER & FIRE FIGHTING
FOR SECOND FLOOR ZONE 1

Scale: 1/100
Drawing No: RBT .M402

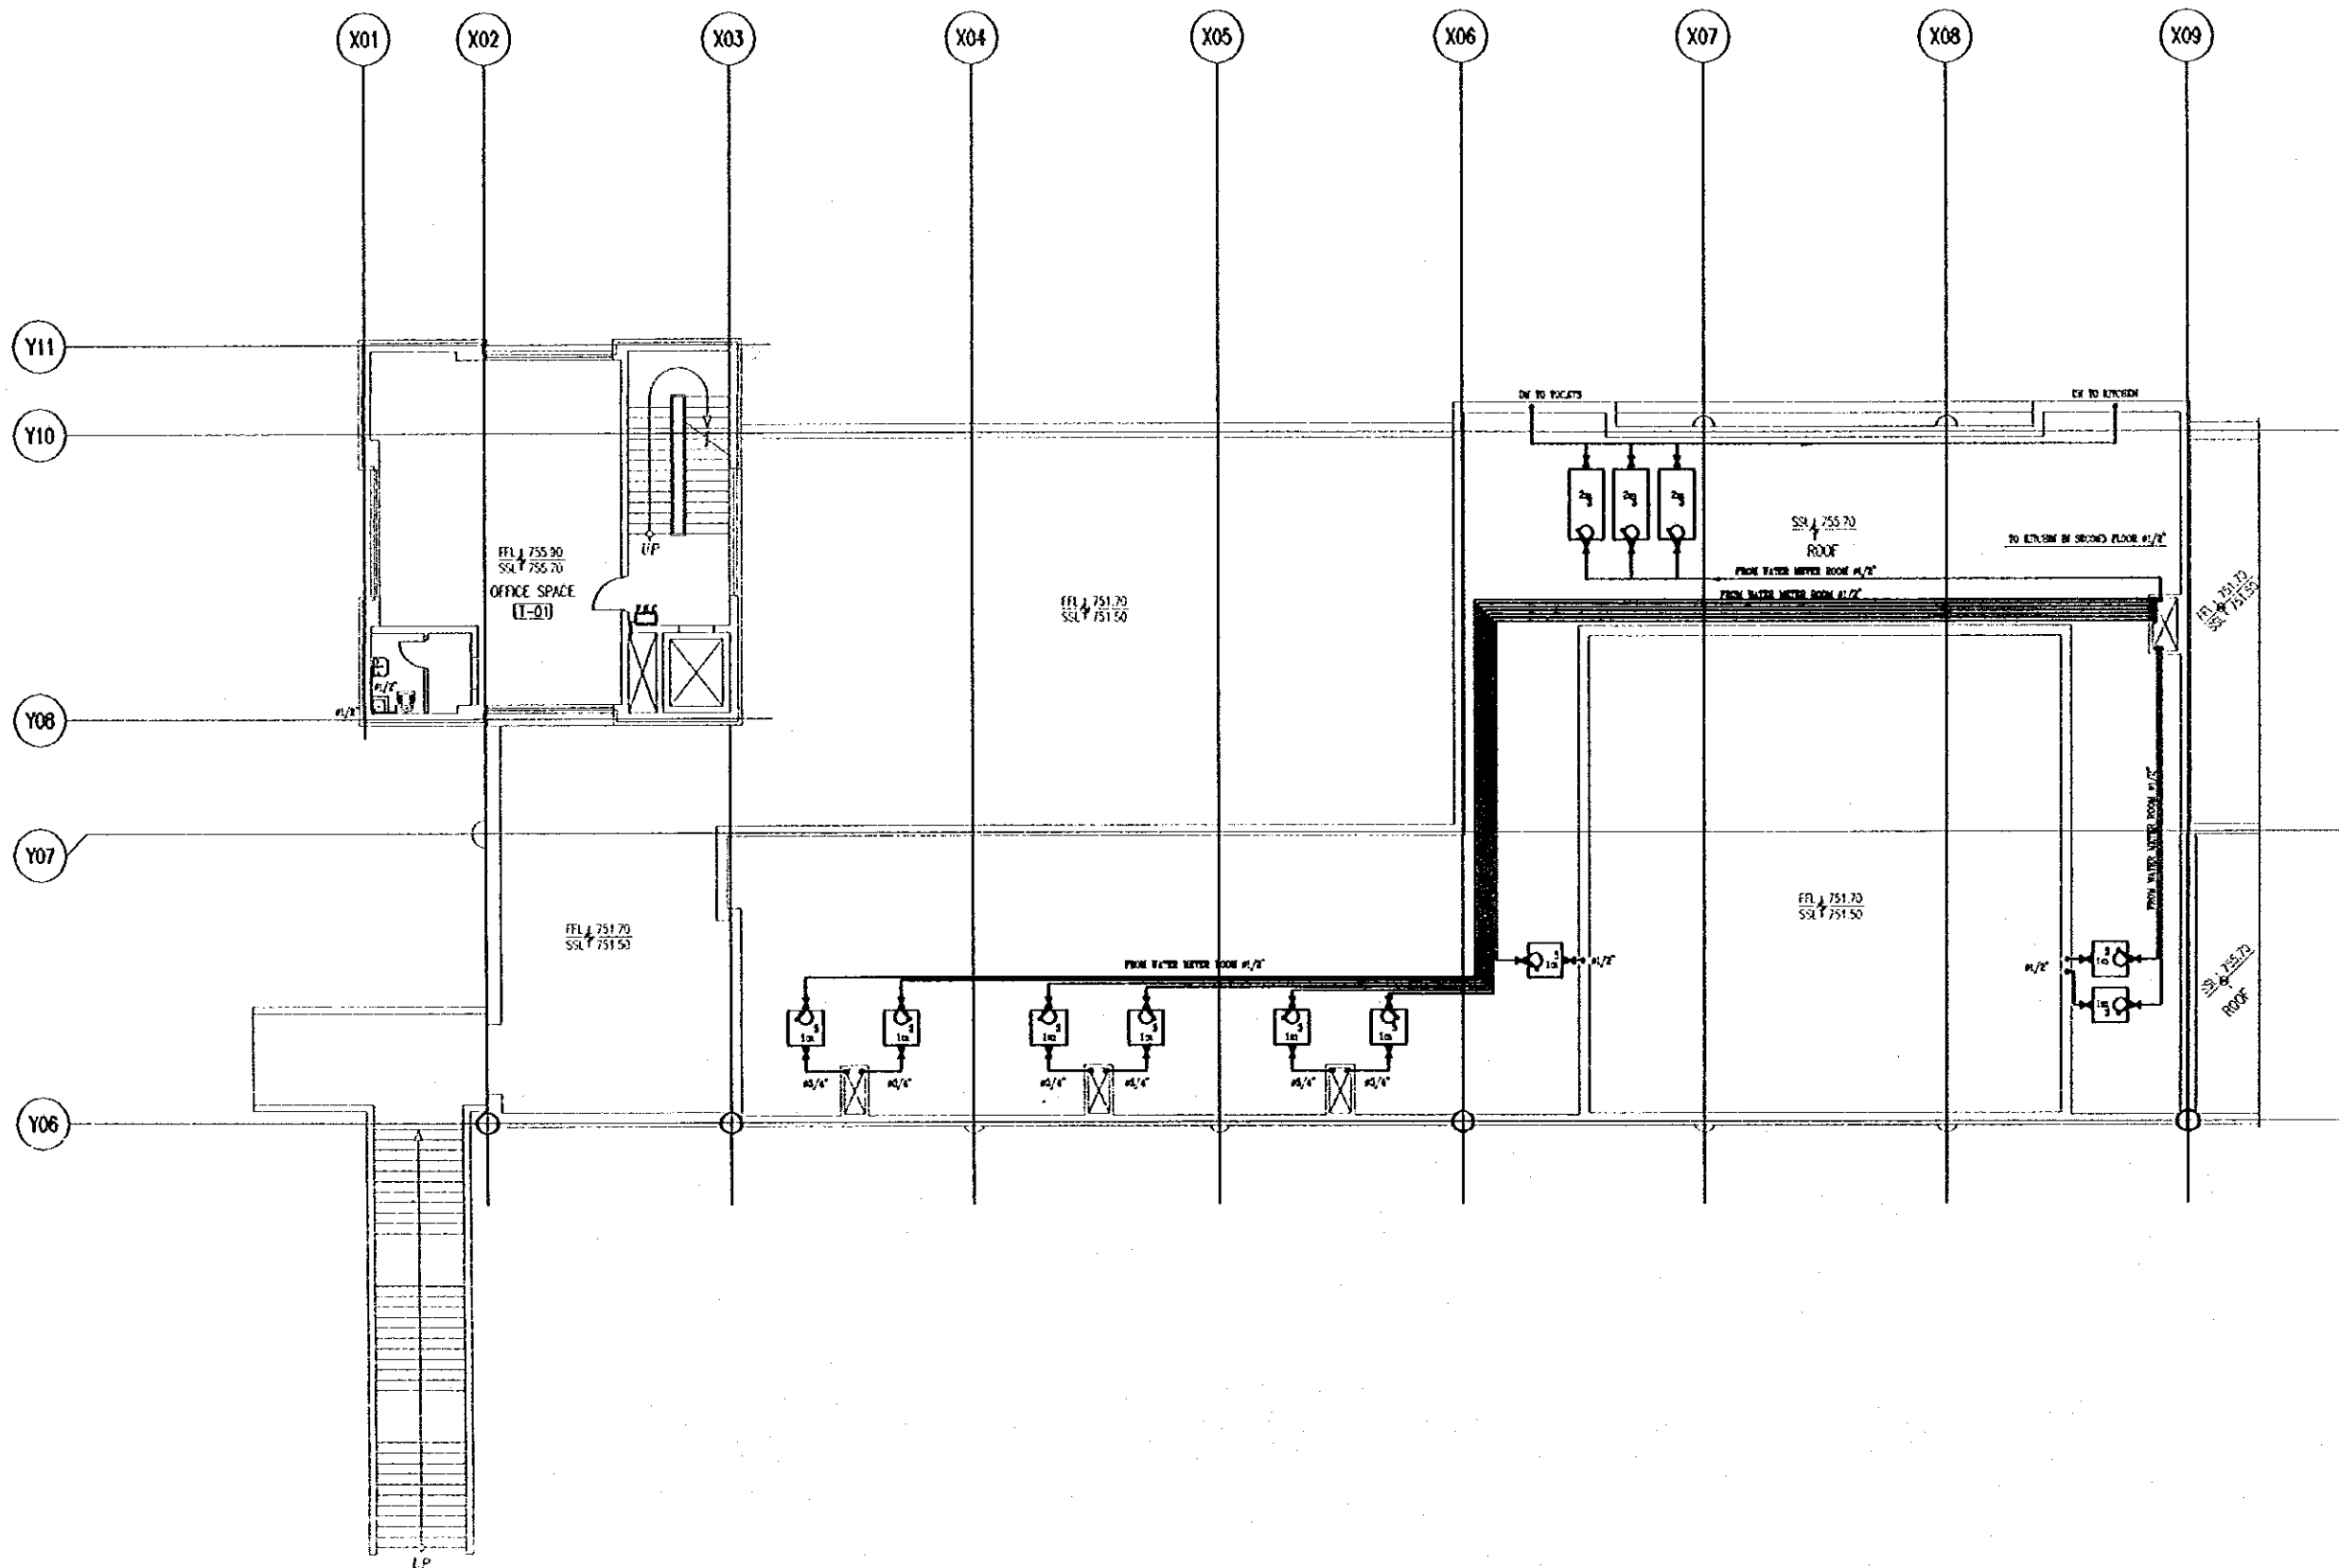

The Government of
the Hashemite Kingdom of Jordan
The Ministry of Tourism and Antiquities
The Ministry of Planning

Sub-Project:
Amman Downtown
Tourist Zone Development



Note:
• This detailed design has been executed by a team of consultants as shown below in accordance with the agreement between Japan International Cooperation Agency (JICA) and JICA Study Team.
• The copyright of this drawing rests with JICA.

Designed by:
Japan International Cooperation Agency (JICA)
JICA Study Team:
Joint Venture of
Pacific Consultants International and
Yamasa Sekkei Inc.
Subcontracted Local Consultant:
TBAH Consultants
Architects, Engineers


Raghadan Bus Terminal
Drawing Title:
**COLD WATER & FIRE FIGHTING
FOR THIRD FLOOR ZONE 1**

Scale: 1/100 Drawing No: RBT .M403

Notes:
 • This detailed design has been executed by a team of consultants as shown below in accordance with the agreement between Japan International Cooperation Agency (JICA) and JICA Study Team.
 • The copyright of this drawing rests with JICA.

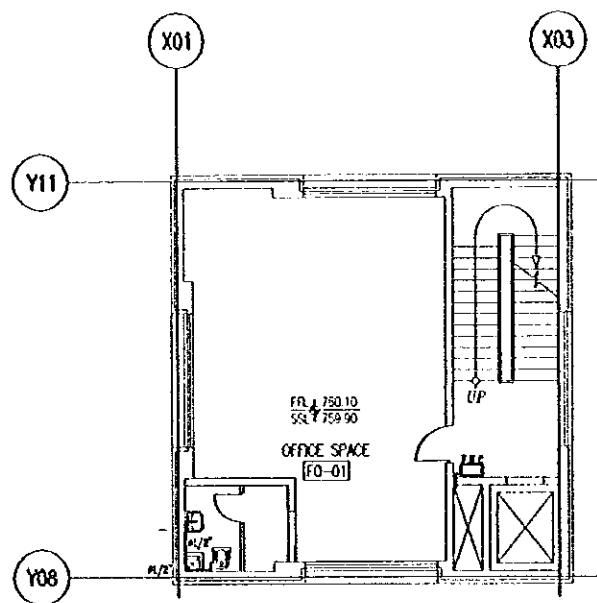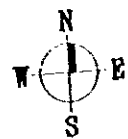

Z1
FOURTH FLOOR PLAN

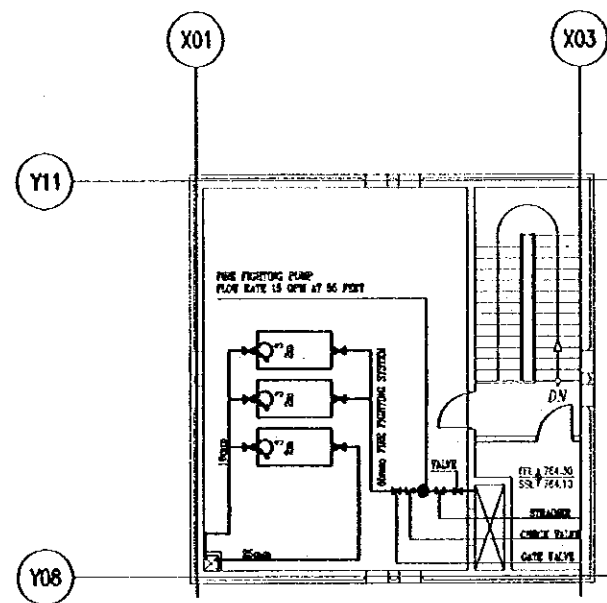

Z1
FIFTH FLOOR PLAN

Designed by:

Japan International Cooperation Agency
(JICA)

JICA Study Team:

Joint Venture of
Pacific Consultants International and
Yamashita Sekkei Inc.

Subcontracted Local Consultant:

TIBAH Consultants
Architects, Engineers

مهندسين معماريين
مهندسين ميكانيكيين




Raghadan Bus Terminal

Drawing Title:
COLD WATER & FIRE FIGHTING
FOR MANAGEMENT TOWER
ZONE 1

Scale:
1/100

Drawing No:
RBT .M404

Note:
- This detailed design has been executed by a team of
consultants as shown below in accordance with the agreement
between Japan International Cooperation Agency (JICA) and
JICA Study Team.
- The copyright of this drawing rests with JICA.

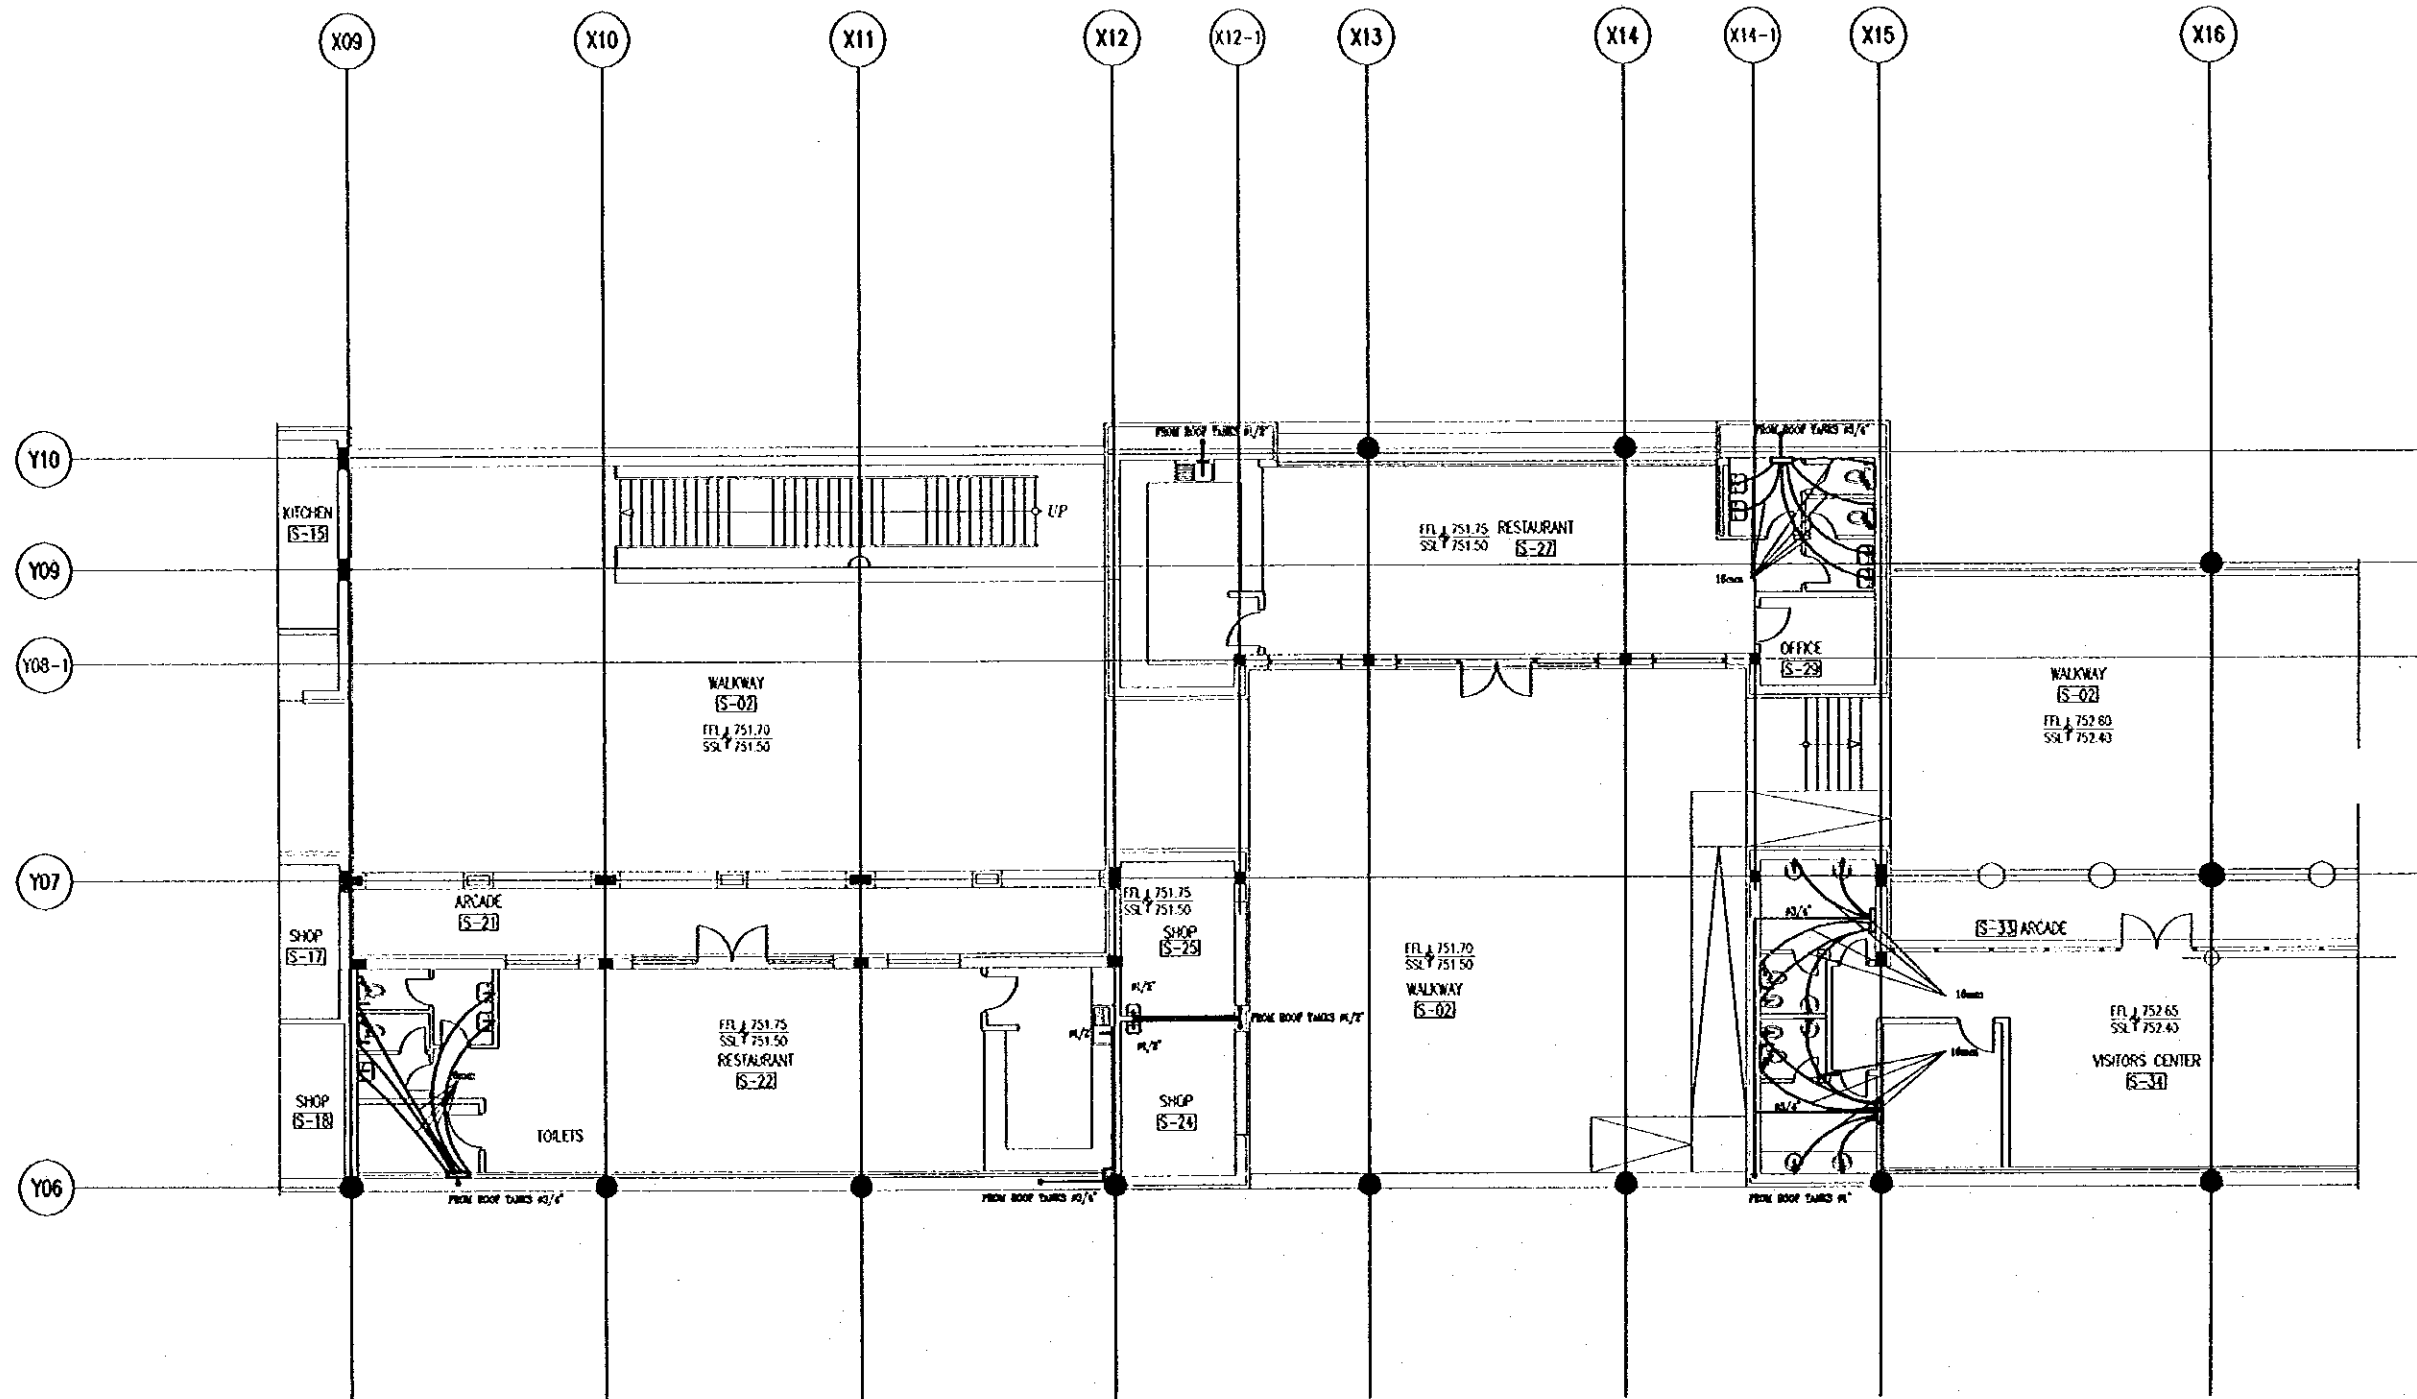

Designed by:
Japan International Cooperation Agency
(JICA)
JICA Study Team:
Joint Venture of
Pacific Consultants International and
Yamato Sekkei Inc.
Subcontracted Local Consultant:
TMAH Consultants
Architects, Engineers


Raghadan Bus Terminal
Drawing Title:
**COLD WATER SYSTEM
FOR SECOND FLOOR ZONE 2**
Scale: 1/100 Drawing No: RBT.M406

Tourism Sector Development Project
in the Hashemite Kingdom of Jordan

The Government of
the Hashemite Kingdom of Jordan
The Ministry of Tourism and Antiquities
The Ministry of Planning

Sub-Project:
Amman Downtown
Tourist Zone Development

Note:
• This detailed design has been executed by a team of
consultants as shown below in accordance with the agreement
between Japan International Cooperation Agency (JICA) and
JICA Study Team.
• The copyright of this drawing rests with JICA.

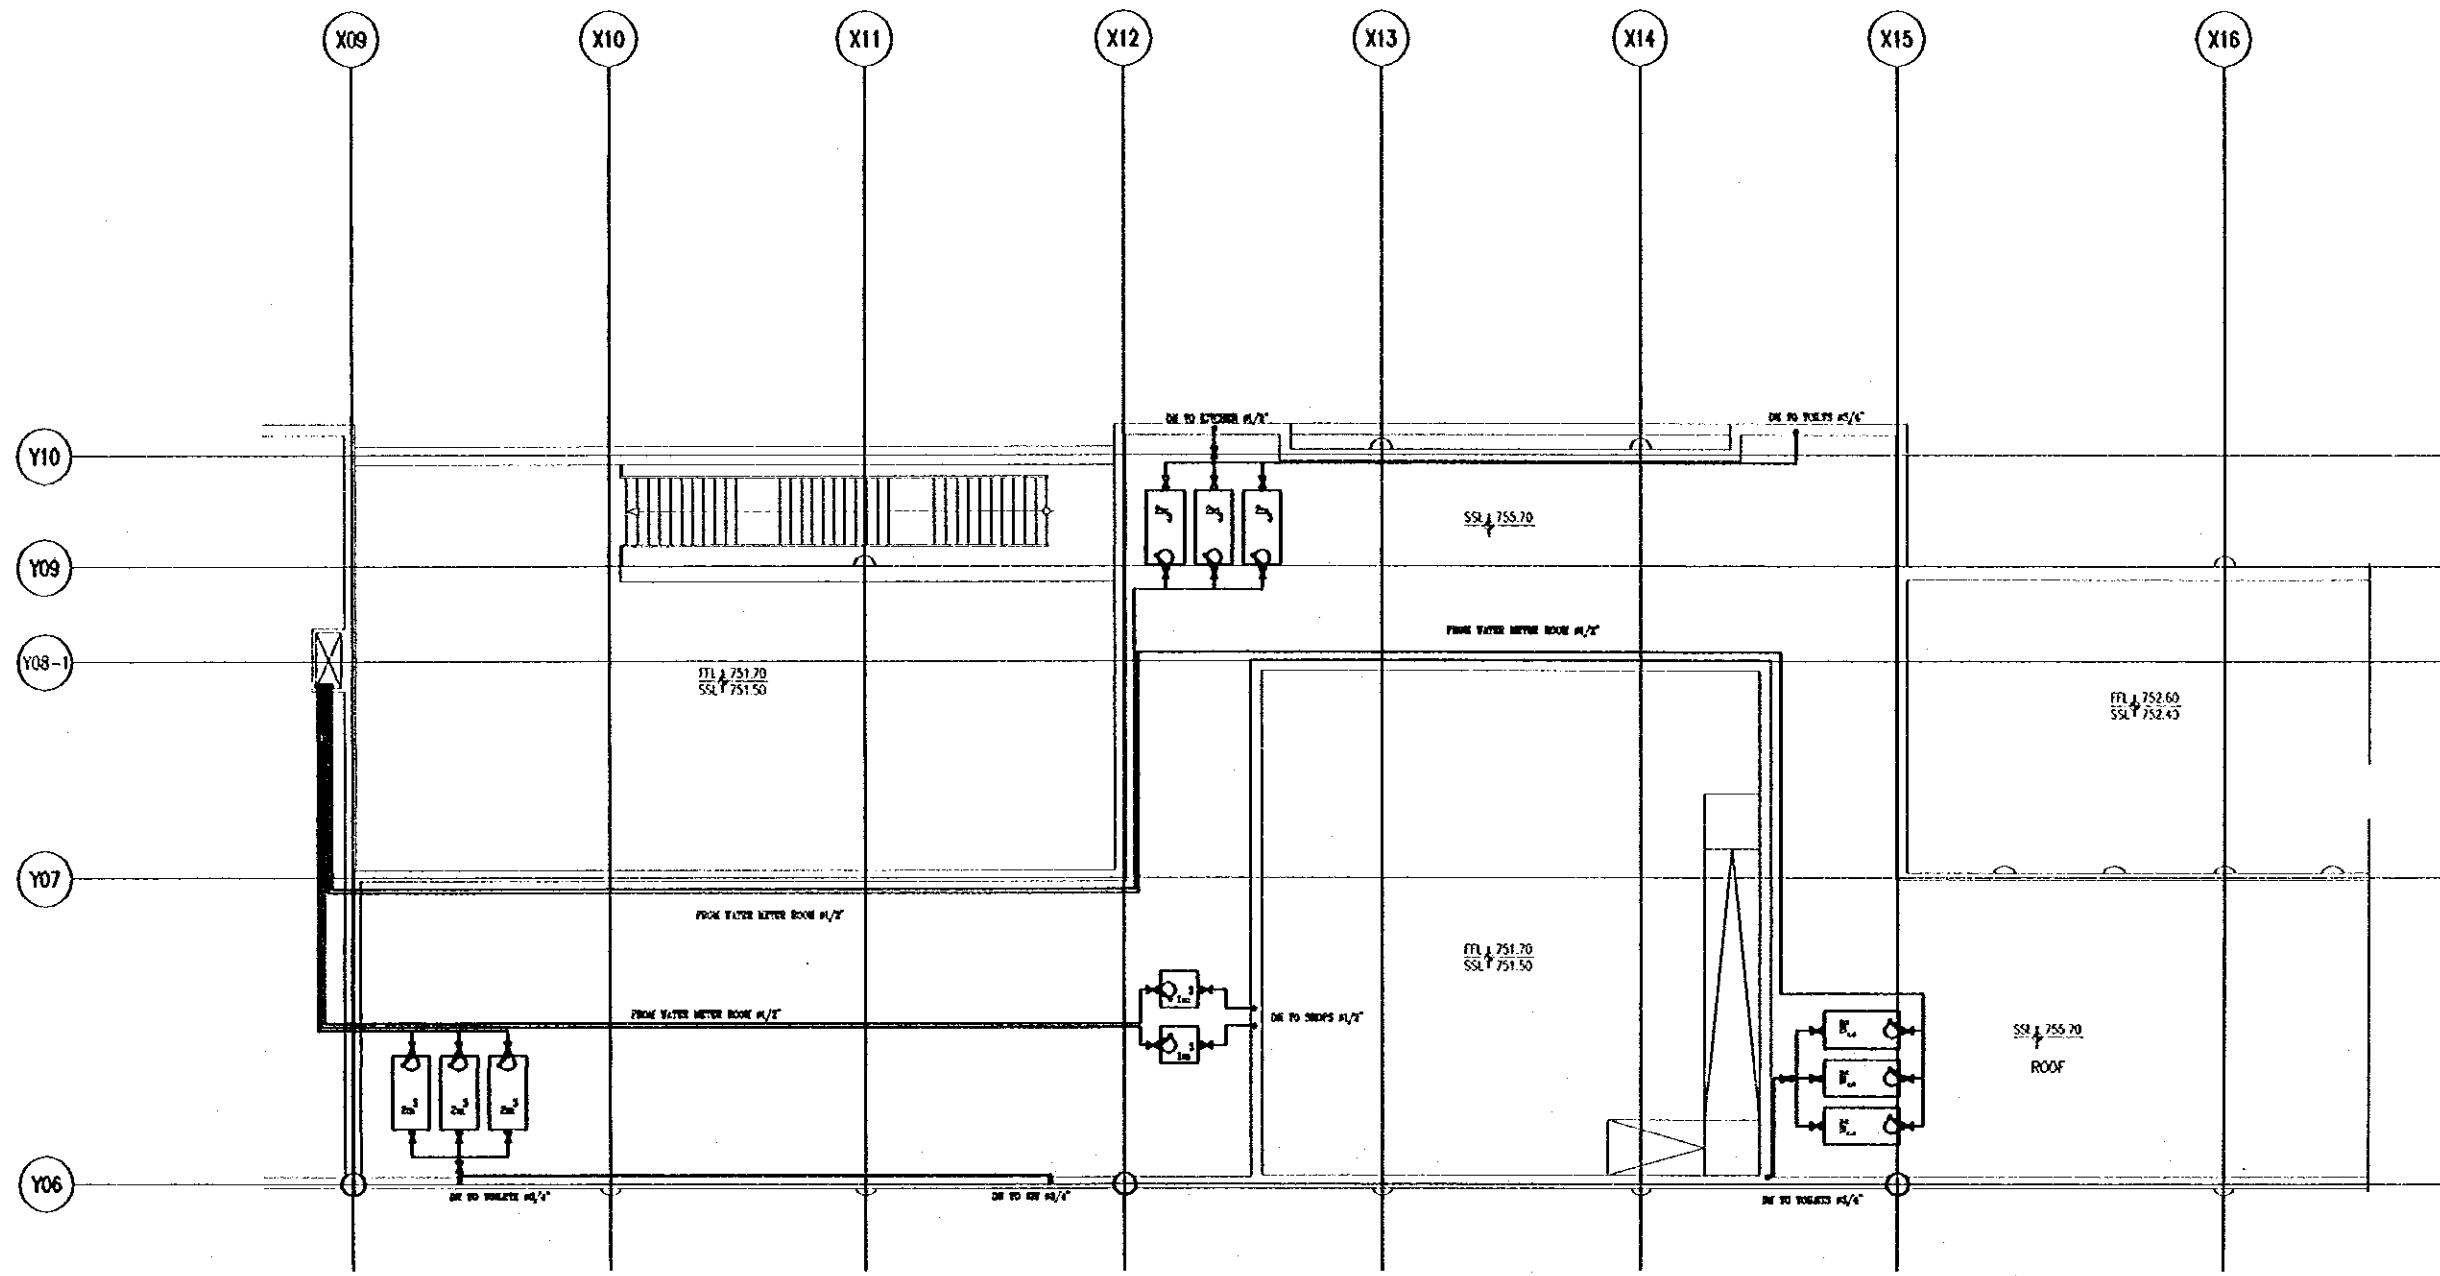

Designed by:
Japan International Cooperation Agency
(JICA)
JICA Study Team:
Joint Venture of
Pacific Consultants International and
Yomoto Seikai Inc.
Subcontracted Local Consultant:
IBAH Consultants
Architects, Engineers

Raghadan Bus Terminal
Drawing Title:
COLD WATER SYSTEM
FOR THIRD FLOOR ZONE 2

Scale: 1/100
Drawing No: RBT .M407


Tourism Sector Development Project
in the Hashemite Kingdom of Jordan

The Government of
the Hashemite Kingdom of Jordan
The Ministry of Tourism and Antiquities
The Ministry of Planning

Sub-Project:
Amman Downtown
Tourist Zone Development


Note:
• This detailed design has been executed by a team of
consultants as shown below in accordance with the agreement
between Japan International Cooperation Agency (JICA) and
JICA Study Team.
• The copyright of this drawing rests with JICA.

NOTE:-
H.L. :- HIGH LEVEL
U.G. :- UNDER GROUND
G.L.P. :- GALVANISED LINE PIPE

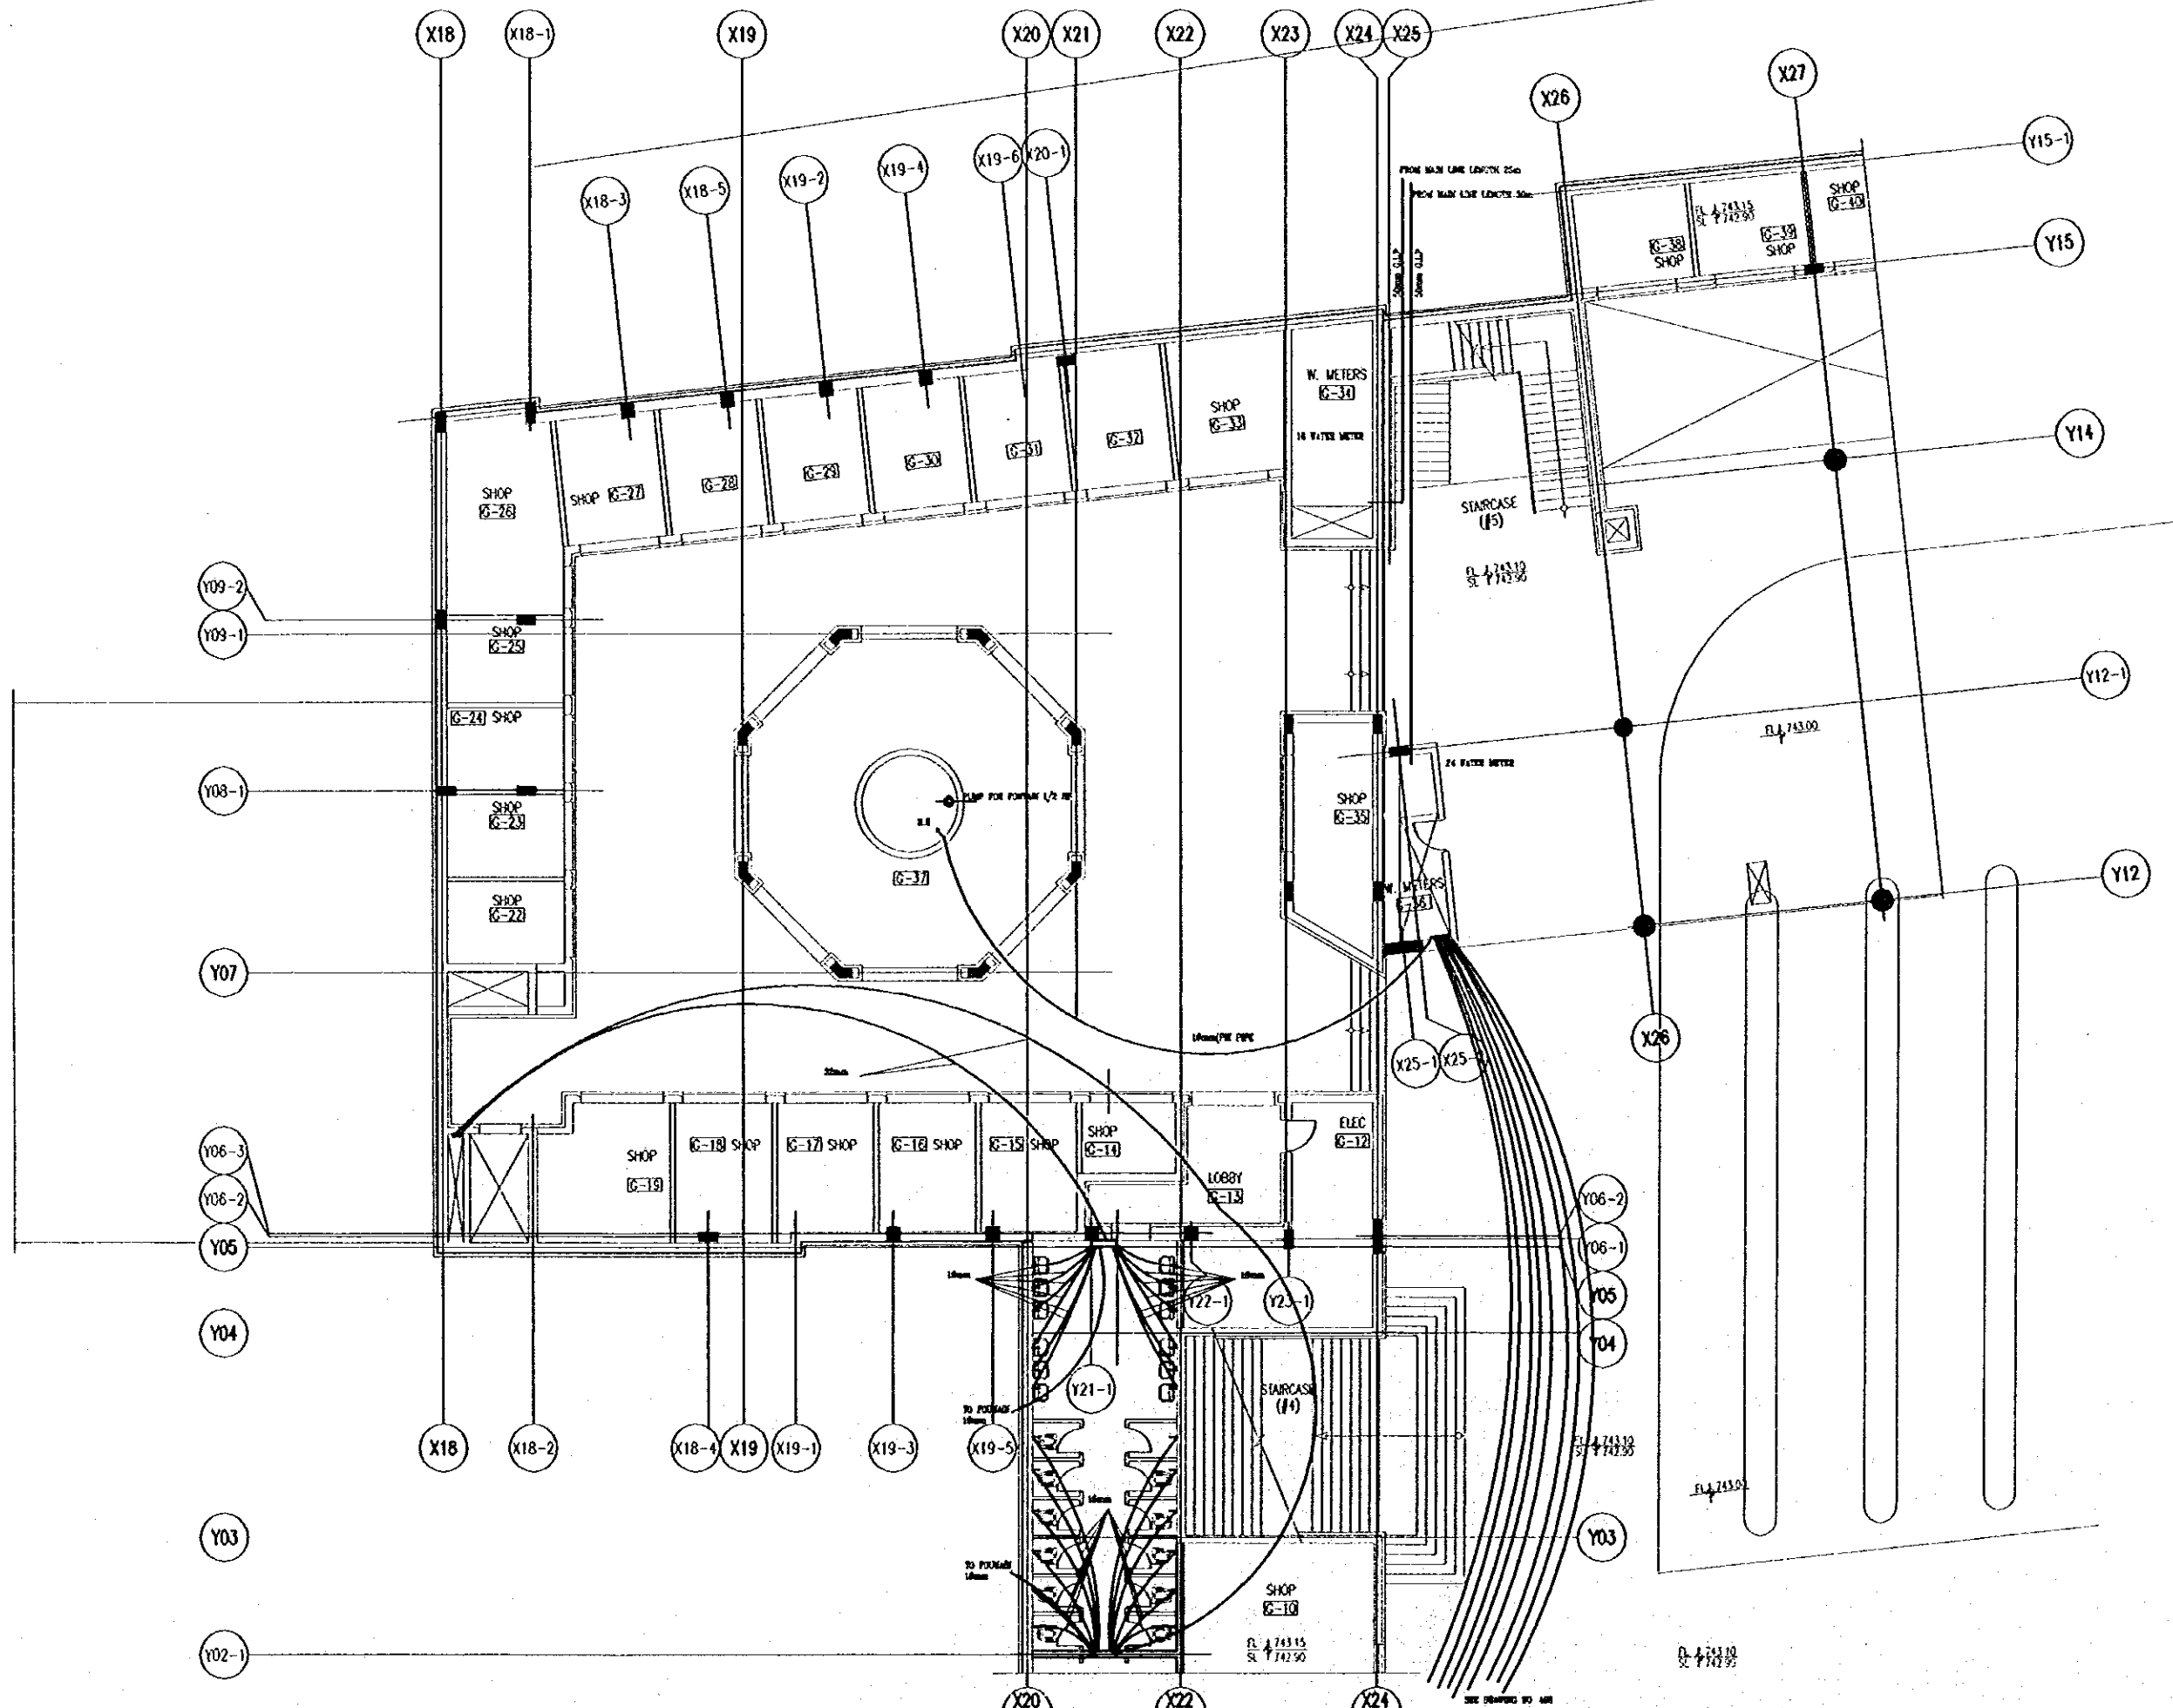

Designed by:
Japan International Cooperation Agency
(JICA)
JICA Study Team:
Joint Venture of
Pacific Consultants International and
Yamato Sekkei Inc.
Subcontracted Local Consultant:
TMAH Consultants
Architects, Engineers

Raghadan Bus Terminal
Drawing Title:
COLD WATER SYSTEM
FOR GROUND FLOOR ZONE 3
Scale: 1/100
Drawing No: RBT ,M408

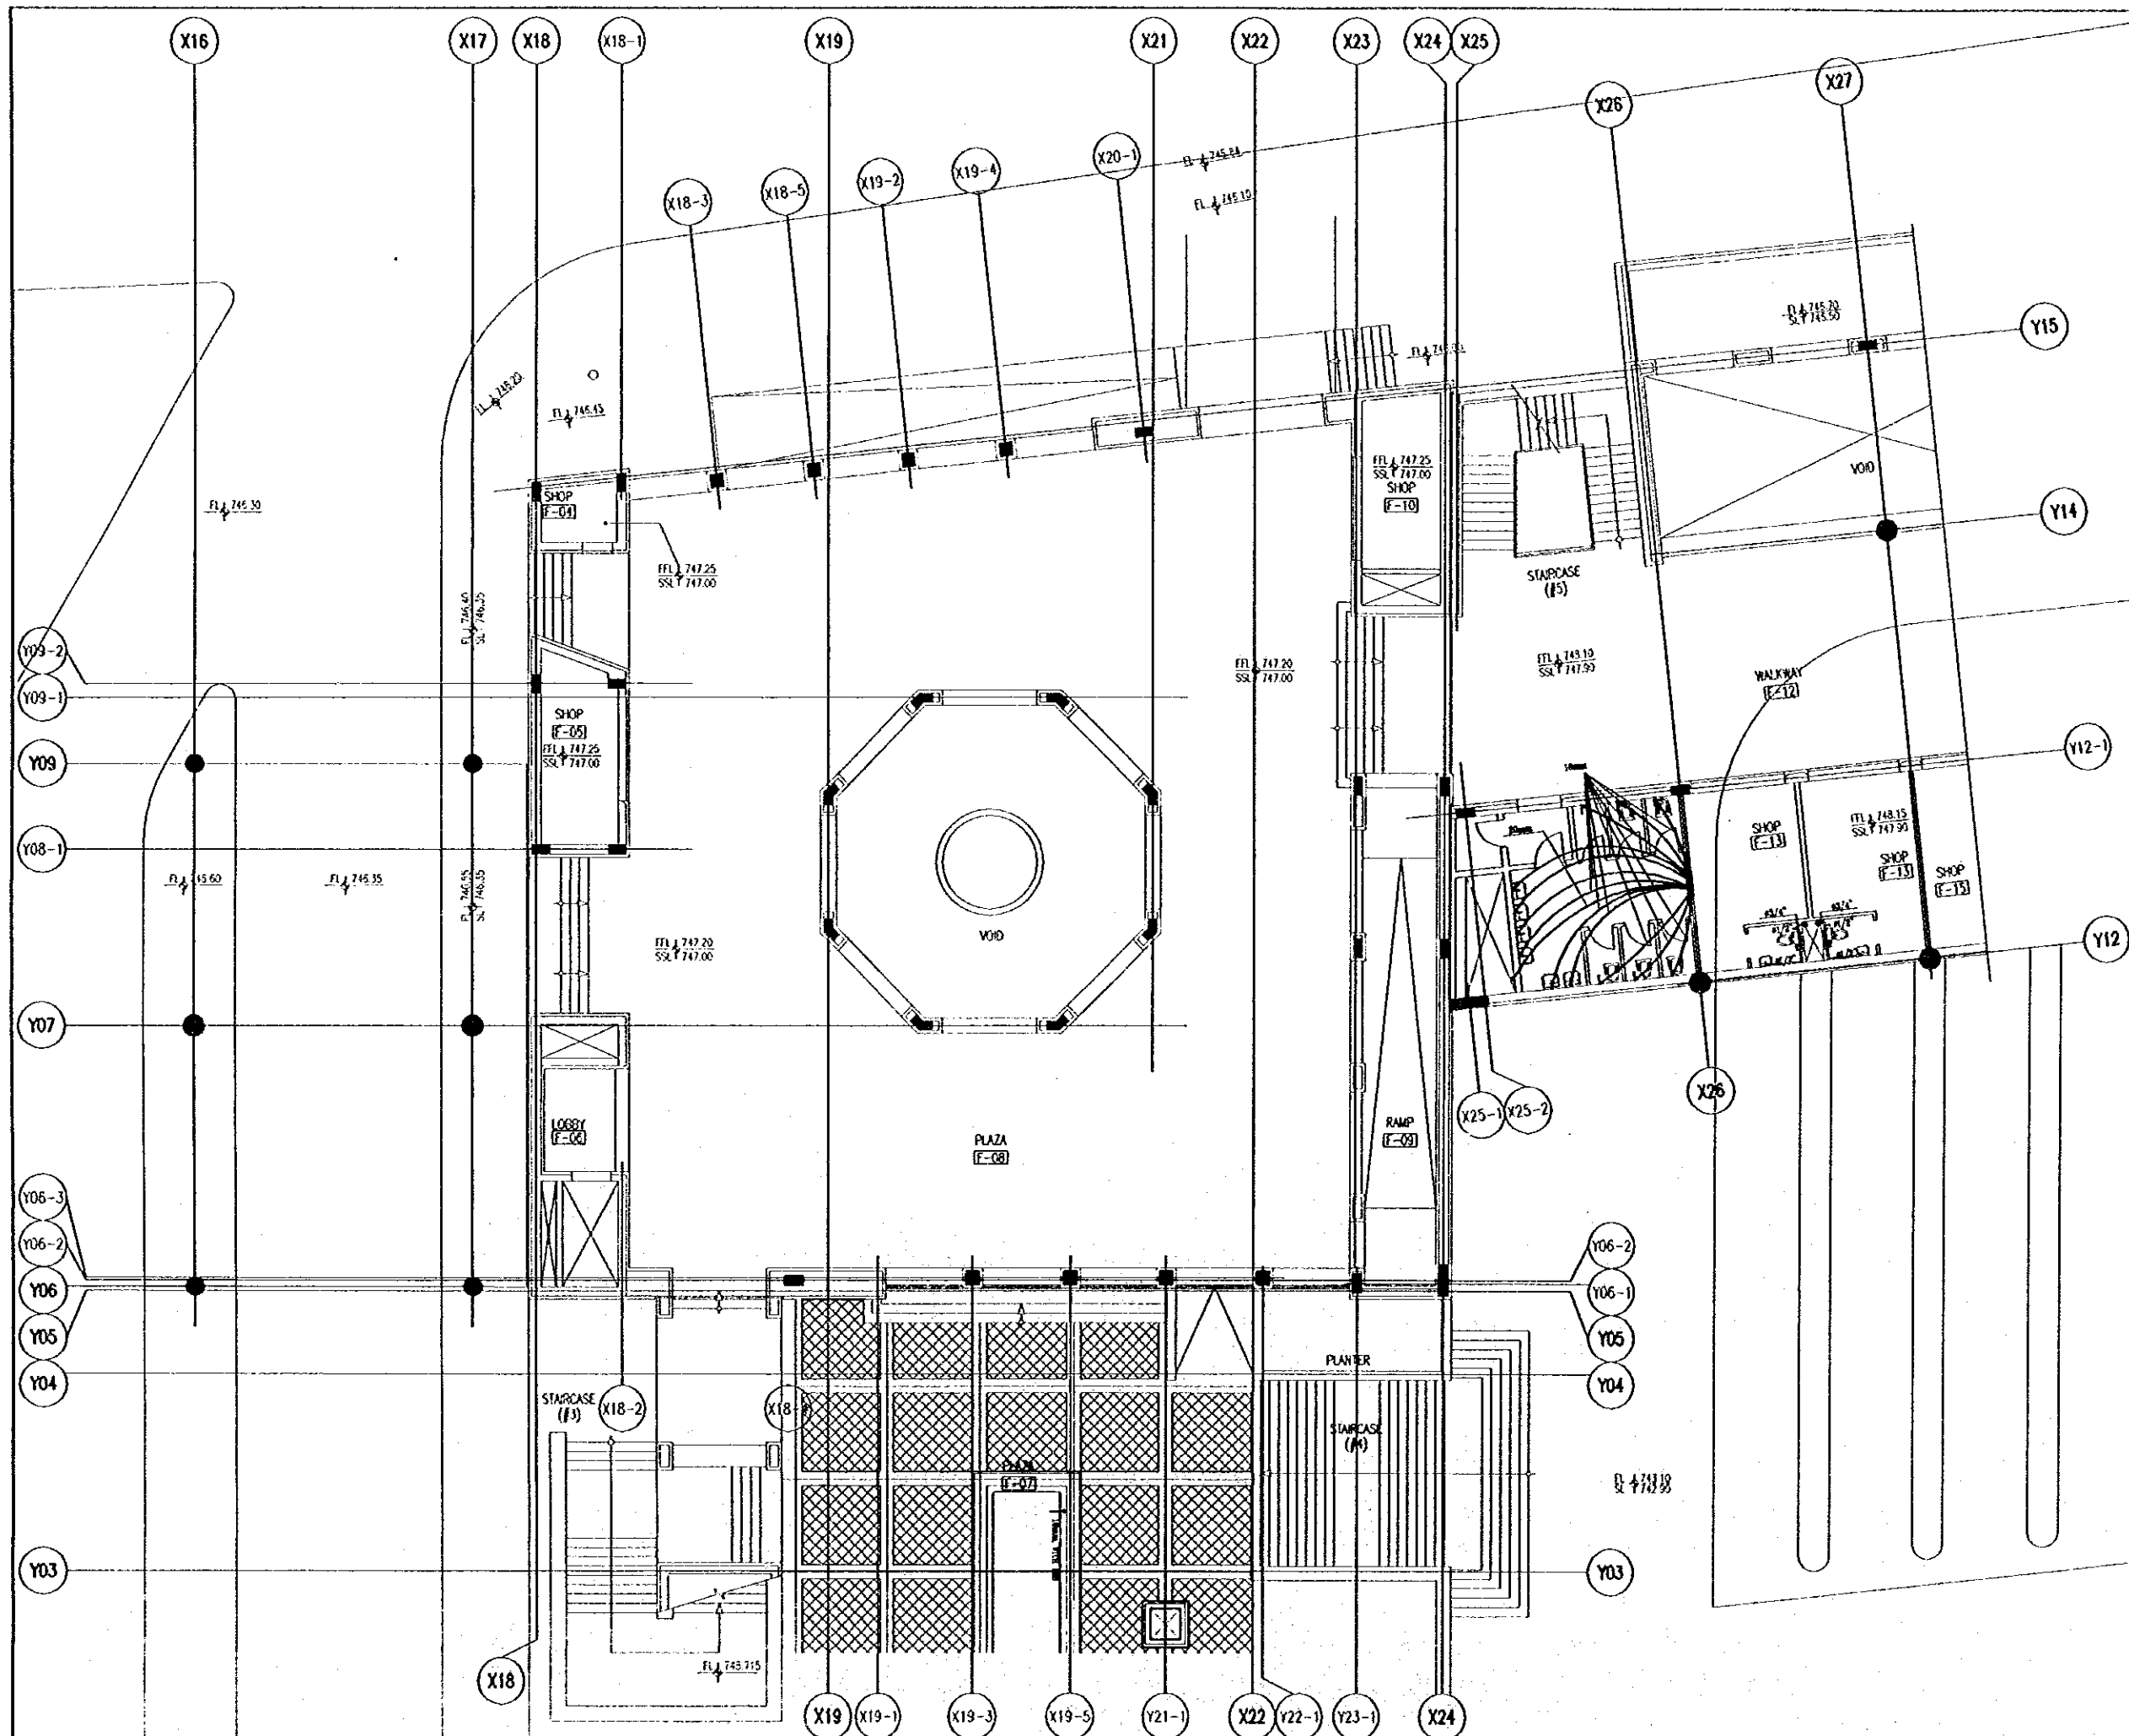

Tourism Sector Development Project
in the Hashemite Kingdom of Jordan

The Government of
the Hashemite Kingdom of Jordan
The Ministry of Tourism and Antiquities
The Ministry of Planning

Sub-Project:
Amman Downtown
Tourist Zone Development

Note:
• This detailed design has been executed by a team of consultants as shown below in accordance with the agreement between Japan International Cooperation Agency (JICA) and JICA Study Team.
• The copyright of this drawing rests with JICA.

Designed by:
Japan International Cooperation Agency (JICA)


JICA Study Team:
Joint Venture of
Pacific Consultants International and
Yamashita Sekkei Inc.

Subcontracted Local Consultant:
TMAH Consultants
Architects, Engineers

Raghadan Bus Terminal

Drawing Title:
**COLD WATER SYSTEM
FOR FIRST FLOOR ZONE 3**

Scale: 1/100 Drawing No.: RBT.M409

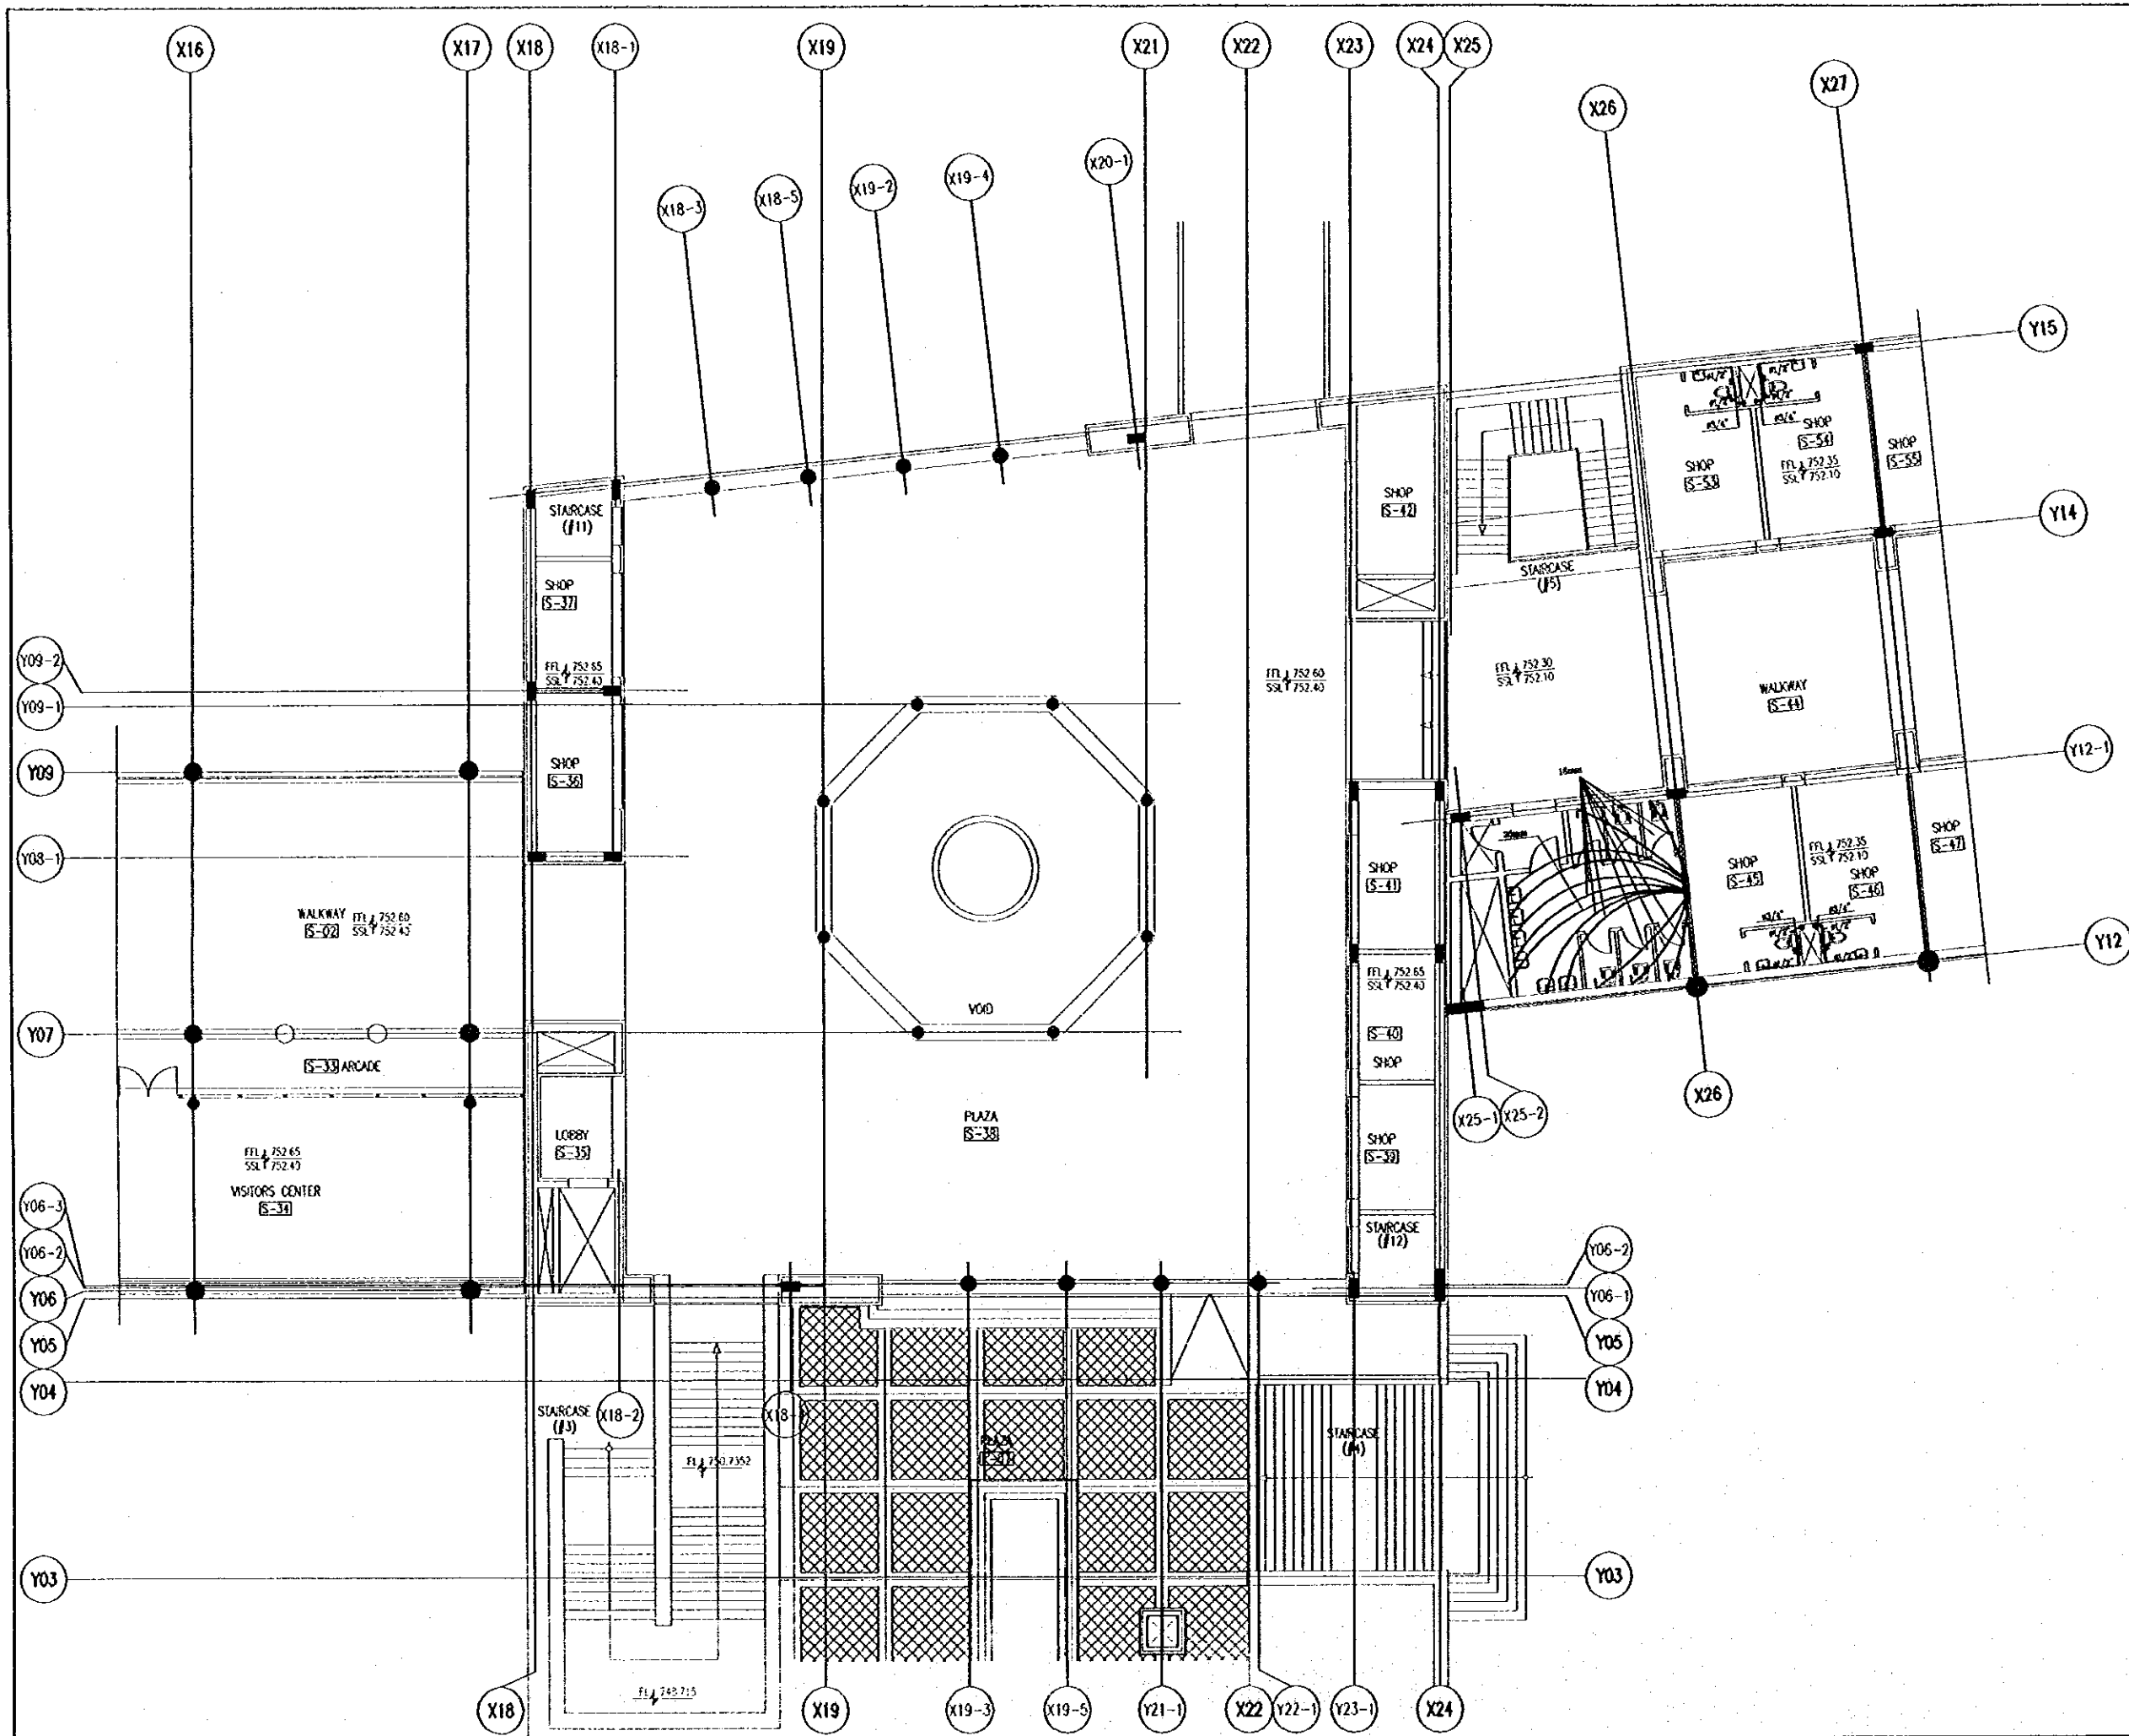

Tourism Sector Development Project
in the Hashemite Kingdom of Jordan

The Government of
the Hashemite Kingdom of Jordan
The Ministry of Tourism and Antiquities
The Ministry of Planning

Sub-Project:
Amman Downtown
Tourist Zone Development

Note:
- This detailed design has been executed by a team of
consultants as shown below in accordance with the agreement
between Japan International Cooperation Agency (JICA) and
JICA Study Team.
- The copyright of this drawing rests with JICA.

Designed by:
Japan International Cooperation Agency
(JICA)


JICA Study Team:
Joint Venture of
Pacific Consultants International and
Yamato Seikei Inc.

Subcontracted Local Consultant:
TMAH Consultants
Architects, Engineers

Raghadan Bus Terminal

Drawing Title:
**COLD WATER SYSTEM
FOR SECOND FLOOR ZONE 3**

Scale: 1/100
Drawing No: RBT .M410

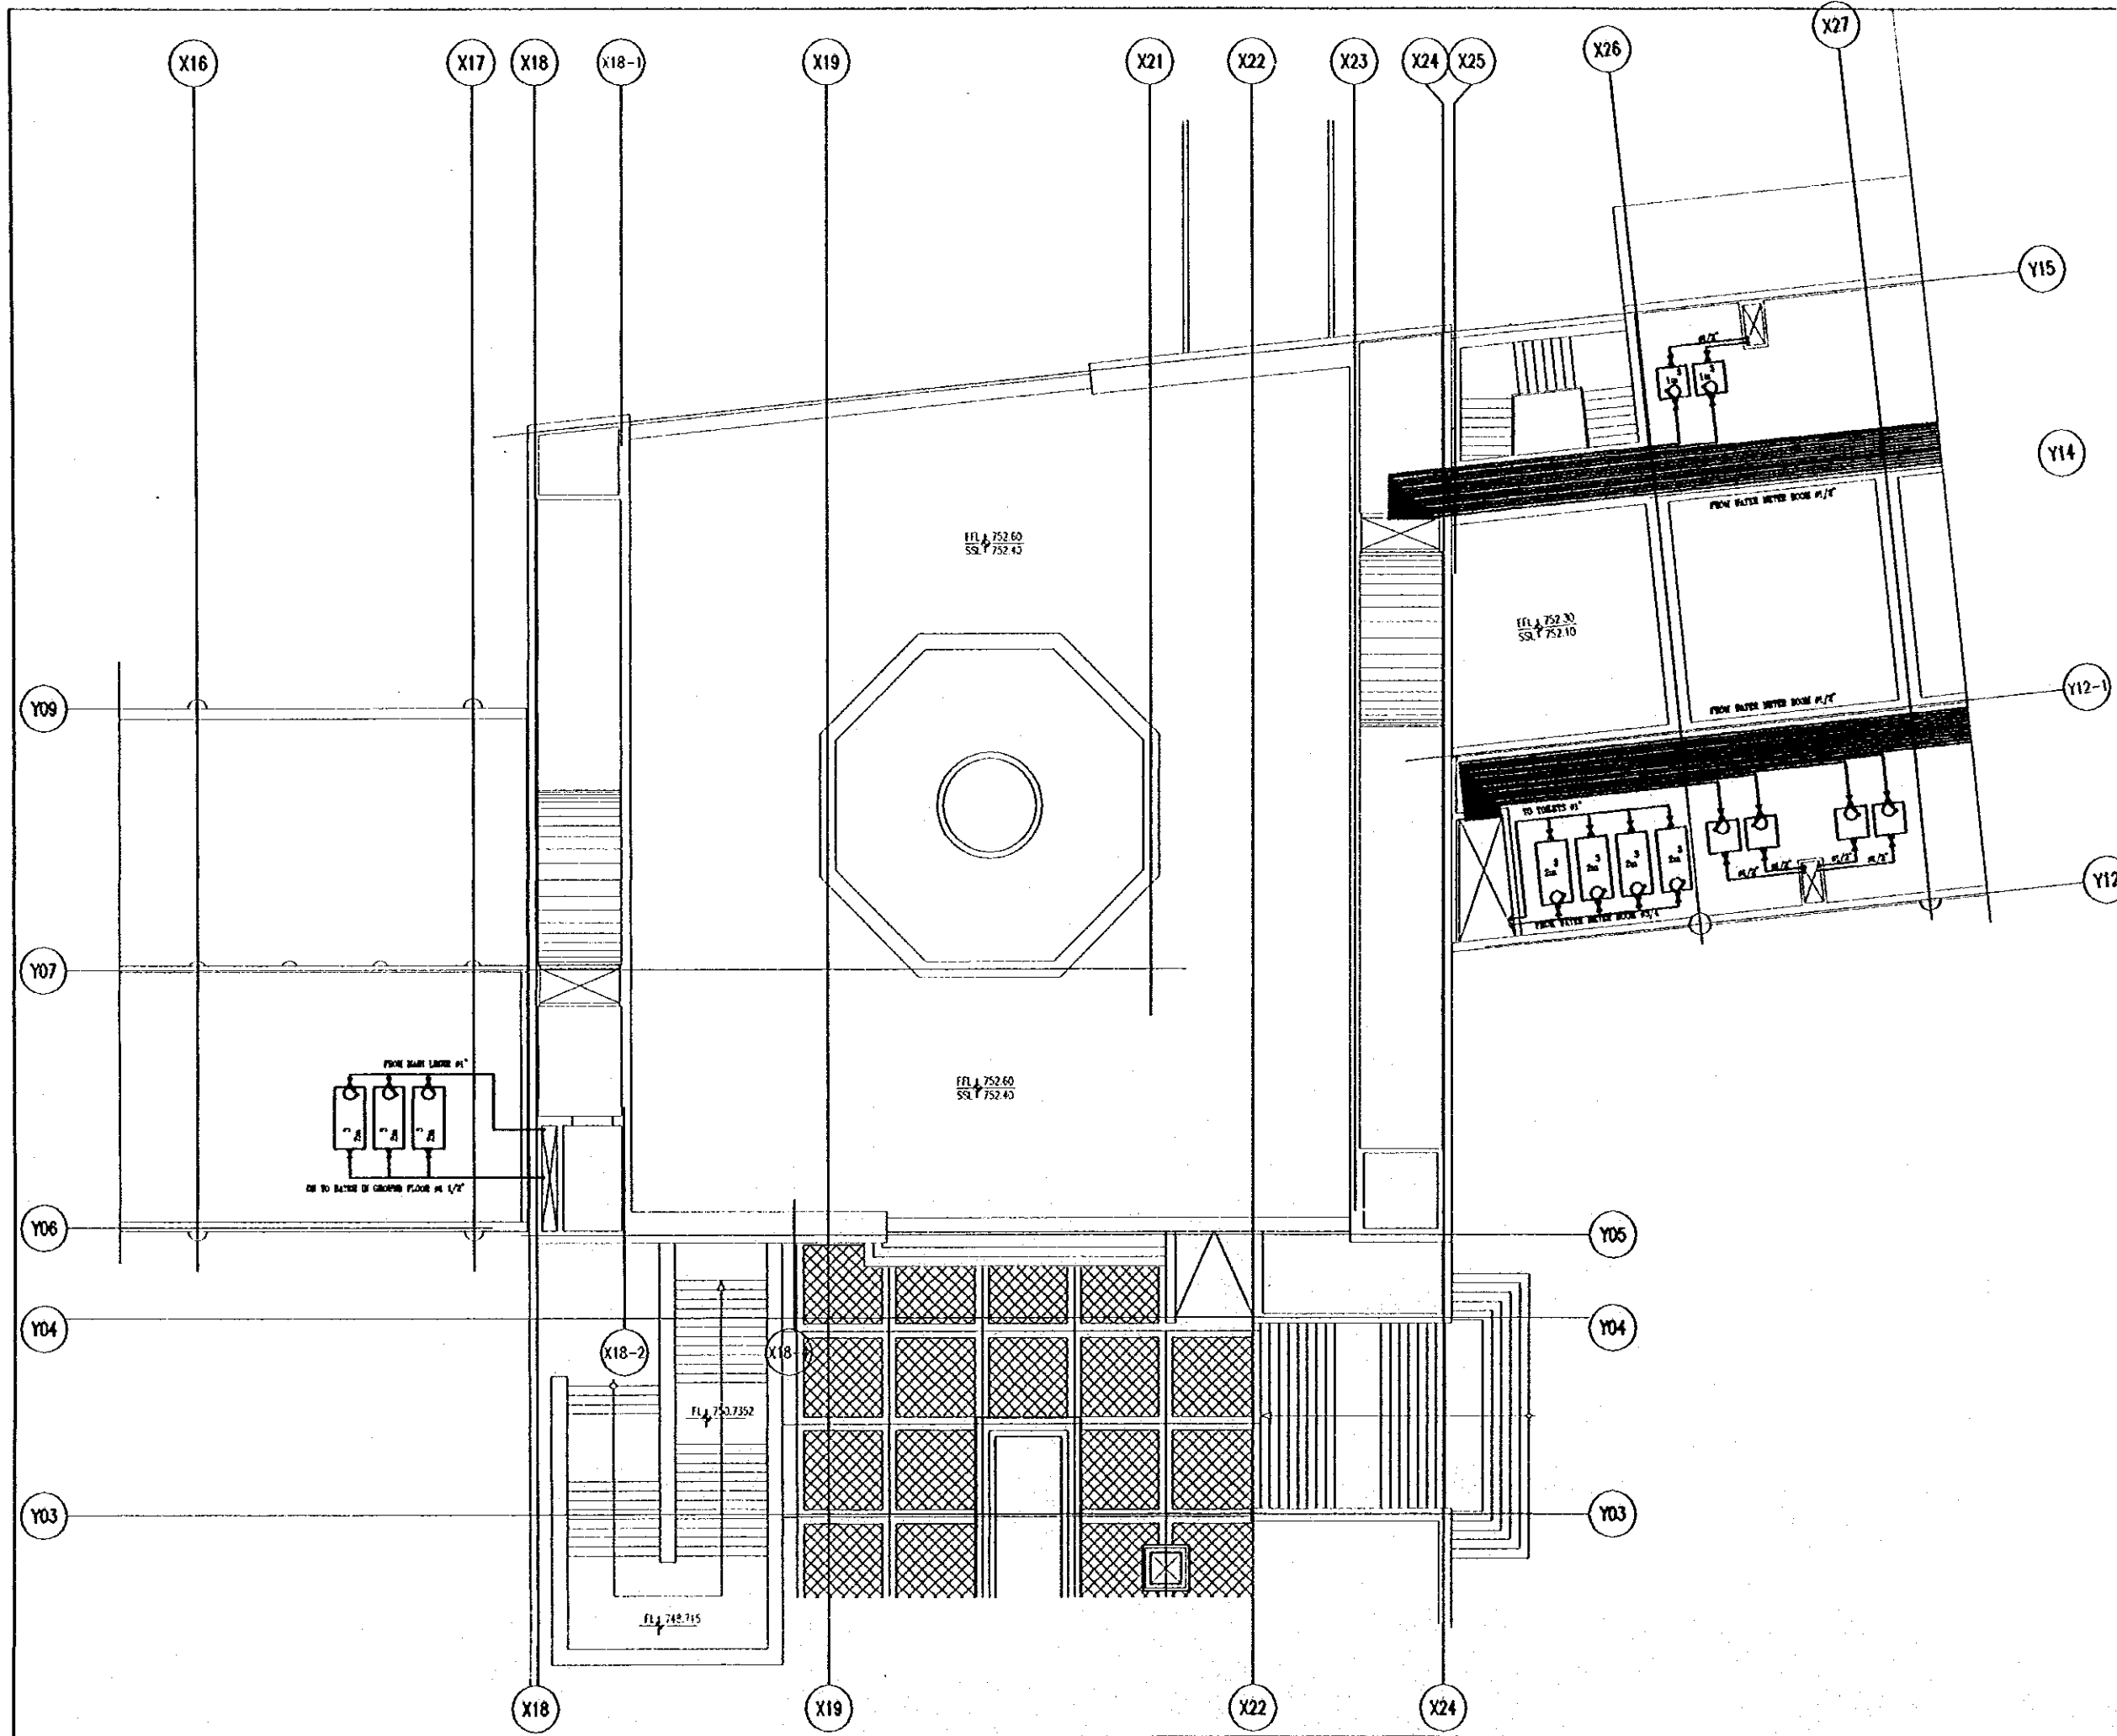

Tourism Sector Development Project
in the Hashemite Kingdom of Jordan

The Government of
the Hashemite Kingdom of Jordan
The Ministry of Tourism and Antiquities
The Ministry of Planning

Sub-Project:
Amman Downtown
Tourist Zone Development

Note:
• This detailed design has been executed by a team of consultants as shown below in accordance with the agreement between Japan International Cooperation Agency (JICA) and JICA Study Team.
• The copyright of this drawing rests with JICA.

Designed by:
Japan International Cooperation Agency (JICA)


JICA Study Team:
Joint Venture of
Pacific Consultants International and
Yamashita Sekkei Inc.

Subcontracted Local Consultant:
TIBAH Consultants
Architects, Engineers
محمد عبد الحليم

Raghadan Bus Terminal

Drawing Title:
COLD WATER SYSTEM
FOR THIRD FLOOR ZONE 3

Scale: 1/100 Drawing No: RBT .M411

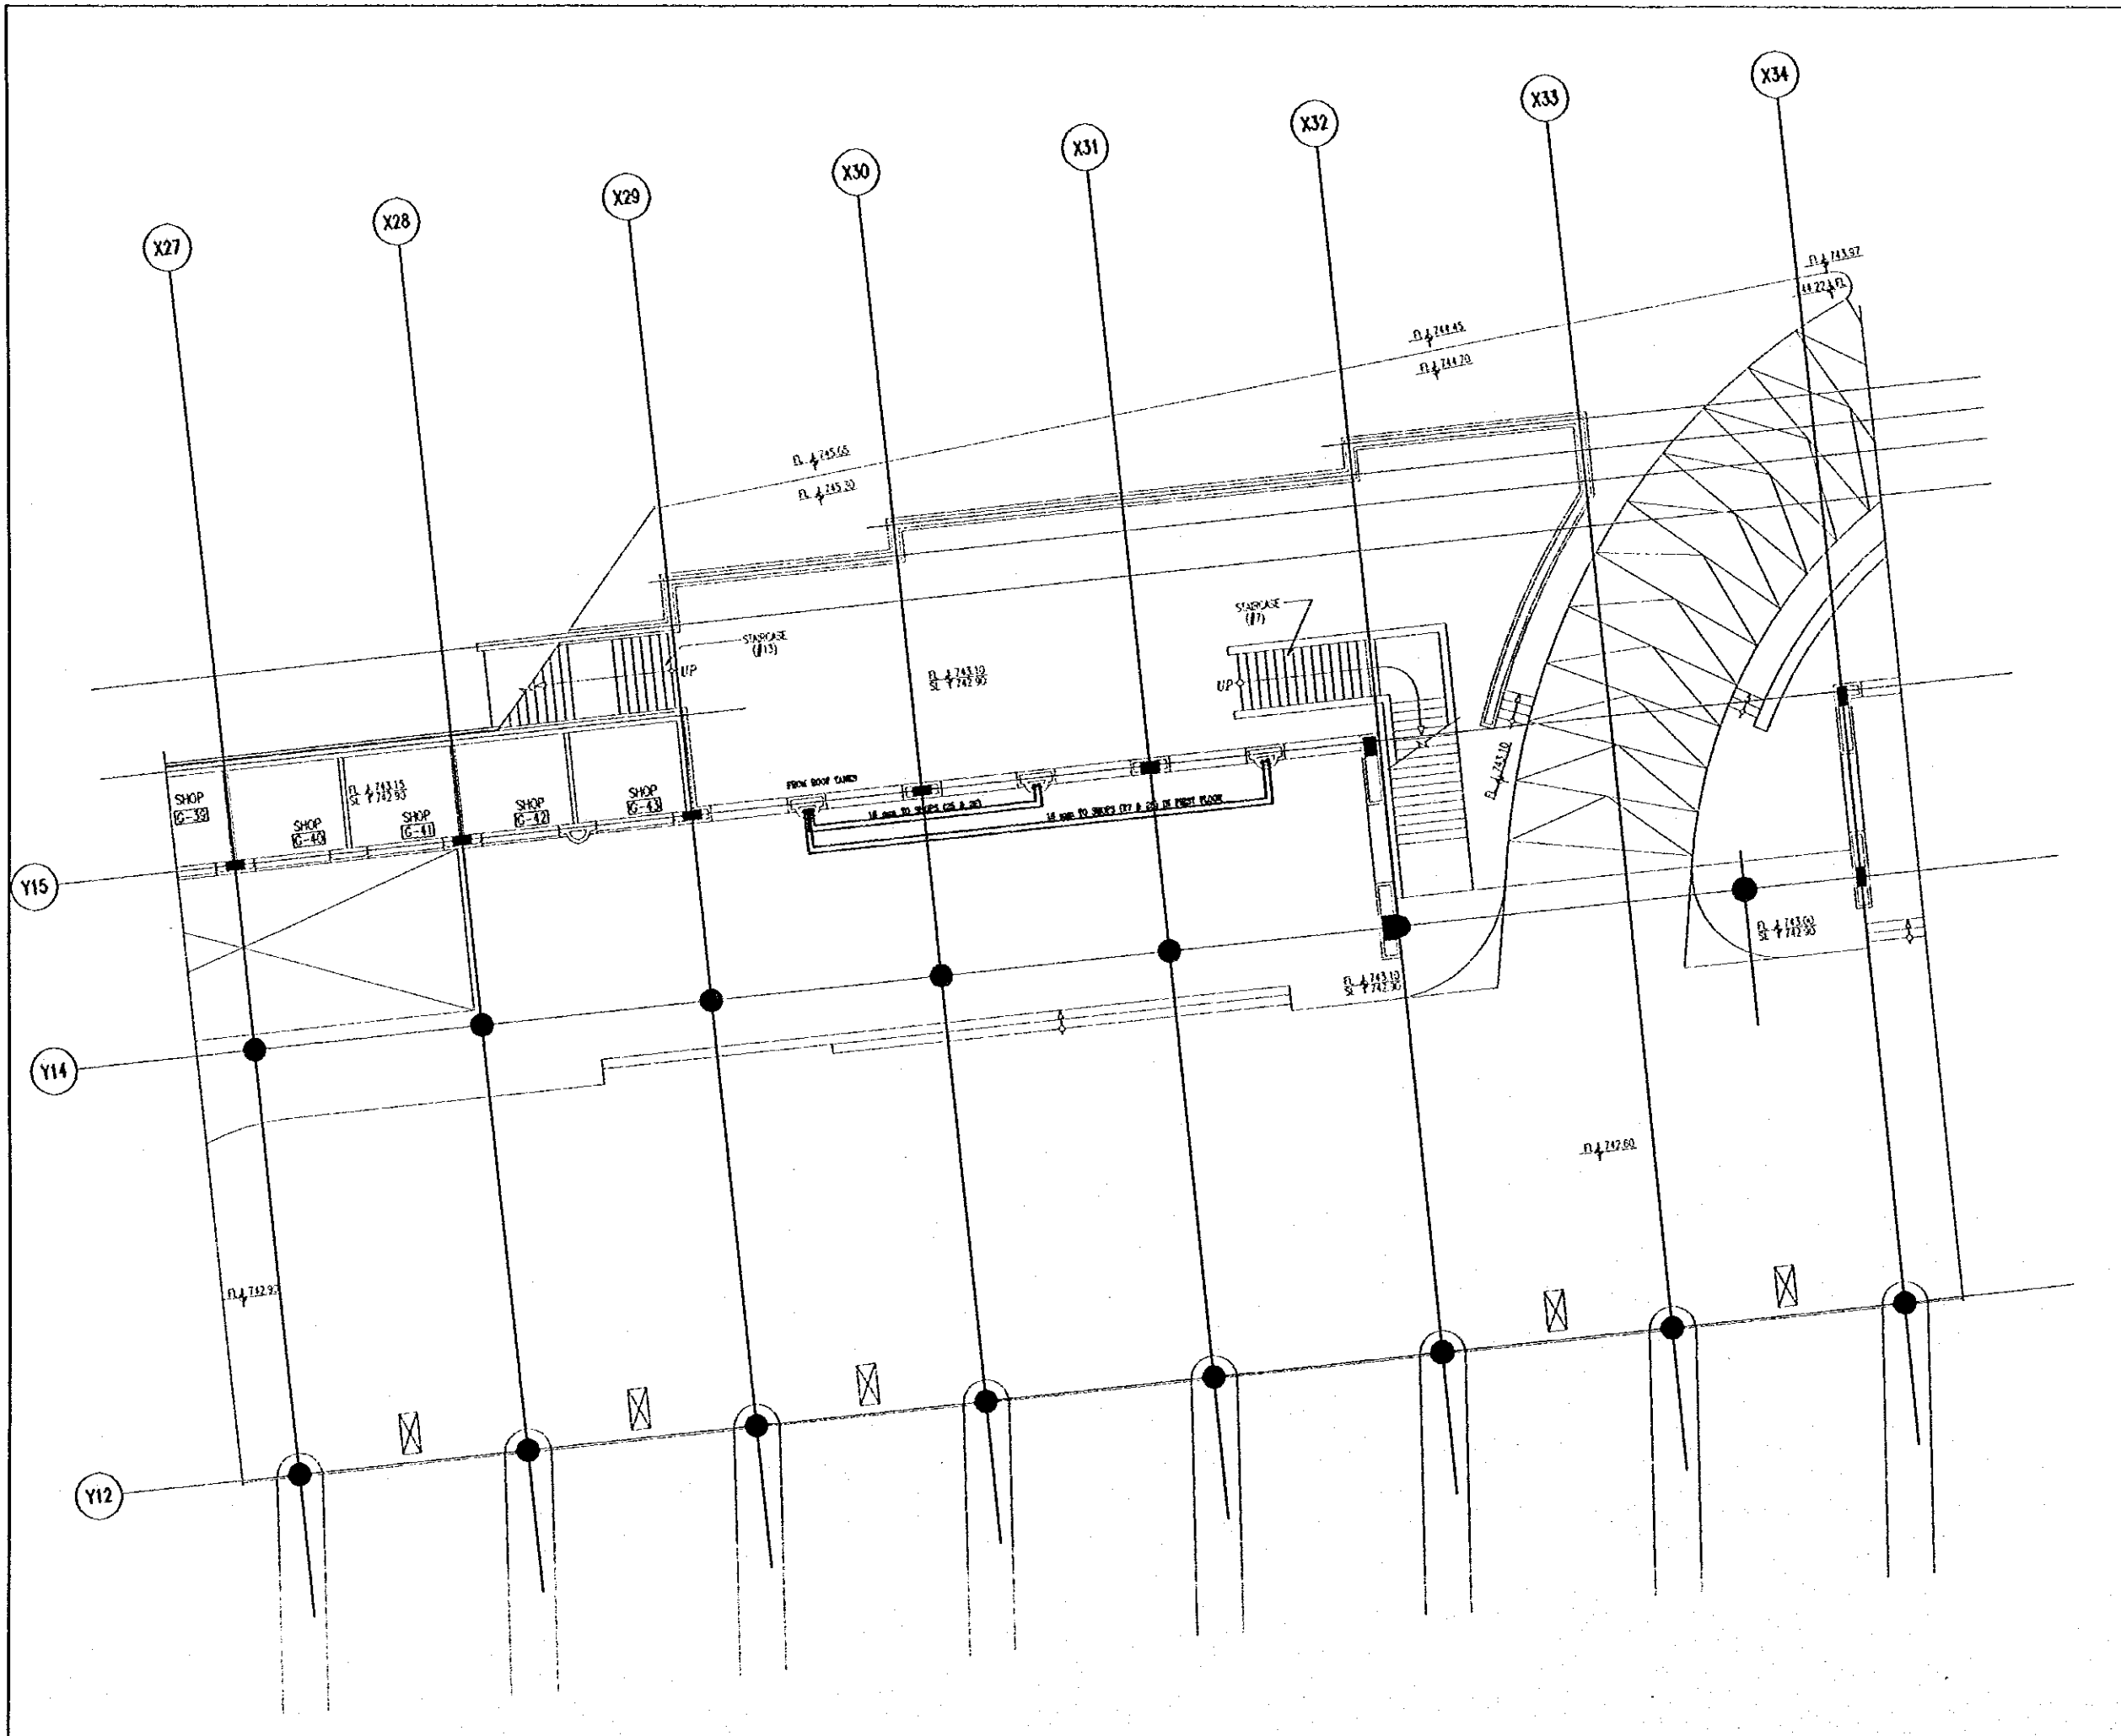

Tourism Sector Development Project
In the Hashemite Kingdom of Jordan

The Government of
the Hashemite Kingdom of Jordan
The Ministry of Tourism and Antiquities
The Ministry of Planning

Sub-Project:
Ammon Downtown
Tourist Zone Development

Note:
• This detailed design has been executed by a team of
consultants as shown below in accordance with the agreement
between Japan International Cooperation Agency (JICA) and
JICA Study Team.

• The copyright of this drawing rests with JICA.

Designed by:

Japan International Cooperation Agency
(JICA)

JICA Study Team:

Joint Venture of
Pacific Consultants International and
Yamashita Sekkei Inc.

Subcontracted Local Consultant:

TAMM Consultants
Architects, Engineers

المصممون المحليون
المهندسون المعماريون والمهندسون



Raghadan Bus Terminal

Drawing Title:


COLD WATER SYSTEM
FOR GROUND FLOOR ZONE 4

Scale:

1/100

Drawing No.:

RBT .M412

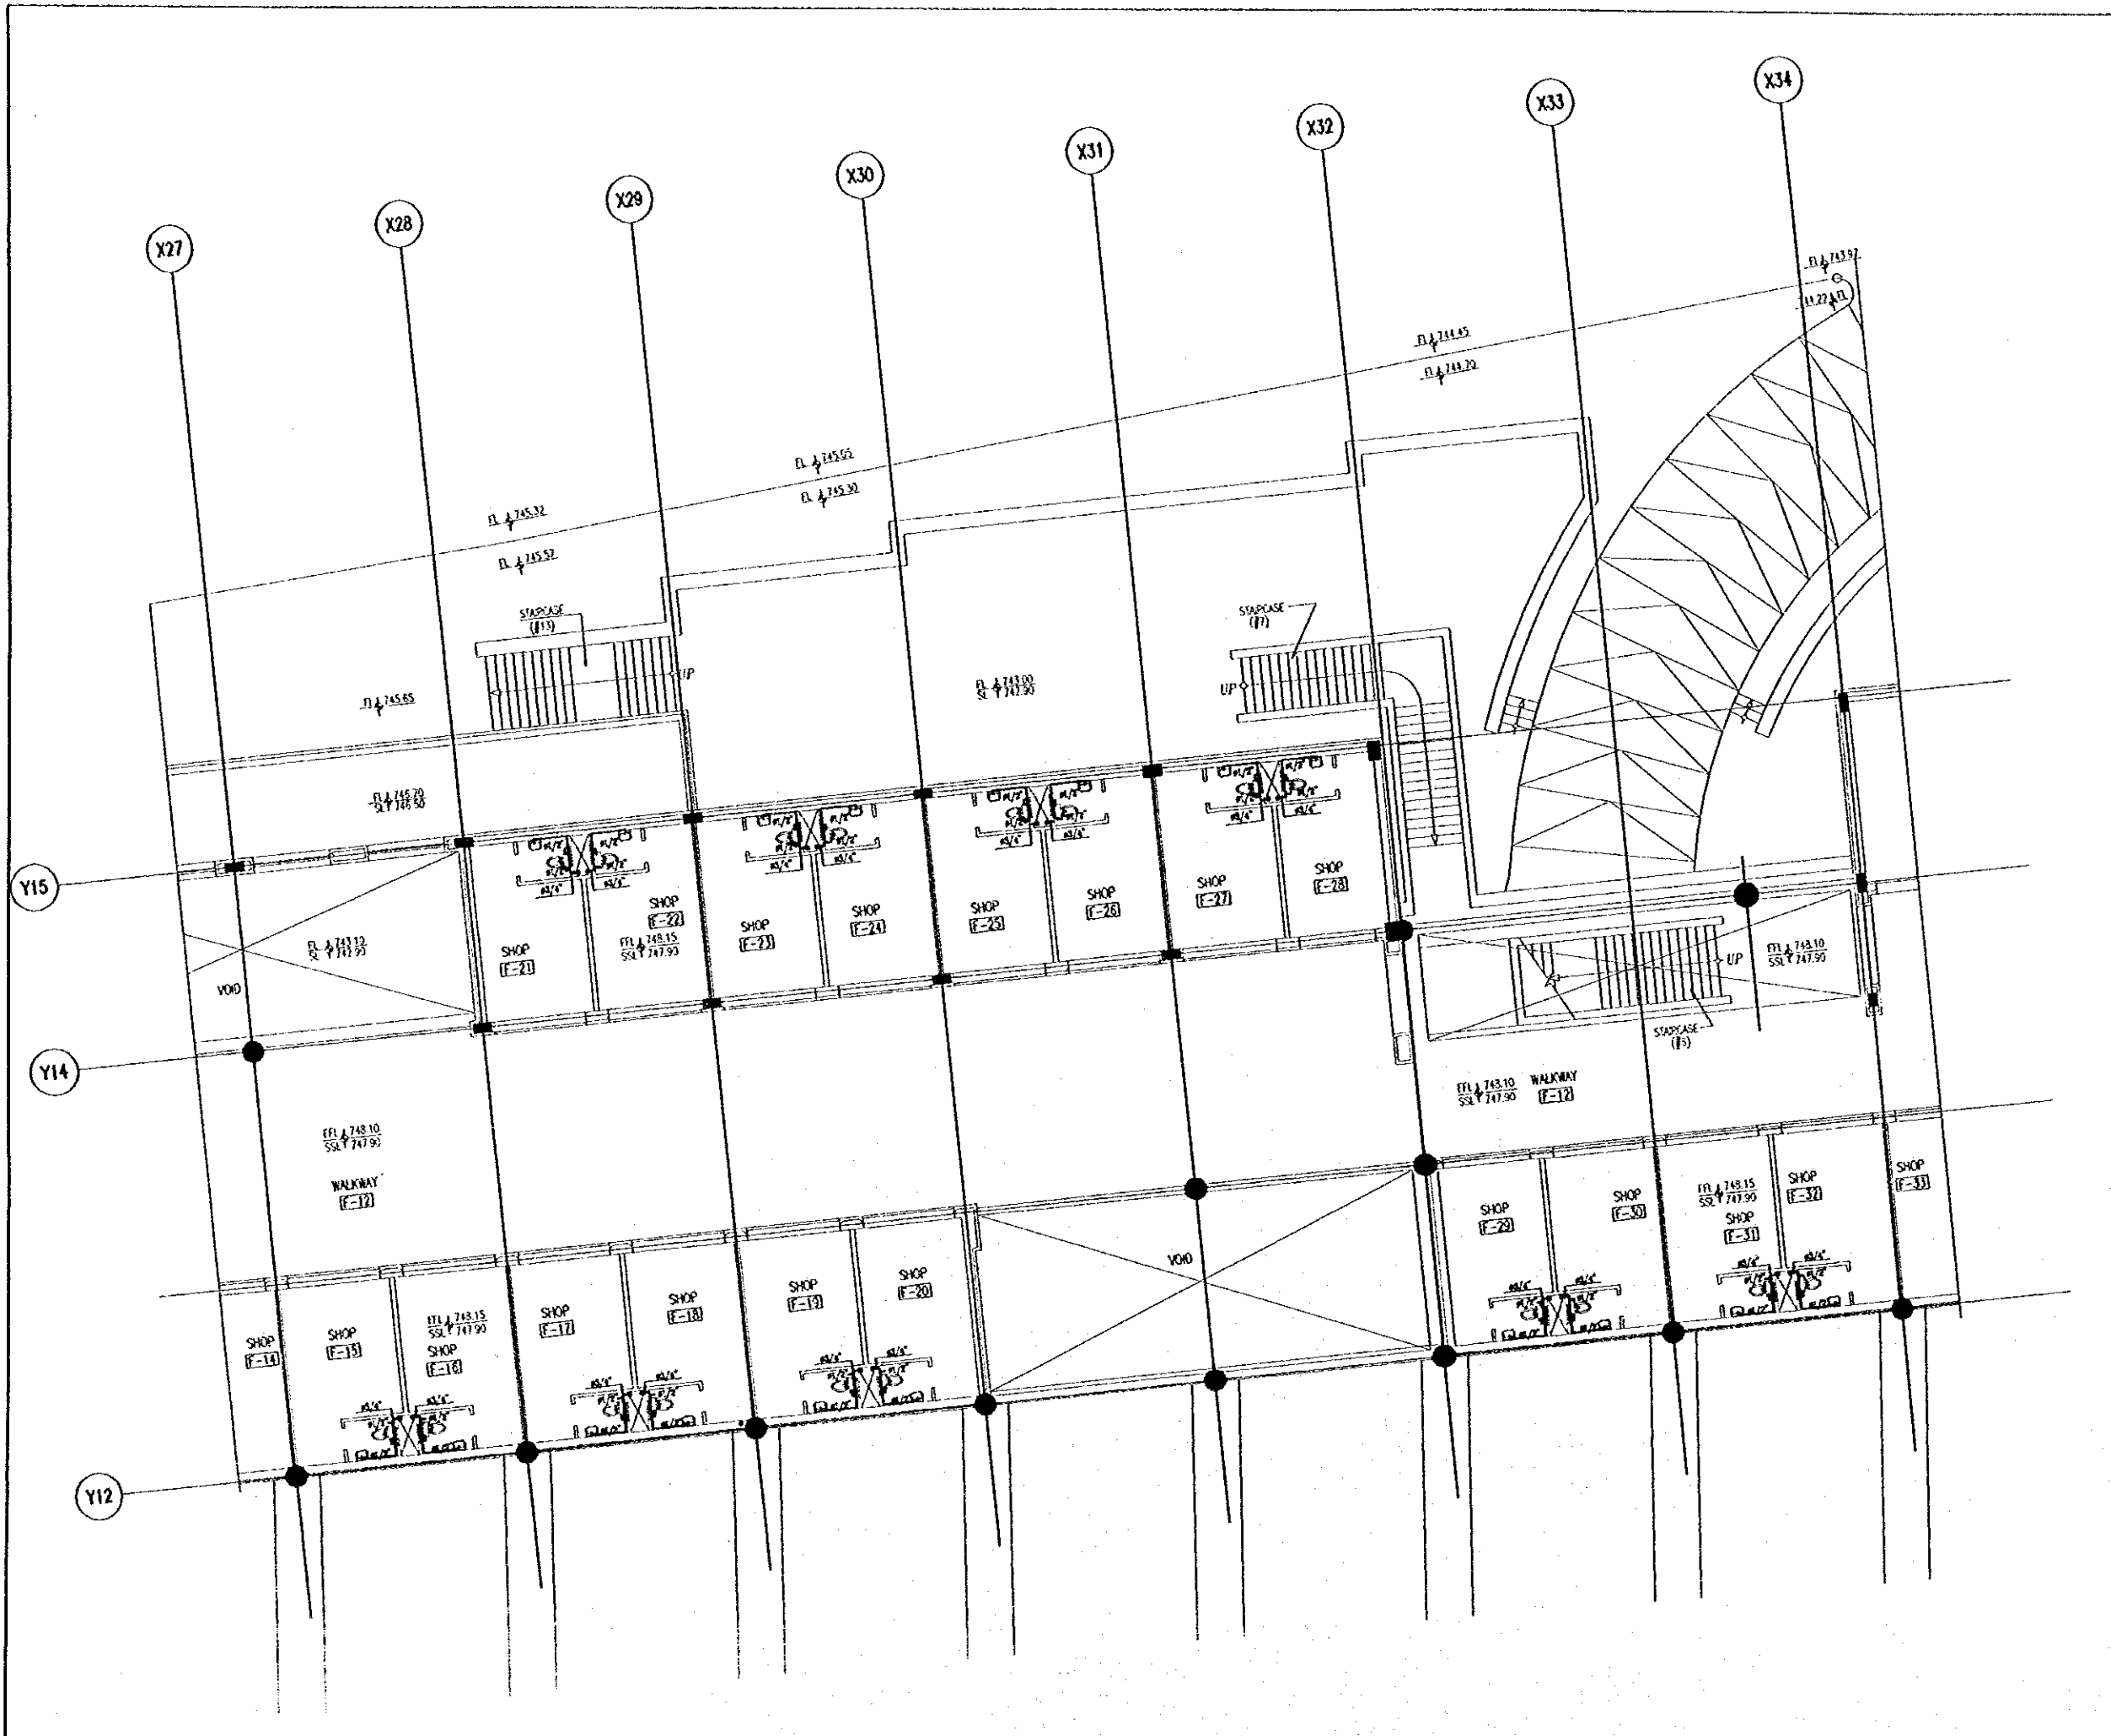

Tourism Sector Development Project
in the Hashemite Kingdom of Jordan

The Government of
the Hashemite Kingdom of Jordan
The Ministry of Tourism and Antiquities
The Ministry of Planning

Sub-Project:
Amman Downtown
Tourist Zone Development

Note:
• This detailed design has been executed by a team of
consultants as shown below in accordance with the agreement
between Japan International Cooperation Agency (JICA) and
JICA Study Team.
• The copyright of this drawing rests with JICA.

Designed by:
Japan International Cooperation Agency
(JICA)

JICA Study Team:
Joint Venture of
Pacific Consultants International and
Yamashi'a Sekitel Inc.

Subcontracted Local Consultant:
FIBAH Consultants
Architects, Engineers

Raghadon Bus Terminal
Drawing Title:
COLD WATER SYSTEM
FOR FIRST FLOOR ZONE 4


Scale: 1/100 Drawing No: RBT_M413

Tourism Sector Development Project
in the Hashemite Kingdom of Jordan

The Government of
the Hashemite Kingdom of Jordan
The Ministry of Tourism and Antiquities
The Ministry of Planning

Sub-Project:
Amman Downtown
Tourist Zone Development


Note:
• The detailed design has been executed by a team of
consultants as shown below in accordance with the agreement
between Japan International Cooperation Agency (JICA) and
JICA Study Team.
• The copyright of this drawing rests with JICA.

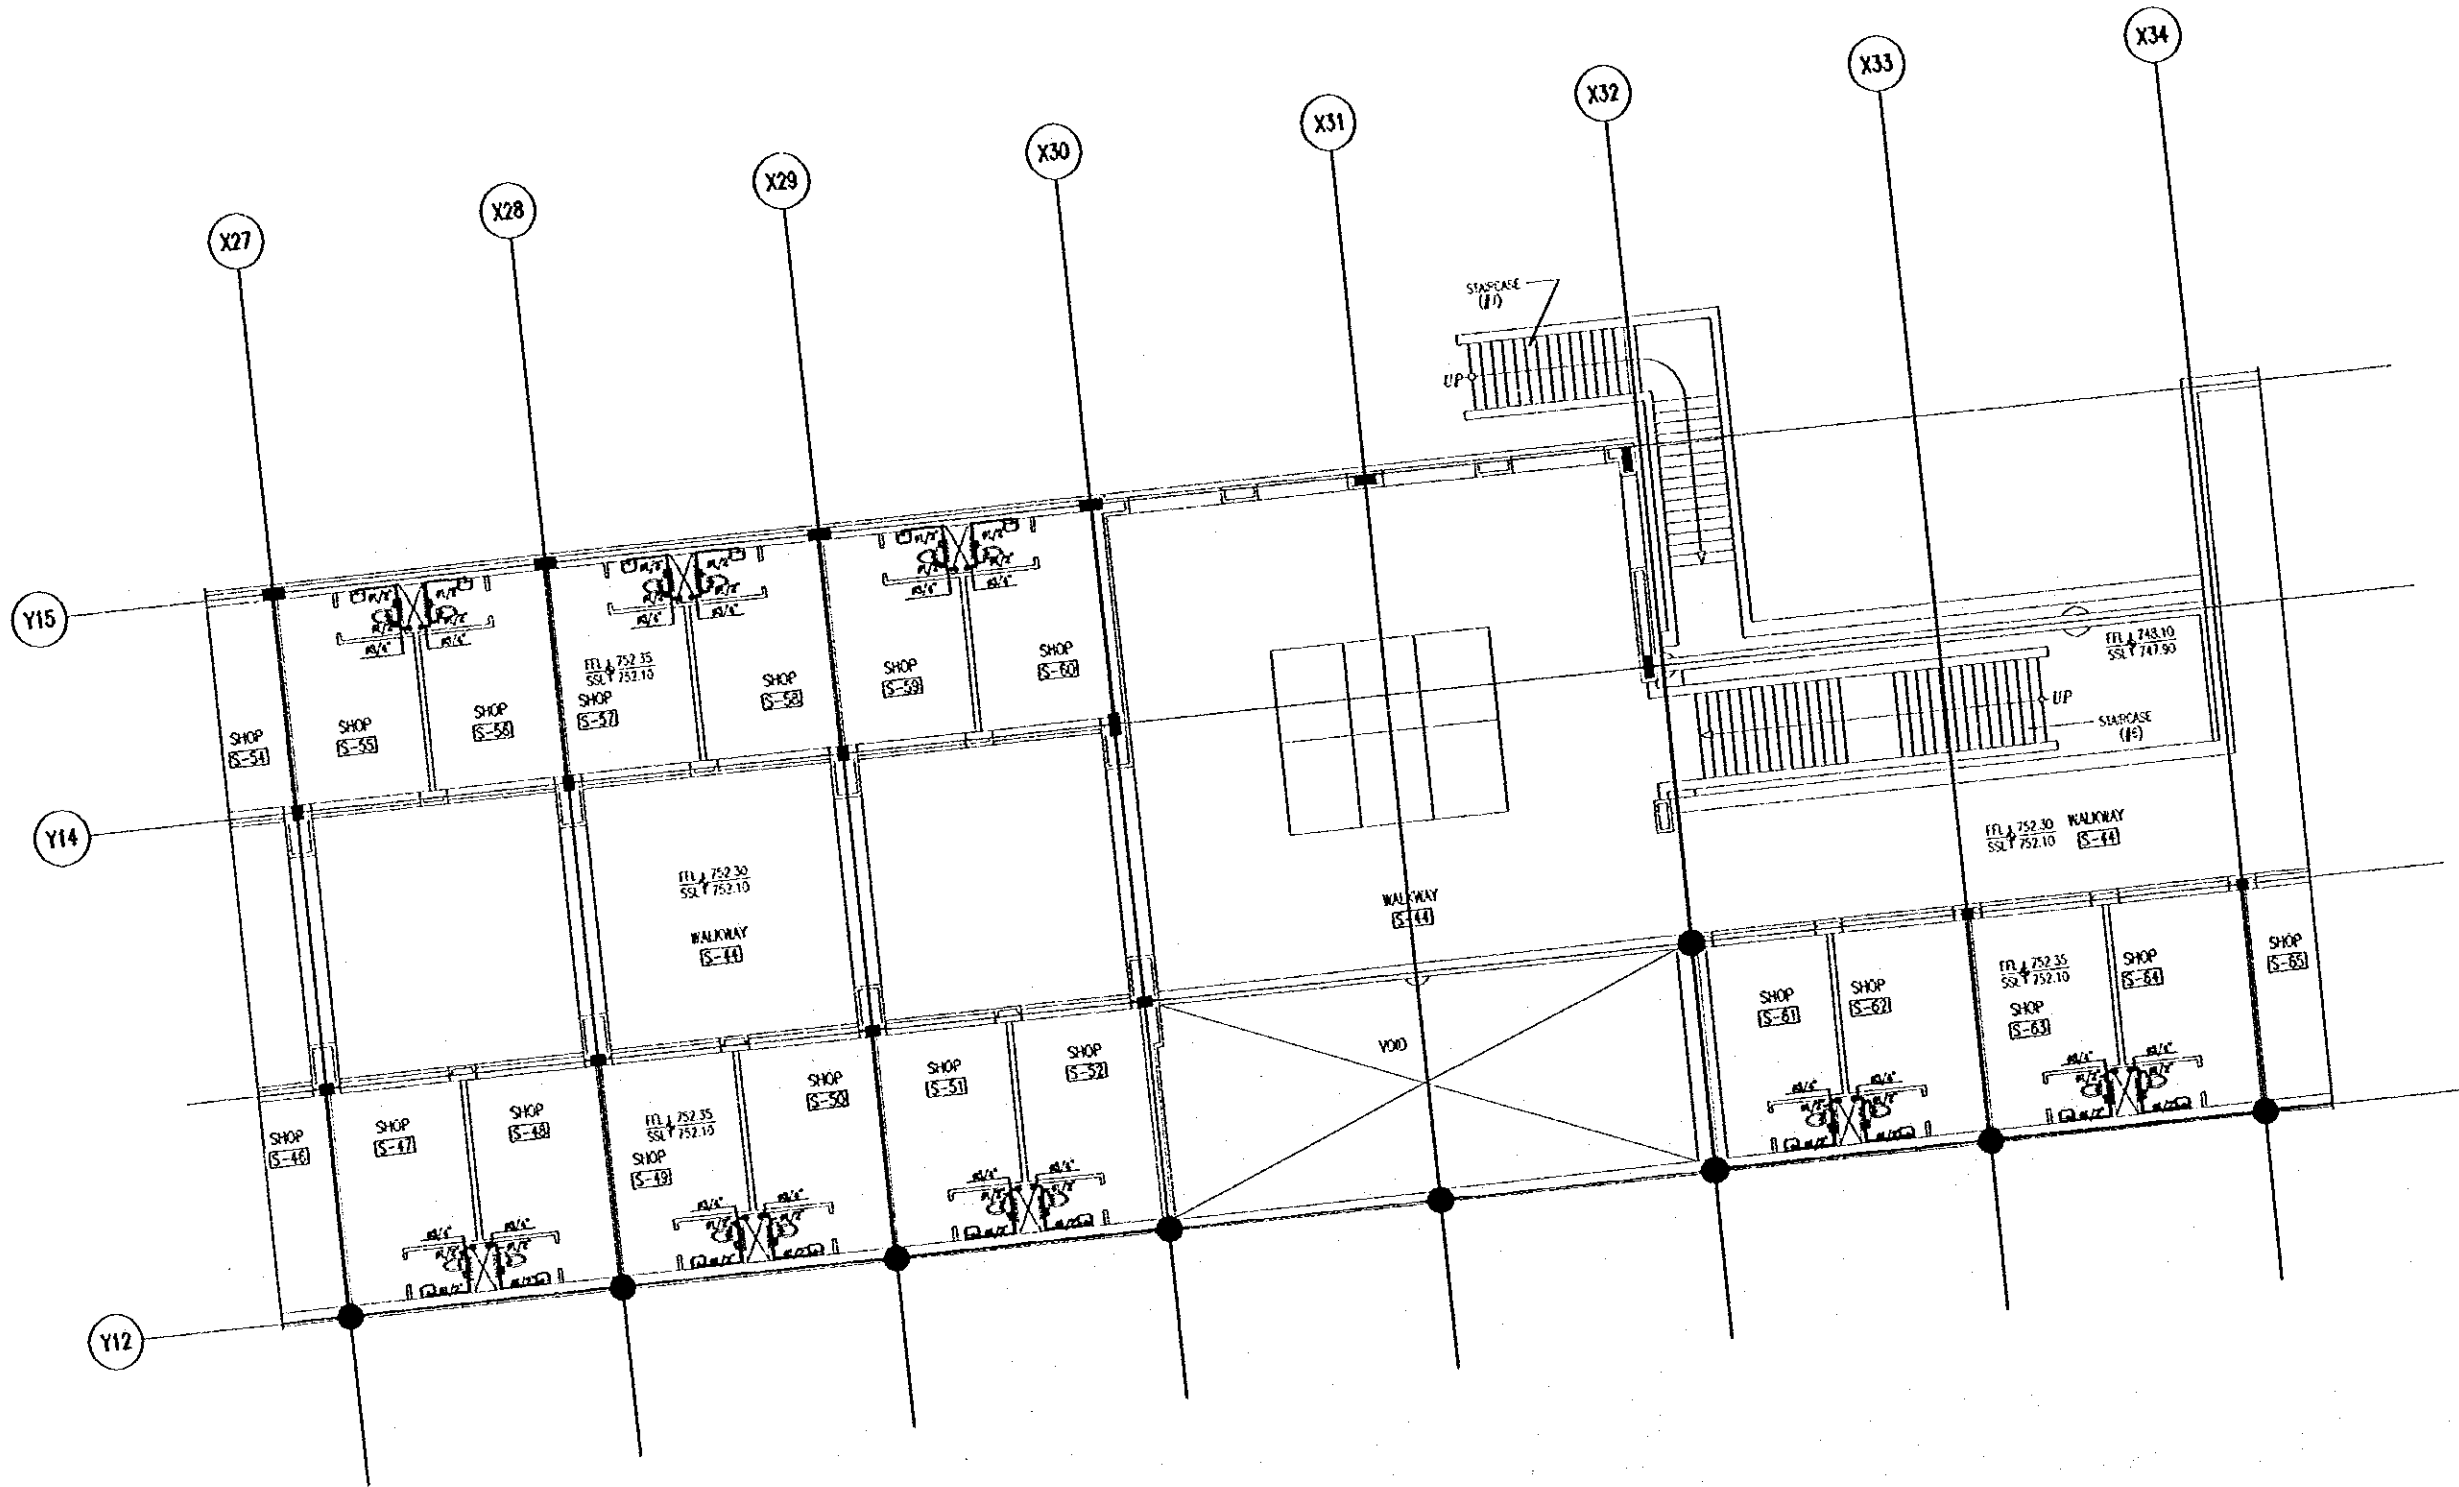

Designed by:
Japan International Cooperation Agency
(JICA)

JICA Study Team:
Joint Venture of
Pacific Consultants International and
Yamato Settei Inc.

Subcontracted Local Consultant:

IBAH Consultants
Architects, Engineers


Raghadan Bus Terminal

Drawing Title:
COLD WATER SYSTEM
FOR SECOND FLOOR ZONE 4


Scale: 1/100 Drawing No: RBT .M414

Tourism Sector Development Project
in the Hashemite Kingdom of Jordan

The Government of
the Hashemite Kingdom of Jordan
The Ministry of Tourism and Antiquities
The Ministry of Planning

Sub-Project:
Amman Downtown
Tourist Zone Development

Note:
• This detailed design has been executed by a team of
consultants as shown below in accordance with the agreement
between Japan International Cooperation Agency (JICA) and
JICA Study Team.
• The copyright of this drawing rests with JICA.

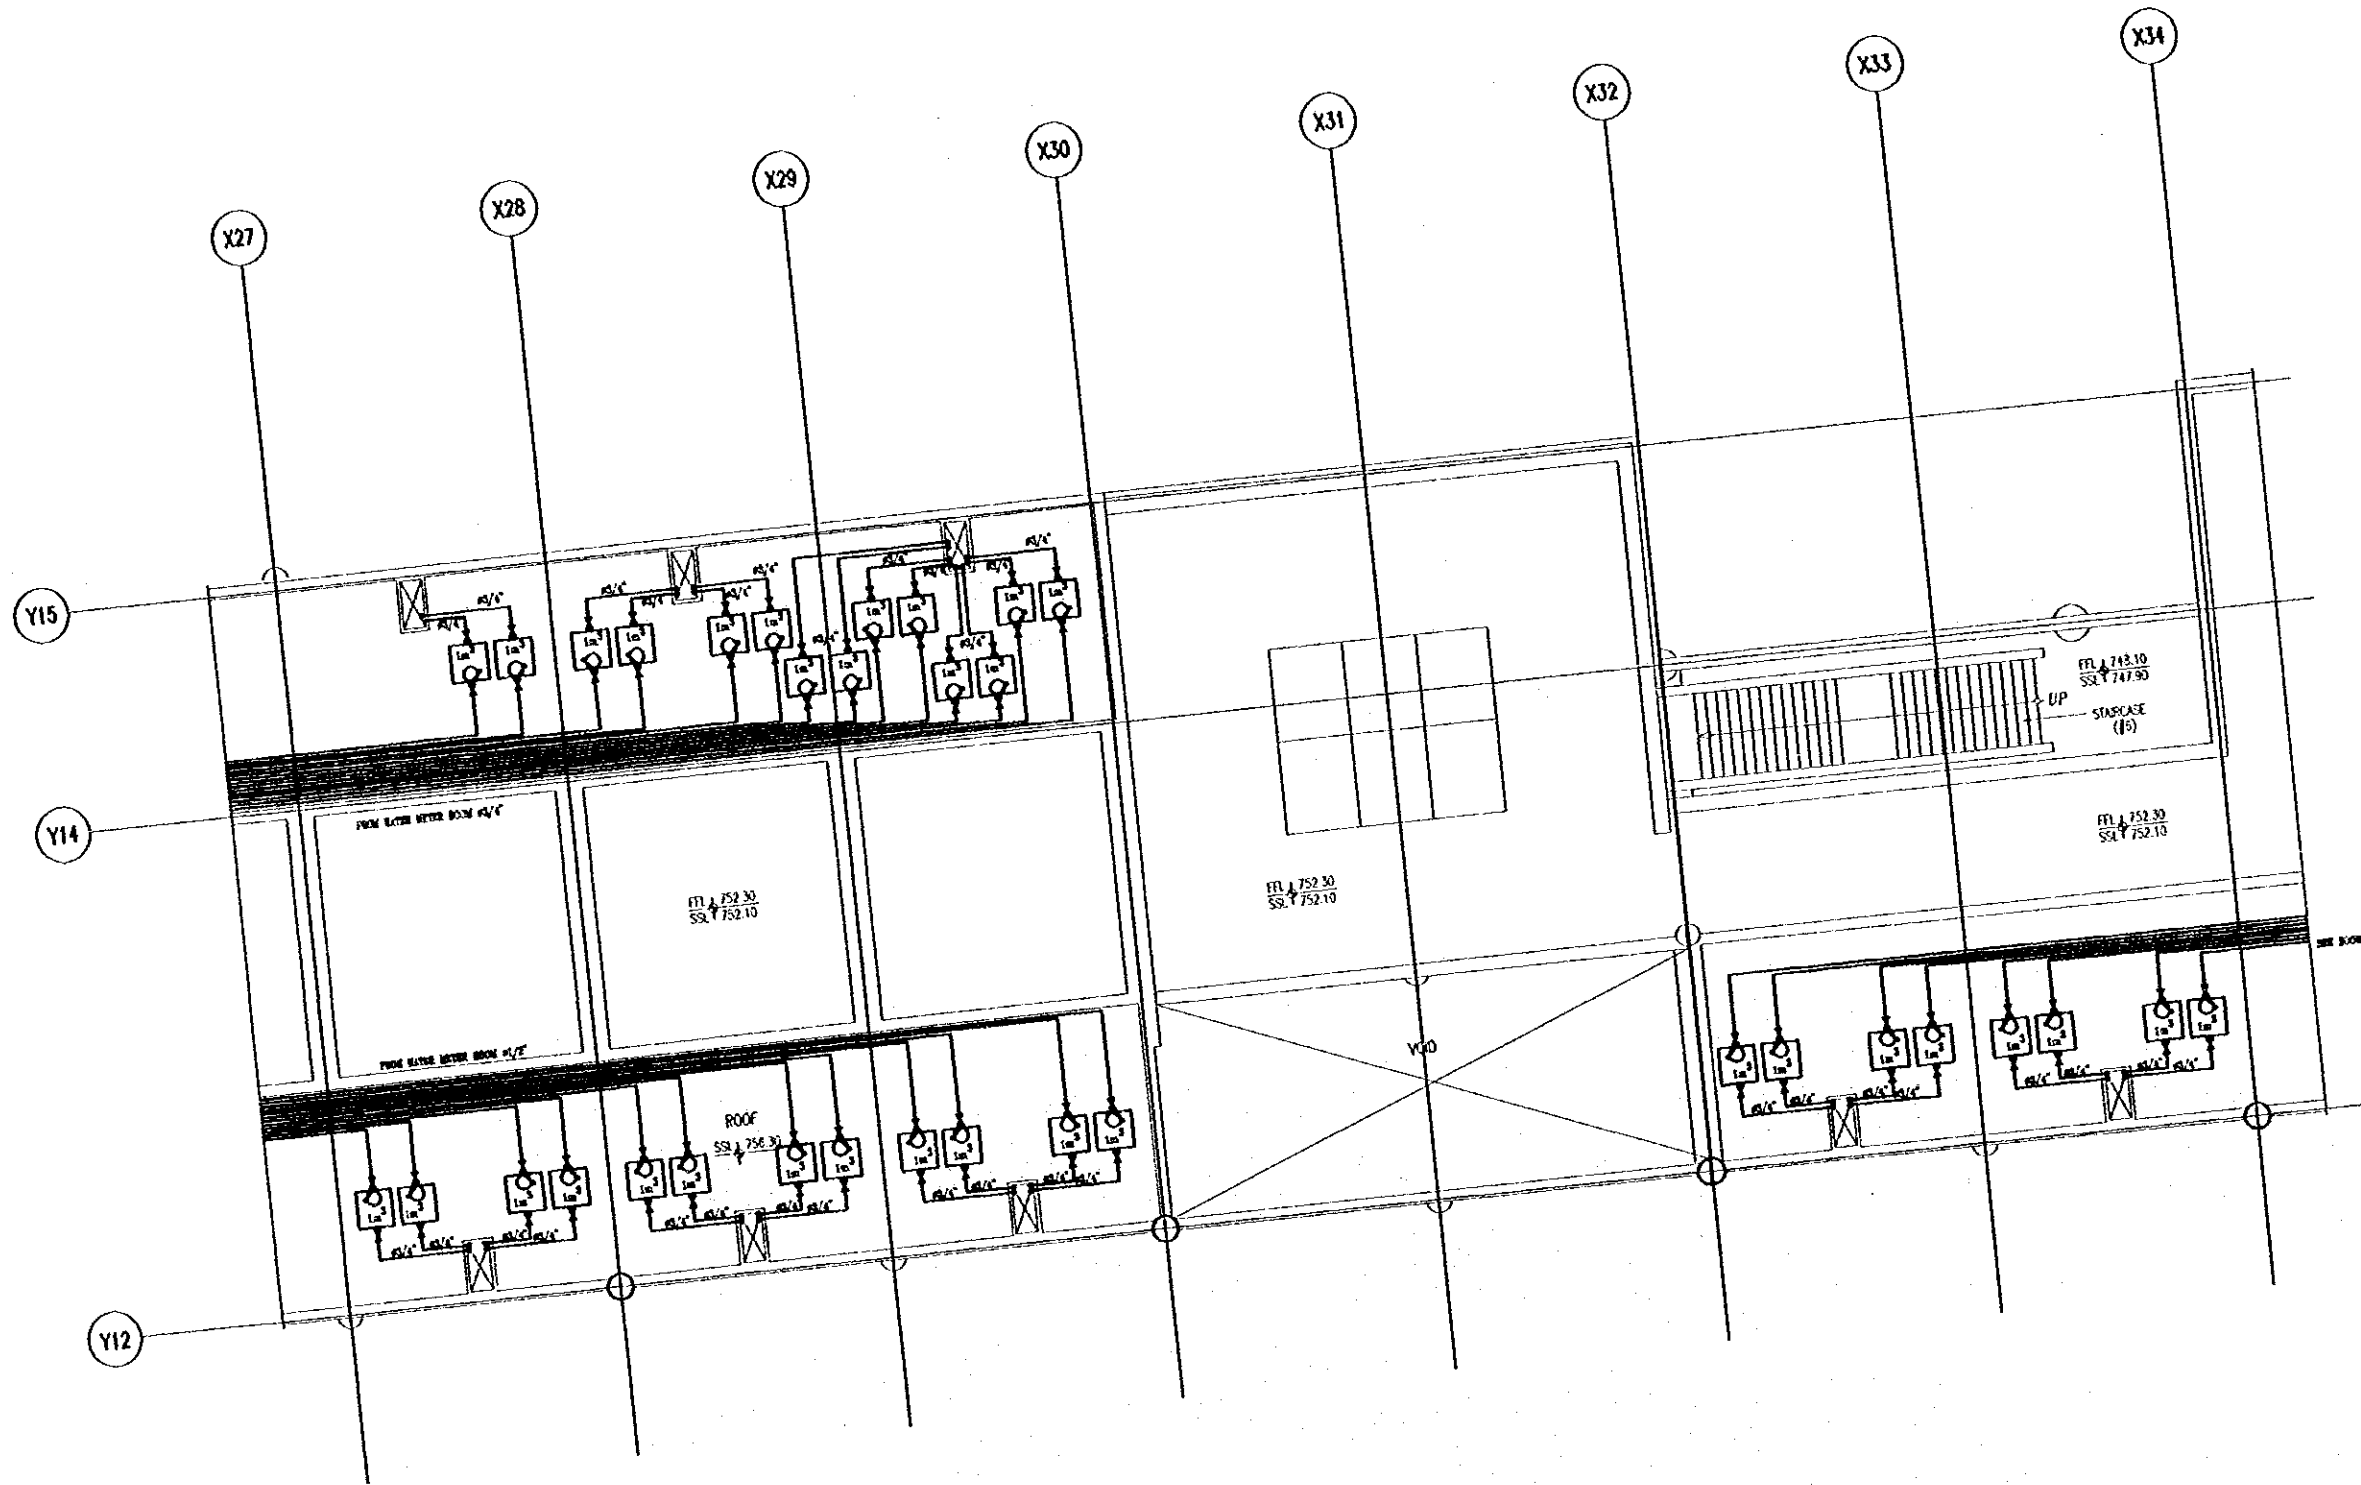

Designed by:
Japan International Cooperation Agency
(JICA)
JICA Study Team:
Joint Venture of
Pacific Consultants International and
Yamashita Sekkei Inc.
Subcontracted Local Consultant:
TBAH Consultants
Architects, Engineers


Raghadan Bus Terminal
Drawing Title:
COLD WATER SYSTEM
FOR THIRD FLOOR ZONE 4

Scale: 1/100 Drawing No.: RBT .M415

Tourism Sector Development Project
in the Hashemite Kingdom of Jordan

The Government of
the Hashemite Kingdom of Jordan
The Ministry of Tourism and Antiquities
The Ministry of Planning

Sub-Project:
Amman Downtown
Tourist Zone Development

Note:
• This detailed design has been executed by a team of
consultants as shown below in accordance with the agreement
between Japan International Cooperation Agency (JICA) and
JICA Study Team.

• The copyright of this drawing rests with JICA.

Designed by:

Japan International Cooperation Agency
(JICA)

JICA Study Team:

Joint Venture of
Pacific Consultants International and
Yamato Sekkei Inc.

Subcontracted Local Consultant:

TIBAH Consultants
Architect, Engineers



Raghadan Bus Terminal

Drawing Title

COLD WATER SYSTEM
FOR FIRST FLOOR ZONE 5


Scale

1/100

Drawing No.

RBT_M417

COLD WATER SYSTEM & FIRE FIGHTING SYSTEM

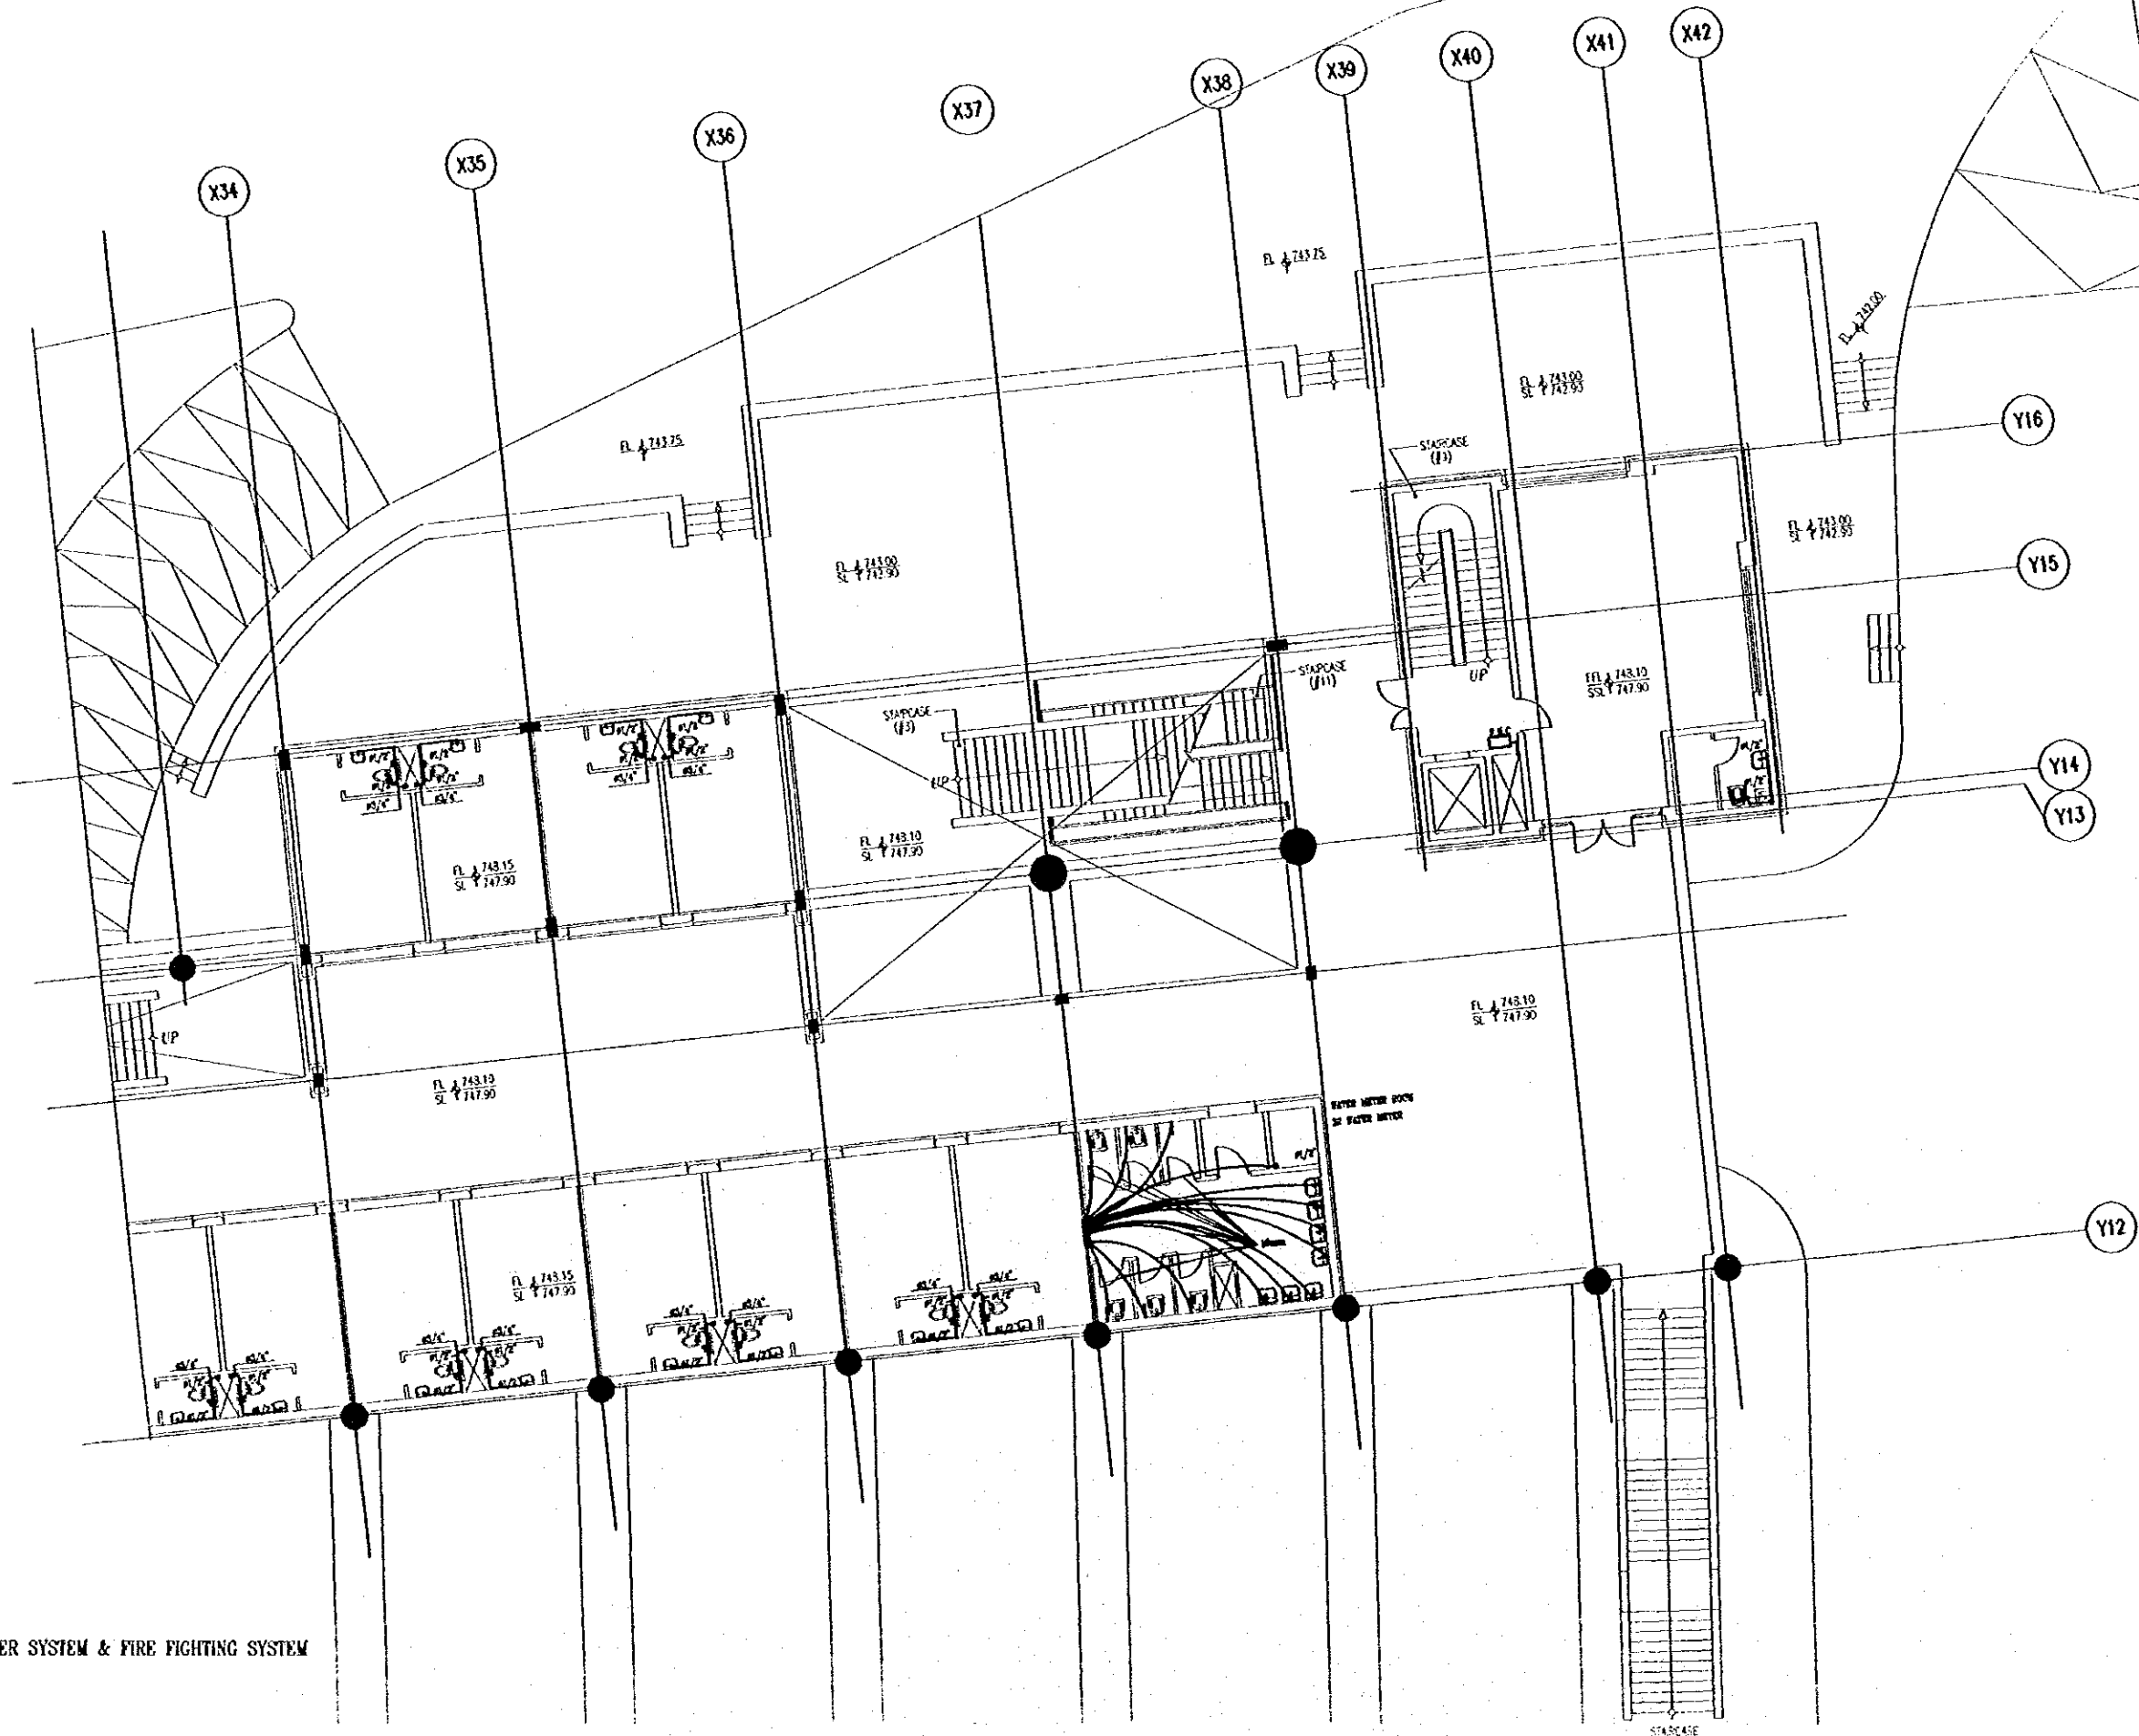

Tourism Sector Development Project
In the Hashemite Kingdom of Jordan

The Government of
the Hashemite Kingdom of Jordan
The Ministry of Tourism and Antiquities
The Ministry of Planning

Sub-Project:
Amman Downtown
Tourist Zone Development


Notes:
• This detailed design has been executed by a team of
consultants as shown below in accordance with the agreement
between Japan International Cooperation Agency (JICA) and
JICA Study Team.
• The copyright of this drawing rests with JICA.

Designed by:
Japan International Cooperation Agency
(JICA)
JICA Study Team:
Joint Venture of
Pacific Consultants International and
Yonaso Saito Inc.
Subcontracted Local Consultant:
TMAH Consultants
Architects, Engineers

Raghadan Bus Terminal

Drawing Title:
COLD WATER SYSTEM
FOR SECOND FLOOR ZONE 5

Scale: 1/100
Drawing No: RBT .M418

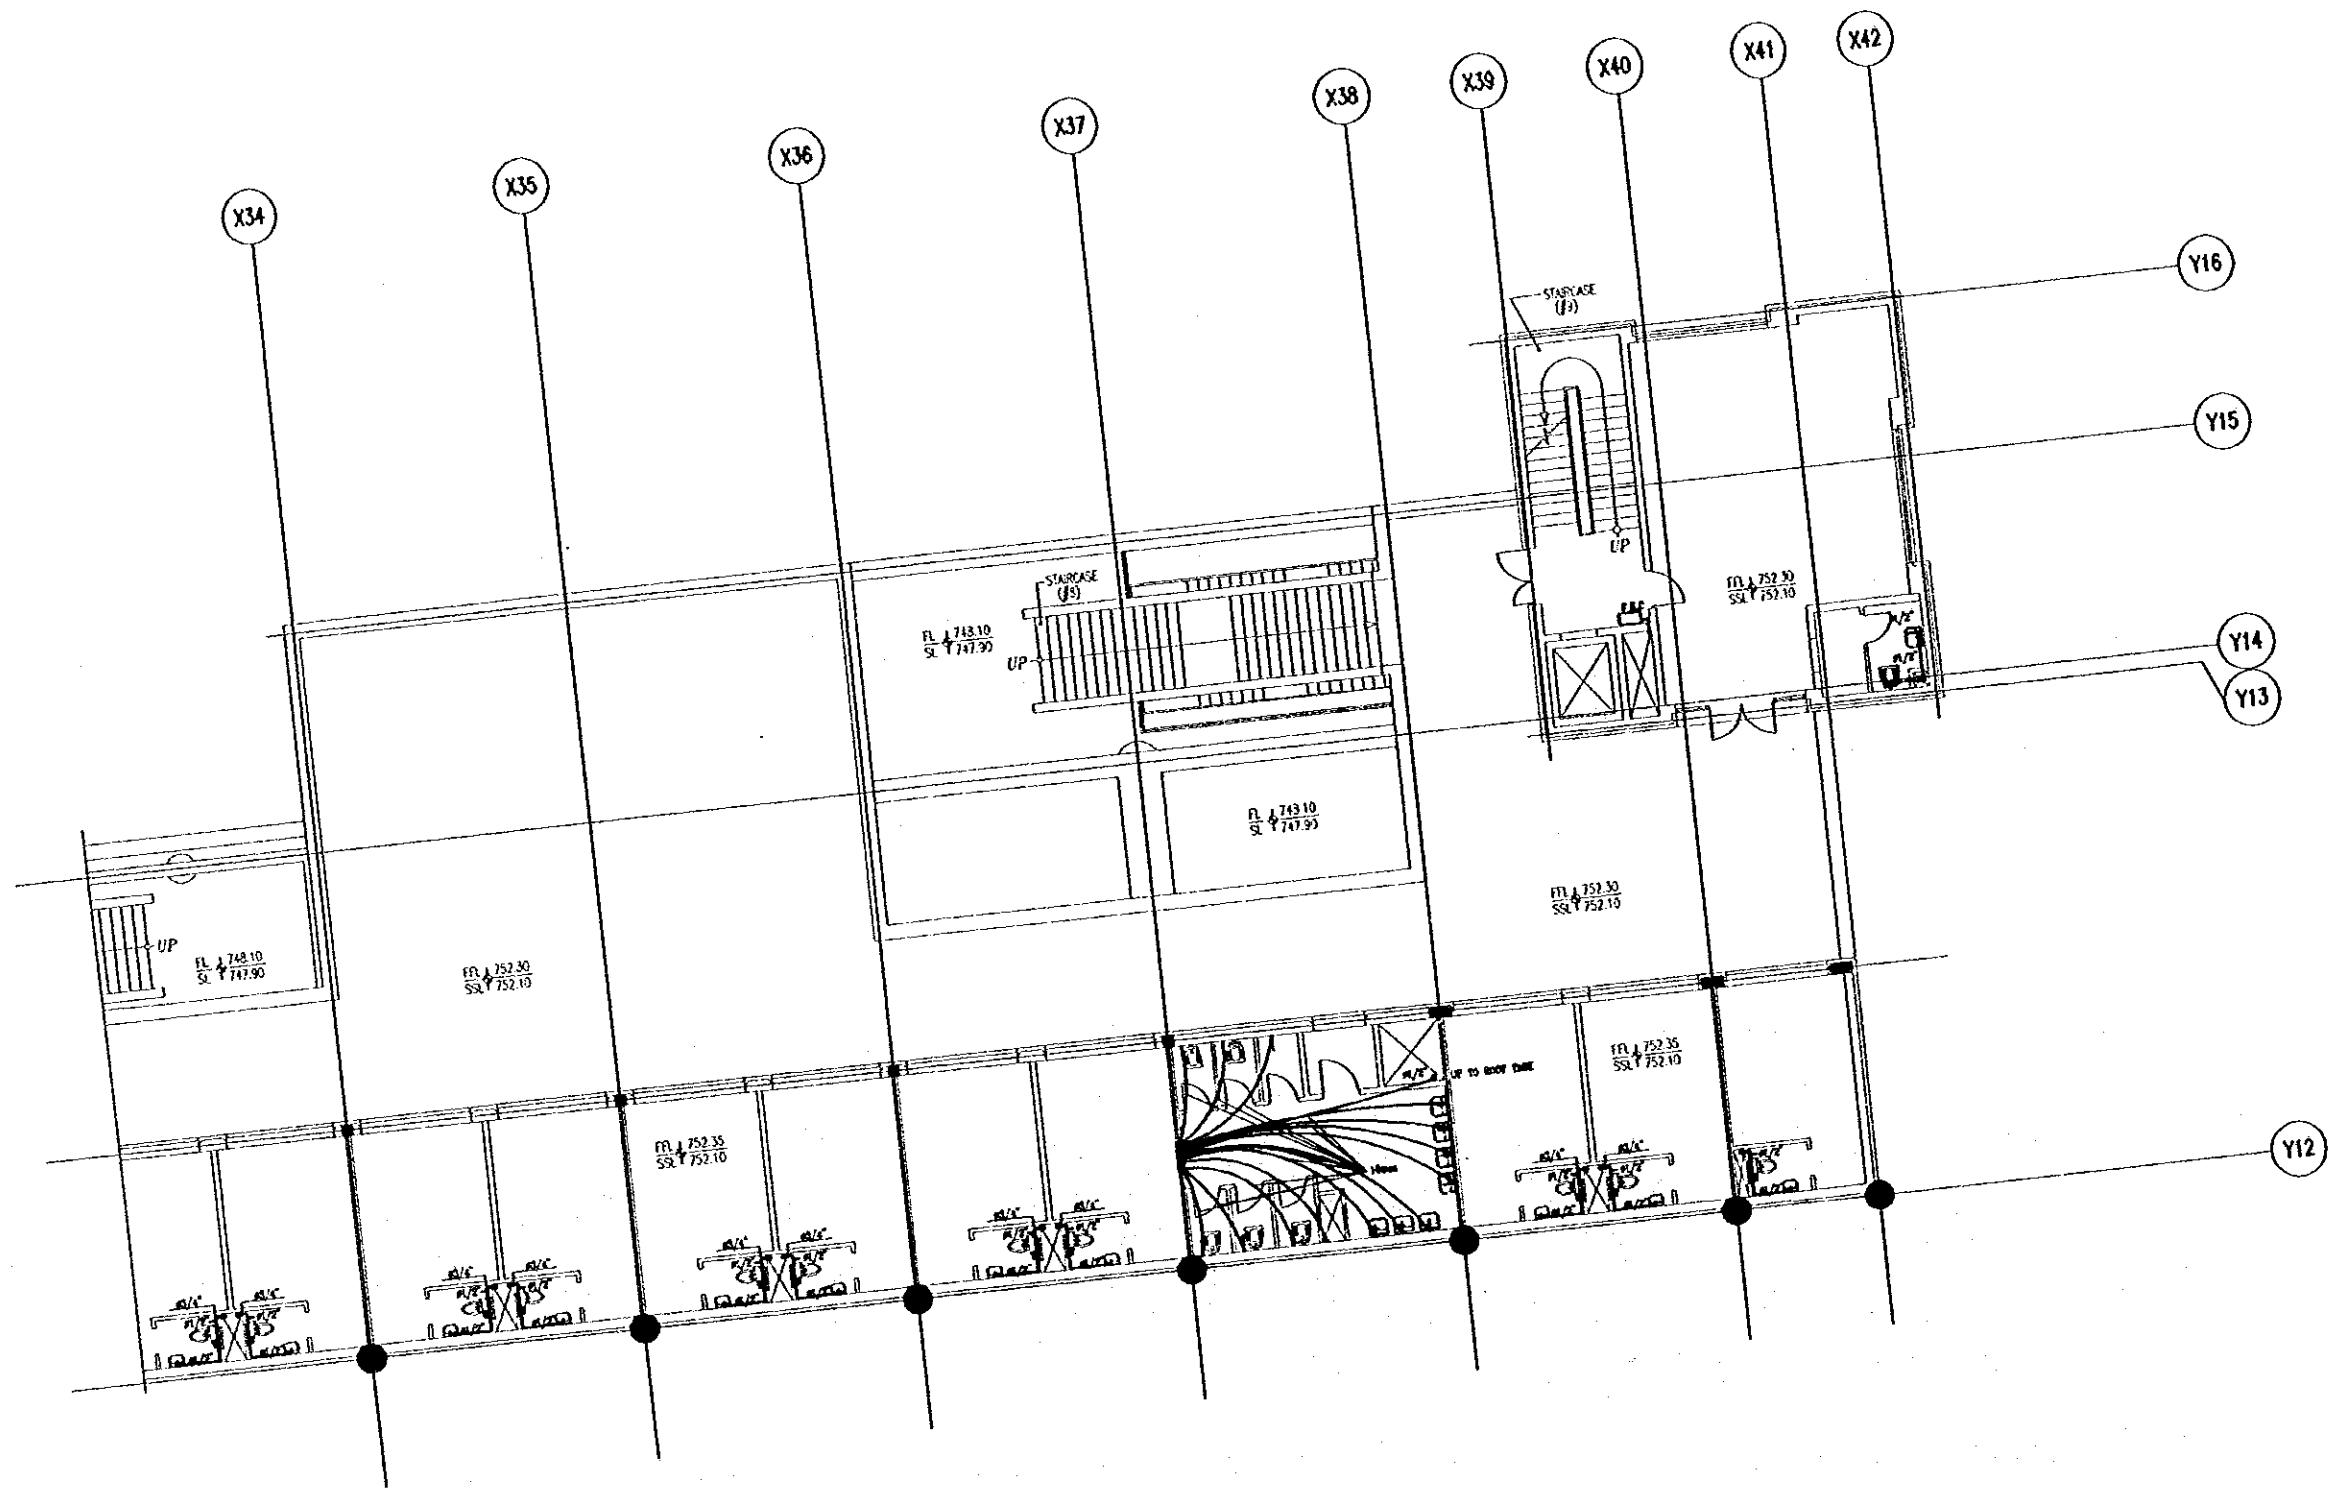


COLD WATER SYSTEM & FIRE FIGHTING SYSTEM

Tourism Sector Development Project
in the Hashemite Kingdom of Jordan

The Government of
the Hashemite Kingdom of Jordan
The Ministry of Tourism and Antiquities
The Ministry of Planning

Sub-Project:
Amman Downtown
Tourist Zone Development

Note:
• This detailed design has been executed by a team of
consultants as shown below in accordance with the agreement
between Japan International Cooperation Agency (JICA) and
JICA Study Team.
• The copyright of this drawing rests with JICA.

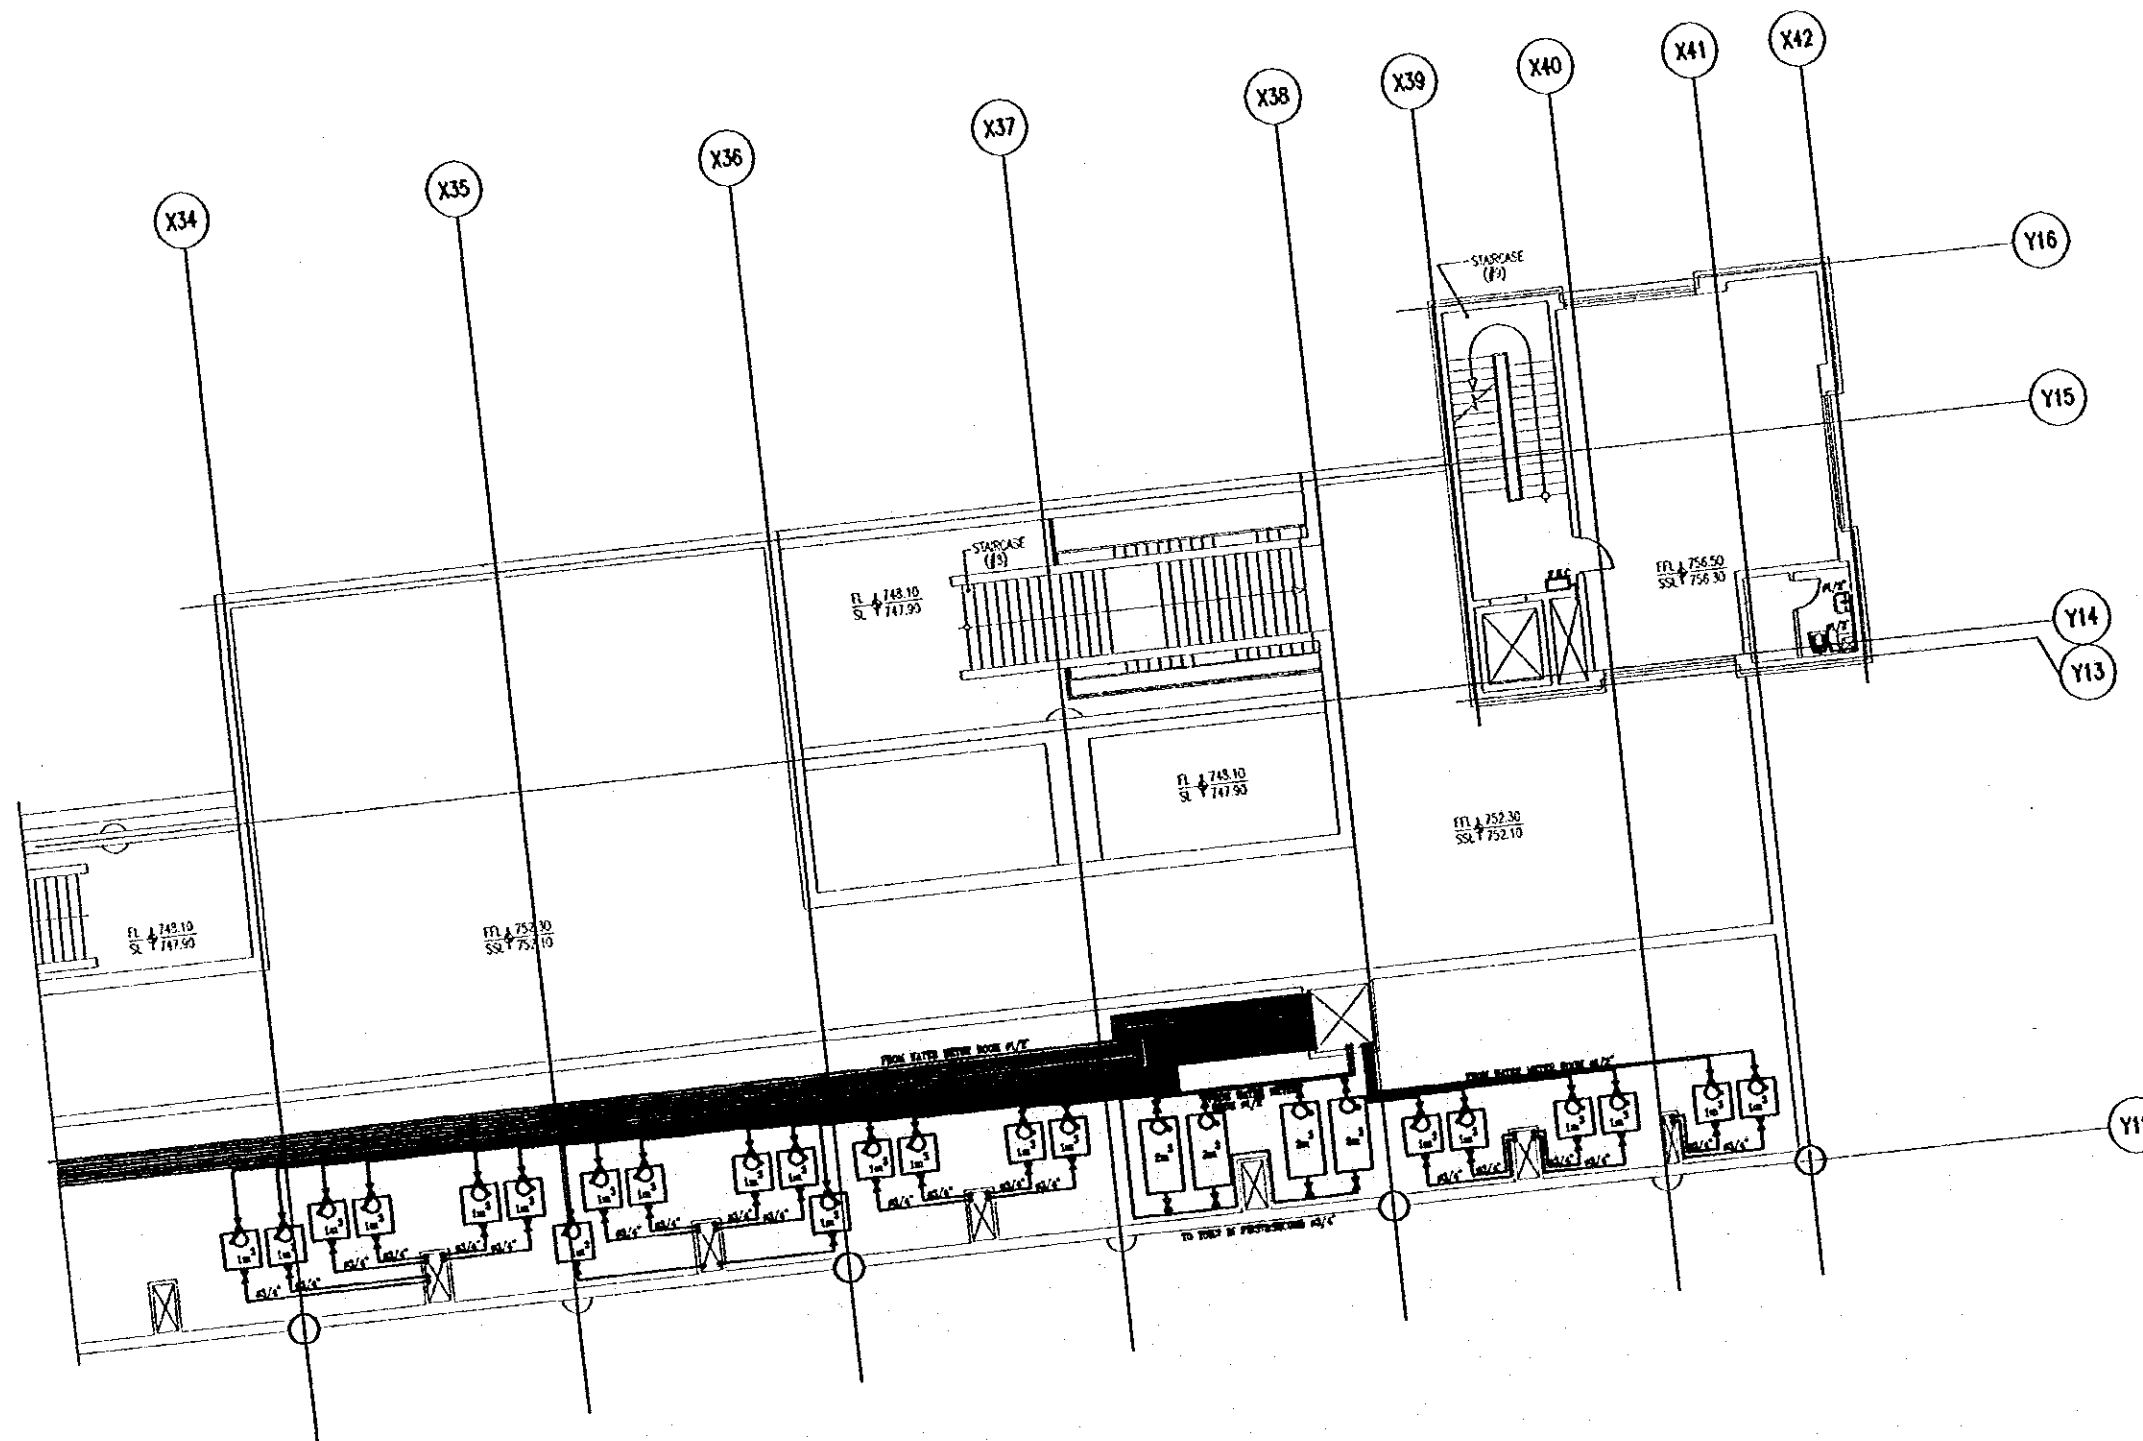


COLD WATER SYSTEM & FIRE FIGHTING SYSTEM

Designed by:
Japan International Cooperation Agency
(JICA)

JICA Study Team:
Joint Venture of
Pacific Consultants International and
Yamato Sekkei Inc.

Subcontracted Local Consultant:

TRAH Consultants
Architects, Engineers


Raghadan Bus Terminal

Drawing Title:
COLD WATER SYSTEM
FOR THIRD FLOOR ZONE 5


Scale: 1/100 Drawing Nos: RBT .M419

Tourism Sector Development Project
in the Hashemite Kingdom of Jordan

The Government of
the Hashemite Kingdom of Jordan
The Ministry of Tourism and Antiquities
The Ministry of Planning

Sub-Project:
Amman Downtown
Tourist Zone Development

Note:
- This detailed design has been prepared by a team of
consultants as shown below in accordance with the agreement
between Japan International Cooperation Agency (JICA) and
JICA Study Team.
- The copyright of this drawing rests with JICA.

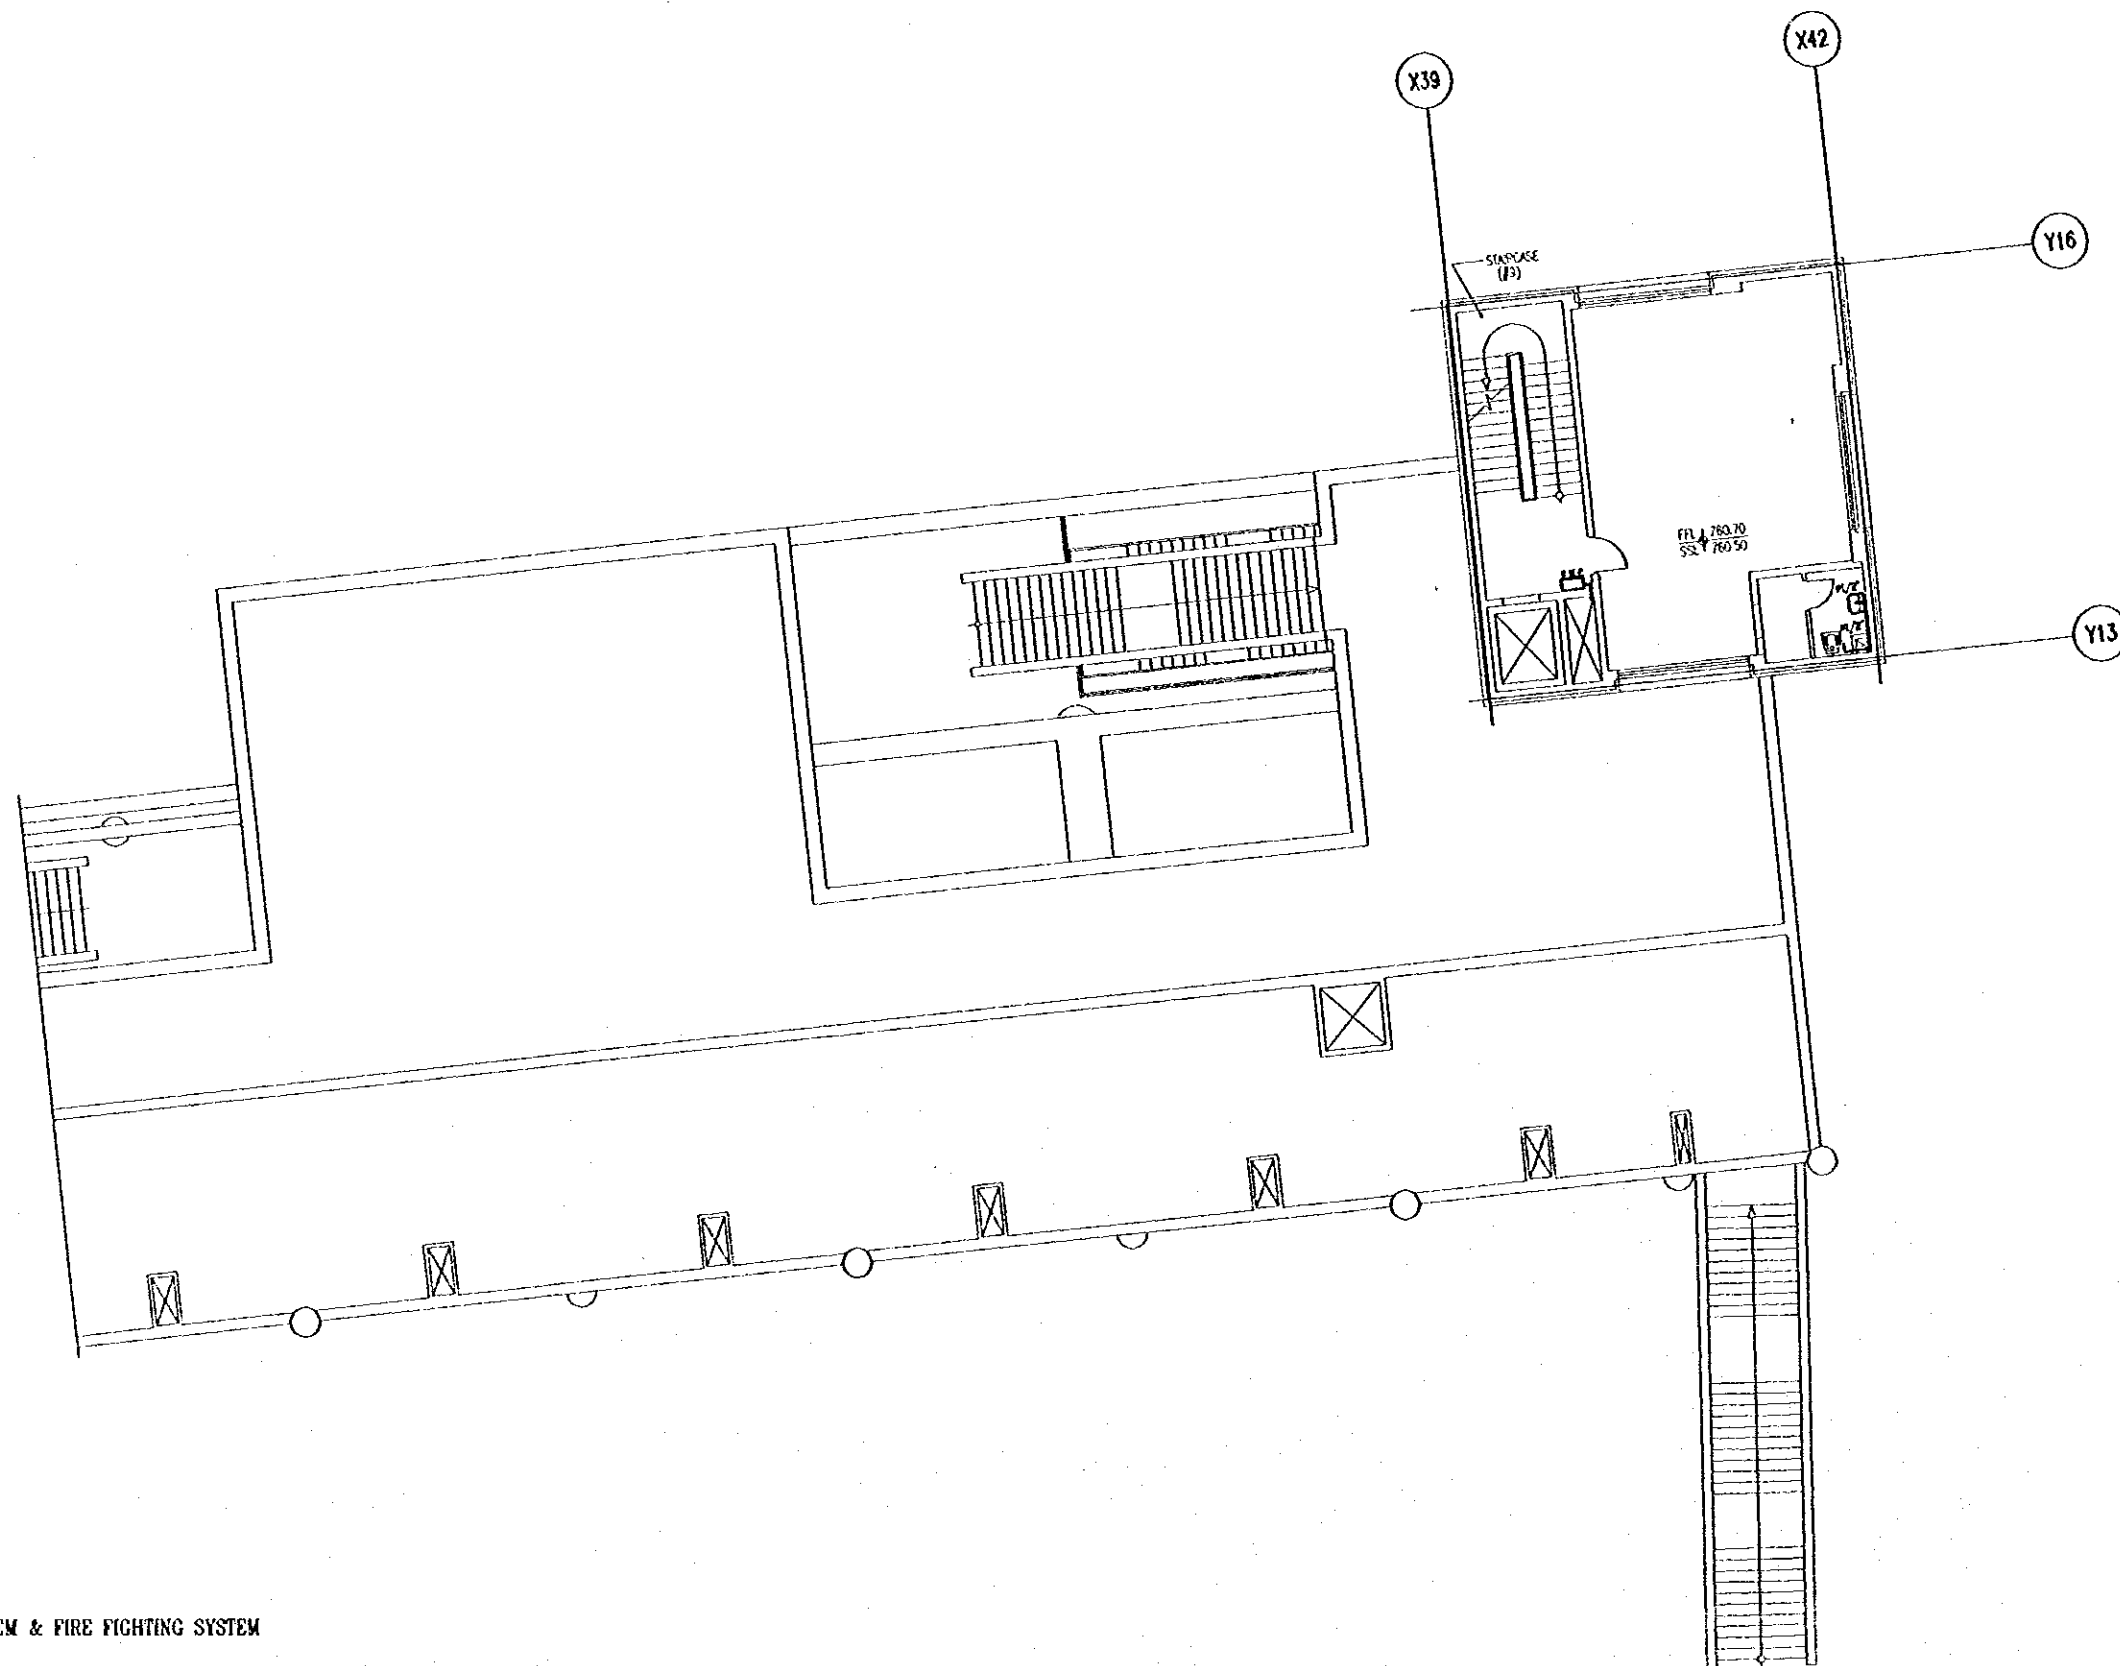


COLD WATER SYSTEM & FIRE FIGHTING SYSTEM

Designed by:
Japan International Cooperation Agency
(JICA)
JICA Study Team:
Joint Venture of
Pacific Consultants International and
Yamashita Seltrei Inc.
Subcontracted Local Consultant:
PMAH Consultants
Architects, Engineers

Raghadan Bus Terminal

Drawing Title:
COLD WATER SYSTEM
FOR FORTH FLOOR ZONE 5

Scale: 1/100
Drawing No: RBT .M420

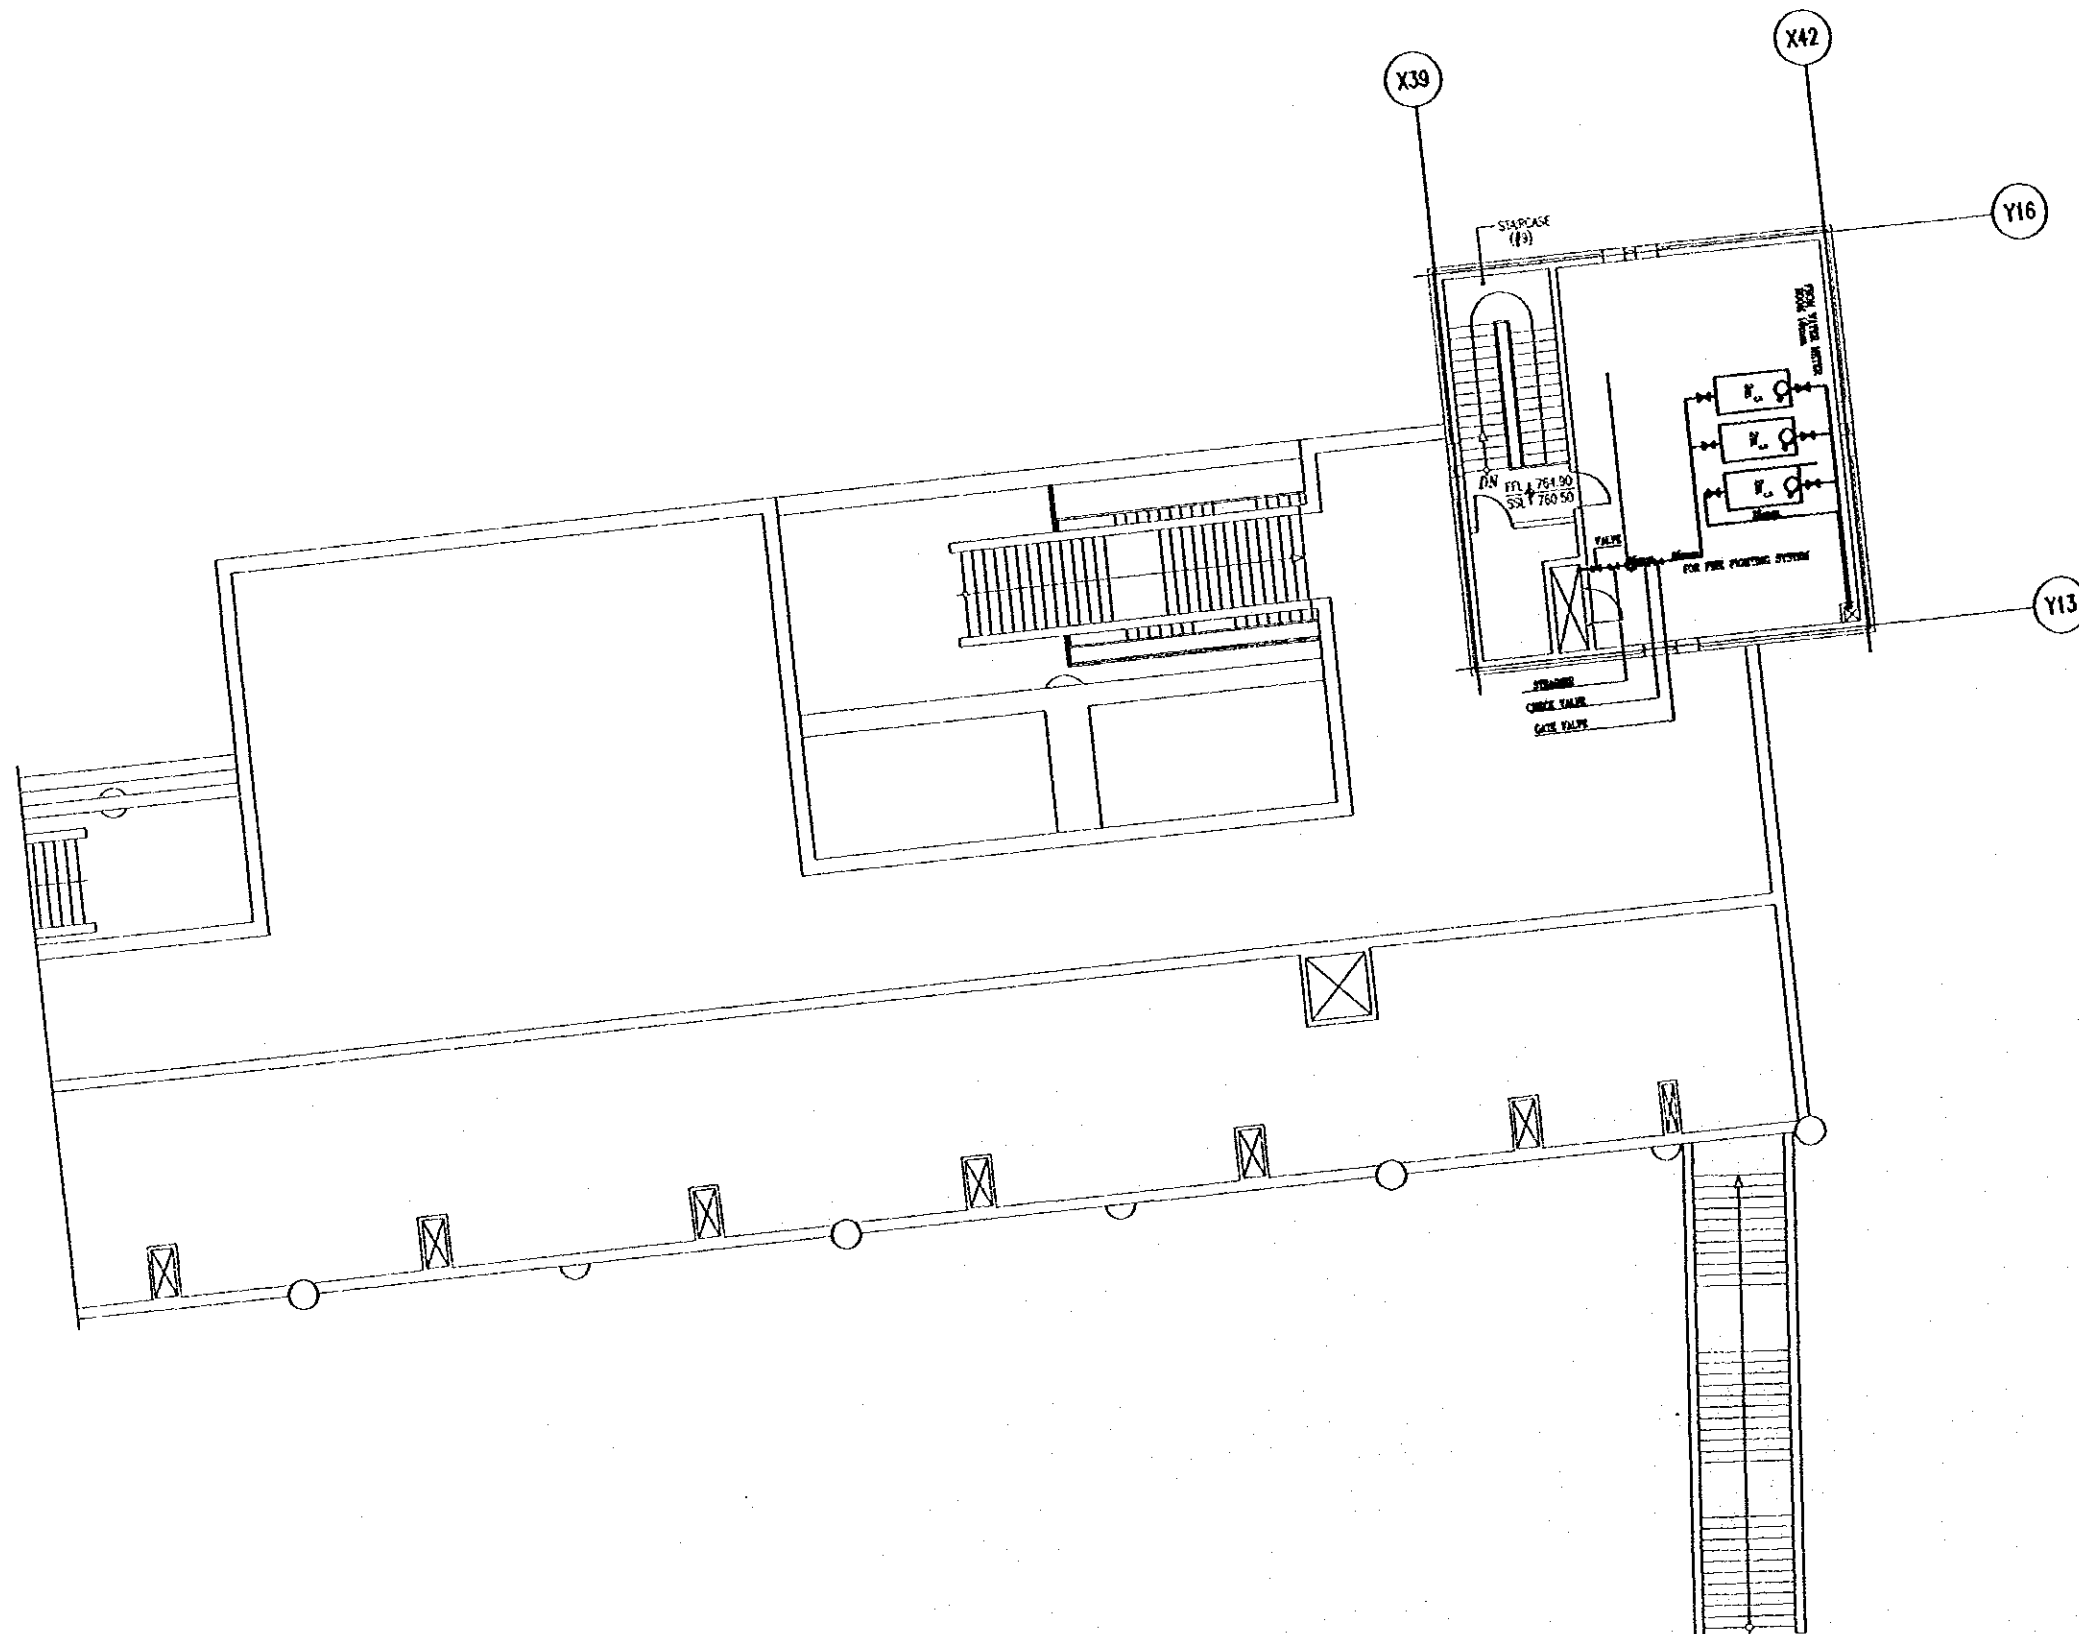

Tourism Sector Development Project
 in the Hashemite Kingdom of Jordan
 The Government of
 the Hashemite Kingdom of Jordan
 The Ministry of Tourism and Antiquities
 The Ministry of Planning


Sub-Project:
 Amman Downtown
 Tourist Zone Development

Note:
 • This detailed design has been executed by a team of consultants as shown below in accordance with the agreement between Japan International Cooperation Agency (JICA) and JICA Study Team.
 • The copyright of this drawing rests with JICA.


Designed by:
 Japan International Cooperation Agency (JICA)
 JICA Study Team:
 Joint Venture of
 Pacific Consultants International and
 Yamashita Sekkei Inc.
 Subcontracted Local Consultant:
 TIBAN Consultants
 Architects, Engineers

Raghadan Bus Terminal
 Drawing Title:
 COLD WATER SYSTEM
 FOR FIFTH FLOOR ZONE 5

Scale: 1/100
 Drawing No.: RBT_M421

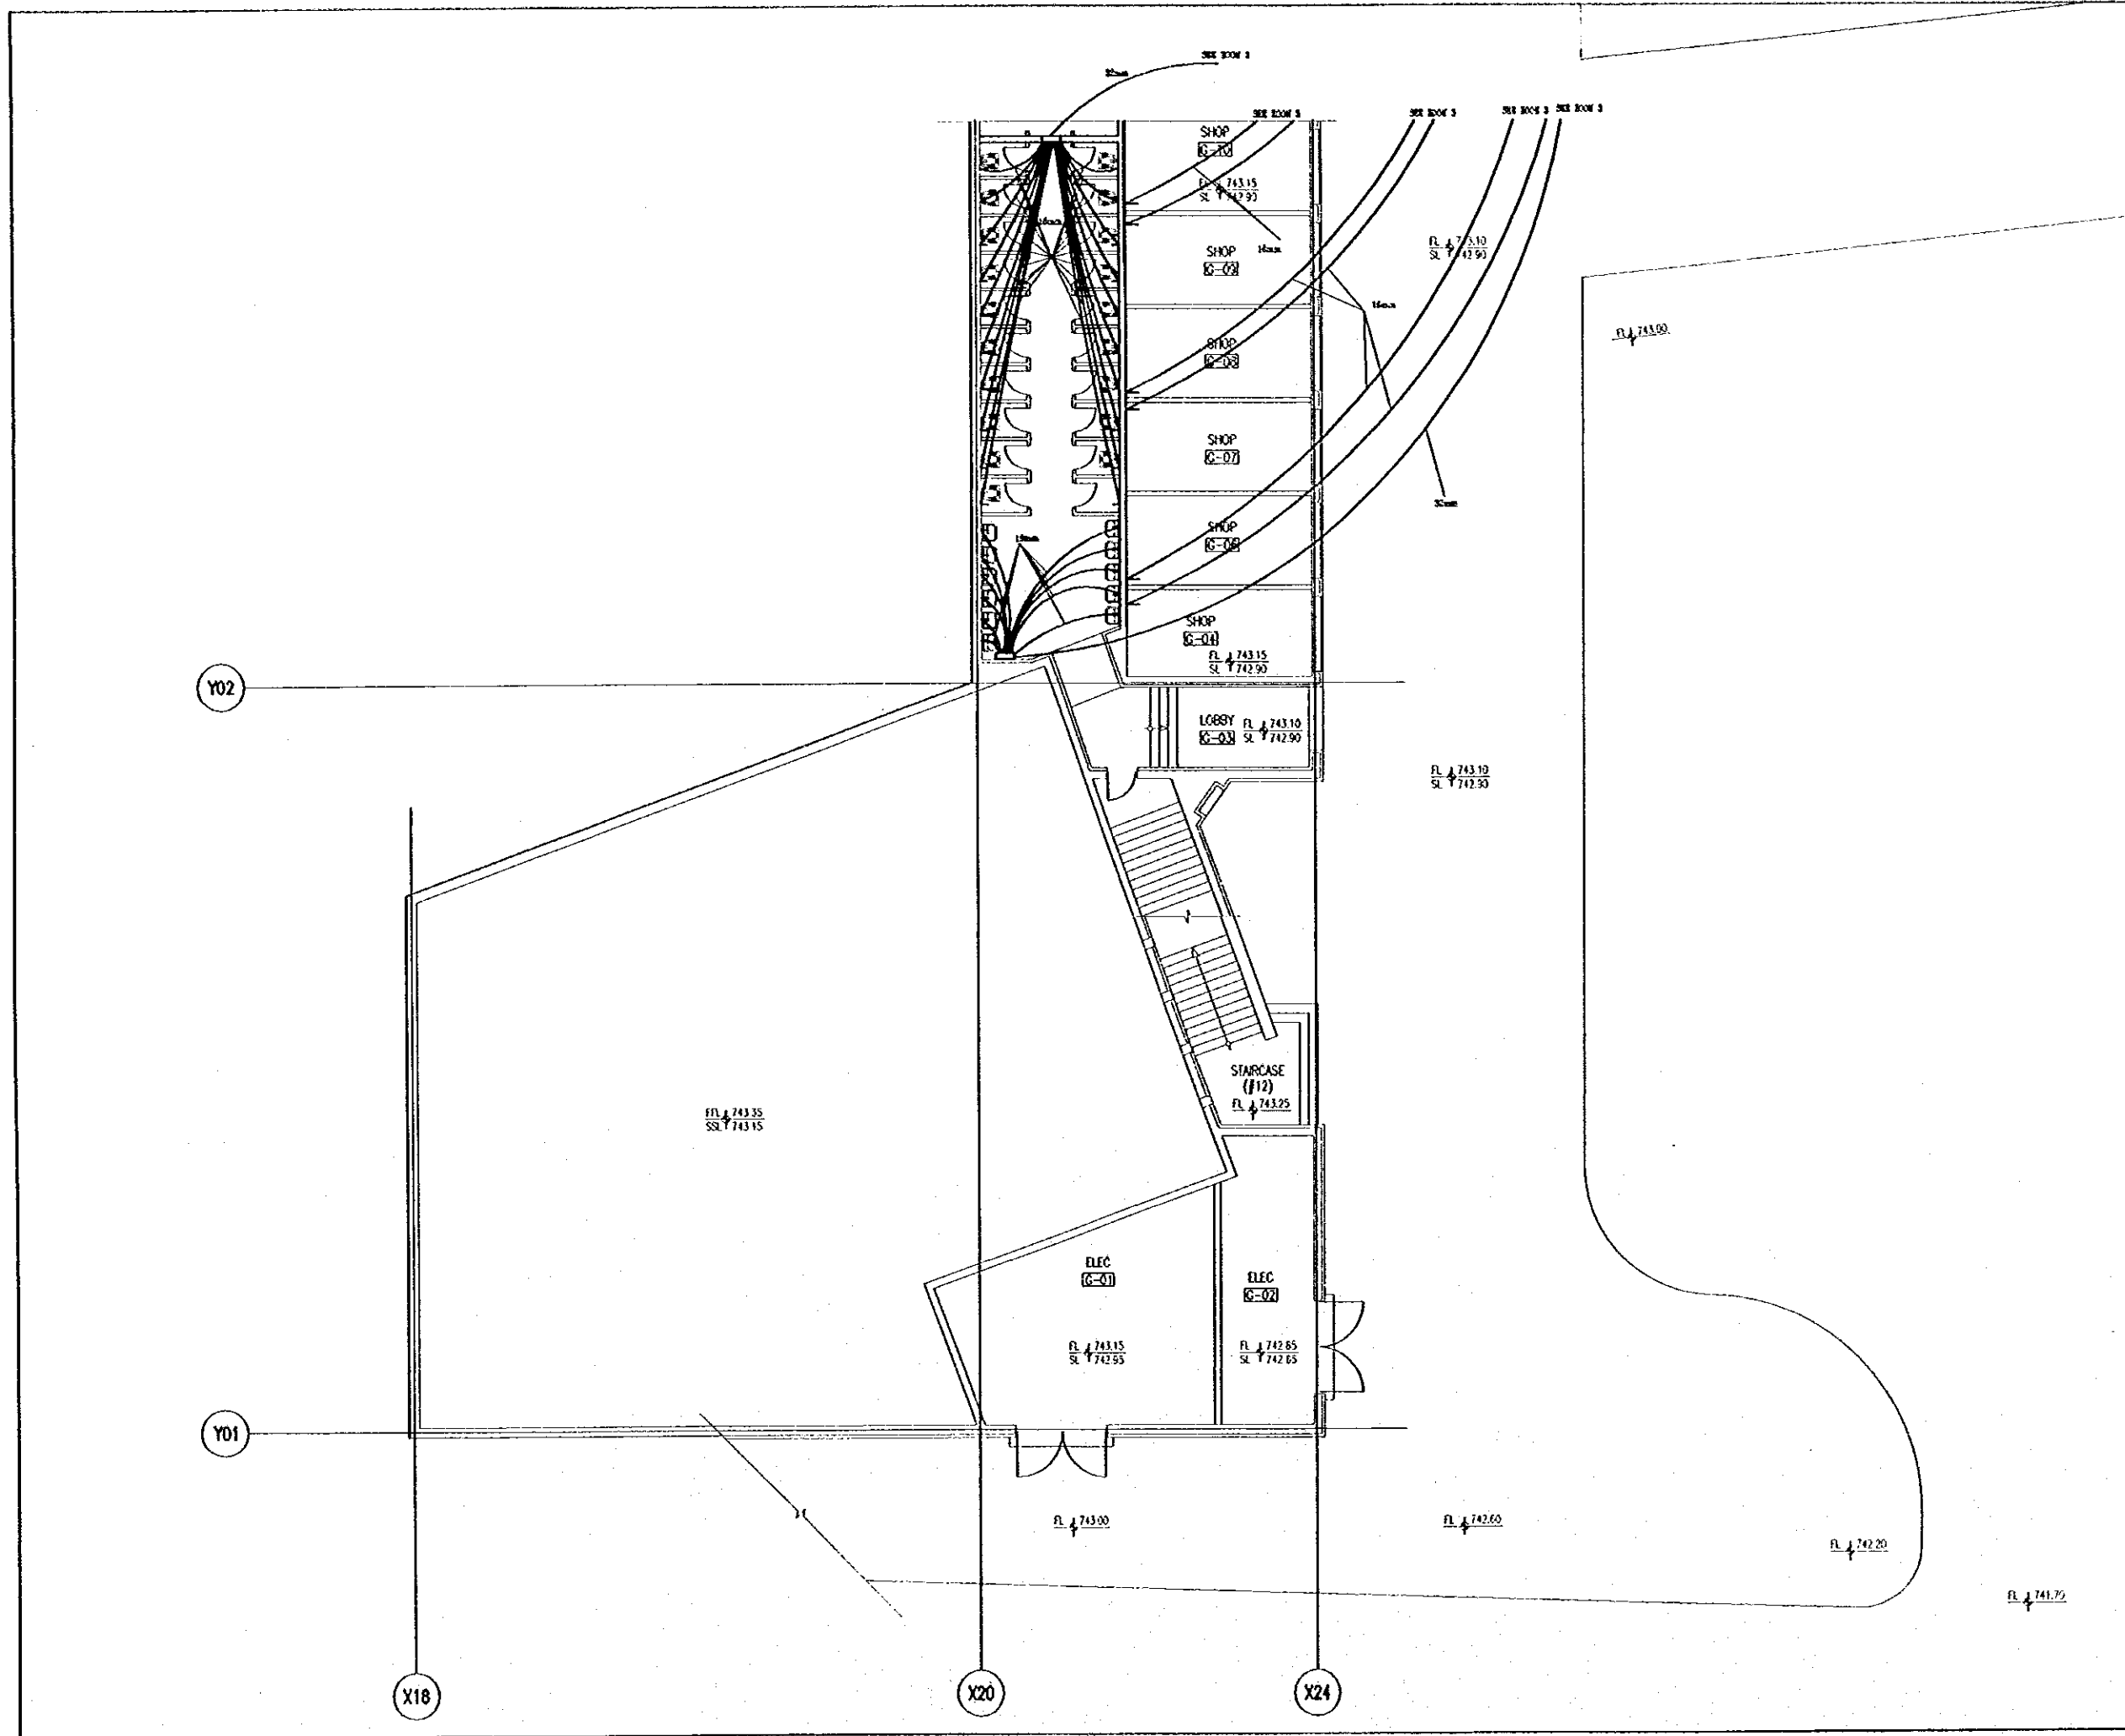

Tourism Sector Development Project in the Hashemite Kingdom of Jordan	
The Government of the Hashemite Kingdom of Jordan The Ministry of Tourism and Antiquities The Ministry of Planning	
Sub-Project: Amman Downtown Tourist Zone Development	
Note: • This detailed design has been executed by a team of consultants as shown below in accordance with the agreement between Japan International Cooperation Agency (JICA) and JICA Study Team. • The copyright of this drawing rests with JICA.	
Designed by: Japan International Cooperation Agency (JICA) JICA Study Team: Joint Venture of Pacific Consultants International and Yamashita Sekkei Inc. Subcontracted Local Consultant: TMAH Consultants Architect, Engineers	
Raghadan Bus Terminal	
Drawing Title: COLD WATER SYSTEM FOR GROUND FLOOR ZONE 6	
Scale: 1/100	Drawing No. RBT_M422

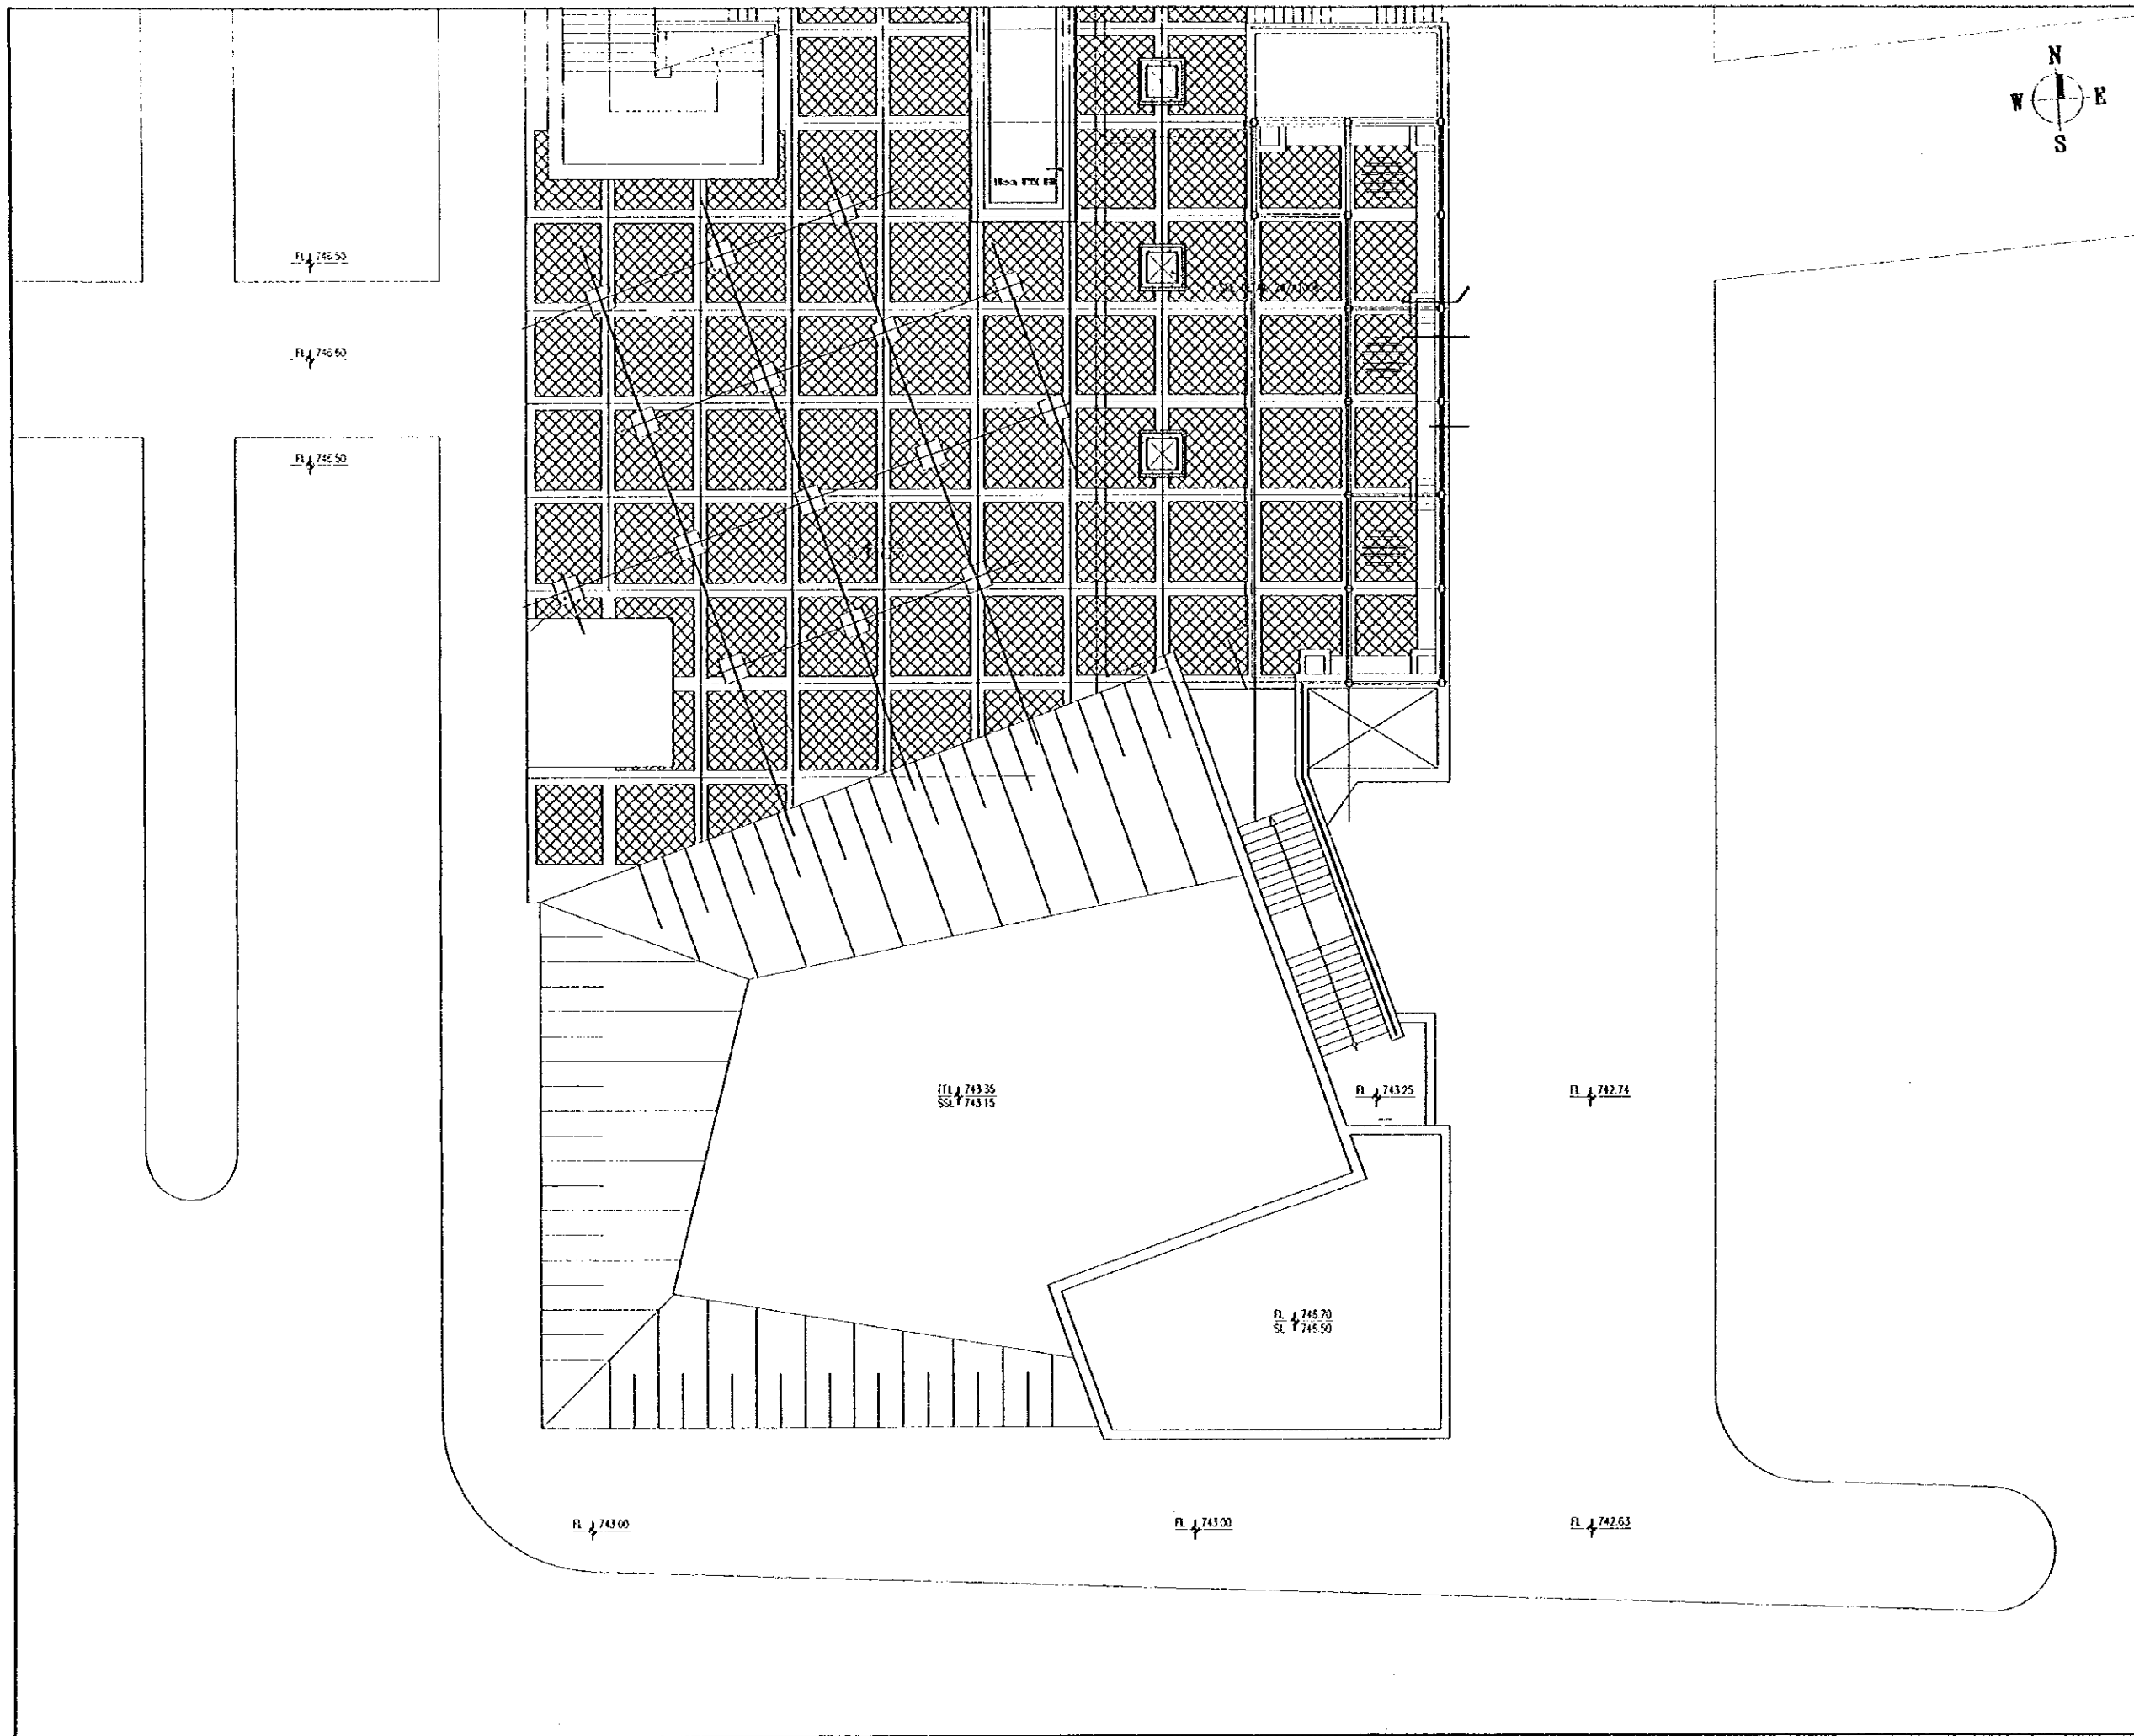

Tourism Sector Development Project
in the Hashemite Kingdom of Jordan

The Government of
the Hashemite Kingdom of Jordan
The Ministry of Tourism and Antiquities
The Ministry of Planning

Sub-Project:
Amman Downtown
Tourist Zone Development

Note:

- The detailed design has been executed by a team of consultants as shown below in accordance with the agreement between Japan International Cooperation Agency (JICA) and JICA Study Team.
- The copyright of this drawing rests with JICA.

Designed by:
Japan International Cooperation Agency (JICA)


JICA Study Team:
Joint Venture of
Pacific Consultants International and
Yamato Seikai Inc.

Subcontracted Local Consultant:
TIBAH Consultants
Architects, Engineers


Raghadan Bus Terminal

Drawing Title:
**COLD WATER SYSTEM
FOR FIRST FLOOR ZONE 6**


Scale: **1/100** Drawing No: **RBT .M423**

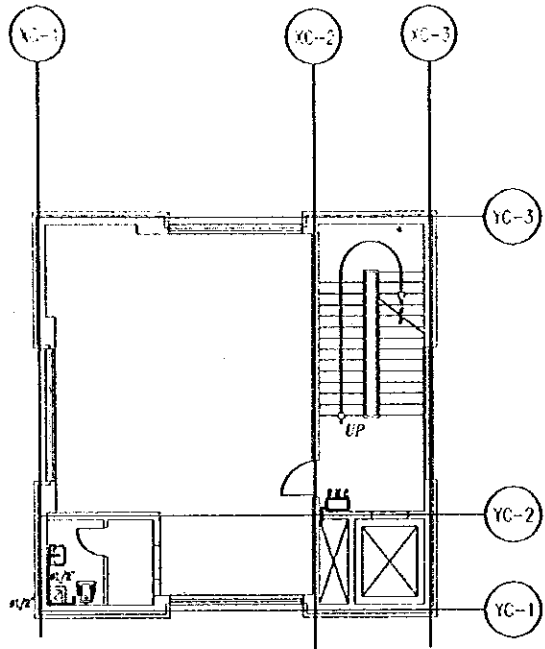


THIRD FLOOR PLAN

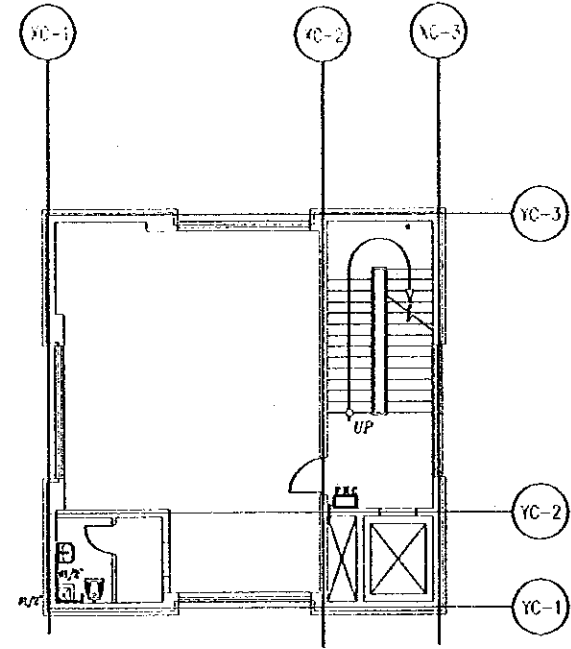


SECOND FLOOR PLAN

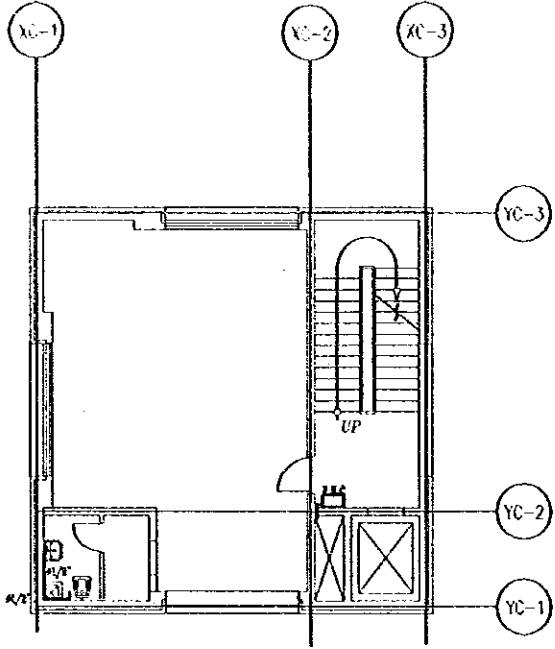


FIRST FLOOR PLAN

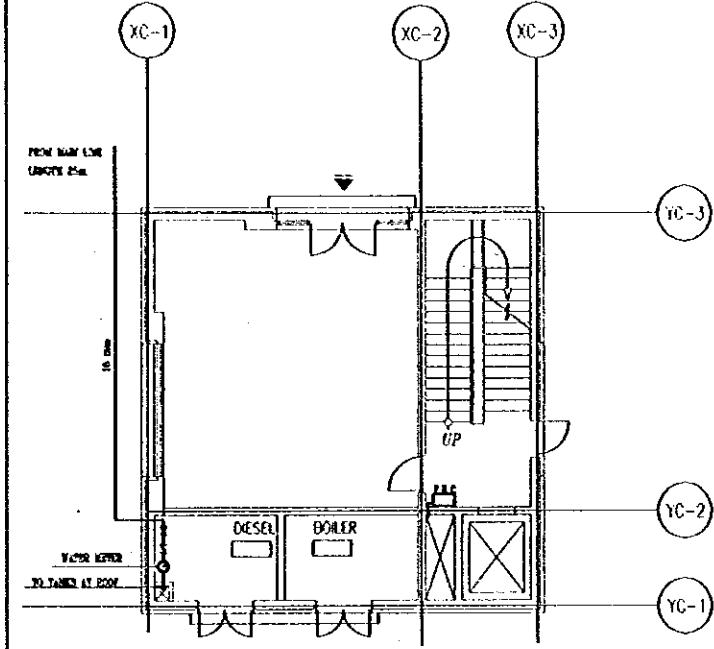

GROUND FLOOR PLAN

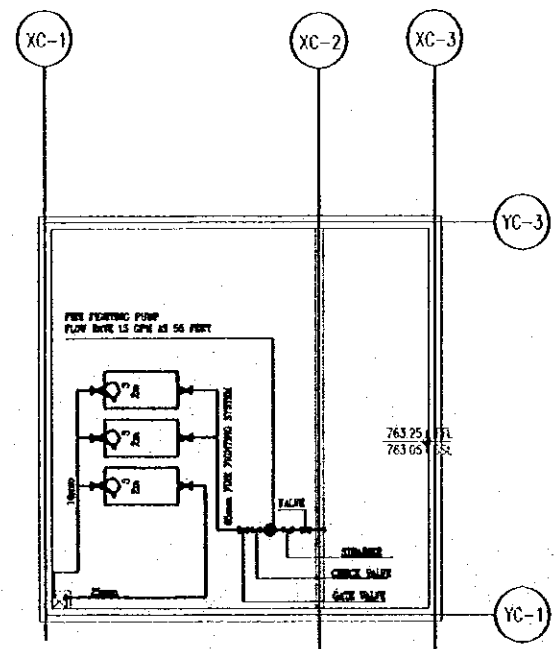

ROOF PLAN

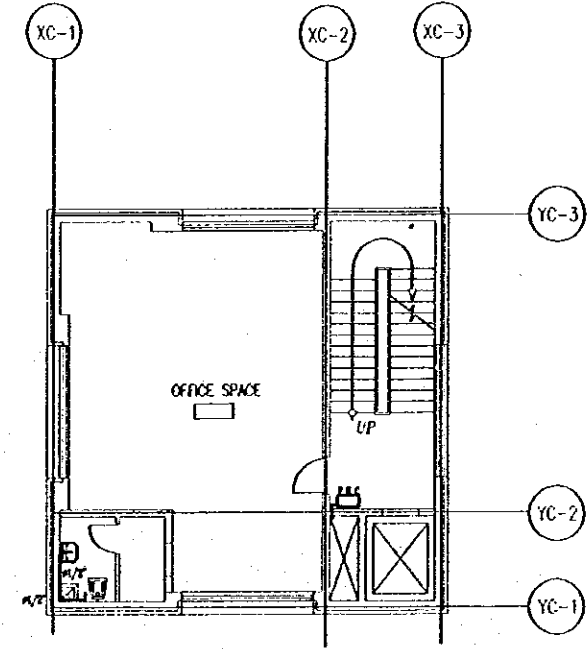

FOURTH FLOOR PLAN

Tourism Sector Development Project
In the Hashemite Kingdom of Jordan

The Government of
the Hashemite Kingdom of Jordan
The Ministry of Tourism and Antiquities
The Ministry of Planning

Sub-Project:
Amman Downtown
Tourist Zone Development

Note:
• This detailed design has been executed by a team of consultants as shown below in accordance with the agreement between Japan International Cooperation Agency (JICA) and JICA Study Team.
• The copyright of this drawing rests with JICA.

Designed by:
Japan International Cooperation Agency (JICA)

JICA Study Team:
Joint Venture of
Pacific Consultants International and
Yamashita Sekkei Inc.


Subcontracted Local Consultant:
TBAH Consultants
Architects, Engineers

Raghadan Bus Terminal


Drawing Title:
COLD WATER & FIRE FIGHTING
SYSTEM FOR ZONE 7

Scale:
1/100


Drawing No.
RBT M-424

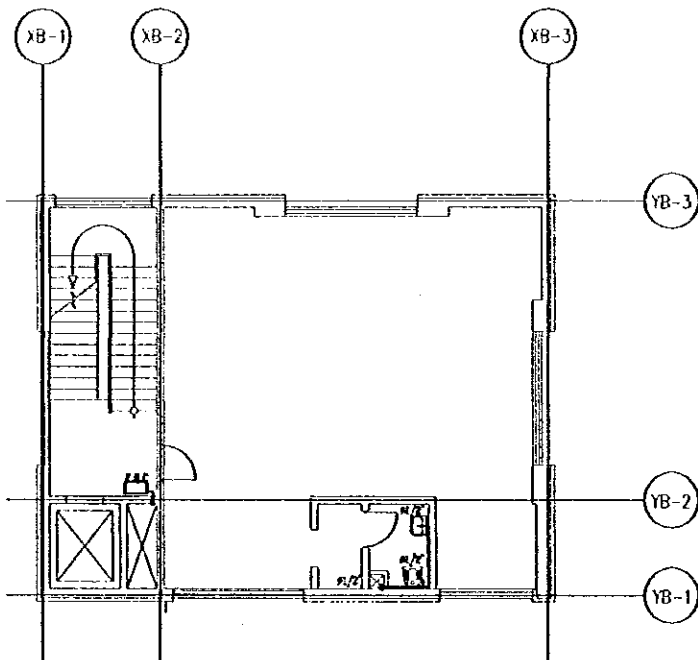


THIRD FLOOR PLAN

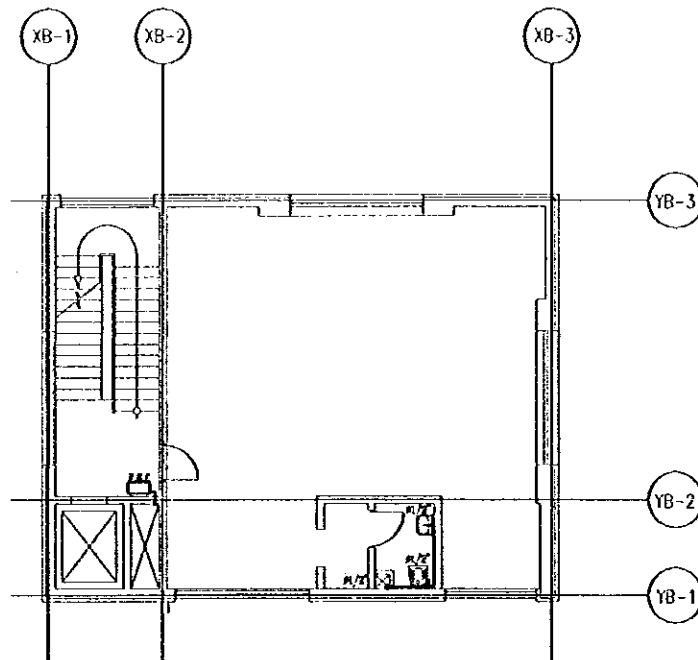


SECOND FLOOR PLAN

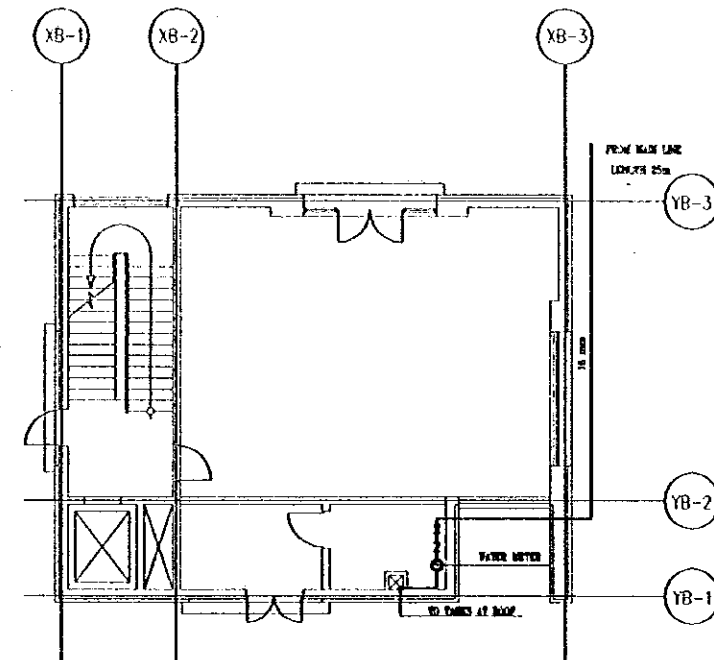

FIRST FLOOR PLAN

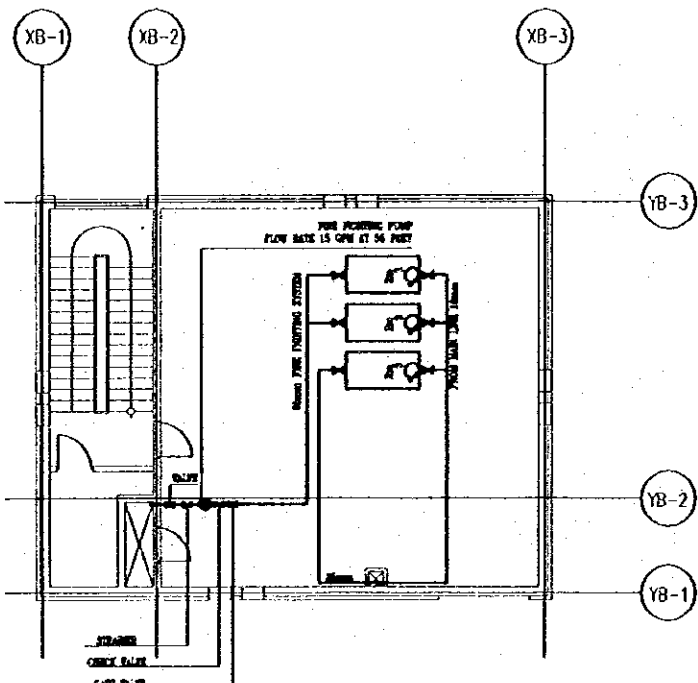

FIFTH FLOOR PLAN

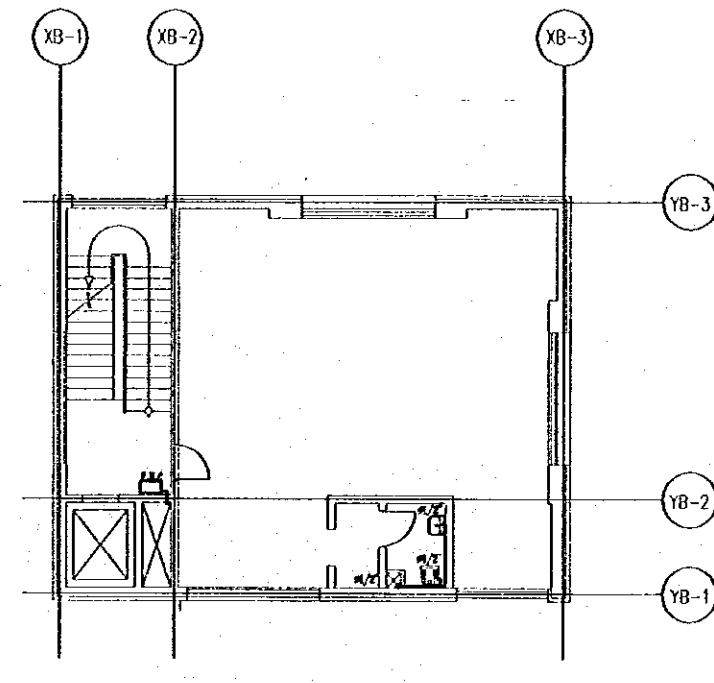

FOURTH FLOOR PLAN

Tourism Sector Development Project
in the Hashemite Kingdom of Jordan

The Government of
the Hashemite Kingdom of Jordan
The Ministry of Tourism and Antiquities
The Ministry of Planning

Sub-Project:
Amman Downtown
Tourist Zone Development

Note:
• The detailed design has been executed by a team of
consultants as shown below in accordance with the agreement
between Japan International Cooperation Agency (JICA) and
JICA Study Team.

• The copyright of this drawing rests with JICA.

Designed by:
Japan International Cooperation Agency
(JICA)
JICA Study Team:
Joint Venture of
Pacific Consultants International and
Yamashita Sekkei Inc.
Subcontracted Local Consultant:
RBAH Consultants
Architects, Engineers

Raghadan Bus Terminal
Drawing Title:
COLD WATER & FIRE FIGHTING
SYSTEM FOR ZONE 8


Scale: 1/100
Drawing No: RBT M-425

Tourism Sector Development Project
in the Hashemite Kingdom of Jordan

The Government of
the Hashemite Kingdom of Jordan
The Ministry of Tourism and Antiquities
The Ministry of Planning

Sub-Project:
Amman Downtown
Tourist Zone Development


Note:
• This detailed design has been executed by a team of
consultants as shown below in accordance with the agreement
between Japan International Cooperation Agency (JICA) and
JICA Study Team.
• The copyright of this drawing rests with JICA.

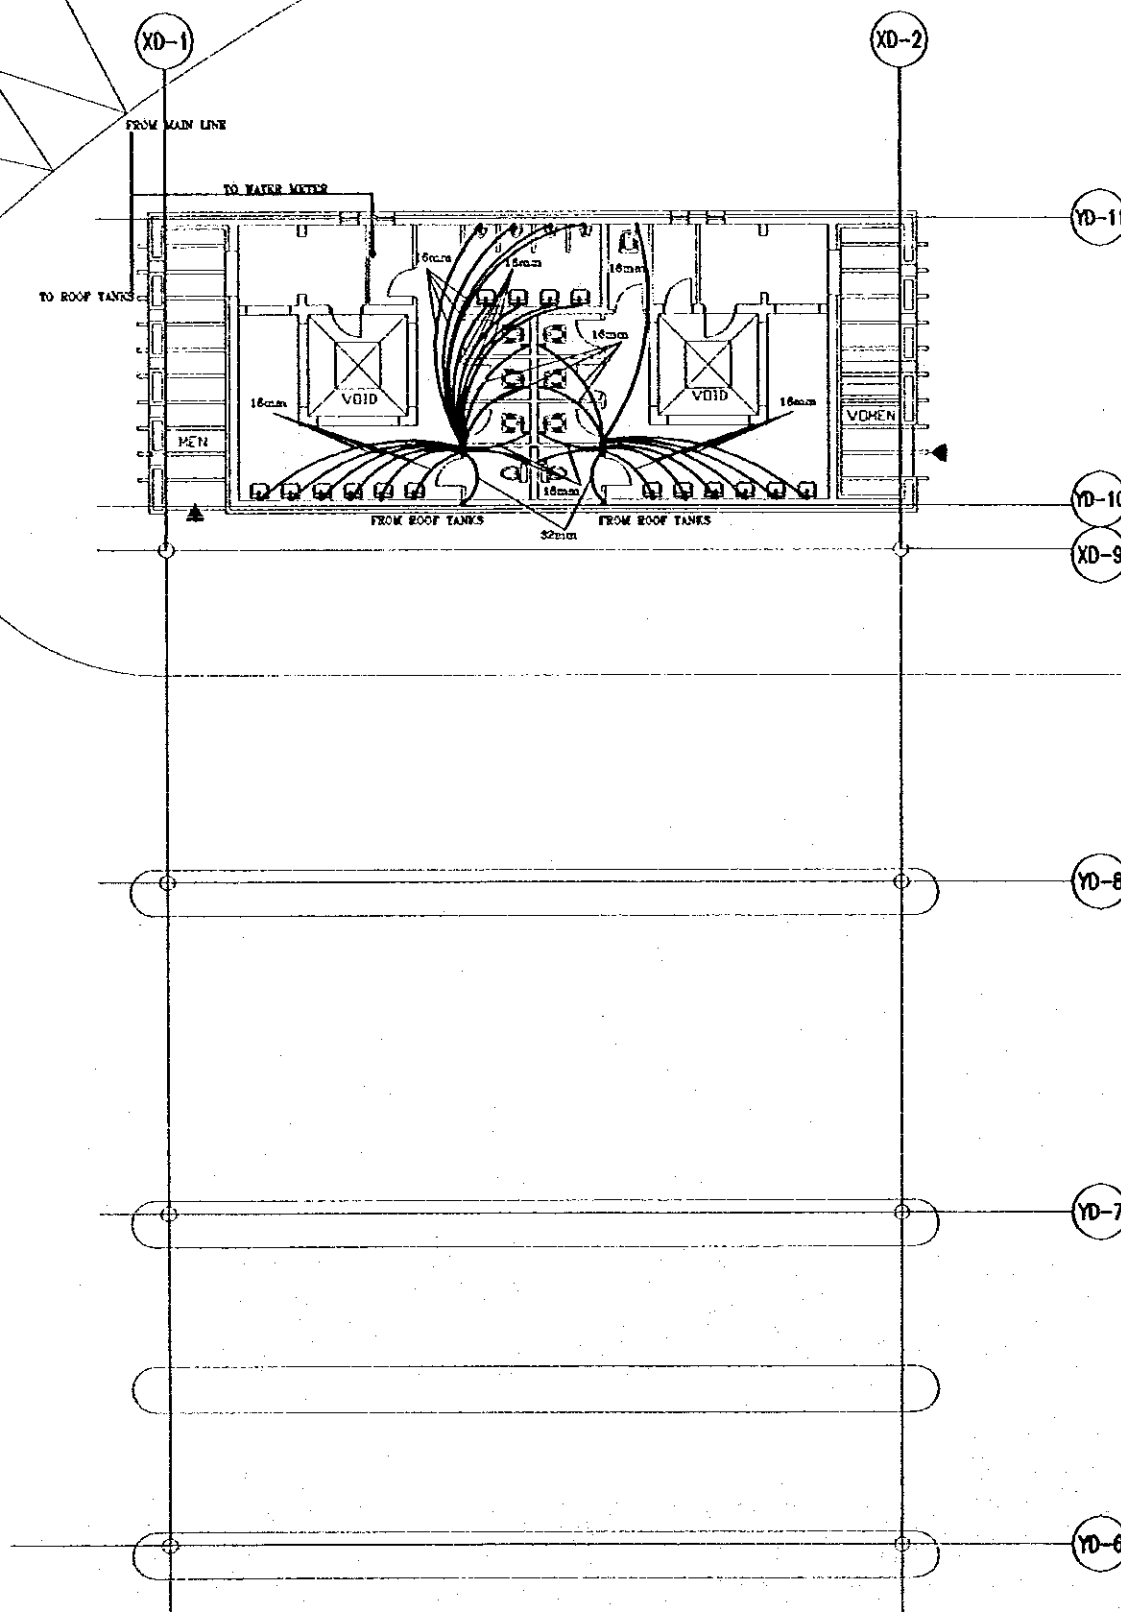

Designed by:
Japan International Cooperation Agency
(JICA)

JICA Study Team:
Joint Venture of
Pacific Consultants International and
Yamashita Sekkei Inc.


Subcontracted Local Consultant:

TBAH Consultants
Architects, Engineers


Raghadan Bus Terminal

Drawing title:
COLD WATER SYSTEM FOR
GROUND FLOOR ZONE 9

Scale: 1/100 Drawing No: RBT M-426

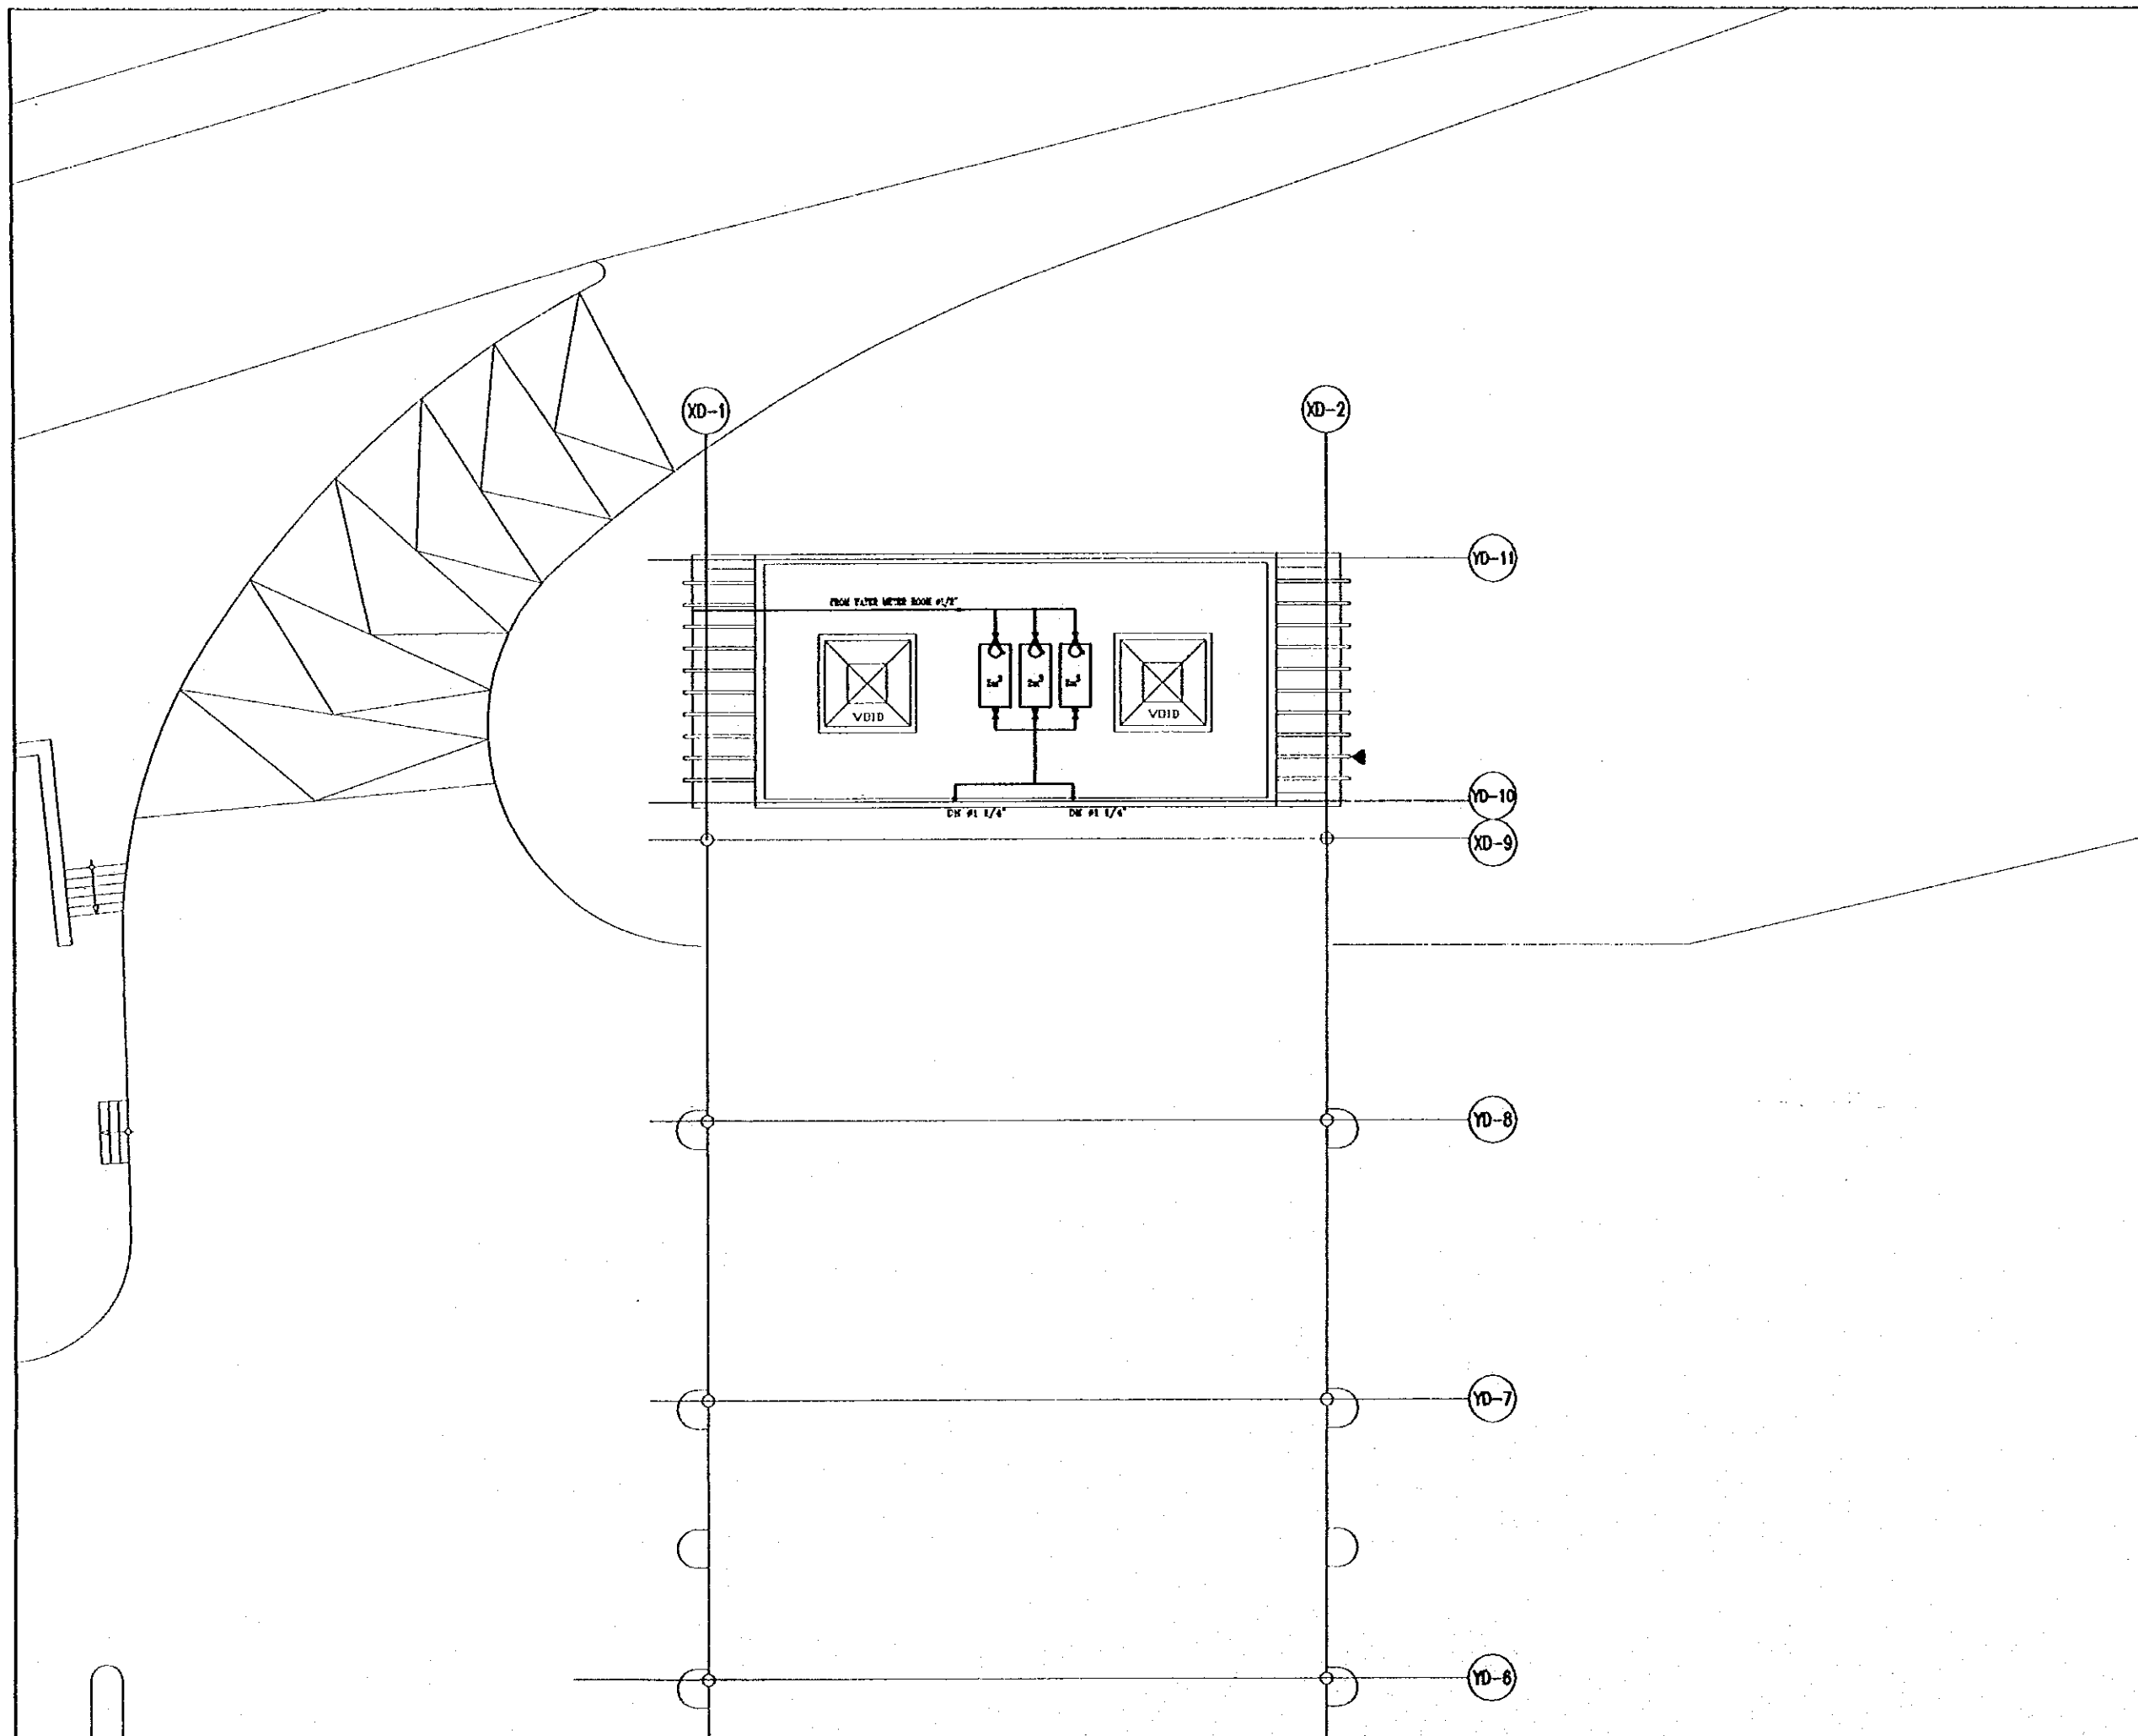

Tourism Sector Development Project
 In the Hashemite Kingdom of Jordan

The Government of
 the Hashemite Kingdom of Jordan
 The Ministry of Tourism and Antiquities
 The Ministry of Planning

Sub-Project:
 Amman Downtown
 Tourist Zone Development

Note:
 • This detailed design has been executed by a team of consultants as shown below in accordance with the agreement between Japan International Cooperation Agency (JICA) and JICA Study Team.
 • The copyright of this drawing rests with JICA.

Designed by:
 Japan International Cooperation Agency (JICA)


JICA Study Team:
 Joint Venture of
 Pacific Consultants International and
 Yamashita Sekkei Inc.

Subcontracted Local Consultant:
 TIBAH Consultants
 Architects, Engineers

Raghadan Bus Terminal

Drawing Title:
**COLD WATER SYSTEM
 ROOF FLOOR ZONE 9**

Scale: 1/100
 Drawing No: RBTM-427

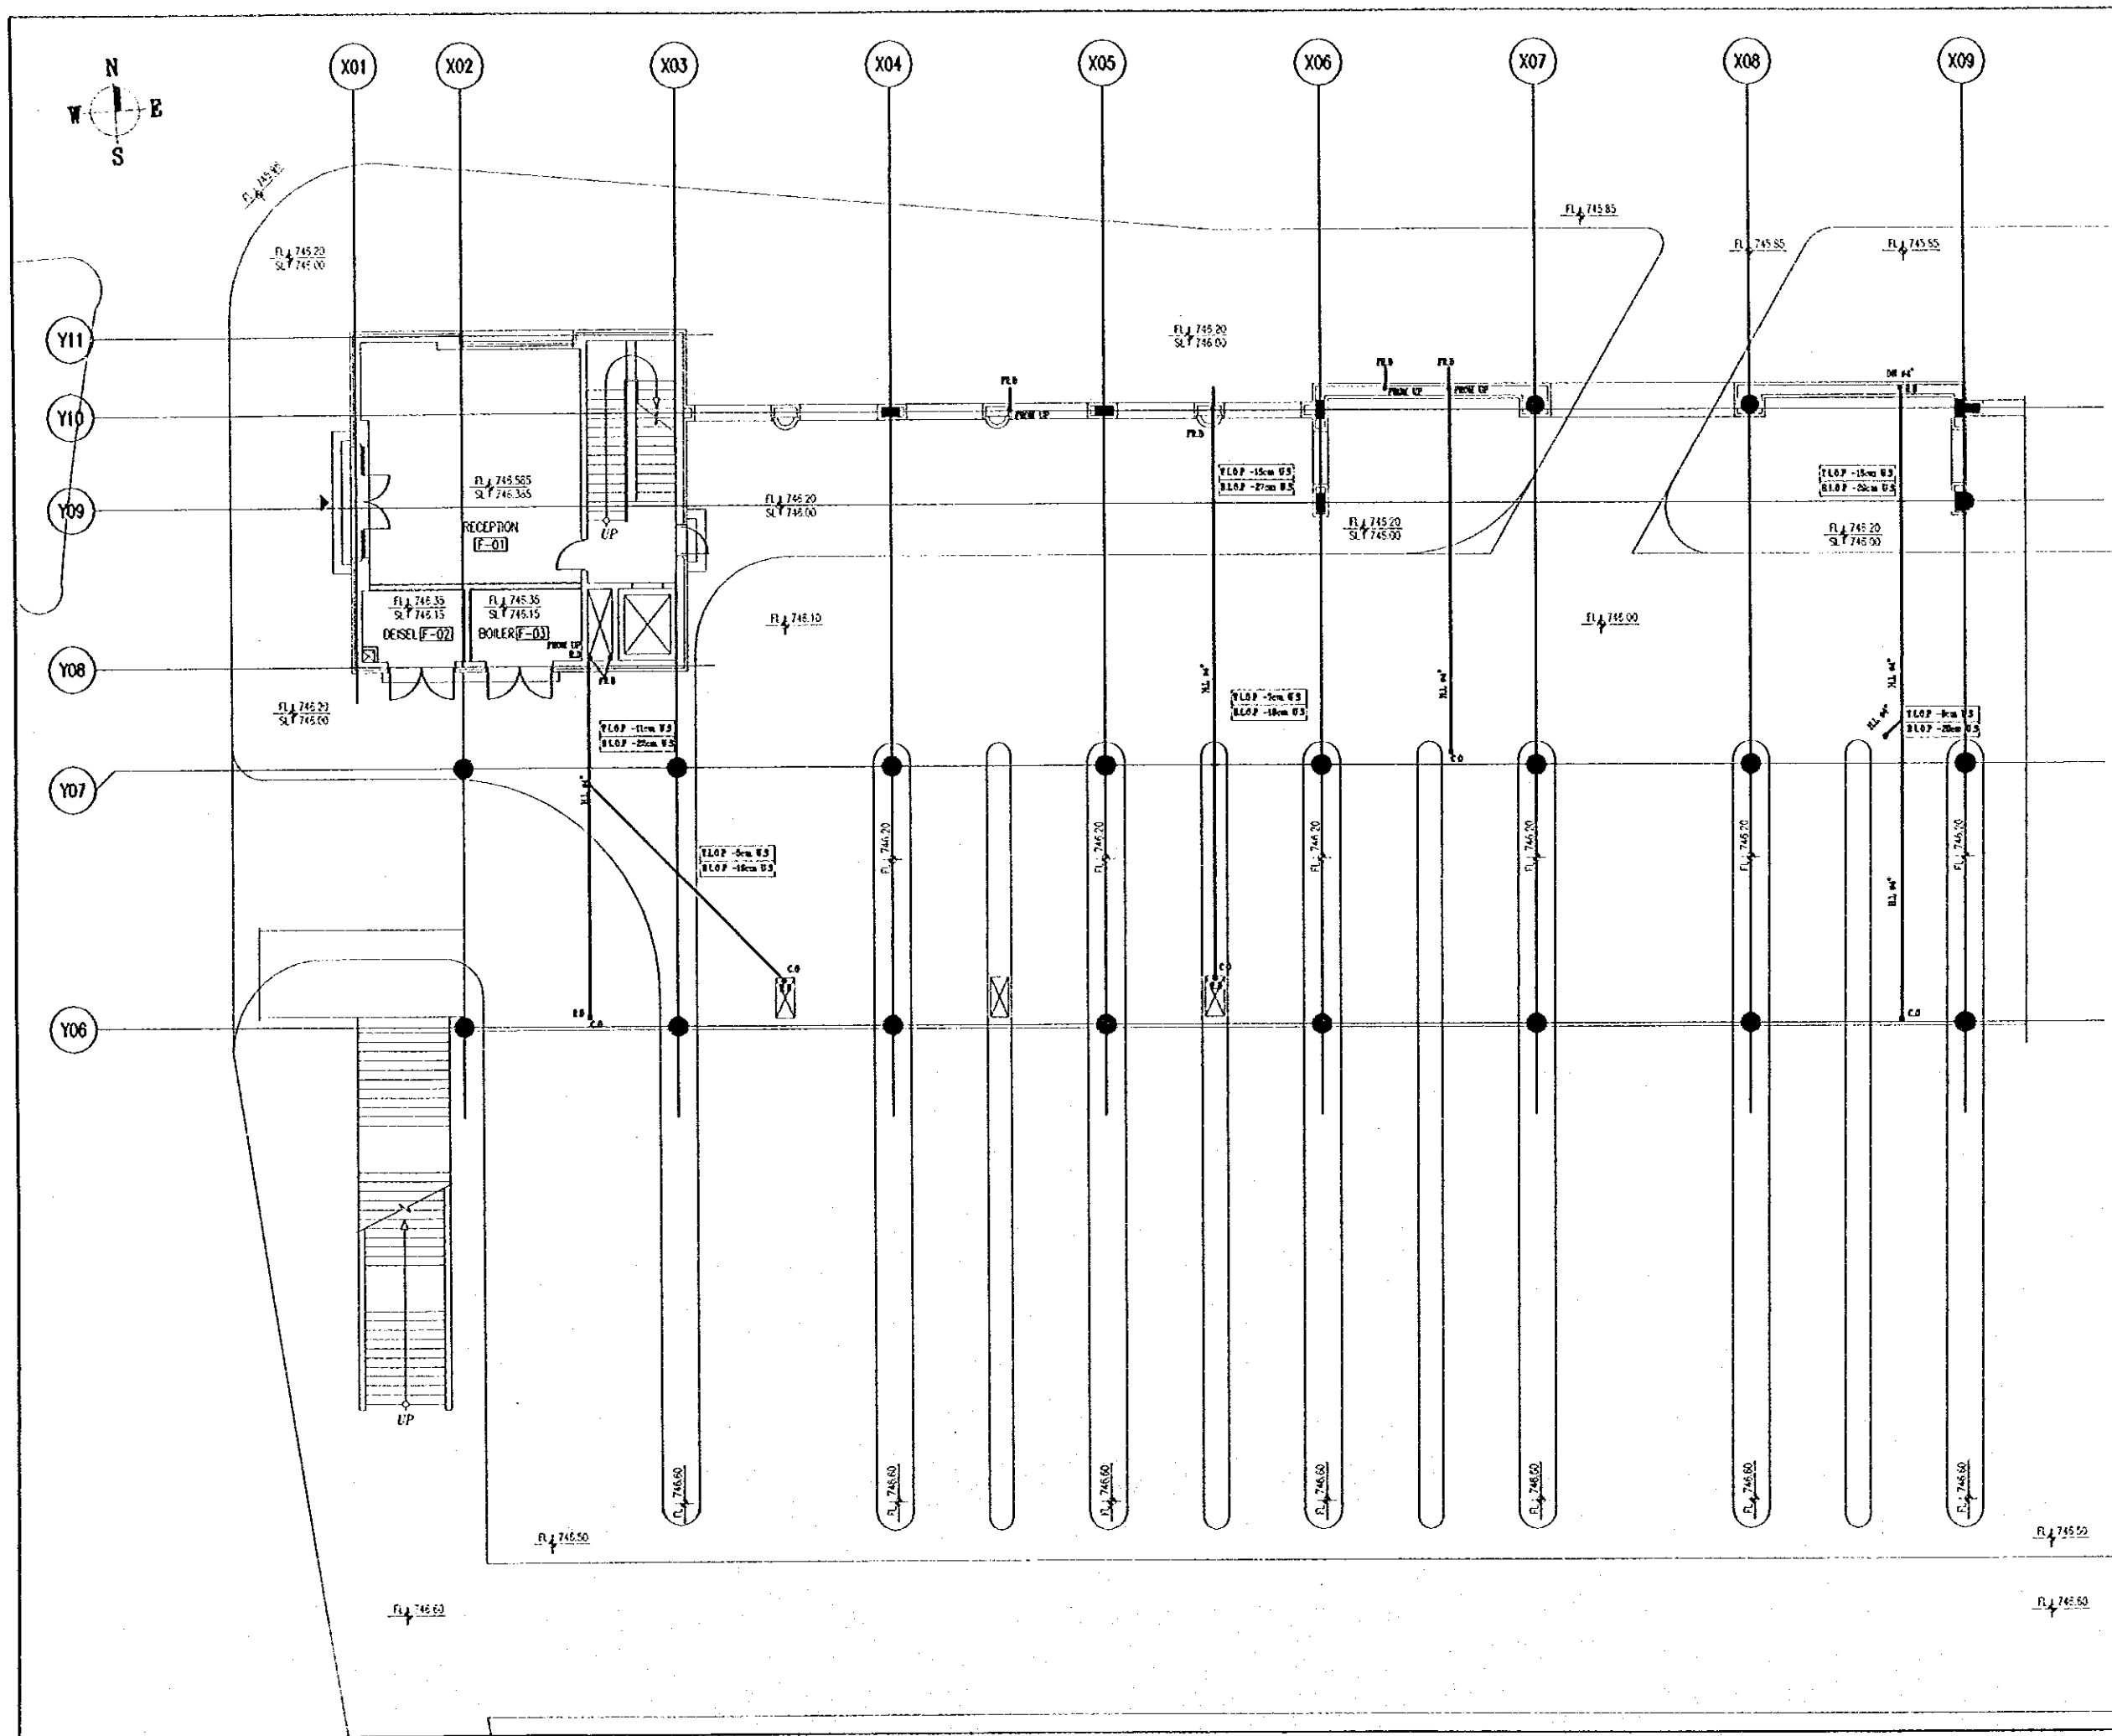

Tourism Sector Development Project
in the Hashemite Kingdom of Jordan

The Government of
the Hashemite Kingdom of Jordan
The Ministry of Tourism and Antiquities
The Ministry of Planning

Sub-Project:
Amman Downtown
Tourist Zone Development

Note:
- This detailed design has been executed by a team of
consultants as shown below in accordance with the agreement
between Japan International Cooperation Agency (JICA) and
JICA Study Team.
- The copyright of this drawing rests with JICA.


NOTE :-
FD :- FLOOR DRAIN
C.O. :- CLEANOUT
U.T :- UNDER TILE
U.S :- UNDER SLAB
FRD :- FREE DISCHARGE
U.G :- UNDER GROUND
T.L.O.P :- TOP LEVEL OF PIPE
B.L.O.P :- BOTTOM LEVEL OF PIPE

Designed by:
Japan International Cooperation Agency
(JICA)
JICA Study Team:
Joint Venture of
Pacific Consultants International and
Yamasa Sekkei Inc.
Subcontracted Local Consultant:
IBAH Consultants
Architect, Engineers

Raghadan Bus Terminal

Drawing Title:
RAIN WATER SYSTEM
FOR FIRST FLOOR ZONE 1

Scale: 1/100 Drawing No: RBT .M501

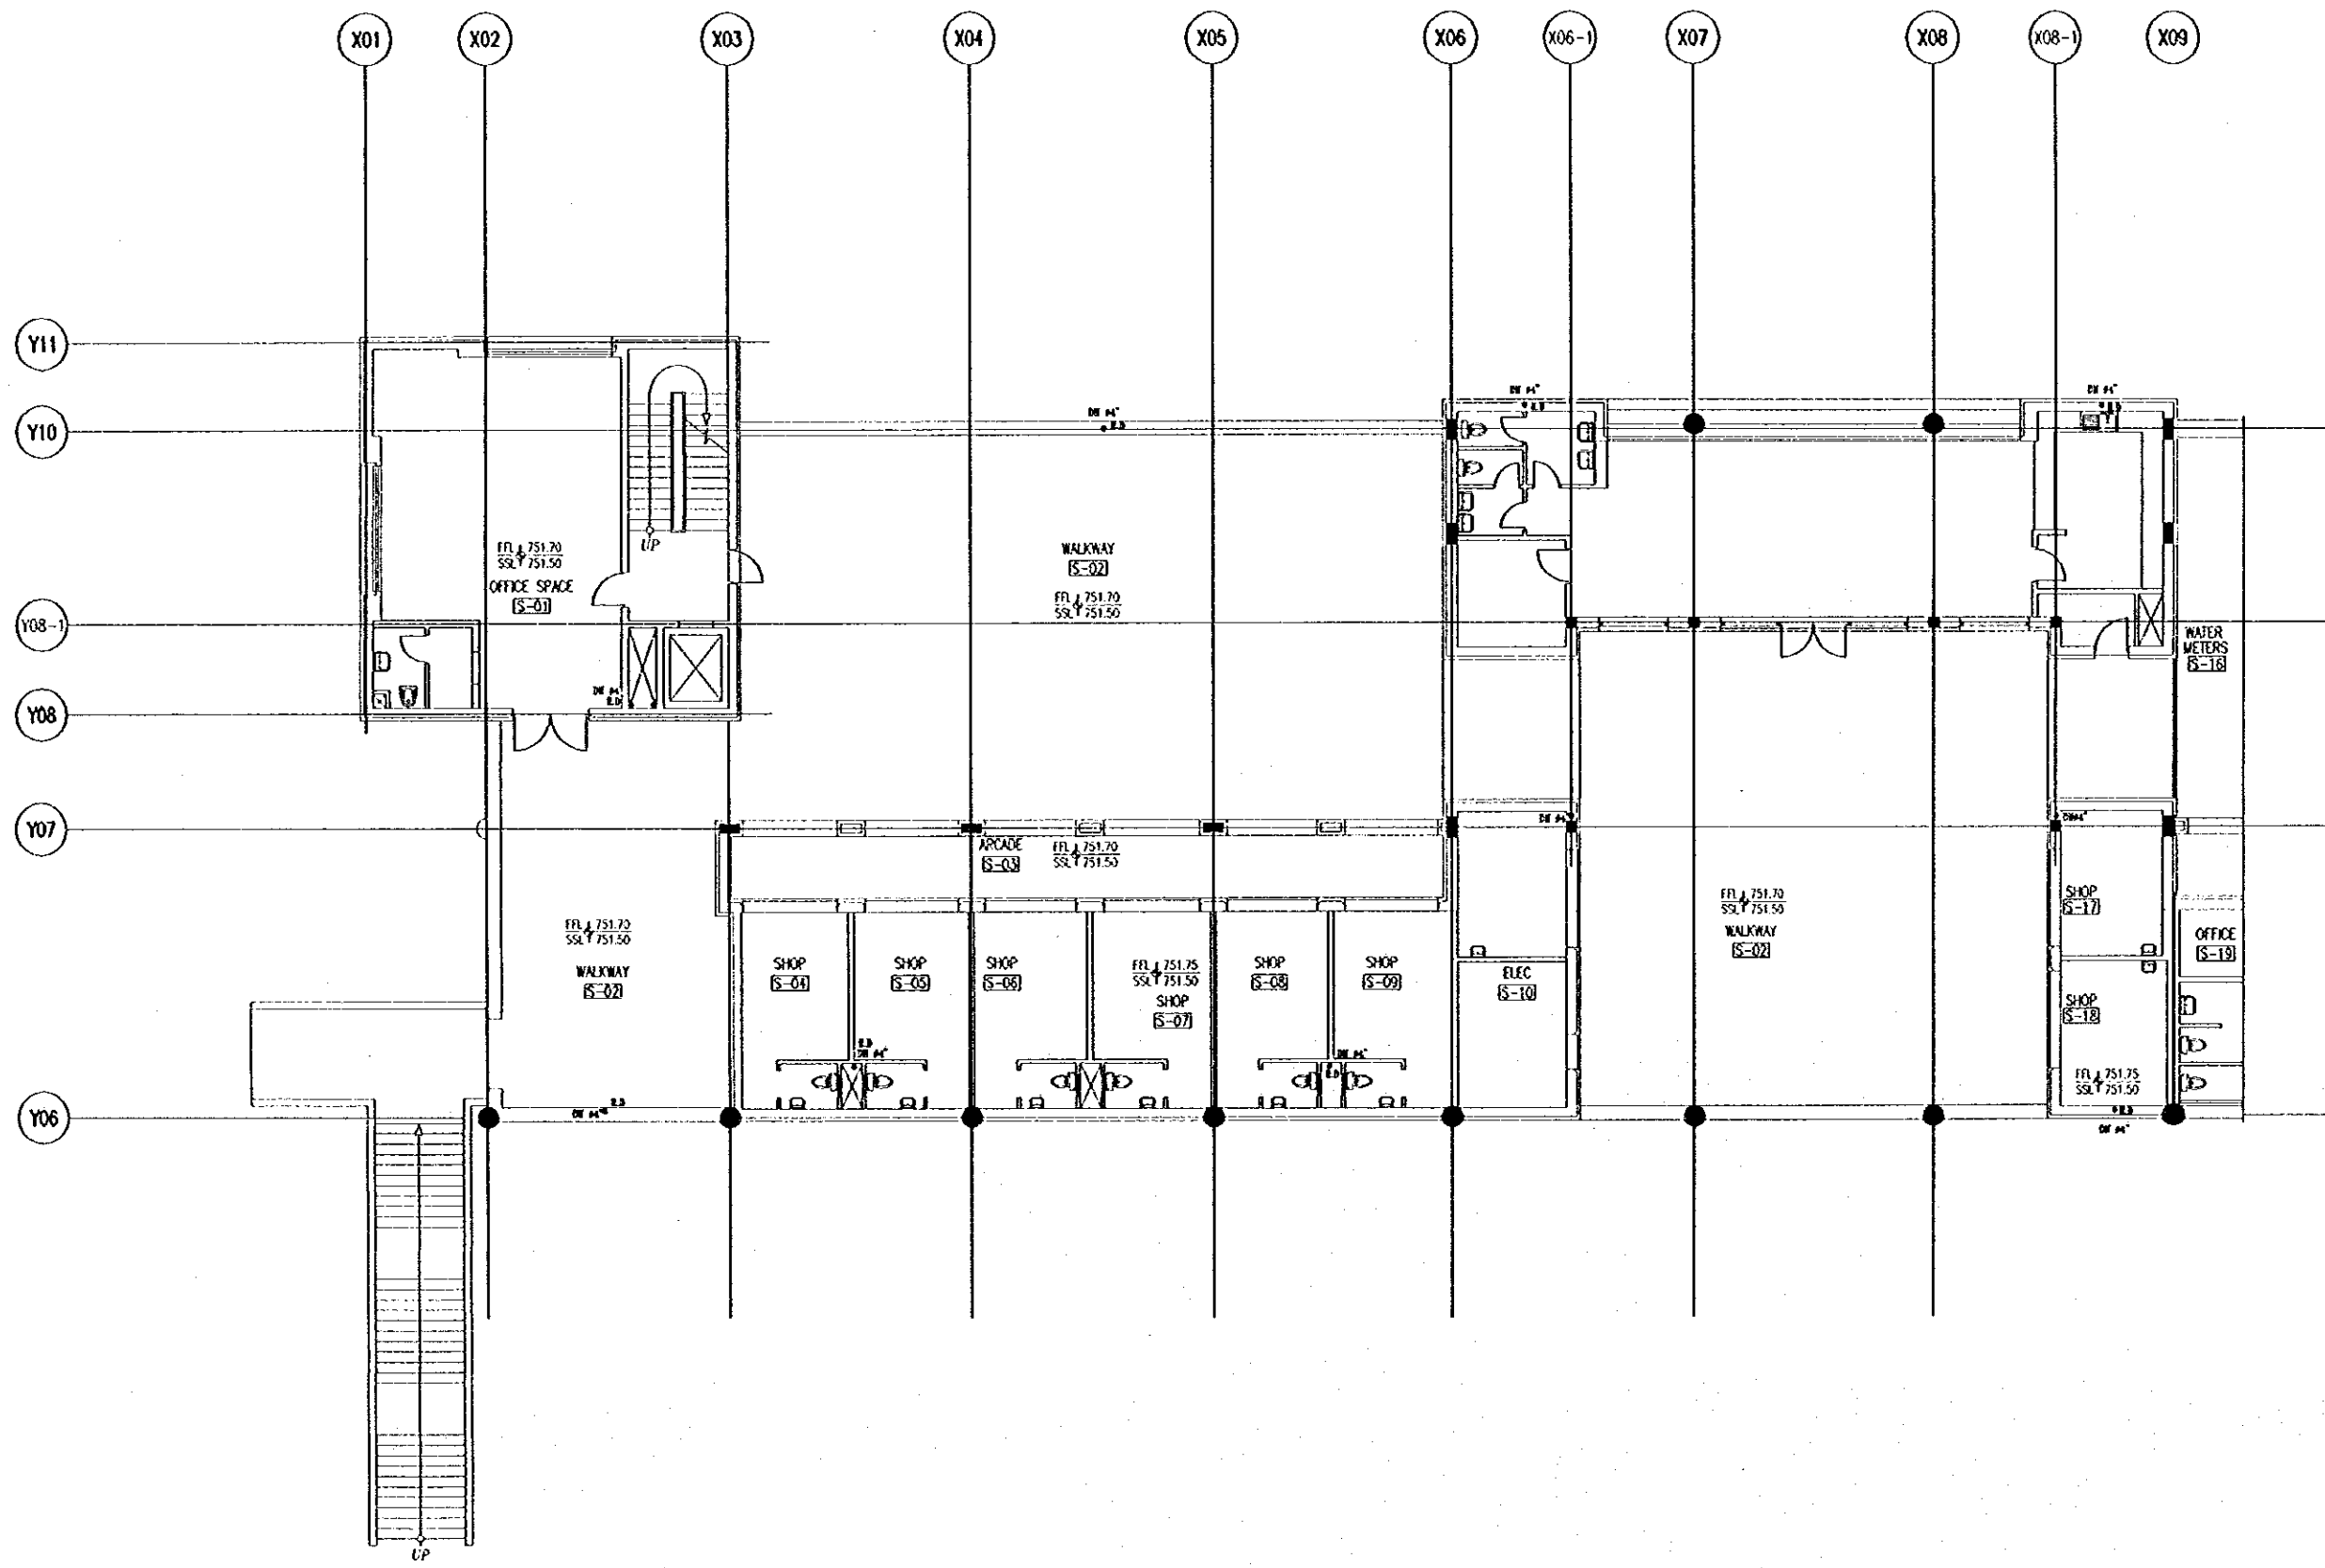

Tourism Sector Development Project
in the Hashemite Kingdom of Jordan

The Government of
the Hashemite Kingdom of Jordan
The Ministry of Tourism and Antiquities
The Ministry of Planning

Sub-Project:
Amman Downtown
Tourist Zone Development

Note:
• This detailed design has been executed by a team of consultants as shown below in accordance with the agreement between Japan International Cooperation Agency (JICA) and JICA Study Team.
• The copyright of this drawing rests with JICA.

Designed by:
Japan International Cooperation Agency (JICA)

JICA Study Team:
Joint Venture of
Pacific Consultants International and
Yamato Sekkei Inc.


Subcontracted Local Consultant:
TRAH Consultants
Architect, Engineers



Raghadan Bus Terminal

Drawing Title:
**RAIN WATER SYSTEM
FOR SECOND FLOOR ZONE 1**

Scale: 1/100 Drawing No.: RBT .M502

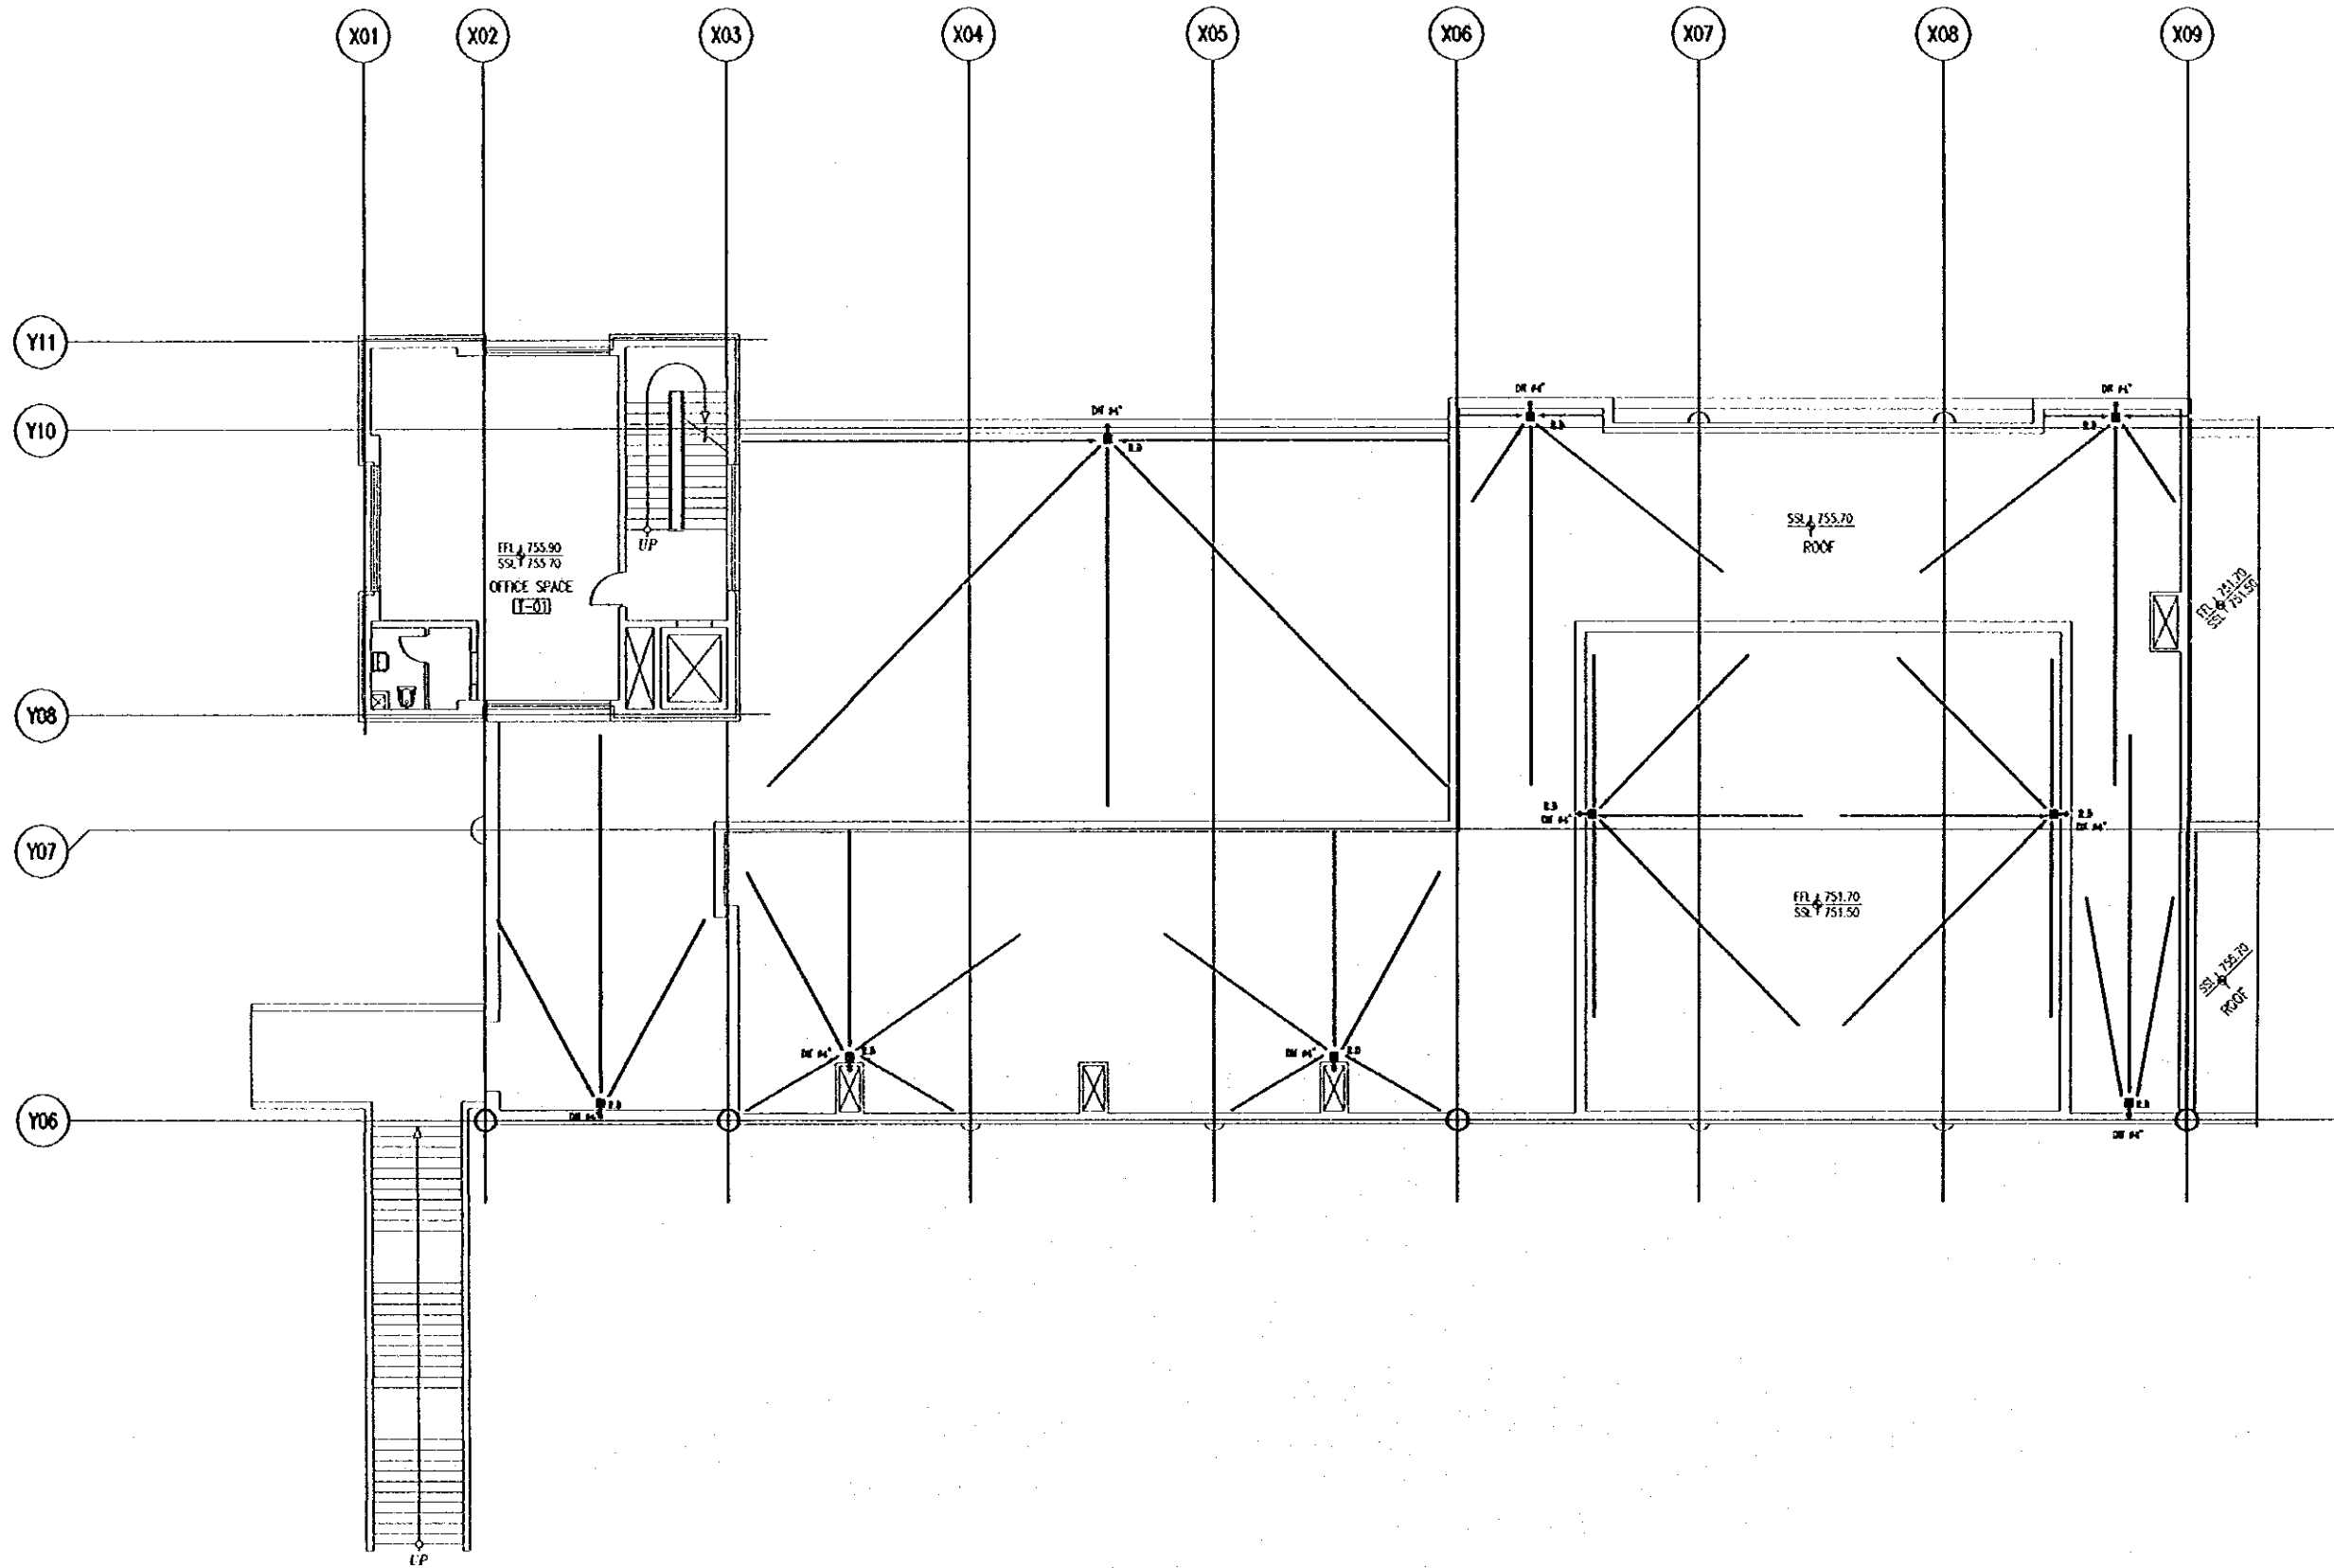

Tourism Sector Development Project
in the Hashemite Kingdom of Jordan

The Government of
the Hashemite Kingdom of Jordan
The Ministry of Tourism and Antiquities
The Ministry of Planning

Sub-Project:
Amman Downtown
Tourist Zone Development

Note:
- This detailed design has been executed by a team of
consultants as shown below in accordance with the agreement
between Japan International Cooperation Agency (JICA) and
JICA Study Team.
- The copyright of this drawing rests with JICA.

Designed by:
Japan International Cooperation Agency
(JICA)
JICA Study Team:
Joint Venture of
Pacific Consultants International and
Yamashita Seki & Inc.
Subcontracted Local Consultant:
TAMM Consultants
Architects, Engineers

Raghadan Bus Terminal

Drawing Title:
RAIN WATER SYSTEM
FOR THIRD FLOOR ZONE 1



Scale: 1/100
Drawing No: RBT .M503

Tourism Sector Development Project
in the Hashemite Kingdom of Jordan


The Government of
the Hashemite Kingdom of Jordan
The Ministry of Tourism and Antiquities
The Ministry of Planning

Sub-Project:
Amman Downtown
Tourist Zone Development


Note:
• This detailed design has been executed by a team of
consultants as shown below in accordance with the agreement
between Japan International Cooperation Agency (JICA) and
JICA Study Team.
• the copyright of this drawing rests with JICA.

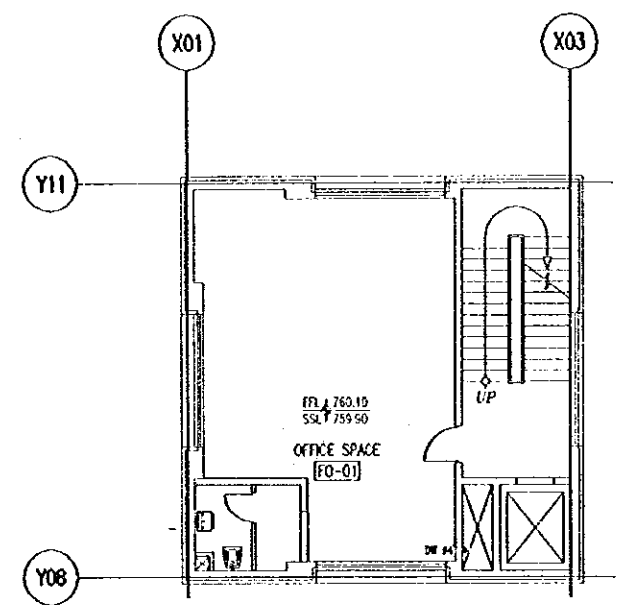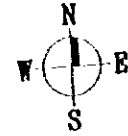

Z1
FOURTH FLOOR PLAN

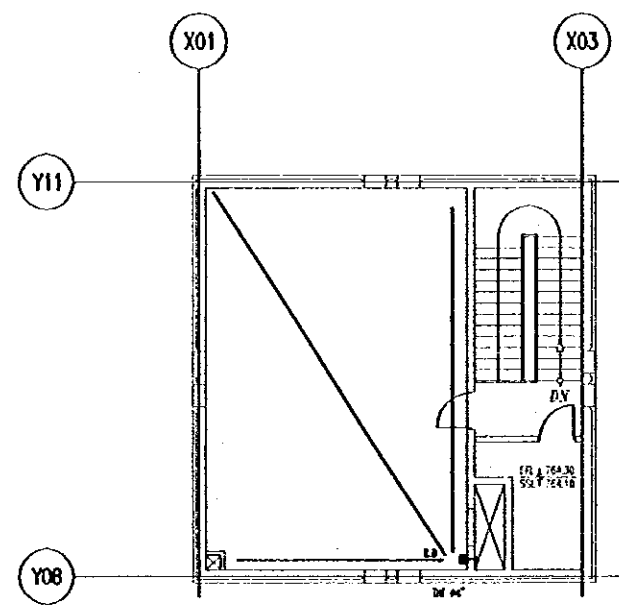

Z1
FIFTH FLOOR PLAN

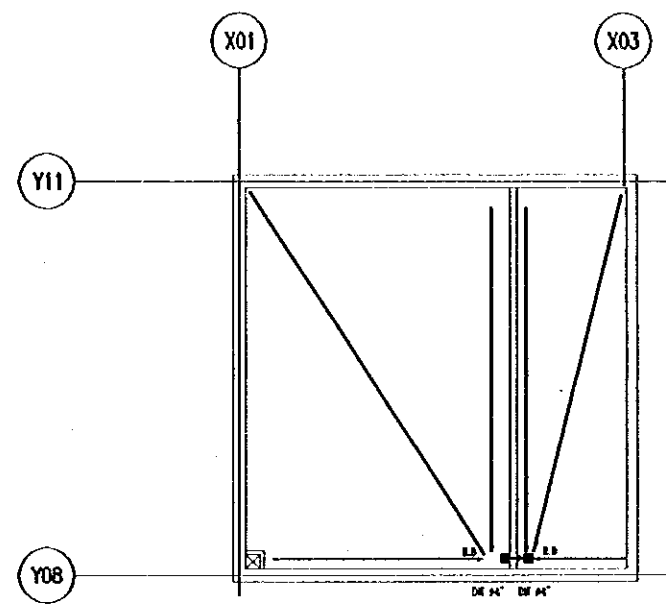

Z1
ROOF FLOOR PLAN

Designed by:
Japan International Cooperation Agency
(JICA)
JICA Study Team:
Joint Venture of
Pacific Consultants International and
Yamashita Sekkei Inc.
Subcontracted Local Consultant:
TIBAH Consultants
Architects, Engineers

Raghadan Bus Terminal

Drawing Title:
RAIN WATER SYSTEM
FOR MANAGEMENT TOWER

Scale: 1/100 Drawing No: RBT .M504

Notes:
• The detailed design has been executed by a team of consultants as shown below in accordance with the agreement between Japan International Cooperation Agency (JICA) and JICA Study Team.
• The copyright of this drawing rests with JICA.


NOTE :-
FD :- FLOOR DRAIN
C.O. :- CLEANOUT
U.T. :- UNDER TILE
U.S. :- UNDER SLAB
U.G. :- UNDER GROUND
T.L.O.P. :- TOP LEVEL OF PIPE
B.L.O.P. :- BOTTOM LEVEL OF PIPE
F.R.O. :- FREE DISCHARGE

Designed by:
Japan International Cooperation Agency
(JICA)
JICA Study Team:
Joint Venture of
Pacific Consultants International and
Yamato Seteki Inc.
Subcontracted Local Consultant:
TBM Consultants
Architects, Engineers

Raghadan Bus Terminal

Drawing Title:
RAIN WATER SYSTEM
FOR FIRST FLOOR ZONE 2

Scale: 1/100 Drawing No.: RBT.M505

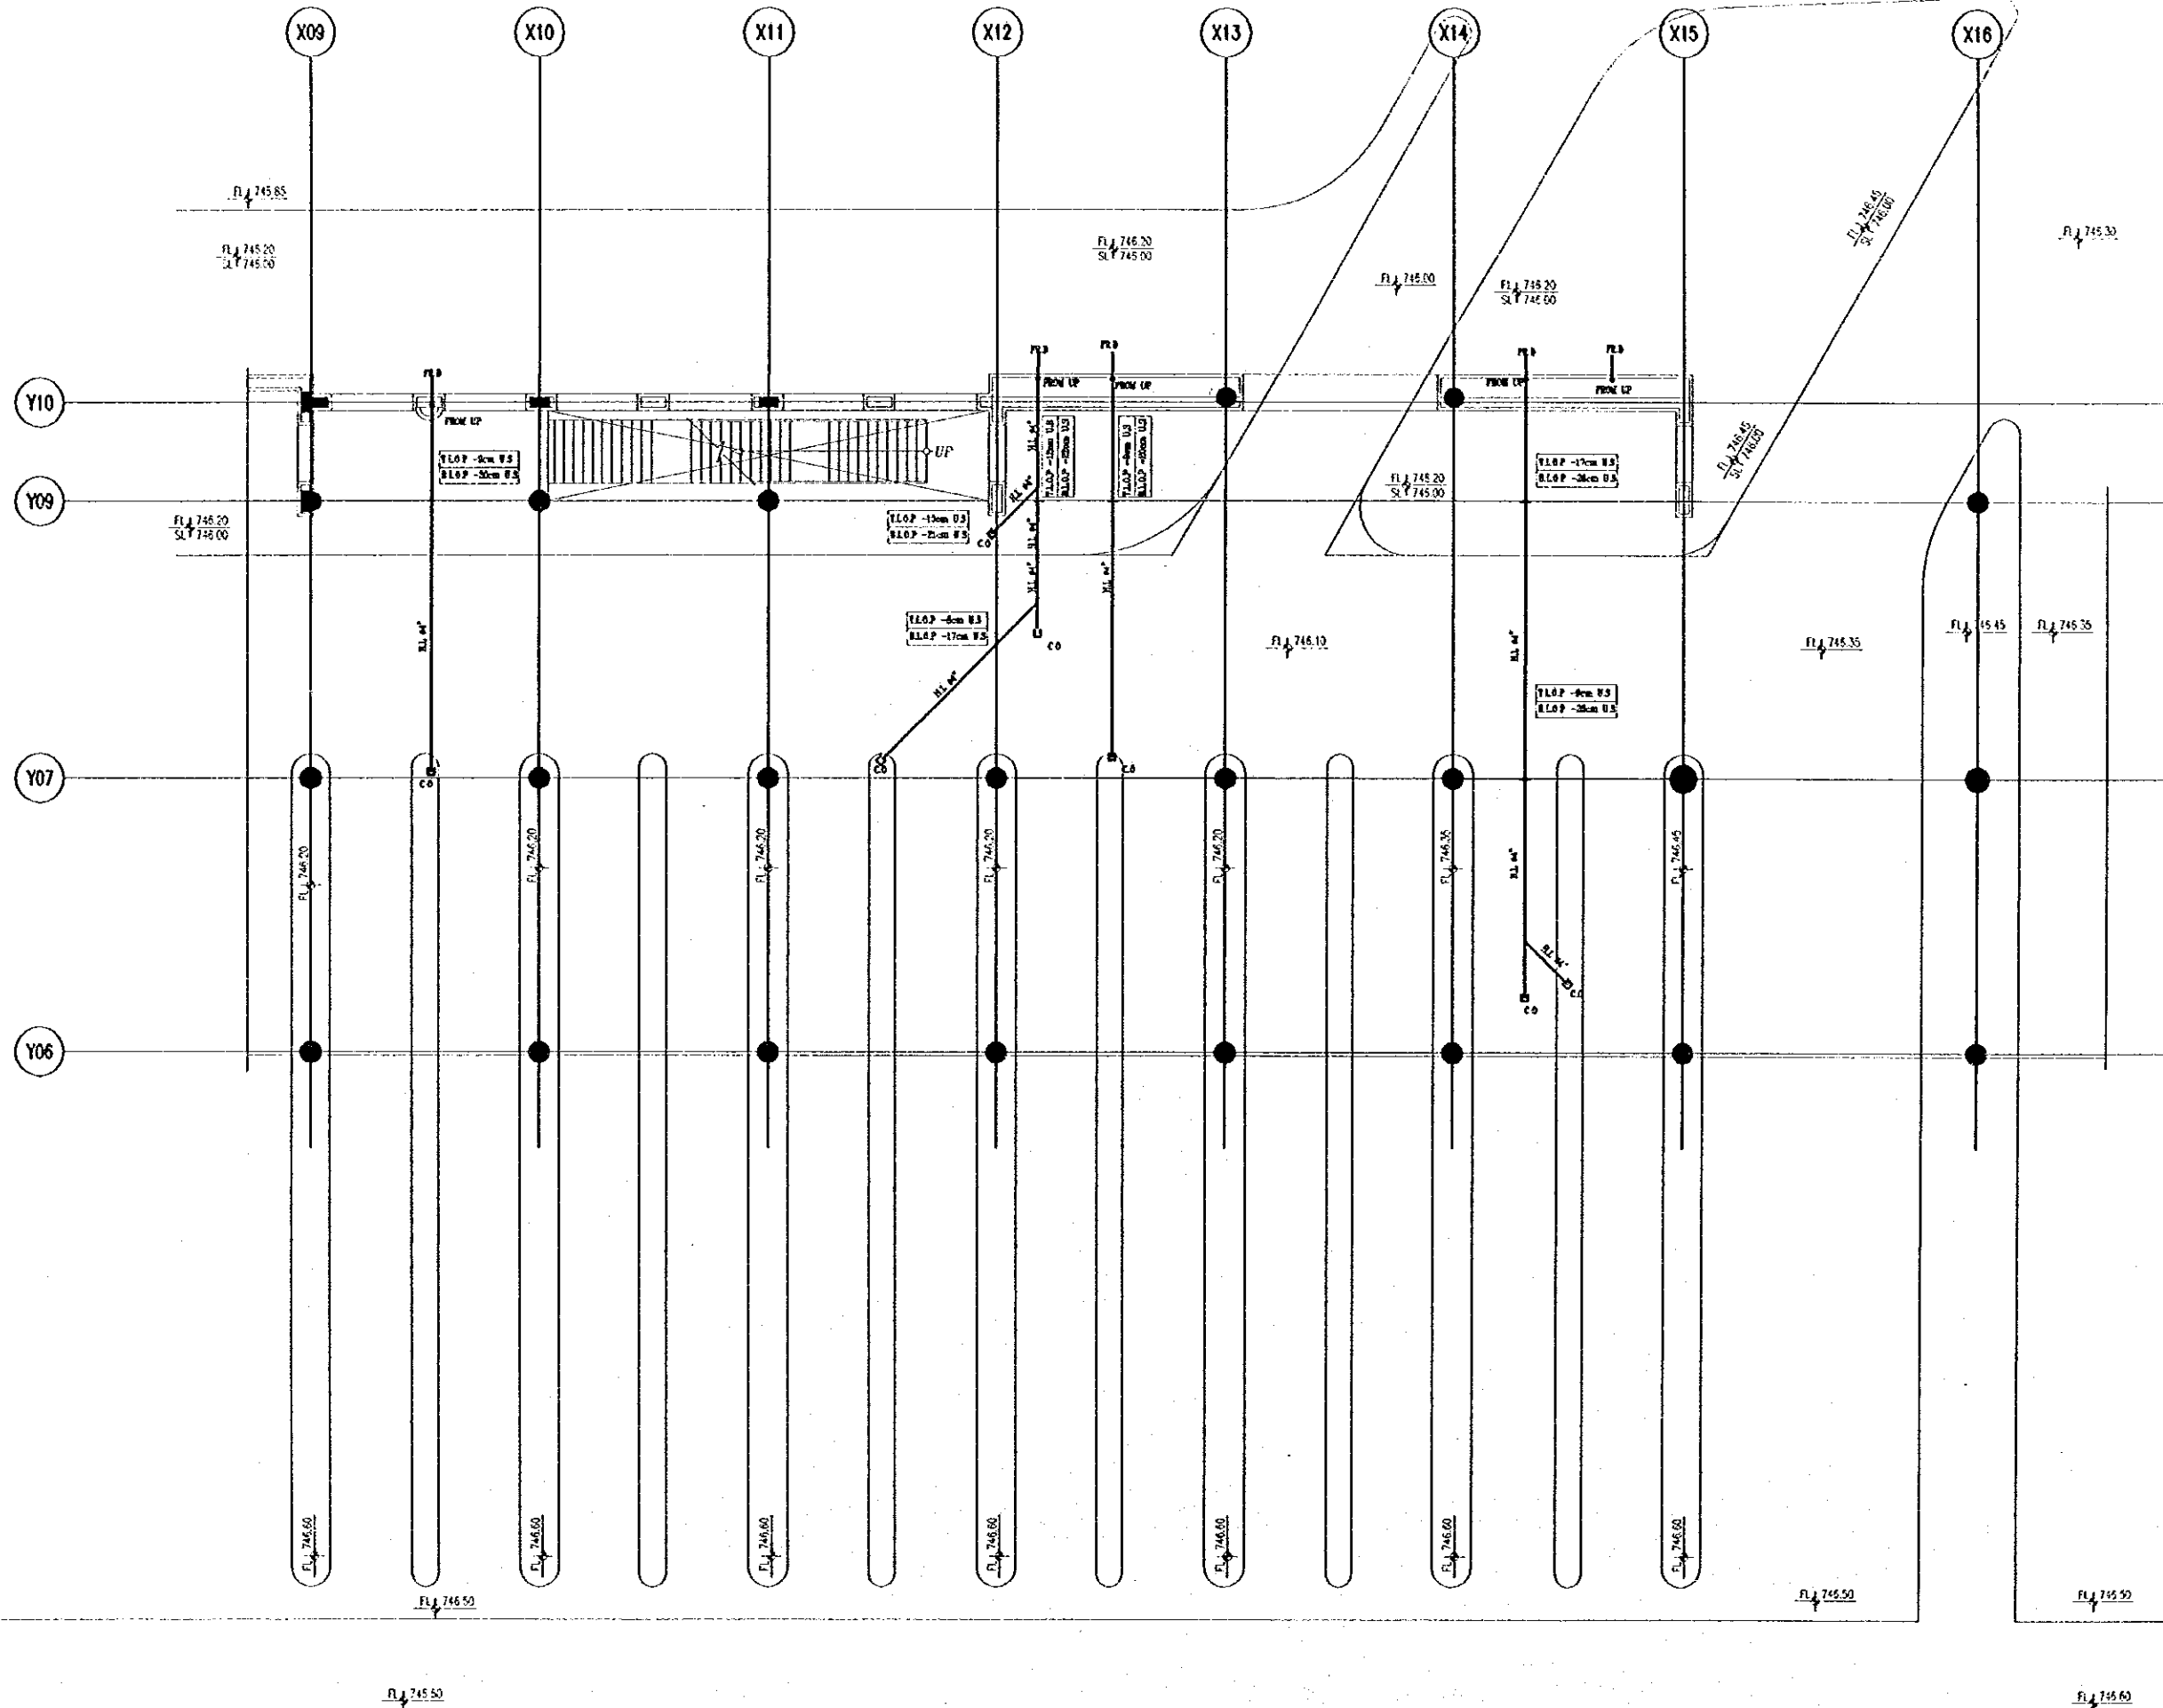


Tourism Sector Development Project
in the Hashemite Kingdom of Jordan

The Government of
the Hashemite Kingdom of Jordan
The Ministry of Tourism and Antiquities
The Ministry of Planning

Sub-Project:
Amman Downtown
Tourist Zone Development

Note:
• This detailed design has been executed by a team of
consultants as shown below in accordance with the agreement
between Japan International Cooperation Agency (JICA) and
JICA Study Team.
• The copyright of this drawing rests with JICA.

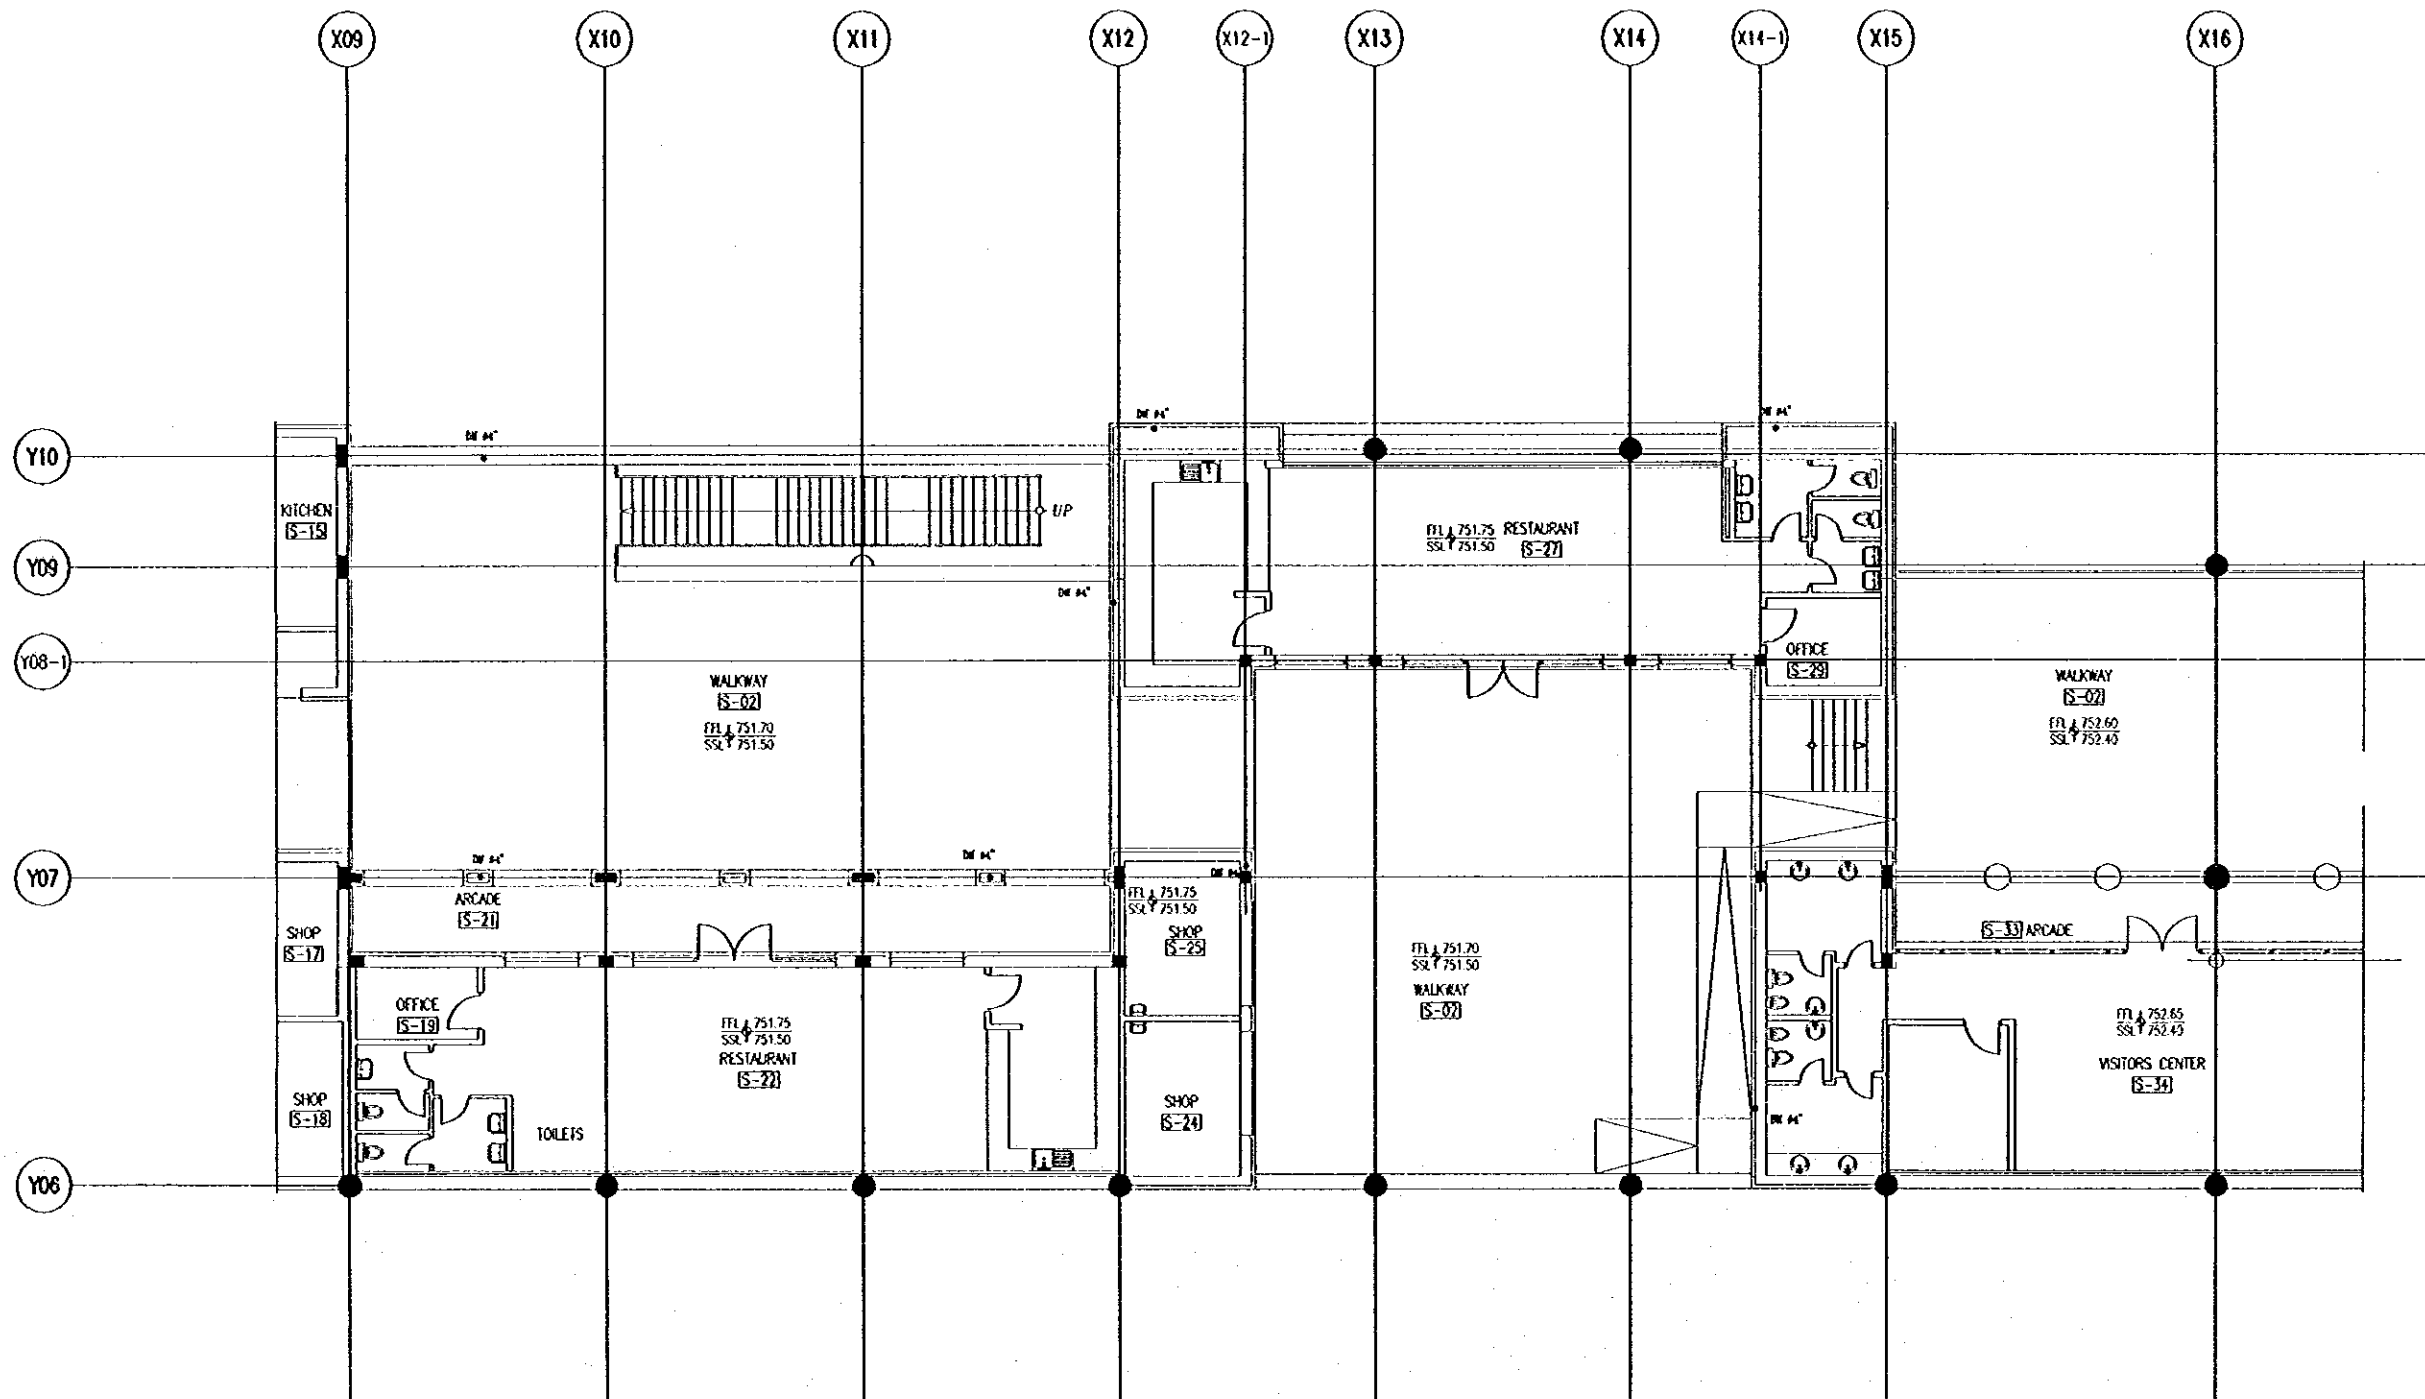

Designed by:
Japan International Cooperation Agency
(JICA)
JICA Study Team:
Joint Venture of
Pacific Consultants International and
Yamasita Sekkol Inc.
Subcontracted Local Consultant:
TBAH Consultants
Architects, Engineers

Raghadan Bus Terminal

Drawing Title:
**RAIN WATER SYSTEM
FOR SECOND FLOOR ZONE2**


Scale: **1/100** Drawing No: **RBT .M506**


Tourism Sector Development Project
in the Hashemite Kingdom of Jordan

The Government of
the Hashemite Kingdom of Jordan
The Ministry of Tourism and Antiquities
The Ministry of Planning

Sub-Project:
Ammon Downtown
Tourist Zone Development

Note:
• This detailed design has been executed by a team of
consultants as shown below in accordance with the agreement
between Japan International Cooperation Agency (JICA) and
JICA Study Team.
• The copyright of this drawing rests with JICA.

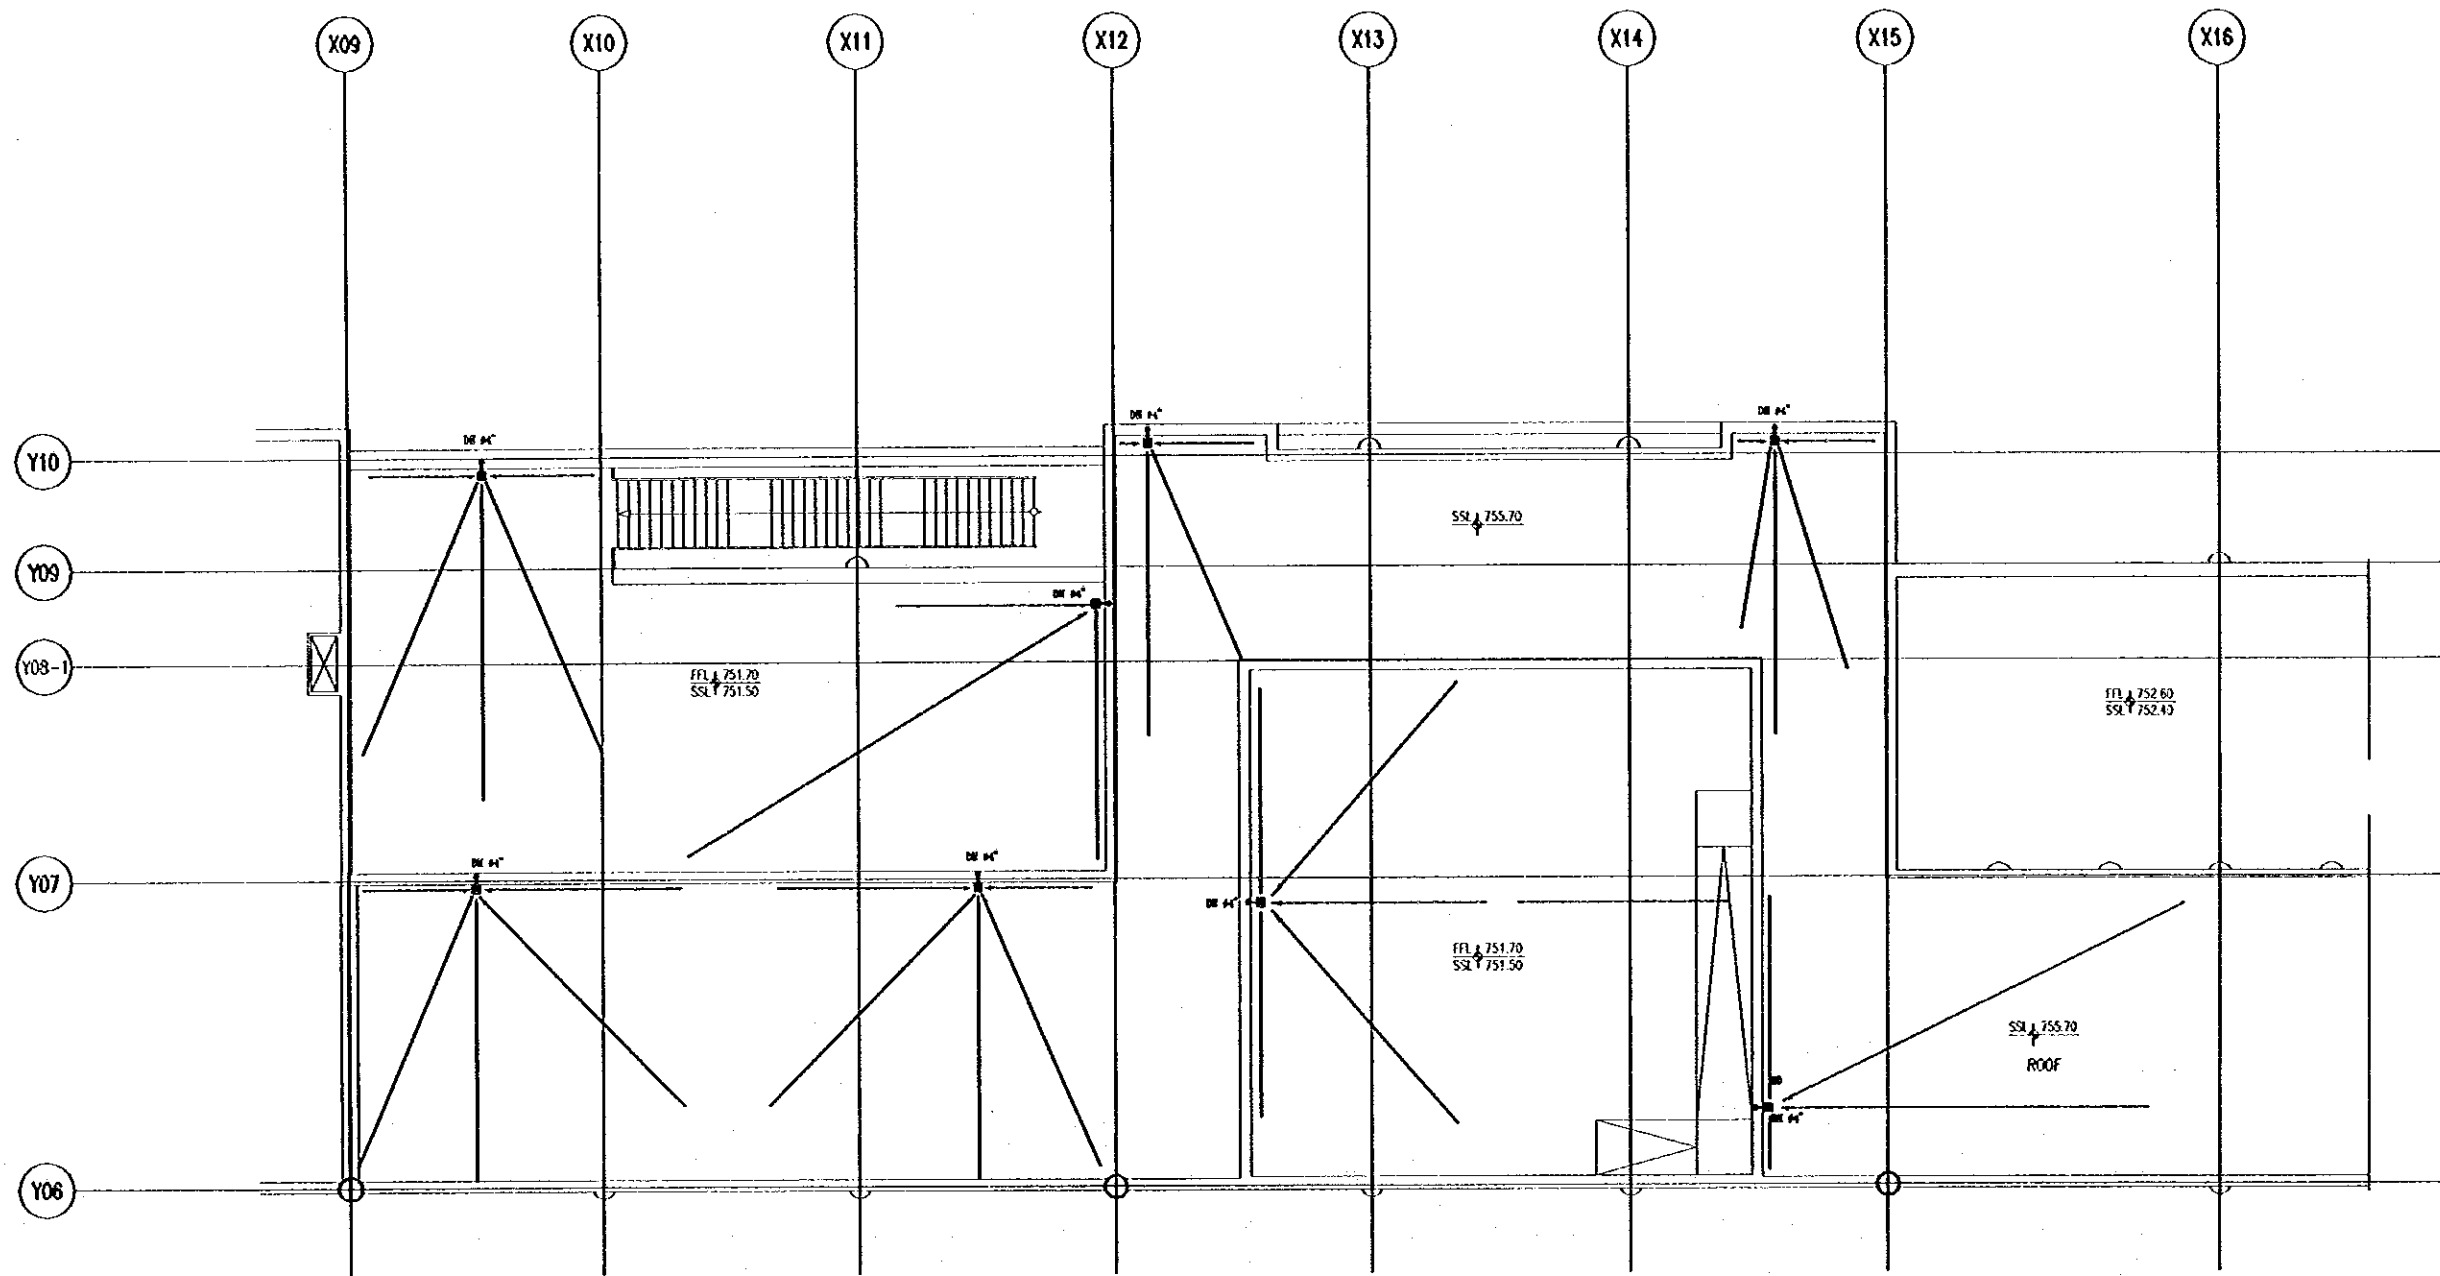

Designed by:
Japan International Cooperation Agency
(JICA)
JICA Study Team:
Joint Venture of
Pacific Consultants International and
Yonashi Sekkei Inc.
Subcontracted Local Consultant:
MAH Consultants
Architects, Engineers


Raghadan Bus Terminal
Drawing Title:
**RAIN WATER SYSTEM
FOR ROOF FLOOR ZONE 2**

Scale: 1/100
Drawing No: RBT.M507

Tourism Sector Development Project
in the Hashemite Kingdom of Jordan

The Government of
the Hashemite Kingdom of Jordan
The Ministry of Tourism and Antiquities
The Ministry of Planning

Sub-Project:
Amman Downtown
Tourist Zone Development

Note:
• This detailed design has been executed by a team of
consultants as shown below in accordance with the agreement
between Japan International Cooperation Agency (JICA) and
JICA Study Team.
• The copyright of this drawing rests with JICA.

NOTE :-
FD :- FLOOR DRAIN
C.O. :- CLEANOUT
U.T. :- UNDER TILE
U.S. :- UNDER SLAB
U.G. :- UNDER GROUND
T.L.O.P. :- TOP LEVEL OF PIPE
B.L.O.P. :- BOTTOM LEVEL OF PIPE

Designed by:
Japan International Cooperation Agency
(JICA)


JICA Study Team:
Joint Venture of
Pacific Consultants International and
Yamashita Sekirei Inc.


Subcontracted Local Consultant:
TRAH Consultants
Architects, Engineers

Raghadan Bus Terminal

Drawing Title:
RAIN WATER SYSTEM
FOR GROUND FLOOR ZONE 3

Scale: 1/100 Drawing No.: RBT.M508

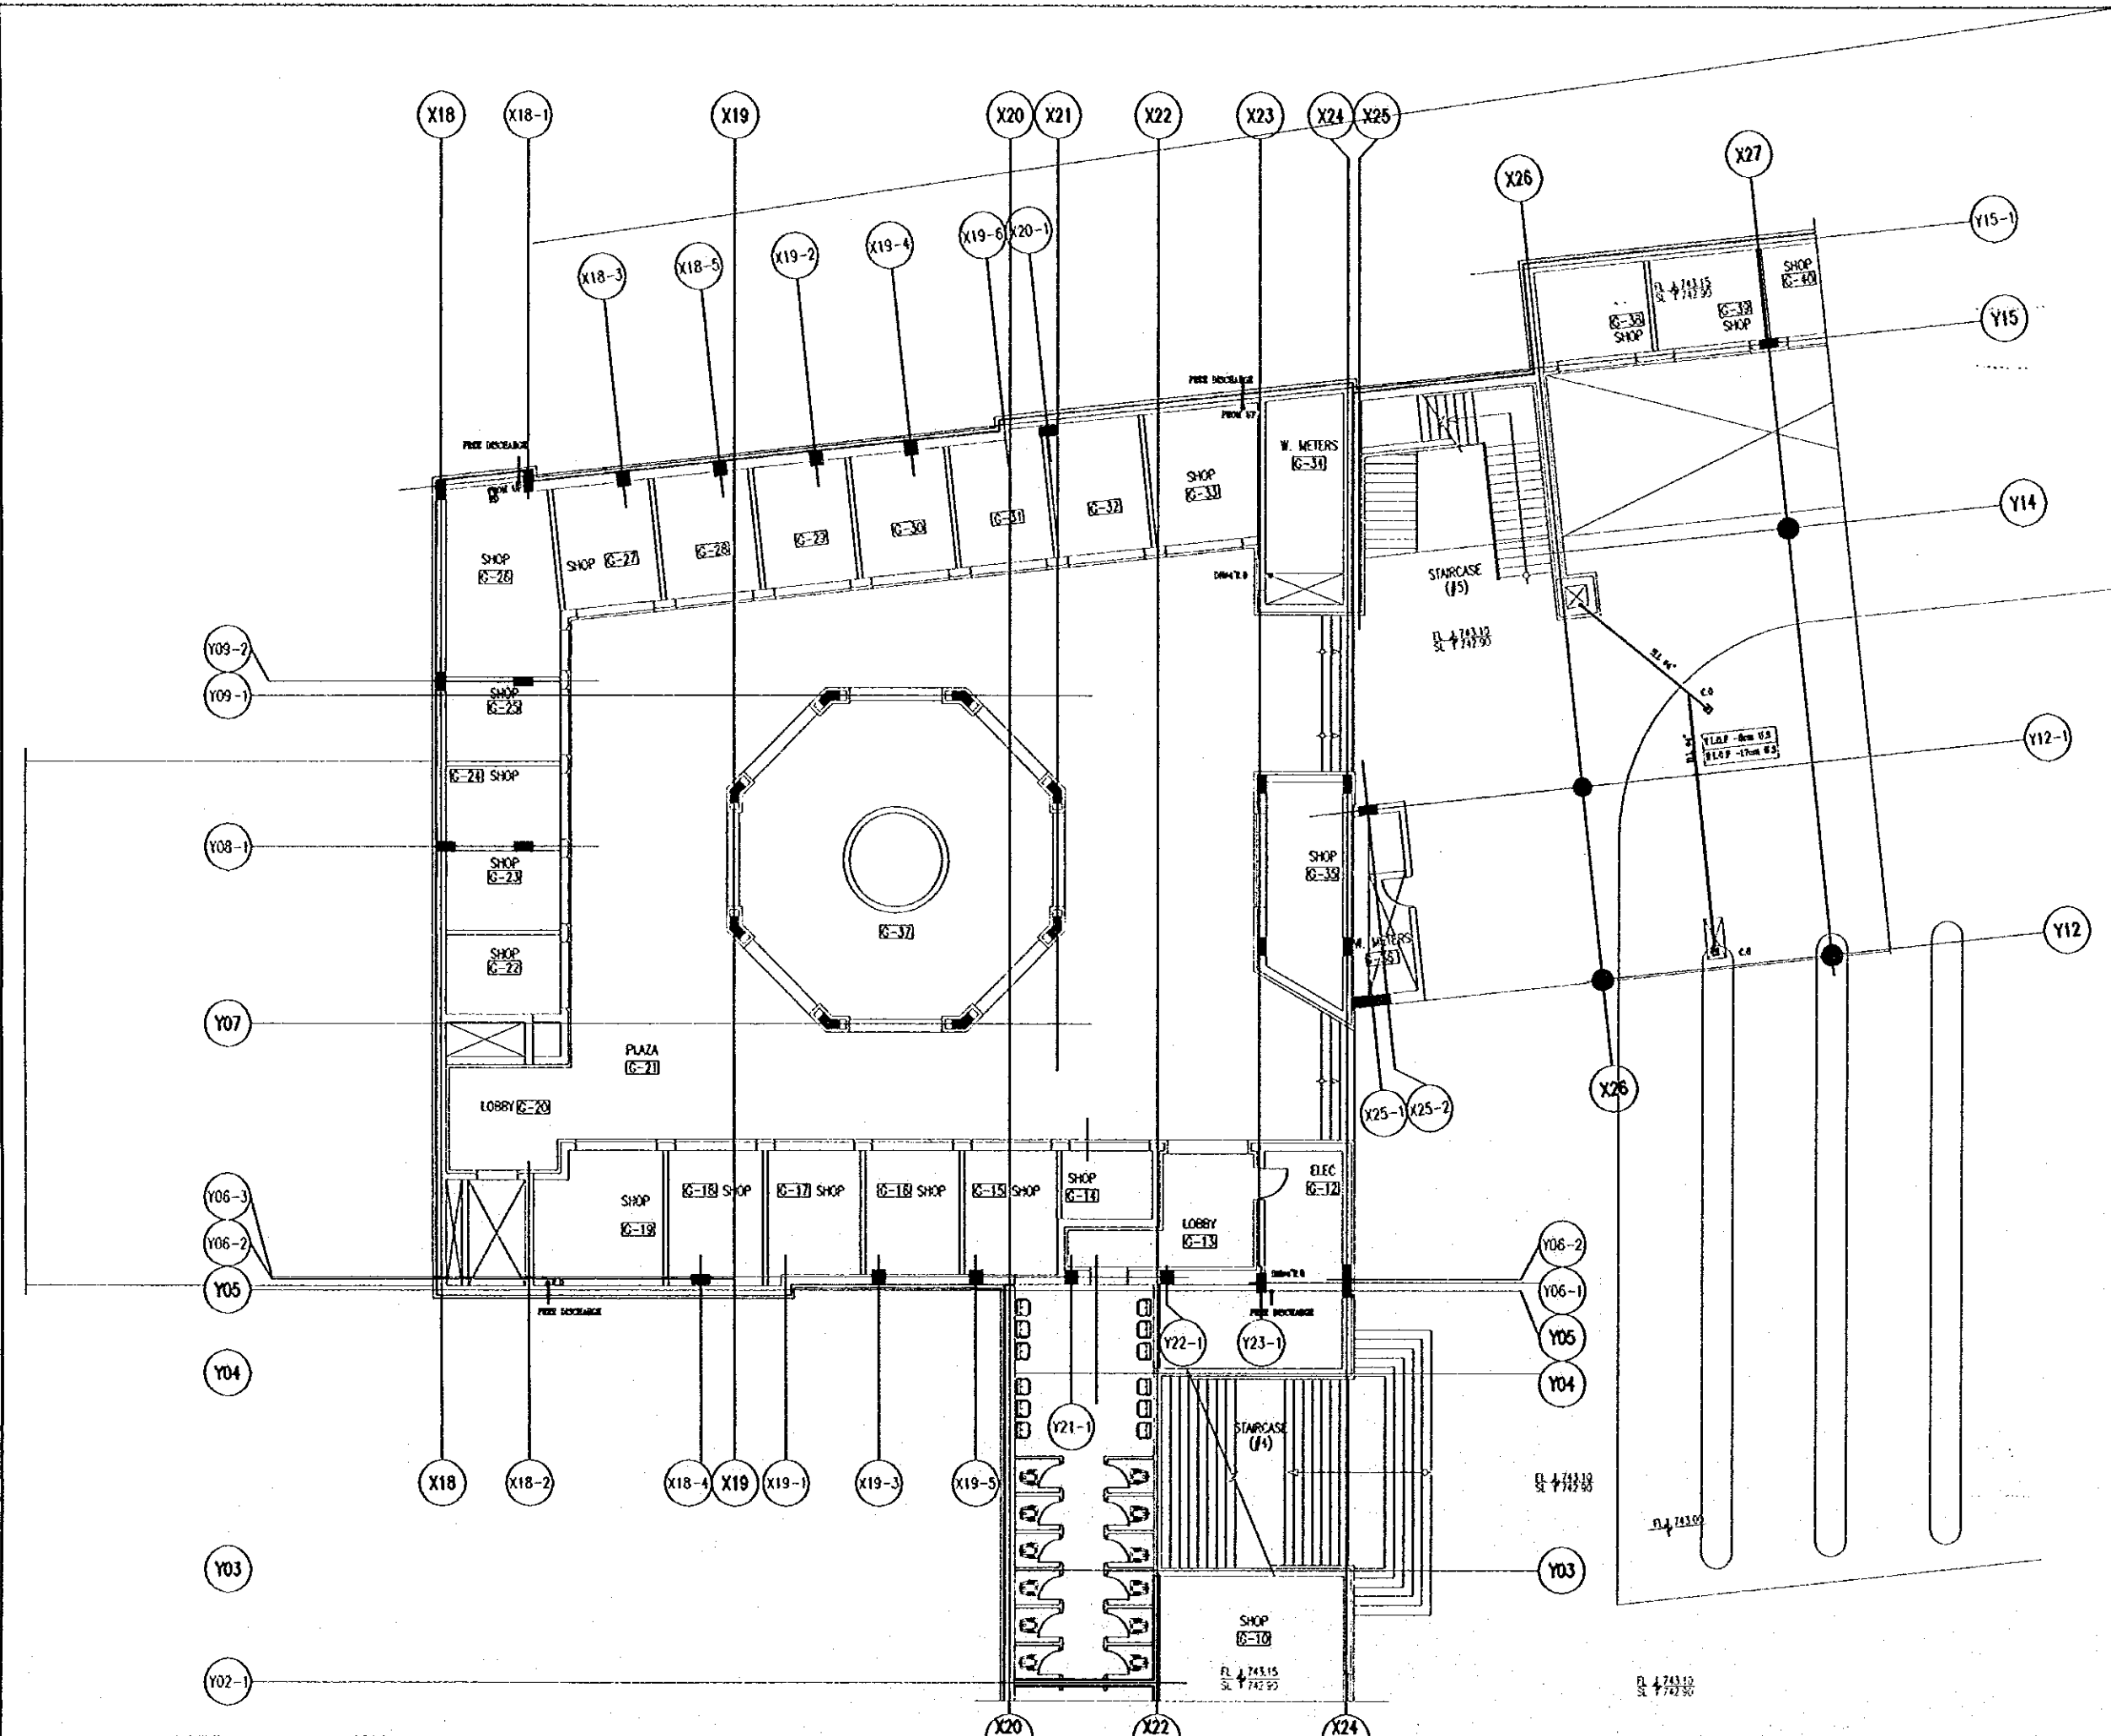

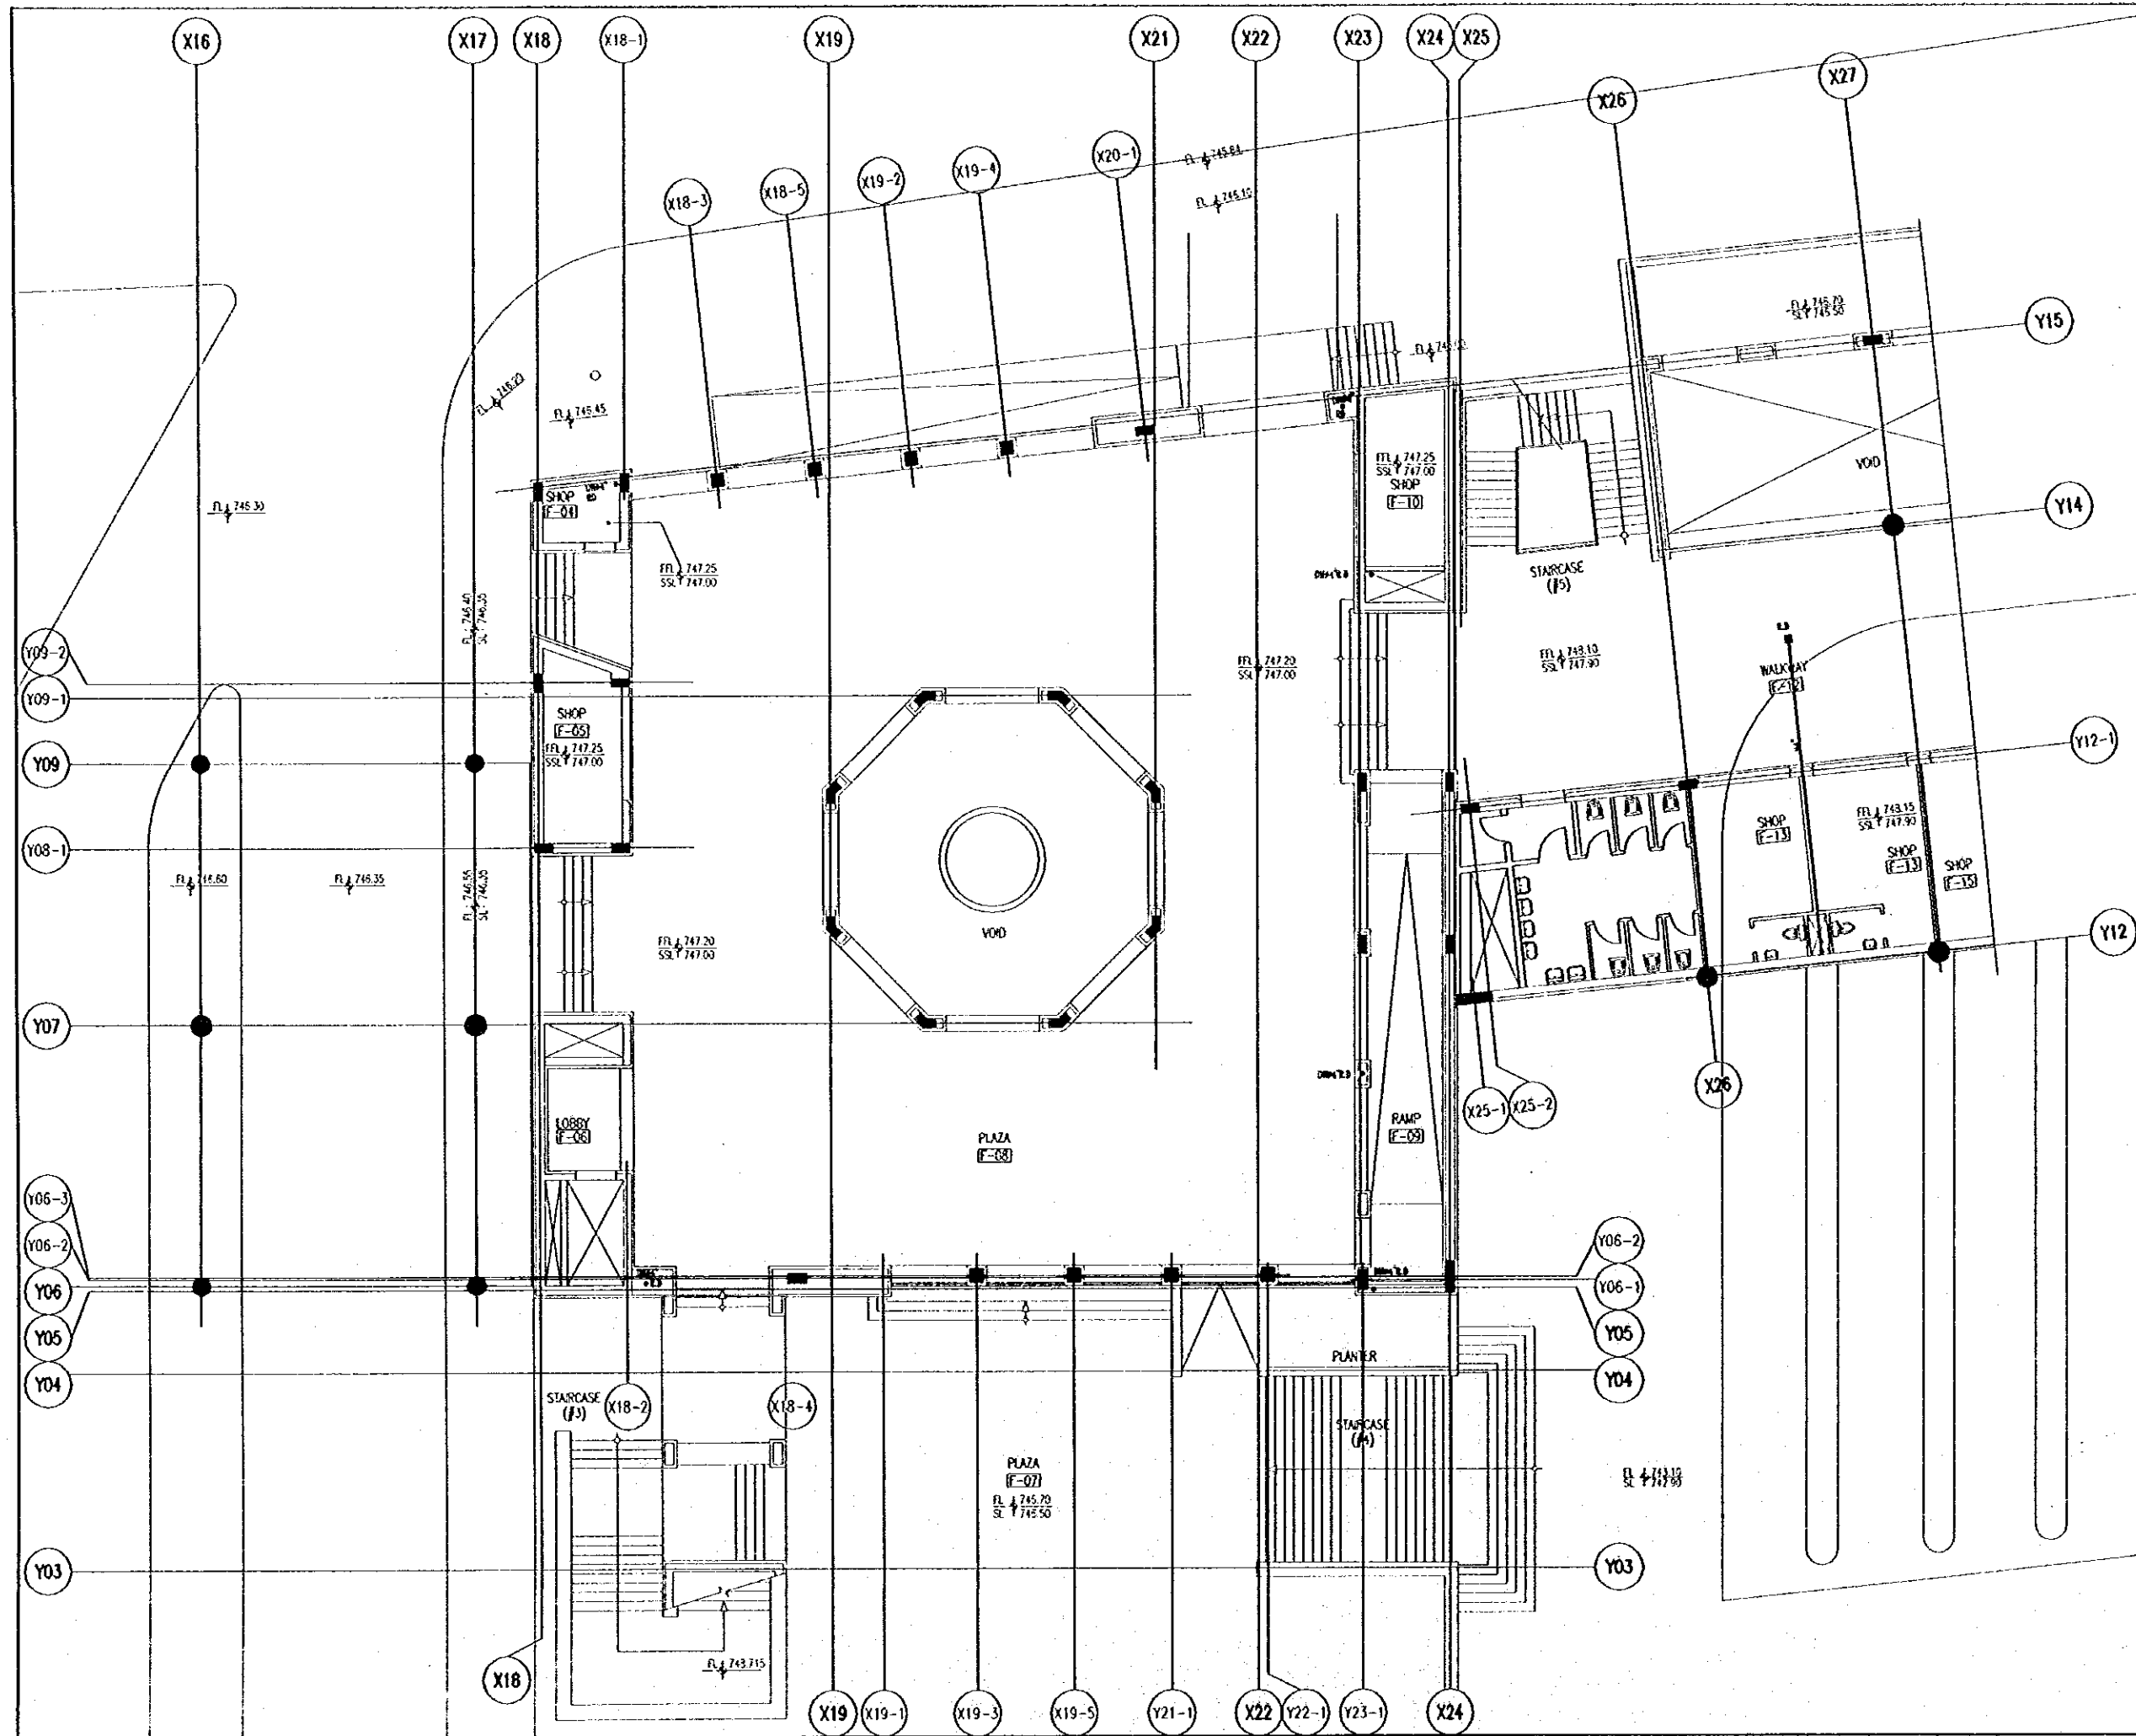

Tourism Sector Development Project
in the Hashemite Kingdom of Jordan

The Government of
the Hashemite Kingdom of Jordan
The Ministry of Tourism and Antiquities
The Ministry of Planning

Sub-Project:
Amman Downtown
Tourist Zone Development

Note:
• This detailed design has been executed by a team of consultants as shown below in accordance with the agreement between Japan International Cooperation Agency (JICA) and JICA Study Team.
• The copyright of this drawing rests with JICA.

Designed by:
Japan International Cooperation Agency (JICA)


JICA Study Team:
Joint Venture of
Pacific Consultants International and
Yamashita Sekitai Inc.

Subcontracted Local Consultant:
TIBAH Consultants
Architects, Engineers

Raghadan Bus Terminal

Drawing Title:
**RAIN WATER SYSTEM
FOR FIRST FLOOR ZONE 3**

Scale: 1/100 Drawing No.: RBT . M509

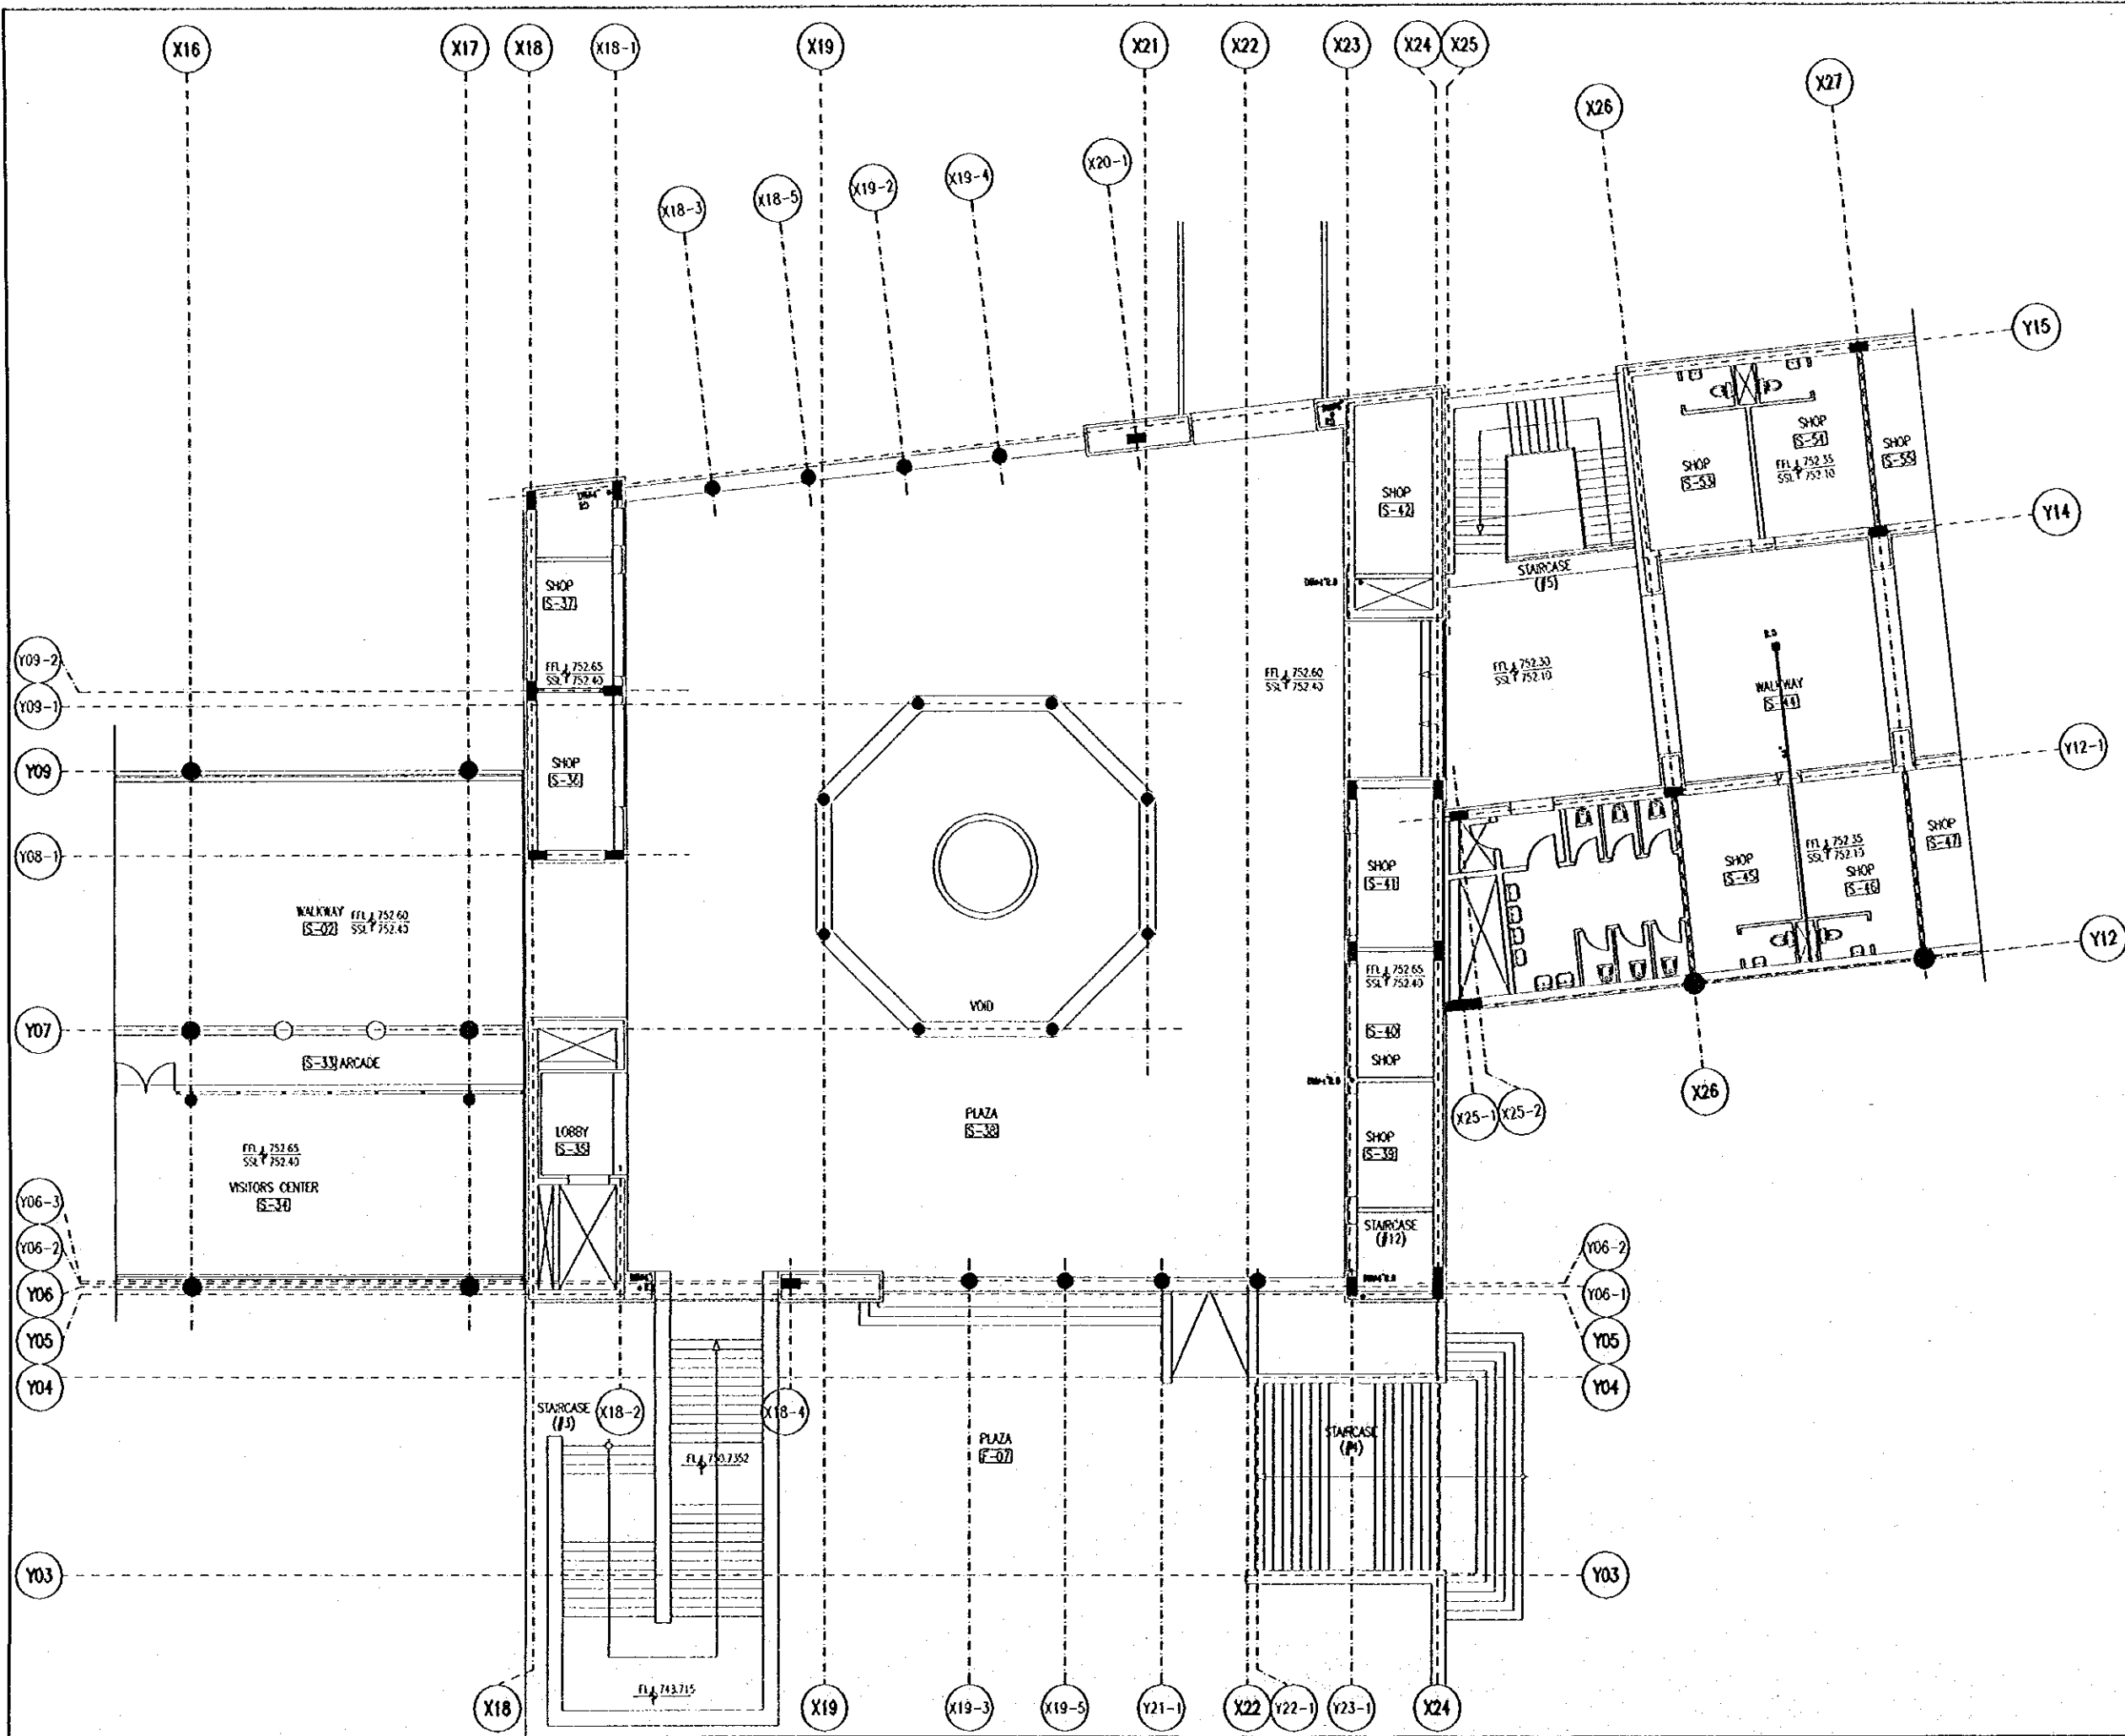

Tourism Sector Development Project
in the Hashemite Kingdom of Jordan


The Government of
the Hashemite Kingdom of Jordan
The Ministry of Tourism and Antiquities
The Ministry of Planning

Sub-Project:
Amman Downtown
Tourist Zone Development

Note:
- This detailed design has been executed by a team of
consultants as shown below in accordance with the agreement
between Japan International Cooperation Agency (JICA) and
JICA Study Team.
- The copyright of this drawing rests with JICA.

Designed by:
Japan International Cooperation Agency
(JICA)
JICA Study Team:
Joint Venture of
Pacific Consultants International and
Yamashita Sekirei Inc.
Subcontracted Local Consultant:
TIRAH Consultants
Architects, Engineers

Raghadan Bus Terminal
Drawing Title:
**RAIN WATER SYSTEM
FOR SECOND FLOOR ZONE 3**
Scale: 1/100
Drawing No.: RBT .M510

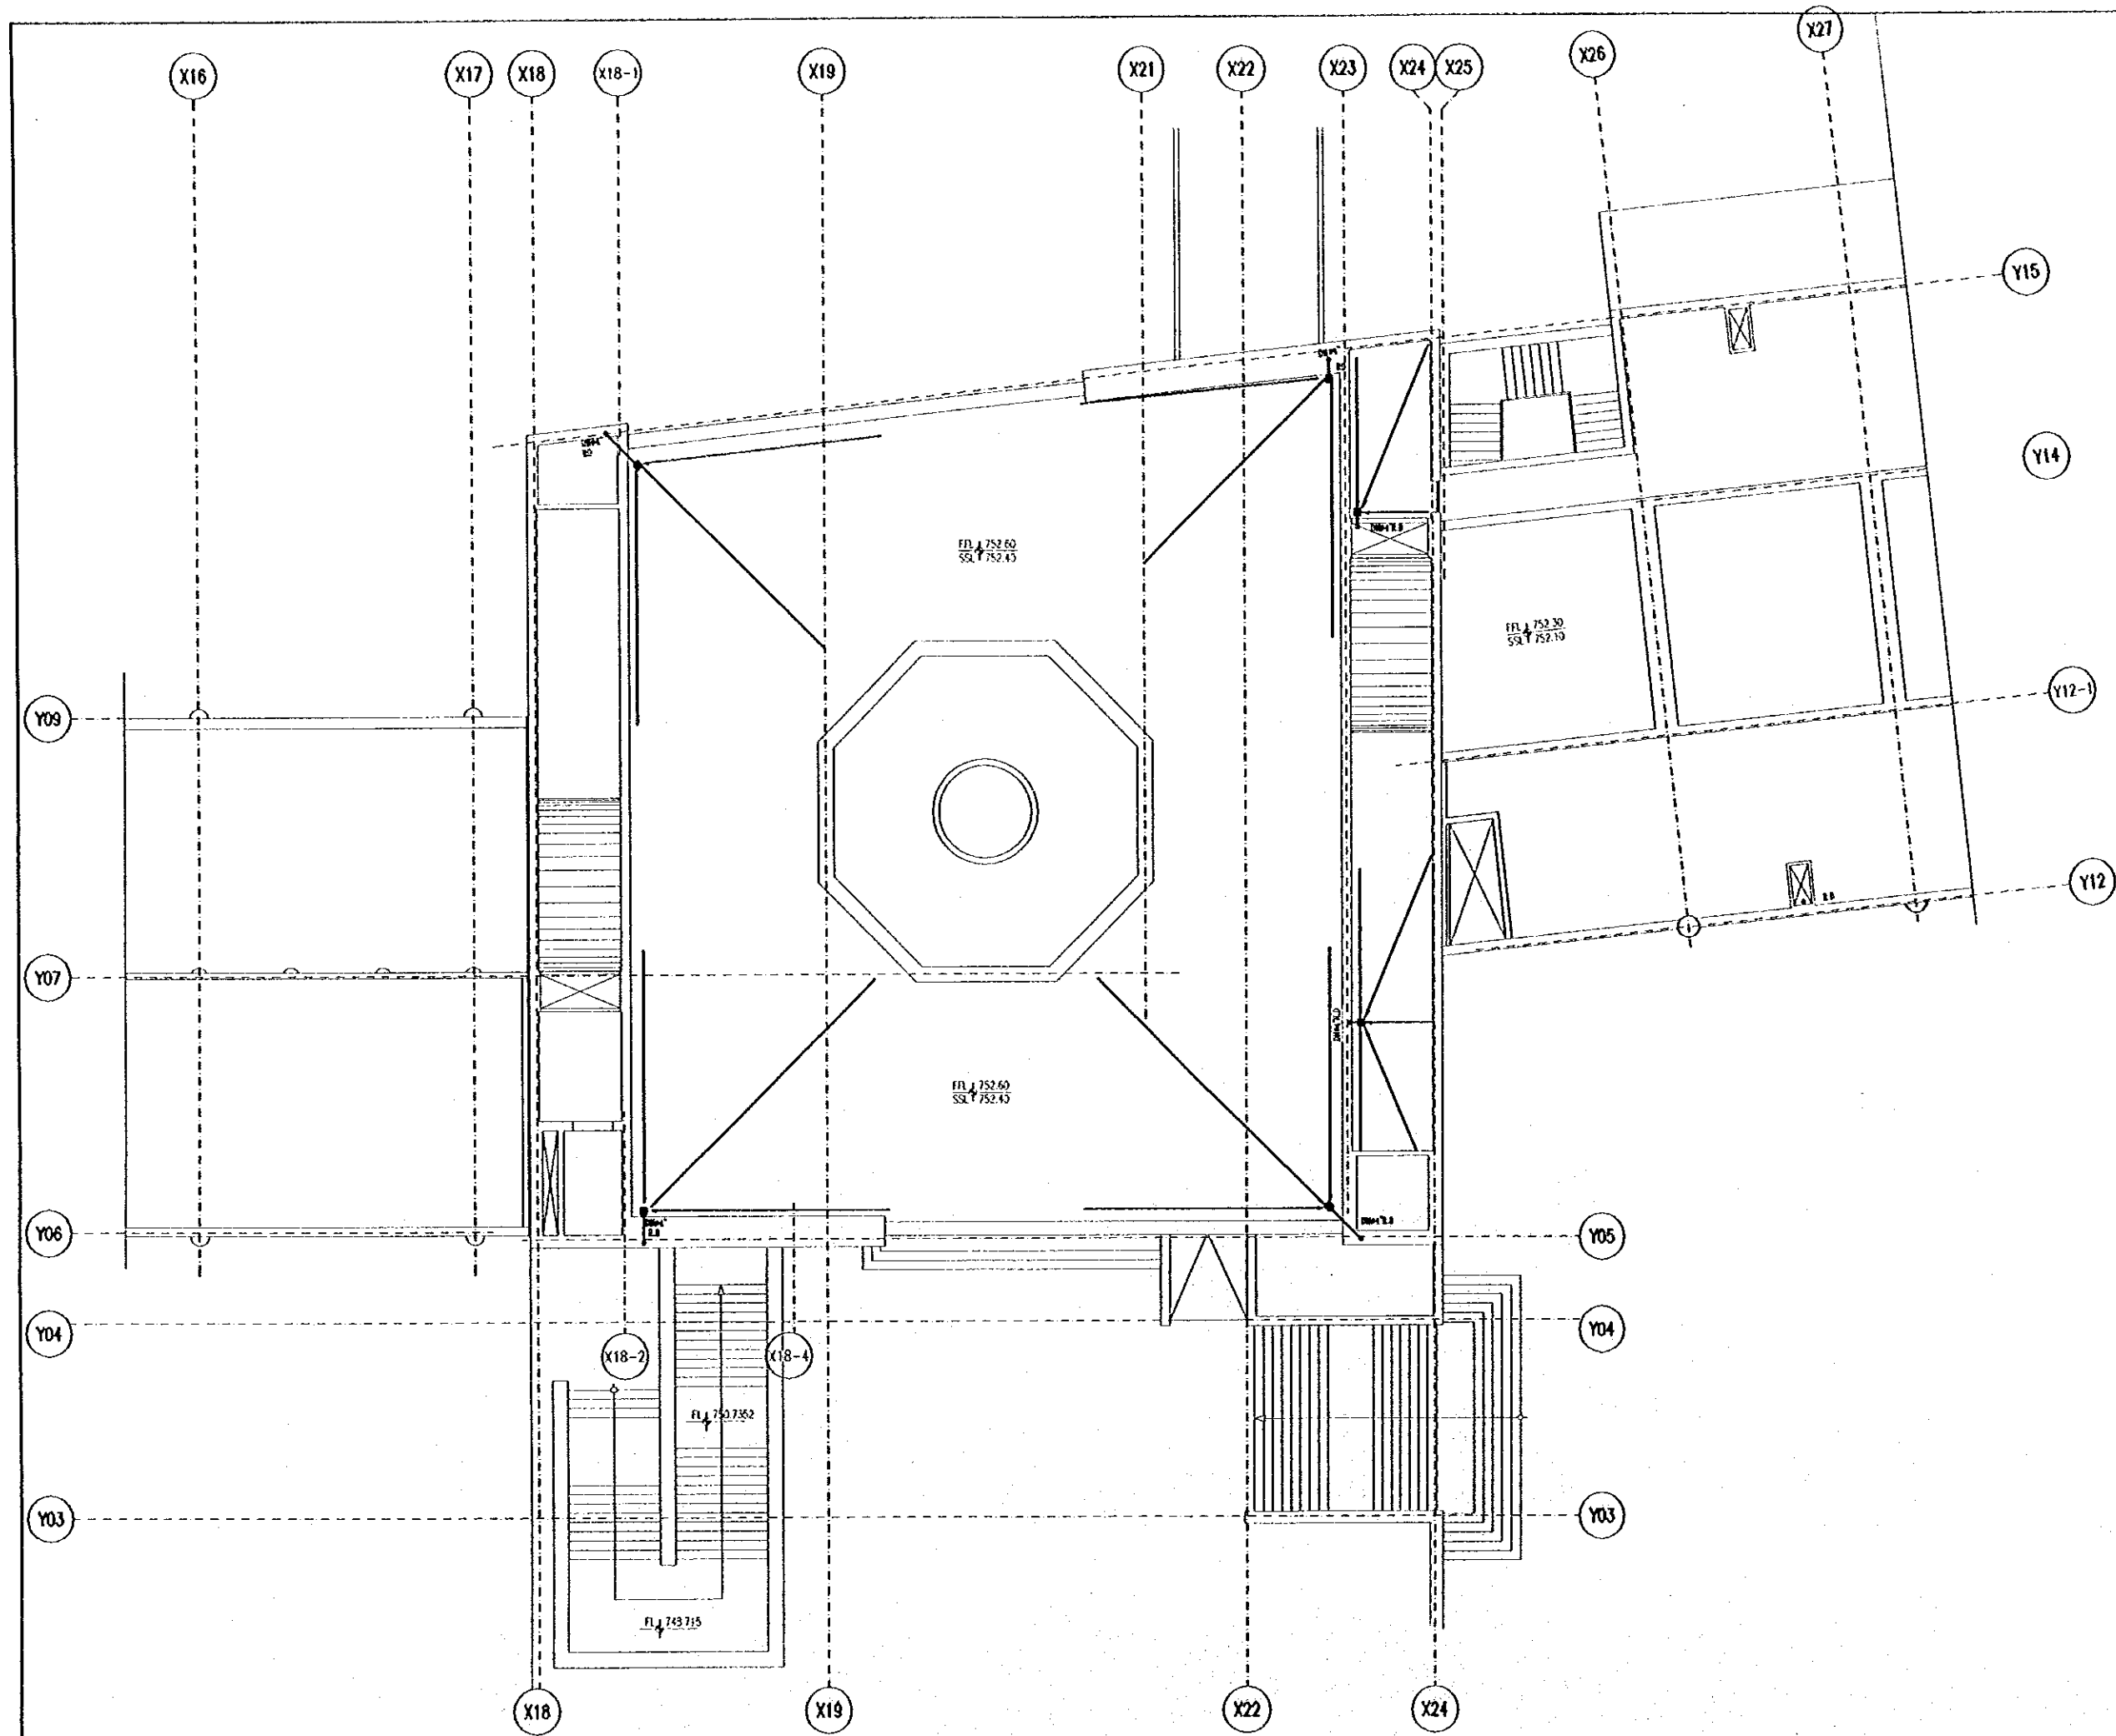

Tourism Sector Development Project
in the Hashemite Kingdom of Jordan

The Government of
the Hashemite Kingdom of Jordan
The Ministry of Tourism and Antiquities
The Ministry of Planning

Sub-Project:
Amman Downtown
Tourist Zone Development

Note:
- This detailed design has been executed by a team of
consultants as shown below in accordance with the agreement
between Japan International Cooperation Agency (JICA) and
JICA Study Team.
- The copyright of this drawing rests with JICA.

Designed by:
Japan International Cooperation Agency
(JICA)

JICA Study Team:
Joint Venture of
Pacific Consultants International and
Yamashita Seki Inc.

Subcontracted Local Consultant:
TMAH Consultants
Architects, Engineers

Raghadan Bus Terminal

Drawing Title:
**RAIN WATER SYSTEM
FOR ROOF FLOOR ZONE 3**

Scale: 1/100 Drawing No.: RBT_M511

Tourism Sector Development Project
in the Hashemite Kingdom of Jordan

The Government of
the Hashemite Kingdom of Jordan
The Ministry of Tourism and Antiquities
The Ministry of Planning

Sub-Project:
Amman Downtown
Tourist Zone Development

Note:
• This detailed design has been executed by a team of
consultants as shown below in accordance with the agreement
between Japan International Cooperation Agency (JICA) and
JICA Study Team.

• The copyright of this drawing rests with JICA.

NOTE :-
FD :- FLOOR DRAIN
C.O. :- CLEANOUT
U.T :- UNDER TILE
U.S :- UNDER SLAB
U.G :- UNDER GROUND
T.L.O.P :- TOP LEVEL OF PIPE
B.L.O.P :- BOTTOM LEVEL OF PIPE

Designed by:

Japan International Cooperation Agency
(JICA)

JICA Study Team:

Joint Venture of
Pacific Consultants International and
Yonasho Setkai Inc.

Subcontracted Local Consultant:

TBAH Consultant's
Architect, Engineer

المصمم المهندس المعماري والمهندس المدني



Raghadan Bus Terminal

Drawing Title:


RAIN WATER SYSTEM
FOR GROUND FLOOR ZONE 4


Scale:

1/100

Drawing No.:

RBT .M512

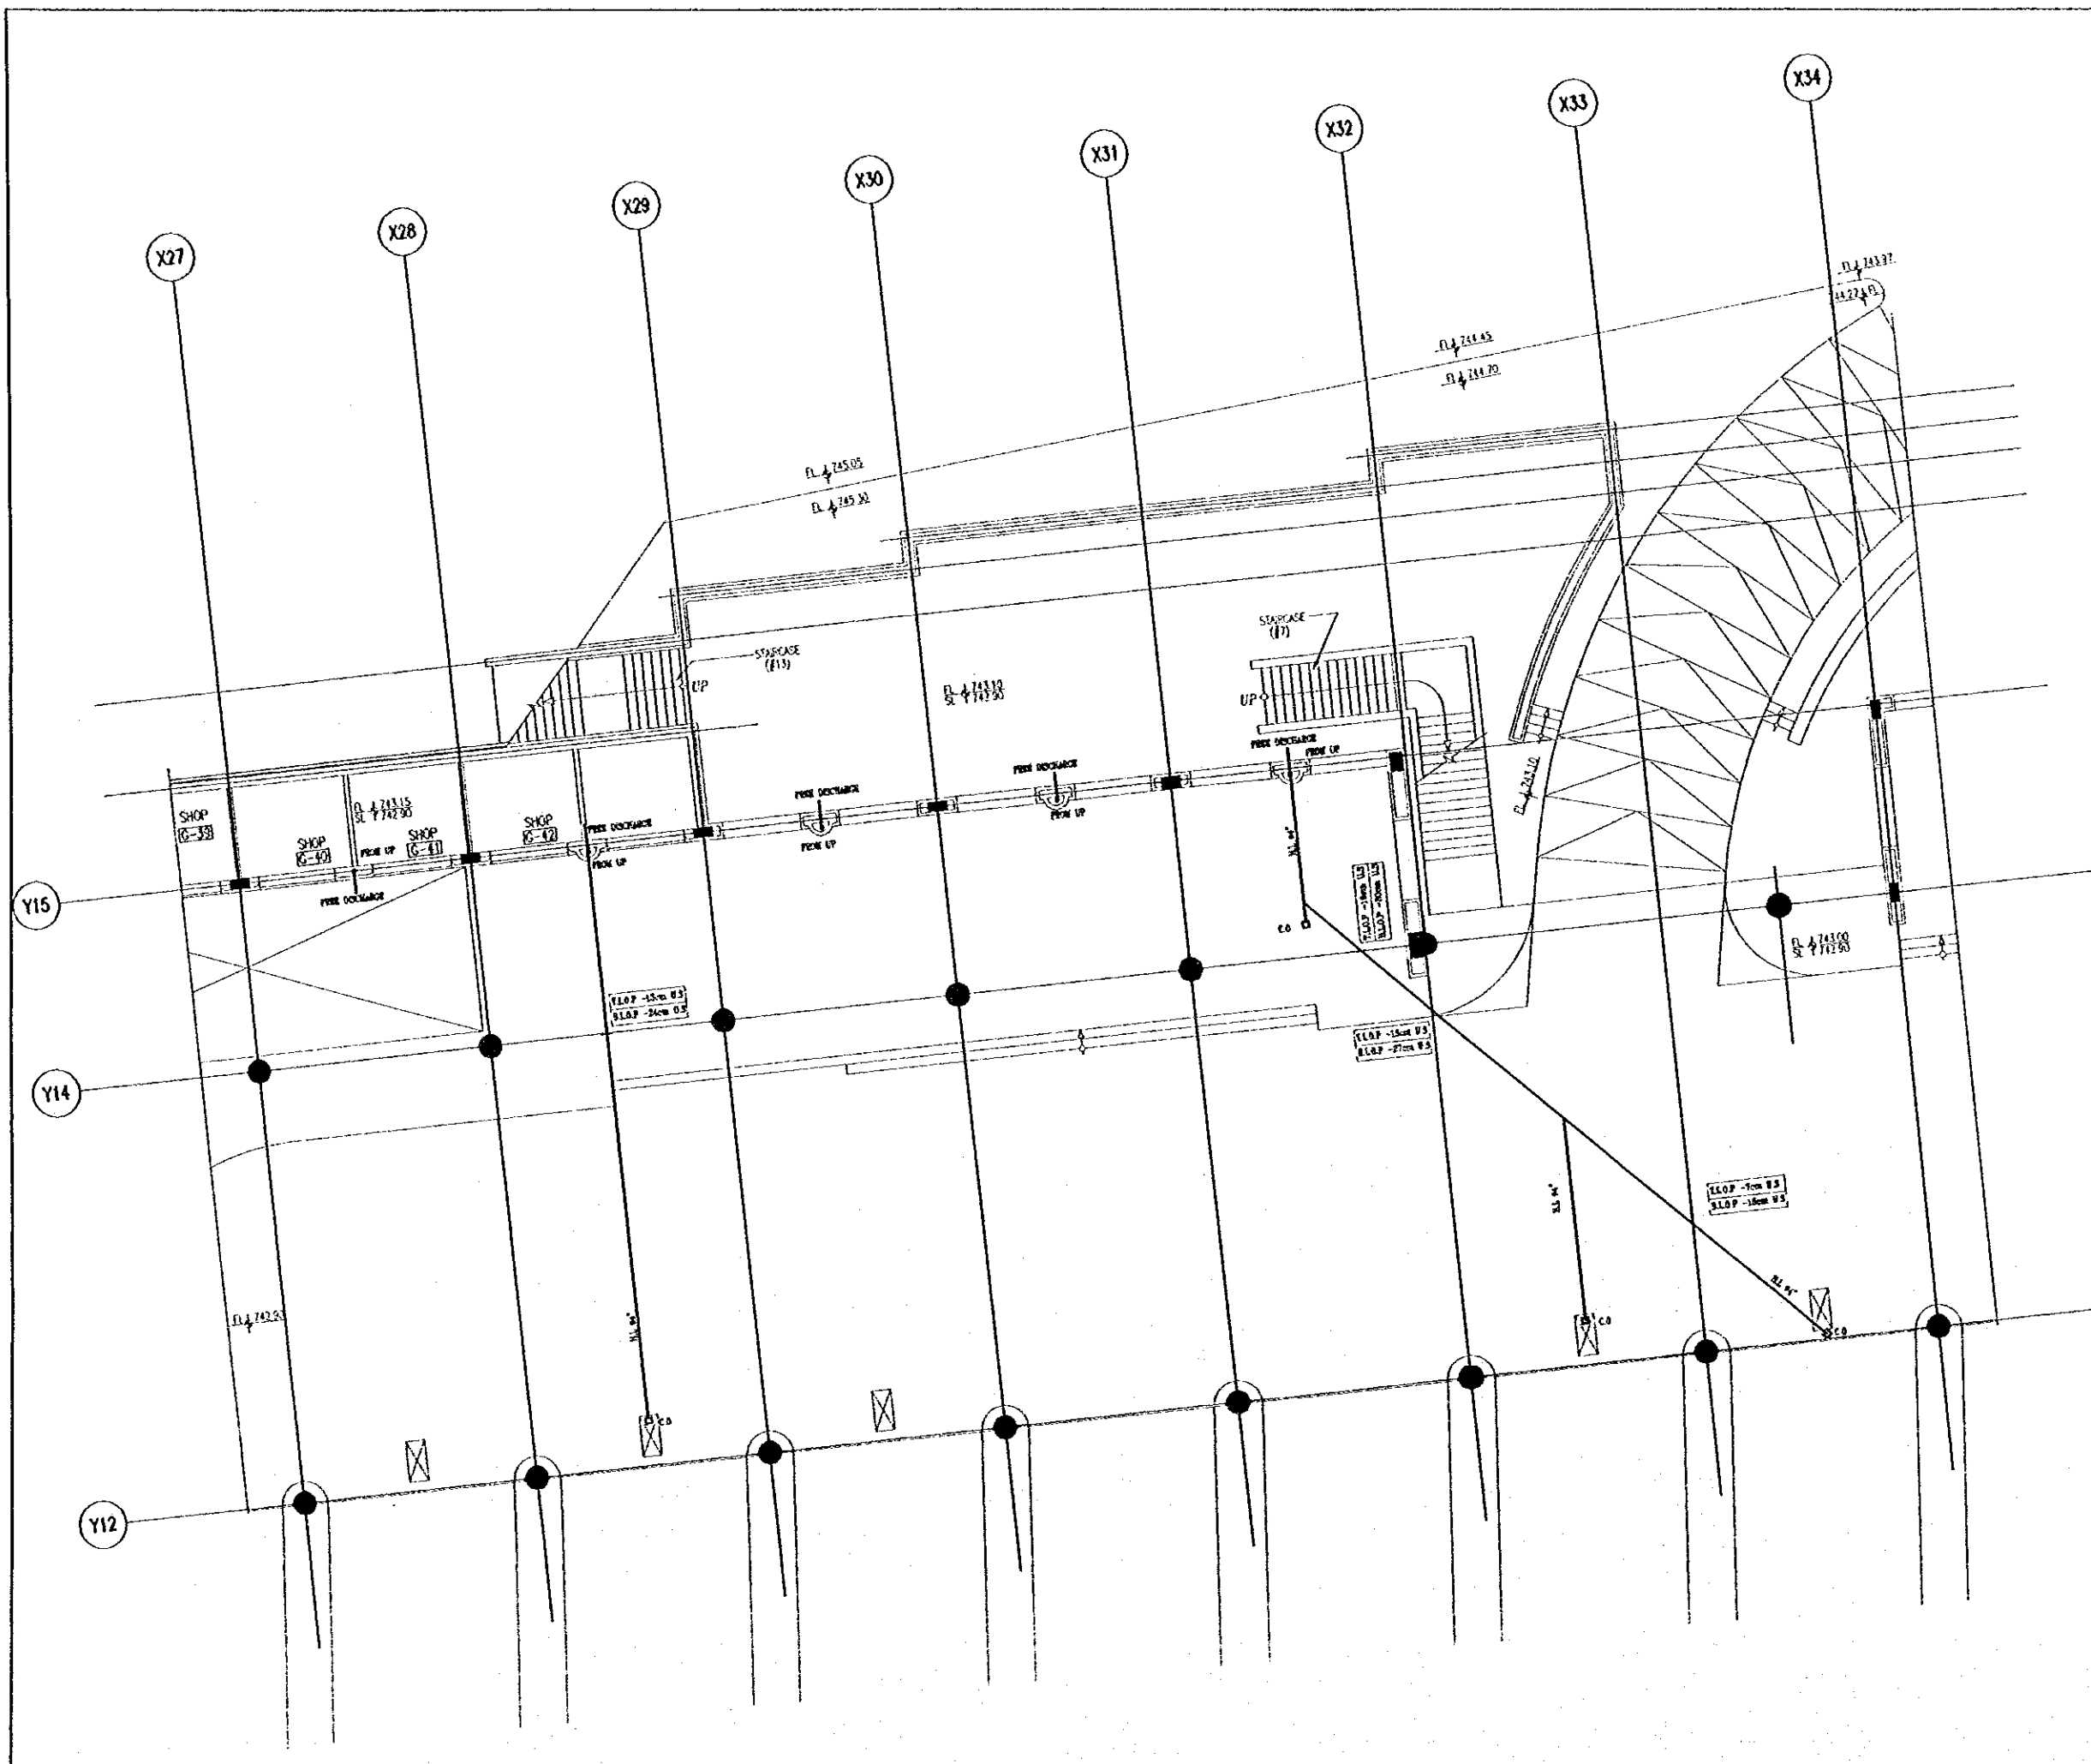

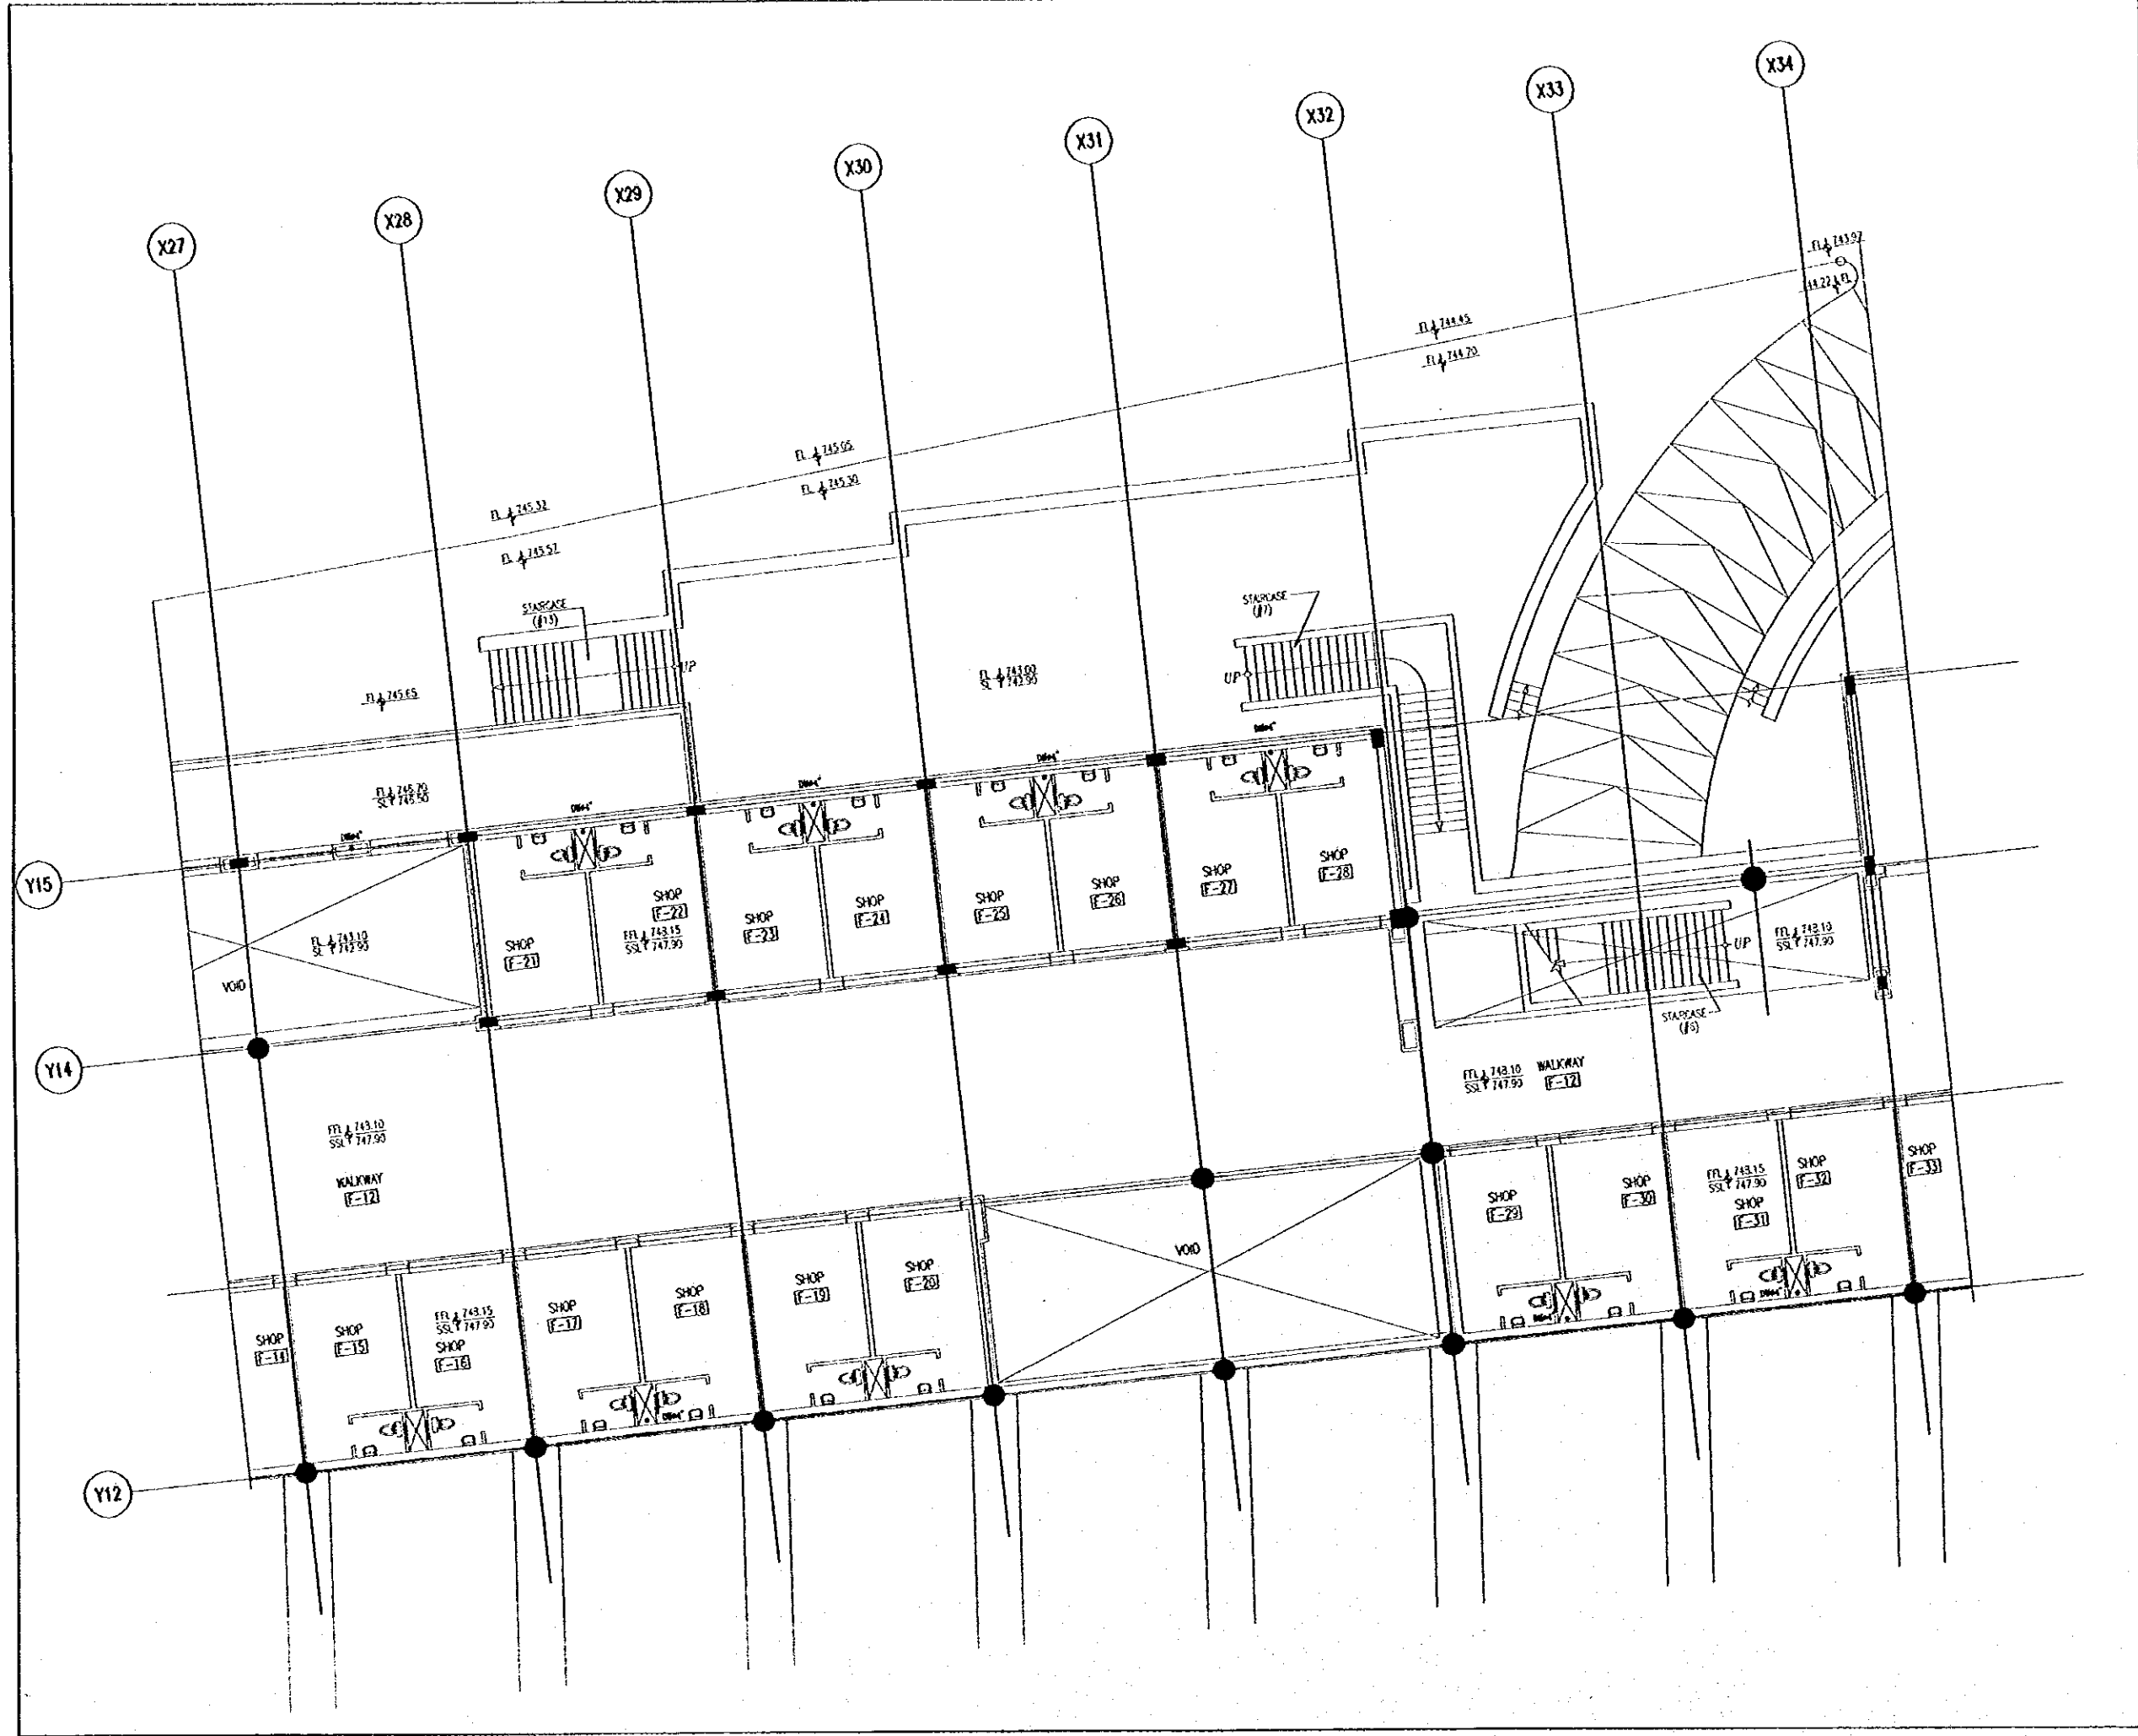

Tourism Sector Development Project
in the Hashemite Kingdom of Jordan

The Government of
the Hashemite Kingdom of Jordan
The Ministry of Tourism and Antiquities
The Ministry of Planning

Sub-Project:
Amman Downtown
Tourist Zone Development

Note:
• This detailed design has been executed by a team of consultants as shown below in accordance with the agreement between Japan International Cooperation Agency (JICA) and JICA Study Team.
• The copyright of this drawing rests with JICA.

Designed by:
Japan International Cooperation Agency
(JICA)

JICA Study Team:
Joint Venture of
Pacific Consultants International and
Yamashita Seki & Inc.

Subcontracted Local Consultant:
TMAH Consultants
Architects Engineers
مستشارية ت. م. ا. ح. م. ا. ح.

Raghadan Bus Terminal

Drawing Title:
RAIN WATER SYSTEM
FOR FIRST FLOOR ZONE 4


Scale: 1/100
Drawing No: RBT .M513

Tourism Sector Development Project
in the Hashemite Kingdom of Jordan

The Government of
the Hashemite Kingdom of Jordan
The Ministry of Tourism and Antiquities
The Ministry of Planning

Sub-Project:
Amman Downtown
Tourist Zone Development

Note:
• This detailed design has been developed by a team of
consultants as shown below in accordance with the agreement
between Japan International Cooperation Agency (JICA) and
JICA Study Team.
• The copyright of this drawing rests with JICA.

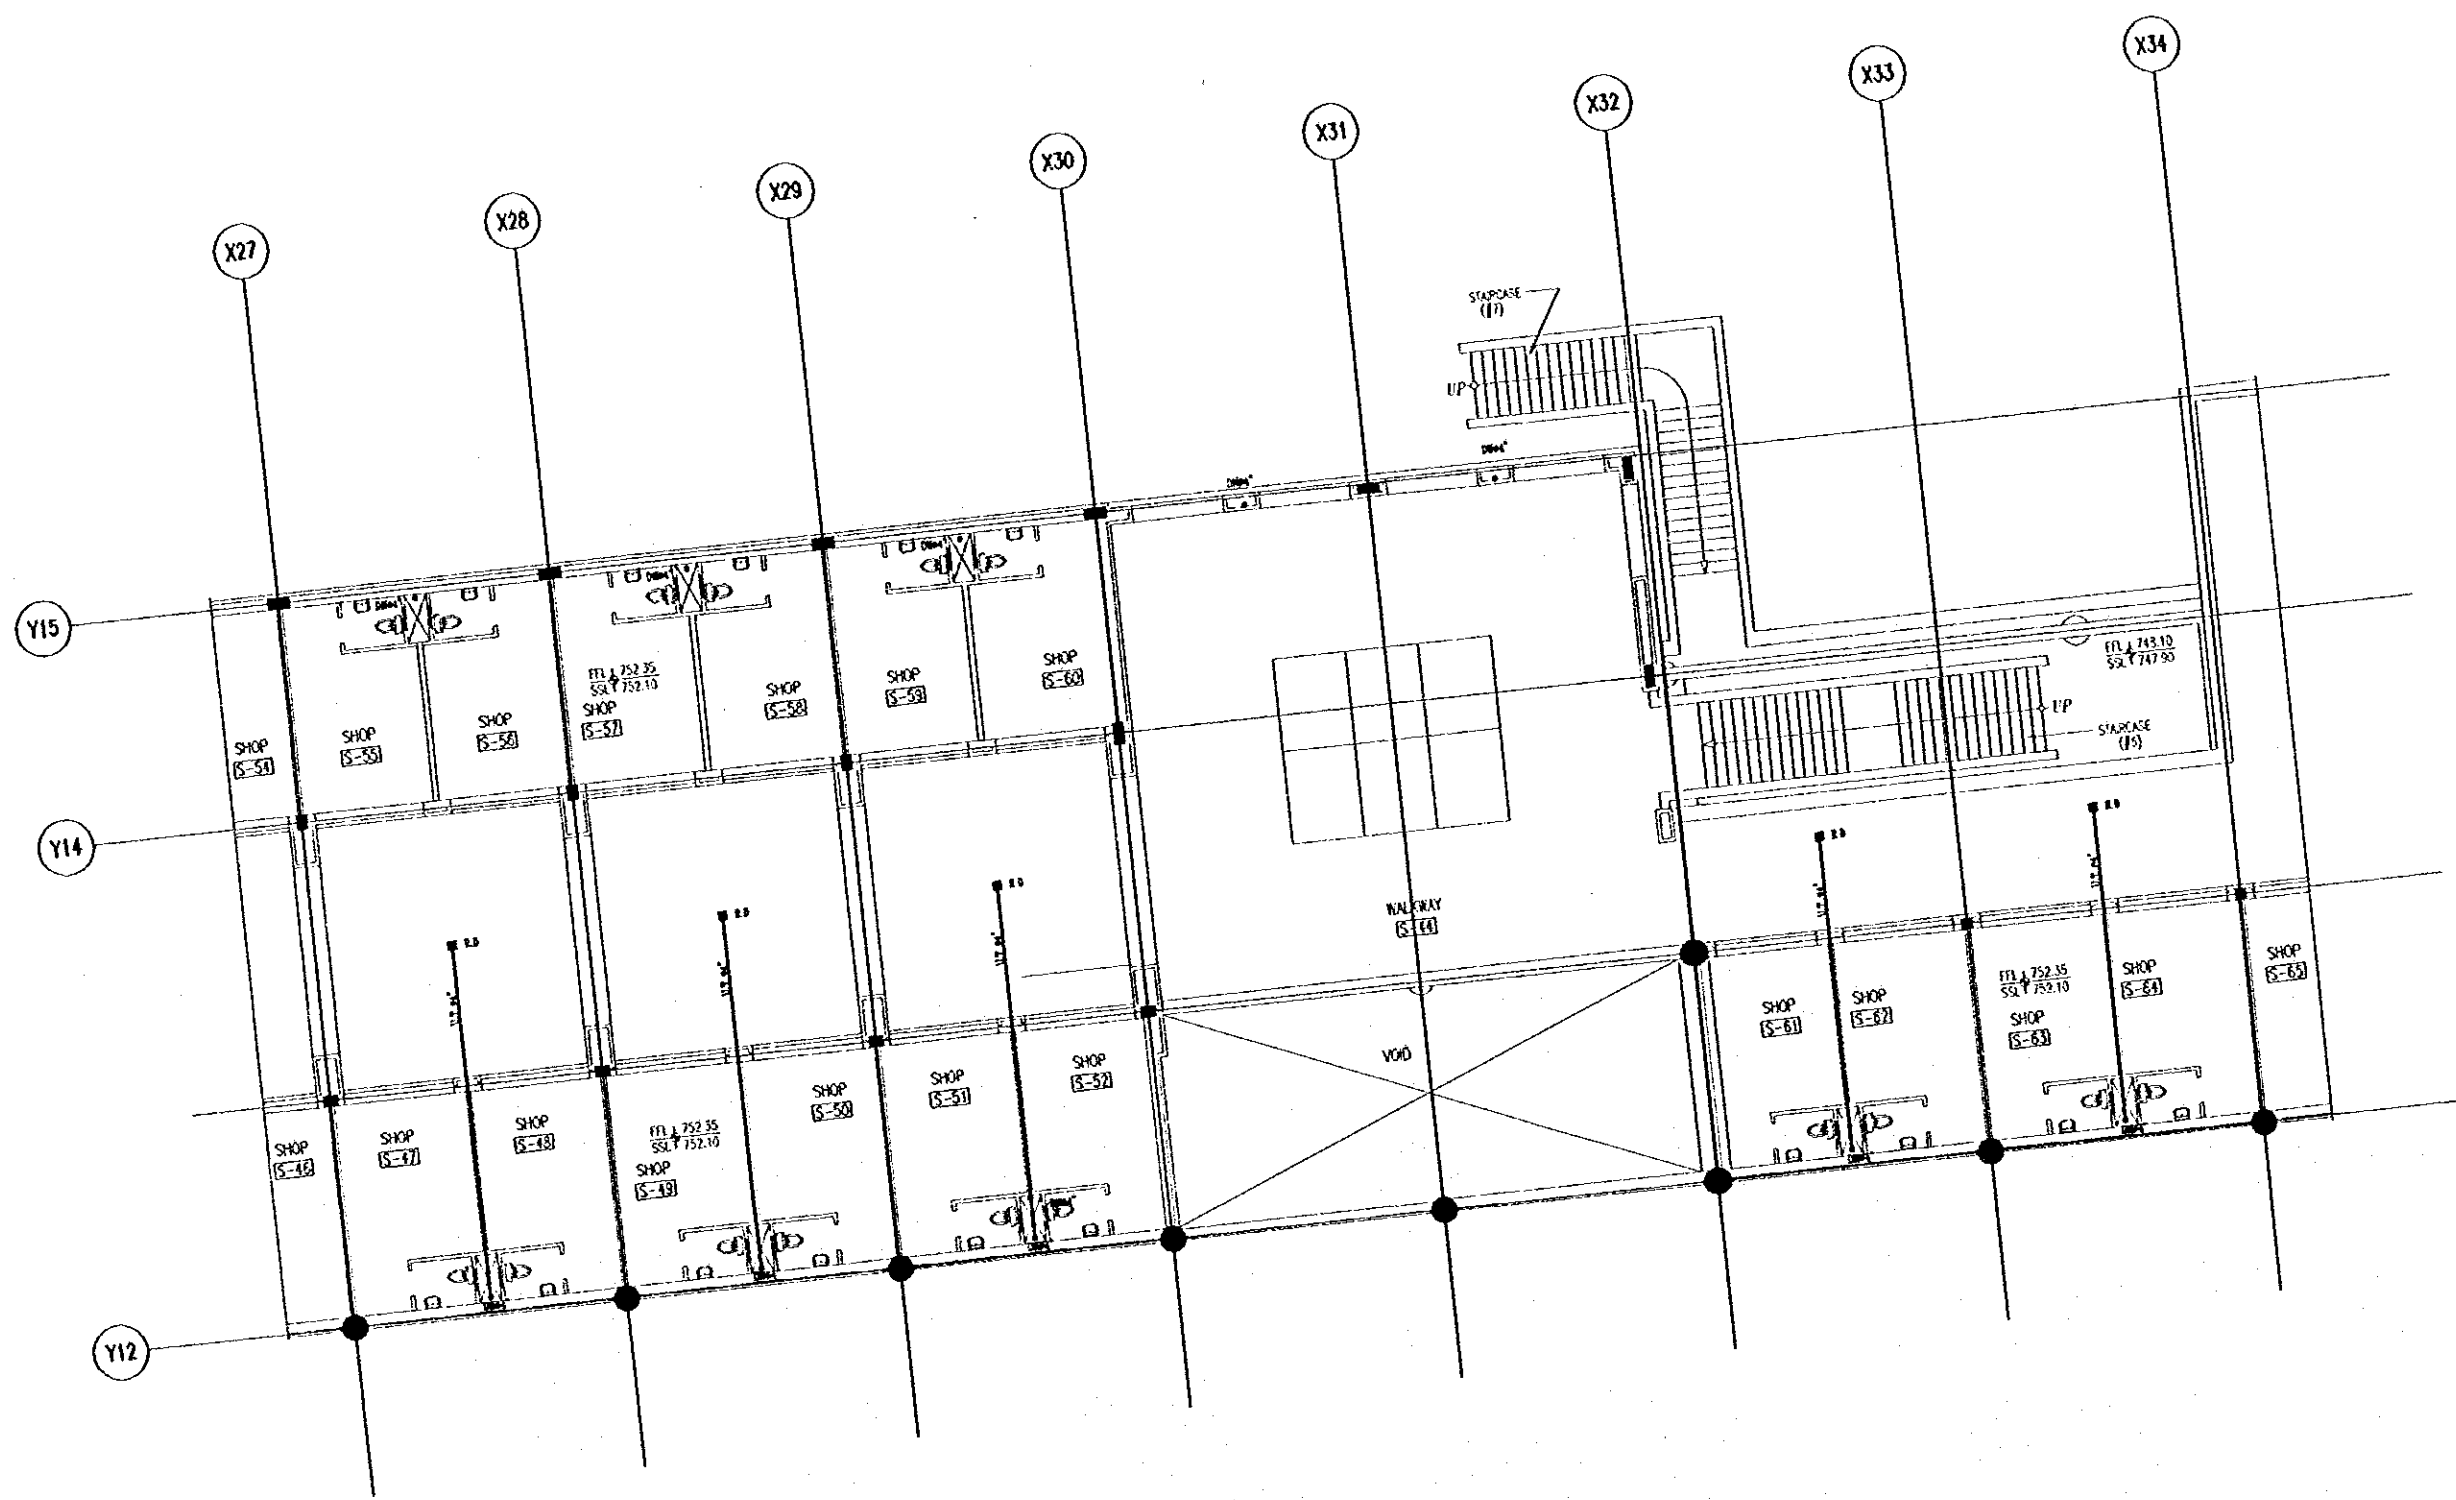

Designed by:
Japan International Cooperation Agency
(JICA)
JICA Study Team:
Joint Venture of
Pacific Consultants International and
Yamato Seiki Inc.
Subcontracted Local Consultant:
TAMM Consultants
Architect, Engineers


Raghadan Bus Terminal
Drawing Title:
RAIN WATER SYSTEM
FOR SECOND FLOOR ZONE 4
Scale:
1/100
Drawing No:
RBT.M514

Tourism Sector Development Project
in the Hashemite Kingdom of Jordan

The Government of
the Hashemite Kingdom of Jordan
The Ministry of Tourism and Antiquities
The Ministry of Planning

Sub-Project:
Amman Downtown
Tourist Zone Development

No's:
• This detailed design has been executed by a team of
consultants as shown below in accordance with the agreement
between Japan International Cooperation Agency (JICA) and
JICA Study Team.
• The copyright of this drawing rests with JICA.

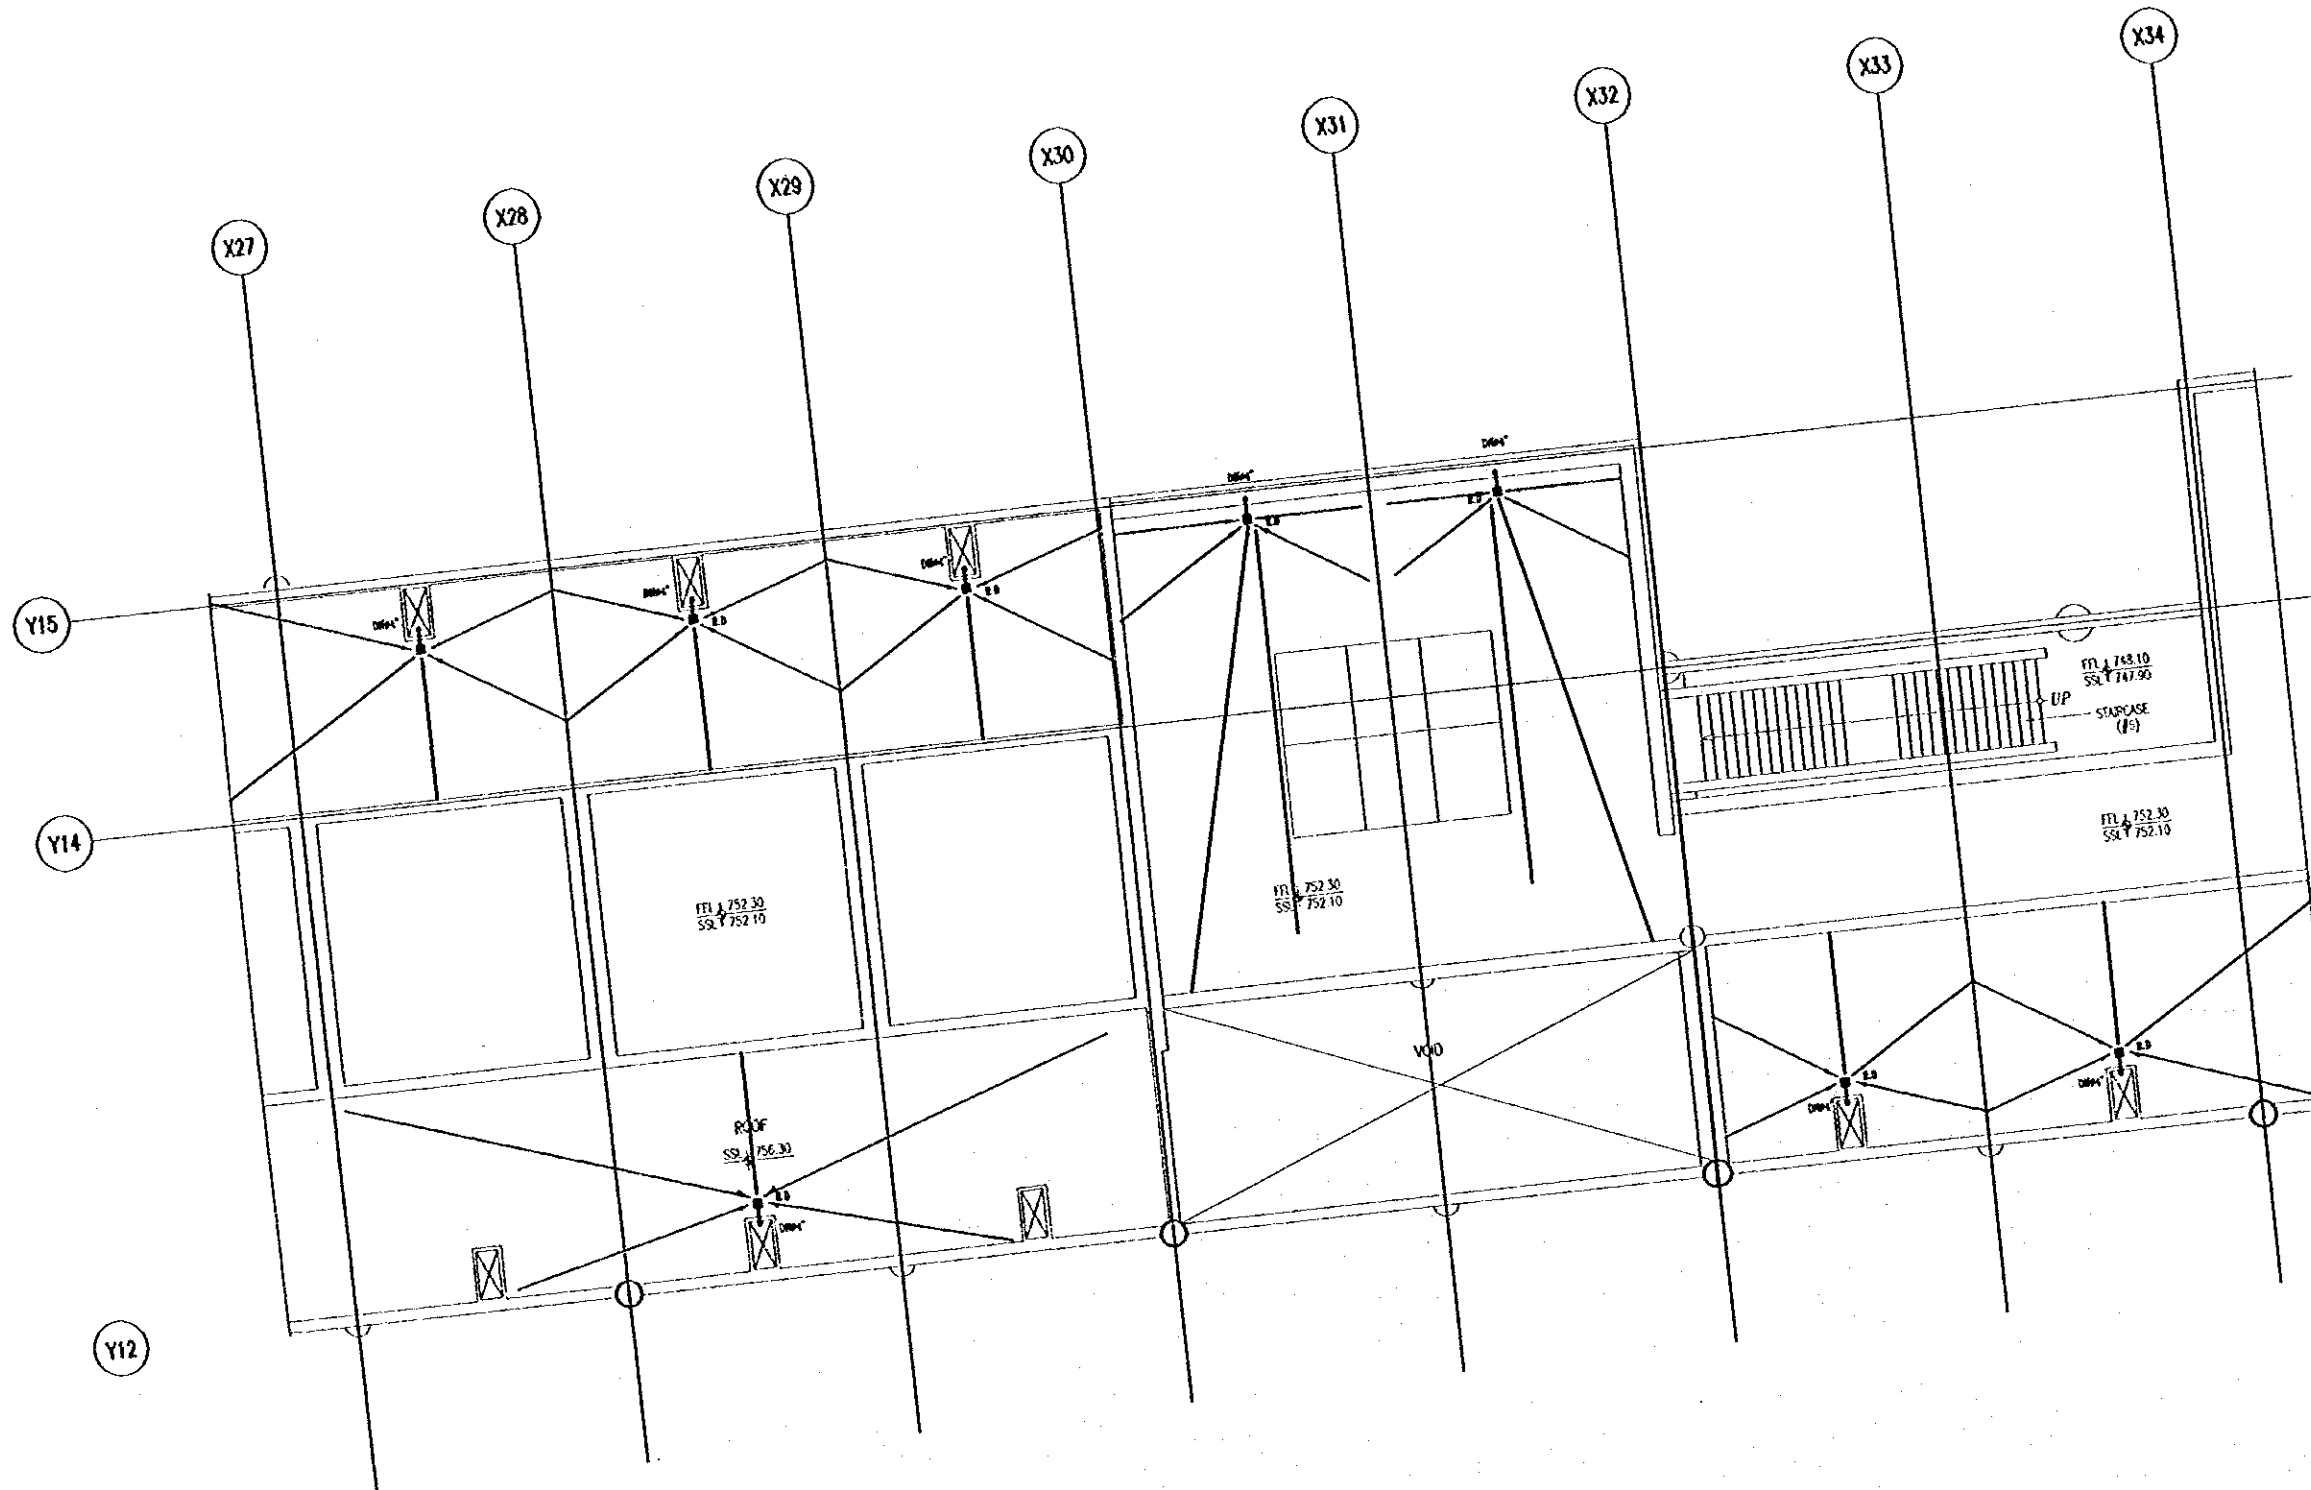

Designed by:
Japan International Cooperation Agency
(JICA)
JICA Study Team:
Joint Venture of
Pacific Consultant's International and
Yamato Sekkei Inc.
Subcontracted Local Consultant:
IBAH Consultants
Architect, Engineers

Raghadan Bus Terminal

Drawing Title:
RAIN WATER SYSTEM
FOR THIRD FLOOR ZONE 4

Scale: 1/100 Drawing No: RBT .M515