


JAPAN INTERNATIONAL COOPERATION AGENCY (JICA)
MINISTRY OF TRANSPORT
SOCIALIST REPUBLIC OF VIET NAM

**THE DETAILED DESIGN
ON
THE CAN THO BRIDGE CONSTRUCTION
IN
SOCIALIST REPUBLIC OF VIET NAM**

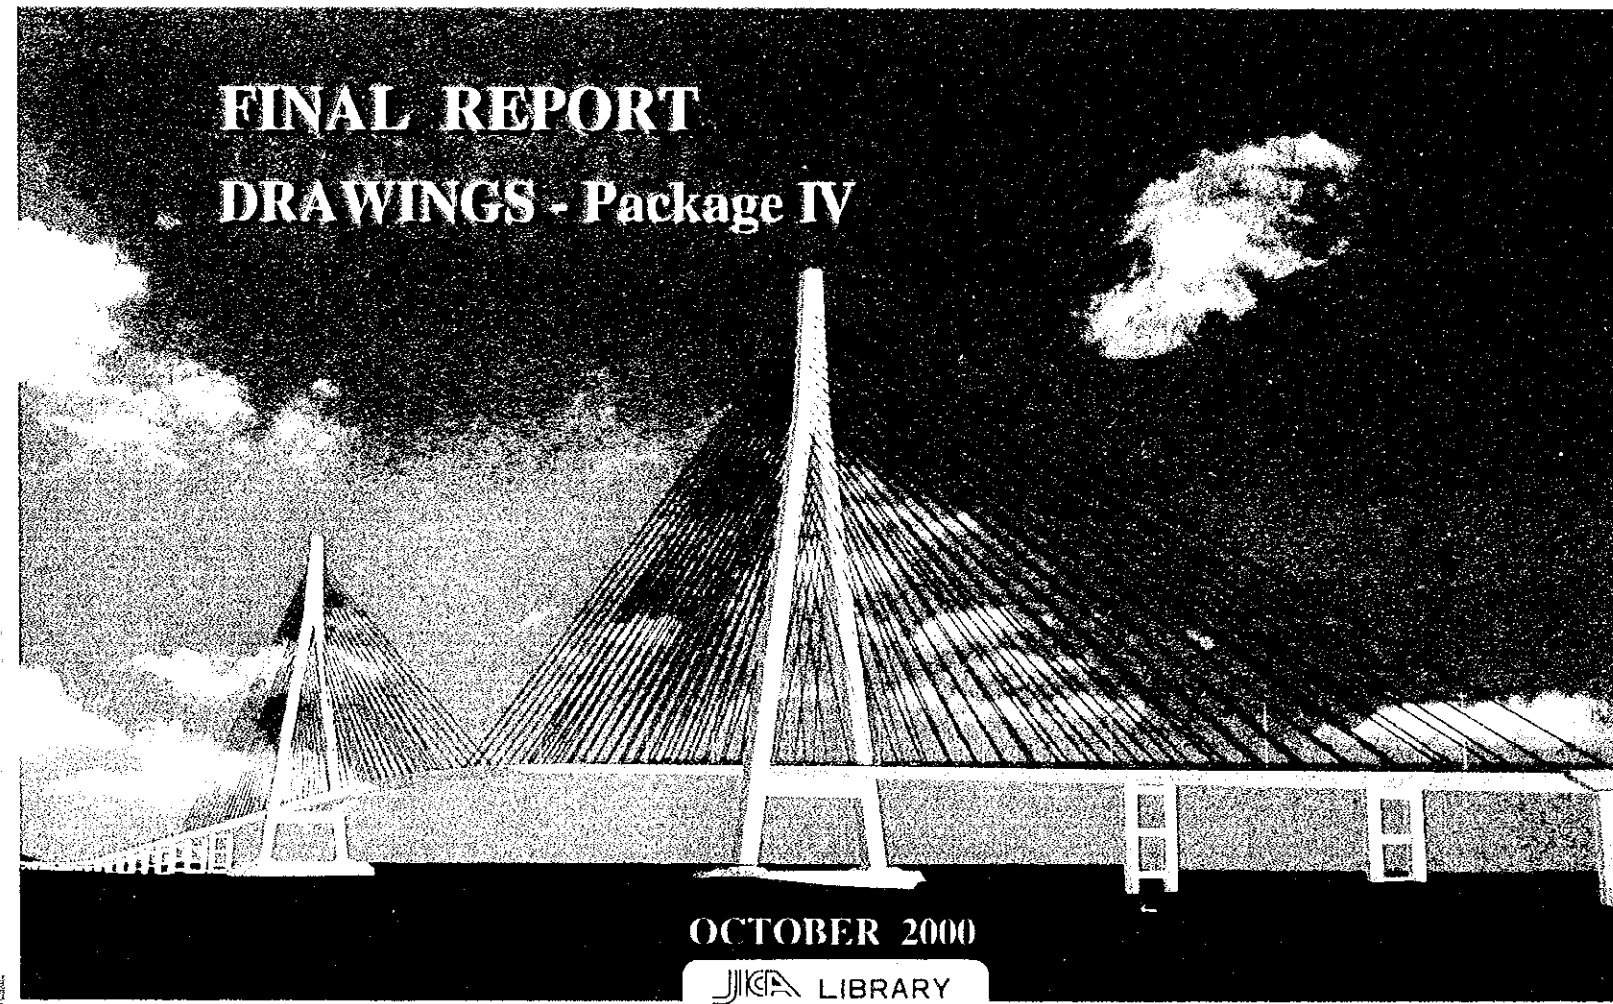

JICA LIBRARY
J1161230(6)

JICA
L123
61.5
SSF
BRARY

JAPAN INTERNATIONAL COOPERATION AGENCY (JICA)
MINISTRY OF TRANSPORT
SOCIALIST REPUBLIC OF VIET NAM

**THE DETAILED DESIGN
ON
THE CAN THO BRIDGE CONSTRUCTION
IN
SOCIALIST REPUBLIC OF VIET NAM**

**FINAL REPORT
DRAWINGS - Package IV**

OCTOBER 2000

NIPPON KOEI CO., LTD.



1161230 [6]

JAPAN INTERNATIONAL COOPERATION AGENCY (JICA)
MINISTRY OF TRANSPORT OF SOCIALIST REPUBLIC OF VIET NAM

THE DETAILED DESIGN
OF
THE CAN THO BRIDGE CONSTRUCTION
IN
SOCIALIST REPUBLIC OF VIET NAM

R E S E T T L E M E N T A R E A

P A C K A G E 4

BINH MINH DISTRICT IN VINH LONG PROVINCE

VOLUME III

D R A W I N G S

FEBRUARY 2000

NIPPON KOEI CO., LTD.


DRAWINGS LIST

PACKAGE 4



Sheet No


Drawing No

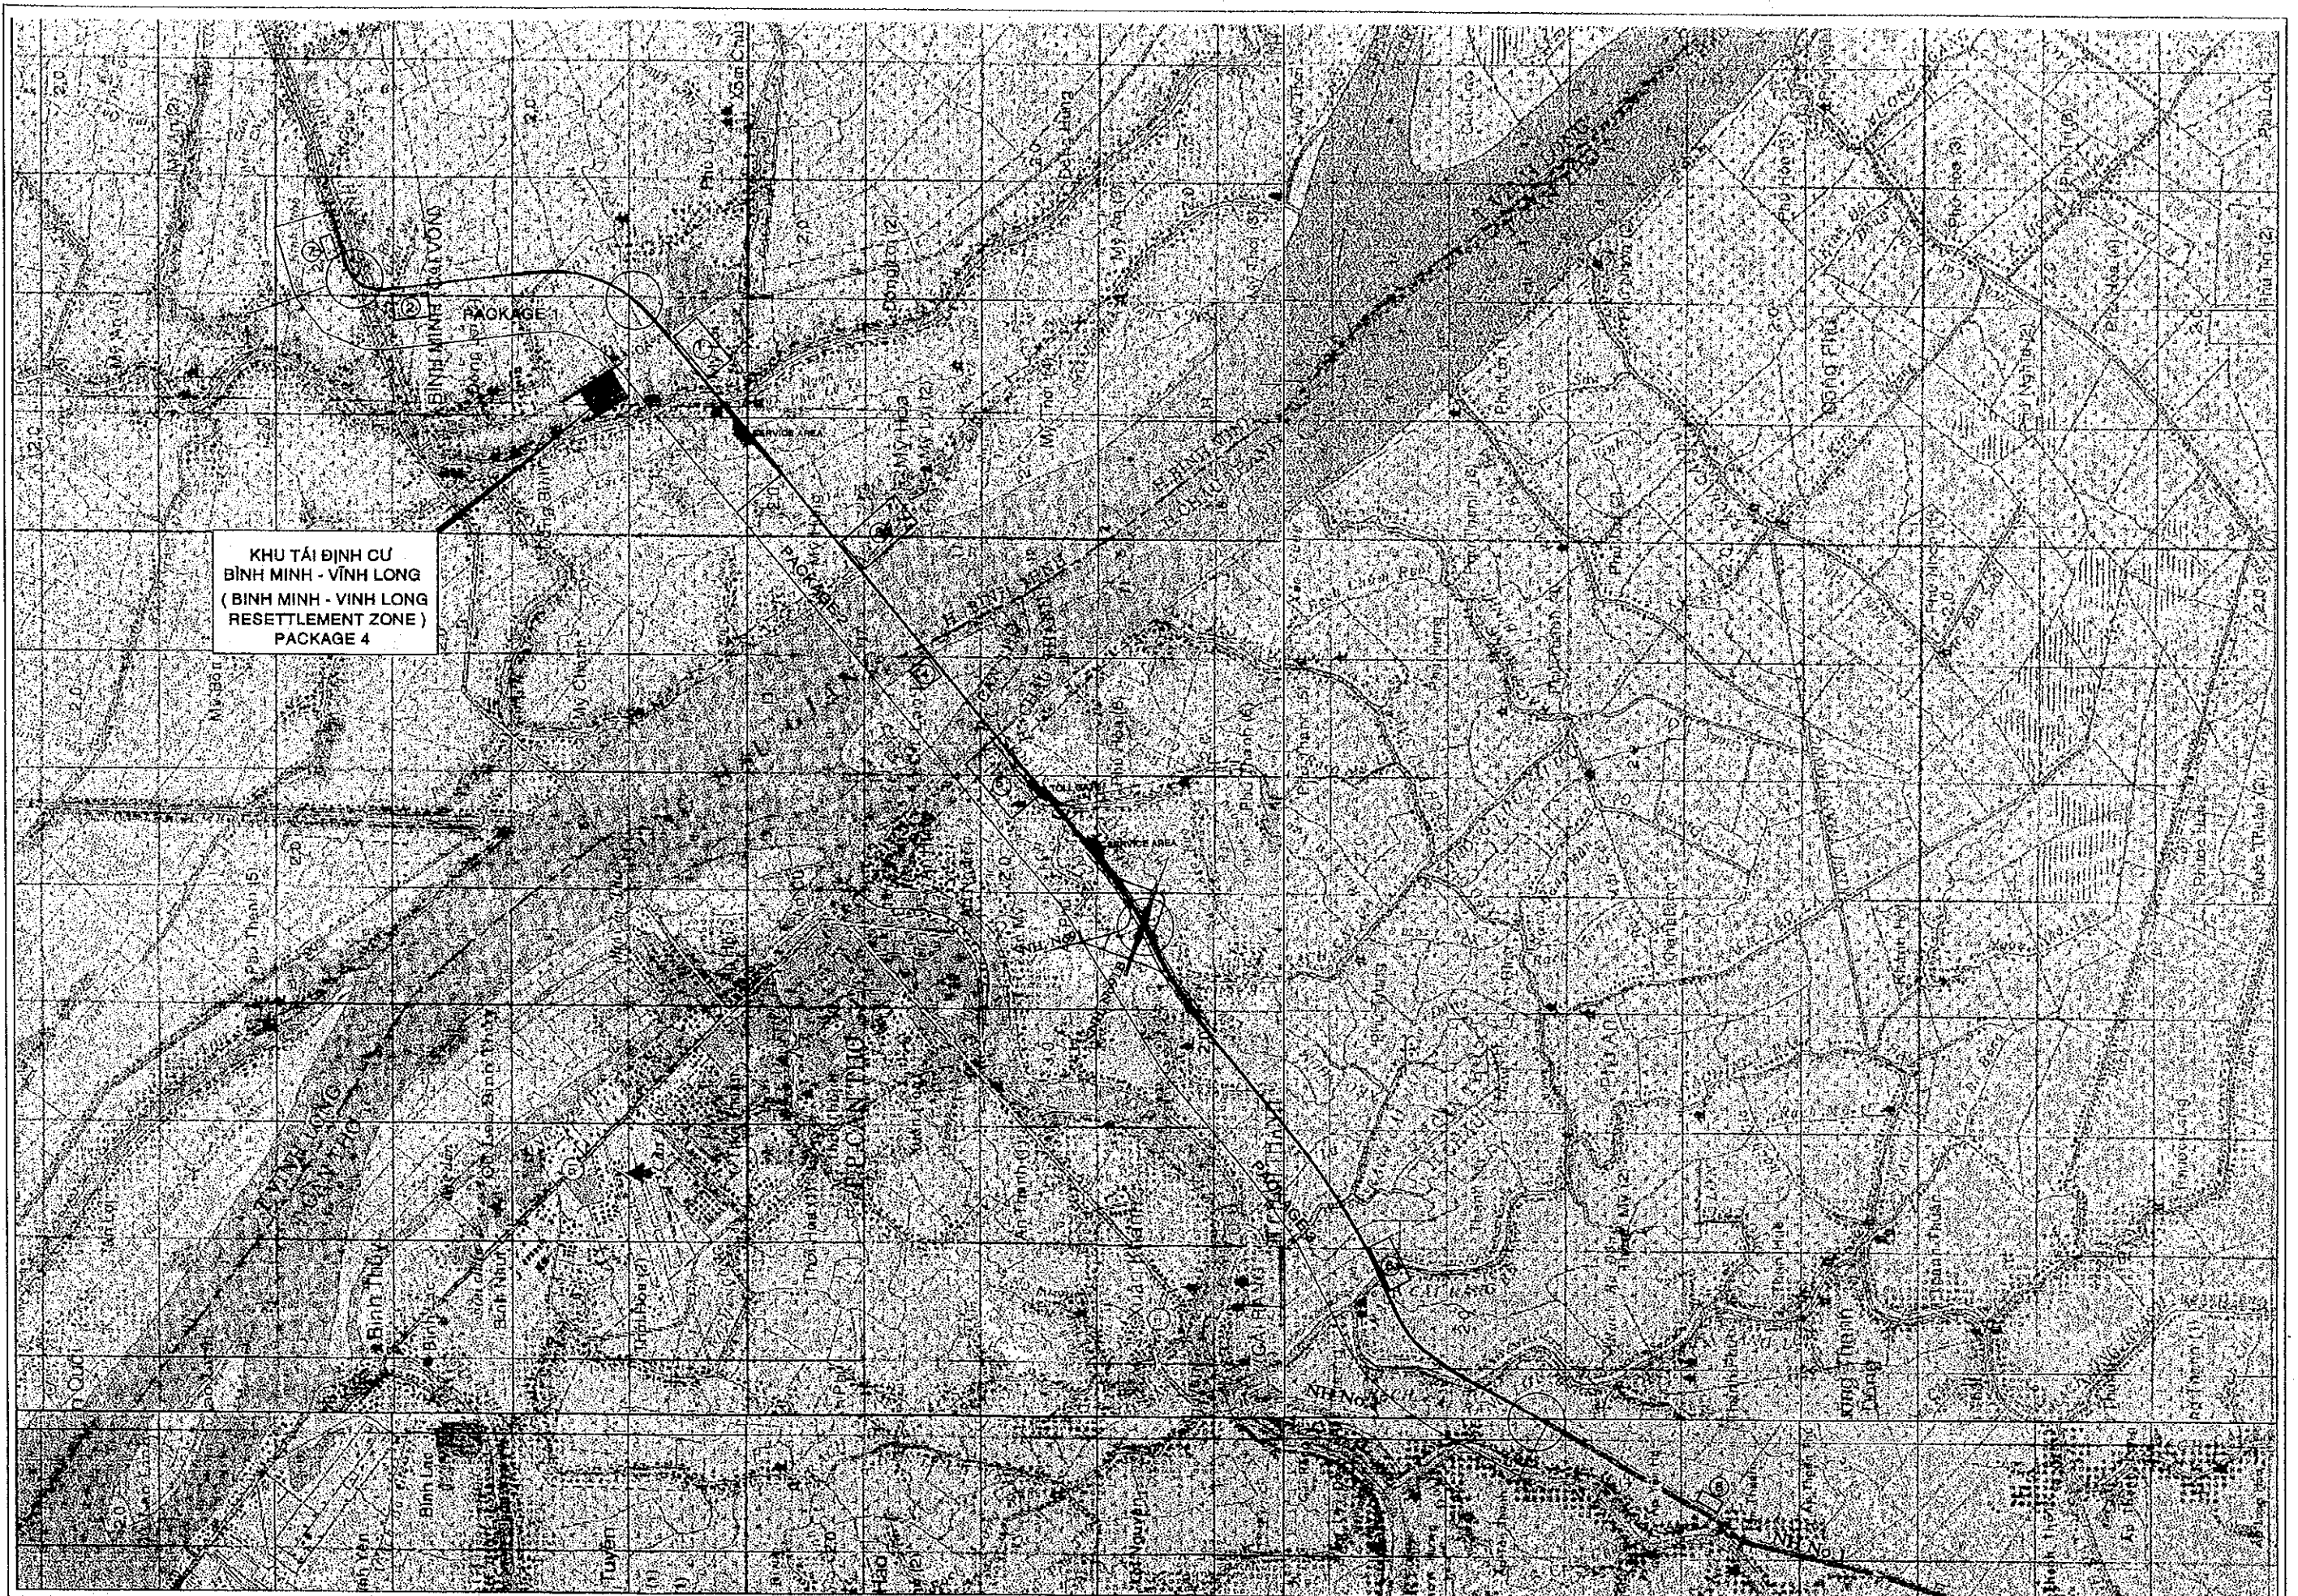1	- Cover Sheet	1 / 25
2	- Drawings List	2 / 25
3	- Vicinity Map	3 / 25
4, 5	- Location Plan	4 / 25 , 5 / 25
6, 7	- Grading Plan	6 / 25 , 7 / 25
8, 9	- Drainage Systems Plan	8 / 25 , 9 / 25
10, 11	- Water Distribution Plan	10 / 25 , 11 / 25
12, 13	- Electrical Distribution Plan	12 / 25 , 13 / 25
14	- Typical Section, Road Cross Section & Details	14 / 25
15, 16	- Cross Sections	15 / 25 , 16 / 25
17, 18, 19	- Detailed of Drainage Structures	17 / 25 , 18 / 25 , 19 / 25
20	- Details of Water Treatment Diagram	20 / 25
21	- Details of Water Treatment Plant	21 / 25
22	- Electrical Details	22 / 25
23	- Public Toilet Layout Plan	23 / 25
24	- Details of Septic Tank	24 / 25
25	- Architect of Water Treatment Plant	25 / 25




KHU TÁI ĐỊNH CƯ
 BÌNH MINH - VINH LONG
 (BÌNH MINH - VINH LONG
 RESETTLEMENT ZONE)
 PACKAGE 4


PROJECT NAME DETAILED DESIGN OF THE CAN THO BRIDGE CONSTRUCTION PROJECT	IMPLEMENTATION AGENCY  JAPAN INTERNATIONAL COOPERATION AGENCY (JICA)	EXECUTING AGENCY SOCIALIST REPUBLIC OF VIET NAM MINISTRY OF TRANSPORT (MOT) MY THUAN PROJECT MANAGEMENT UNIT	JICA STUDY TEAM  NIPPON KOEI CO.,LTD.	PREPARED BY NAME SIGNATURE 4-A-2000	CHECKED BY NAME SIGNATURE 4-A-2000	APPROVED BY NAME SIGNATURE 4-A-2000	DRAWING TITLE VICINITY MAP	DWG NO. 3/25
---	---	--	--	---	--	---	--------------------------------------	------------------------

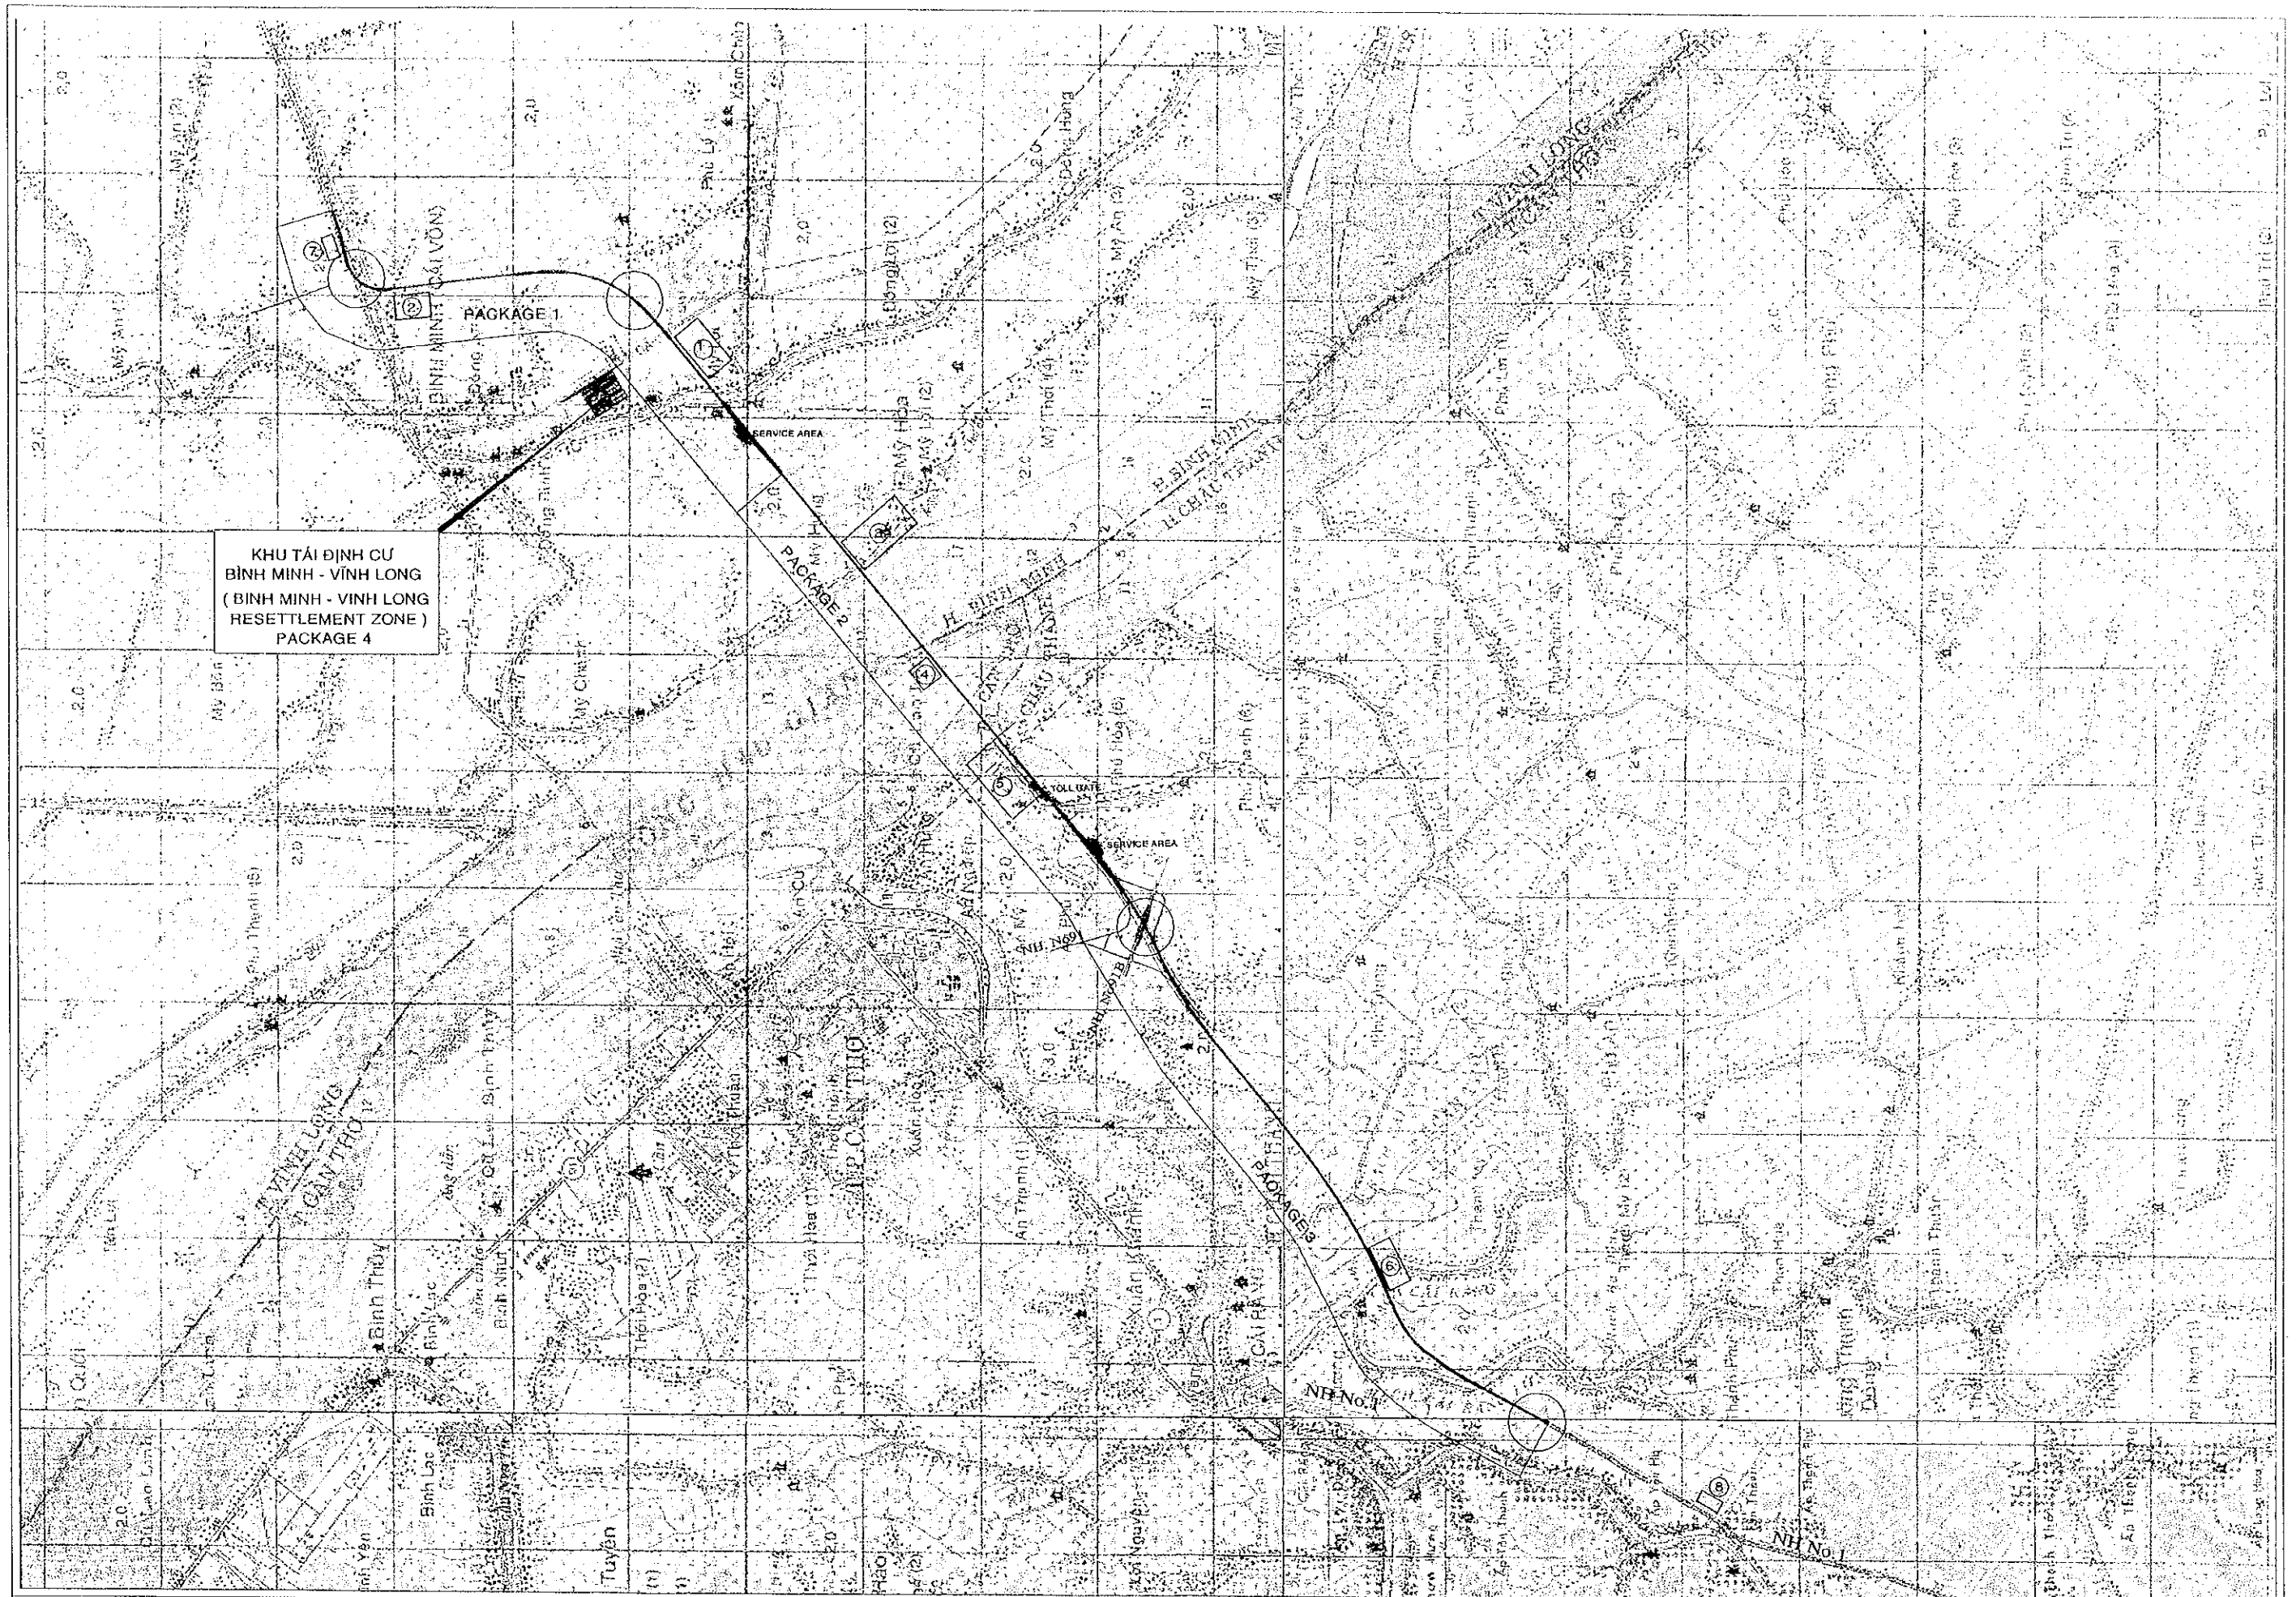

PROJECT NAME DETAILED DESIGN OF THE CAN THO BRIDGE CONSTRUCTION PROJECT	IMPLEMENTATION AGENCY JICA JAPAN INTERNATIONAL COOPERATION AGENCY (JICA)	EXECUTING AGENCY SOCIALIST REPUBLIC OF VIET NAM MINISTRY OF TRANSPORT (MOT) MY THUAN PROJECT MANAGEMENT UNIT	JICA STUDY TEAM (NK) NIPPON KOEI CO.,LTD.	PREPARED BY	CHECKED BY	APPROVED BY	DRAWING TITLE VICINITY MAP	DWG NO. 3/25
				NAME LE THI VAN PHU	NAME LE THI VAN PHU	NAME M. FUJIKAWA		
				SIGNATURE [Signature]	SIGNATURE [Signature]	SIGNATURE [Signature]		
				DATE 4-4-2000	DATE 4-4-2000	DATE 4/4/2000		

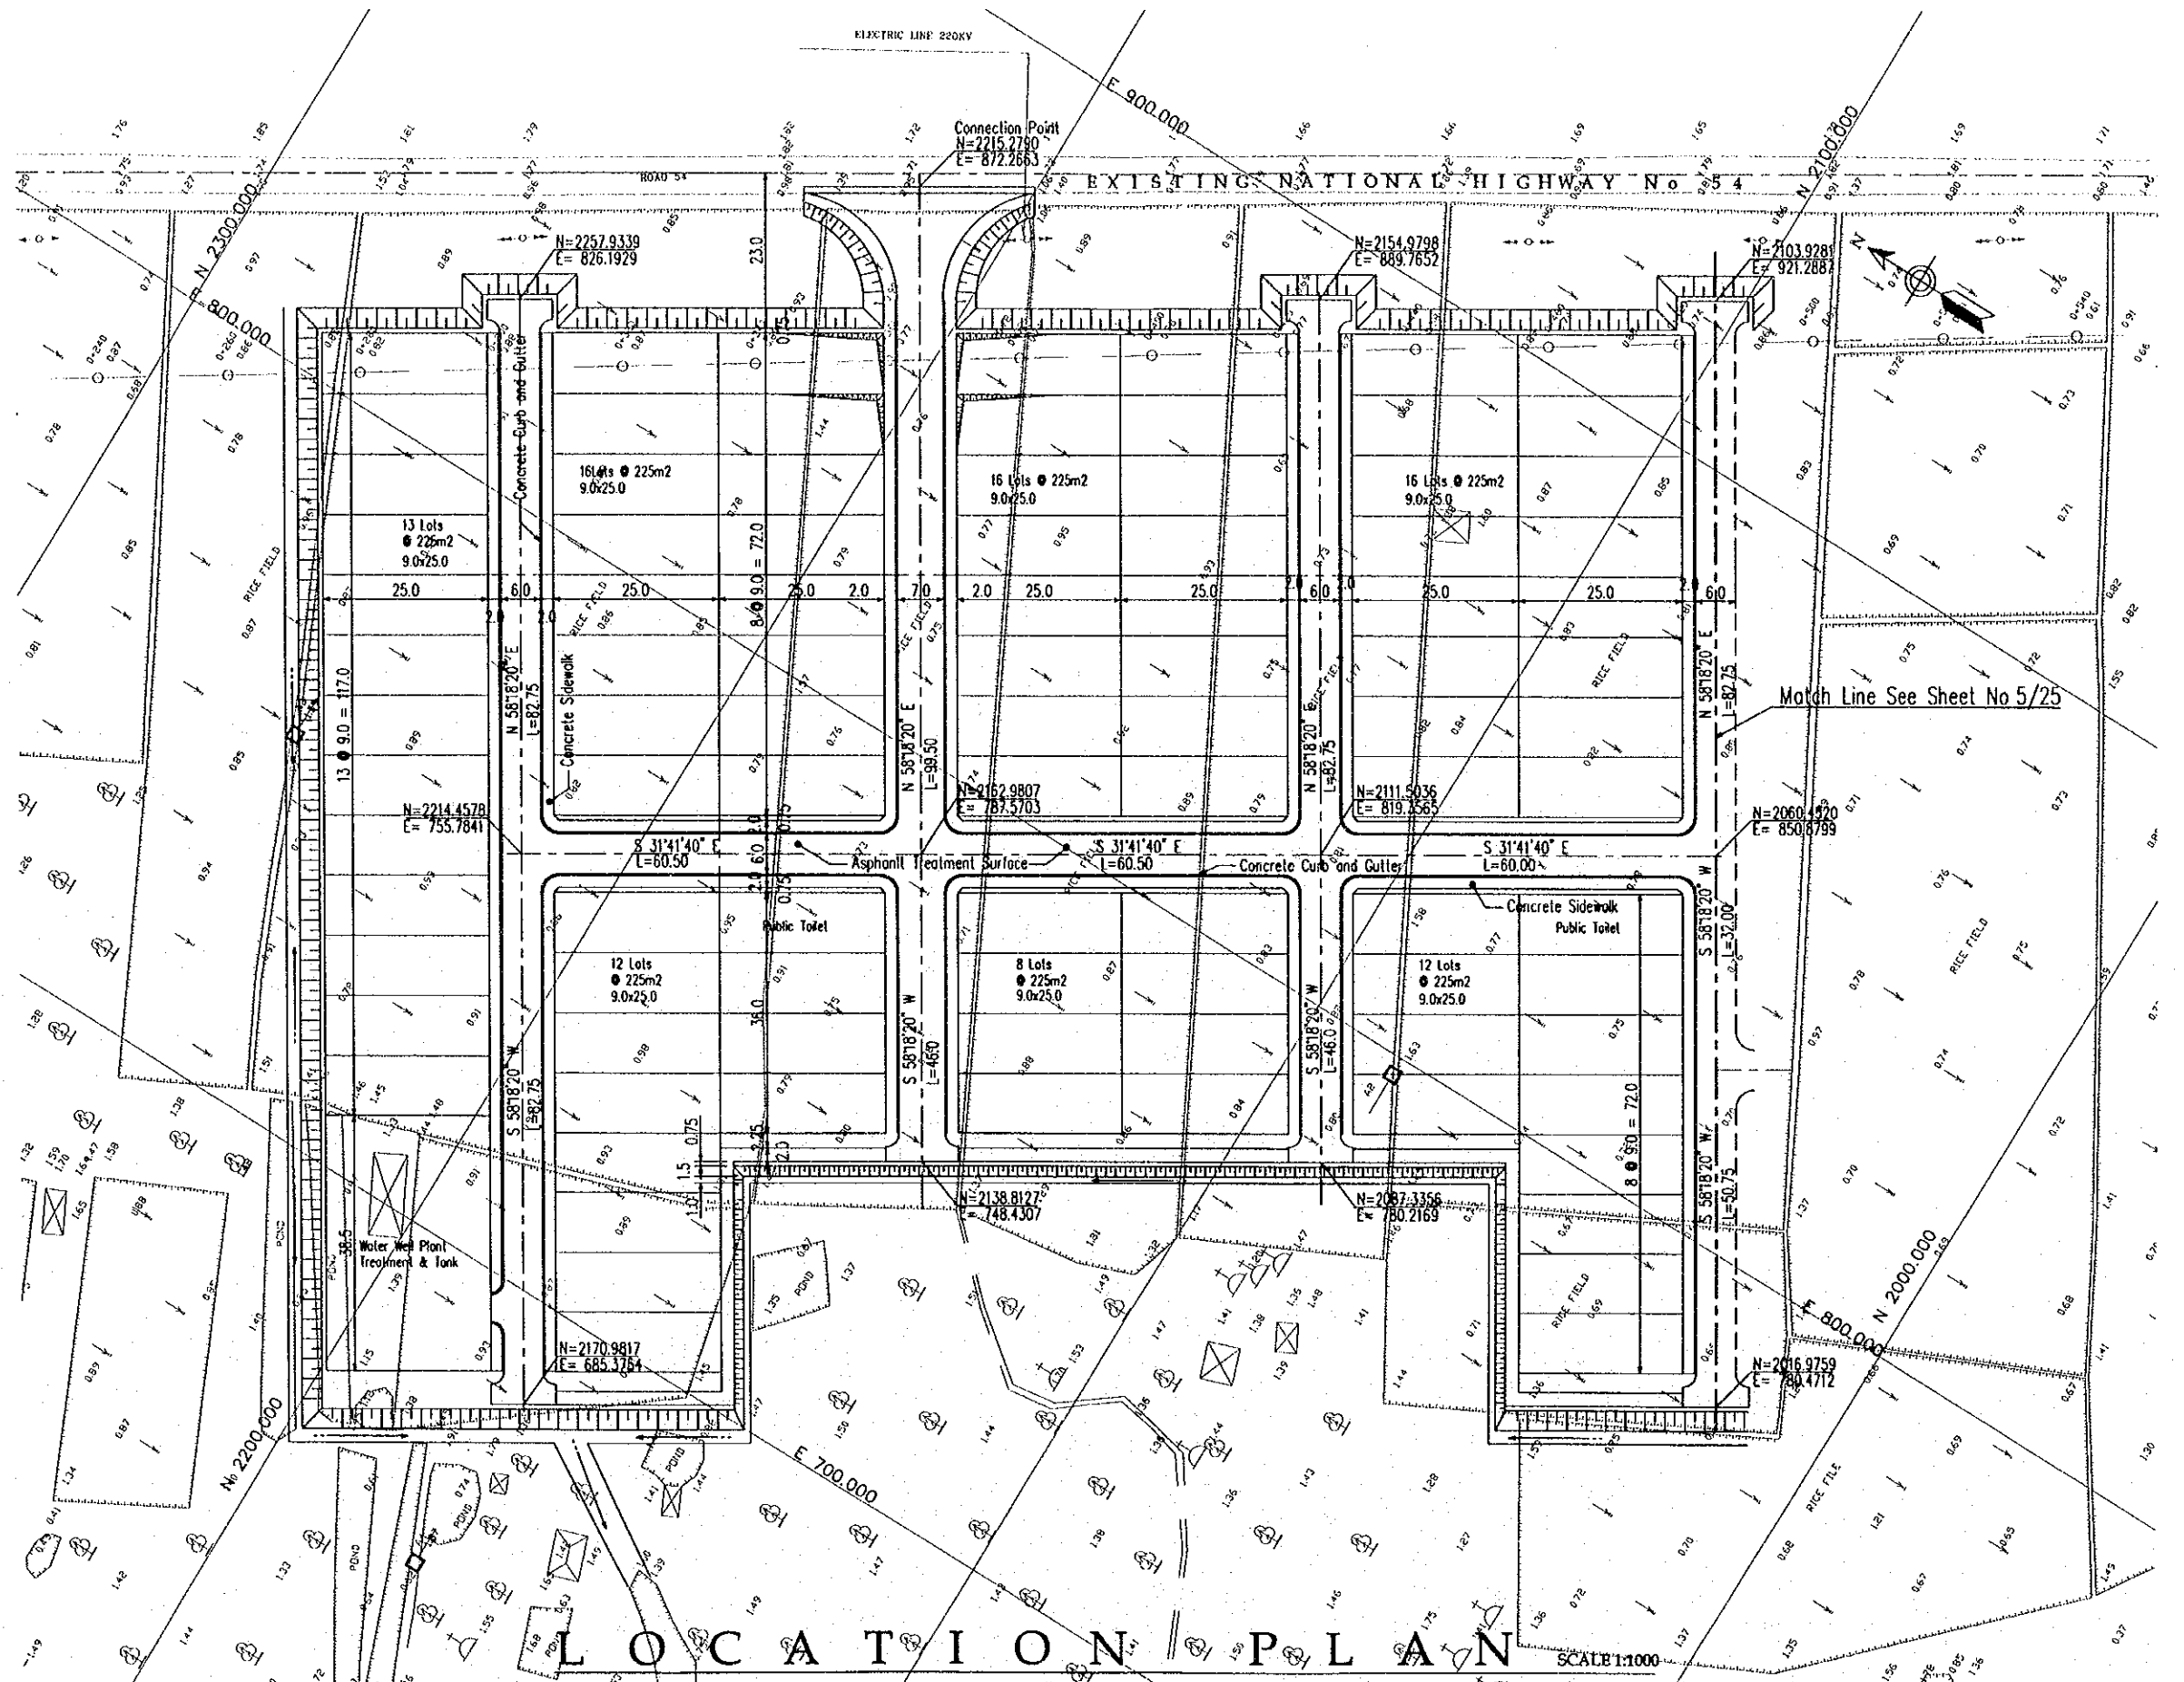


PROJECT NAME	IMPLEMENTATION AGENCY	EXECUTING AGENCY	JICA STUDY TEAM	PREPARED BY	CHECKED BY	APPROVED BY	DRAWING TITLE	DWG NO.
DETAILED DESIGN OF THE CAN THO BRIDGE CONSTRUCTION PROJECT	JICA JAPAN INTERNATIONAL COOPERATION AGENCY (JICA)	SOCIALIST REPUBLIC OF VIET NAM MINISTRY OF TRANSPORT (MOT) MY THUAN PROJECT MANAGEMENT UNIT	(NK) NIPPON KOEI CO.,LTD.	NAME: VOHY HAI SIGNATURE: <i>[Signature]</i> DATE: 4.11.2000	NAME: M. FUJIKAWA SIGNATURE: <i>[Signature]</i> DATE: 05/11/2000	NAME: H. FUJIKAWA SIGNATURE: <i>[Signature]</i> DATE: 05/11/2000	LOCATION PLAN	4/25

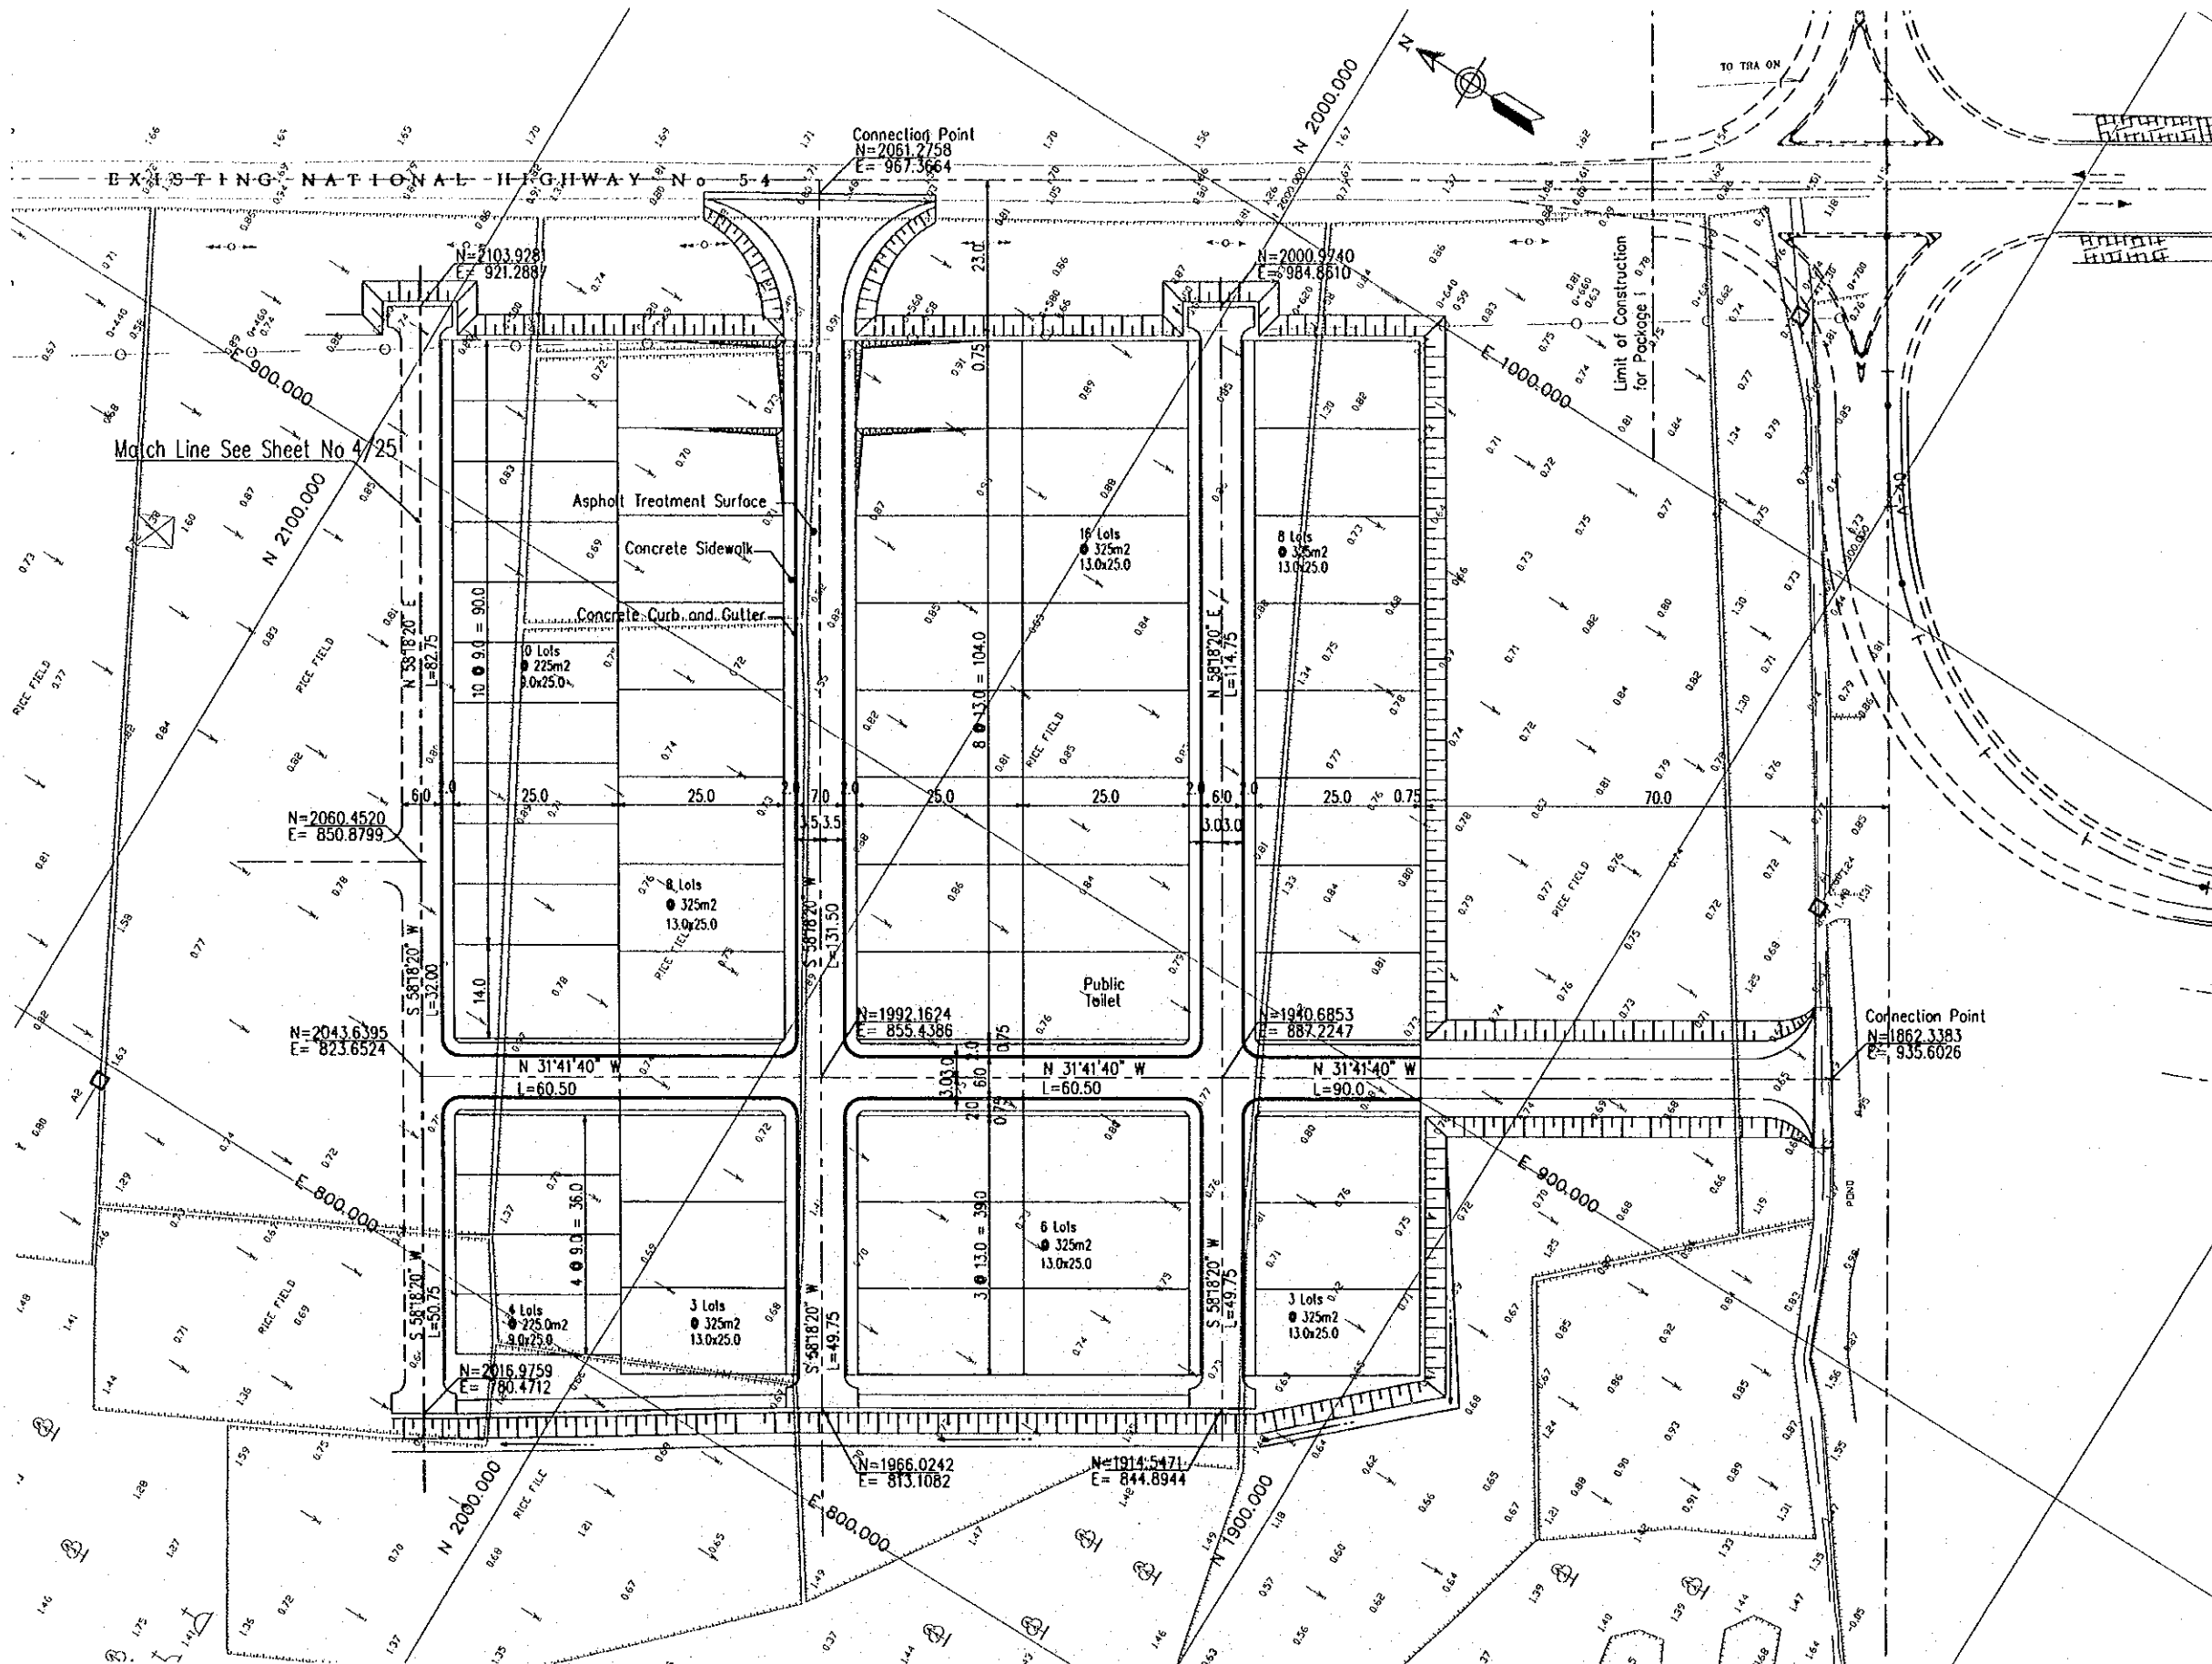


LOCATION PLAN SCALE 1:1000

PROJECT NAME	IMPLEMENTATION AGENCY	EXECUTING AGENCY	JICA STUDY TEAM	PREPARED BY	CHECKED BY	APPROVED BY	DRAWING TITLE	DWG NO.
DETAILED DESIGN OF THE CAN THO BRIDGE CONSTRUCTION PROJECT	JAPAN INTERNATIONAL COOPERATION AGENCY (JICA)	SOCIALIST REPUBLIC OF VIET NAM MINISTRY OF TRANSPORT (MOT) MY THUAN PROJECT MANAGEMENT UNIT	NIPPON KOEI CO., LTD.	NAME VOHY HAI	M. FUJIKAWA	M. FUJIKAWA	LOCATION PLAN	5/25
				SIGNATURE <i>[Signature]</i>	<i>[Signature]</i>	<i>[Signature]</i>		
				DATE 4.4.2000	05/04/2000	05/04/2000		

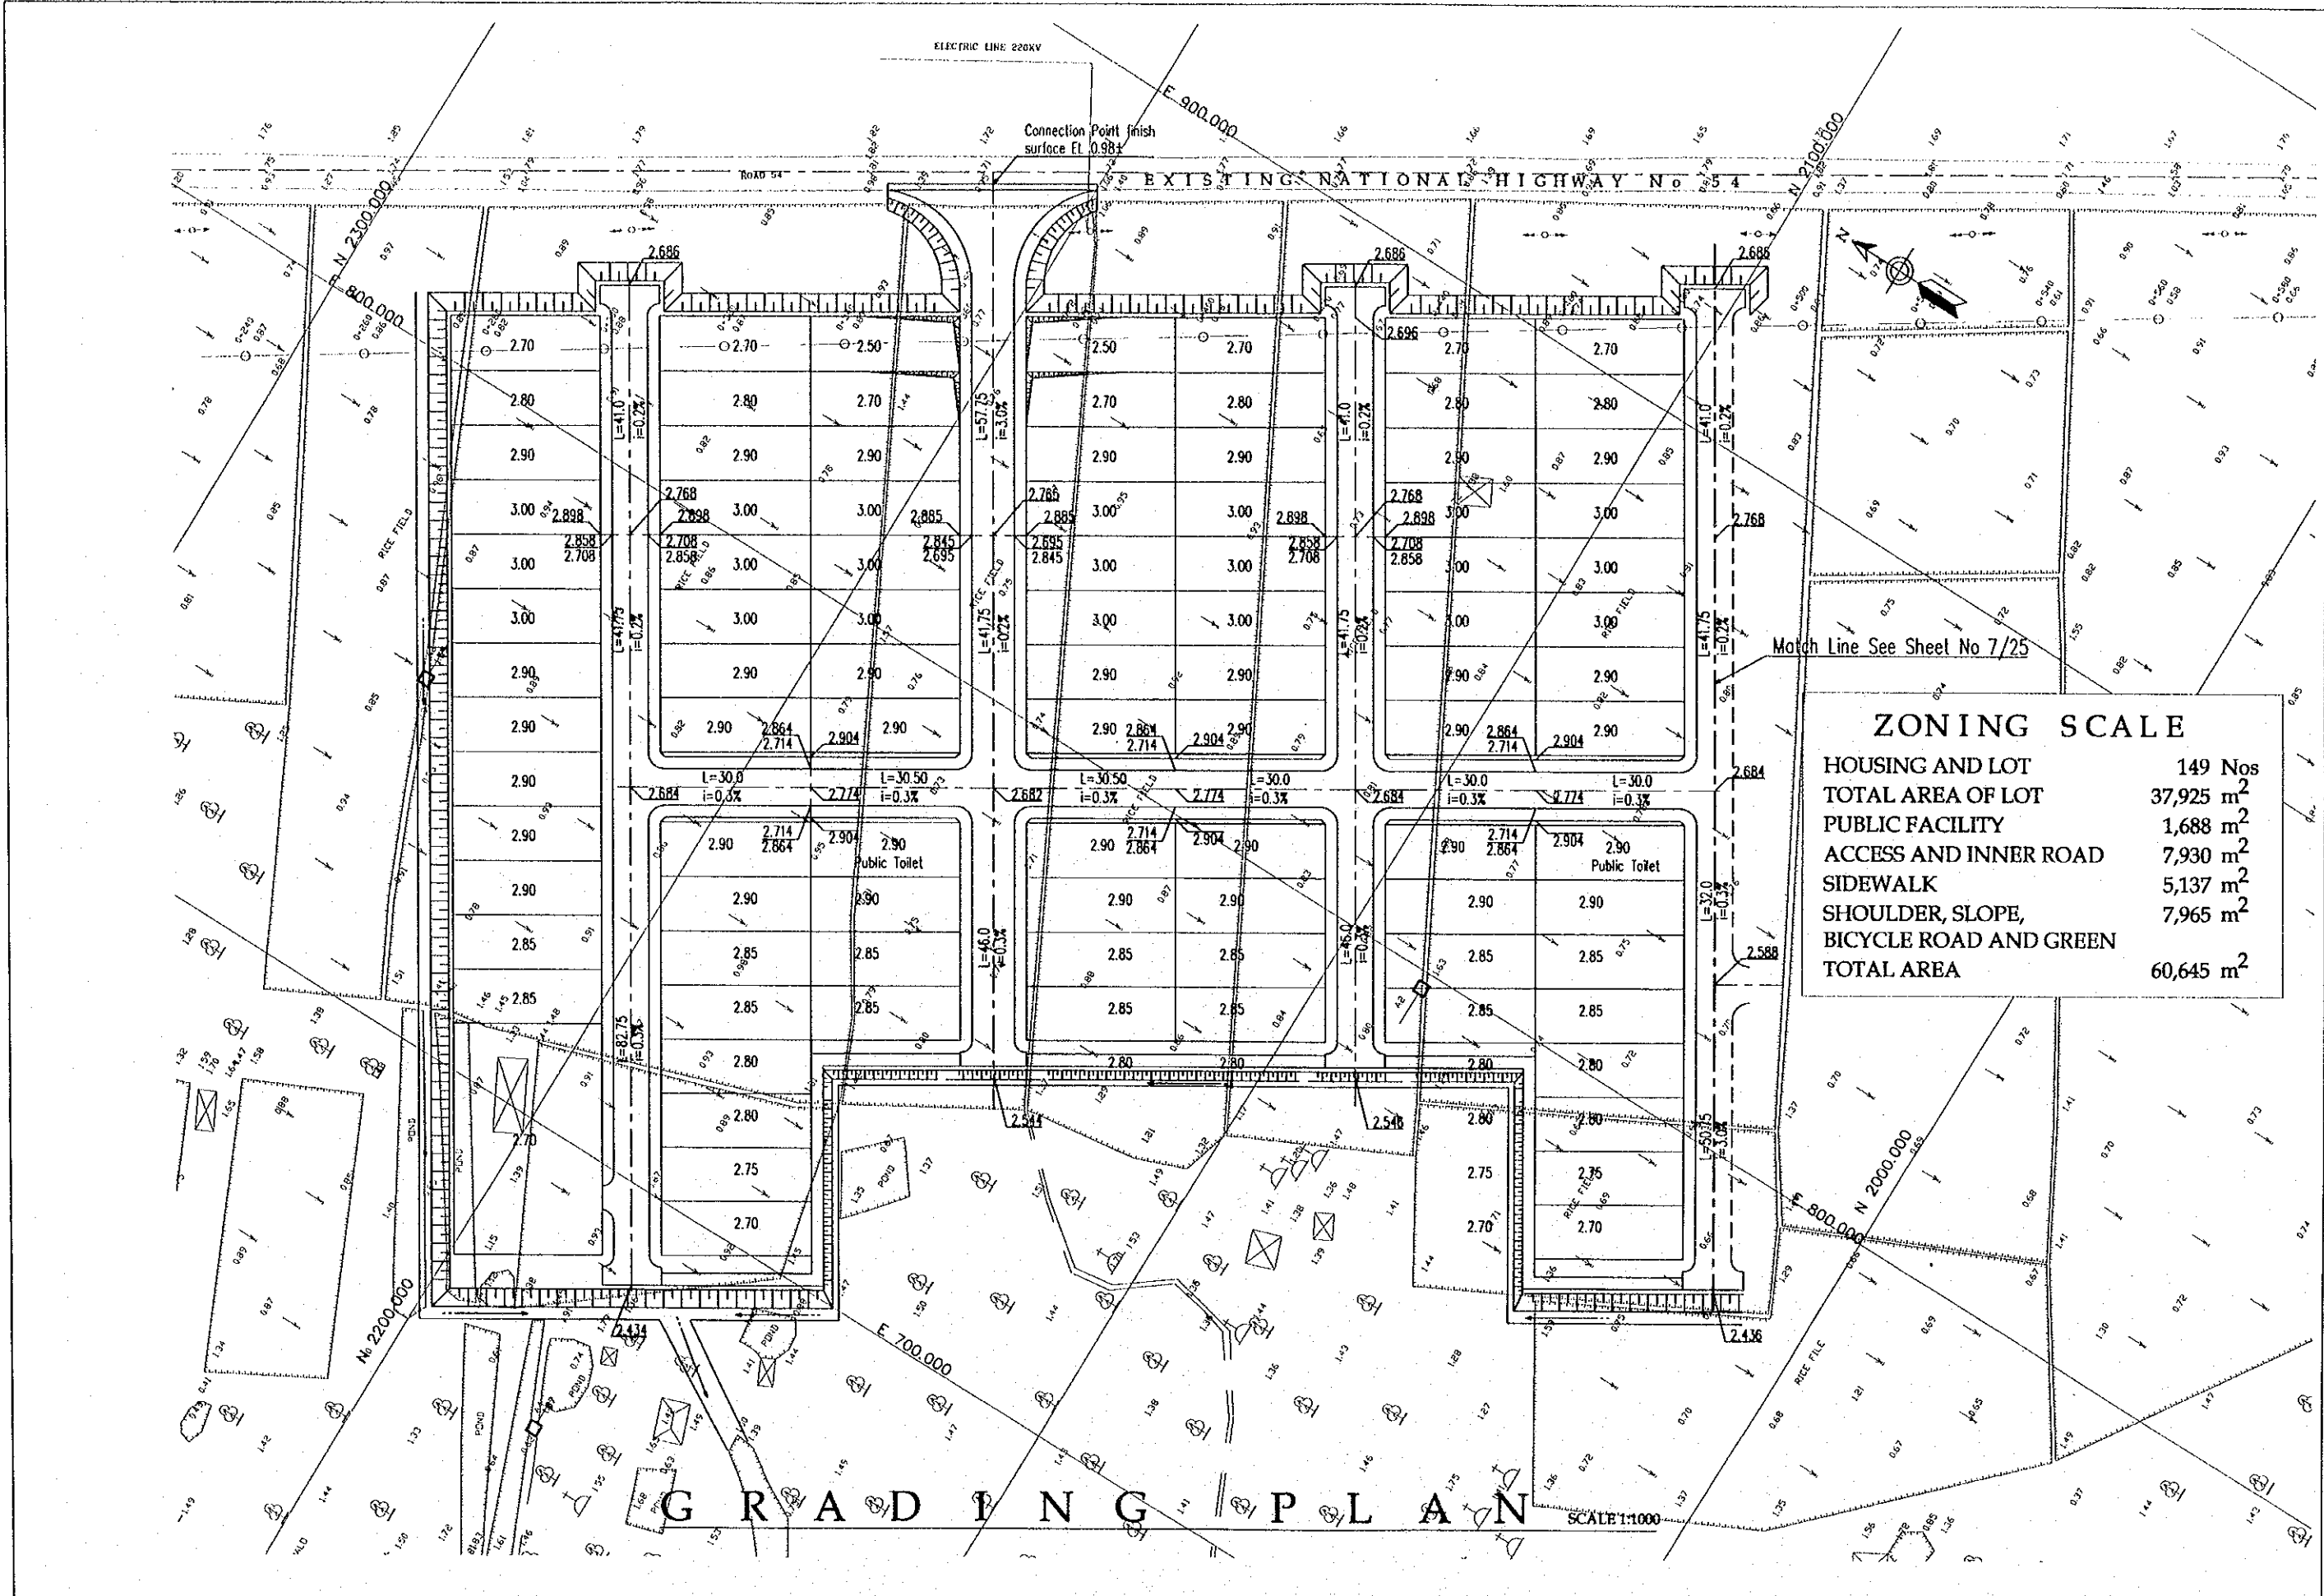


ZONING SCALE	
HOUSING AND LOT	149 Nos
TOTAL AREA OF LOT	37,925 m ²
PUBLIC FACILITY	1,688 m ²
ACCESS AND INNER ROAD	7,930 m ²
SIDEWALK	5,137 m ²
SHOULDER, SLOPE, BICYCLE ROAD AND GREEN	7,965 m ²
TOTAL AREA	60,645 m²

PROJECT NAME DETAILED DESIGN OF THE CAN THO BRIDGE CONSTRUCTION PROJECT	IMPLEMENTATION AGENCY JAPAN INTERNATIONAL COOPERATION AGENCY (JICA)	EXECUTING AGENCY SOCIALIST REPUBLIC OF VIET NAM MINISTRY OF TRANSPORT (MOT) MY THUAN PROJECT MANAGEMENT UNIT	JICA STUDY TEAM NIPPON KOEI CO.,LTD.	PREPARED BY	CHECKED BY	APPROVED BY	DRAWING TITLE GRADING PLAN	DWG NO. 6/25	
				NAME	VOHY HAI	M.FUJIKAWA			M.FUJIKAWA
				SIGNATURE	<i>[Signature]</i>	<i>[Signature]</i>			<i>[Signature]</i>
				DATE	4.4.2000	05/04/2000			05/04/2000

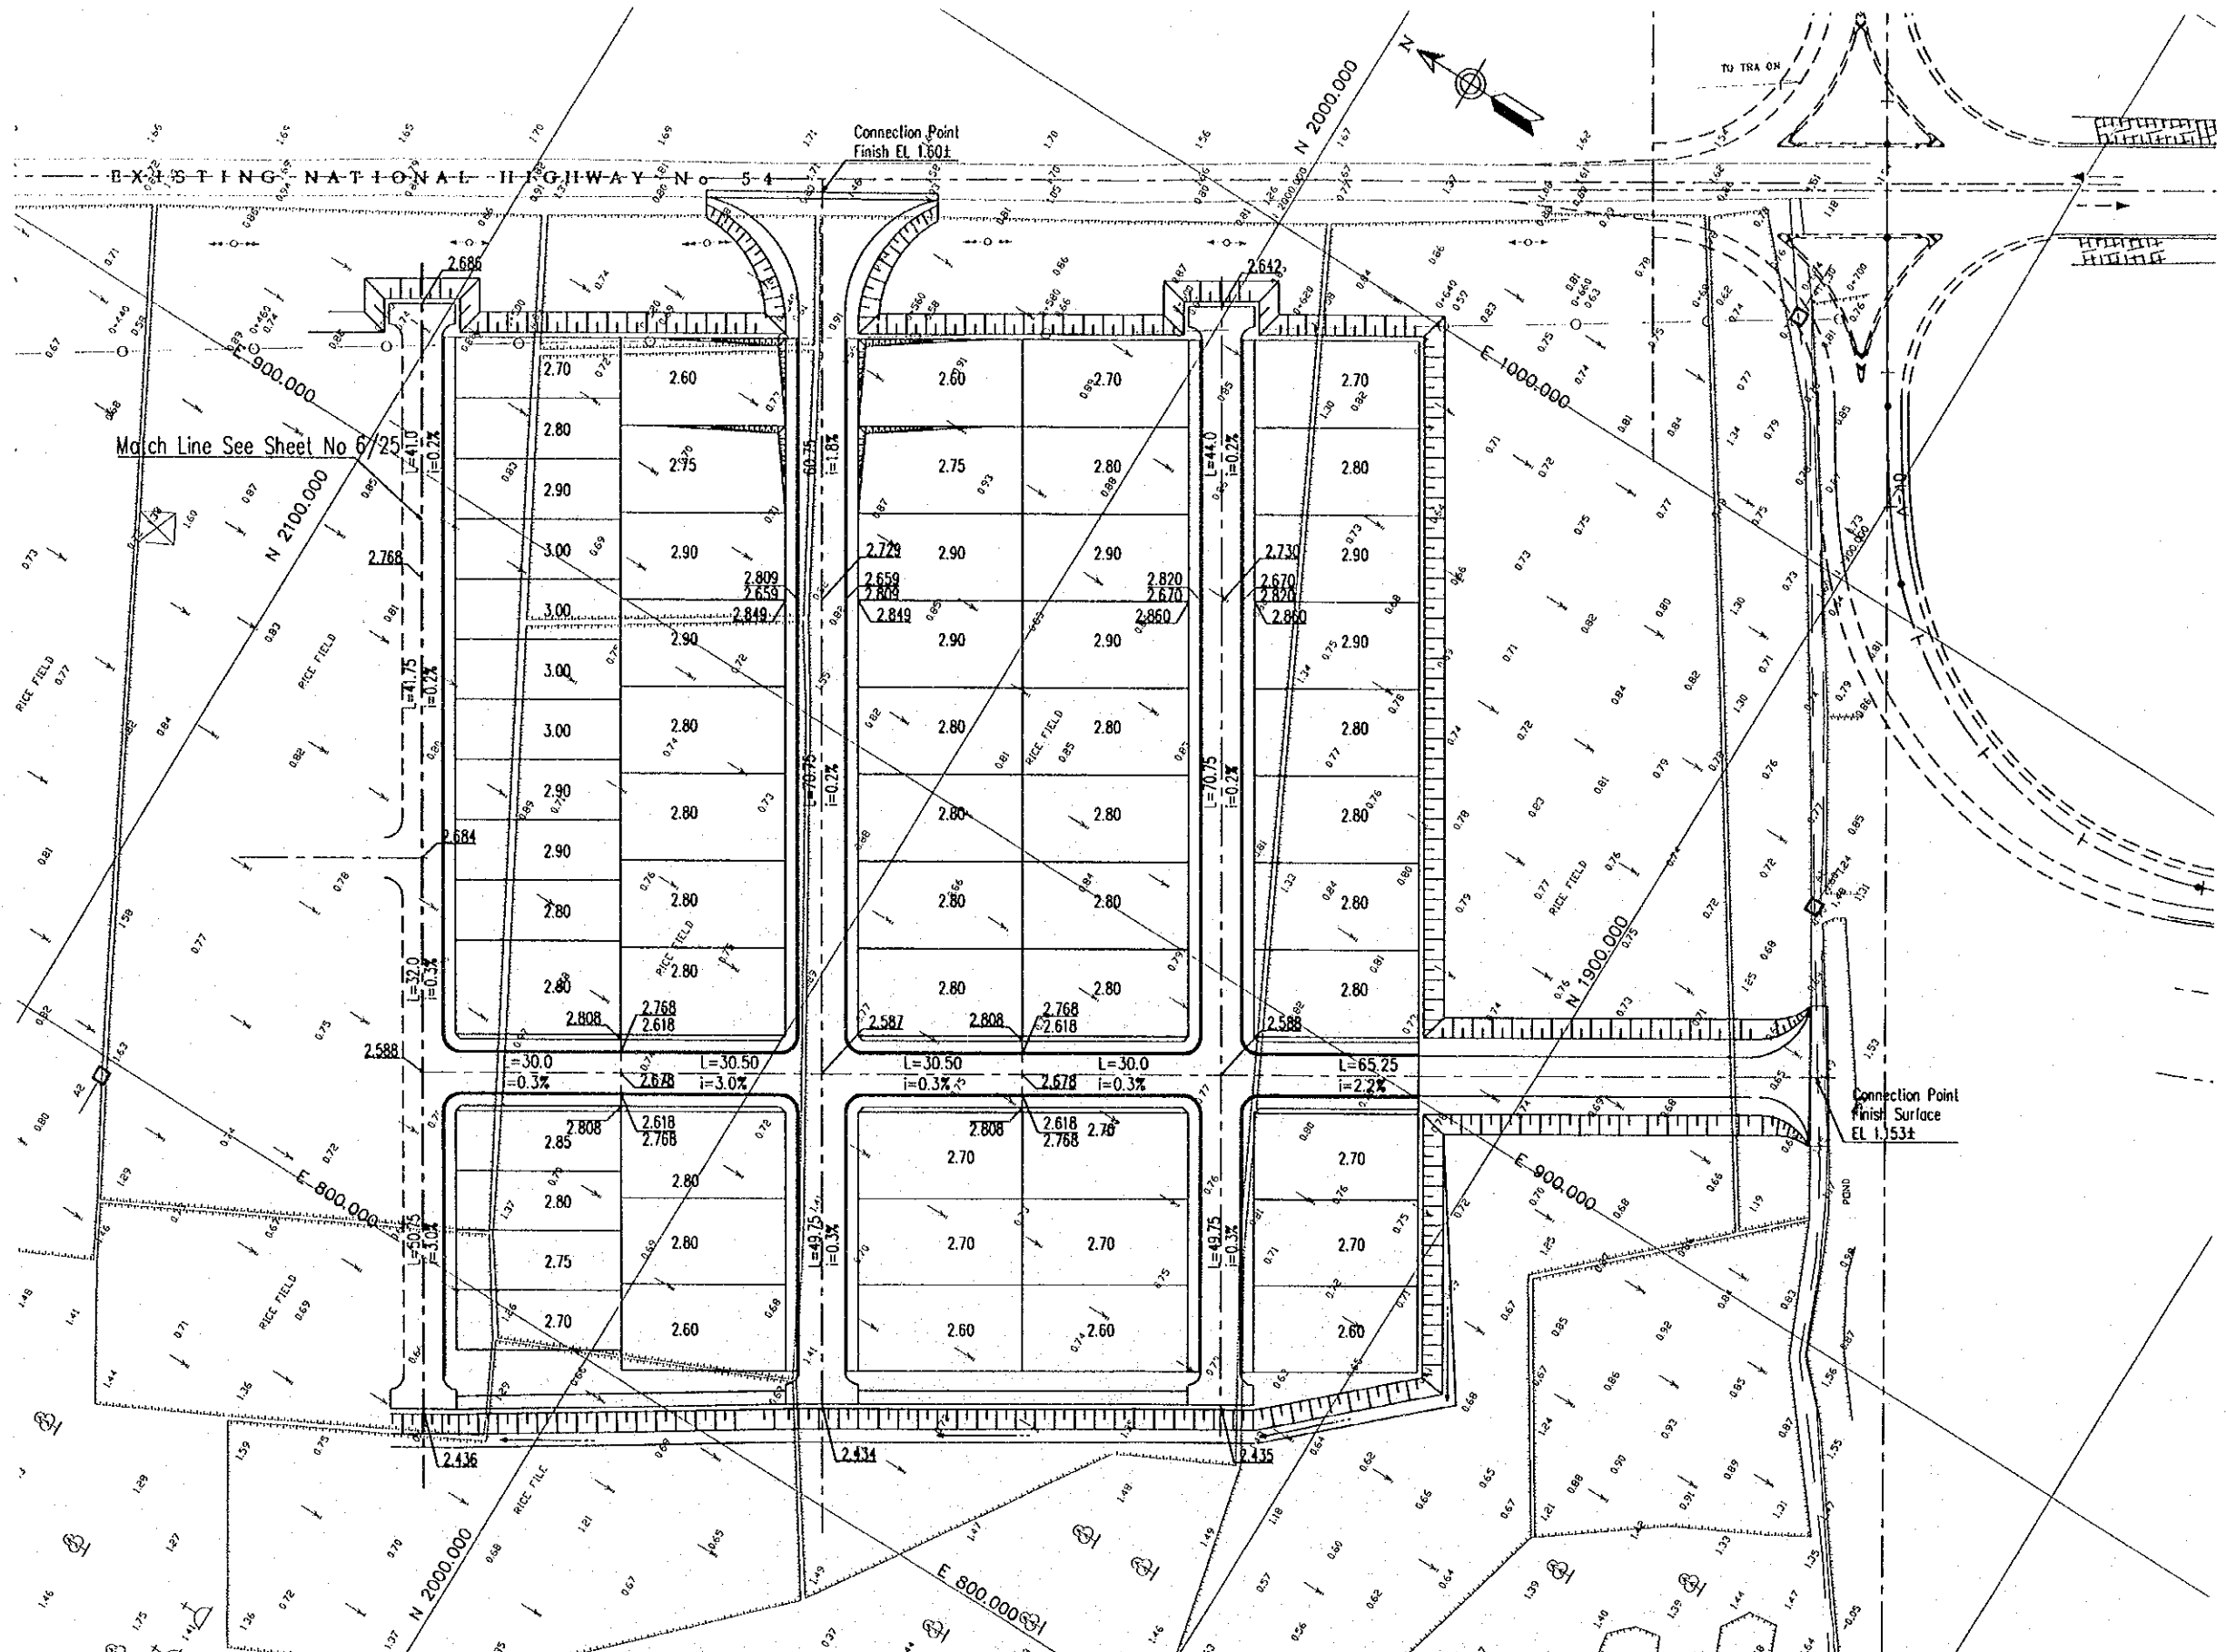

GRADING PLAN SCALE 1:1000


PROJECT NAME	IMPLEMENTATION AGENCY	EXECUTING AGENCY	JICA STUDY TEAM	PREPARED BY	CHECKED BY	APPROVED BY	DRAWING TITLE	DWG NO.
DETAILED DESIGN OF THE CAN THO BRIDGE CONSTRUCTION PROJECT	JAPAN INTERNATIONAL COOPERATION AGENCY (JICA)	SOCIALIST REPUBLIC OF VIET NAM MINISTRY OF TRANSPORT (MOT) MY THUAN PROJECT MANAGEMENT UNIT	NIPPON KOEI CO., LTD.	NAME: VOHYHAI SIGNATURE: <i>[Signature]</i> DATE: 4.4.2000	M. FUJIKAWA <i>[Signature]</i> 05/04/2000	M. FUJIKAWA <i>[Signature]</i> 23/04/2000	GRADING PLAN	7/25

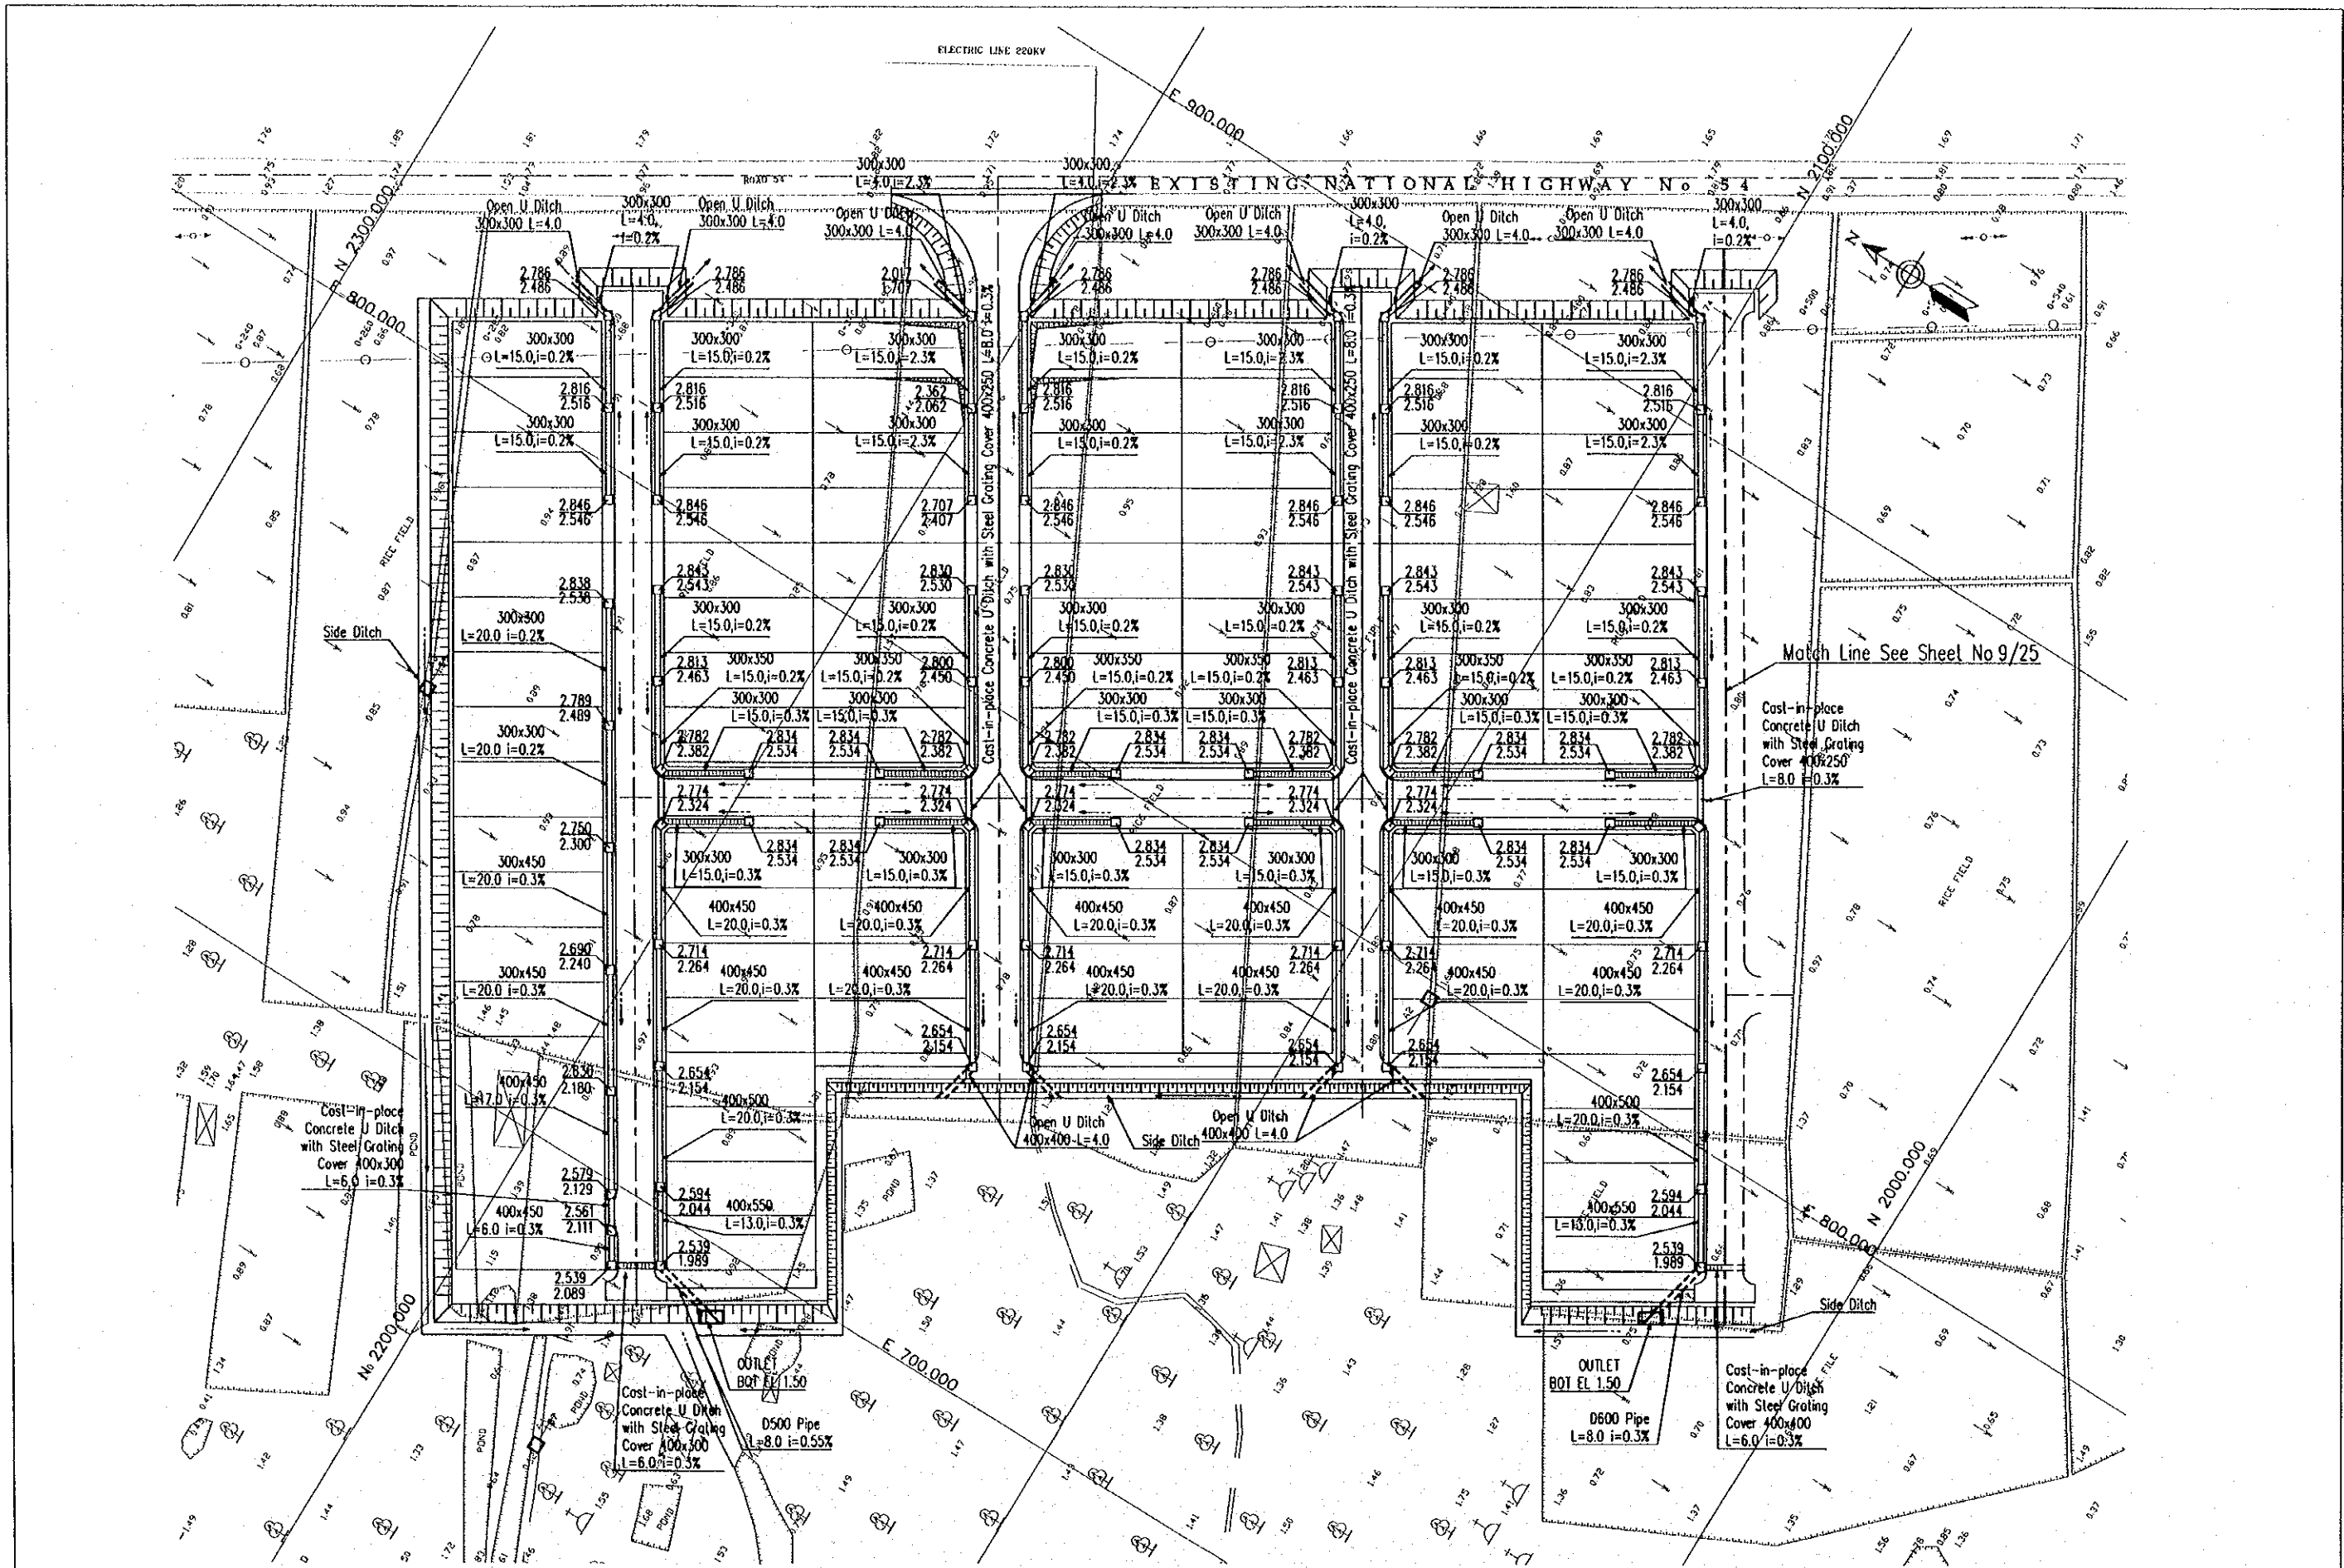

DRAINAGE SYSTEMS PLAN

SCALE 1:1000


PROJECT NAME	IMPLEMENTATION AGENCY	EXECUTING AGENCY	JICA STUDY TEAM	PREPARED BY	CHECKED BY	APPROVED BY	DRAWING TITLE	DWG NO.
DETAILED DESIGN OF THE CAN THO BRIDGE CONSTRUCTION PROJECT	JAPAN INTERNATIONAL COOPERATION AGENCY (JICA)	SOCIALIST REPUBLIC OF VIET NAM MINISTRY OF TRANSPORT (MOT) MY THUAN PROJECT MANAGEMENT UNIT	NIPPON KOBI CO., LTD.	NAME: VOHY HAI SIGNATURE: <i>Hai</i> DATE: 4.4.2000	NAME: NG. VAN THUAN SIGNATURE: <i>Van</i> DATE: 04/04/2000	NAME: H. FUJIKAWA SIGNATURE: <i>Fujikawa</i> DATE: 05/04/2000	DRAINAGE SYSTEMS PLAN	8/25

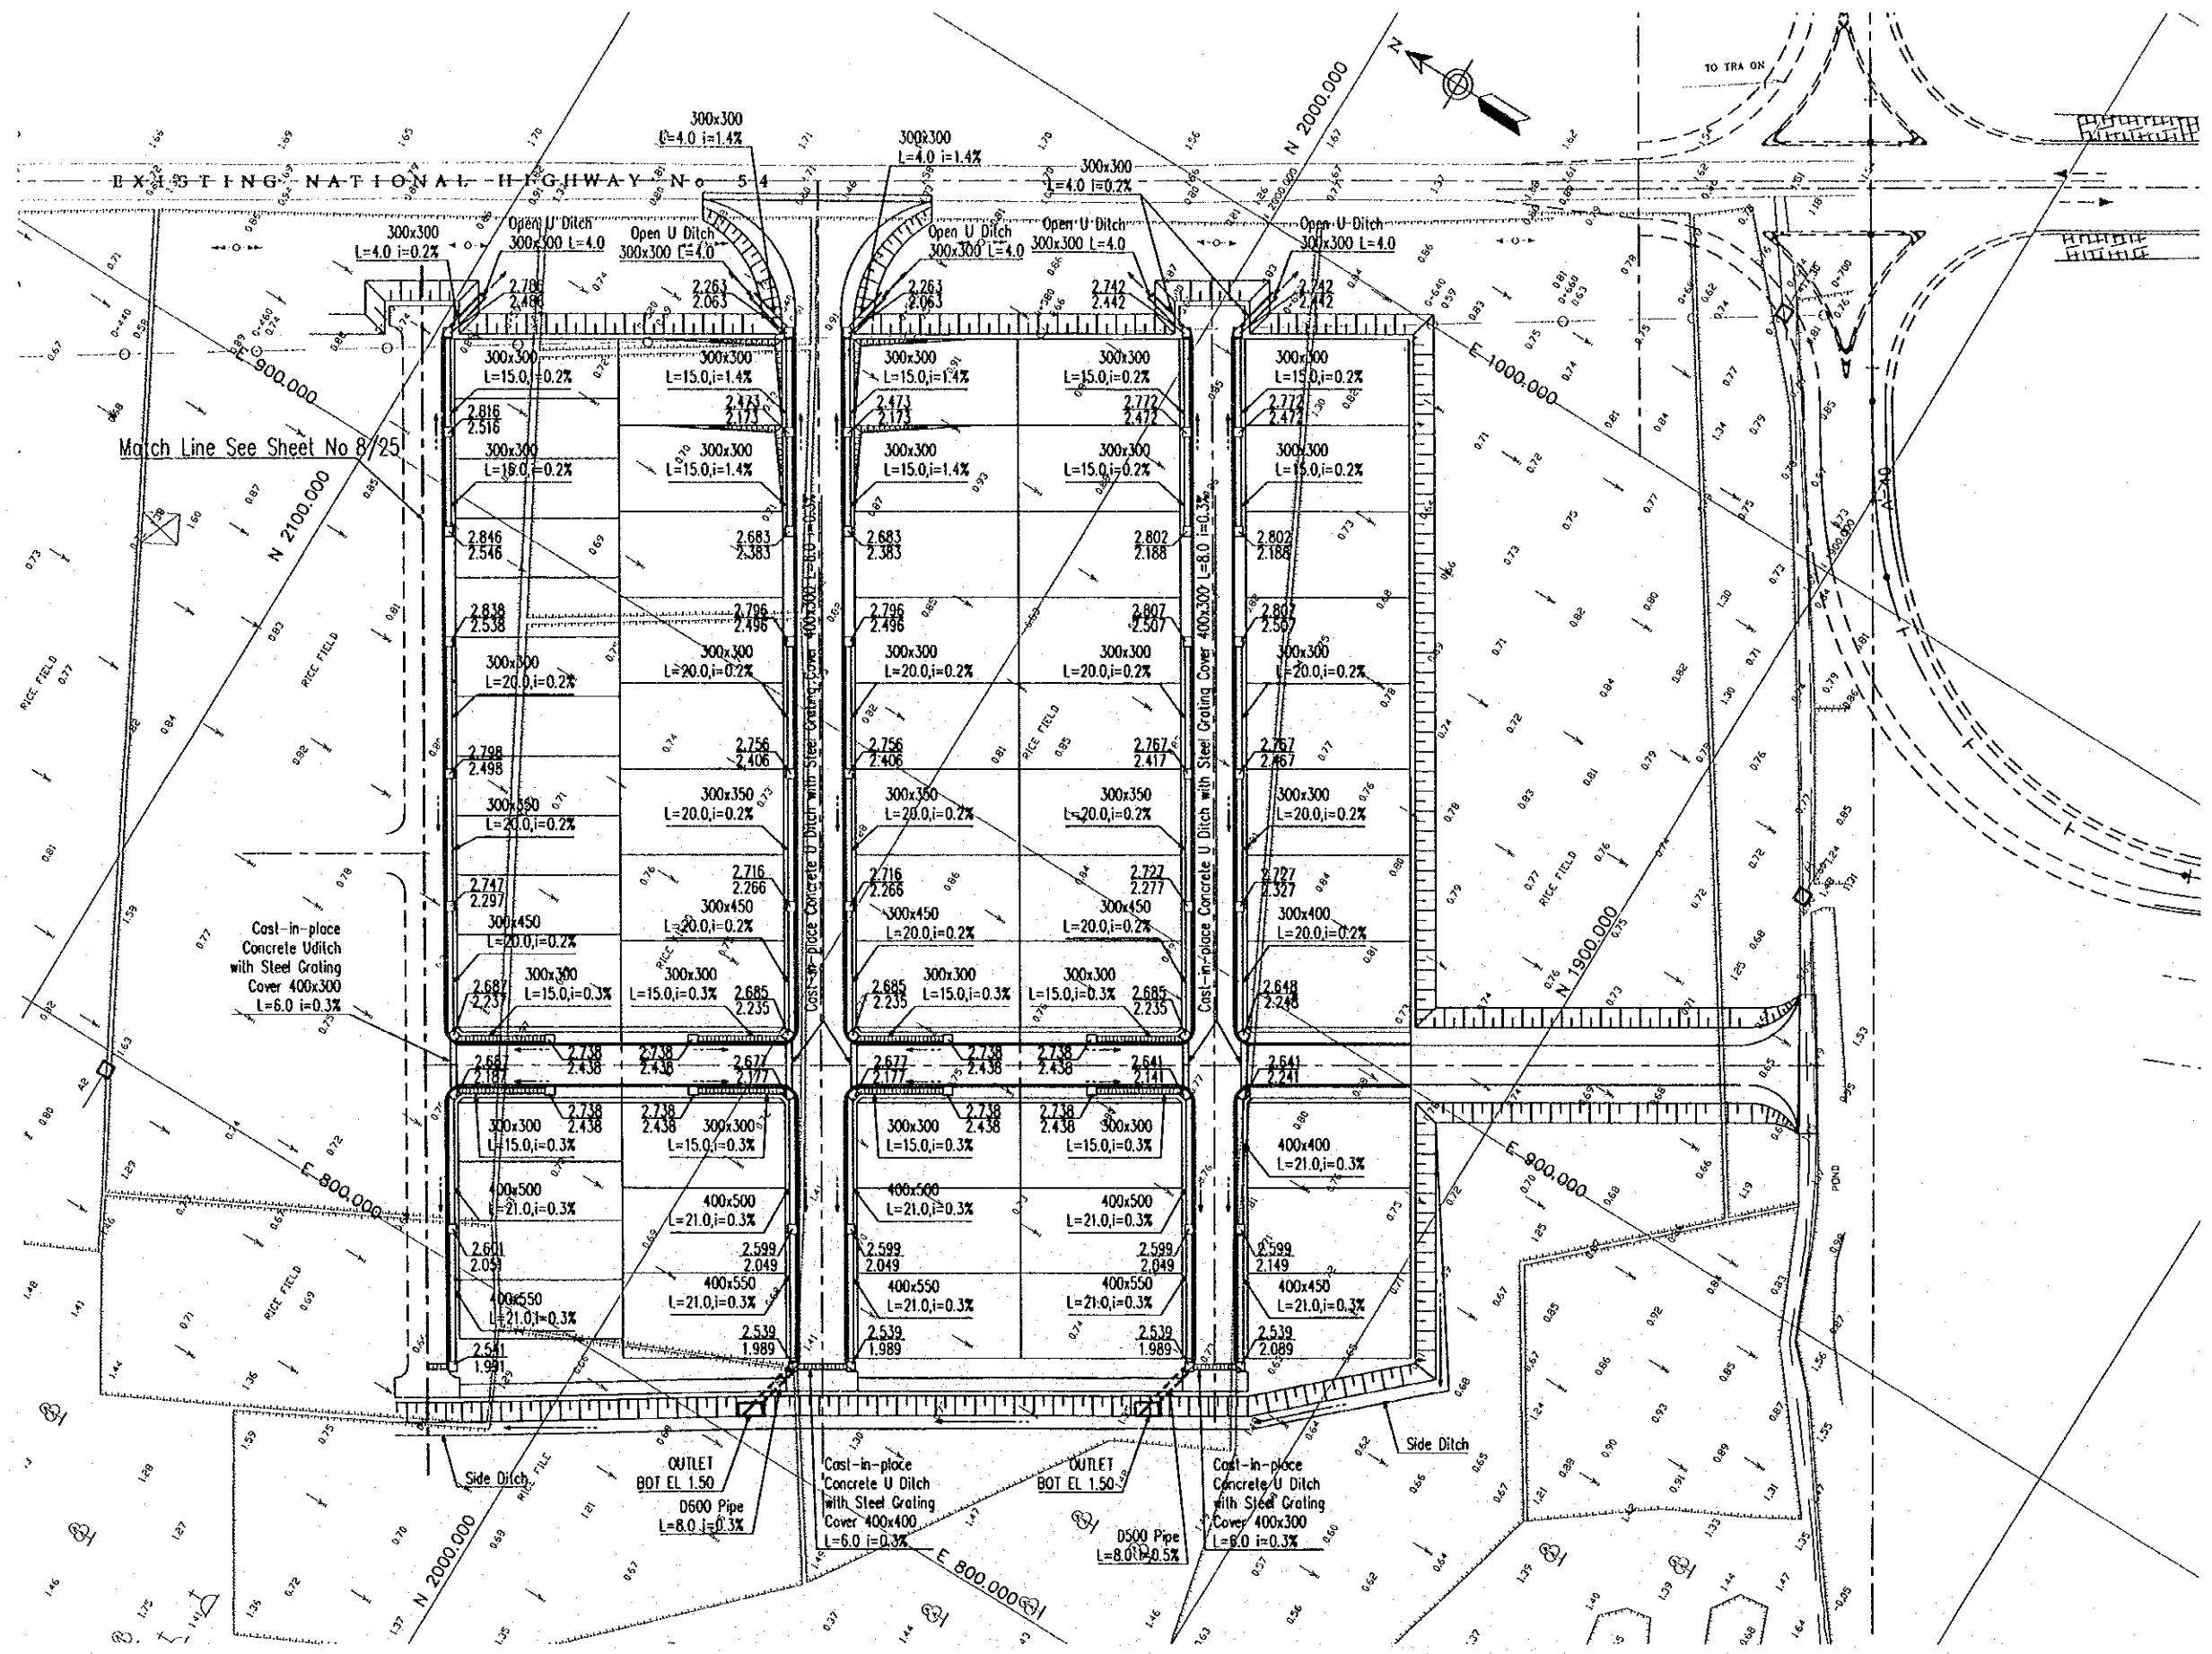

DRAINAGE SYSTEMS PLAN

SCALE 1:1000

PROJECT NAME	IMPLEMENTATION AGENCY	EXECUTING AGENCY	JICA STUDY TEAM	PREPARED BY	CHECKED BY	APPROVED BY	DRAWING TITLE	DWG. NO.
DETAILED DESIGN OF THE CAN THO BRIDGE CONSTRUCTION PROJECT	JAPAN INTERNATIONAL COOPERATION AGENCY (JICA)	SOCIALIST REPUBLIC OF VIET NAM MINISTRY OF TRANSPORT (MOT) MY THUAN PROJECT MANAGEMENT UNIT	NIPPON KOBI CO., LTD.	NAME: VOI HAI SIGNATURE: <i>[Signature]</i> DATE: 4.4.2000	NAME: NG VAN TRUNG SIGNATURE: <i>[Signature]</i> DATE: 4.4.2000	NAME: M. FUJIKAWA SIGNATURE: <i>[Signature]</i> DATE: 4/14/2000	DRAINAGE SYSTEMS PLAN	9/25

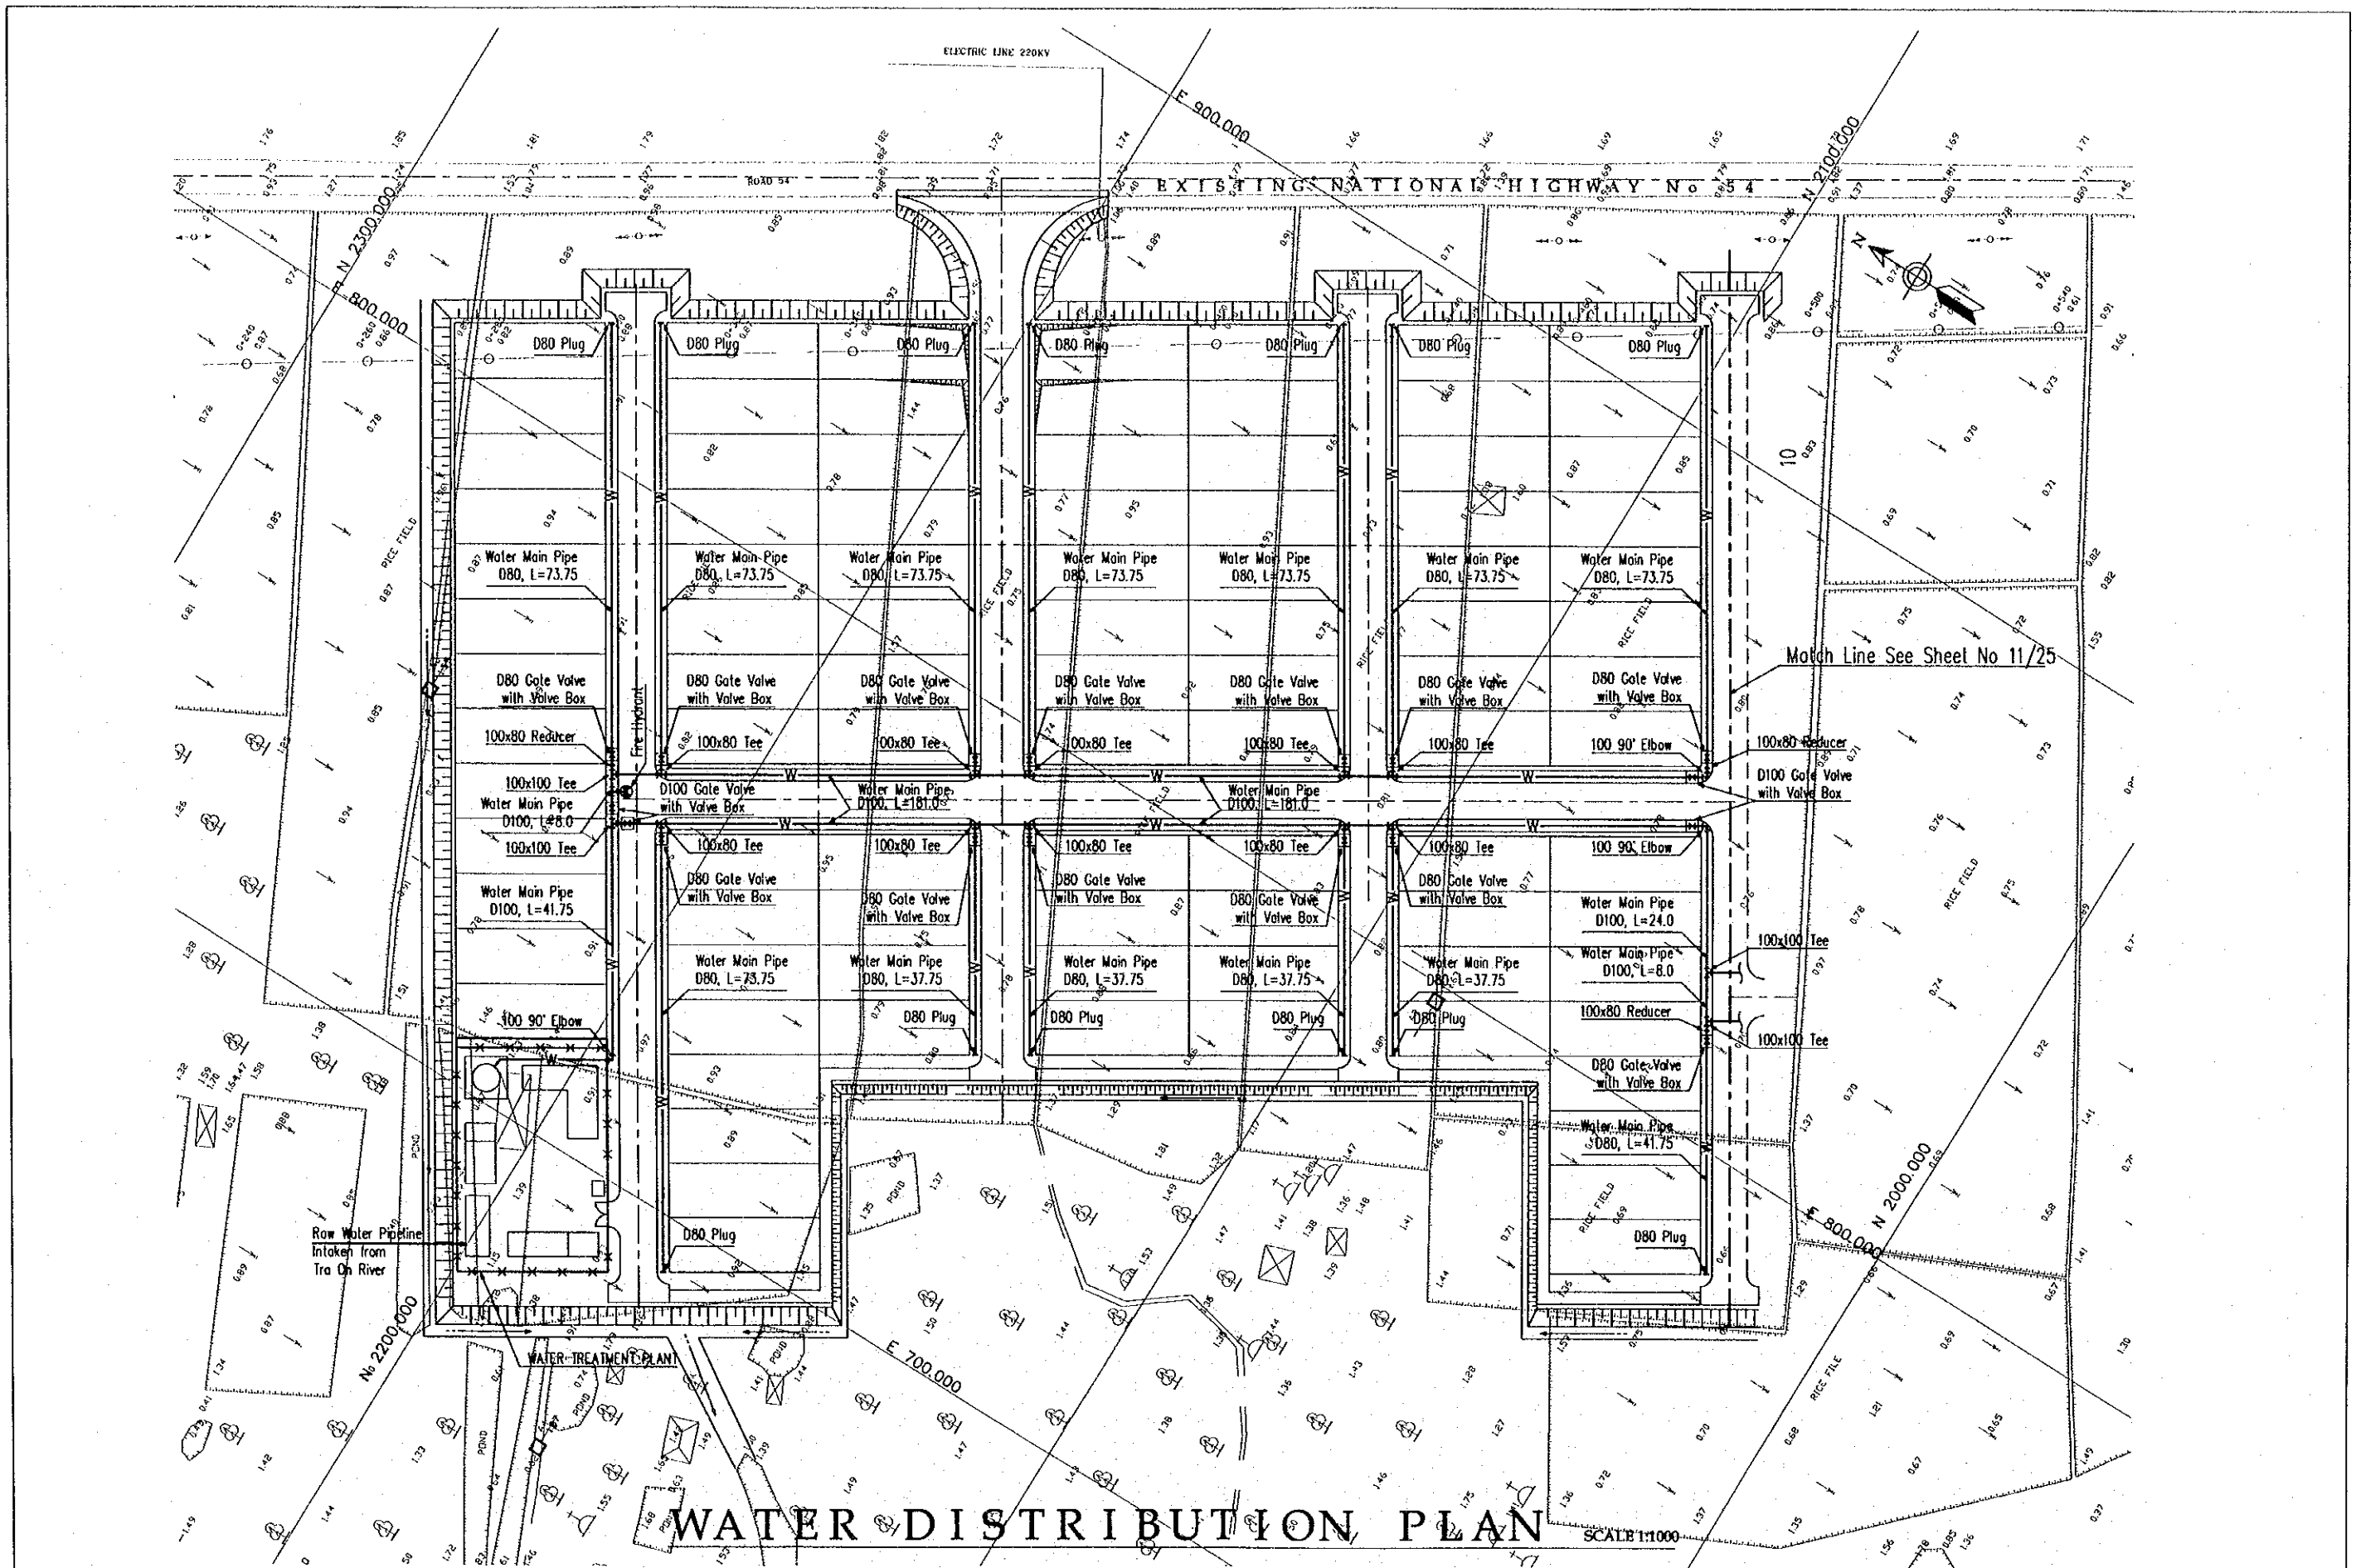

PROJECT NAME	IMPLEMENTATION AGENCY	EXECUTING AGENCY	JICA STUDY TEAM	PREPARED BY	CHECKED BY	APPROVED BY	DRAWING TITLE	DWG NO.
DETAILED DESIGN OF THE CAN THO BRIDGE CONSTRUCTION PROJECT	JICA JAPAN INTERNATIONAL COOPERATION AGENCY (JICA)	SOCIALIST REPUBLIC OF VIET NAM MINISTRY OF TRANSPORT (MOT) MY THUAN PROJECT MANAGEMENT UNIT	(NK) NIPPON KOBI CO., LTD.	NAME: VO HY HAI SIGNATURE: <i>VO HY HAI</i> DATE: 4.4.2000	NAME: TRAN O-CU SIGNATURE: <i>TRAN O-CU</i> DATE: 4.4.2000	NAME: M. FUJIKAWA SIGNATURE: <i>M. FUJIKAWA</i> DATE: 05/04/2000	WATER DISTRIBUTION PLAN	10/25