
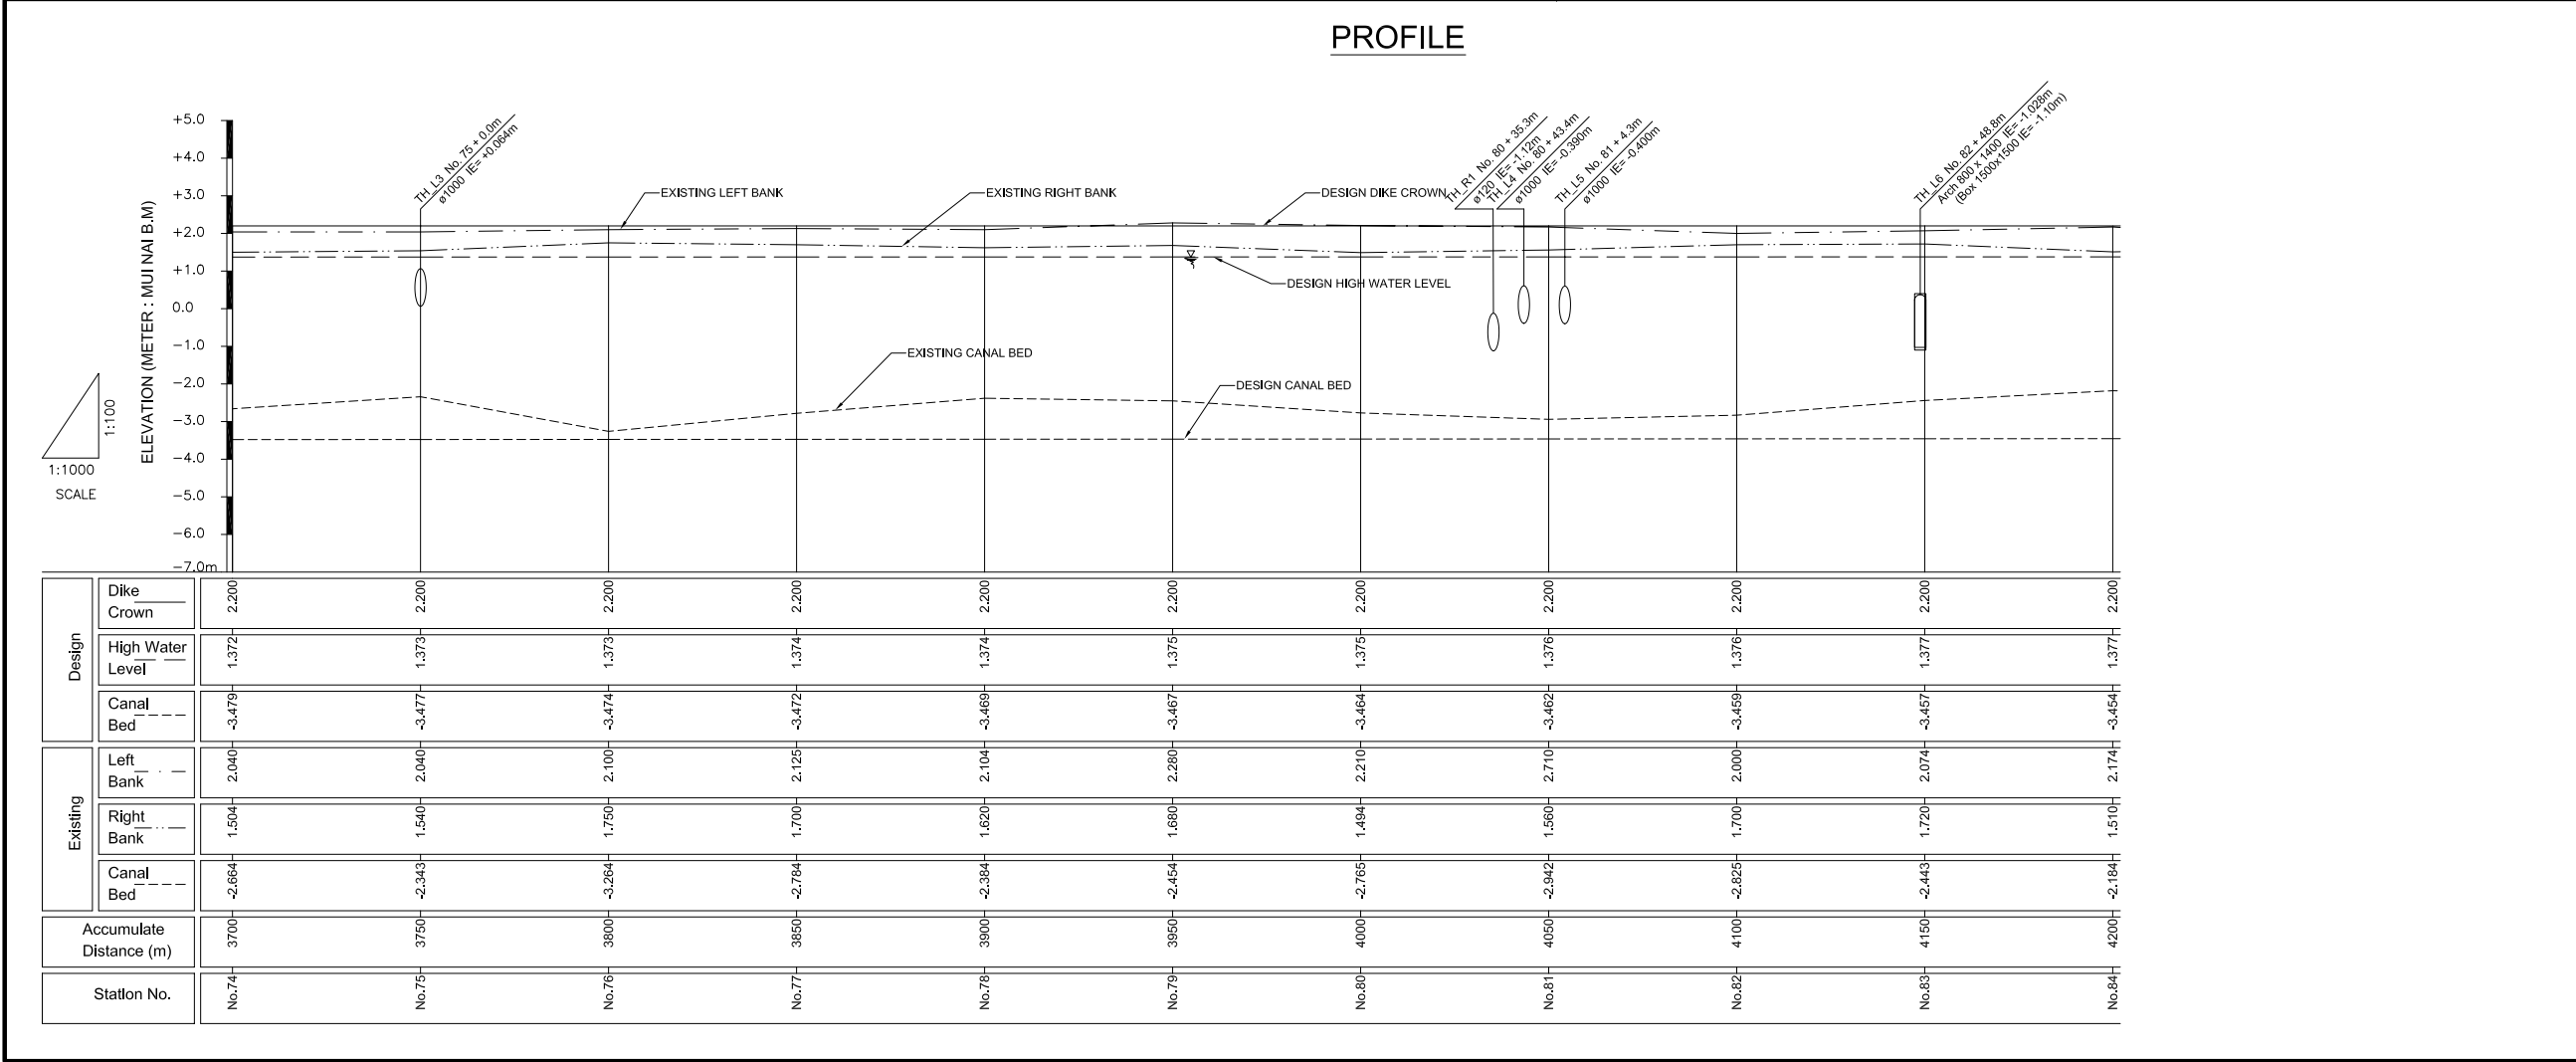
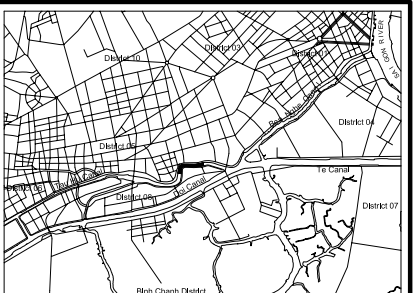




NO.	DATE	DESCRIPTIONS	BY	APPRO.
REVISIONS				
PROJECT MANAGEMENT UNIT FOR HO CHI MINH CITY WATER ENVIRONMENT IMPROVEMENT				
THE DETAILED DESIGN STUDY ON HO CHI MINH CITY WATER ENVIRONMENT IMPROVEMENT PROJECT IN THE SOCIALIST REPUBLIC OF VIET NAM				
PACKAGE A TAU HU - BEN NGHE CANAL IMPROVEMENT				
PLAN AND PROFILE (No. 62 ~ No. 74)				
SCALE : AS SHOW				
JAPAN INTERNATIONAL COOPERATION AGENCY (JICA)				
PACIFIC CONSULTANTS INTERNATIONAL				
DESIGNED TOKUMASU TOSHIKI		CHECKED KONDO MASAMI		
DATE : JUNE 2001		DWG. No. PA - THBNCI - 207		

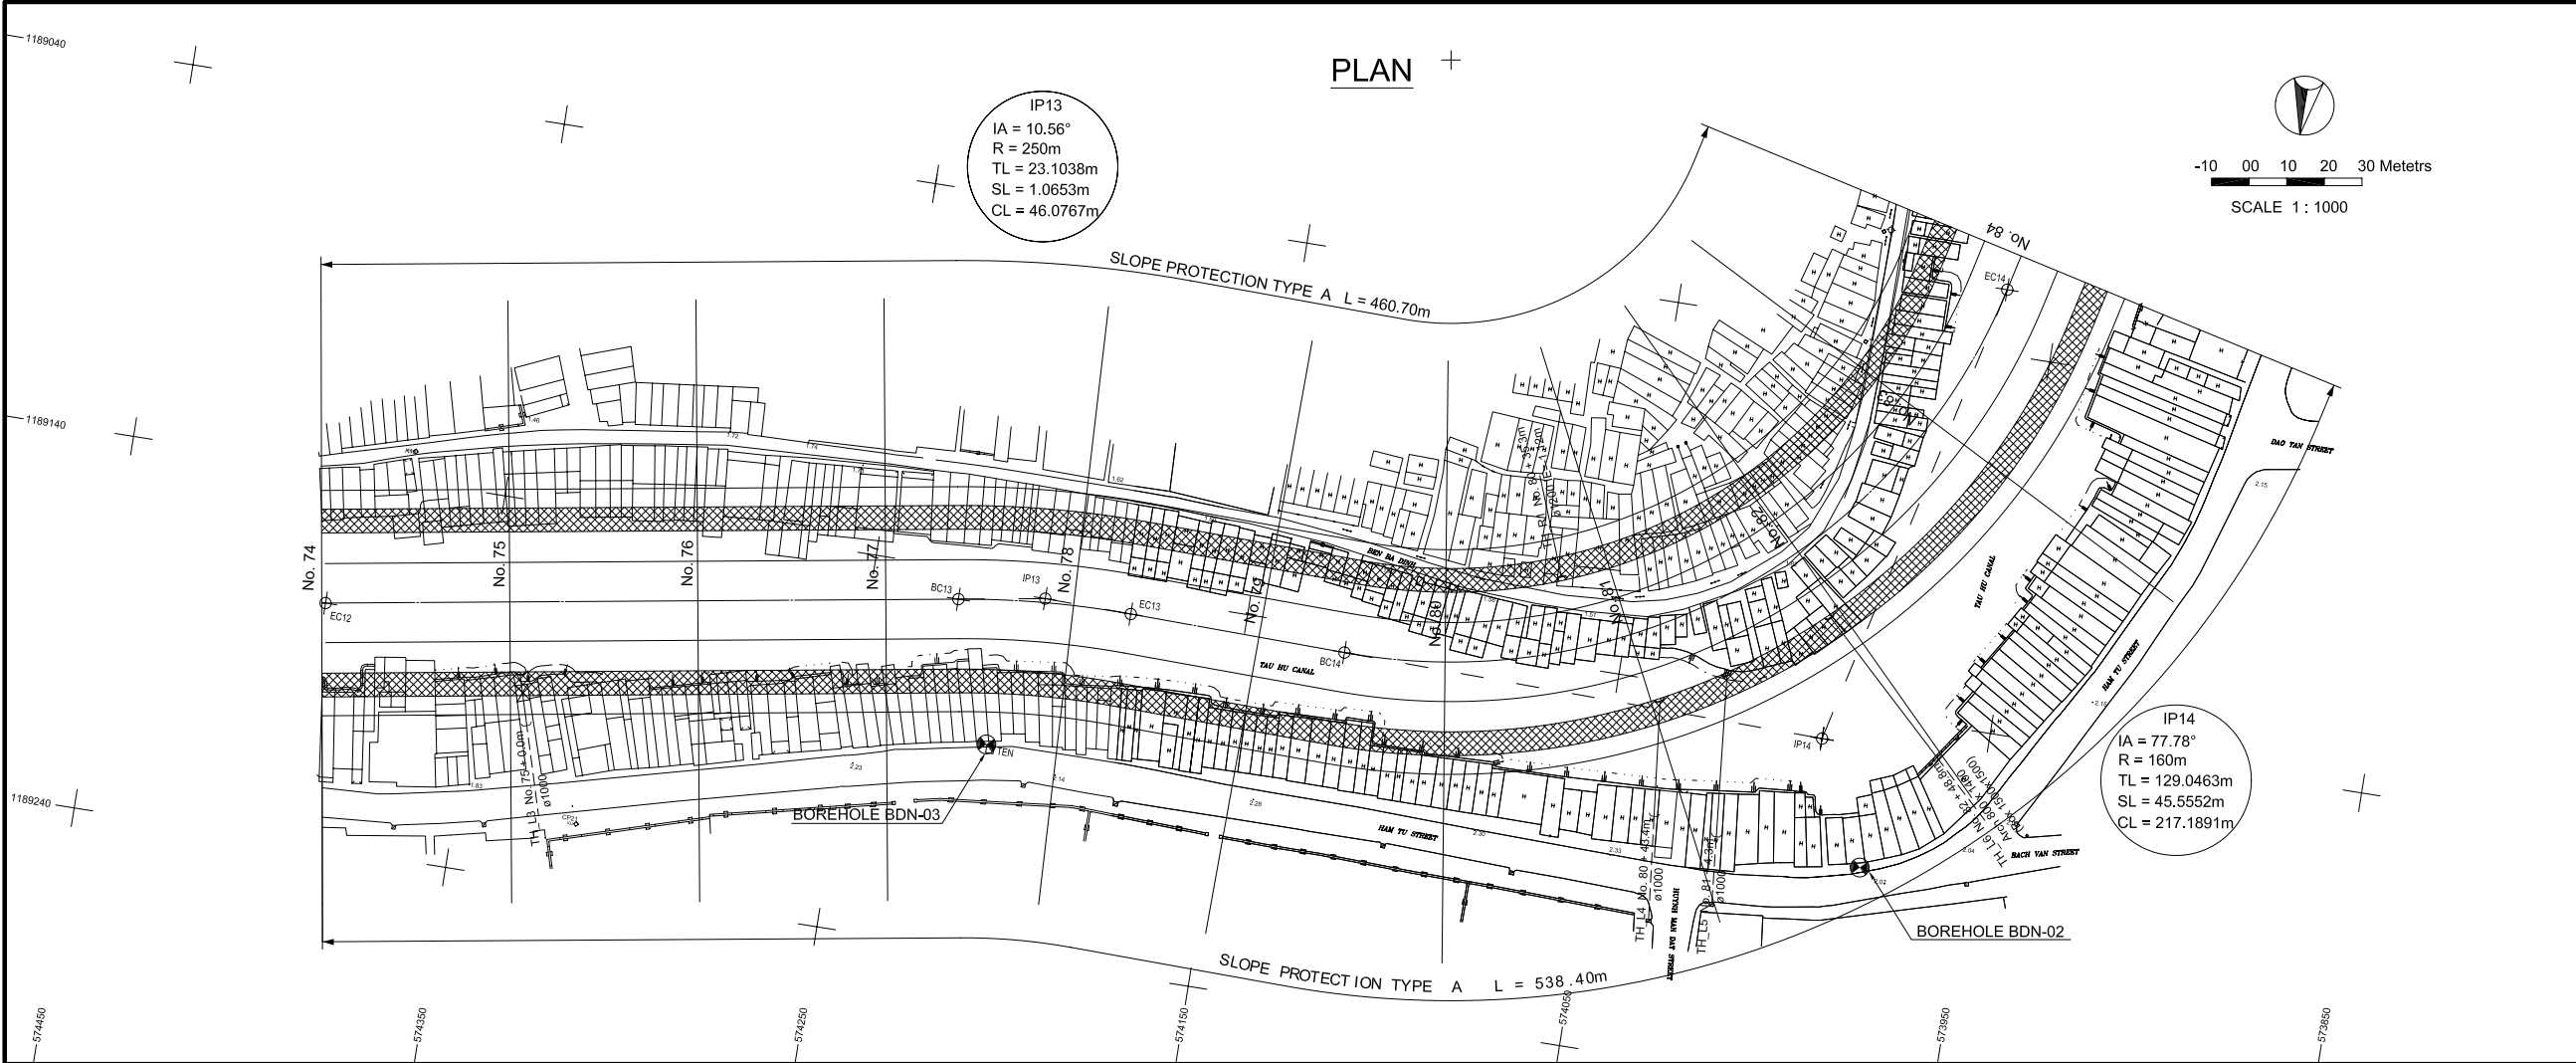


NO.	DATE	DESCRIPTIONS	BY	APRO.
REVISIONS				
PROJECT MANAGEMENT UNIT FOR HO CHI MINH CITY WATER ENVIRONMENT IMPROVEMENT				
THE DETAILED DESIGN STUDY ON HO CHI MINH CITY WATER ENVIRONMENT IMPROVEMENT PROJECT IN THE SOCIALIST REPUBLIC OF VIET NAM				
PACKAGE A TAU HU - BEN NGHE CANAL IMPROVEMENT				
PLAN AND PROFILE (No. 74 ~ No. 84)				
SCALE : AS SHOW				
JAPAN INTERNATIONAL COOPERATION AGENCY (JICA)				
PACIFIC CONSULTANTS INTERNATIONAL				
DESIGNED TOKUMASU TOSHIKI		CHECKED KONDO MASAMI		
DATE : JUNE 2001		DWG. No. PA - THBNCI - 208		

PLAN


IP15
 IA = 75.40°
 R = 250m
 TL = 193.2254m
 SL = 65.9685m
 CL = 328.9989m

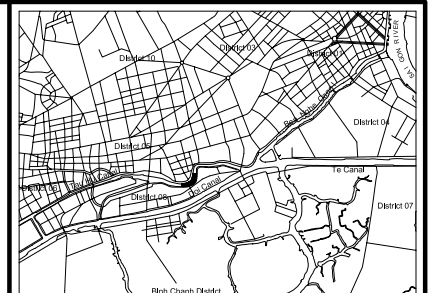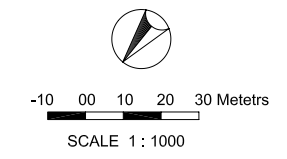

LOCATION MAP
 Scale 1:65,000

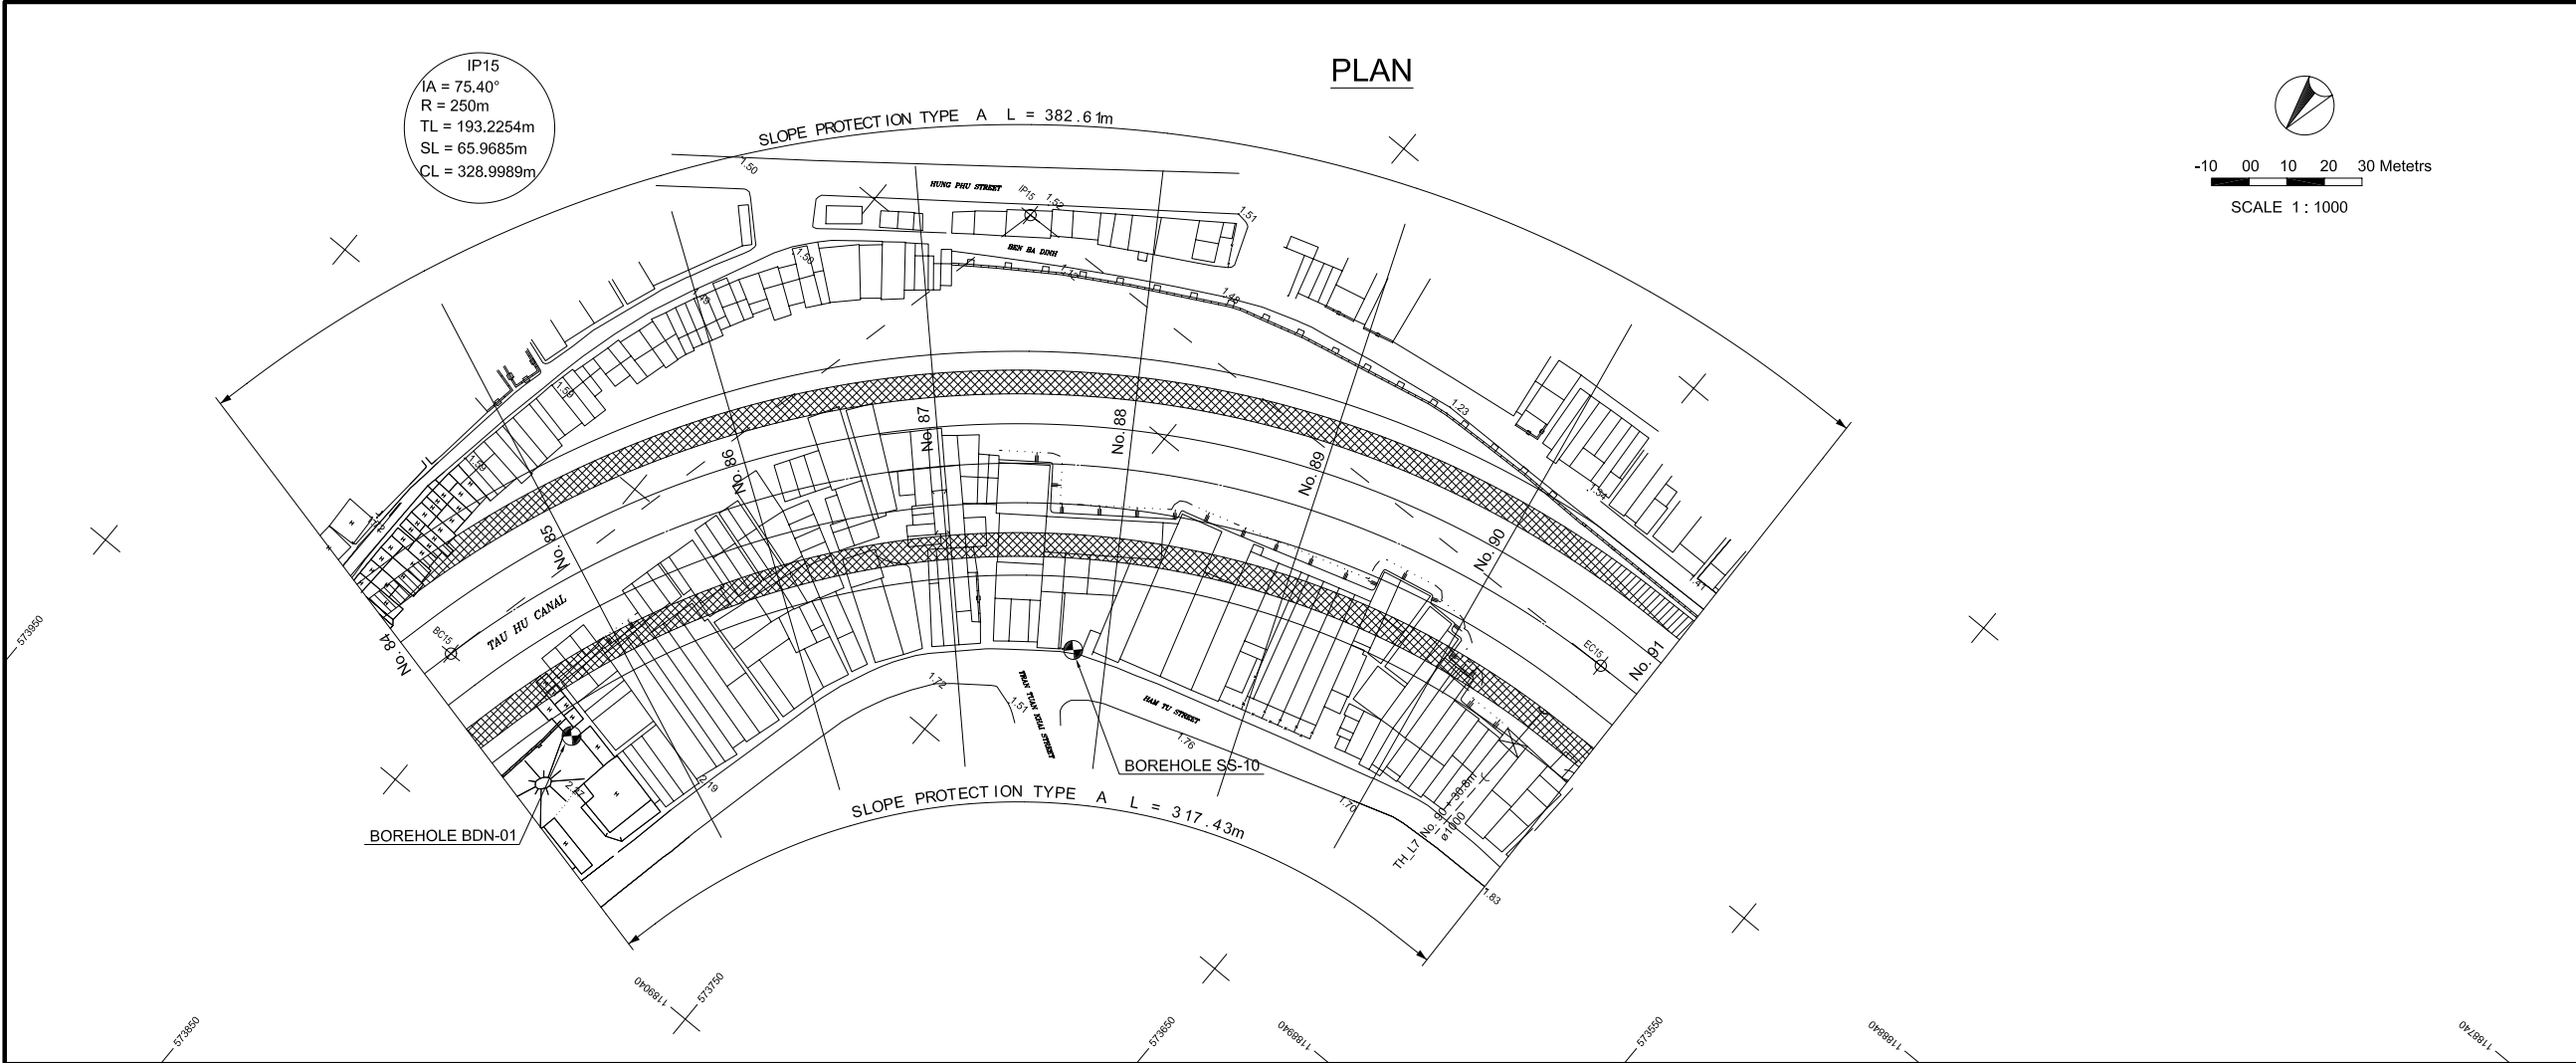

PROFILE

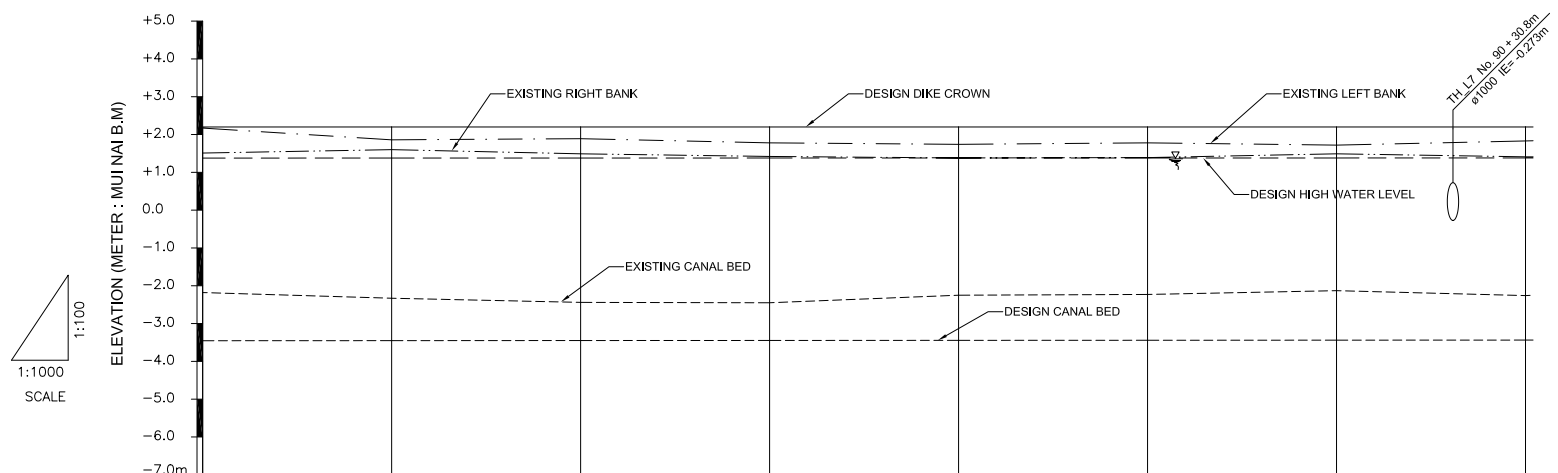

Station No.	Design		Existing		Accumulate Distance (m)
	Dike Crown	High Water Level	Left Bank	Right Bank	
No.84	2.200	1.377	2.174	1.510	4200
No.85	2.200	1.378	1.880	1.600	4250
No.86	2.200	1.378	1.880	1.490	4300
No.87	2.200	1.379	1.784	1.420	4350
No.88	2.200	1.379	1.742	1.384	4400
No.89	2.200	1.380	1.780	1.389	4450
No.90	2.200	1.380	1.720	1.490	4500
No.91	2.200	1.381	1.830	1.410	4550

NO.	DATE	DESCRIPTIONS	BY	APPRO.

REVISIONS

PROJECT MANAGEMENT UNIT FOR
 HO CHI MINH CITY
 WATER ENVIRONMENT IMPROVEMENT

THE DETAILED DESIGN STUDY ON HO CHI MINH CITY
 WATER ENVIRONMENT IMPROVEMENT PROJECT
 IN THE SOCIALIST REPUBLIC OF VIET NAM

PACKAGE A
 TAU HU - BEN NGHE CANAL IMPROVEMENT
PLAN AND PROFILE
 (No. 84 ~ No. 91)

SCALE : AS SHOW

JICA JAPAN INTERNATIONAL COOPERATION AGENCY (JICA)

PACIFIC CONSULTANTS INTERNATIONAL

DESIGNED: TOKUMASU TOSHIKI
 CHECKED: KONDO MASAMI

DATE: JUNE 2001 DWG. No. PA - THBNCI - 209