

 **ROOF PLAN**

NO.	DATE	DESCRIPTIONS	BY	APPRO.


REVISIONS

PROJECT MANAGEMENT UNIT FOR  
HO CHI MINH CITY  
WATER ENVIRONMENT IMPROVEMENT

THE DETAILED DESIGN STUDY ON HO CHI MINH CITY  
WATER ENVIRONMENT IMPROVEMENT PROJECT  
IN THE SOCIALIST REPUBLIC OF VIET NAM

PACKAGE C  
INTERMEDIATE WASTEWATER PUMPING STATION  
PUMP HOUSE AND O/M OFFICE  
ROOF PLAN


SCALE : 1/100

 JAPAN INTERNATIONAL COOPERATION  
AGENCY ( JICA )


 PACIFIC CONSULTANTS INTERNATIONAL

DESIGNED KIMURA TORU	CHECKED KONDO MASAMI
-------------------------	-------------------------


DATE : JUNE 2001      DWG. No. PC - IWPS - 303

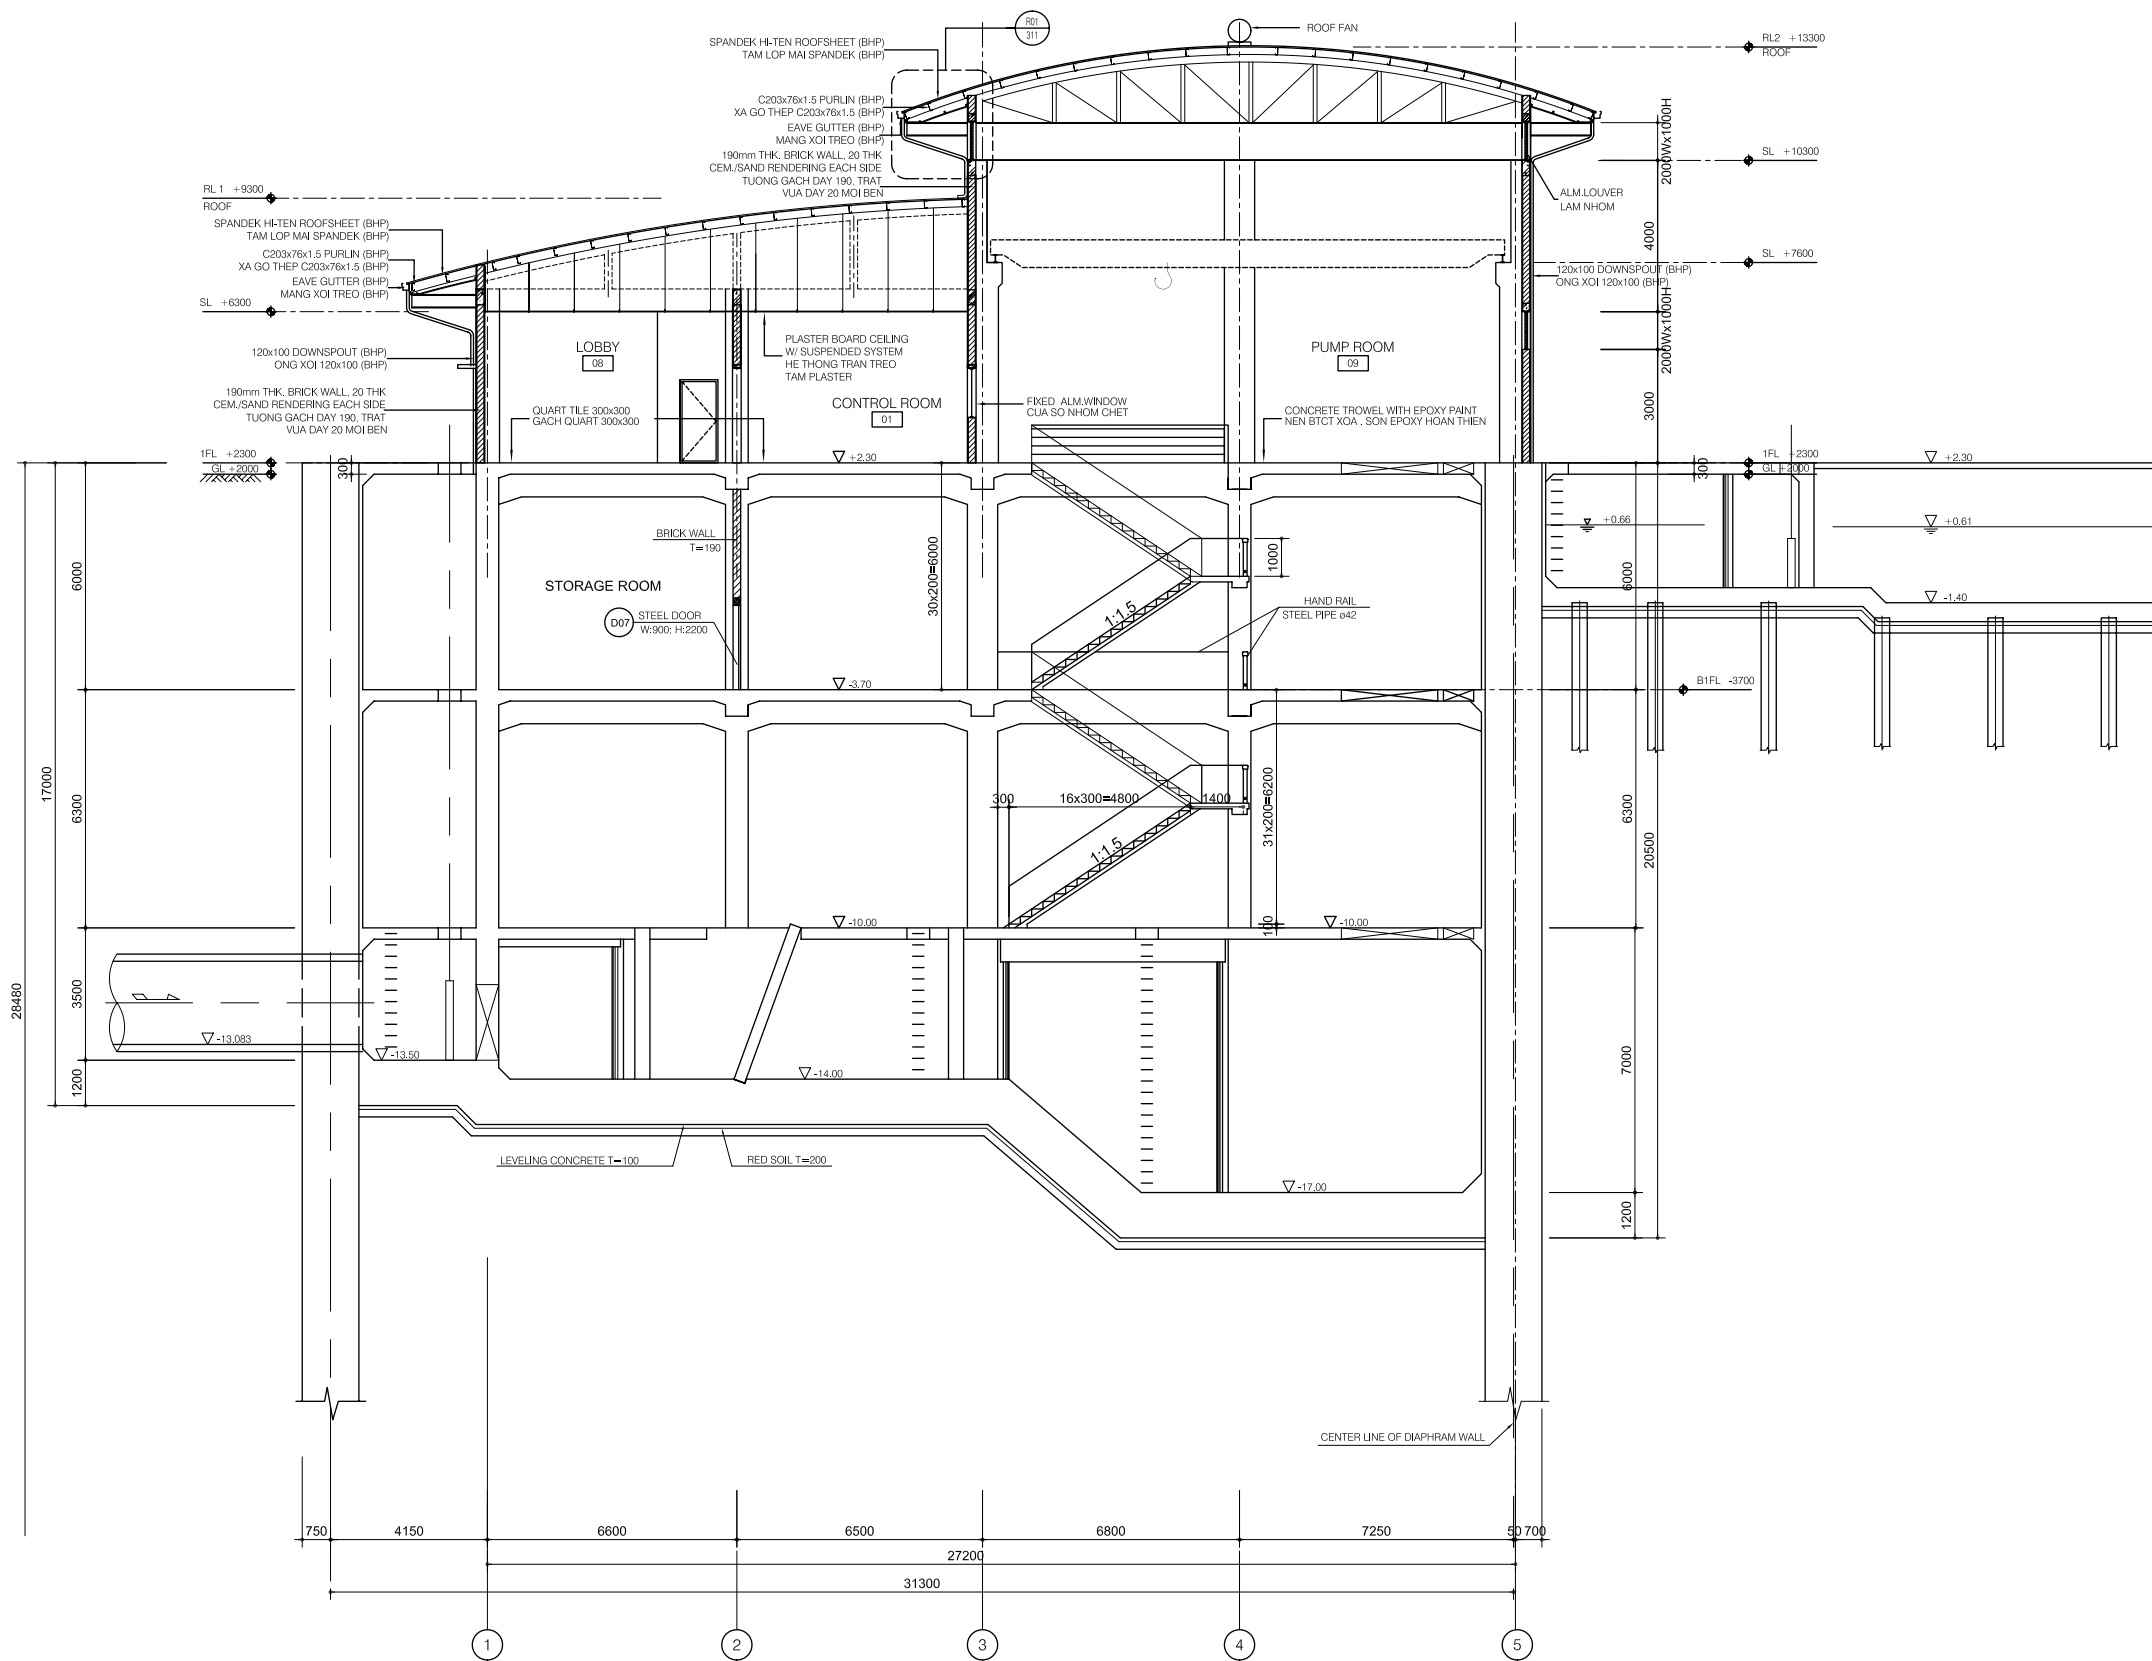


**SECTION A-A**

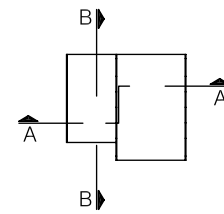

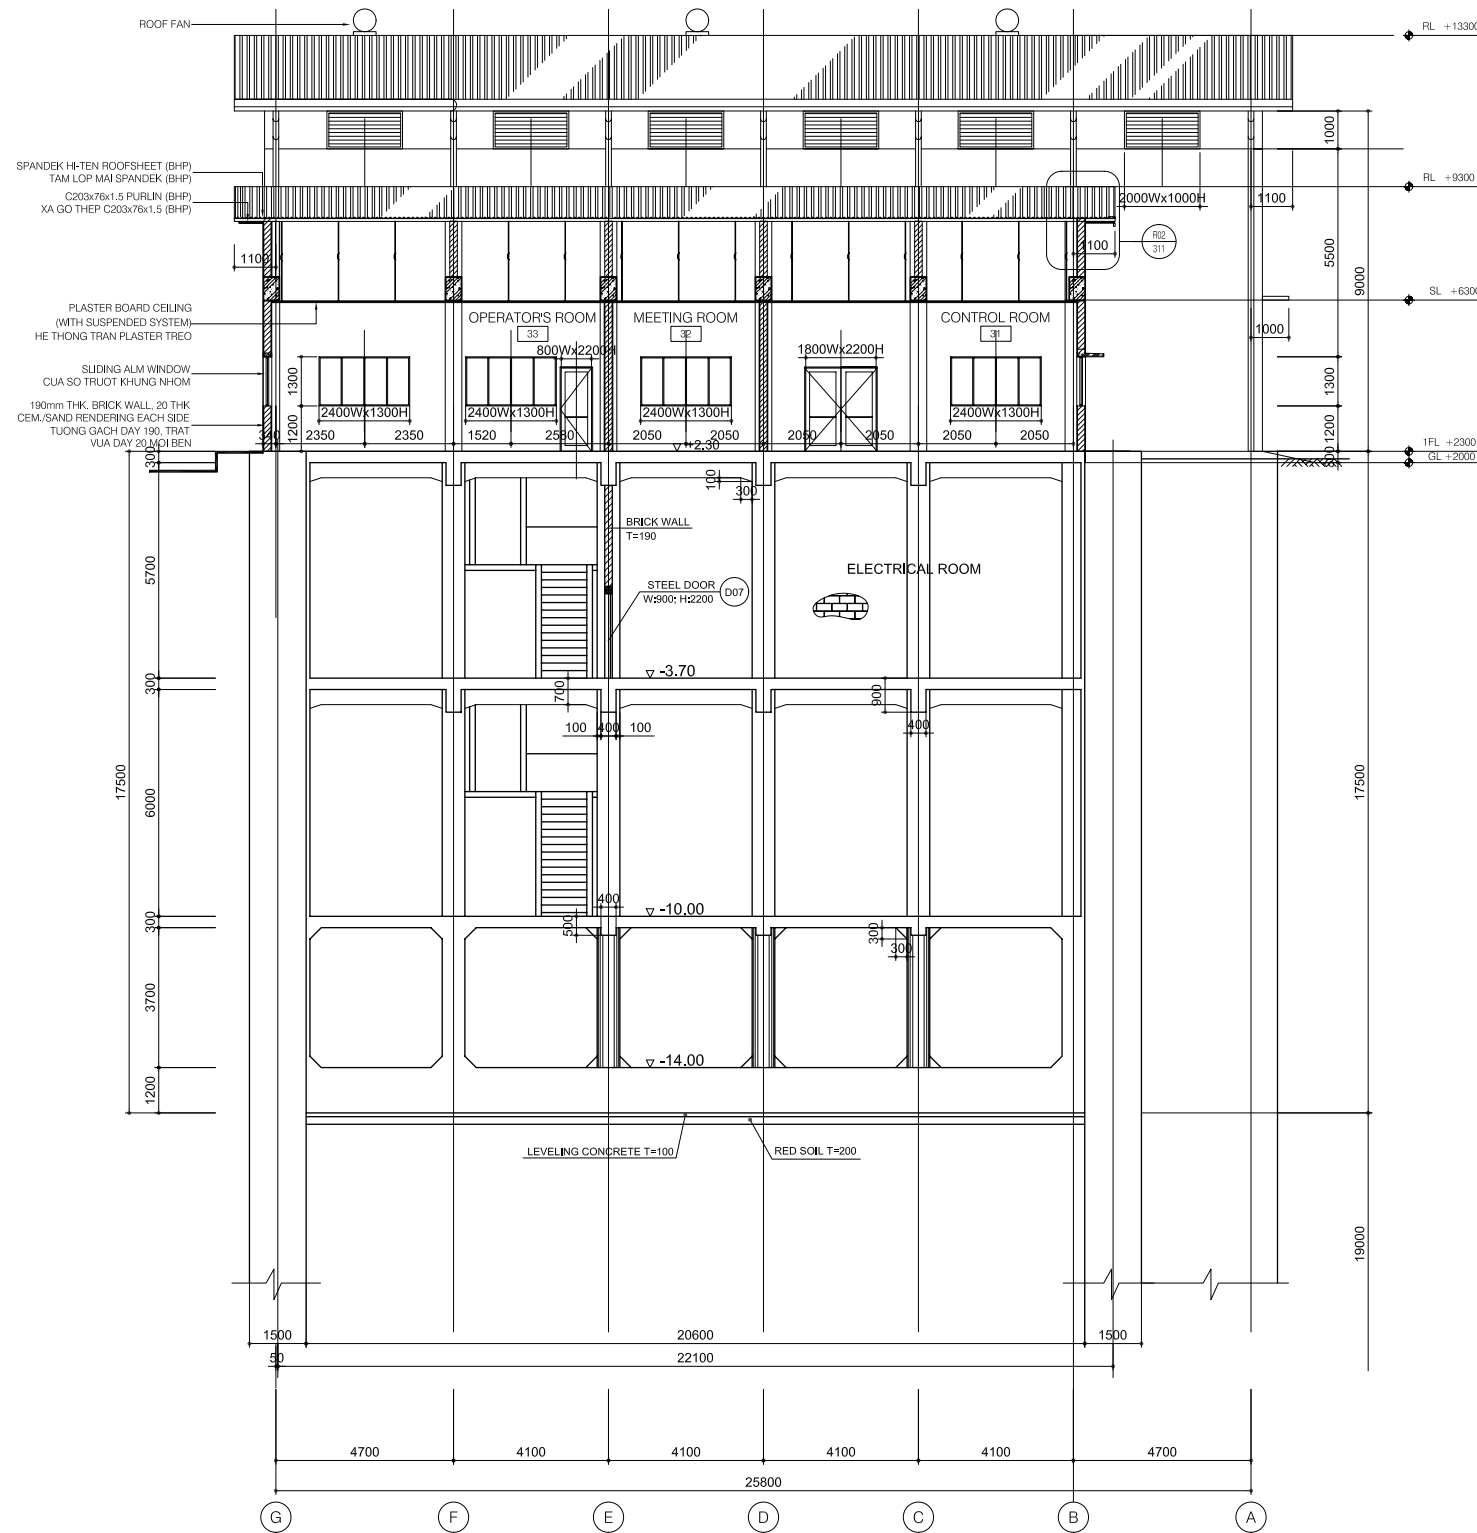


NO.	DATE	DESCRIPTIONS	BY	APRO.
REVISIONS				
PROJECT MANAGEMENT UNIT FOR HO CHI MINH CITY WATER ENVIRONMENT IMPROVEMENT				
THE DETAILED DESIGN STUDY ON HO CHI MINH CITY WATER ENVIRONMENT IMPROVEMENT PROJECT IN THE SOCIALIST REPUBLIC OF VIET NAM				
PACKAGE INTERMEDIATE WASTEWATER PUMPING STATION  PUMP HOUSE, O/M OFFICE AND ELECTRIC ROOM SECTION A-A				
SCALE : 1/100				
JAPAN INTERNATIONAL COOPERATION AGENCY ( JICA )				
PACIFIC CONSULTANTS INTERNATIONAL				
DESIGNED KIMURA TORU			CHECKED KONDO MASAMI	
DATE : JUNE 2001		DWG. No. PC - IWPS - 304		

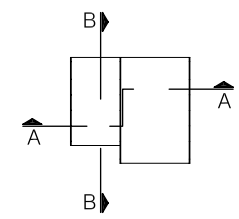


**SECTION B-B**



NO.	DATE	DESCRIPTIONS	BY	APRO.
REVISIONS				
PROJECT MANAGEMENT UNIT FOR HO CHI MINH CITY WATER ENVIRONMENT IMPROVEMENT				
THE DETAILED DESIGN STUDY ON HO CHI MINH CITY WATER ENVIRONMENT IMPROVEMENT PROJECT IN THE SOCIALIST REPUBLIC OF VIET NAM				
PACKAGE C INTERMEDIATE WASTEWATER PUMPING STATION				
PUMP HOUSE, O/M OFFICE AND ELECTRIC ROOM SECTION B-B				
SCALE : 1/100				
 JAPAN INTERNATIONAL COOPERATION AGENCY ( JICA )				
 PACIFIC CONSULTANTS INTERNATIONAL				
DESIGNED KIMURA TORU		CHECKED KONDO MASAMI		
DATE : JUNE 2001		DWG. No. PC - IWPS - 305		

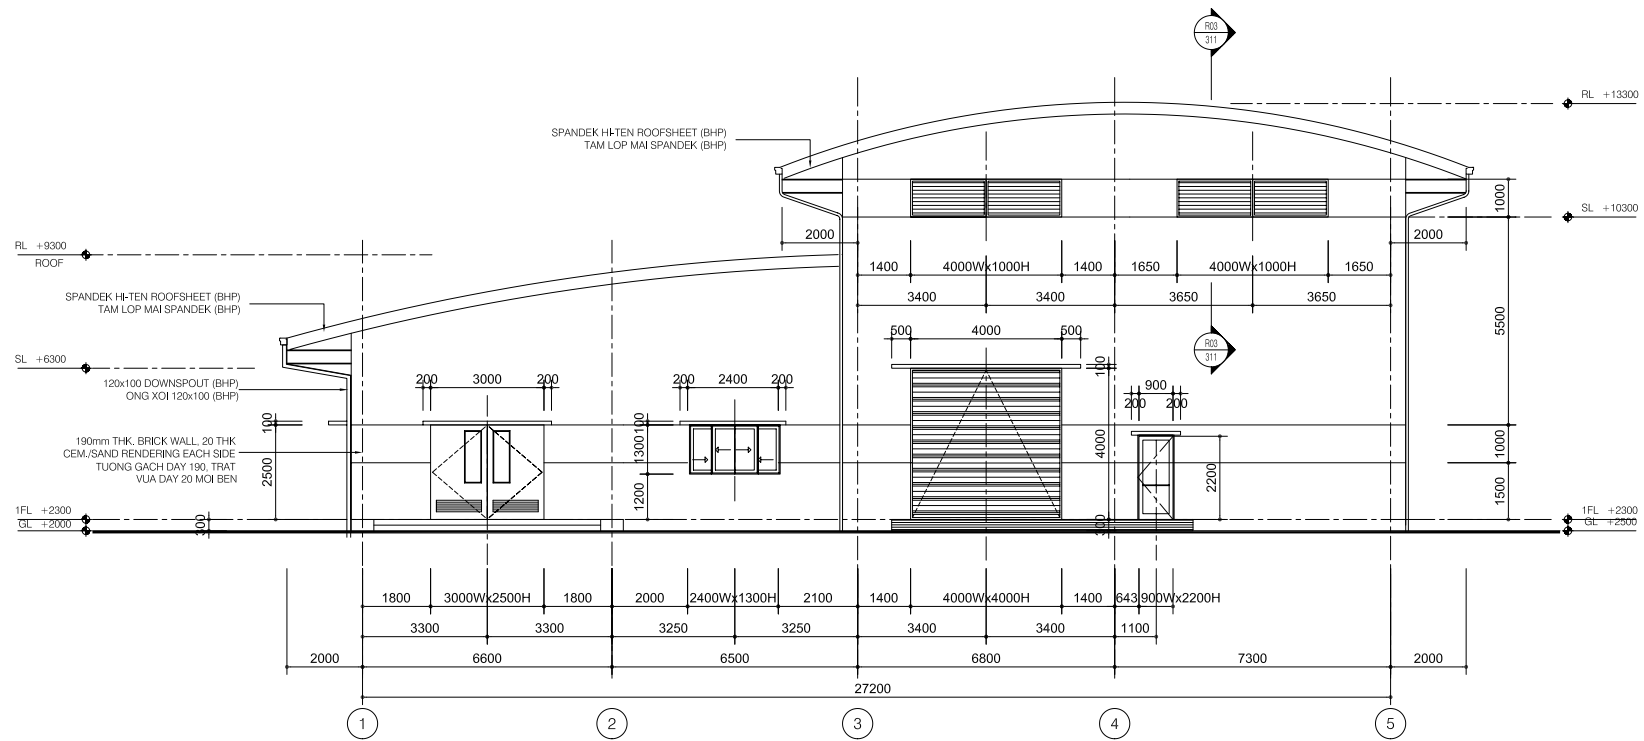


**ELEVATION LINE A**

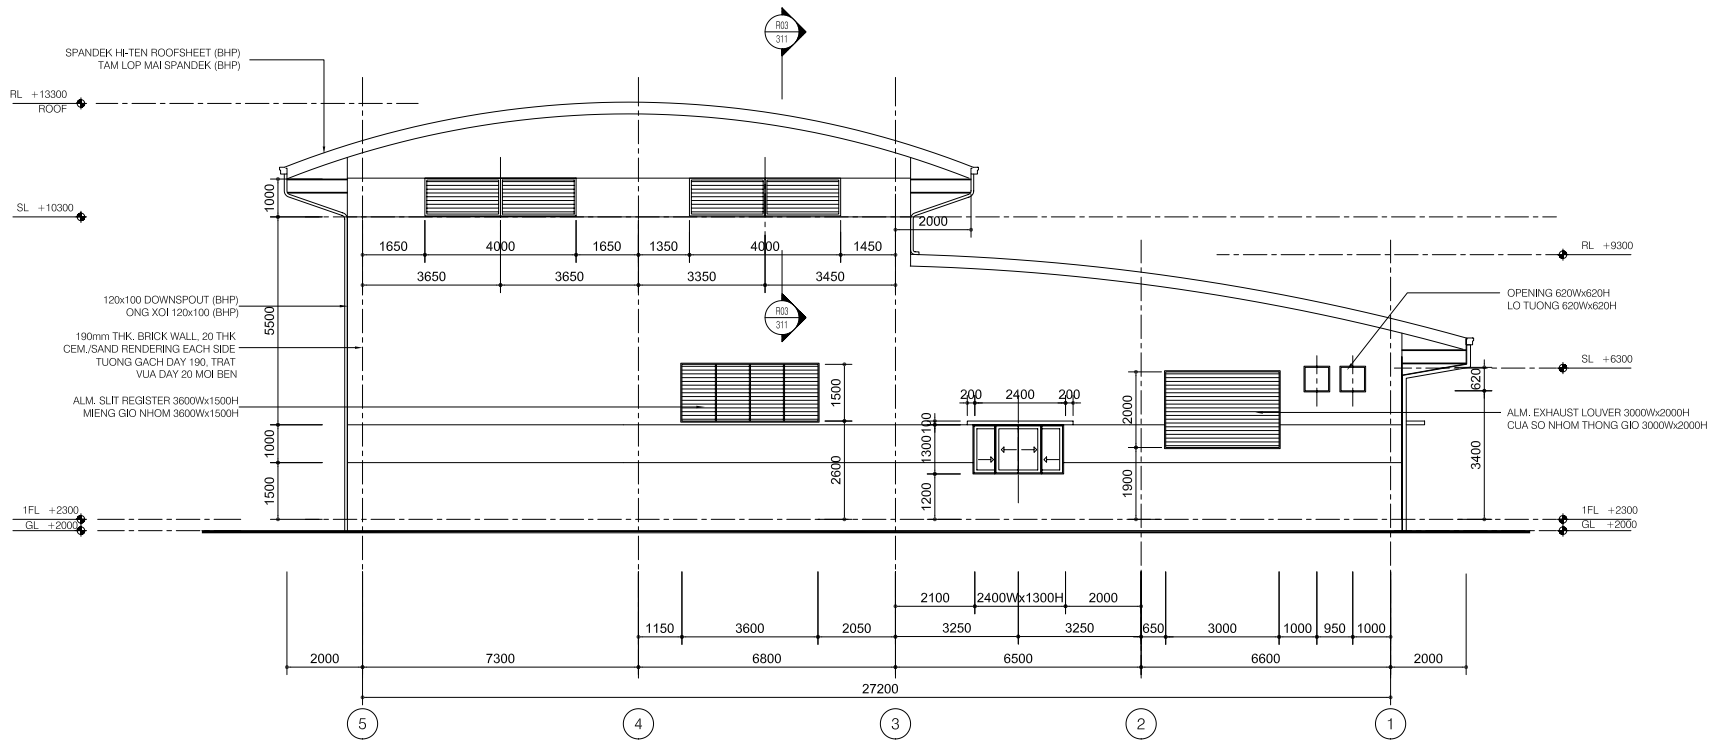


**ELEVATION LINE G**

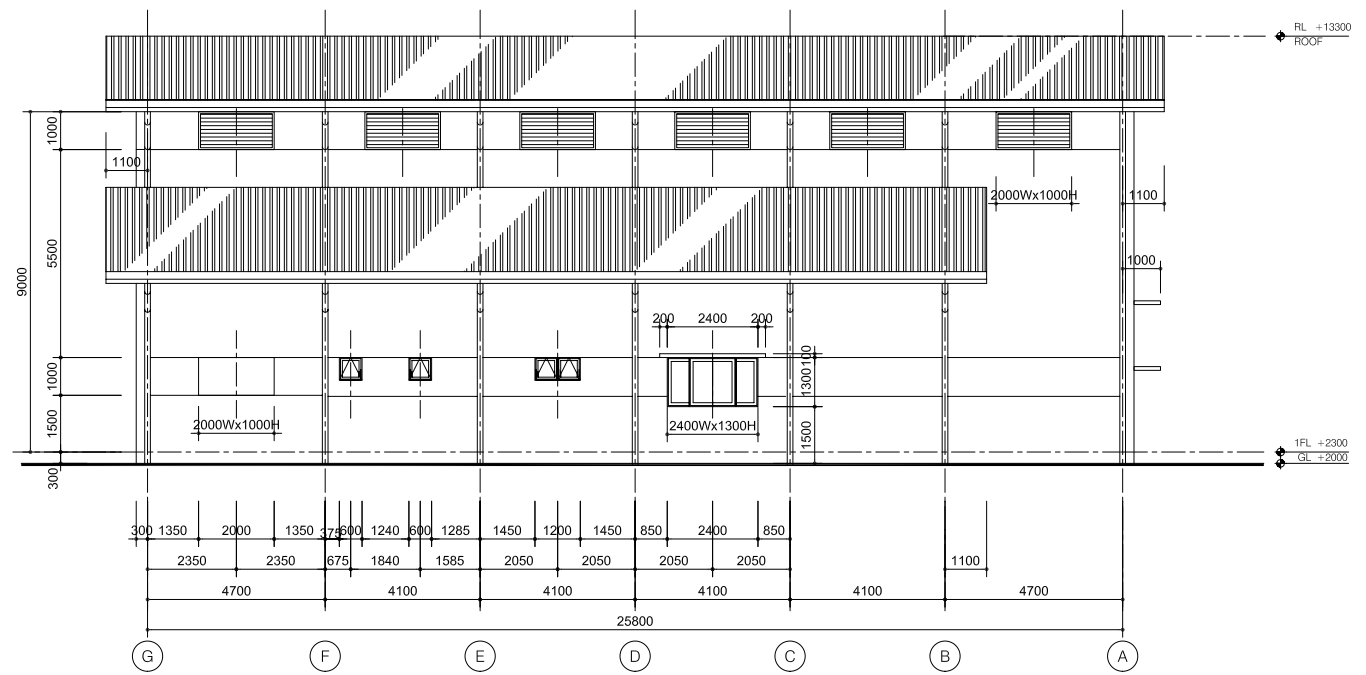

NO.	DATE	DESCRIPTIONS	BY	APRO.
REVISIONS				
PROJECT MANAGEMENT UNIT FOR HO CHI MINH CITY WATER ENVIRONMENT IMPROVEMENT				
THE DETAILED DESIGN STUDY ON HO CHI MINH CITY WATER ENVIRONMENT IMPROVEMENT PROJECT IN THE SOCIALIST REPUBLIC OF VIET NAM				
PACKAGE C INTERMEDIATE WASTEWATER PUMPING STATION  PUMP HOUSE AND O/M OFFICE ELEVATION LINE A & G				
SCALE : 1/100				
JAPAN INTERNATIONAL COOPERATION AGENCY ( JICA )				
PACIFIC CONSULTANTS INTERNATIONAL				
DESIGNED KIMURA TORU		CHECKED KONDO MASAMI		
DATE : JUNE 2001		DWG. No. PC-IWPS-306		

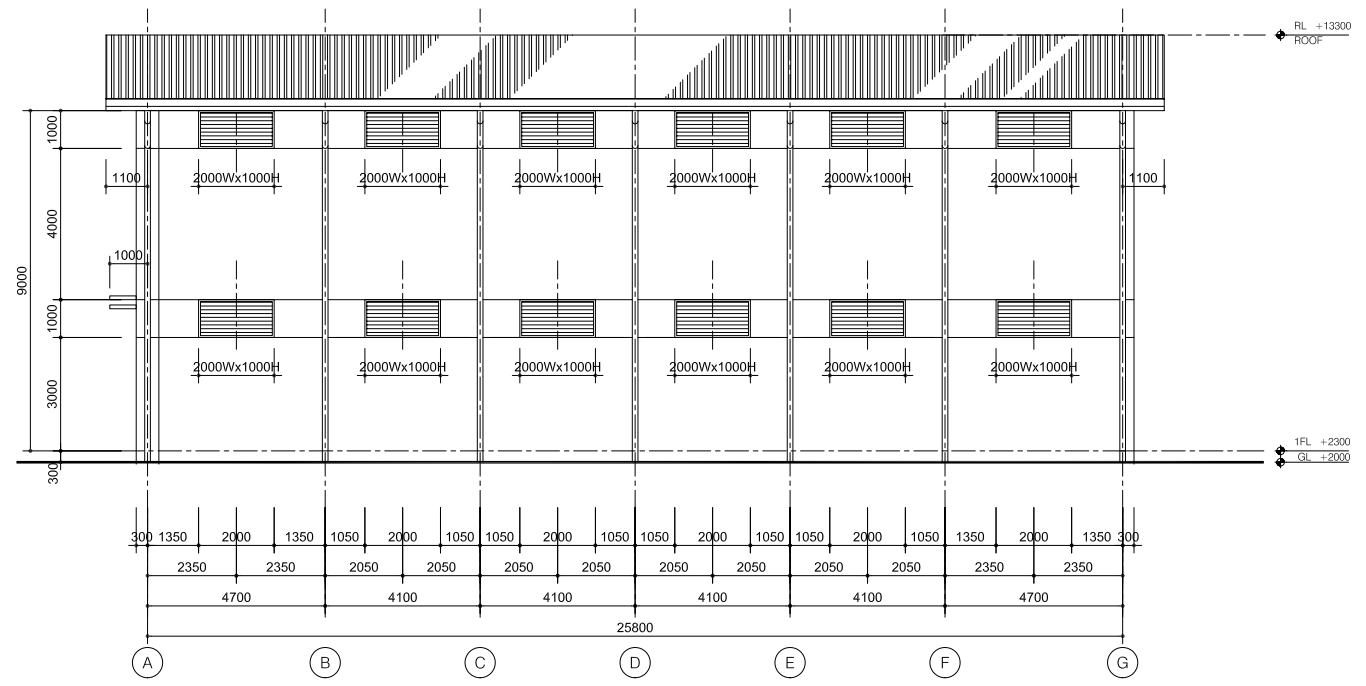

**ELEVATION LINE 1**



**ELEVATION LINE 5**

NO.	DATE	DESCRIPTIONS	BY	APRO.
REVISIONS				
PROJECT MANAGEMENT UNIT FOR HO CHI MINH CITY WATER ENVIRONMENT IMPROVEMENT				
THE DETAILED DESIGN STUDY ON HO CHI MINH CITY WATER ENVIRONMENT IMPROVEMENT PROJECT IN THE SOCIALIST REPUBLIC OF VIET NAM				
PACKAGE C INTERMEDIATE WASTEWATER PUMPING STATION PUMP HOUSE AND O/M OFFICE ELEVATION LINE 1 & 5				
SCALE : 1/100				
 JAPAN INTERNATIONAL COOPERATION AGENCY ( JICA )				
 PACIFIC CONSULTANTS INTERNATIONAL				
DESIGNED KIMURA TORU		CHECKED KONDO MASAMI		
DATE : JUNE 2001		DWG. No. PC - IWPS - 307		