



NO.	DATE	DESCRIPTIONS	BY	APRO.
REVISIONS				
PROJECT MANAGEMENT UNIT FOR WATER ENVIRONMENT IMPROVEMENT FOR HO CHI MINH CITY				
THE DETAILD DESIGN ON HO CHI MINH CITY WATER ENVIRONMENT IMPROVEMENT PROJECT IN THE SOCIALIST REPUBLIC OF VIET NAM				
PACKAGE E WASTEWATER TREATMENT PLANT WATER TREATMENT FACILITY PLAN (20 / 20)				
SCALE : 1:100				
JAPAN INTERNATIONAL COOPERATION AGENCY (JICA)				
PACIFIC CONSULTANTS INTERNATIONAL				
DESIGNED KAWAZU SHINYA			CHECKED KONDO MASAMI	
DATE : JUNE 2001			DWG. No. PE - WWTP - 440	


FINAL SEDIMENTATION TANK PIPE GALLERY LOWER&MIDDLE PLAN (2)

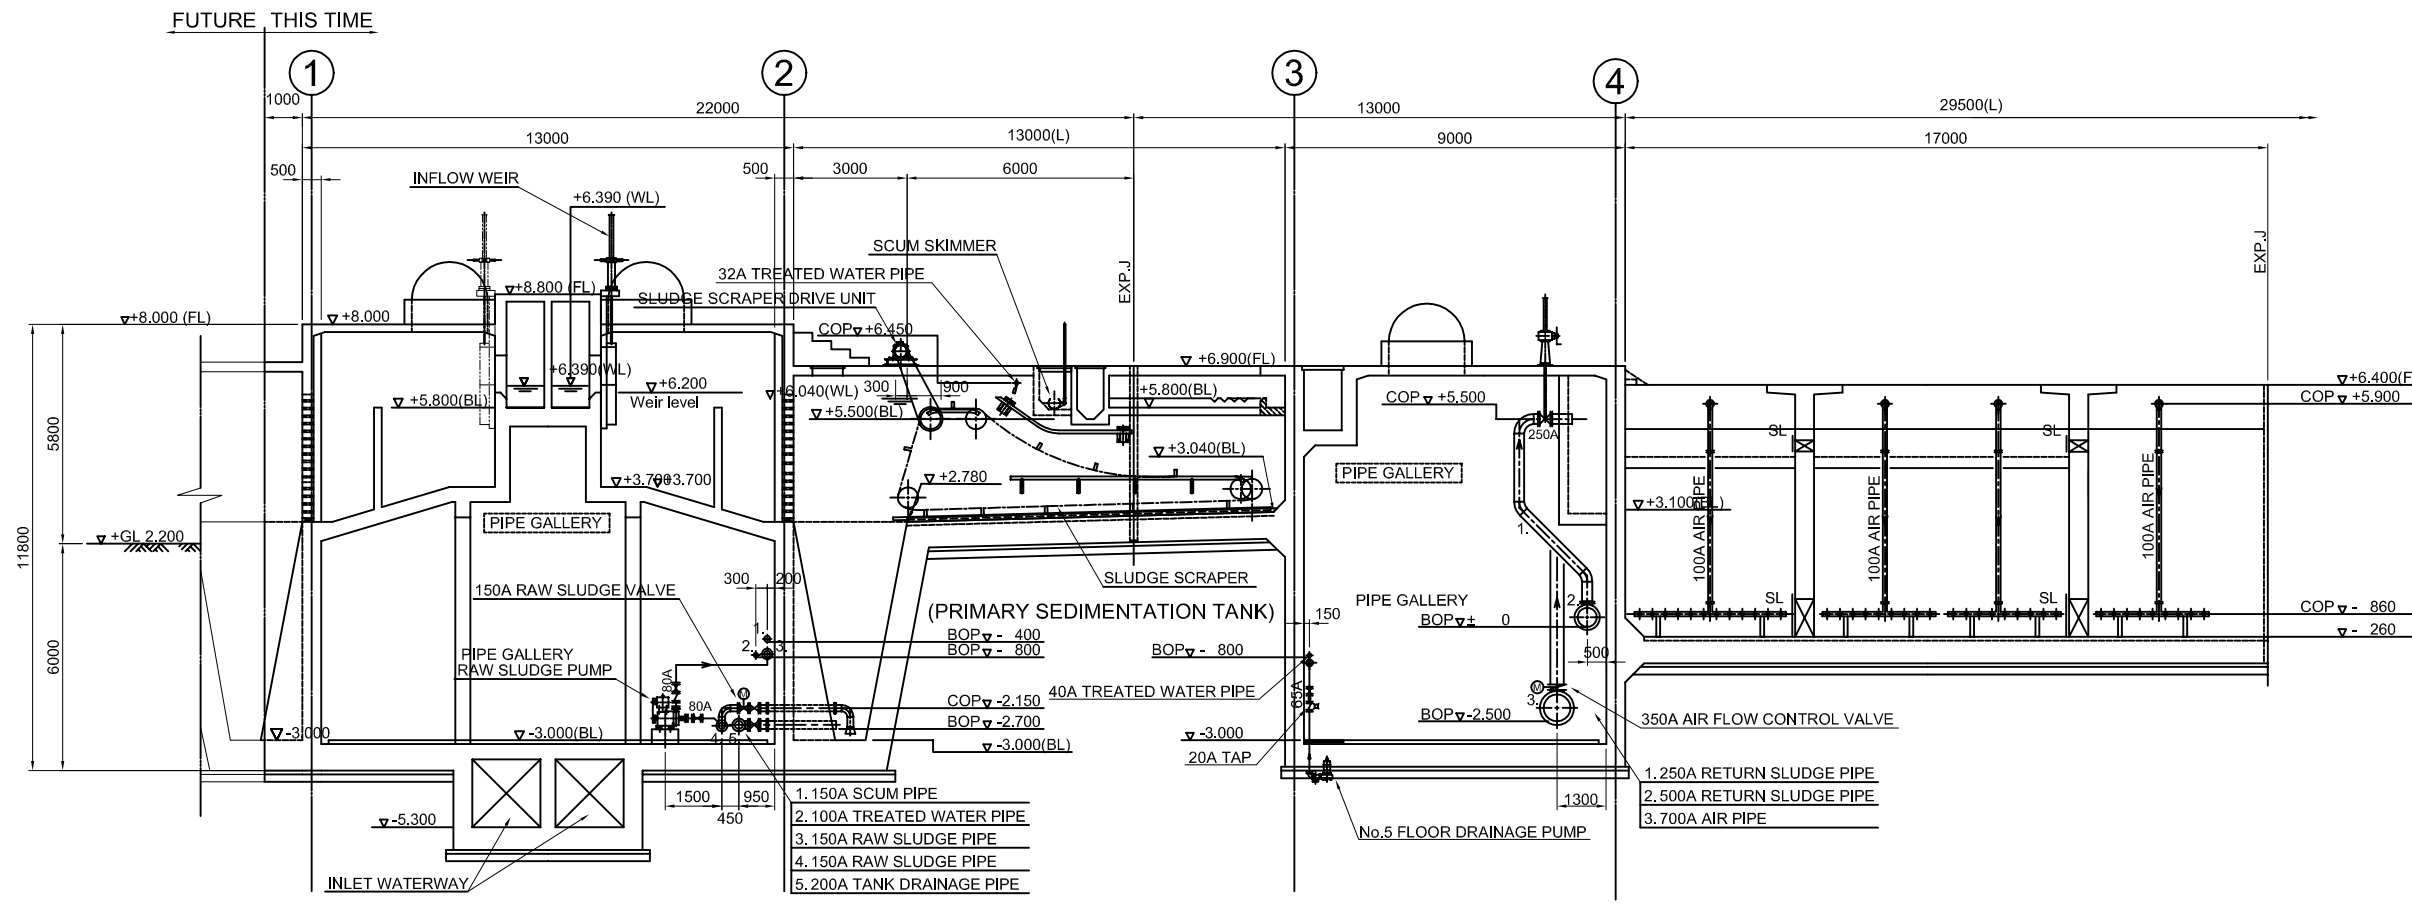


SECTION A-A

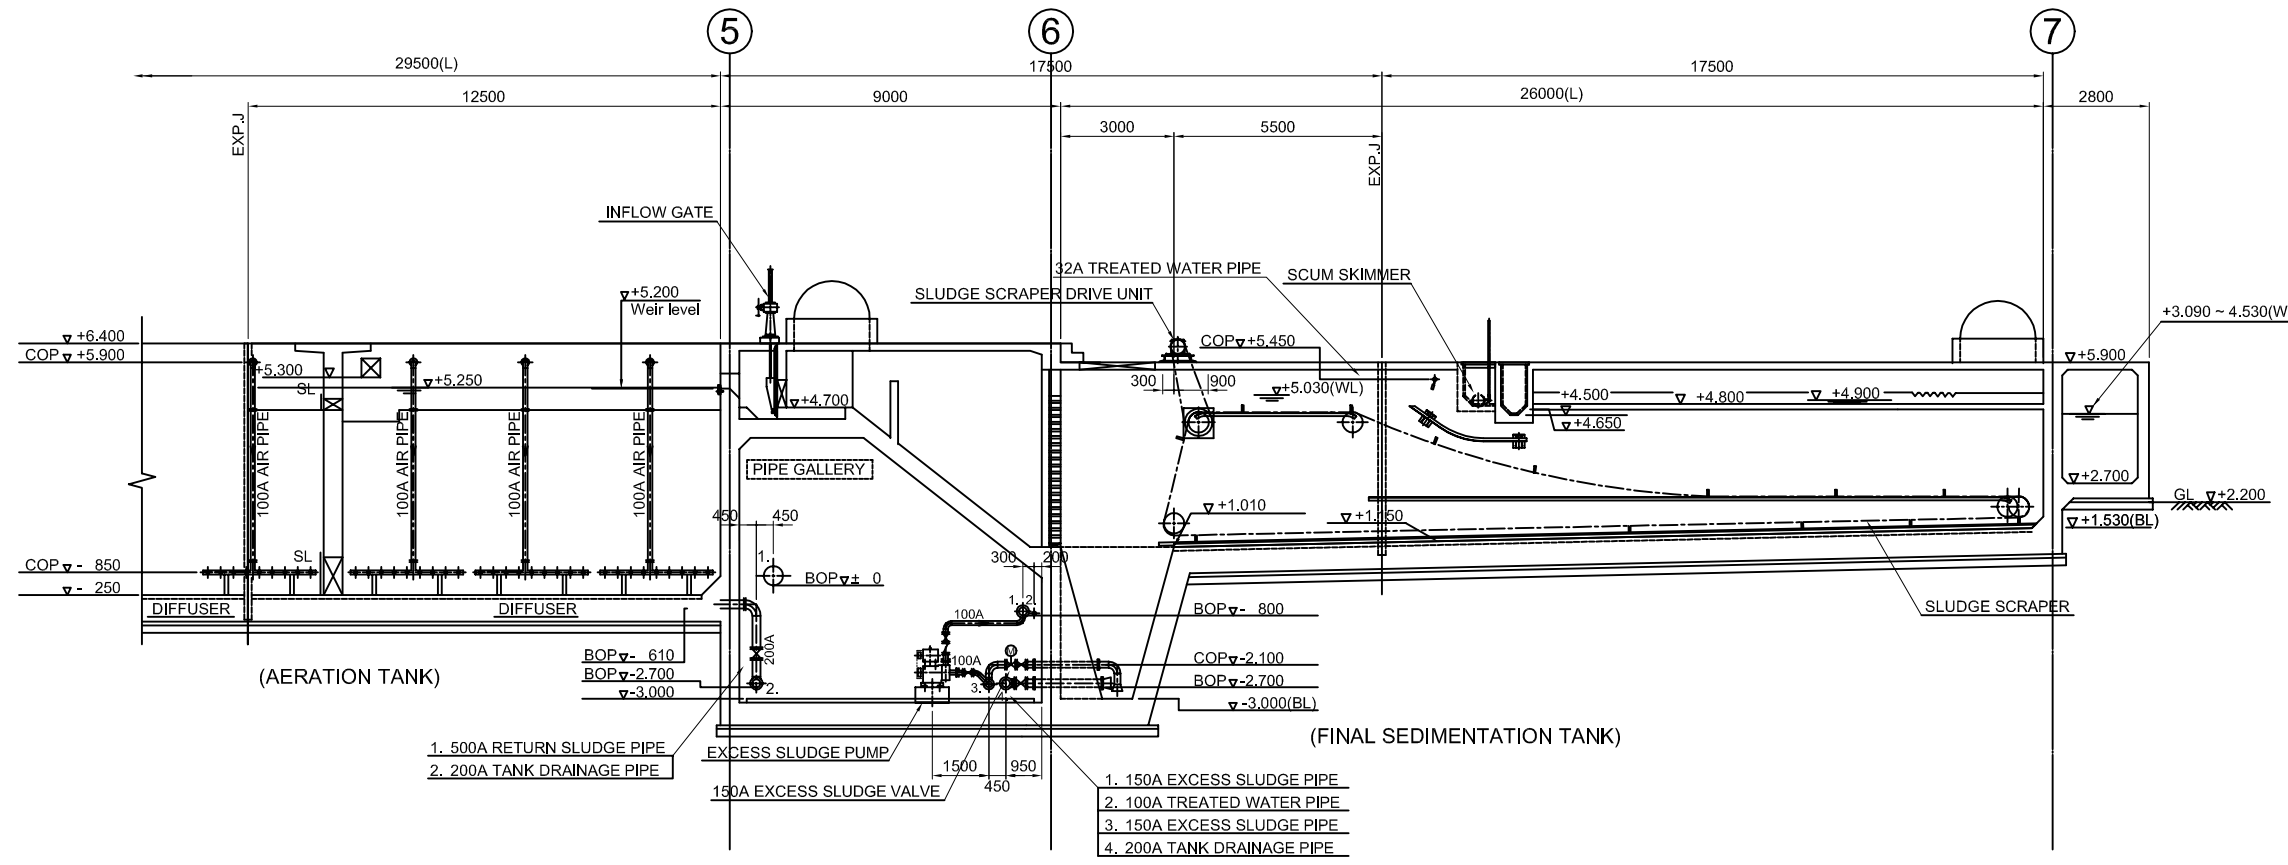


SECTION A-A

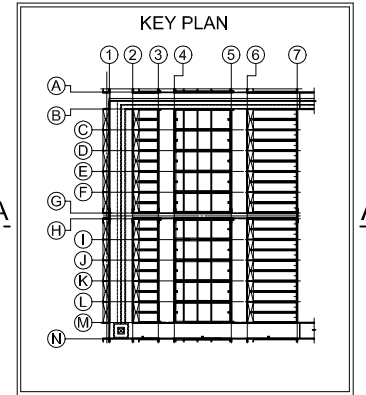


NO.	DATE	DESCRIPTIONS	BY	APRO.
REVISIONS				
PROJECT MANAGEMENT UNIT FOR WATER ENVIRONMENT IMPROVEMENT FOR HO CHI MINH CITY				
THE DETAILD DESIGN ON HO CHI MINH CITY WATER ENVIRONMENT IMPROVEMENT PROJECT IN THE SOCIALIST REPUBLIC OF VIET NAM				
PACKAGE E WASTEWATER TREATMENT PLANT WATER TREATMENT FACILITY CROSS SECTION(1 / 4)				
SCALE : 1:100				
JAPAN INTERNATIONAL COOPERATION AGENCY (JICA)				
PACIFIC CONSULTANTS INTERNATIONAL				
DESIGNED KAWAZU SHINYA		CHECKED KONDO MASAMI		
DATE : JUNE 2001		DWG. No. PE - WWTP - 441		

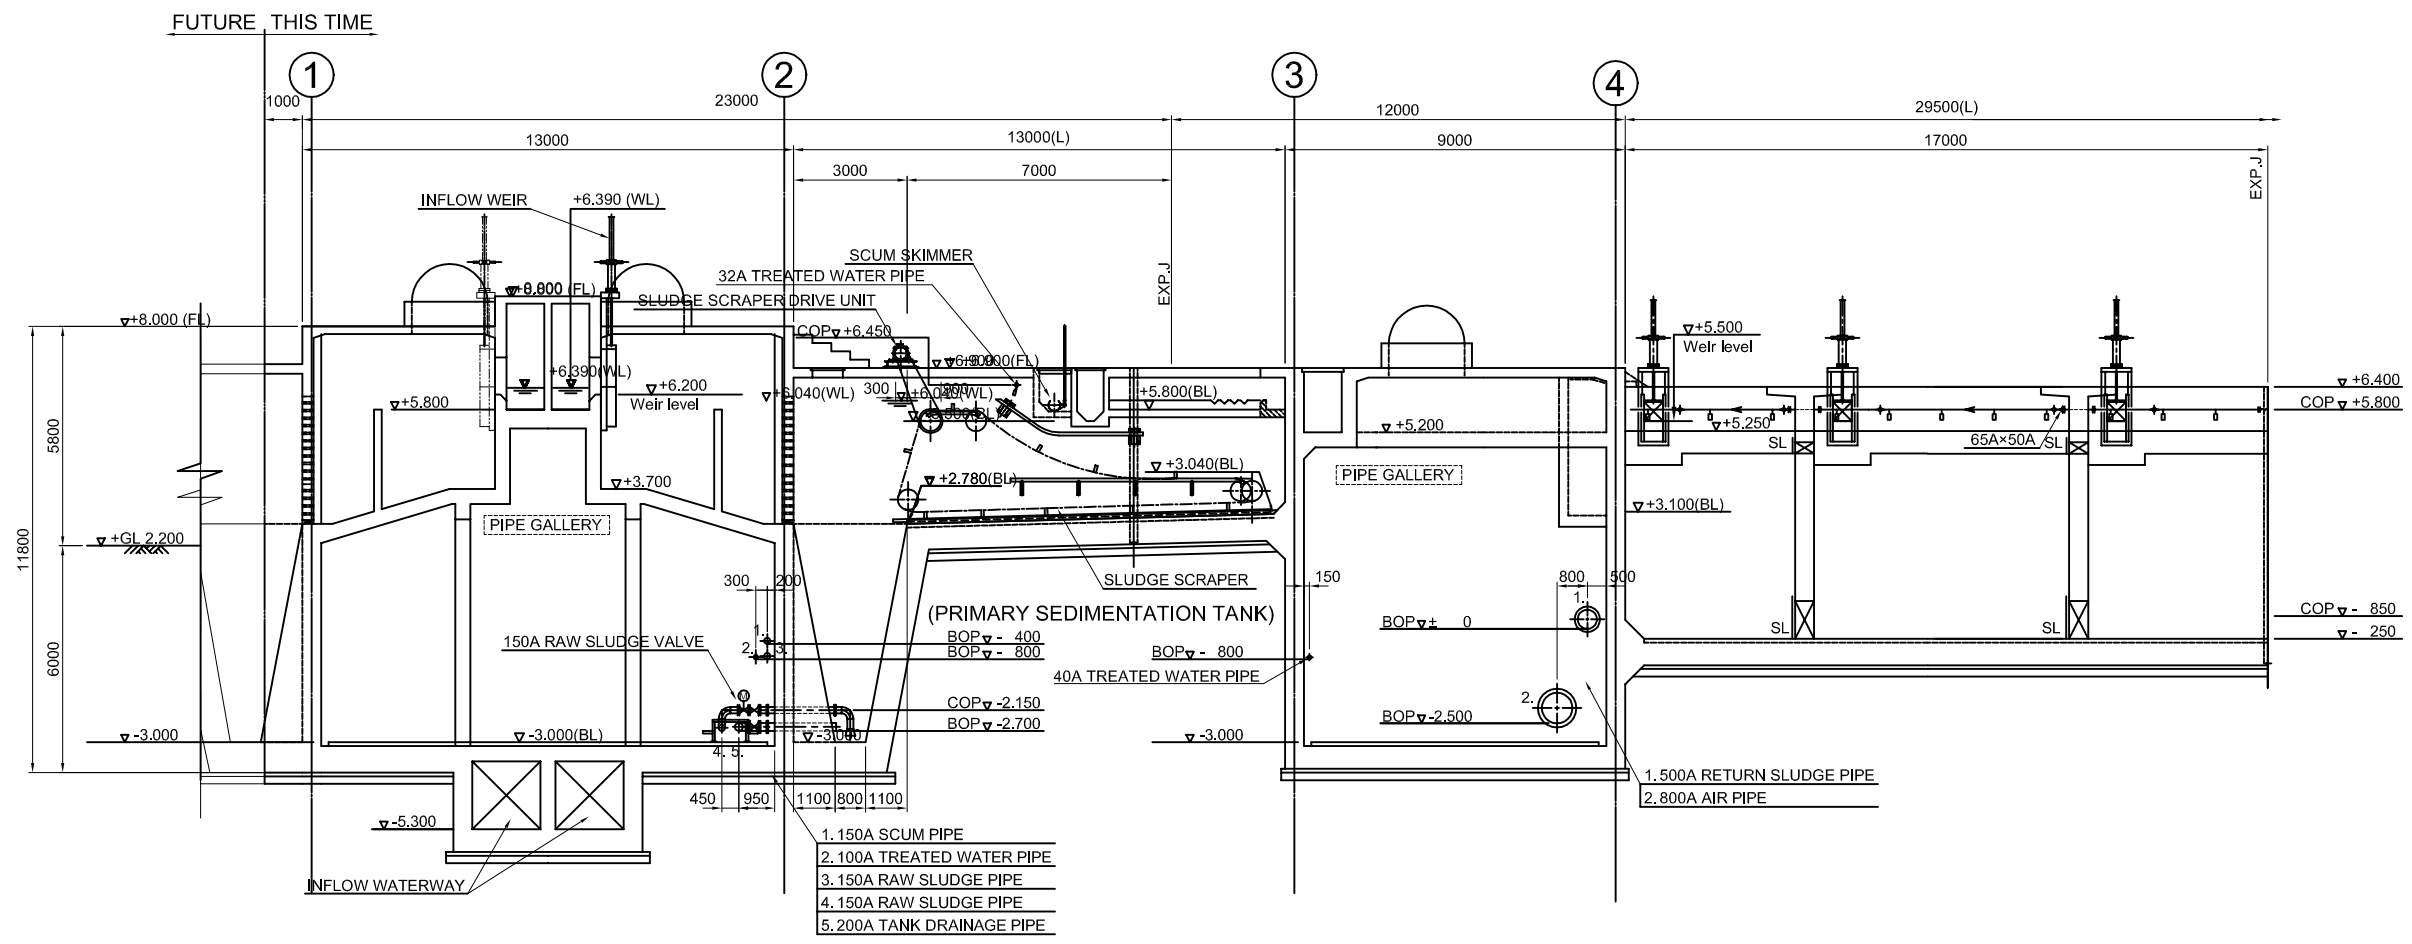

SECTION B-B

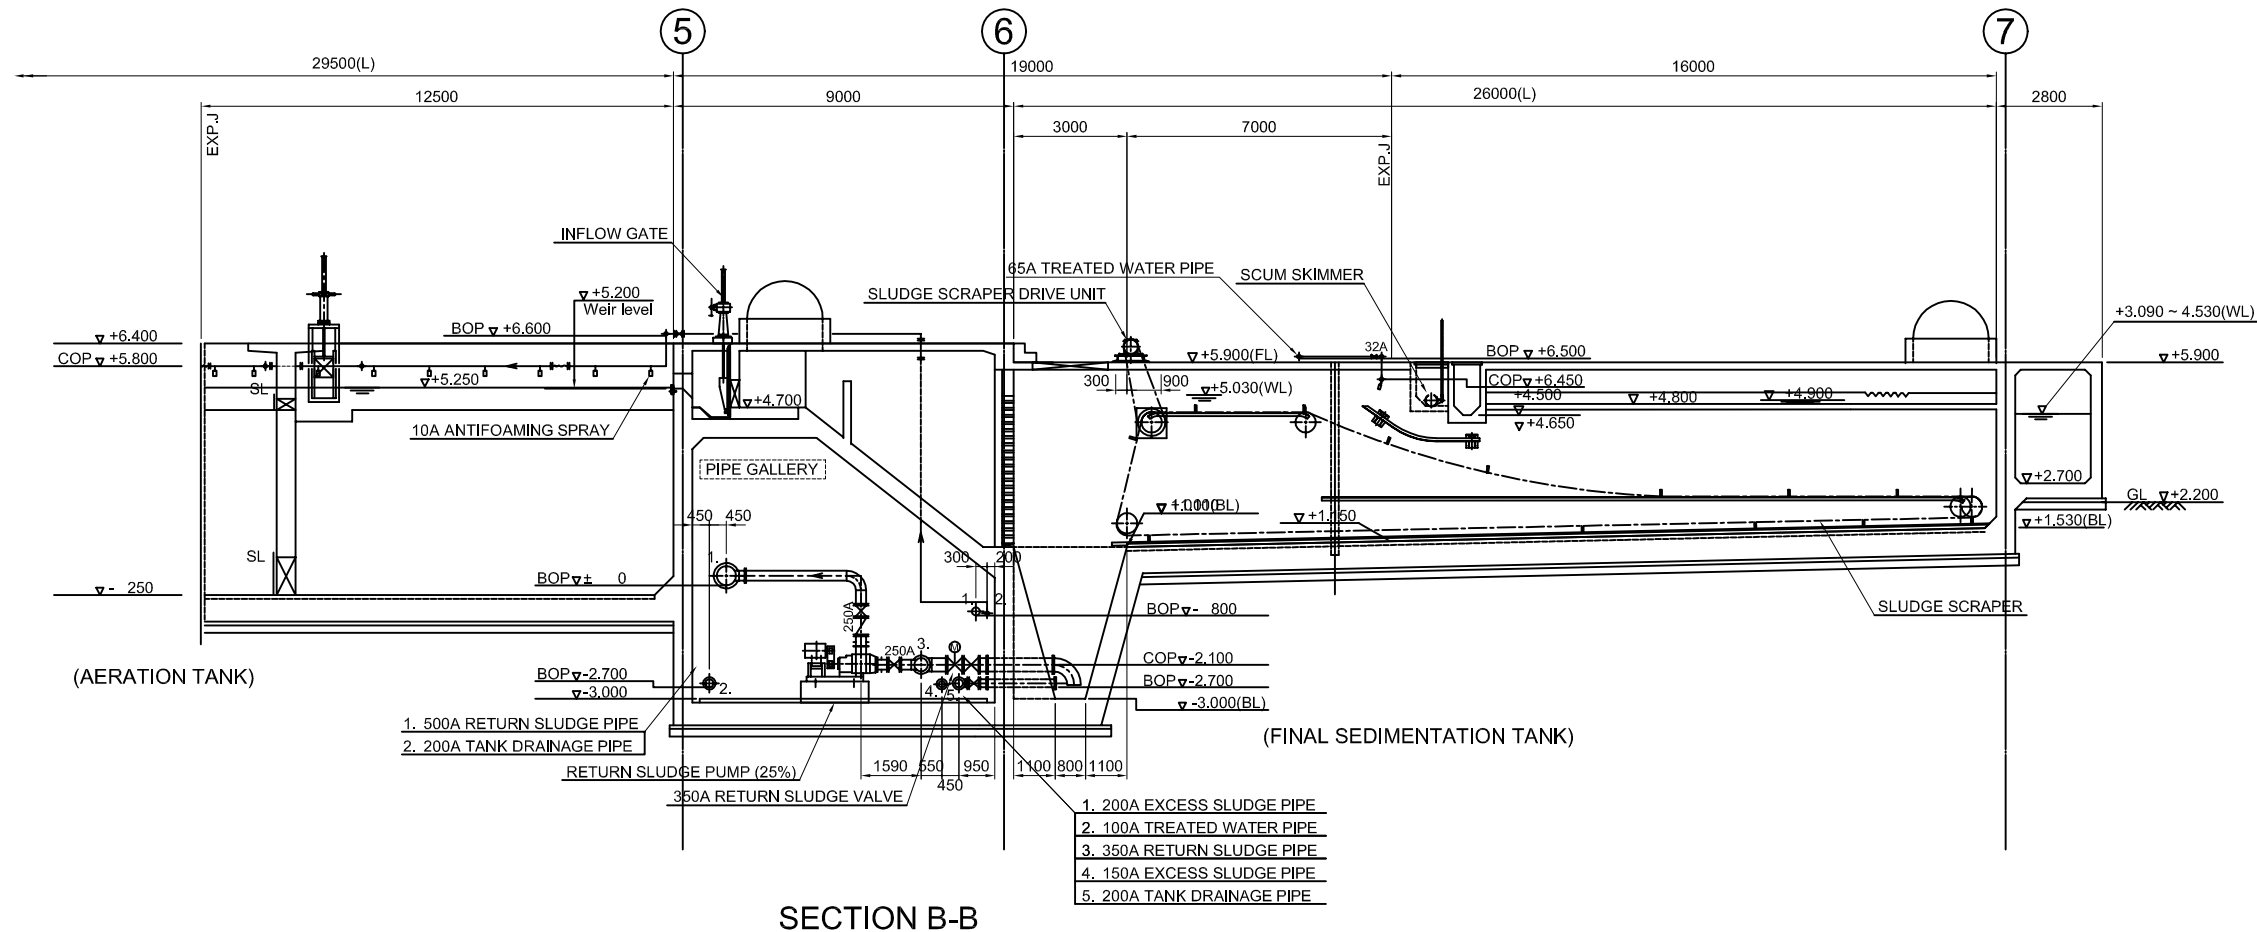

SECTION B-B

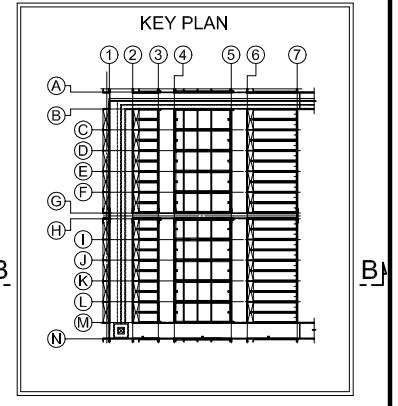

NO.	DATE	DESCRIPTIONS	BY	APRO.

REVISIONS

PROJECT MANAGEMENT UNIT FOR
WATER ENVIRONMENT IMPROVEMENT FOR
HO CHI MINH CITY

THE DETAILD DESIGN ON HO CHI MINH CITY
WATER ENVIRONMENT IMPROVEMENT PROJECT
IN THE SOCIALIST REPUBLIC OF VIET NAM

PACKAGE E

WASTEWATER TREATMENT PLANT

WATER TREATMENT FACILITY


CROSS SECTION(2 / 4)

SCALE : 1:100

JICA JAPAN INTERNATIONAL COOPERATION
AGENCY (JICA)



PACIFIC CONSULTANTS INTERNATIONAL

DESIGNED KAWAZU SHINYA	CHECKED KONDO MASAMI
DATE : JUNE 2001	DWG. No. PE - WWTP - 442

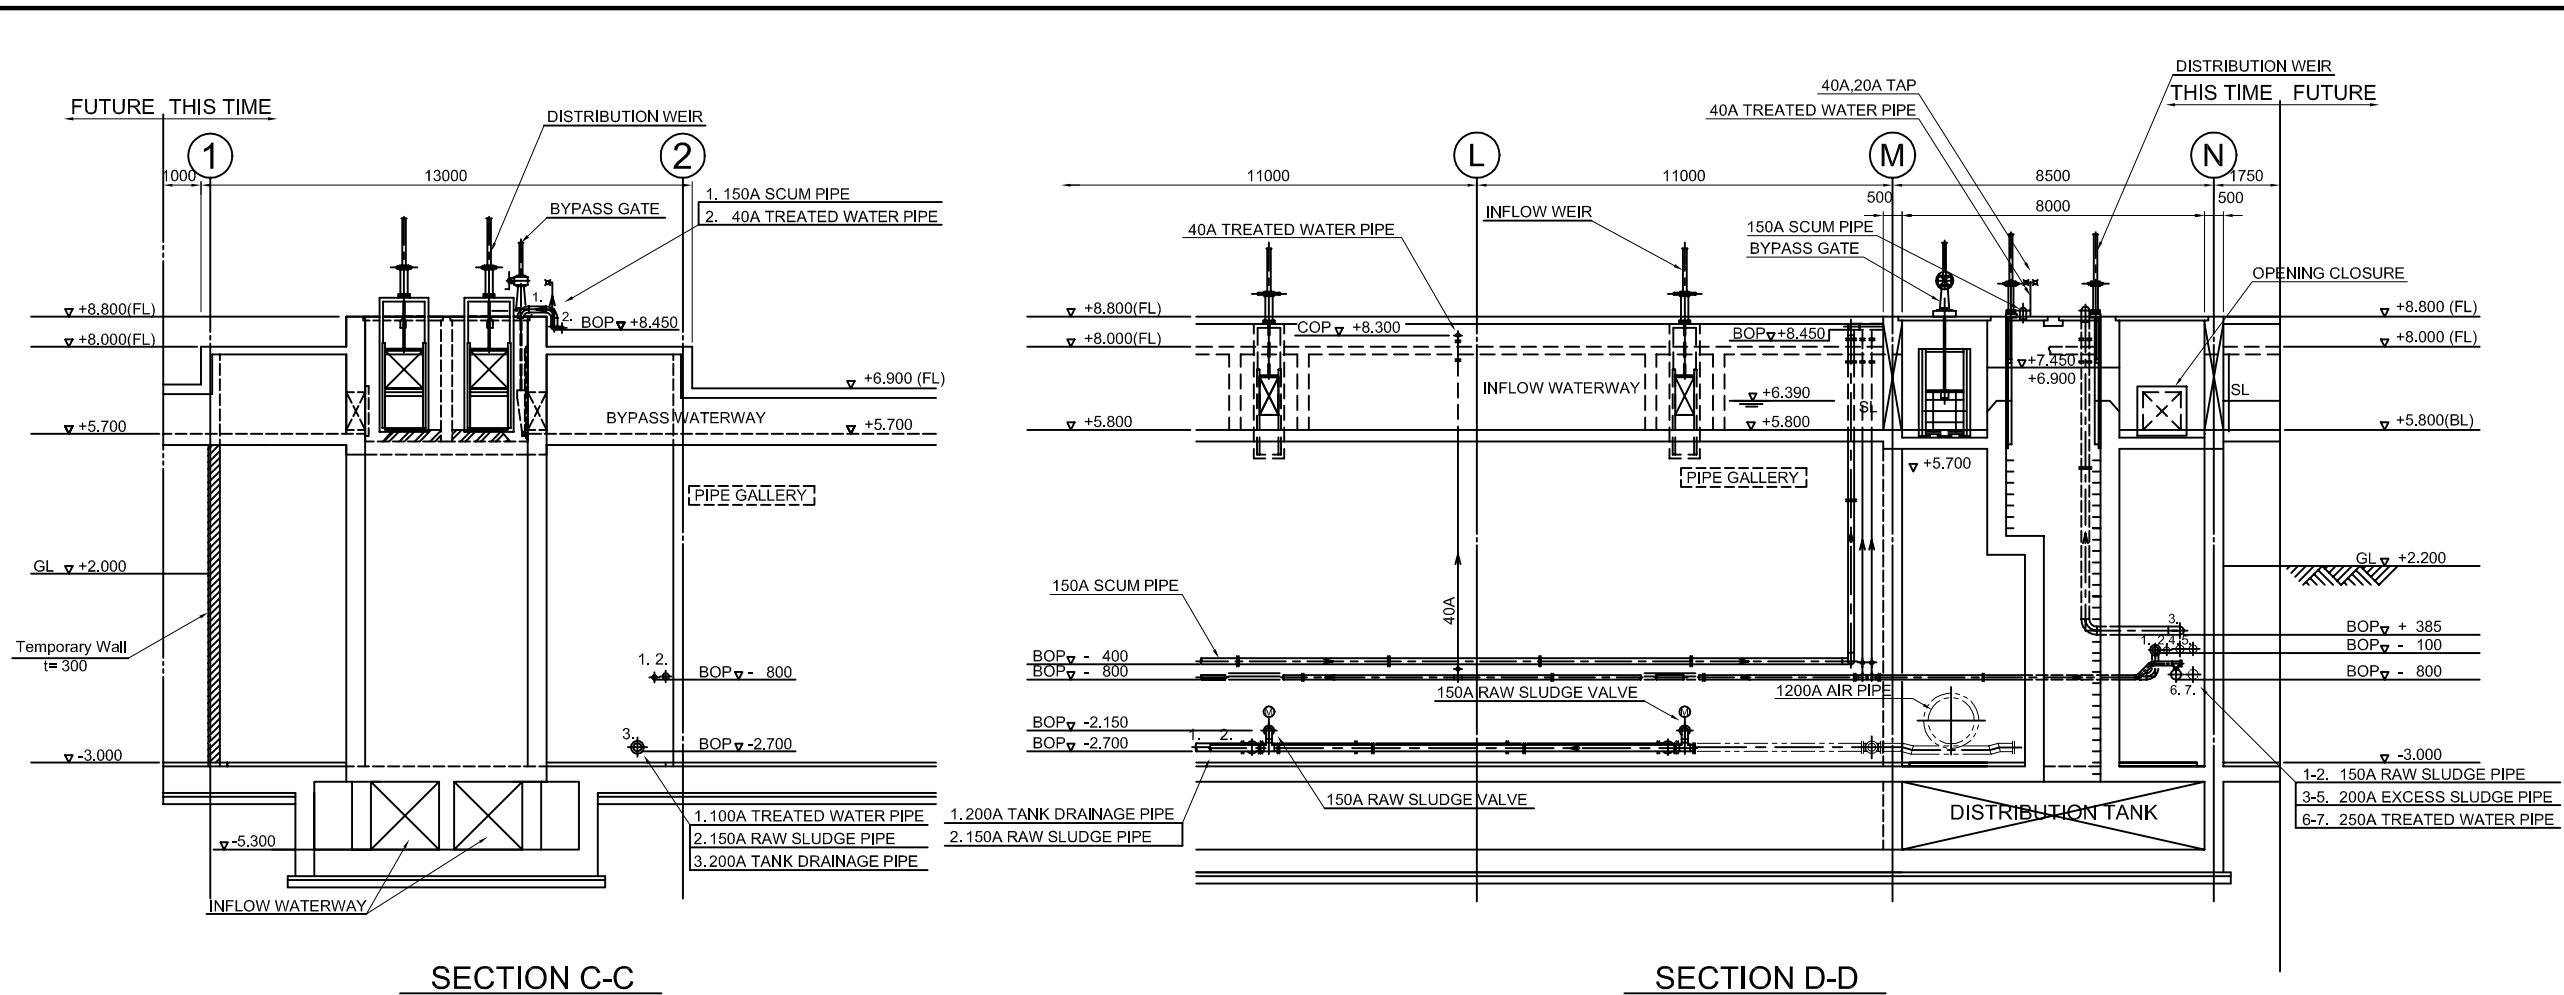

SECTION C-C


SECTION D-D

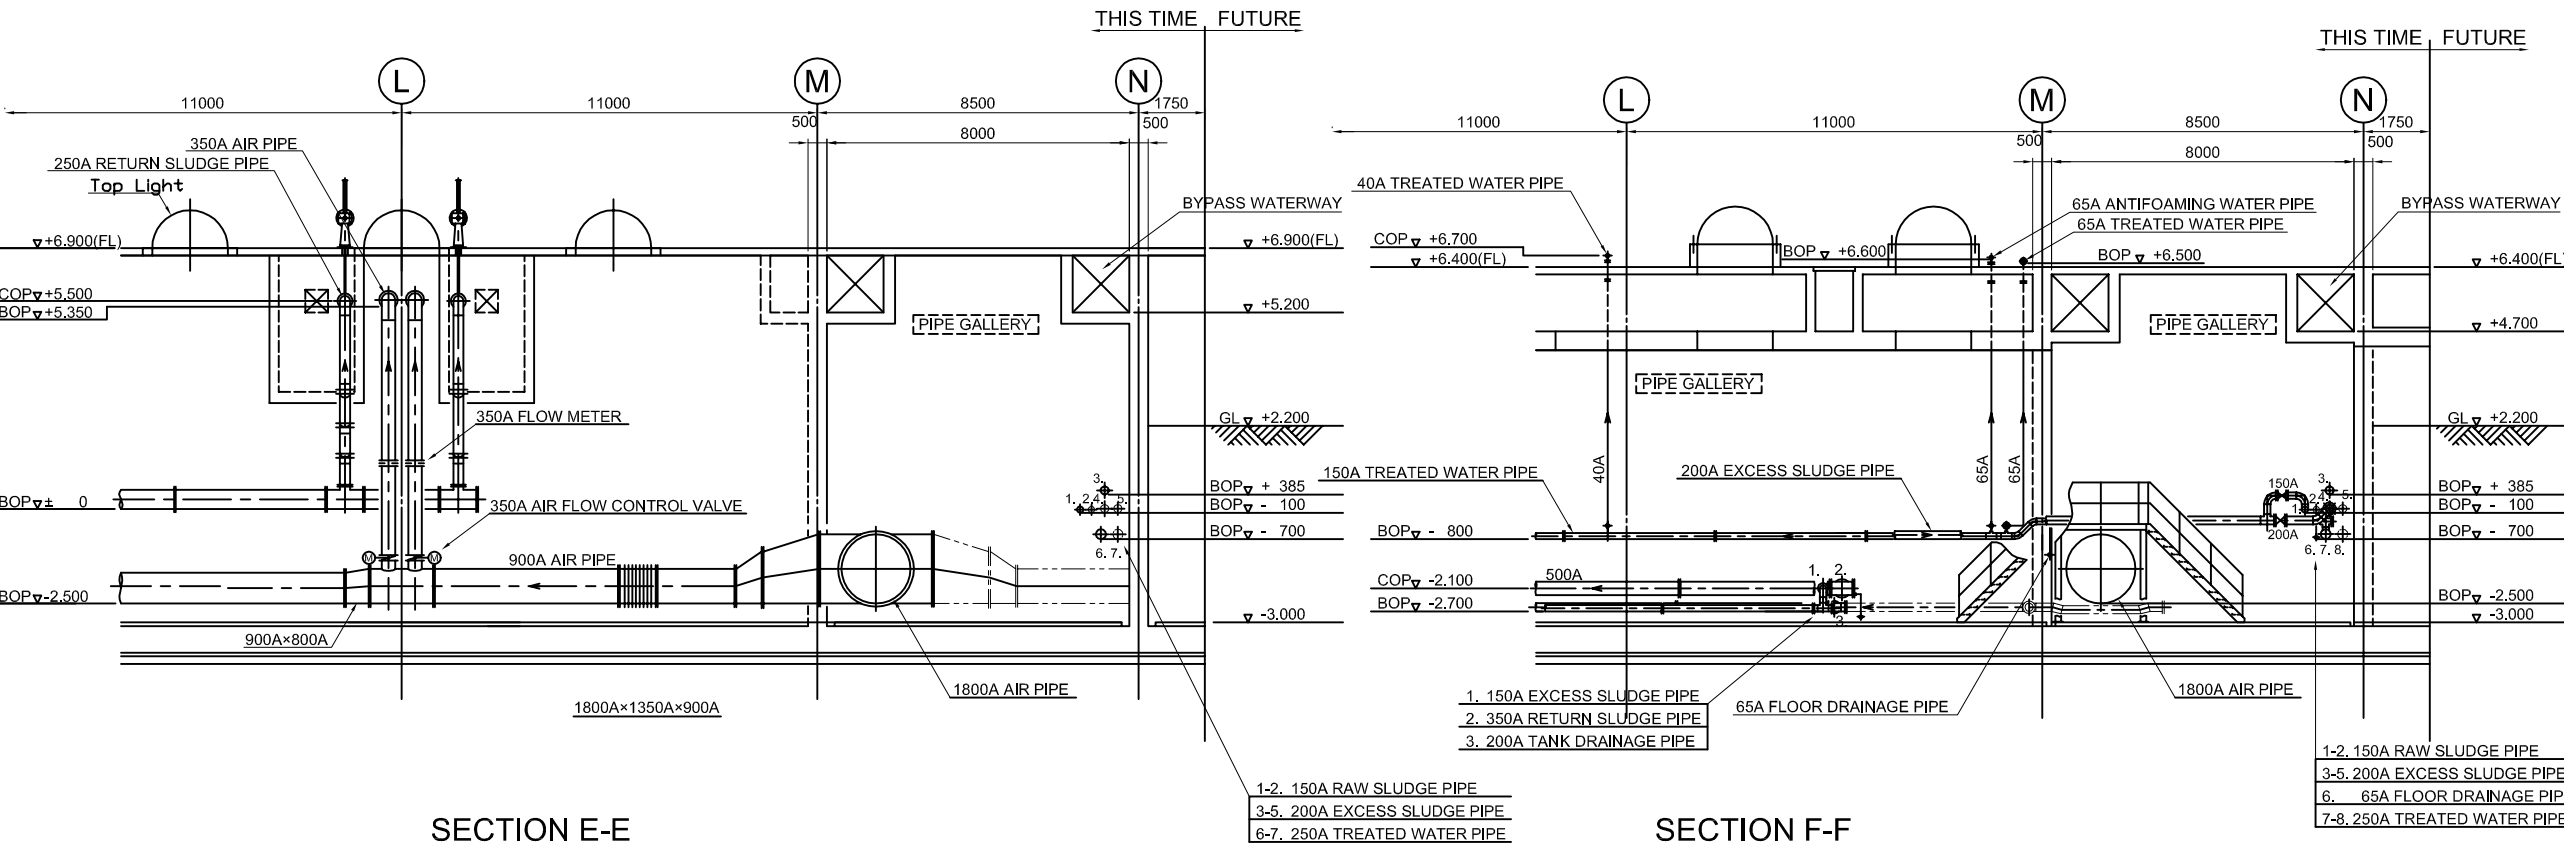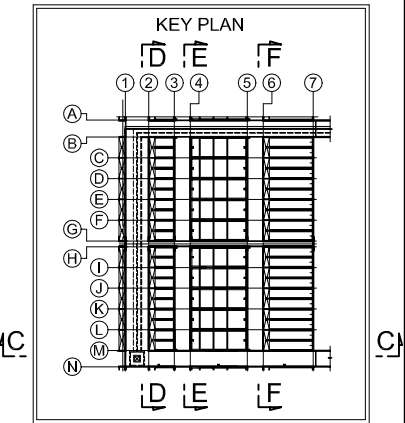


SECTION E-E

SECTION F-F


NO.	DATE	DESCRIPTIONS	BY	APRO.
REVISIONS				
PROJECT MANAGEMENT UNIT FOR WATER ENVIRONMENT IMPROVEMENT FOR HO CHI MINH CITY				
THE DETAILD DESIGN ON HO CHI MINH CITY WATER ENVIRONMENT IMPROVEMENT PROJECT IN THE SOCIALIST REPUBLIC OF VIET NAM				
PACKAGE E				
WASTEWATER TREATMENT PLANT				
WATER TREATMENT FACILITY CROSS SECTION (3 / 4)				
SCALE : 1:100				
JAPAN INTERNATIONAL COOPERATION AGENCY (JICA)				
PACIFIC CONSULTANTS INTERNATIONAL				
DESIGNED KAWAZU SHINYA		CHECKED KONDO MASAMI		
DATE : JUNE 2001		DWG. No. PE -WWTP - 443		

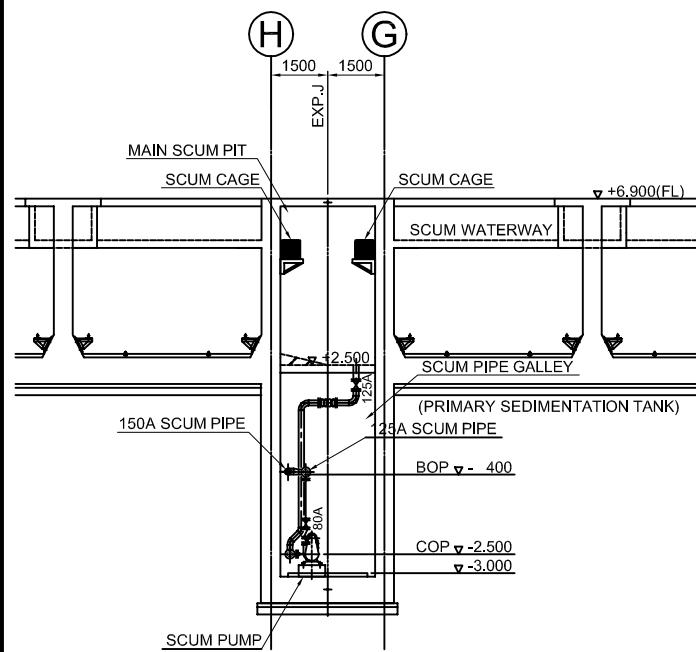



SECTION G-G

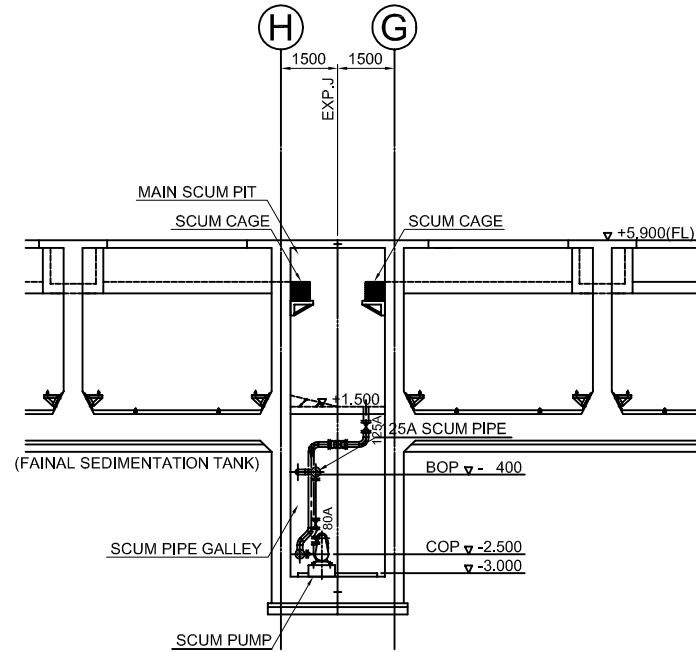


SECTION H-H

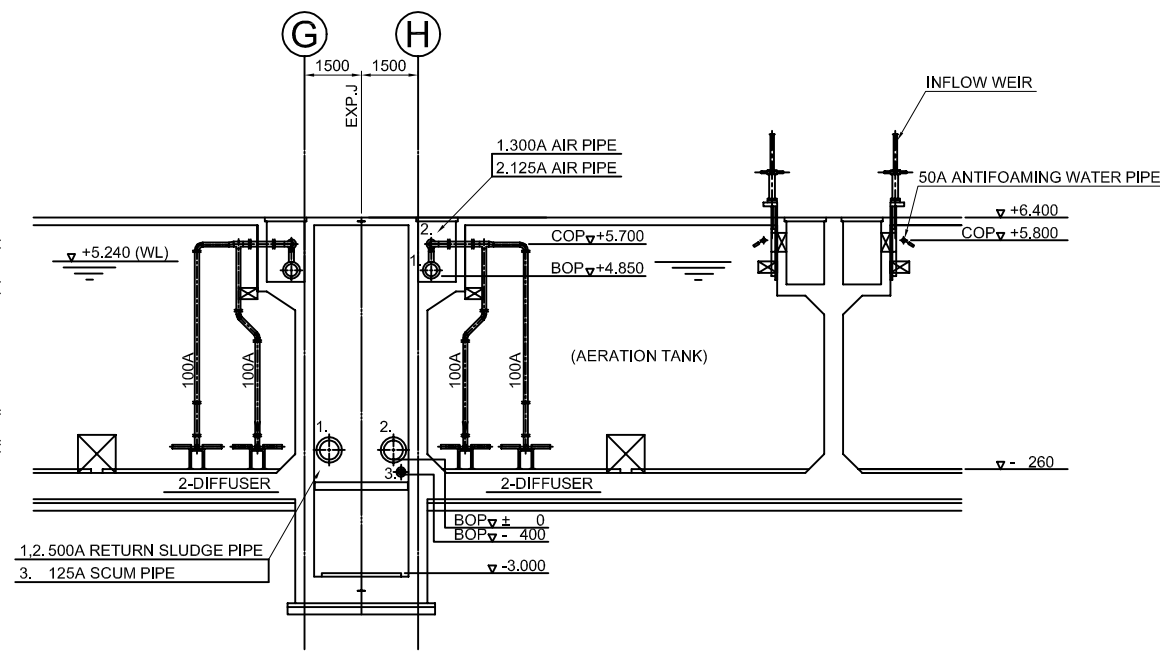

SECTION I-I

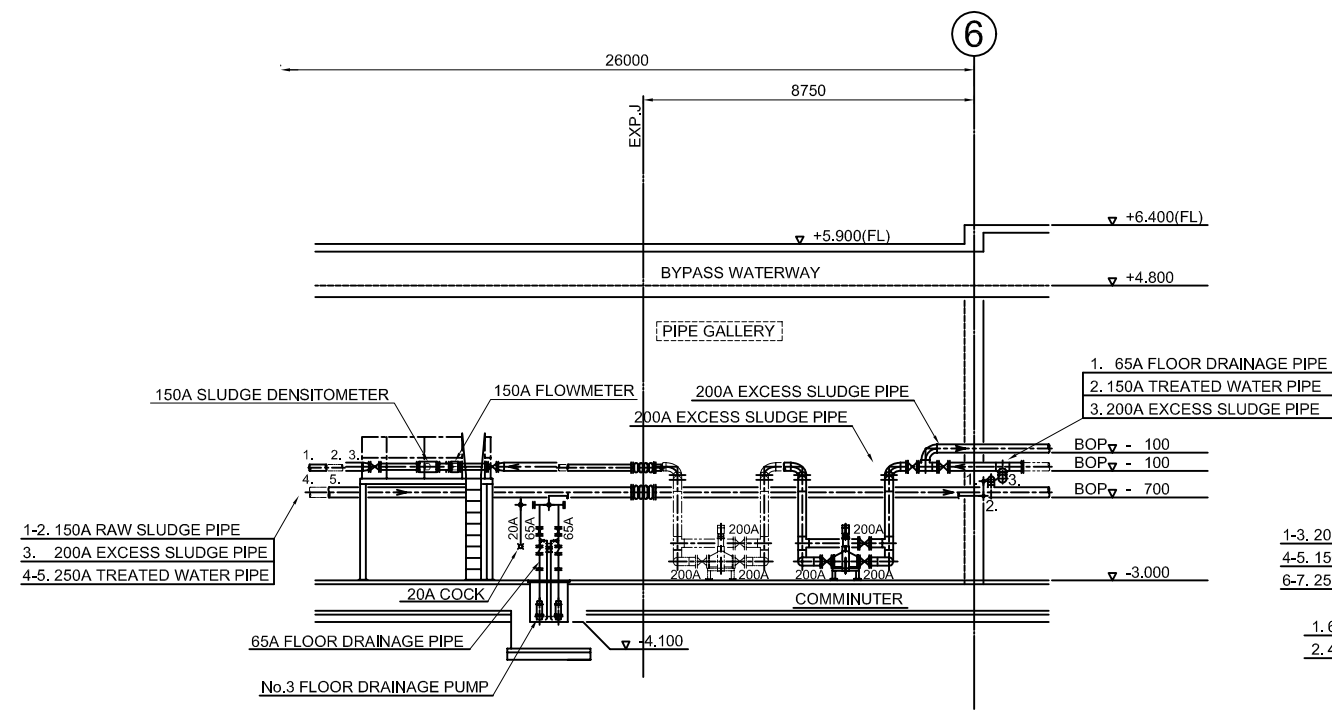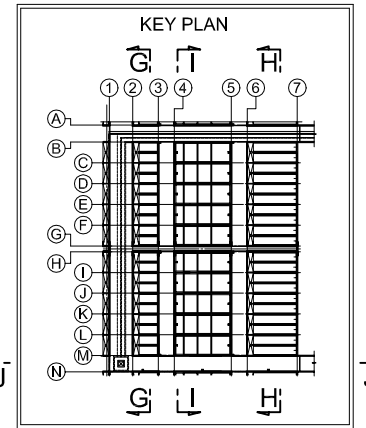


SECTION J-J

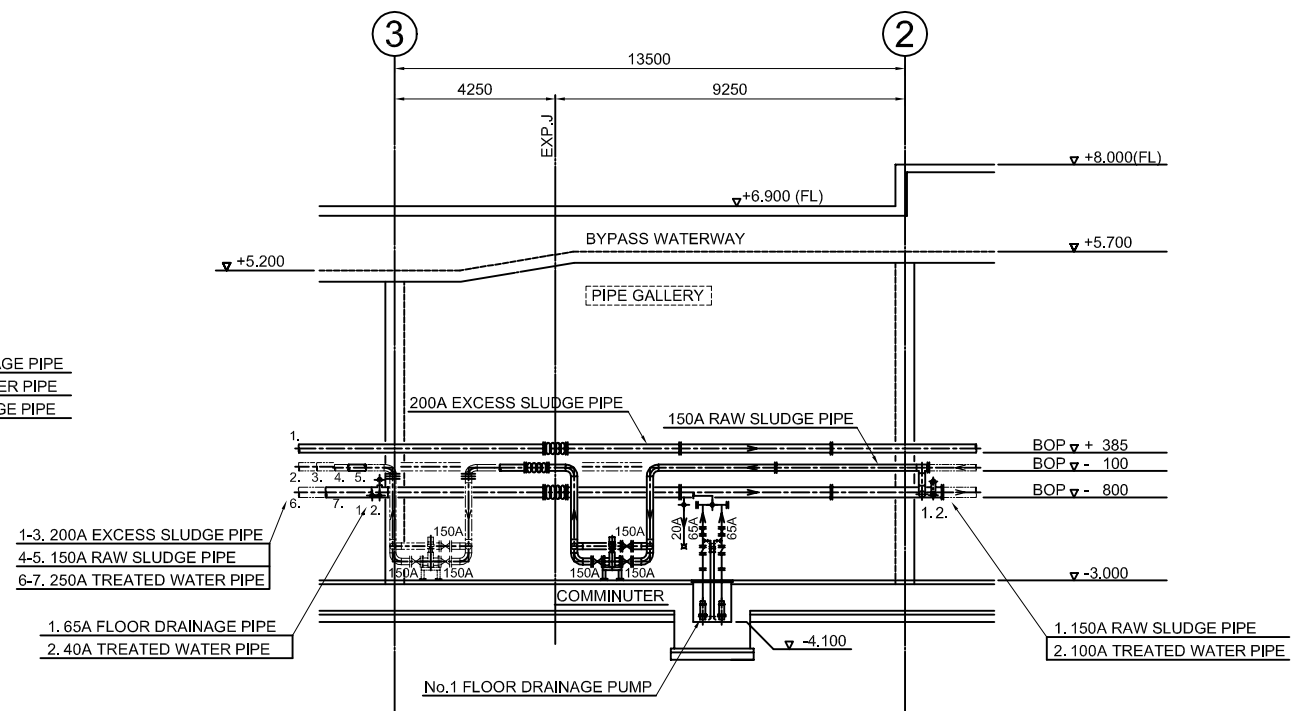

SECTION J-J

NO.	DATE	DESCRIPTIONS	BY	APRO.
REVISIONS				
PROJECT MANAGEMENT UNIT FOR WATER ENVIRONMENT IMPROVEMENT FOR HO CHI MINH CITY				
THE DETAILD DESIGN ON HO CHI MINH CITY WATER ENVIRONMENT IMPROVEMENT PROJECT IN THE SOCIALIST REPUBLIC OF VIET NAM				
PACKAGE E WASTEWATER TREATMENT PLANT WATER TREATMENT FACILITY CROSS SECTION(4 / 4)				
SCALE : 1:100				
JAPAN INTERNATIONAL COOPERATION AGENCY (JICA)				
PACIFIC CONSULTANTS INTERNATIONAL				
DESIGNED KAWAZU SHINYA		CHECKED KONDO MASAMI		
DATE : JUNE 2001		DWG. No. PE -WWTP - 444		

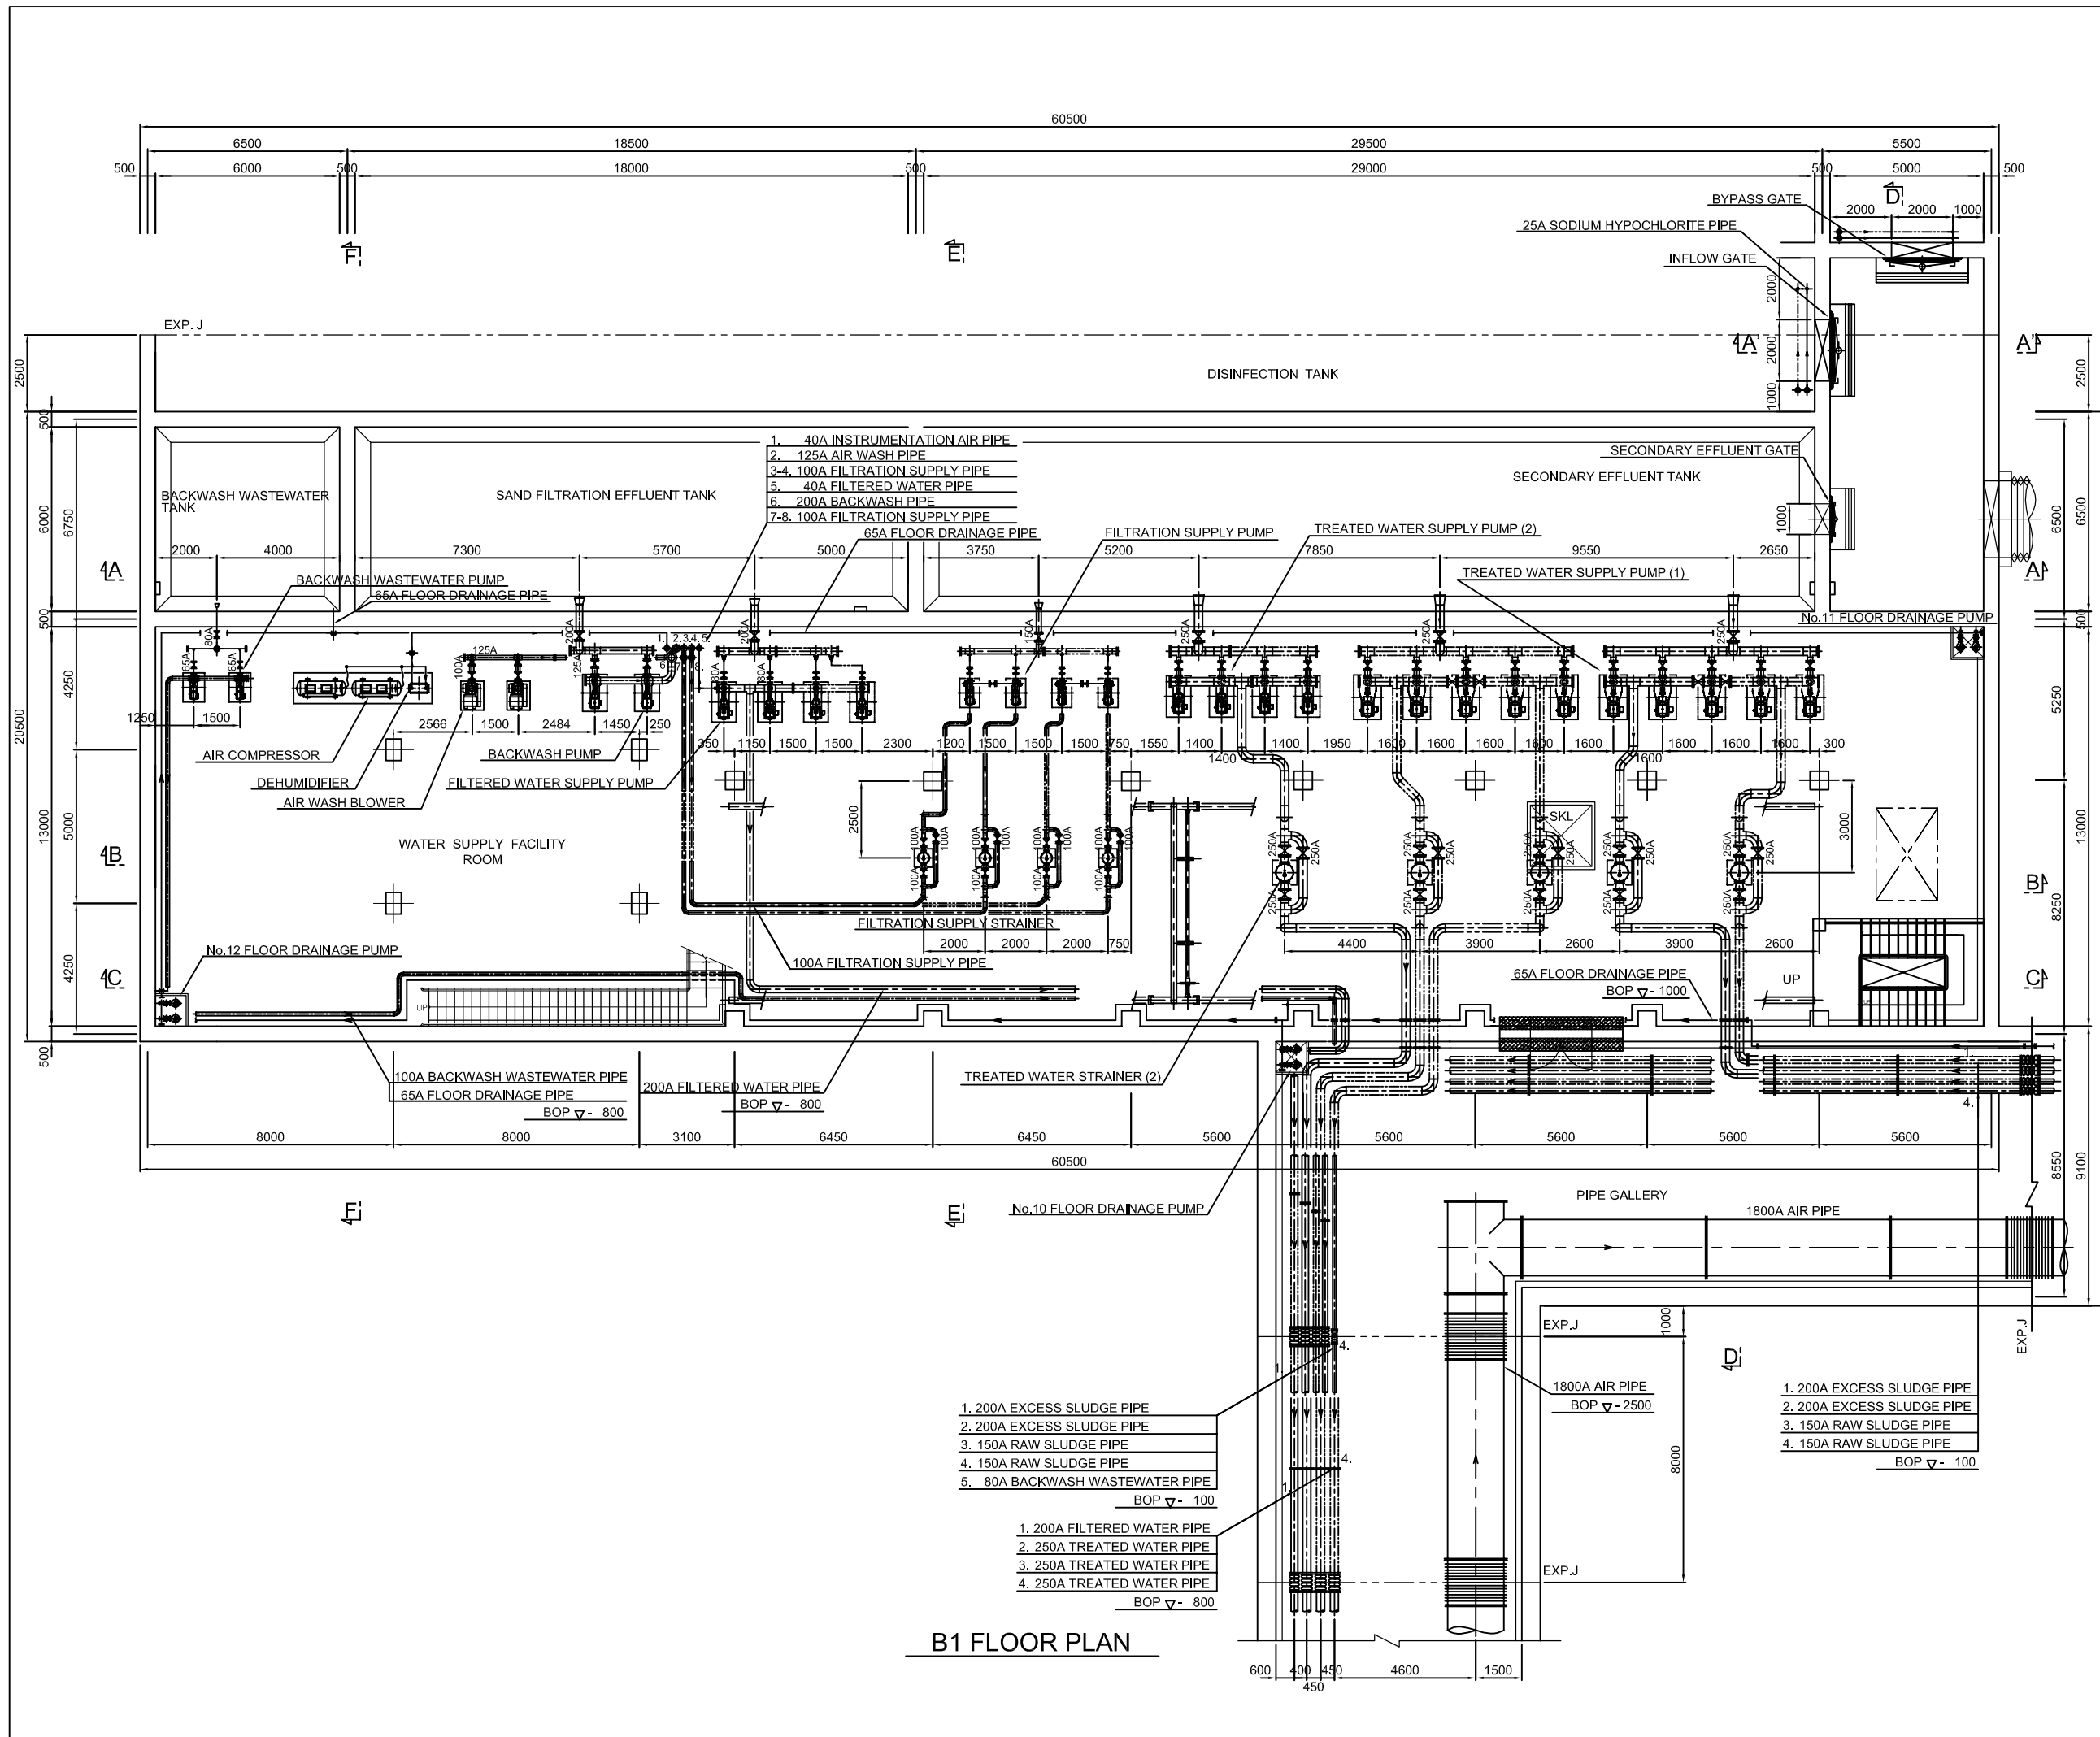

B1 FLOOR PLAN

NO.	DATE	DESCRIPTIONS	BY	APRO.

REVISIONS

PROJECT MANAGEMENT UNIT FOR
WATER ENVIRONMENT IMPROVEMENT FOR
HO CHI MINH CITY

THE DETAILD DESIGN ON HO CHI MINH CITY
WATER ENVIRONMENT IMPROVEMENT PROJECT
IN THE SOCIALIST REPUBLIC OF VIET NAM

PACKAGE E
WASTEWATER TREATMENT PLANT
**DISINFECTION-WATER SUPPLY
FACILITY PLAN (1 / 2)**


SCALE : 1:100

JAPAN INTERNATIONAL COOPERATION
AGENCY (JICA)

PACIFIC CONSULTANTS INTERNATIONAL

DESIGNED KAWAZU SHINYA	CHECKED KONDO MASAMI
---------------------------	-------------------------

DATE : JUNE 2001 DWG. No. PE - WWTP - 451

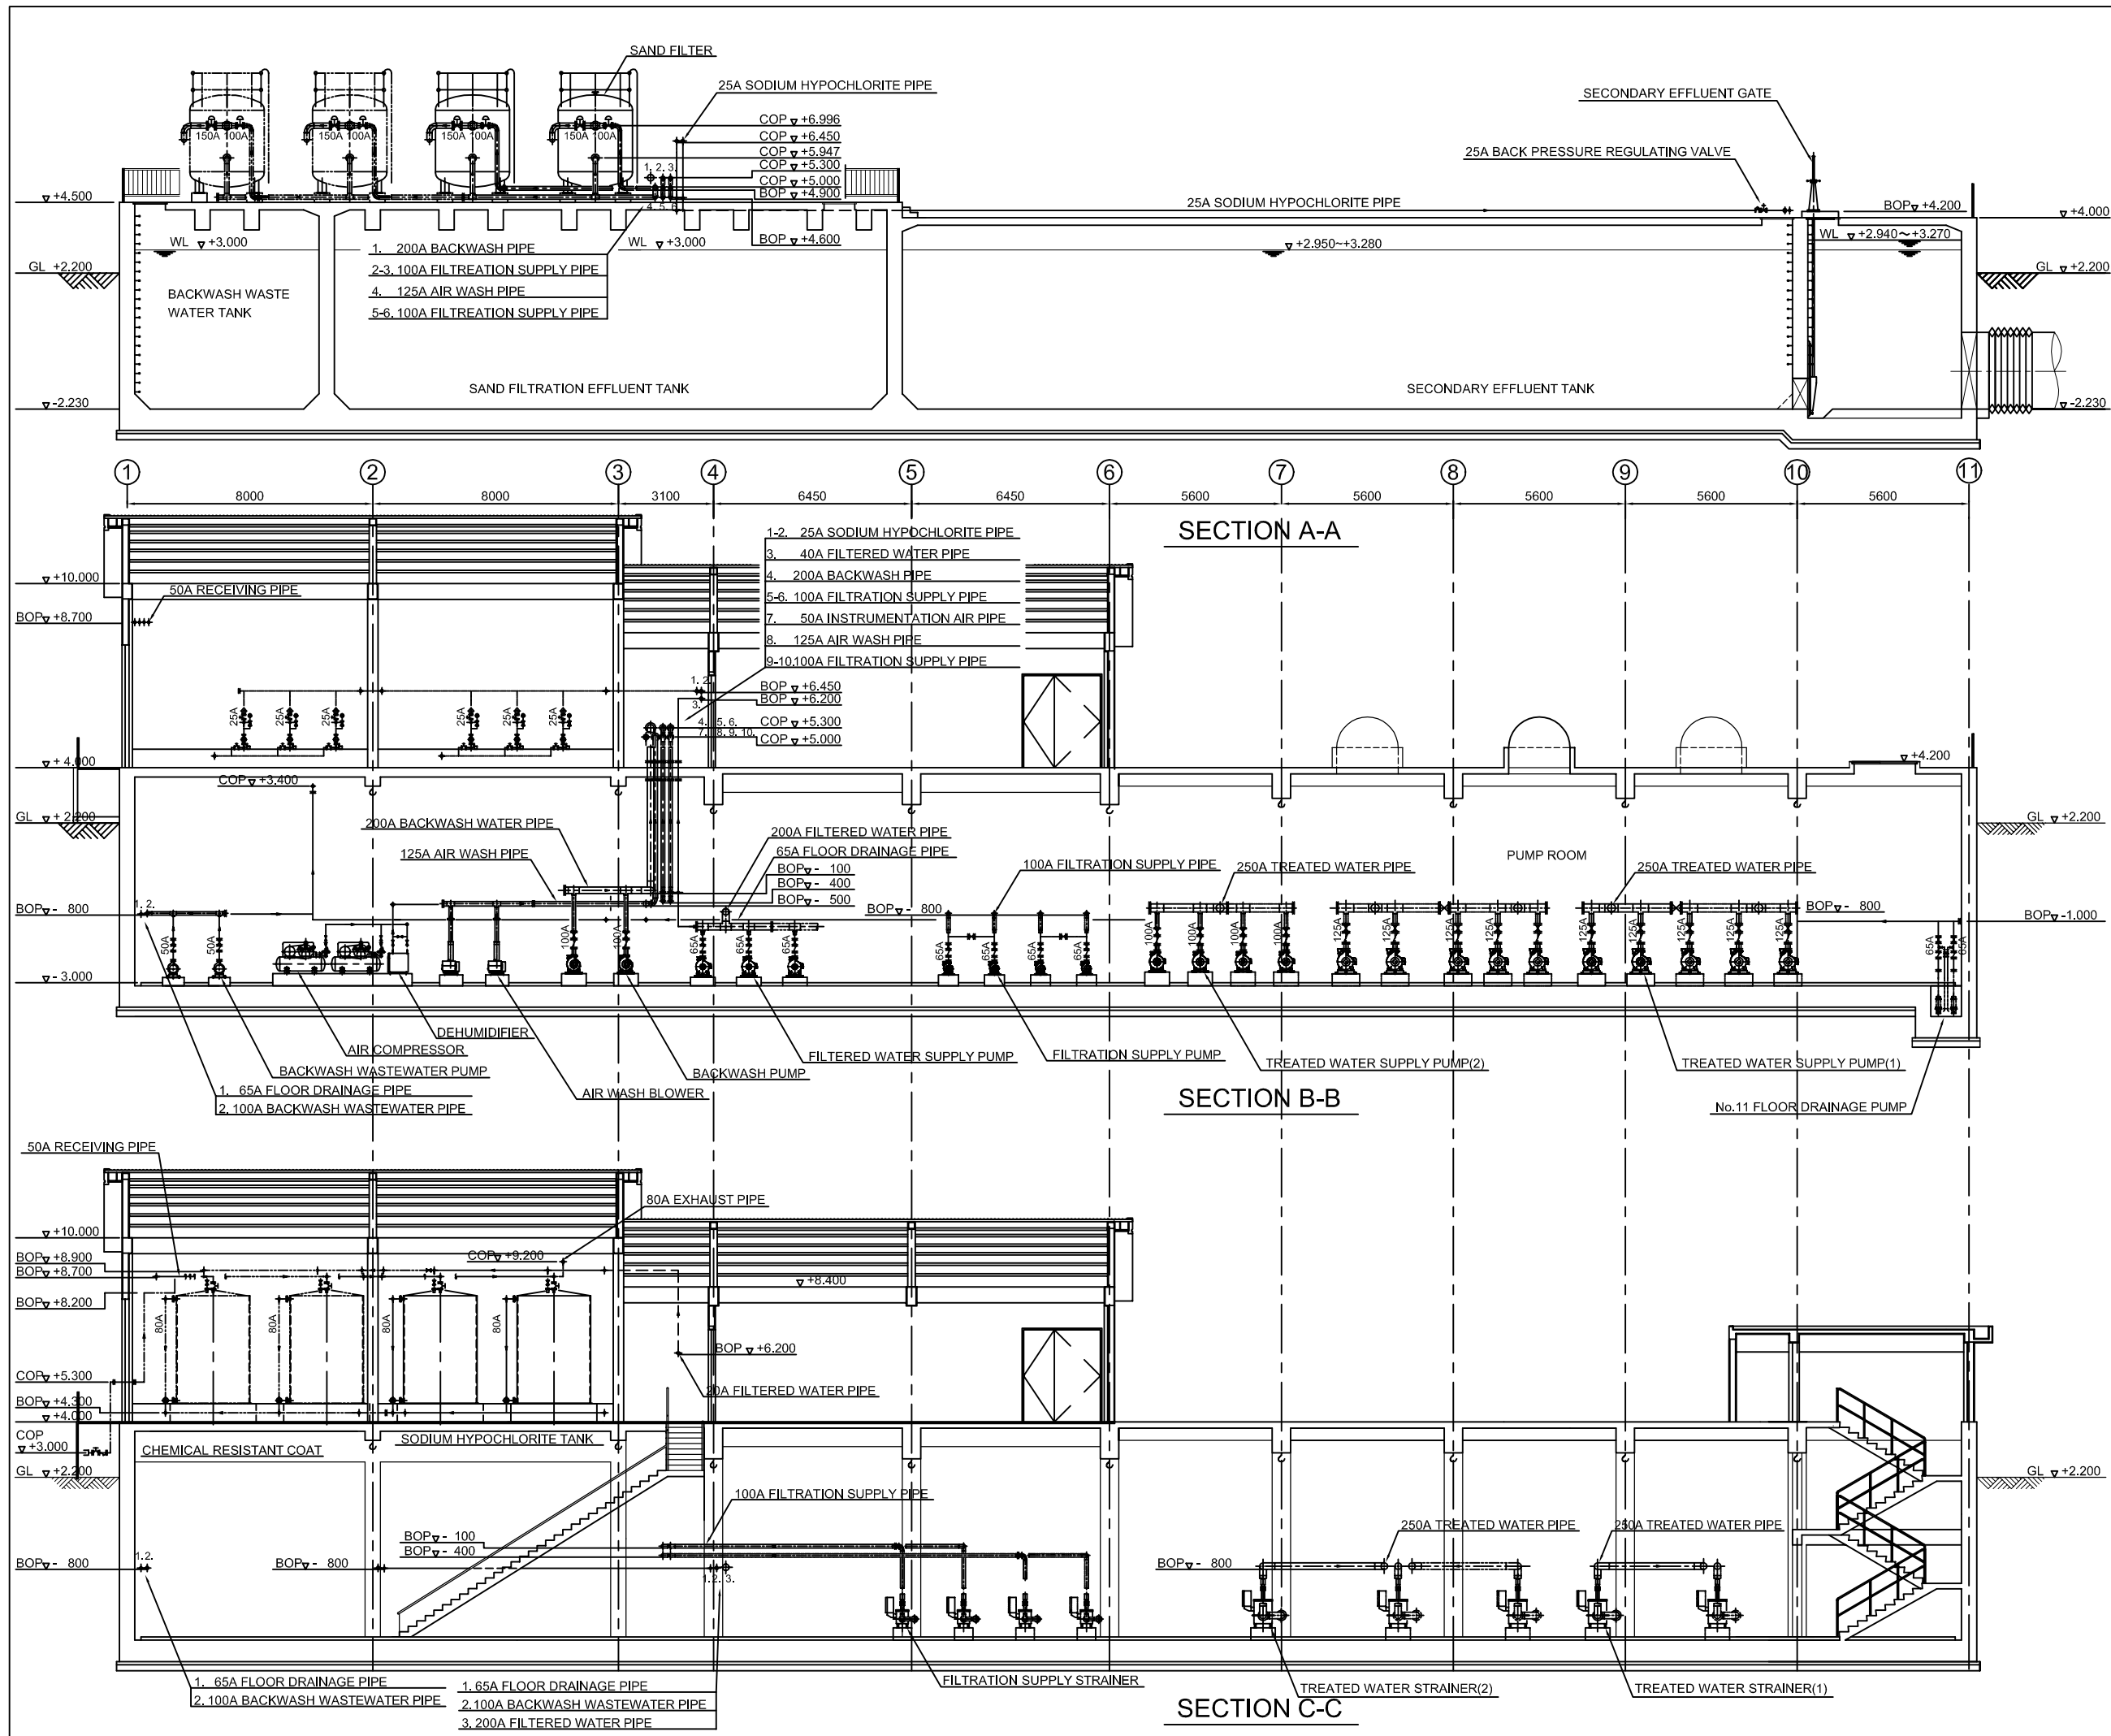

NO.	DATE	DESCRIPTIONS	BY	APRO.

REVISIONS

PROJECT MANAGEMENT UNIT FOR
WATER ENVIRONMENT IMPROVEMENT FOR
HO CHI MINH CITY

THE DETAILD DESIGN ON HO CHI MINH CITY
WATER ENVIRONMENT IMPROVEMENT PROJECT
IN THE SOCIALIST REPUBLIC OF VIET NAM

PACKAGE E
WASTEWATER TREATMENT PLANT
DISINFECTION-WATER SUPPLY
FACILITY CROSS SECTION (1 / 2)

SCALE : 1:100

JICA JAPAN INTERNATIONAL COOPERATION
AGENCY (JICA)

PACIFIC CONSULTANTS INTERNATIONAL

DESIGNED
KAWAZU SHINYA

CHECKED
KONDO MASAMI

DATE : JUNE 2001 DWG. No. PE - WWTP - 453