


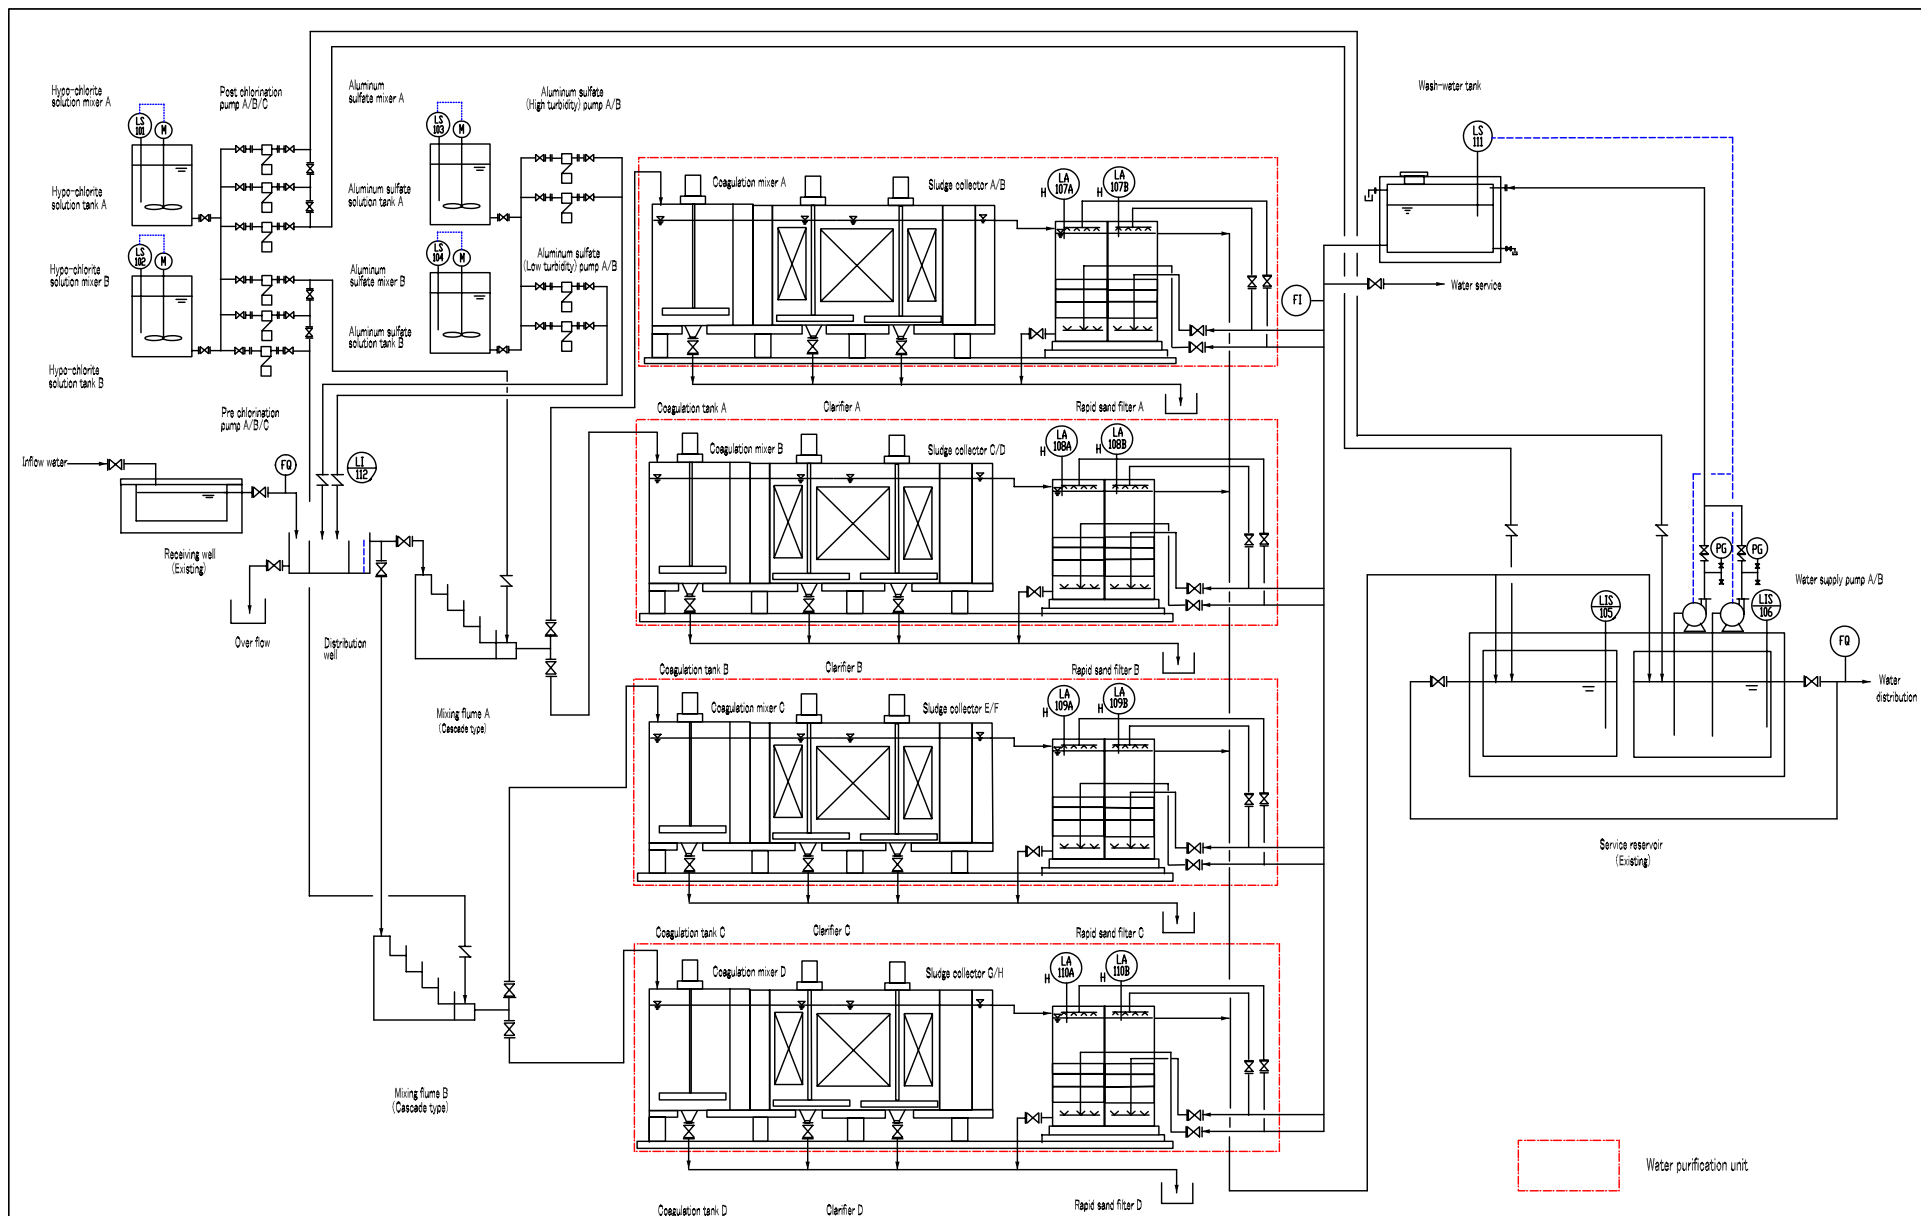

THE BASIC DESIGN STUDY ON THE PROJECT
FOR IMPROVEMENT OF WATER SUPPLY IN DILI AND DISTRICTS
IN THE DEMOCRATIC REPUBLIC OF TIMOR-LESTE

JICA JAPAN INTERNATIONAL COOPERATION AGENCY


DWG
No.

3


浄水場フローシート図

ディリ / ベモス浄水場

PLAN

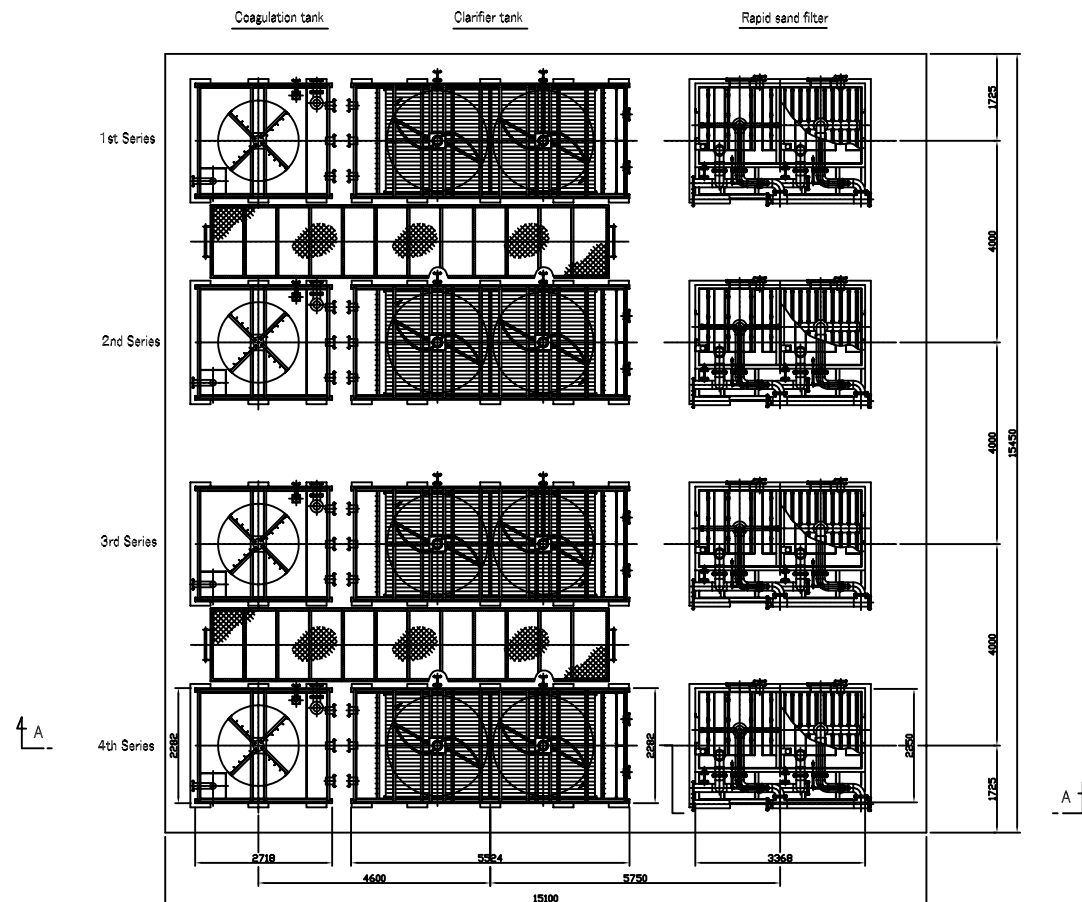

SECTION A-A

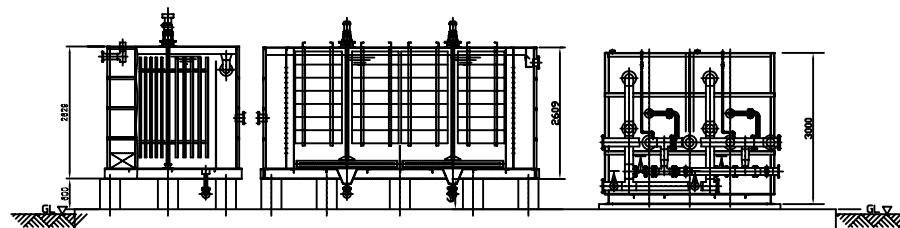

THE BASIC DESIGN STUDY ON THE PROJECT
FOR IMPROVEMENT OF WATER SUPPLY IN DILI AND DISTRICTS
IN THE DEMOCRATIC REPUBLIC OF TIMOR-LESTE



JICA JAPAN INTERNATIONAL COOPERATION AGENCY

DWG
No.

4

浄水処理装置図

ディリ / ペモス浄水場

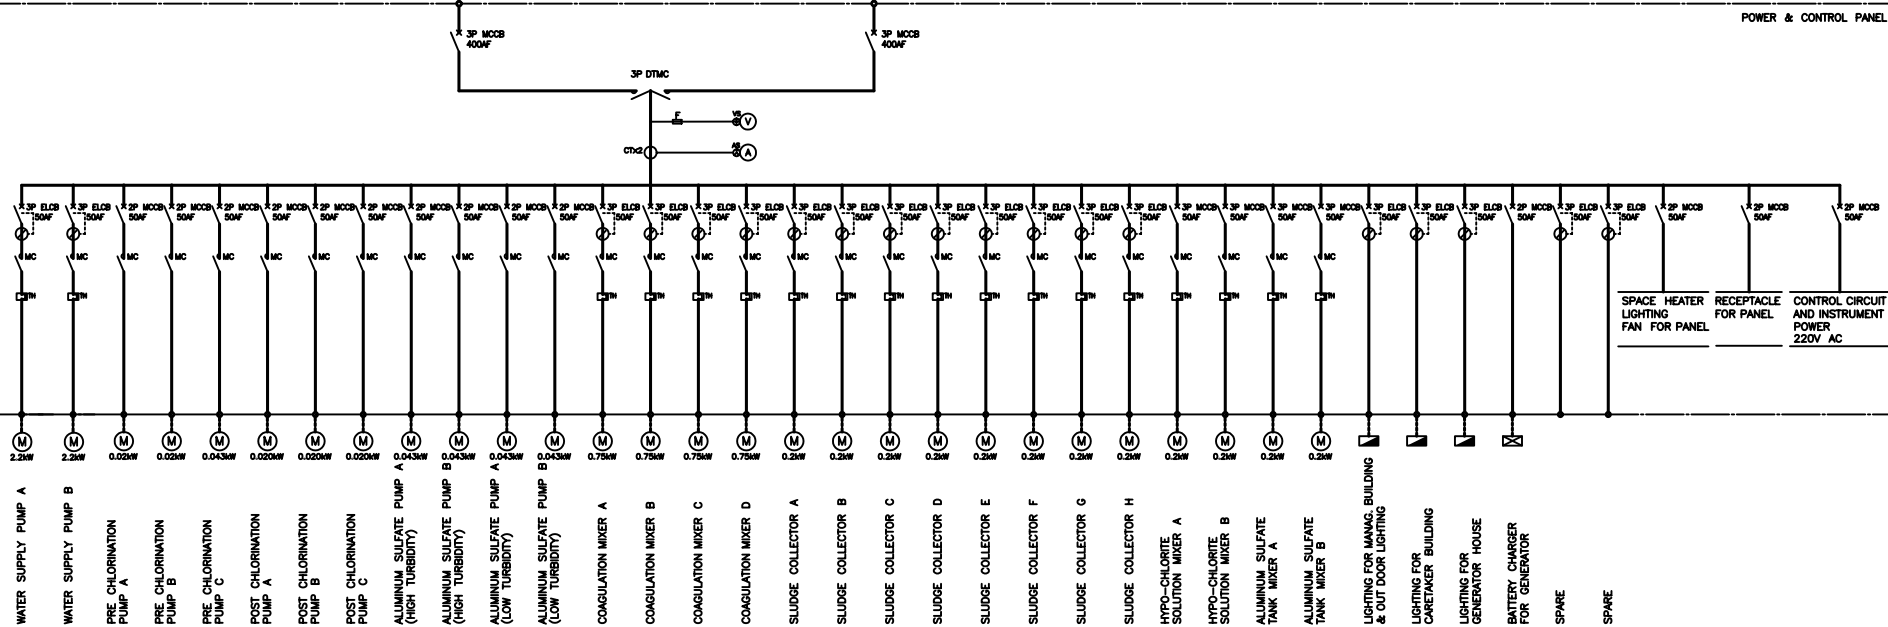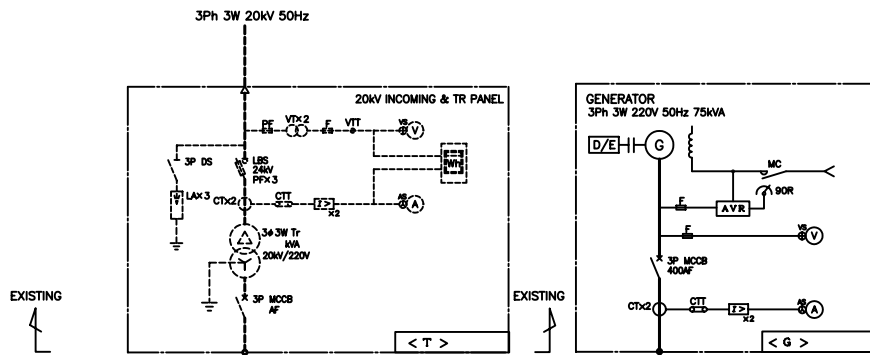

THE BASIC DESIGN STUDY ON THE PROJECT
FOR IMPROVEMENT OF WATER SUPPLY IN DILI AND DISTRICTS
IN THE DEMOCRATIC REPUBLIC OF TIMOR-LESTE




JICA JAPAN INTERNATIONAL COOPERATION AGENCY

DWG
No.

浄水場単線結線図

ディリ / ヘモ浄水場

5

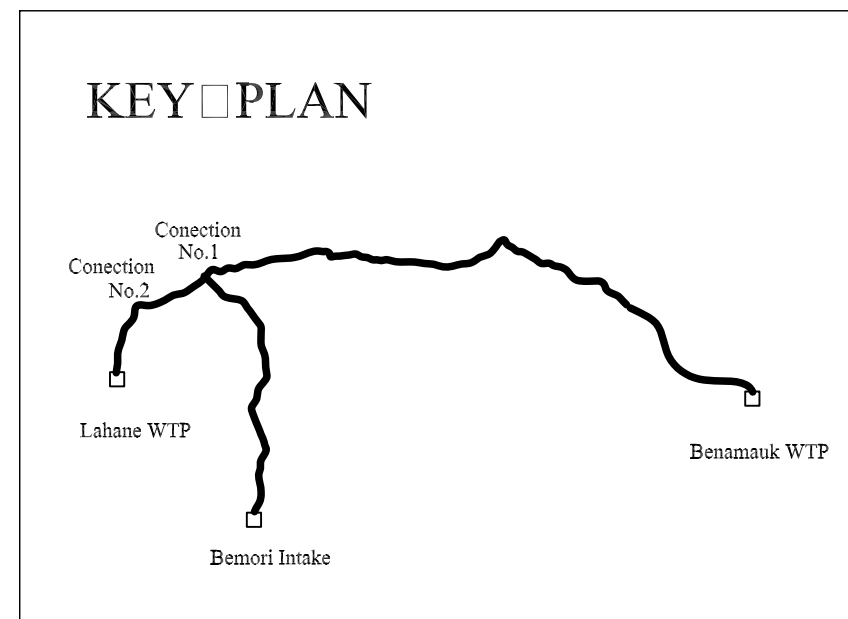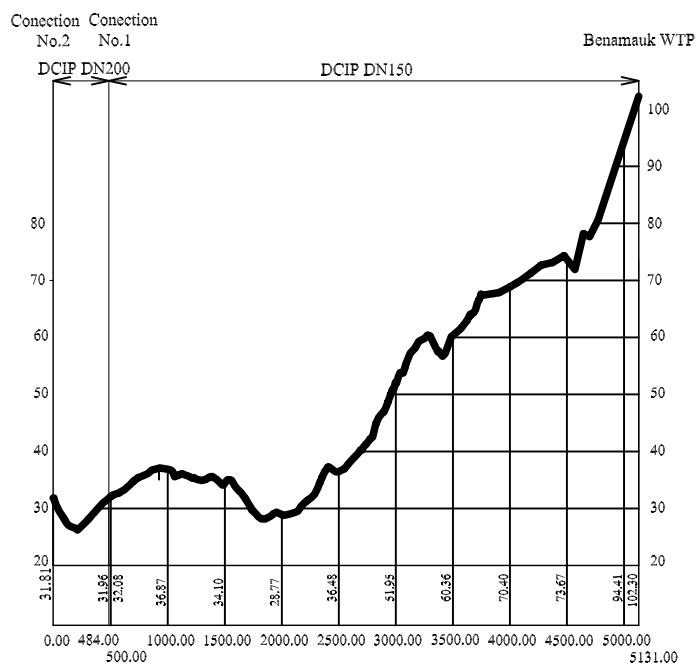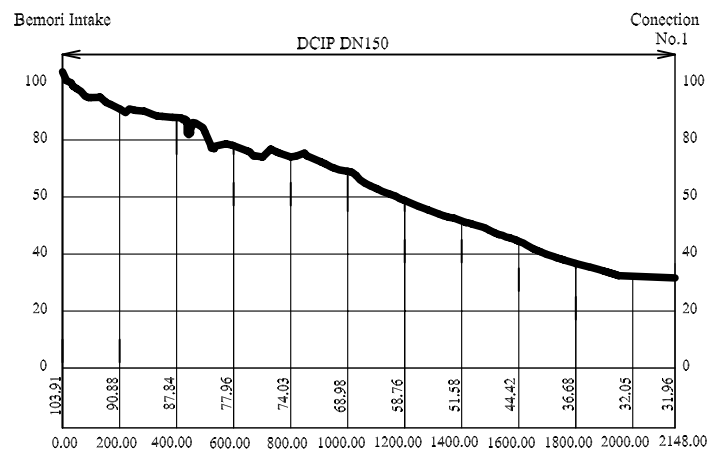



THE BASIC DESIGN STUDY ON THE PROJECT
FOR IMPROVEMENT OF WATER SUPPLY IN DILI AND DISTRICTS
IN THE DEMOCRATIC REPUBLIC OF TIMOR-LESTE

JICA JAPAN INTERNATIONAL COOPERATION AGENCY

DWG
No.

6

 導水管平面図
(取水場～浄水場)
ディリ / ラハネ

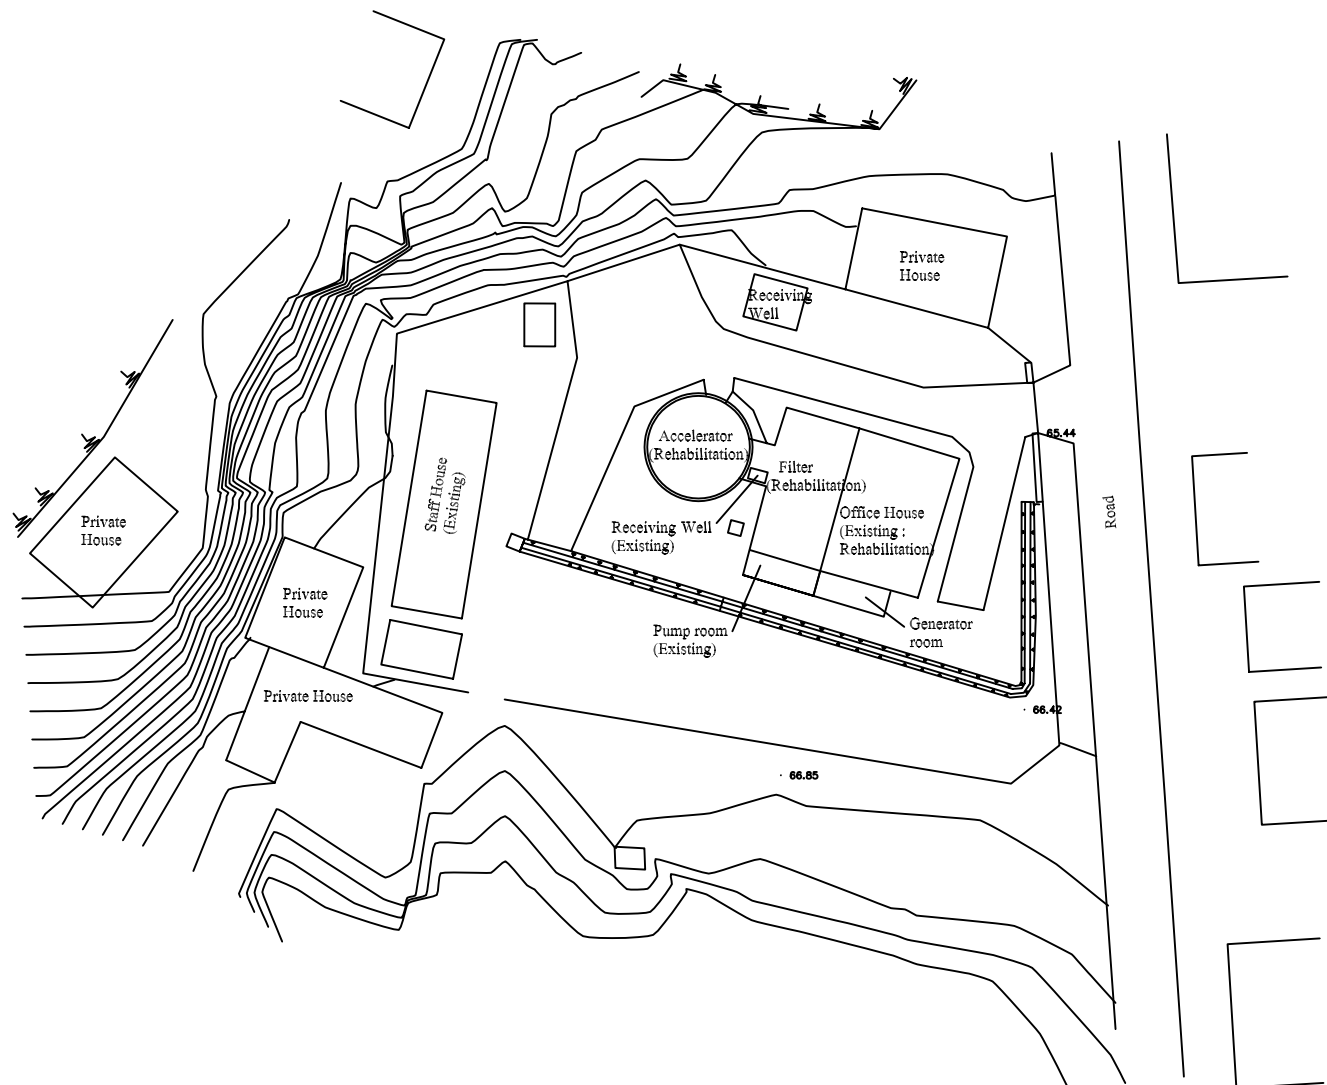

THE BASIC DESIGN STUDY ON THE PROJECT
FOR IMPROVEMENT OF WATER SUPPLY IN DILI AND DISTRICTS
IN THE DEMOCRATIC REPUBLIC OF TIMOR-LESTE


JICA JAPAN INTERNATIONAL COOPERATION AGENCY

DWG
No.

7

浄水場一般平面図

ディリ / ラハネ浄水場

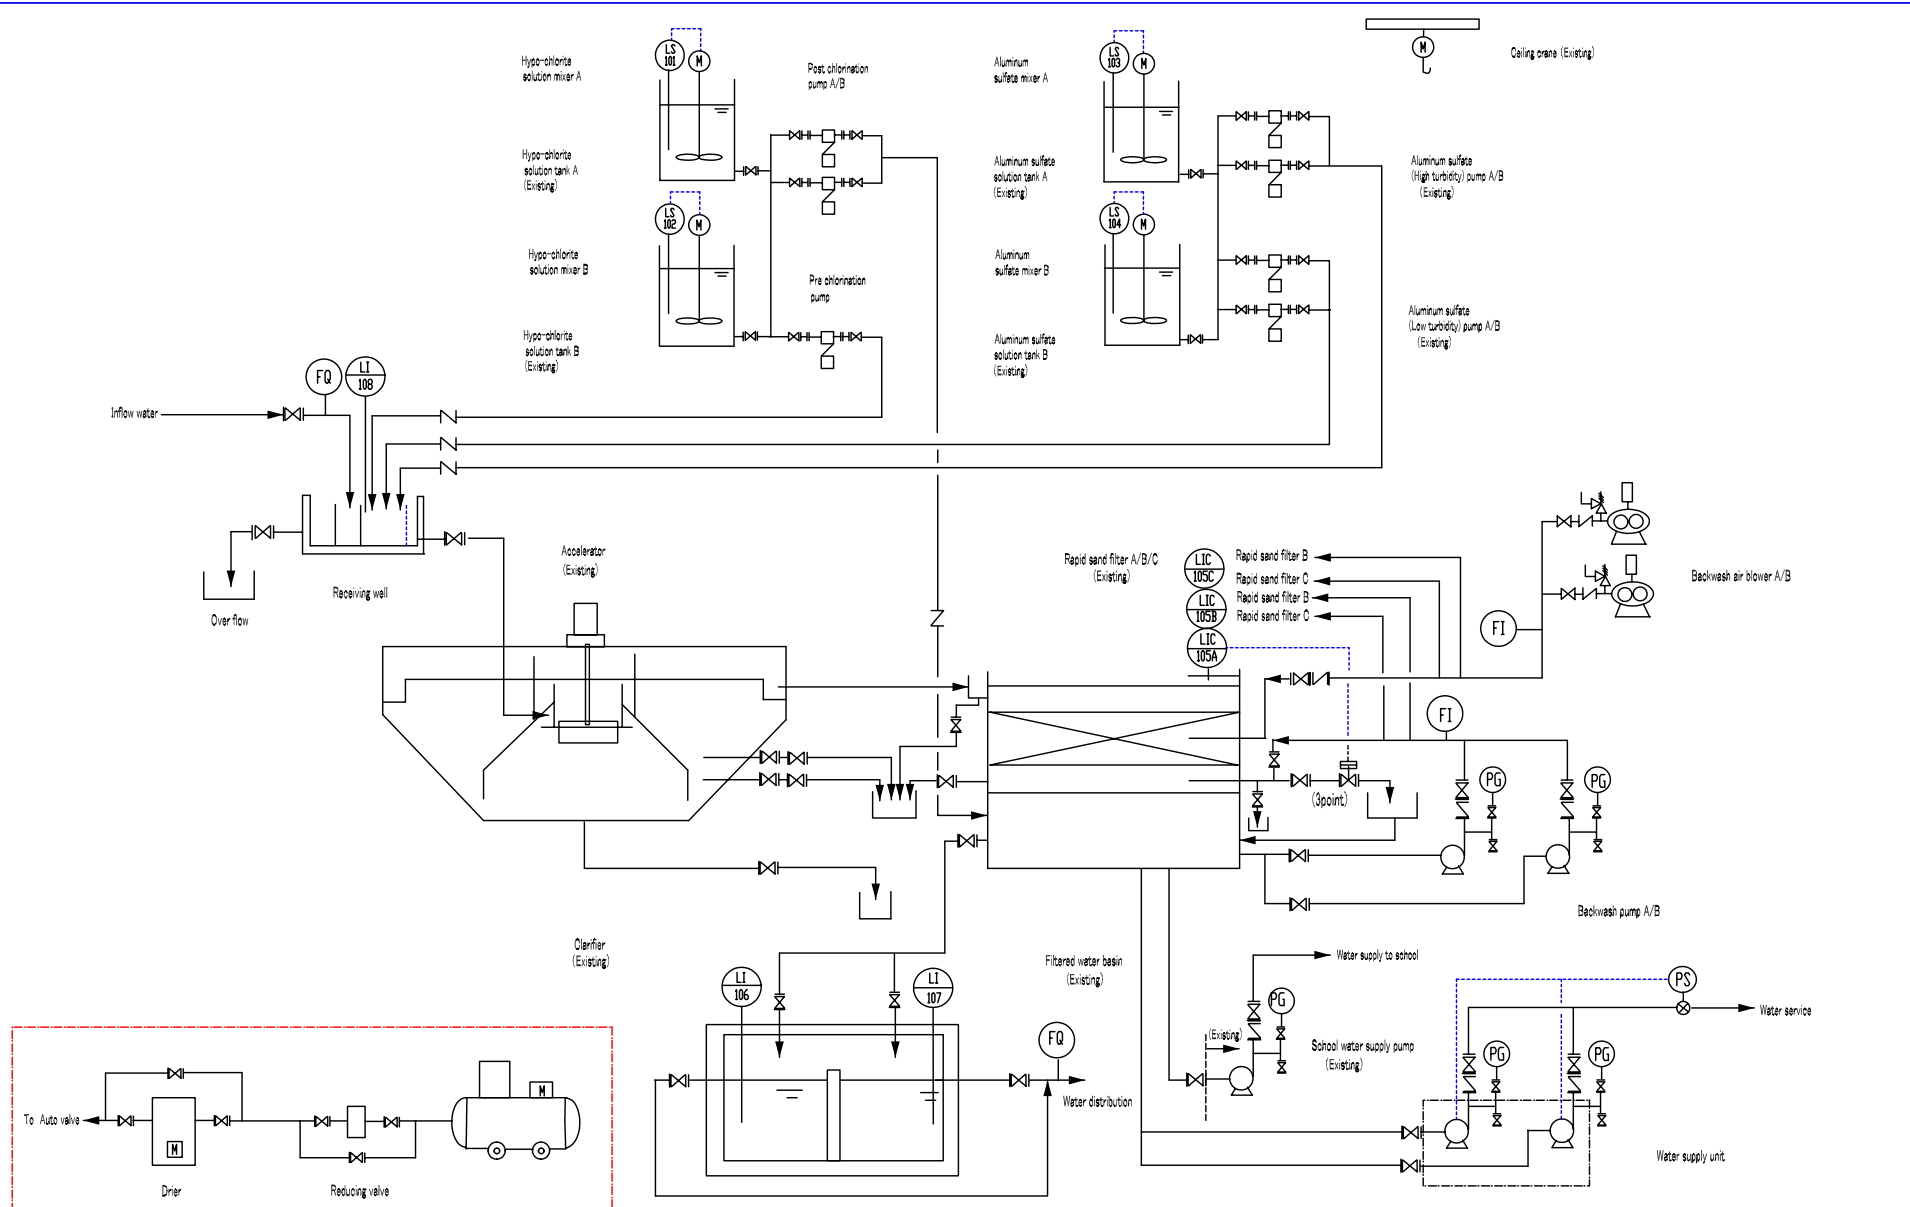

THE BASIC DESIGN STUDY ON THE PROJECT FOR IMPROVEMENT OF WATER SUPPLY IN DILI AND DISTRICTS IN THE DEMOCRATIC REPUBLIC OF TIMOR-LESTE JICA JAPAN INTERNATIONAL COOPERATION AGENCY	DWG No.	浄水場フローシート図
	8	デシリ / ラハネ浄水場