


KEY PLAN

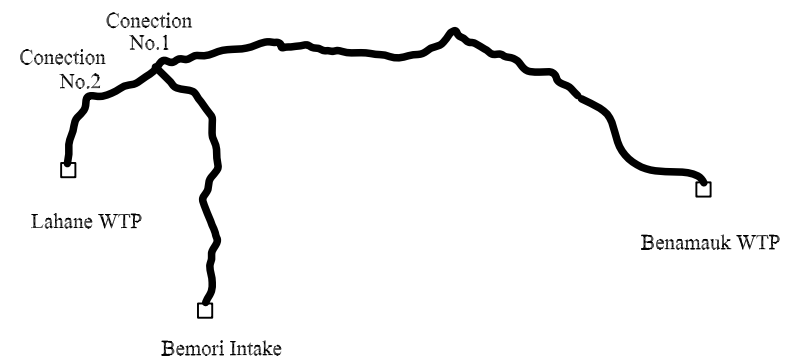

 

THE BASIC DESIGN STUDY ON THE PROJECT
FOR IMPROVEMENT OF WATER SUPPLY IN DILI AND DISTRICTS
IN THE DEMOCRATIC REPUBLIC OF TIMOR-LESTE

JICA JAPAN INTERNATIONAL COOPERATION AGENCY

DWG
No.

6

Raw water main
plan and profile
Lahane WTP / Dili

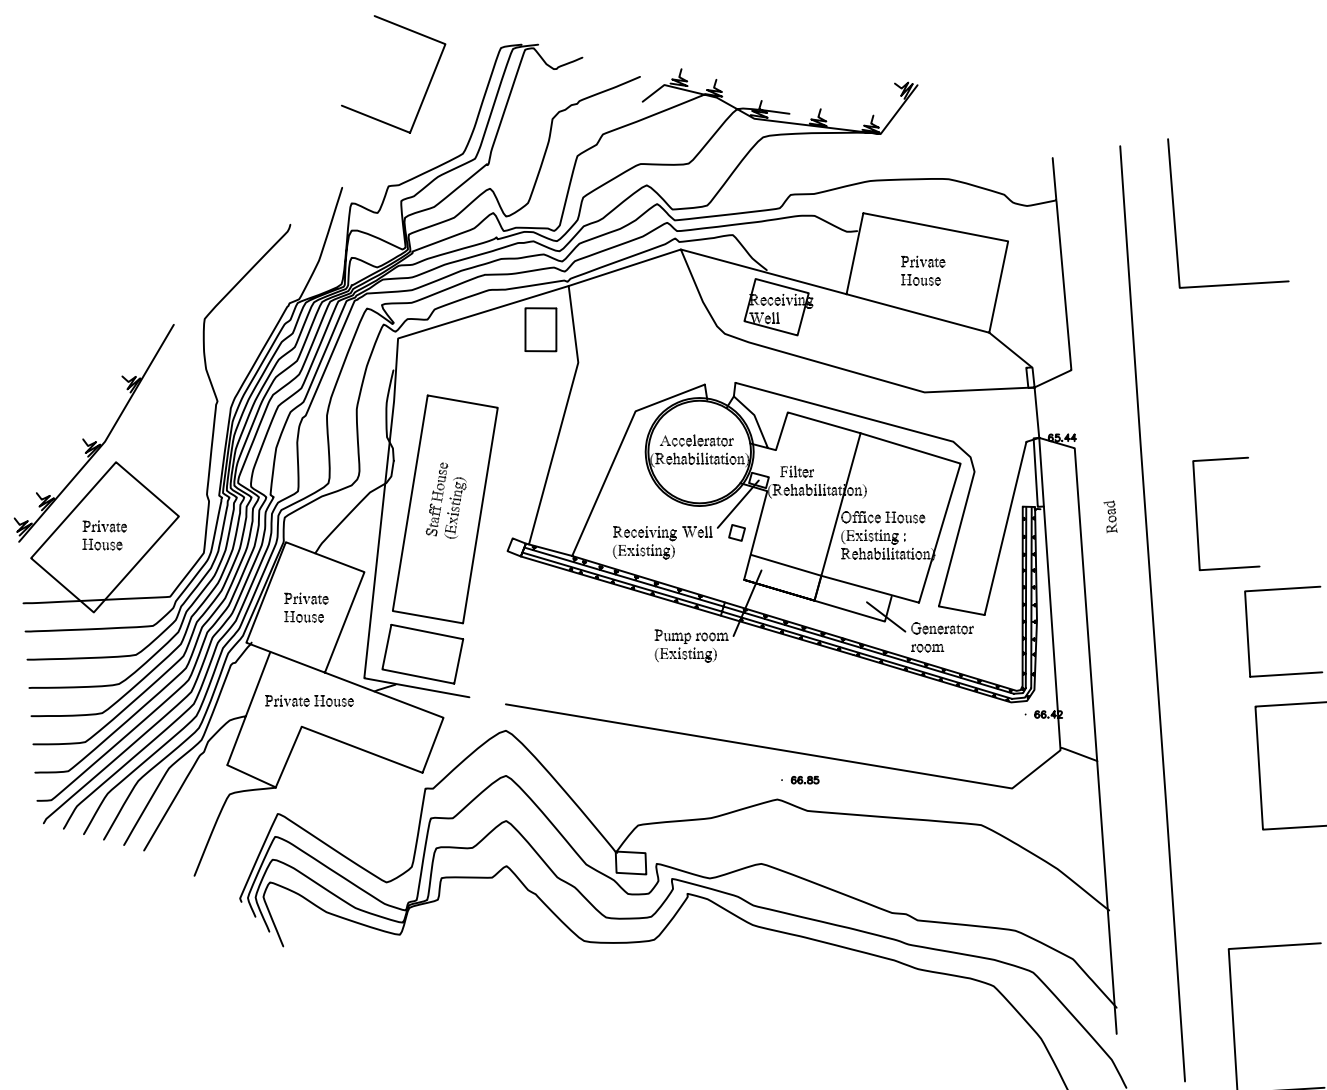


THE BASIC DESIGN STUDY ON THE PROJECT
FOR IMPROVEMENT OF WATER SUPPLY IN DILI AND DISTRICTS
IN THE DEMOCRATIC REPUBLIC OF TIMOR-LESTE


JICA JAPAN INTERNATIONAL COOPERATION AGENCY

DWG
No.

7

Water treatment plant
general plan
/ Lahane WTP / Dili

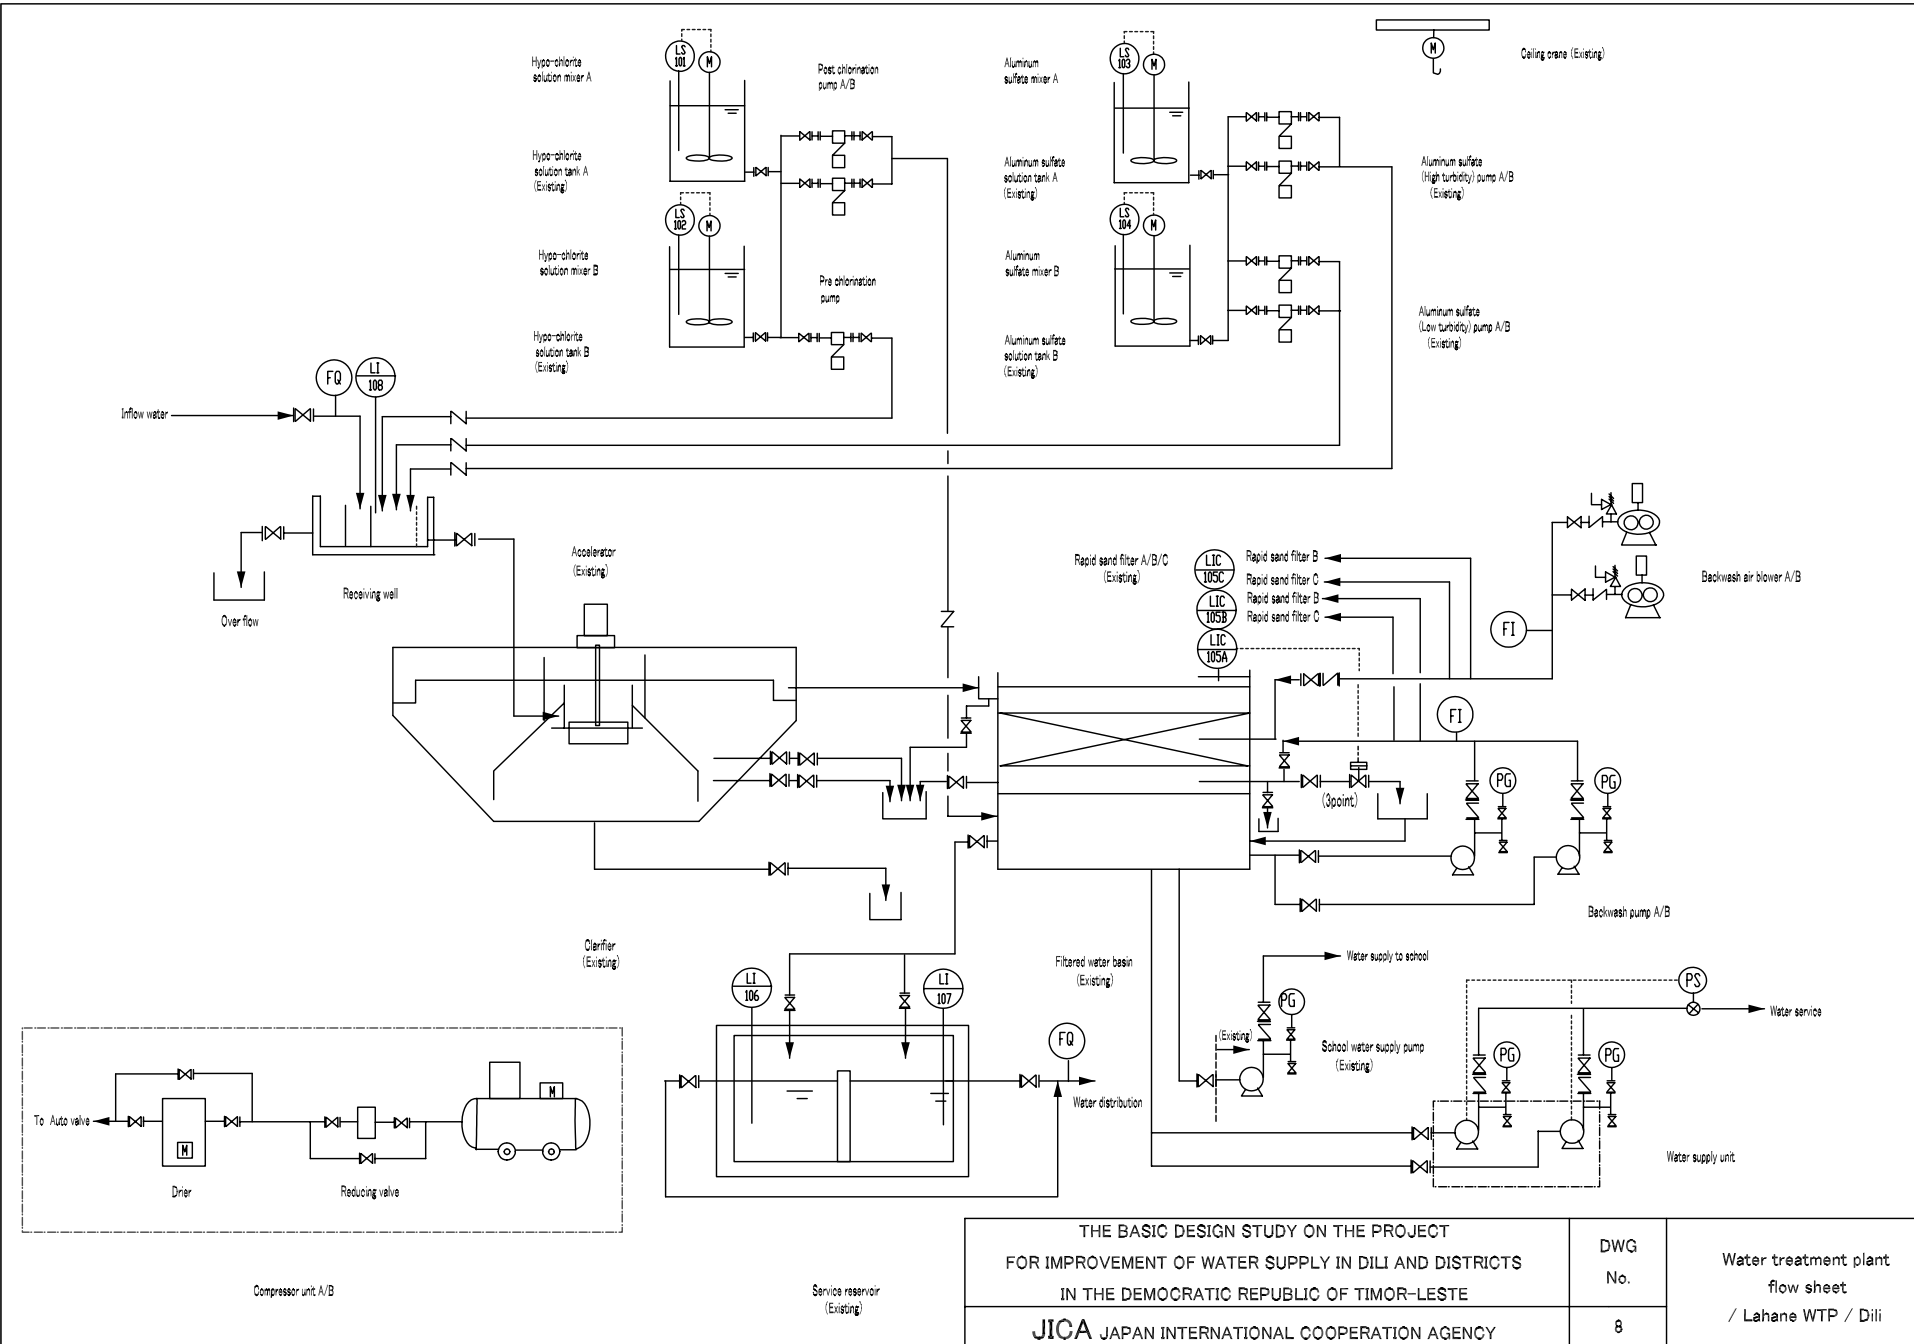

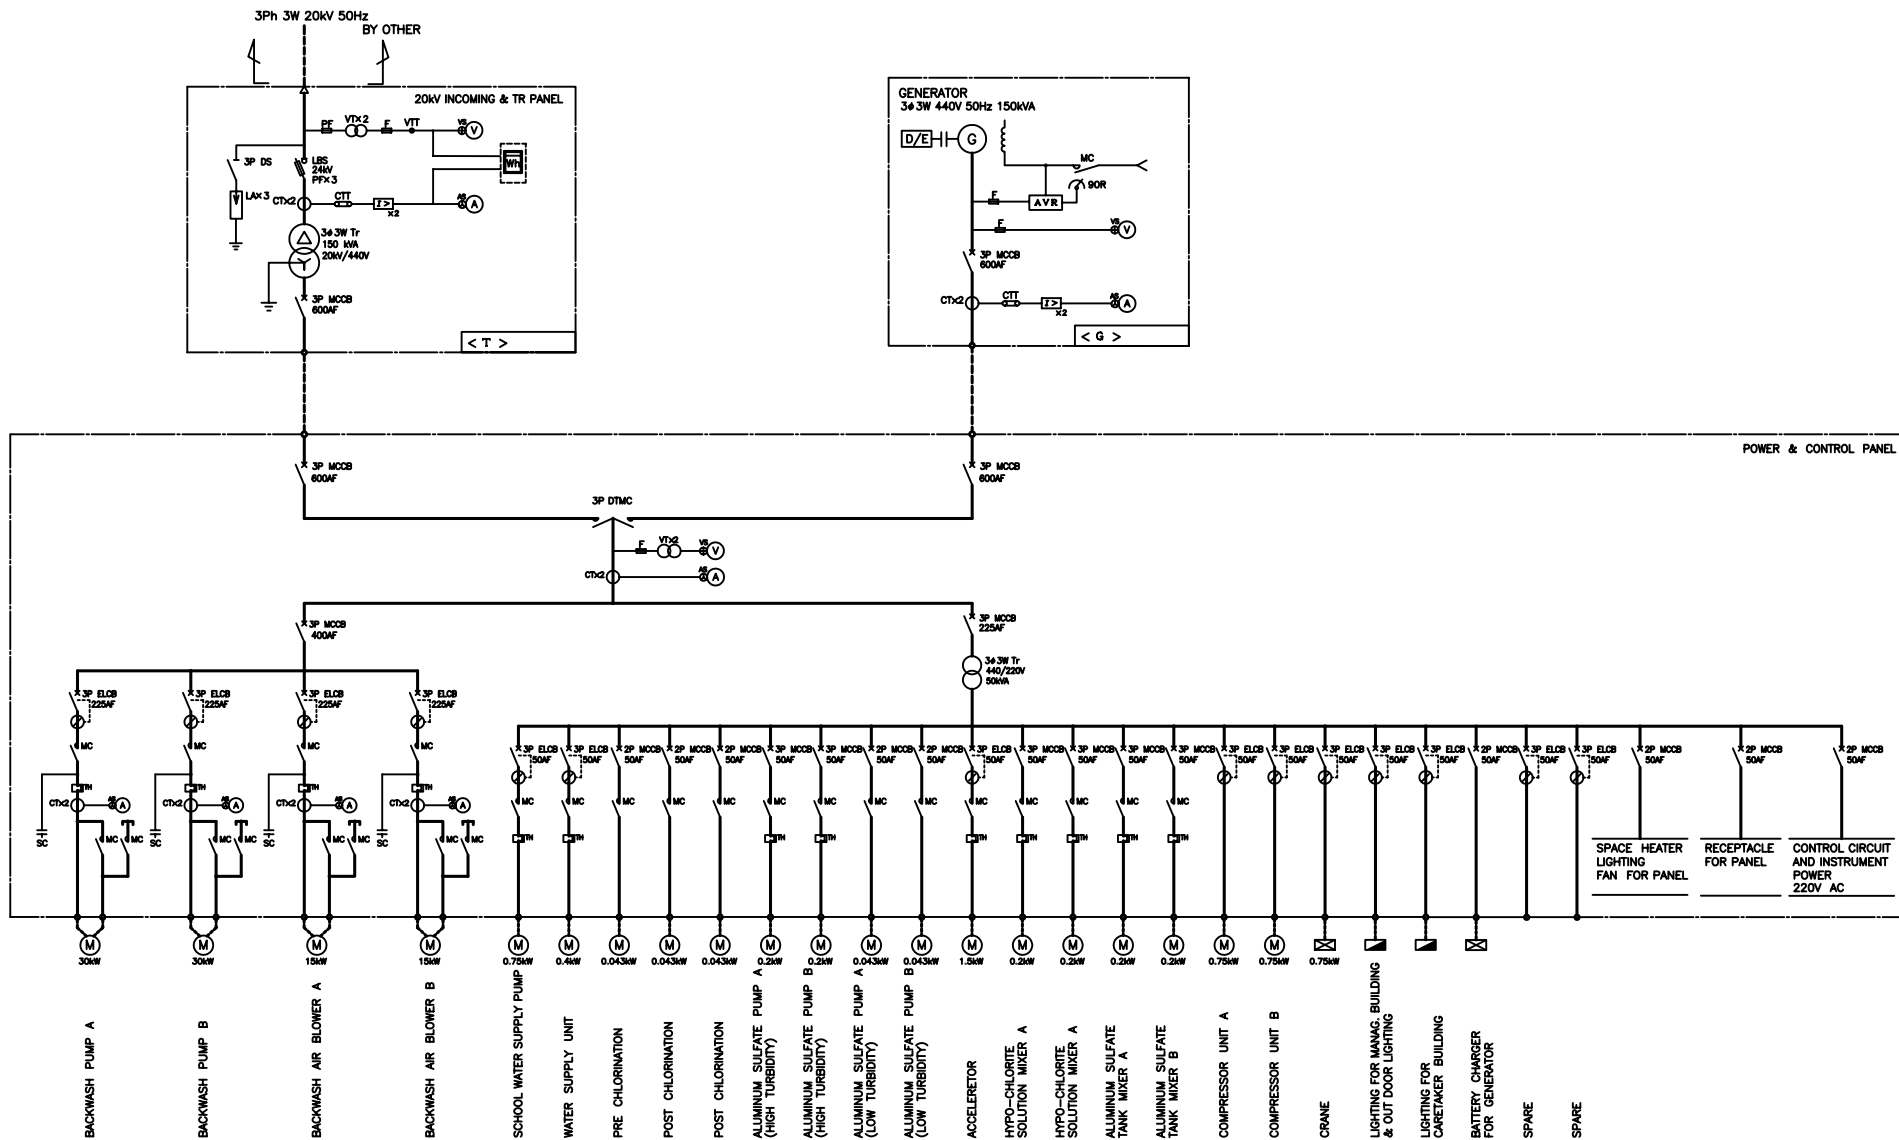

THE BASIC DESIGN STUDY ON THE PROJECT
FOR IMPROVEMENT OF WATER SUPPLY IN DILI AND DISTRICTS
IN THE DEMOCRATIC REPUBLIC OF TIMOR-LESTE

 

JICA JAPAN INTERNATIONAL COOPERATION AGENCY

DWG
No.

9

Single line diagram

/ Lahane WTP / Dili

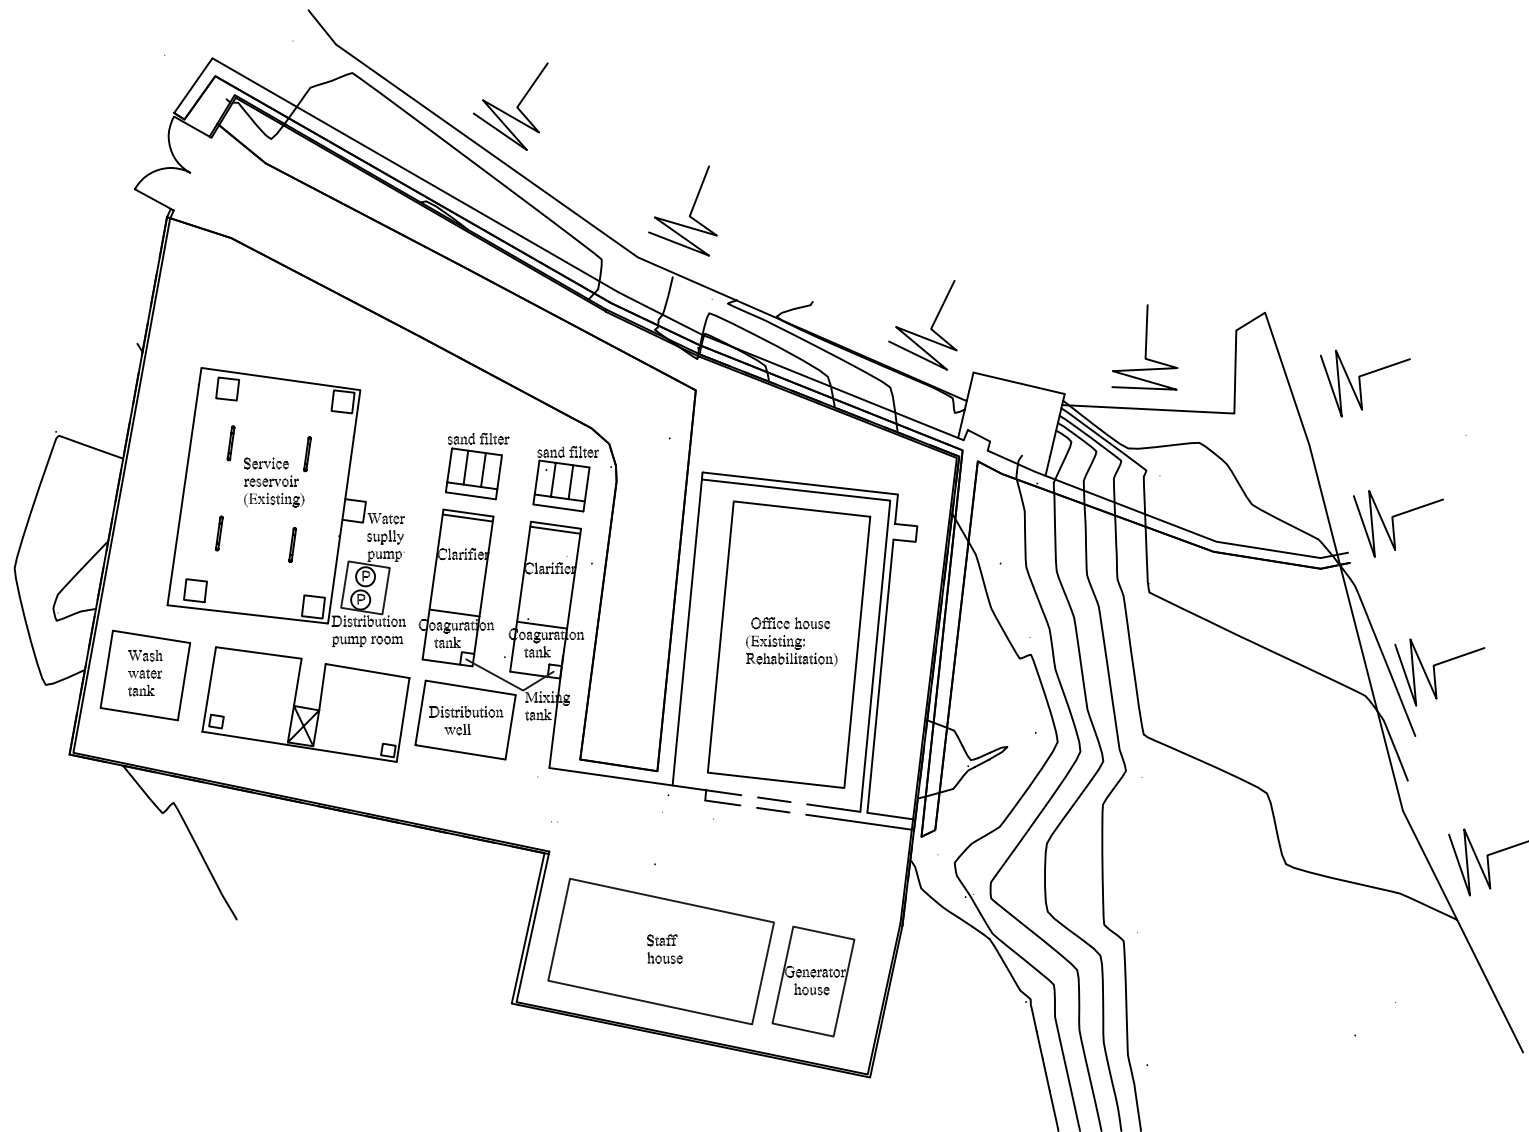


THE BASIC DESIGN STUDY ON THE PROJECT
FOR IMPROVEMENT OF WATER SUPPLY IN DILI AND DISTRICTS
IN THE DEMOCRATIC REPUBLIC OF TIMOR-LESTE

JICA JAPAN INTERNATIONAL COOPERATION AGENCY

DWG
No.

10

Water treatment plant
general plan
/ Benamauk WTP / Dili

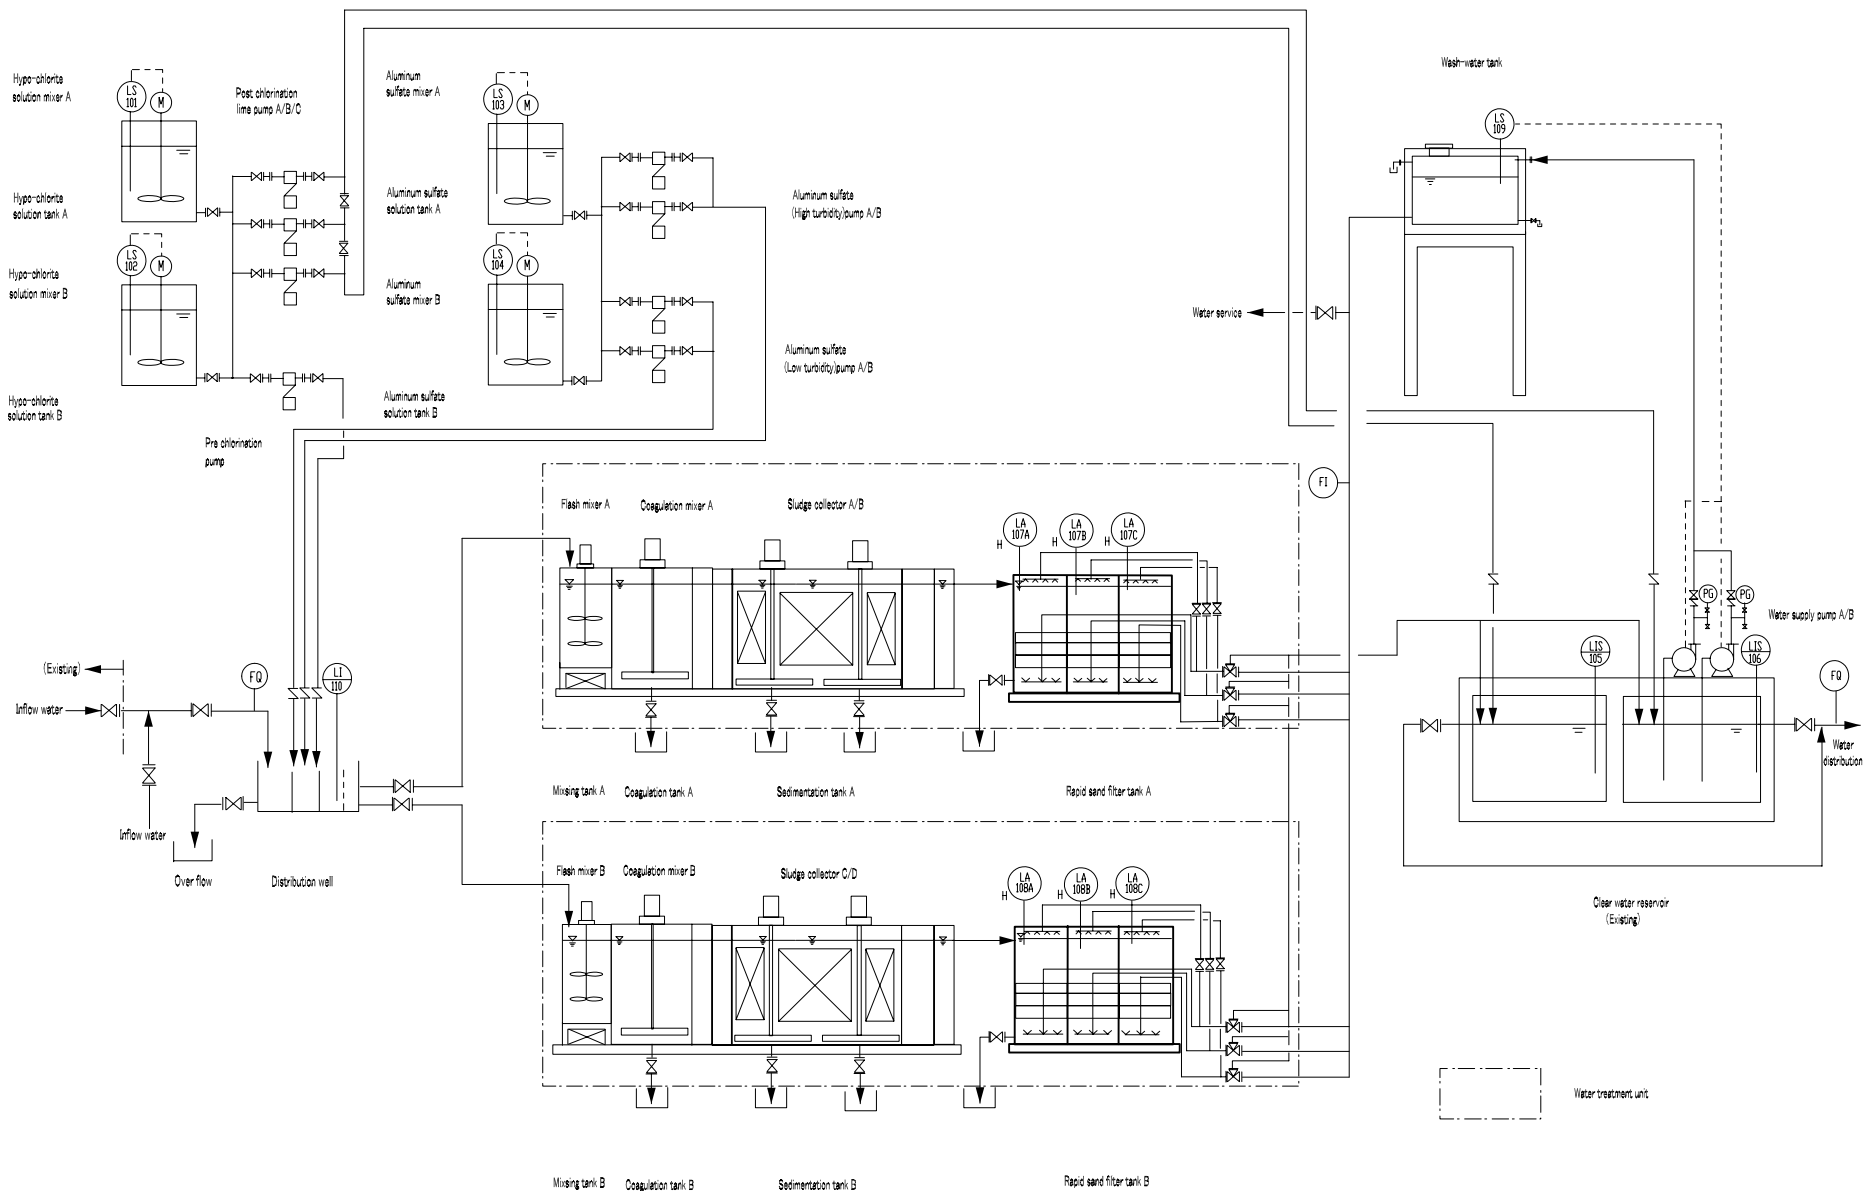


THE BASIC DESIGN STUDY ON THE PROJECT
FOR IMPROVEMENT OF WATER SUPPLY IN DILI AND DISTRICTS
IN THE DEMOCRATIC REPUBLIC OF TIMOR-LESTE
JICA JAPAN INTERNATIONAL COOPERATION AGENCY


DWG
No.
11

Water treatment plant
flow sheet
/ Benamauk WTP / Dili

PLAN

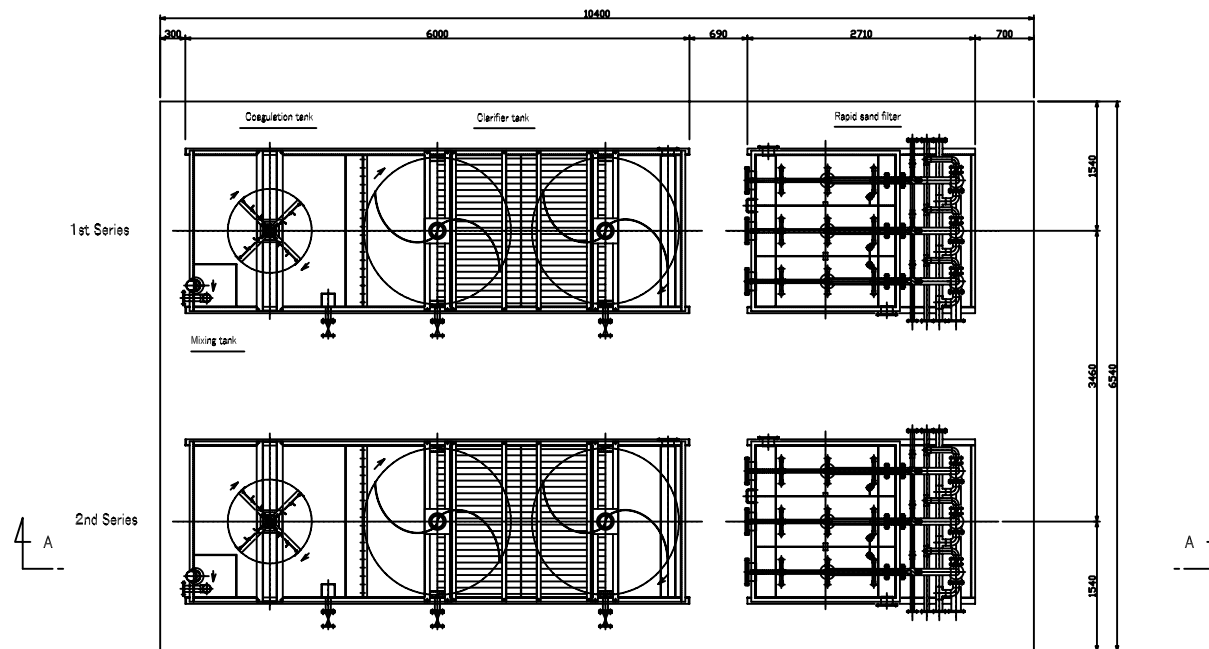

SECTION A-A

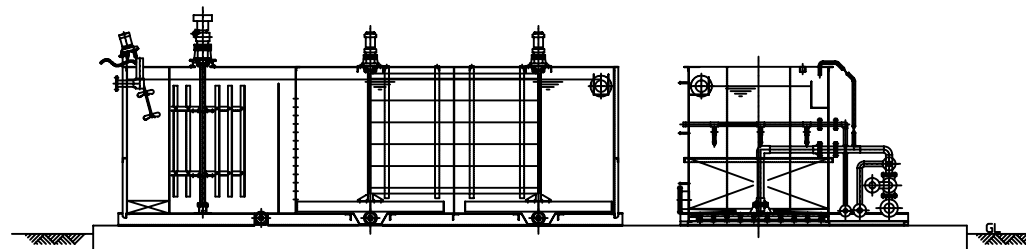


THE BASIC DESIGN STUDY ON THE PROJECT
FOR IMPROVEMENT OF WATER SUPPLY IN DILI AND DISTRICTS
IN THE DEMOCRATIC REPUBLIC OF TIMOR-LESTE

JICA JAPAN INTERNATIONAL COOPERATION AGENCY

DWG
No.

12

Water purification unit
/ Benamauk WTP / Dili

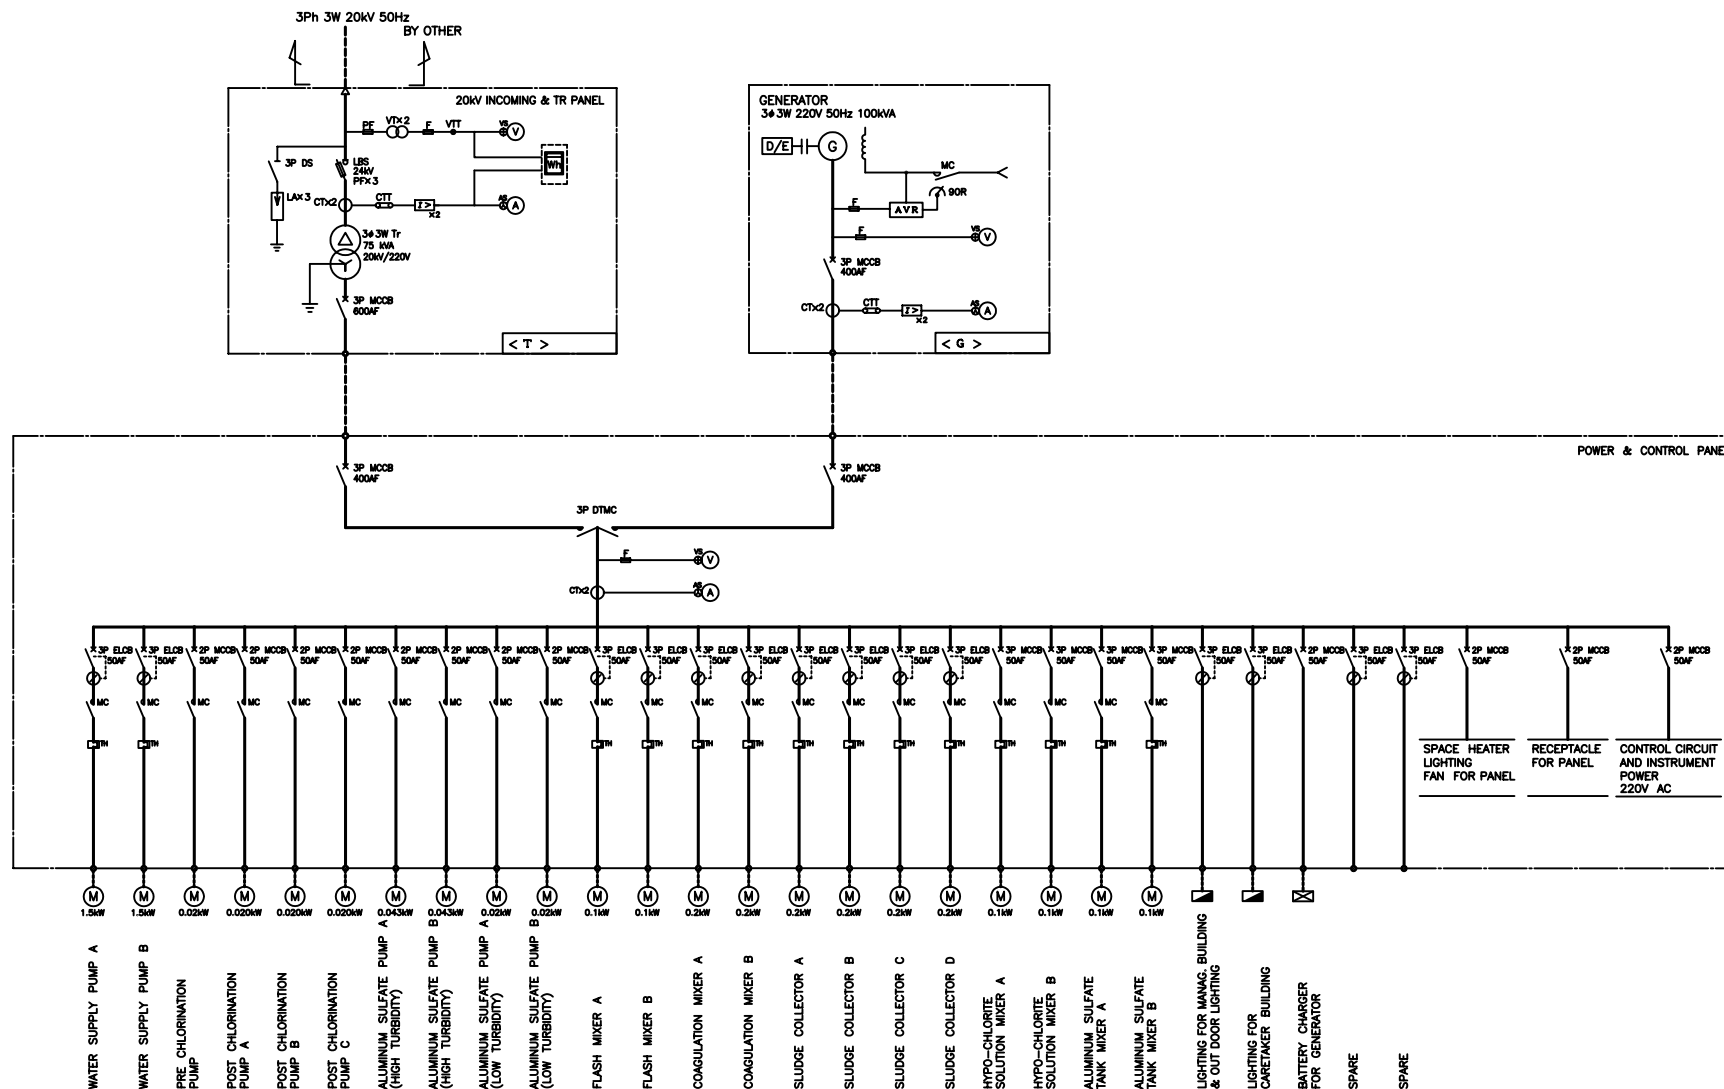

THE BASIC DESIGN STUDY ON THE PROJECT FOR IMPROVEMENT OF WATER SUPPLY IN DILI AND DISTRICTS IN THE DEMOCRATIC REPUBLIC OF TIMOR-LESTE	DWG No.	Single line diagram
JICA JAPAN INTERNATIONAL COOPERATION AGENCY	13	/ Benamauk WTP / Dili