

資料 7-3 サマーワ散歩道整備計画
概略設計図面

**DEPARTMENT OF BRIDGES AND ROADS
MUTHANNA GOVERNMENT
REPUBLIC OF IRAQ**

**THE PROJECTS FOR CONSTRUCTION AND IMPROVEMENT OF ROADS
AND BRIDGES IN SAMAWAH AND SUBURBAN AREA IN IRAQ**

SAMAWAH PROMENADE DEVELOPMENT PLAN

DESIGN DRAWINGS

MAY 2005



JAPAN INTERNATIONAL COOPERATION AGENCY



PACIFIC CONSULTANTS INTERNATIONAL

DRAWING LIST

Drawing No.	Drawing Title	Remarks
A. General		
A-1	Location Map	
B. Typical Cross Section and Pavement Detail		
B-1	Typical Cross Section	
C. Plan and Profile		
C-1	Plan and Profile (1/9)	STA. 0+000 - 0+150
C-2	Plan and Profile (2/9)	STA. 0+150 - 0+300
C-3	Plan and Profile (3/9)	STA. 0+300 - 0+450
C-4	Plan and Profile (4/9)	STA. 0+450 - 0+600
C-5	Plan and Profile (5/9)	STA. 0+600 - 0+750
C-6	Plan and Profile (6/9)	STA. 0+750 - 0+900
C-7	Plan and Profile (7/9)	STA. 0+900 - 0+050
C-8	Plan and Profile (8/9)	STA. 0+050 - 1+200
C-9	Plan and Profile (9/9)	STA. 0+200 - 1+340
D. Drainage		
D-1	Drainage System Plan (1/9)	STA. 0+000 - 0+150
D-2	Drainage System Plan (2/9)	STA. 0+150 - 0+300
D-3	Drainage System Plan (3/9)	STA. 0+300 - 0+450
D-4	Drainage System Plan (4/9)	STA. 0+450 - 0+600
D-5	Drainage System Plan (5/9)	STA. 0+600 - 0+750
D-6	Drainage System Plan (6/9)	STA. 0+750 - 0+900
D-7	Drainage System Plan (7/9)	STA. 0+900 - 0+050
D-8	Drainage System Plan (8/9)	STA. 0+050 - 1+200
D-9	Drainage System Plan (9/9)	STA. 0+200 - 1+340
D-10	Backfilling Method of Pipe excavations	
D-11	Detail of catch basin (inlet) Type A	
D-12	Detail of catch basin (inlet) Type B	
D-13	Detail of Manhole	
E. Details		
E-1	Road Marking Details	
E-2	Detail of Concrete Curb, L-Gutter, Inlet, Manhole and Pipe Excavation	
E-3	Cross Section (1/5)	
E-4	Cross Section (2/5)	
E-5	Cross Section (3/5)	
E-6	Cross Section (4/5)	
E-7	Cross Section (5/5)	




Drawing No.	Drawing Title	Remarks
F. Street Lighting		
F-1	Street Lighting Layout (1/9)	STA. 0+000 - 0+150
F-2	Street Lighting Layout (2/9)	STA. 0+150 - 0+300
F-3	Street Lighting Layout (3/9)	STA. 0+300 - 0+450
F-4	Street Lighting Layout (4/9)	STA. 0+450 - 0+600
F-5	Street Lighting Layout (5/9)	STA. 0+600 - 0+750
F-6	Street Lighting Layout (6/9)	STA. 0+750 - 0+900
F-7	Street Lighting Layout (7/9)	STA. 0+900 - 0+050
F-8	Street Lighting Layout (8/9)	STA. 0+050 - 1+200
F-9	Street Lighting Layout (9/9)	STA. 0+200 - 1+340
F-10	Distribution Panels (1/4)	
F-11	Distribution Panels (2/4)	
F-12	Distribution Panels (3/4)	
F-13	Distribution Panels (4/4)	
F-14	Manhole, Foundation, Distribution Board Details for Street Lighting	
F-15	Lighting Poles Details	
G. Sidewalk, Planting and Bench		
G-1	Sidewalk, Planting and Bench Layout (1/9)	STA. 0+000 - 0+150
G-2	Sidewalk, Planting and Bench Layout (2/9)	STA. 0+150 - 0+300
G-3	Sidewalk, Planting and Bench Layout (3/9)	STA. 0+300 - 0+450
G-4	Sidewalk, Planting and Bench Layout (4/9)	STA. 0+450 - 0+600
G-5	Sidewalk, Planting and Bench Layout (5/9)	STA. 0+600 - 0+750
G-6	Sidewalk, Planting and Bench Layout (6/9)	STA. 0+750 - 0+900
G-7	Sidewalk, Planting and Bench Layout (7/9)	STA. 0+900 - 0+050
G-8	Sidewalk, Planting and Bench Layout (8/9)	STA. 0+050 - 1+200
G-9	Sidewalk, Planting and Bench Layout (9/9)	STA. 0+200 - 1+340
G-10	Bench and Planting Details	
G-11	Detail of Sidewalk and Planting Area	

Owner: SAMAWAH MAYORALTY MUTHANNA GOVERNORATE REPUBLIC OF IRAQ	Consultant:	Client :	Project : REHABILITATION AND IMPROVEMENT OF THE ROADS AND ROAD SIDES IN SAMAWAH FOR SAMAWAH PROMENADE DEVELOPMENT PLAN	Drawing No.	Rev:	Drawn by :
			Dwg Title: DRAWING LIST	Scale	Date:	Checked by:



LOCATION MAP

SCALE 1:8,000

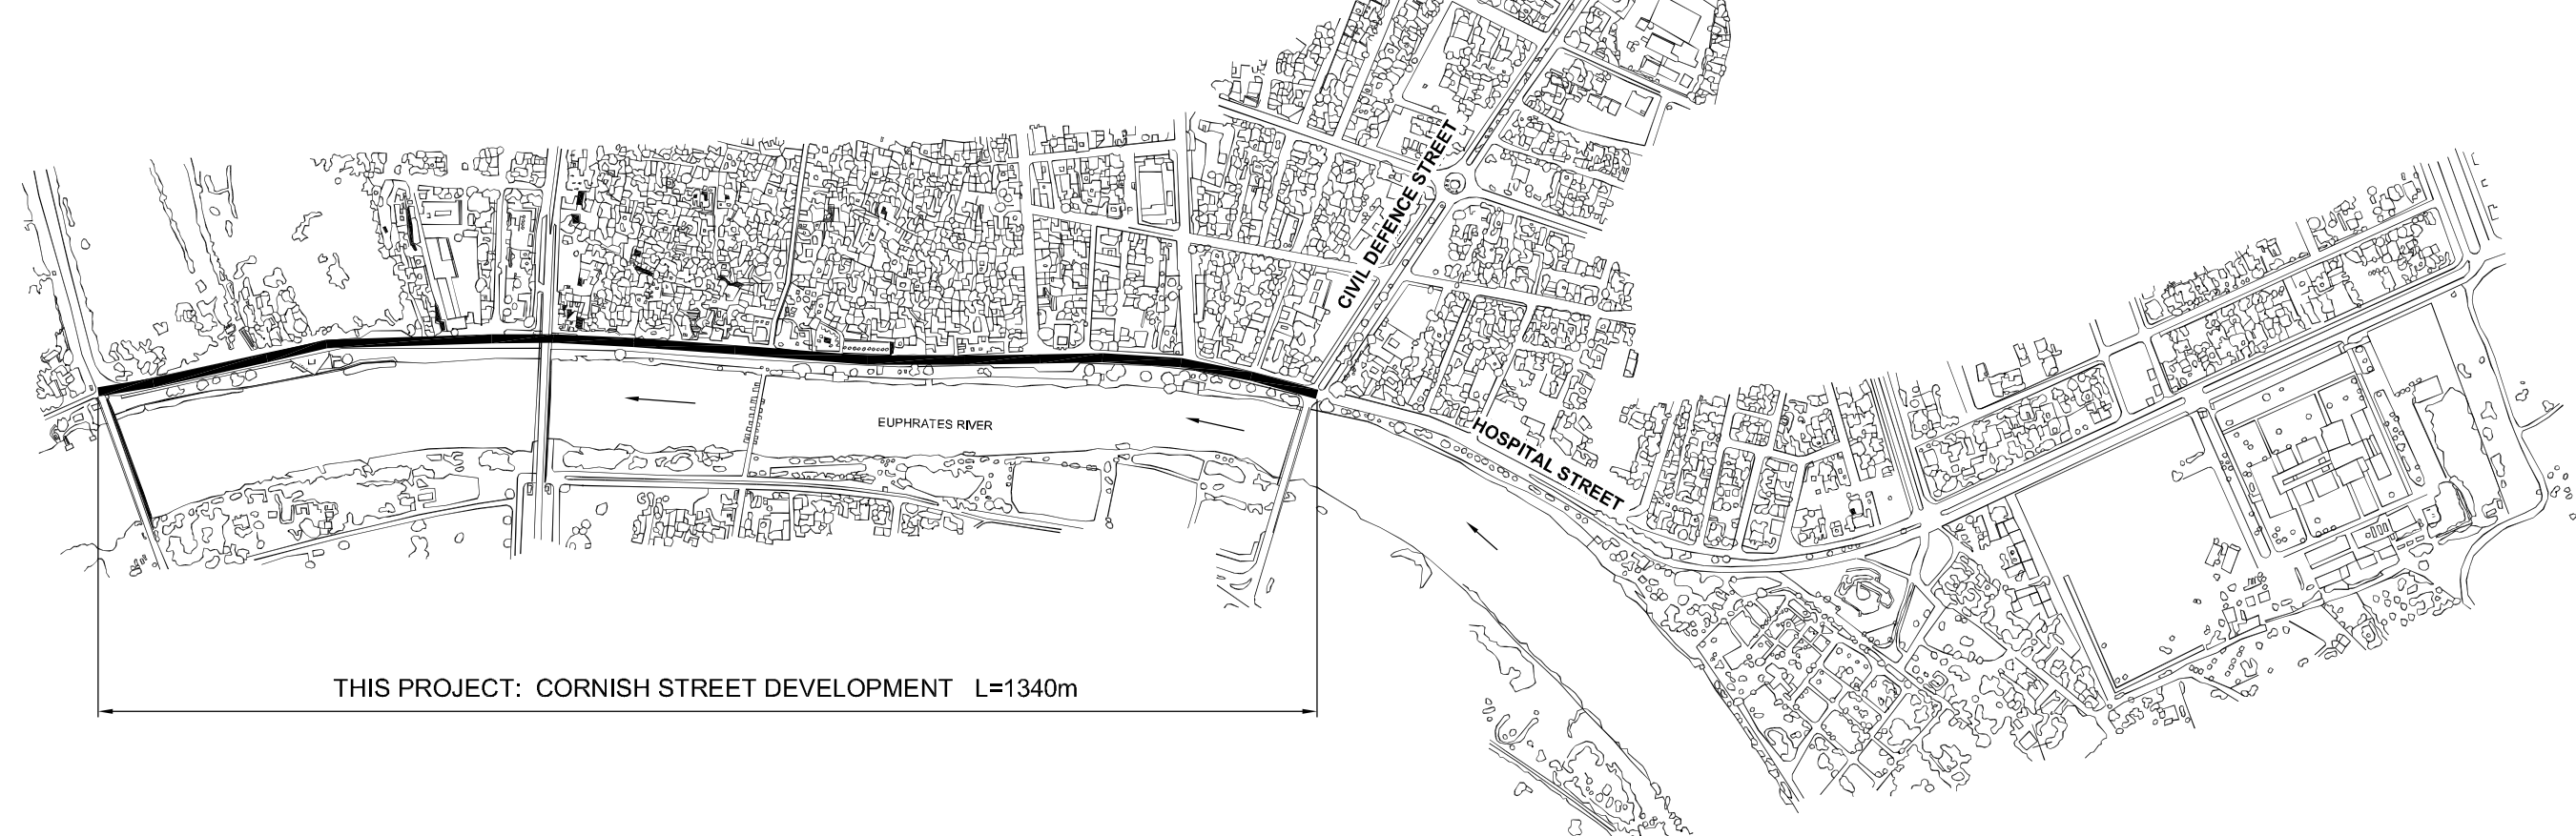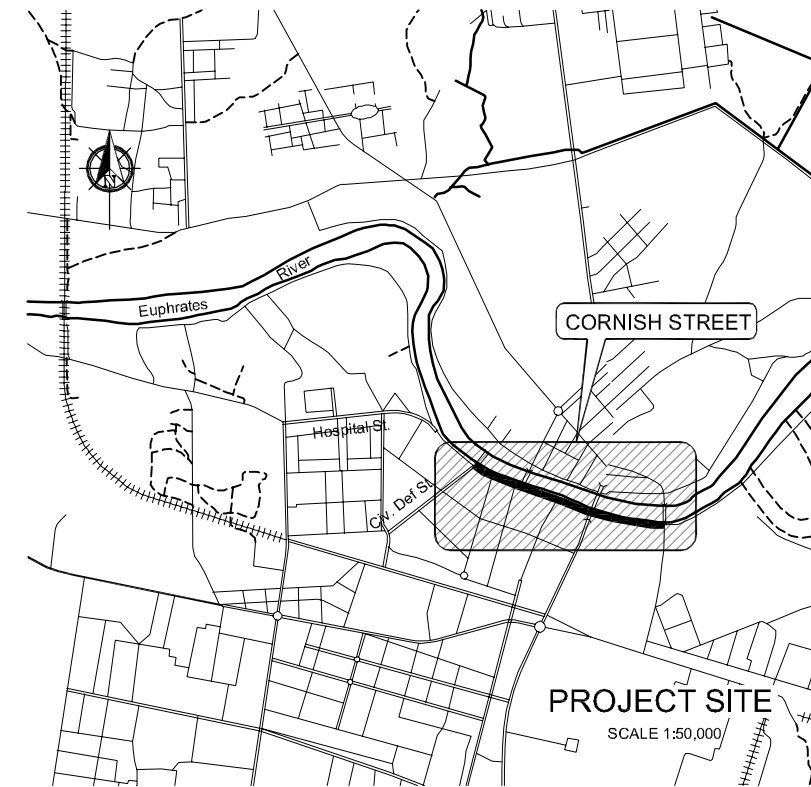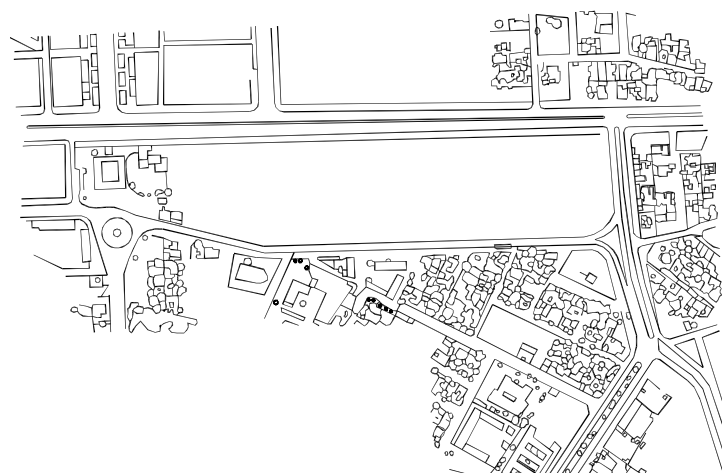


C:\IPAD\FROM APRIL 2005 WORKING DRAWINGS (00) A-1 LOCATION MAP.DWG Layout: May 07 2005 8:32 PM

Owner: SAMAWAH MAYORALTY MUTHANNA GOVERNORATE REPUBLIC OF IRAQ	Consultant:	Client :	Project : REHABILITATION AND IMPROVEMENT OF THE ROADS AND ROAD SIDES IN SAMAWAH FOR SAMAWAH PROMENADE DEVELOPMENT PLAN	Drawing No. A-1	Rev:	Drawn by :
			Dwg Title: LOCATION MAP	Scale AS SHOWN	Date:	Checked by:


TYPICAL ROAD CROSS SECTION

SCALE NTS

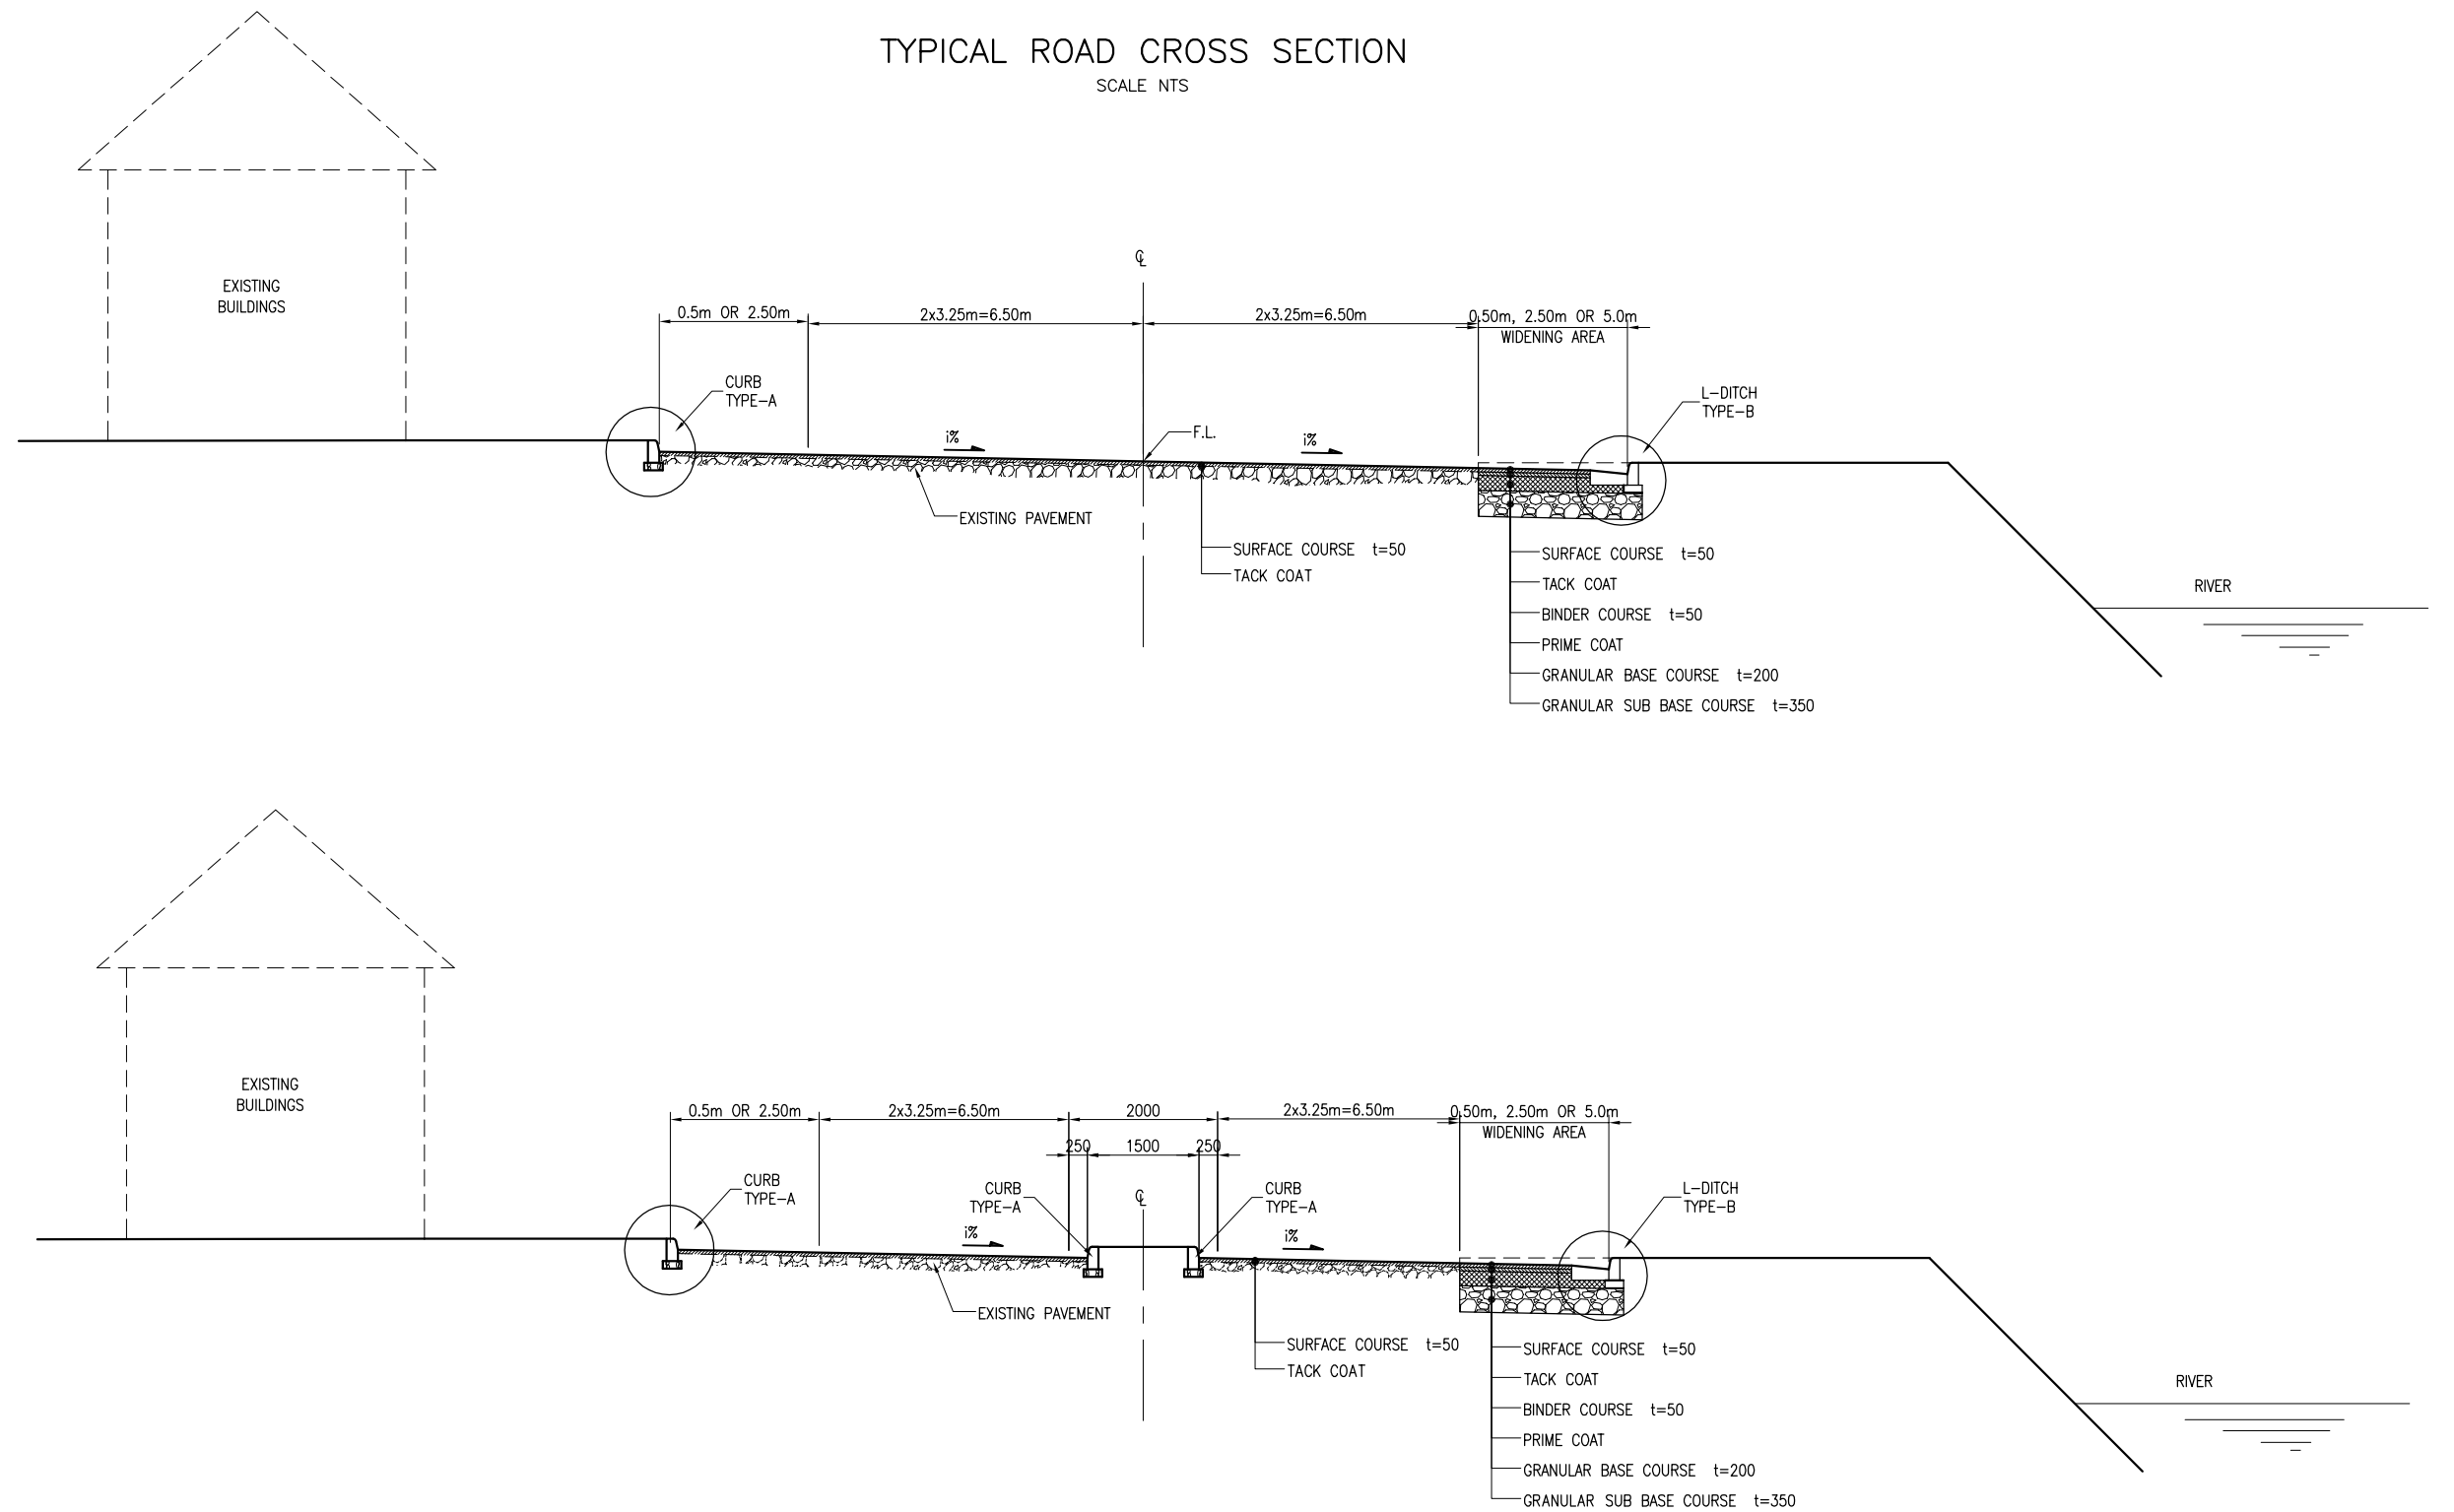


Owner: SAMAWAH MAYORALTY MUTHANNA GOVERNORATE REPUBLIC OF IRAQ	Consultant:	Client :	Project : REHABILITATION AND IMPROVEMENT OF THE ROADS AND ROAD SIDES IN SAMAWAH FOR SAMAWAH PROMENADE DEVELOPMENT PLAN	Drawing No. B-1	Rev: 0	Drawn by : H.S.
			Dwg Title: TYPICAL CROSS SECTION	Scale AS SHOWN	Date: 8-5-2005	Checked by: E.I.

PLAN SCALE 1:500

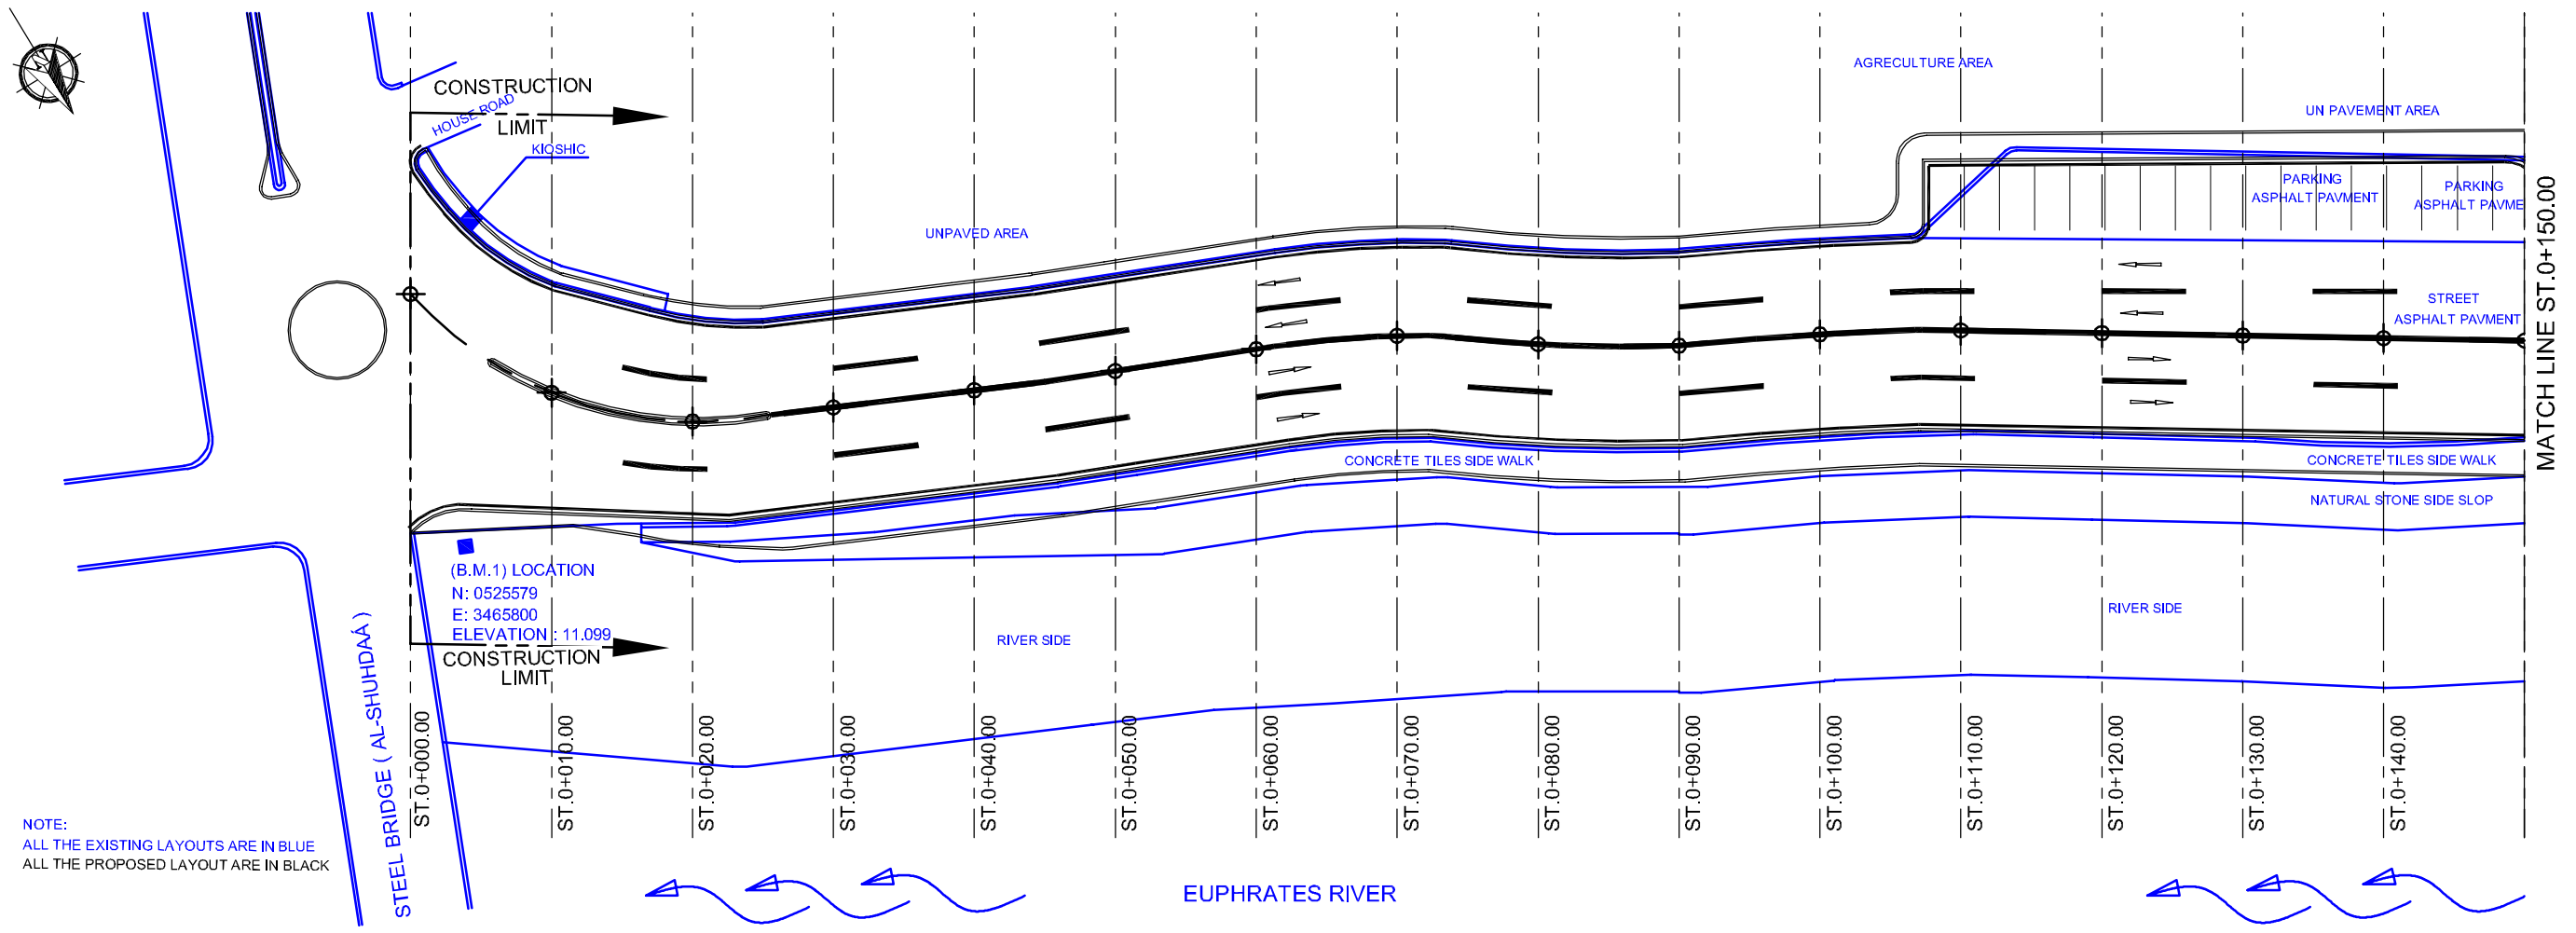

NOTE:
ALL THE EXISTING LAYOUTS ARE IN BLUE
ALL THE PROPOSED LAYOUT ARE IN BLACK

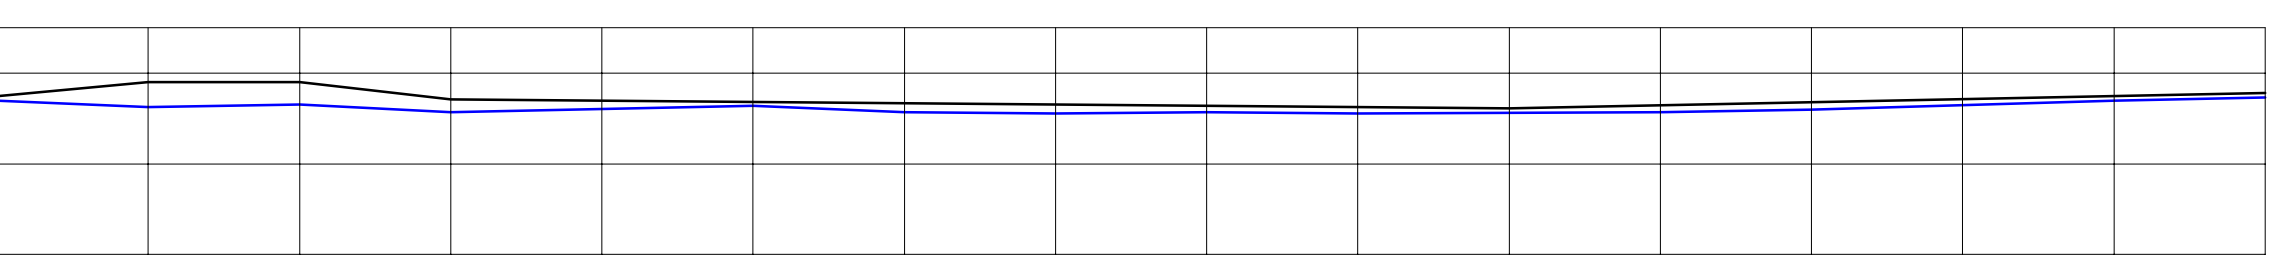


F.F.L ELEVATION		11.748	11.901	11.901	11.707	11.694	11.681	11.667	11.653	11.640	11.626	11.613	11.646	11.680	11.714	11.748	11.782
C.L. ELEVATION		11.698	11.628	11.653	11.568	11.605	11.638	11.568	11.555	11.565	11.555	11.563	11.571	11.596	11.646	11.693	11.732
C.L. COORDINATE (U.T.M. SYSTEM)	N:	0528252	0528240	0528231	0528222	0528210	0528202	0528190	0528179	0528171	0528160	0528151	0528142	0528133	0528122	0528112	0528102
	E:	3464369	3464376	3464382	3464382	3464386	3464386	3464386	3464387	3464389	3464391	3464391	3464392	3464395	3464396	3464398	3464399
STATION		0+000.00	0+100.00	0+200.00	0+300.00	0+400.00	0+500.00	0+600.00	0+700.00	0+800.00	0+900.00	0+1000.00	0+1100.00	0+1200.00	0+1300.00	0+1400.00	0+1500.00

PROFILE SECTION OF AL-CORNISH STREET (000.00 - 150.00)m



C:\PAC\FROM APRIL 2015 WORKING DRAWINGS (03) C-1 PLAN AND PROFILE.DWG P-1 (1) May 08, 2005-5:31 PM

Owner: SAMAWAH MAYORALTY MUTHANNA GOVERNORATE REPUBLIC OF IRAQ	Consultant:	Client :	Project : REHABILITATION AND IMPROVEMENT OF THE ROADS AND ROAD SIDES IN SAMAWAH FOR SAMAWAH PROMENADE DEVELOPMENT PLAN	Drawing No.: C-1	Rev.:	Drawn by :
			Dwg Title: CORNISH STREET PLAN & PROFILE (1/9)	Scale: AS SHOWN	Date:	Checked by:

PLAN SCALE 1:500

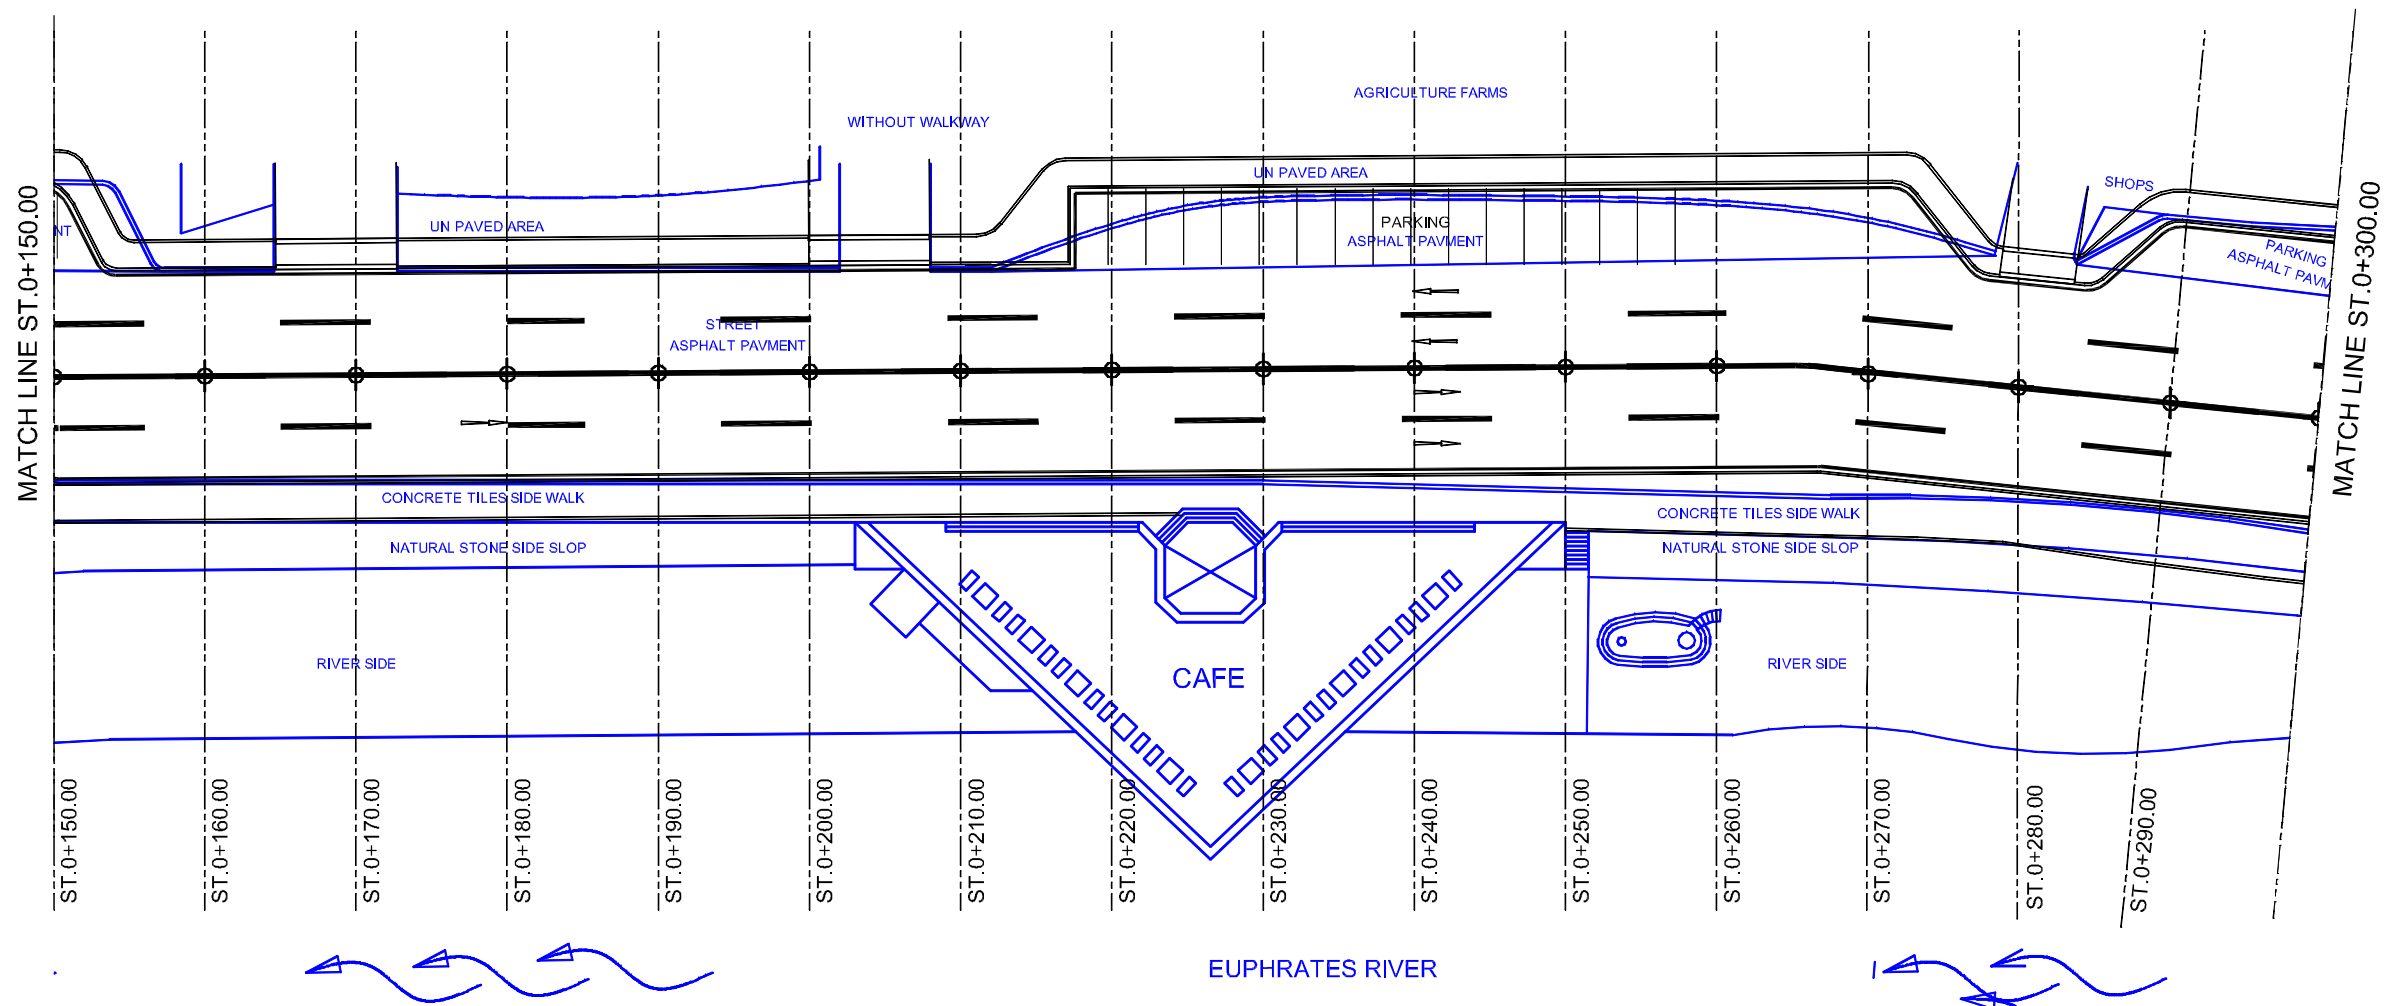

NOTE:
ALL THE EXISTING LAYOUTS ARE IN BLUE
ALL THE PROPOSED LAYOUT ARE IN BLACK

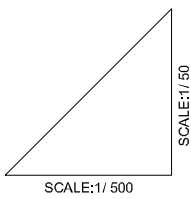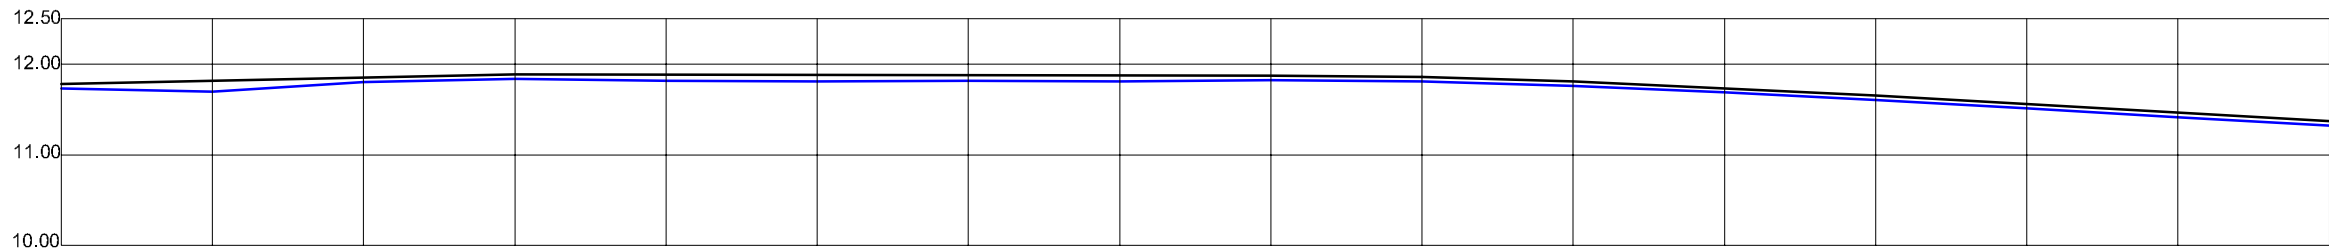


F.F.L ELEVATION		11.782	11.817	11.853	11.889	11.885	11.881	11.877	11.873	11.869	11.857	11.809	11.732	11.655	11.561	11.467	11.373
C.L. ELEVATION		11.732	11.693	11.804	11.839	11.816	11.805	11.813	11.808	11.819	11.807	11.759	11.686	11.605	11.512	11.412	11.323
C.L. COORDINATE (U.T.M. SYSTEM)	N:	0528102	0528093	0528084	0528073	0528063	0528053	0528042	0528031	0528022	0528012	0528002	0527994	0527983	0527974	0527964	0527954
	E:	3464399	3464399	3464399	3464399	3464400	3464401	3464403	3464403	3464405	3464407	3463409	3464411	3464412	3464415	3464420	3464423
STATION		0+150.00	0+160.00	0+170.00	0+180.00	0+190.00	0+200.00	0+210.00	0+220.00	0+230.00	0+240.00	0+250.00	0+260.00	0+270.00	0+280.00	0+290.00	0+300.00

PROFILE SECTION OF AL-CORNISH STREET (150.00 - 300.00)m



Owner: SAMAWAH MAYORALTY MUTHANNA GOVERNORATE REPUBLIC OF IRAQ	Consultant:	Client :	Project :	Drawing No.	Rev:	Drawn by :
			REHABILITATION AND IMPROVEMENT OF THE ROADS AND ROAD SIDES IN SAMAWAH FOR SAMAWAH PROMENADE DEVELOPMENT PLAN	C-2		
			Dwg Title:	Scale	Date:	Checked by:
			CORNISH STREET PLAN & PROFILE (2/9)	AS SHOWN		



PLAN SCALE 1:500

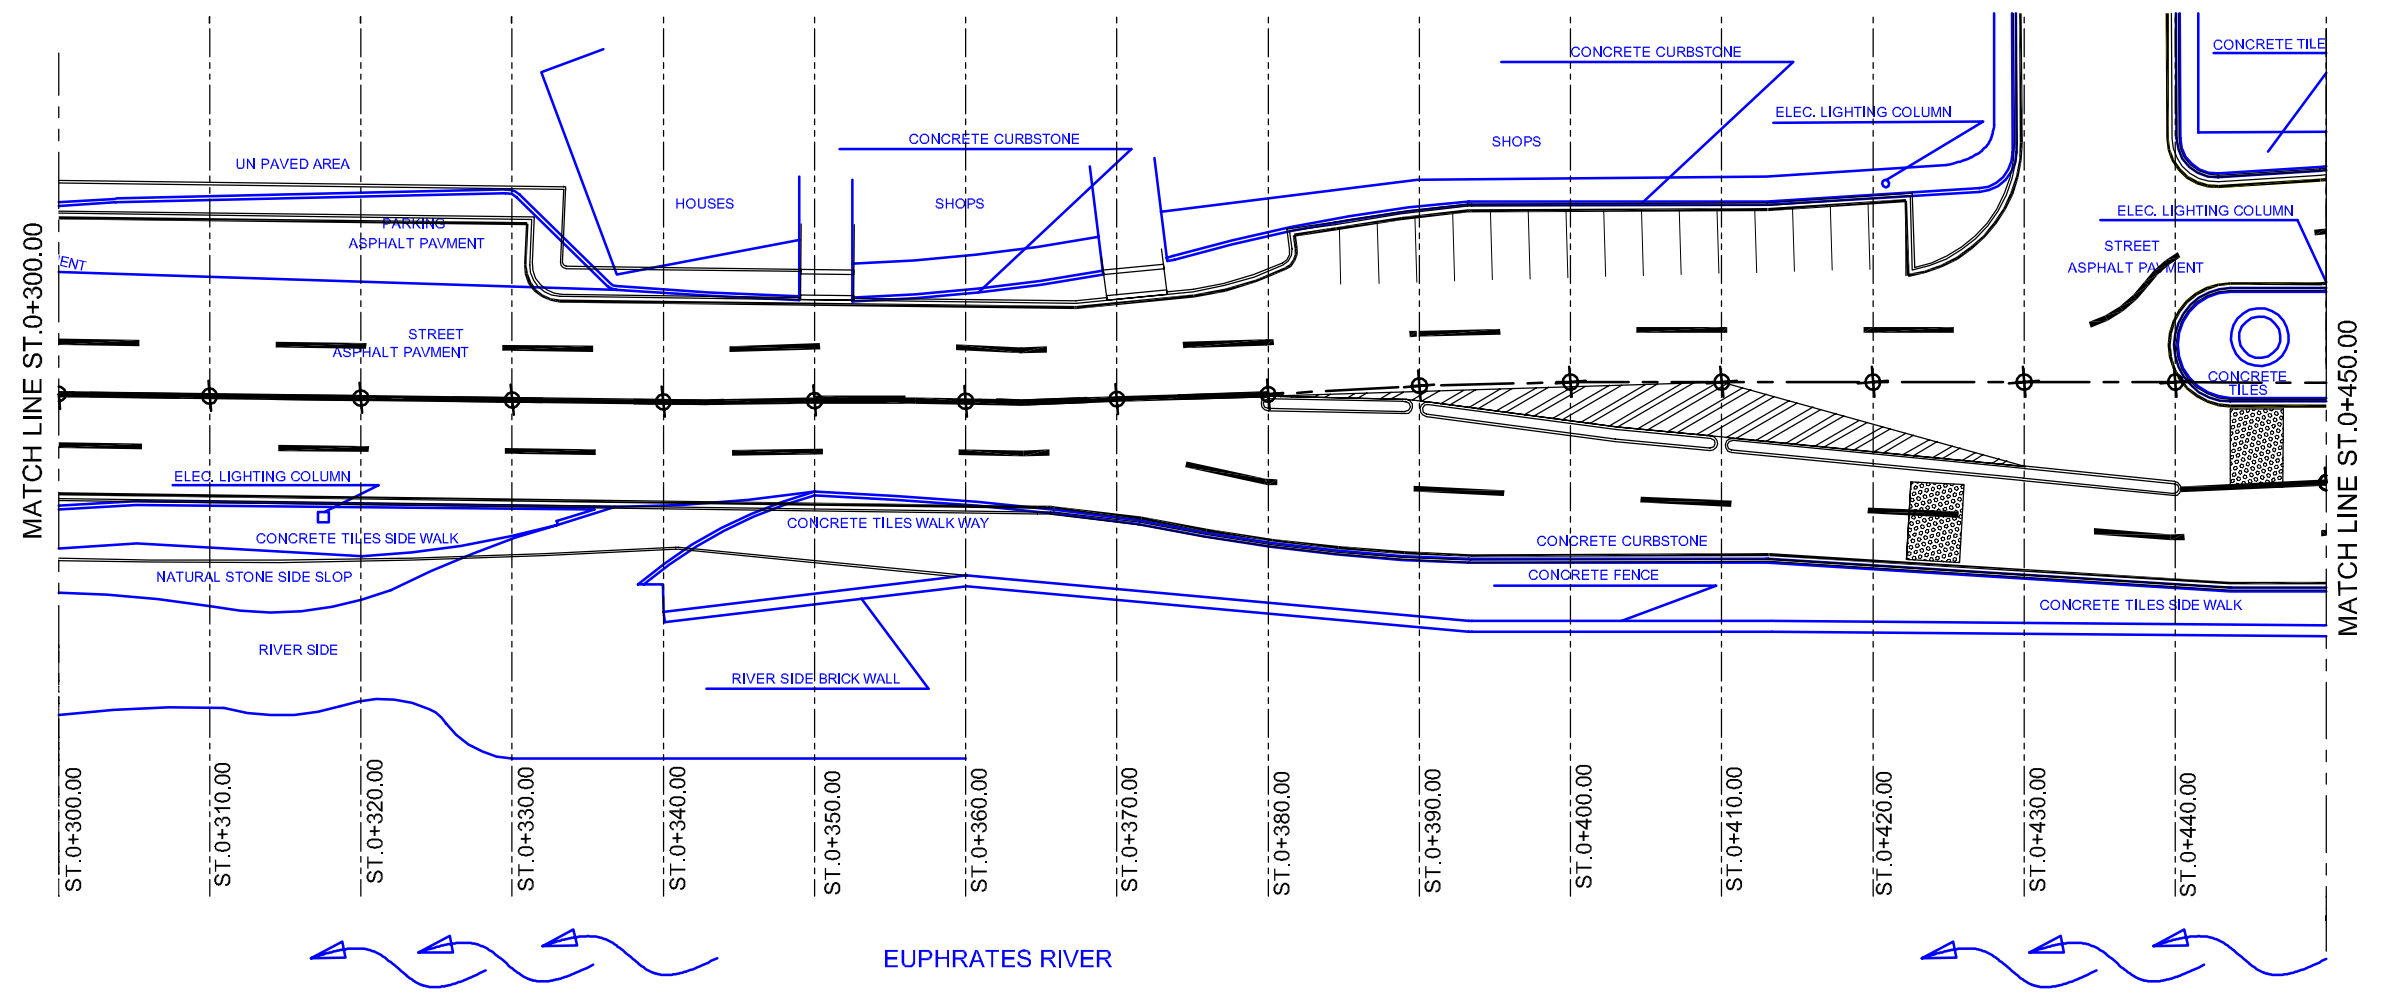

NOTE:
 ALL THE EXISTING LAYOUTS ARE IN BLUE
 ALL THE PROPOSED LAYOUT ARE IN BLACK

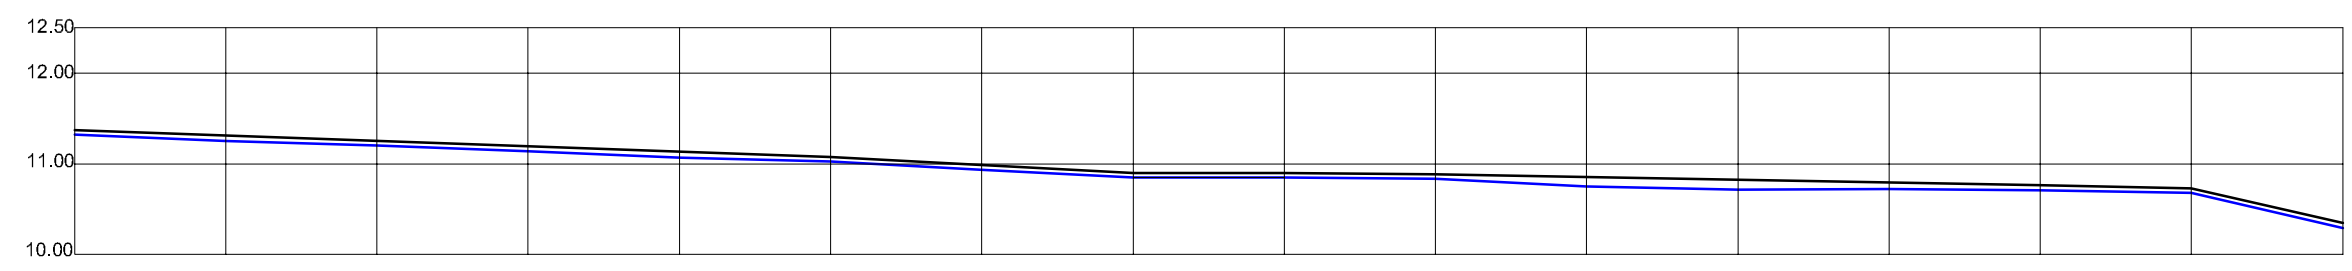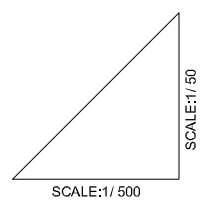

F.F.L ELEVATION		11.373	11.313	11.253	11.193	11.133	11.073	10.985	10.898	10.898	10.887	10.855	10.824	10.792	10.762	10.731	10.346
C.L. ELEVATION		11.323	11.241	11.204	11.140	11.070	11.023	10.932	10.848	10.848	10.837	10.750	10.713	10.720	10.711	10.680	10.295
C.L. COORDINATE (U.T.M. SYSTEM)	N:	0527954	0527944	0527934	0527926	0527914	0527906	0527897	0527887	0527878	0527868	0527859	0527949	0527839	0527828	0527821	0527812
	E:	3464423	3464426	3464429	3464433	3464434	3464437	3464439	3464443	3464446	3464451	3464453	3464455	3464463	3464462	3464465	3464470
STATION		0+300.00	0+310.00	0+320.00	0+330.00	0+340.00	0+350.00	0+360.00	0+370.00	0+380.00	0+390.00	0+400.00	0+410.00	0+420.00	0+430.00	0+440.00	0+450.00

PROFILE SECTION OF AL-CORNISH STREET (300.00 - 450.00)m

C:\PAC\FROM APRIL 2015 WORKING DRAWINGS\03\J-C\ PLAN AND PROFILE.DWG P-3 (3) May 08, 2015-5:59 PM

Owner: SAMAWAH MAYORALTY MUTHANNA GOVERNORATE REPUBLIC OF IRAQ	Consultant:	Client :	Project : REHABILITATION AND IMPROVEMENT OF THE ROADS AND ROAD SIDES IN SAMAWAH FOR SAMAWAH PROMENADE DEVELOPMENT PLAN	Drawing No. C-3	Rev:	Drawn by :
			Dwg Title: CORNISH STREET PLAN & PROFILE (3/9)	Scale AS SHOWN	Date:	Checked by: