




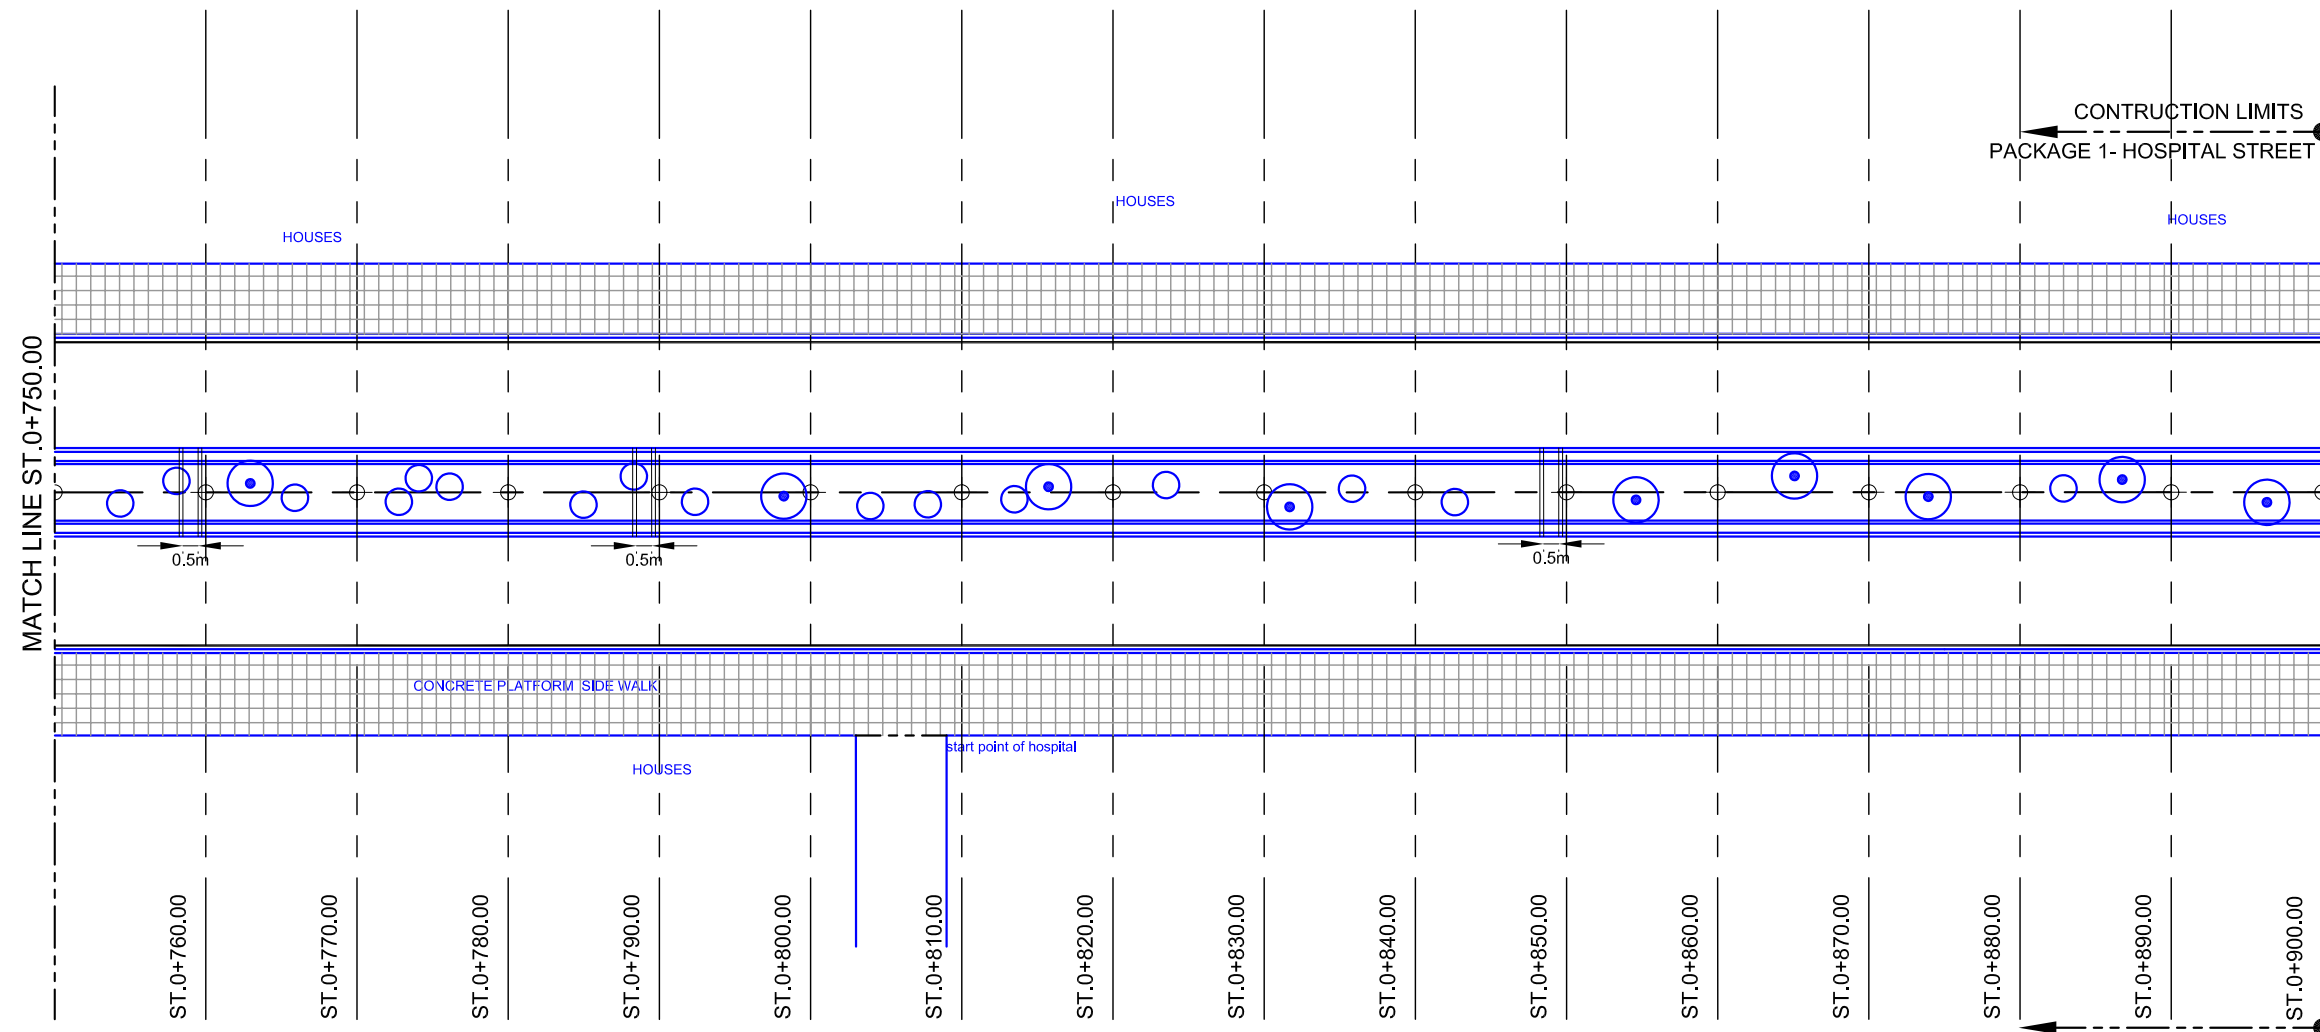
LEGEND

	EXISTING BIG TREE
	EXISTING SMALL TREE
	DATE PALM PLANTING TOTAL NUMBER: 10



CONCRETE TILES PAVEMENT

NOTE: BIG TREES TO BE TRIMMED AS PER ENGINEER INSTRUCTION ON SITE




NOTE:
ALL THE EXISTING LAYOUTS ARE IN BLUE

H:\SAMAWAH\JUNE 18, 2005\PACKAGE 1\07A) G SIDEWALK PLANTING & BENCH.DWG (6) Jun 18, 2005-5:03 PM


Owner: SAMAWAH MAYORALTY MUTHANNA GOVERNORATE REPUBLIC OF IRAQ	Consultant:	Client :	Project : REHABILITATION AND IMPROVEMENT OF THE ROADS AND ROAD SIDES IN SAMAWAH FOR SAMAWAH PROMENADE DEVELOPMENT PLAN	Drawing No. G-6	Rev:	Drawn by :
			Dwg Title: HOSPITAL STREET (PACKAGE 1) SIDEWALK, PLANTING AND BENCH LAYOUT (6-6)	Scale AS SHOWN	Date:	Checked by:

H:\SAMAWAH\JUNE 18, 2005\PACKAGE 1\07B) G-8 PLANTING AND PAVEMENT.DWG G-8 Jun 18, 2005-2:29 PM

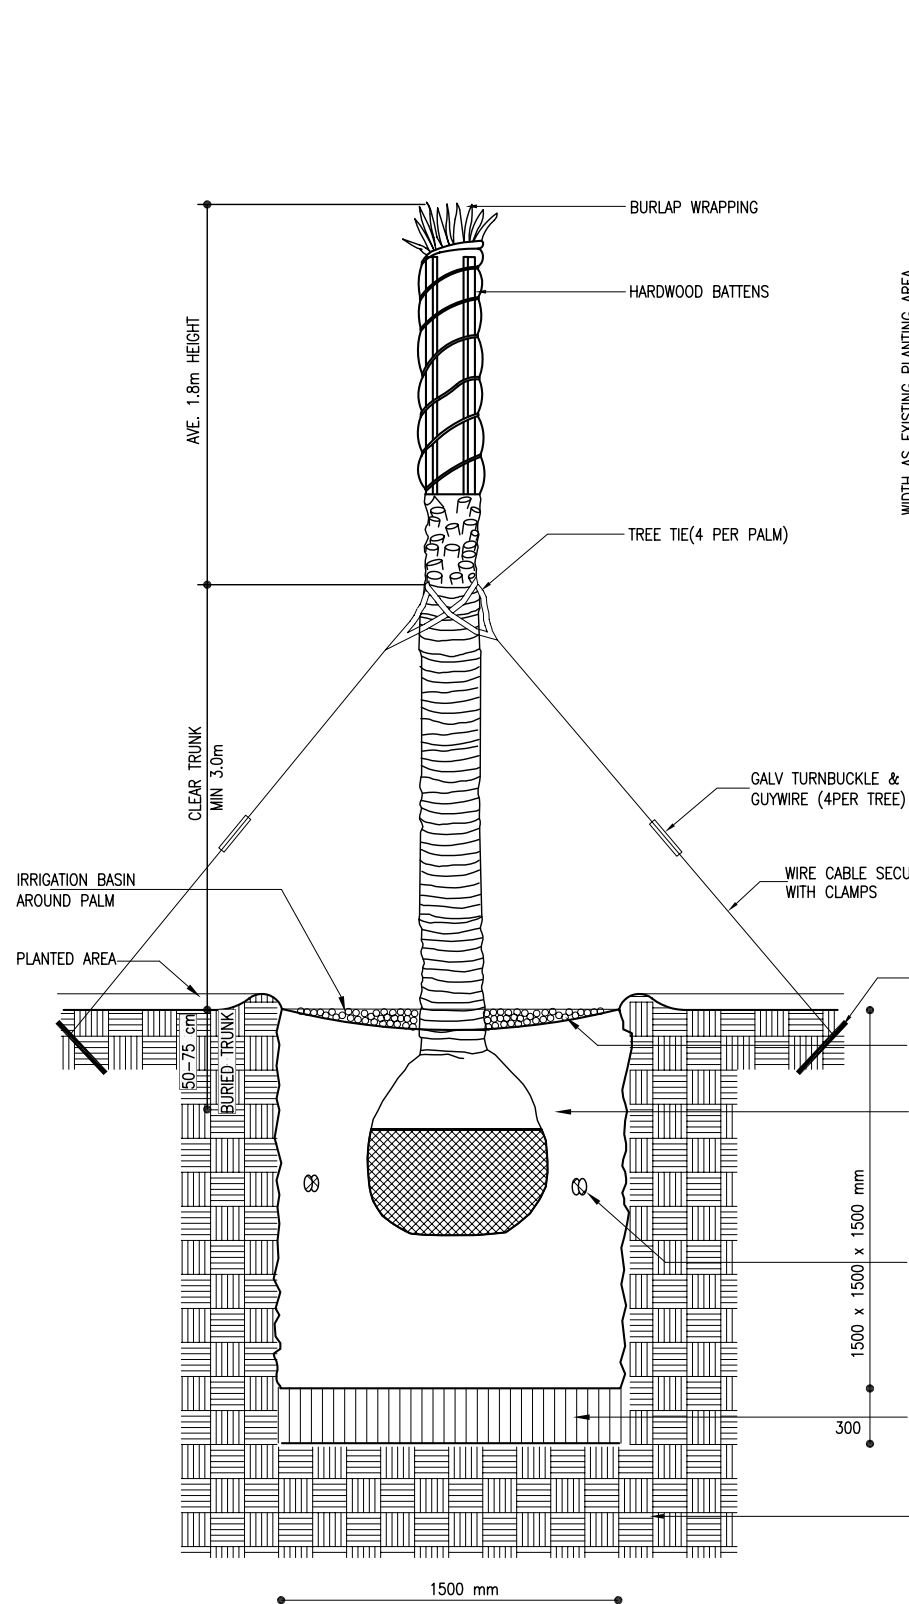


PALM PLANTING AND BRACING


PLAN
SCALE 1:20

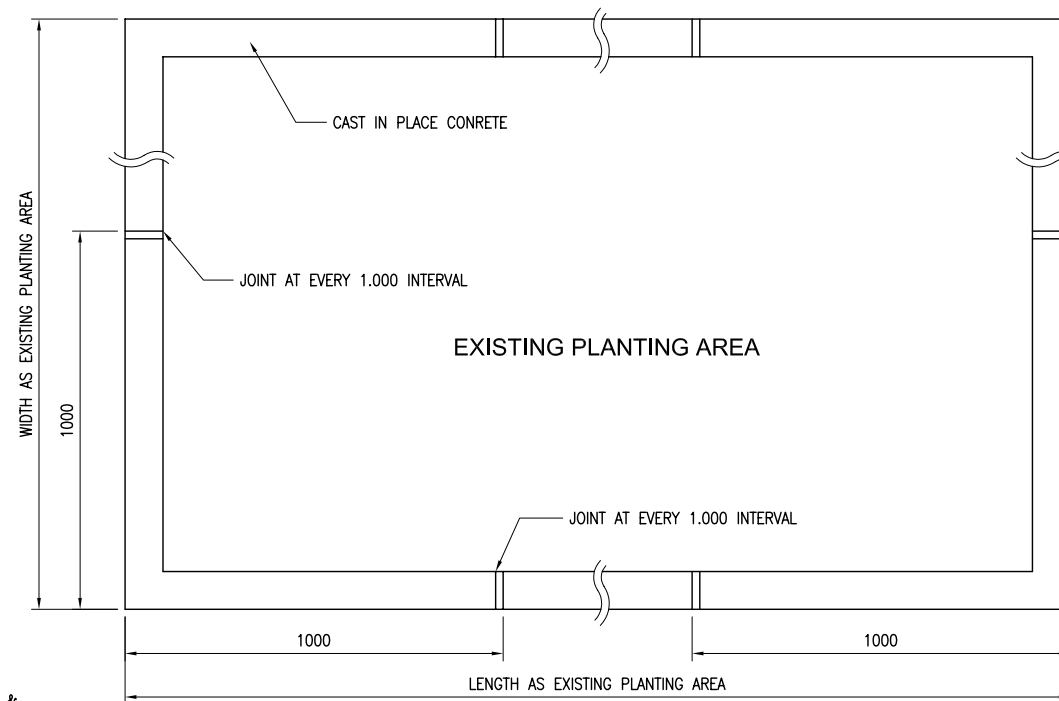


PLAN
SCALE 1:10

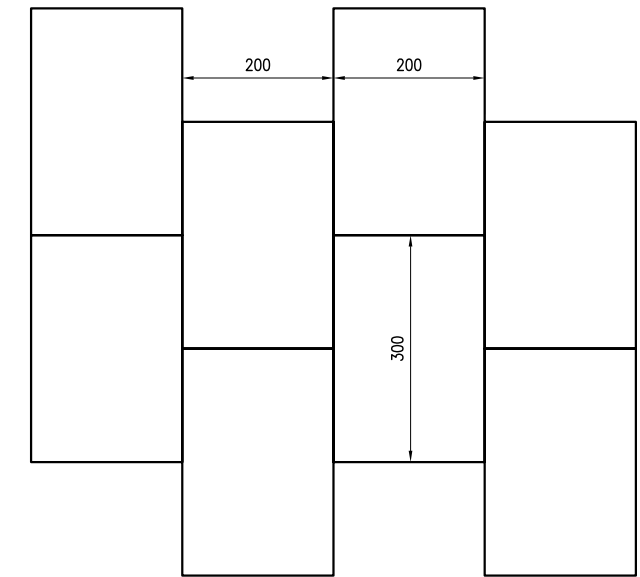

SECTION

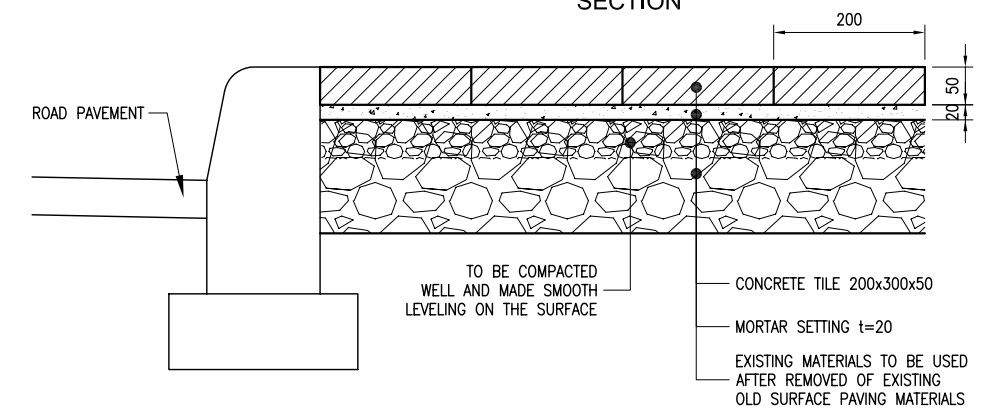

PLANTING AREA CONCRETE EDGE TRIM
SCALE 1:10

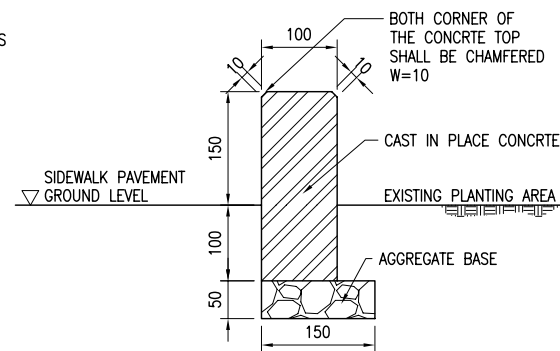

NOTE:

REHABILITATION OF EXISTING PLANTING AREA CONCRETE CORNER PLATE

- EXISTING PLANTING AREAS WITH BETTER CONDITIONED CONCRETE CORNER PLATE SHALL BE CHOSEN FOR REHABILITATION.
- FIFTY (50) PERCENT OF EXISTING CORNER PLATE OF EXISTING PLANTING AREA SHALL BE REHABILITATED BY USING CORNER PLATES OF OTHER PLANTING AREAS OF MORE DAMAGED AREA.
- CORNER PLATES WITHOUT DAMAGE IN THE OTHER PLANTING AREAS SHALL BE CAREFULLY REMOVED TO THE AREAS OF REHABILITATION AND INSTALLED THEM IN SAME PRACTICE OF FIXING AS EXISTING WAY OF CORNER PLATE FITTING.
- OTHER FIFTY (50) PERCENT OF EXISTING PLANTING AREAS AFTER REMOVED CORNER PLATES SHALL BE MADE EDGE TRIM BY CONCRETE IN PLACE AS SHOWN IN DETAIL DRAWING.

Owner: SAMAWAH MAYORALTY MUTHANNA GOVERNORATE REPUBLIC OF IRAQ	Consultant:	Client :	Project : REHABILITATION AND IMPROVEMENT OF THE ROADS AND ROAD SIDES IN SAMAWAH FOR SAMAWAH PROMENADE DEVELOPMENT PLAN	Drawing No. G-7	Rev:	Drawn by : B.H.
			Dwg Title: HOSPITAL STREET (PACKAGE 1) PLANTING AND PAVEMENT DETAILS	Scale AS SHOWN	Date: 16-05-05	Checked by: M.J.

**DEPARTMENT OF BRIDGES AND ROADS
MUTHANNA GOVERNMENT
REPUBLIC OF IRAQ**

**THE PROJECTS FOR CONSTRUCTION AND IMPROVEMENT OF ROADS
AND BRIDGES IN SAMAWAH AND SUBURBAN AREA IN IRAQ**

SAMAWAH PROMENADE DEVELOPMENT PLAN

**DESIGN DRAWINGS
HOSPITAL STREET (PACKAGE 2)**

JUNE 2005



JAPAN INTERNATIONAL COOPERATION AGENCY



PACIFIC CONSULTANTS INTERNATIONAL

DRAWING LIST

Drawing No.	Drawing Title	Remarks
A. General		
A-1	Location Map & Site Plan	
B. Typical Cross Section and Pavement Detail		
B-1	Typical Cross Section	
C. Plan and Profile		
C-1	Plan and Profile (1/4)	STA. 0+900 - 1+050
C-2	Plan and Profile (2/4)	STA. 1+050 - 1+200
C-3	Plan and Profile (3/4)	STA. 1+200 - 1+350
C-4	Plan and Profile (4/4)	STA. 1+350 - 1+370
D. Drainage		
D-1	Drainage System Plan (1/4)	STA. 0+900 - 1+050
D-2	Drainage System Plan (2/4)	STA. 1+050 - 1+200
D-3	Drainage System Plan (3/4)	STA. 1+200 - 1+350
D-4	Drainage System Plan (4/4)	STA. 1+350 - 1+370
D-5	Detail of Inlet, Manhole and Backfilling Methods of Pipe Excavations	
E. Details		
E-1	Road Marking Details	
E-2	Cross Section (1/2)	
E-3	Cross Section (2/2)	

Drawing No.	Drawing Title	Remarks
F. Street Lighting		
F-1	Street Lighting Layout (1/4)	STA. 0+900 - 1+050
F-2	Street Lighting Layout (2/4)	STA. 1+050 - 1+200
F-3	Street Lighting Layout (3/4)	STA. 1+200 - 1+350
F-4	Street Lighting Layout (4/4)	STA. 1+350 - 1+370
F-5	Distribution Panels (1/2)	
F-6	Manhole, Foundation, Distribution Board Details for Street Lighting	
F-7	Lighting Poles Details	
G. Sidewalk, Planting and Bench		
G-1	Sidewalk, Planting and Bench Layout (1/4)	STA. 0+900 - 1+050
G-2	Sidewalk, Planting and Bench Layout (2/4)	STA. 1+050 - 1+200
G-3	Sidewalk, Planting and Bench Layout (3/4)	STA. 1+200 - 1+350
G-4	Sidewalk, Planting and Bench Layout (4/4)	STA. 1+350 - 1+370
G-5	Planting and Pavement Detail	




H:\SAMAWAH\JUNE 18, 2005\PACKAGE 2\100A\DRAWING LIST.DWG (0-0) Jun 18, 2005-5:10 PM

Owner: SAMAWAH MAYORALTY MUTHANNA GOVERNORATE REPUBLIC OF IRAQ	Consultant:	Client :	Project : REHABILITATION AND IMPROVEMENT OF THE ROADS AND ROAD SIDES IN SAMAWAH FOR SAMAWAH PROMENADE DEVELOPMENT PLAN	Drawing No.	Rev:	Drawn by :
			Dwg Title: DRAWING LIST FOR THE HOSPITAL STREET PACKAGE 2	Scale	Date:	Checked by:



LOCATION MAP


SCALE 1:8,000

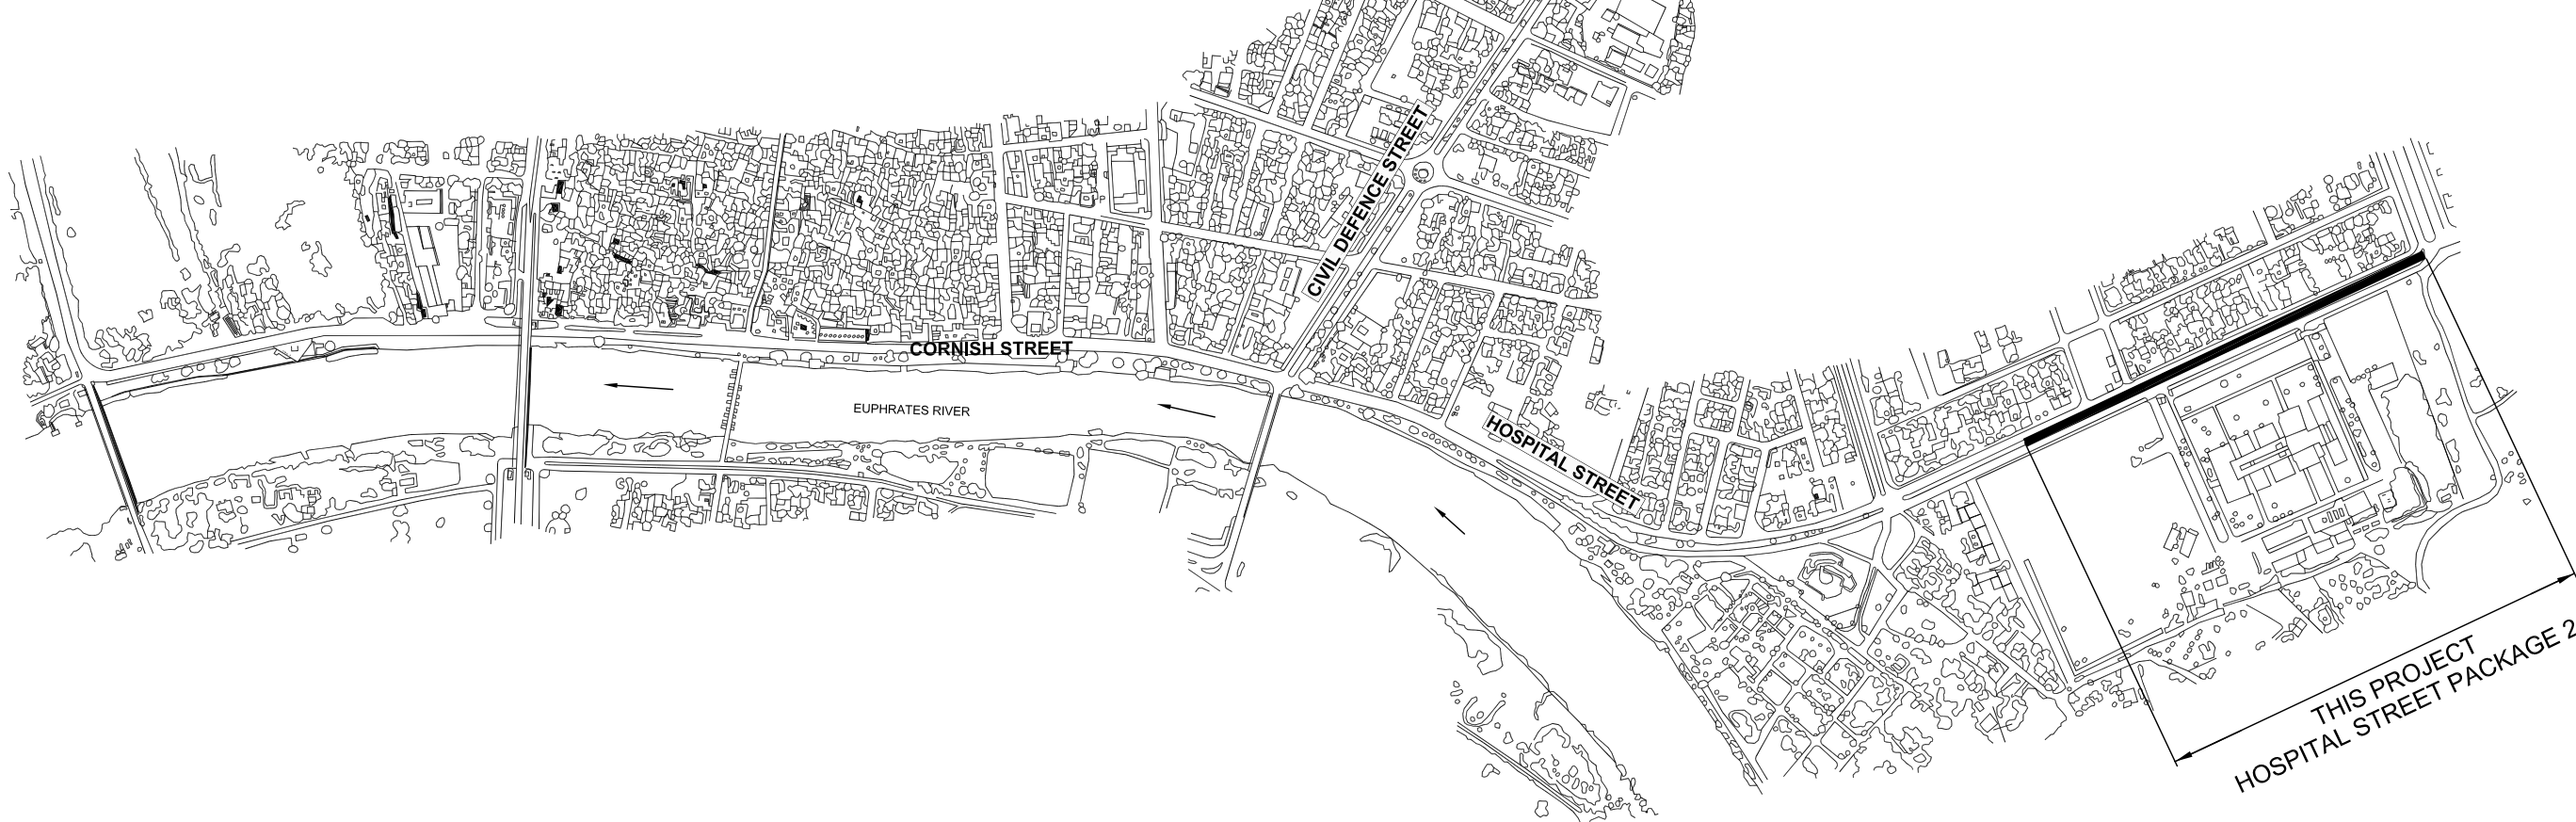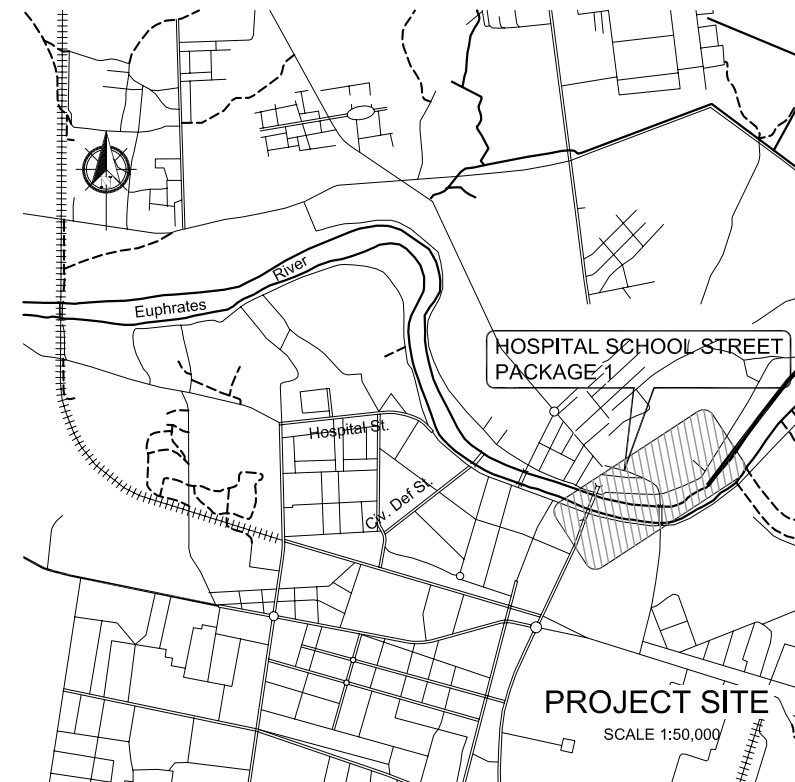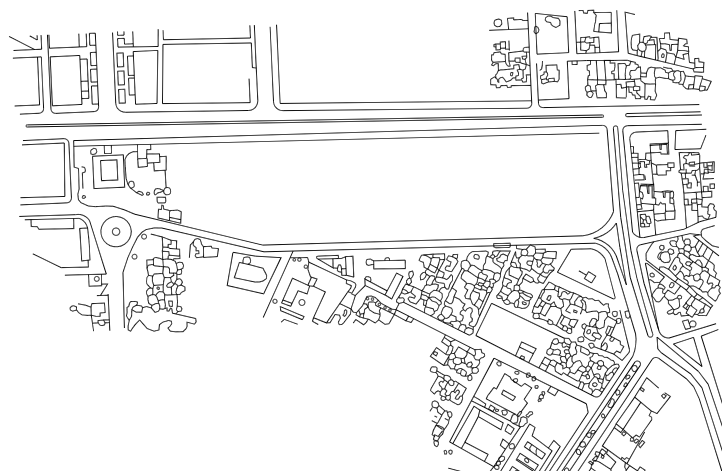


Owner: SAMAWAH MAYORALTY MUTHANNA GOVERNORATE REPUBLIC OF IRAQ	Consultant:	Client :	Project : REHABILITATION AND IMPROVEMENT OF THE ROADS AND ROAD SIDES IN SAMAWAH FOR SAMAWAH PROMENADE DEVELOPMENT PLAN	Drawing No. A-1	Rev:	Drawn by :
			Dwg Title: HOSPITAL STREET (PACKAGE 2) LOCATION MAP & SITE PLAN	Scale	Date:	Checked by:

TYPICAL ROAD CROSS SECTION


STA. 0+930 to STA. 1+050
SCALE NTS

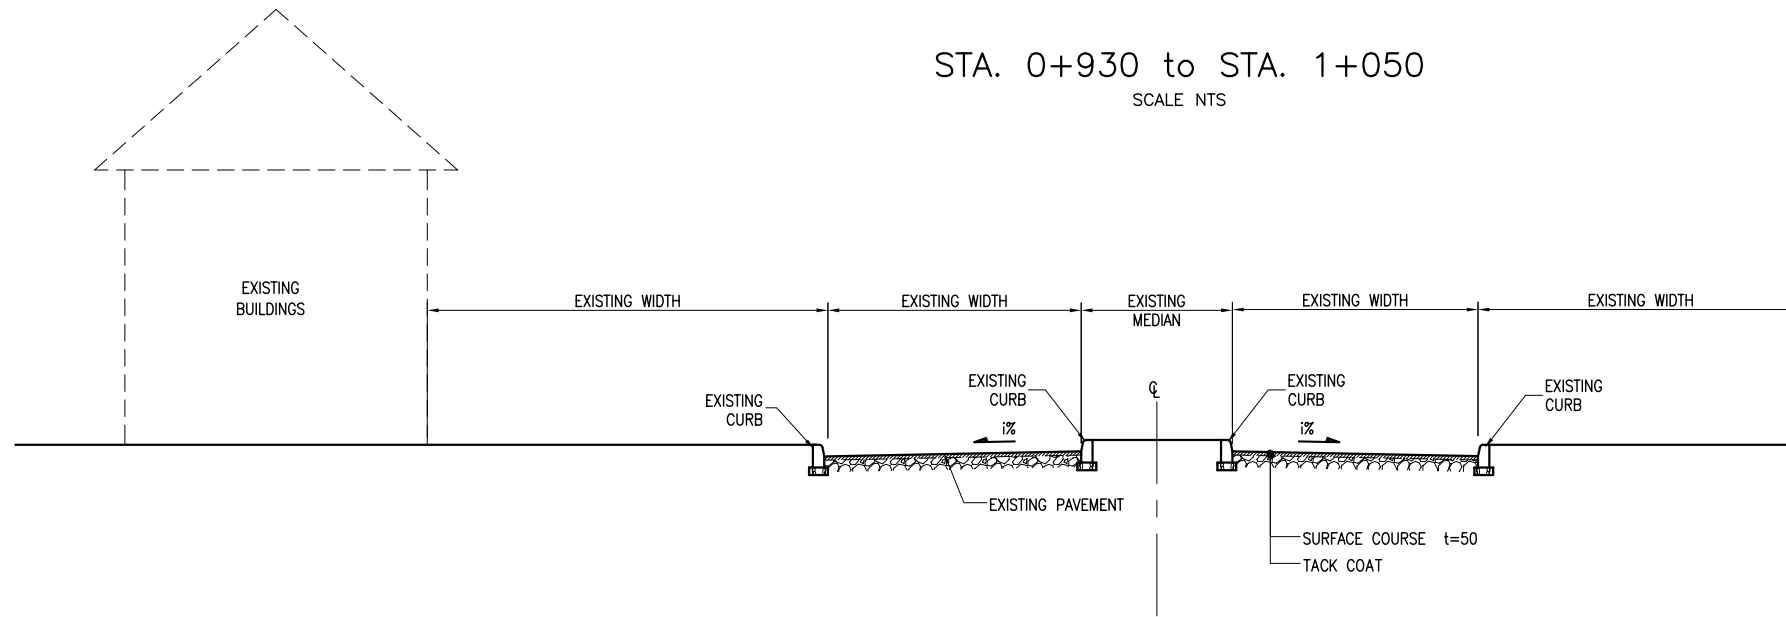

CURB TYPE-A
SCALE 1:30

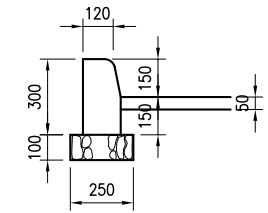

STA. 1+050 to STA. 1+370
SCALE NTS

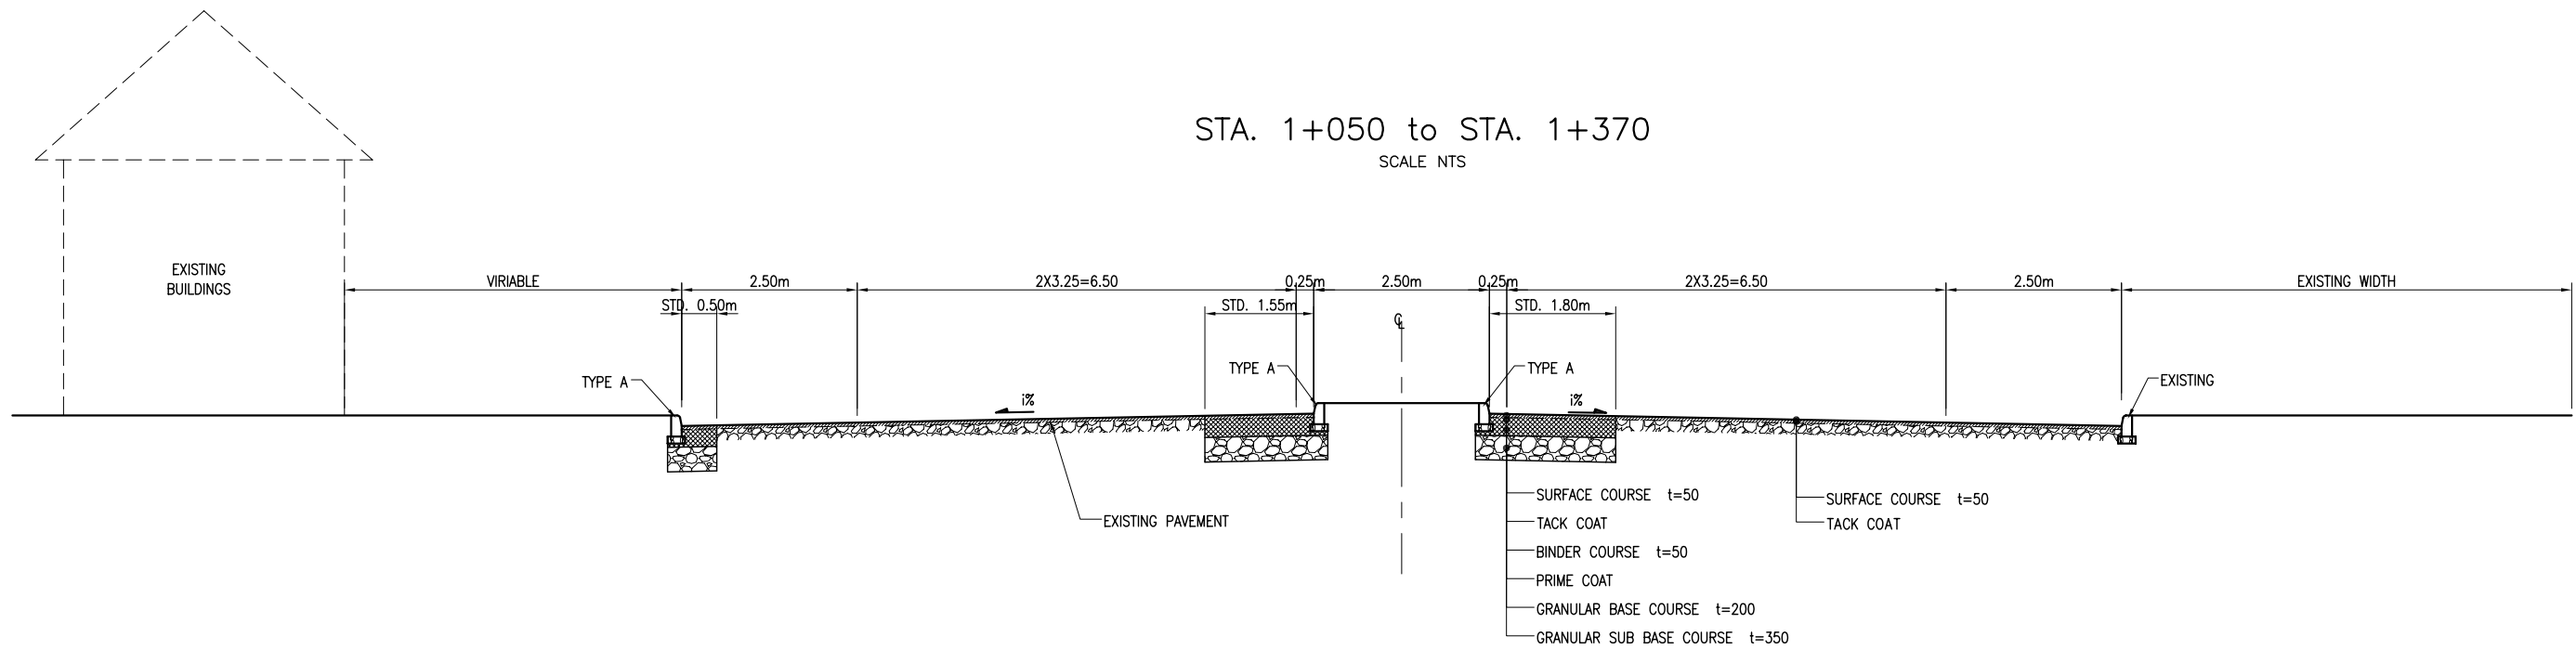


H:\SAMAWAH\JUNE 18, 2005\PACKAGE 2\101B) B-1 TYPICAL CROSS SECTION.DWG a3 Jun 18, 2005-4:15 PM

Owner: SAMAWAH MAYORALTY MUTHANNA GOVERNORATE REPUBLIC OF IRAQ	Consultant:	Client :	Project : REHABILITATION AND IMPROVEMENT OF THE ROADS AND ROAD SIDES IN SAMAWAH FOR SAMAWAH PROMENADE DEVELOPMENT PLAN	Drawing No. B-1	Rev:	Drawn by :
			Dwg Title: HOSPITAL STREET (PACKAGE 2) TYPICAL CROSS SECTION	Scale AS SHOWN	Date:	Checked by:




PLAN SCALE 1:500

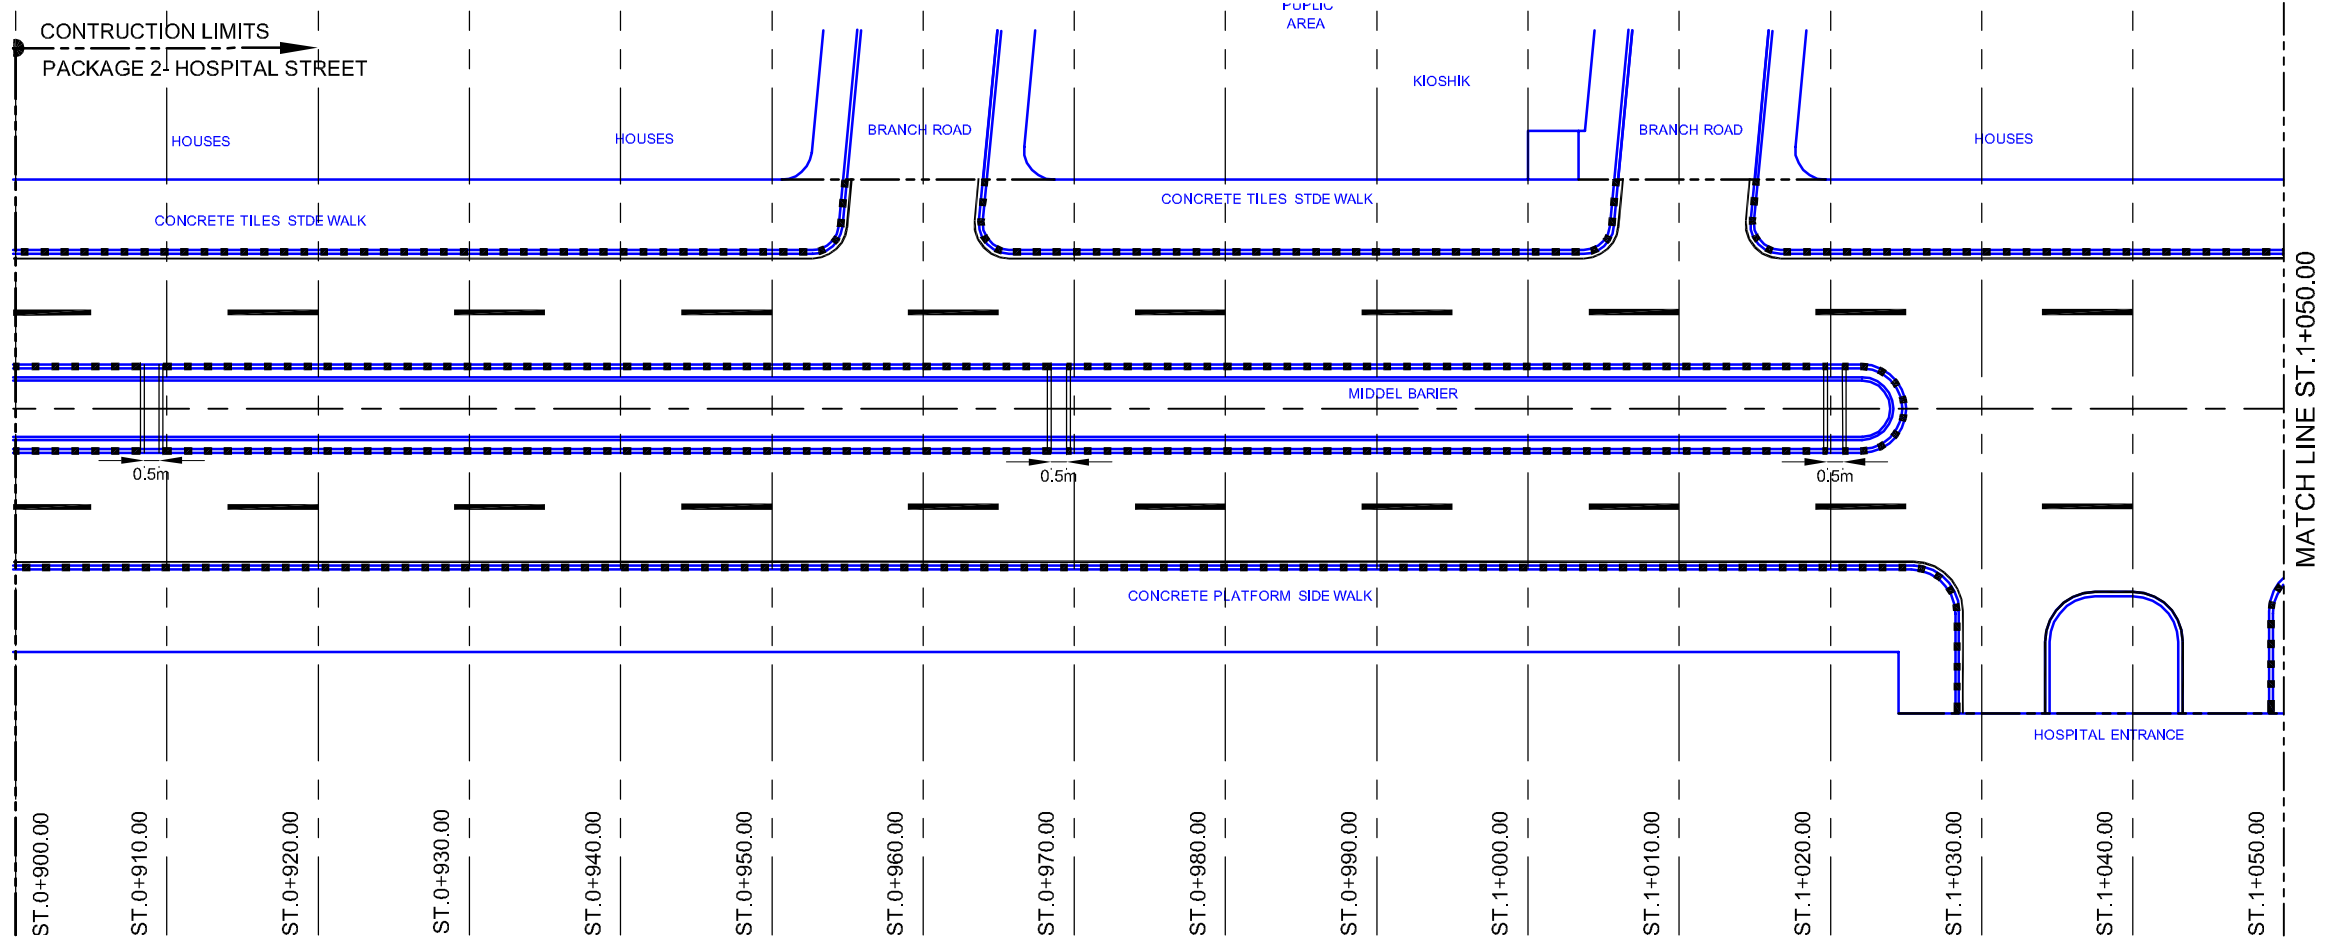

NOTE:
ALL THE EXISTING LAYOUTS ARE IN BLUE
ALL THE PROPOSED LAYOUT ARE IN BLACK
CENTRELINE OF STREET IN THE MIDDLE BARRIER

PROFILE

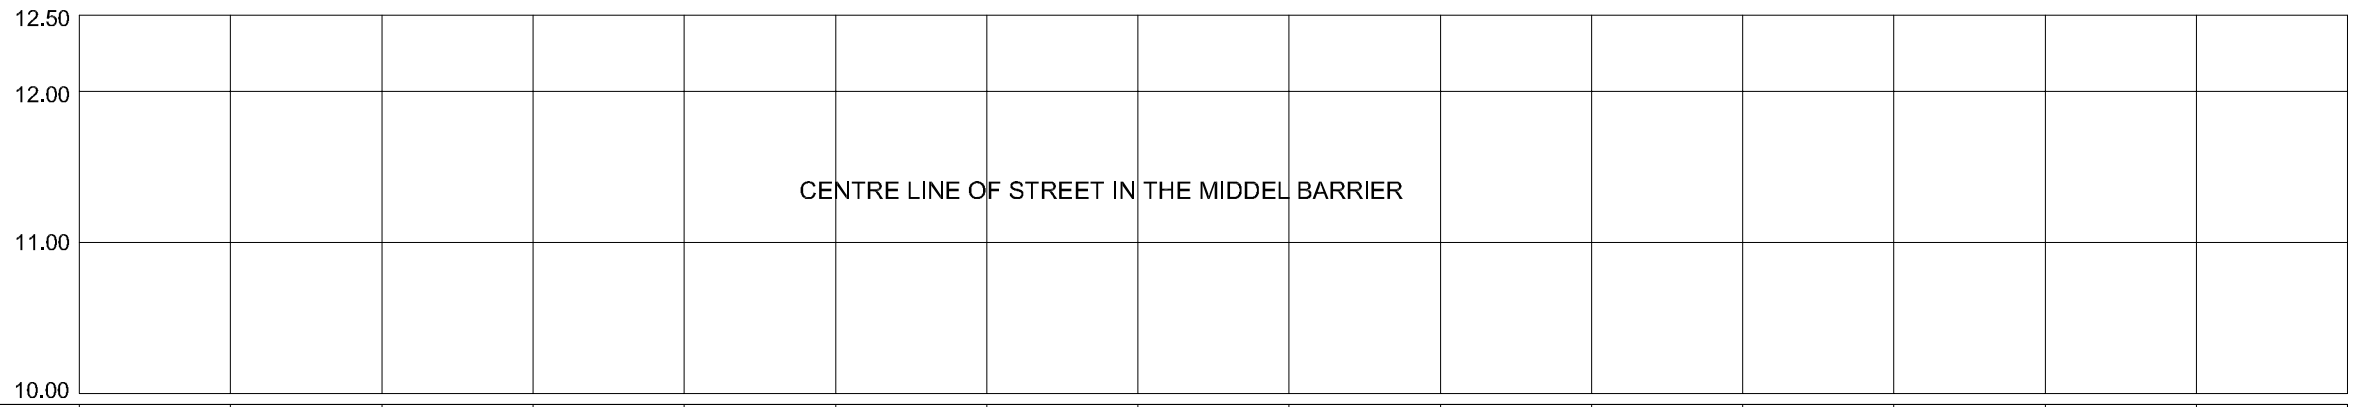

C.L. ELEVATION		10.883	10.883	10.913	10.903	10.904	10.901	10.878	10.893	10.883	10.884	10.857	10.858	10.820	10.781	10.797	10.785
C.L. COORDINATE (U.T.M. SYSTEM)	N:	0526228	0526219	0526209	0526199	0526189	0526179	0526169	0526159	0526149	0526139	0526129	0526120	0526110	0526100	0526090	0526080
	E:	3465123	3465121	3465120	3465119	3465118	3465117	3465116	3465115	3465114	3465113	3465112	3465110	3465109	3465108	3465107	3465106
STATION		0+900.00	0+910.00	0+920.00	0+930.00	0+940.00	0+950.00	0+960.00	0+970.00	0+980.00	0+990.00	1+000.00	1+010.00	1+020.00	1+030.00	1+040.00	1+050.00

PROFILE SECTION OF HOSPITAL STREET (900.00 - 1050.00)m

Owner: SAMAWAH MAYORALTY MUTHANNA GOVERNORATE REPUBLIC OF IRAQ	Consultant:	Client :	Project : REHABILITATION AND IMPROVEMENT OF THE ROADS AND ROAD SIDES IN SAMAWAH FOR SAMAWAH PROMENADE DEVELOPMENT PLAN	Drawing No. C-1	Rev:	Drawn by :
			Dwg Title: HOSPITAL STREET (PACKAGE 2) PLAN & PROFILE (1-4)	Scale AS SHOWN	Date:	Checked by: