


Single Line Diagram

Accra

A ODORKOR 11kv NETWORK


Approved
Checked
Scale
Date
Dec. 2005

Surveyed	B-J.KUMFO	Approved	B.AKINYATE
Drawn	TFIO CECIL	Checked	B-J.KUMFO
Date		Scale	
		Date	

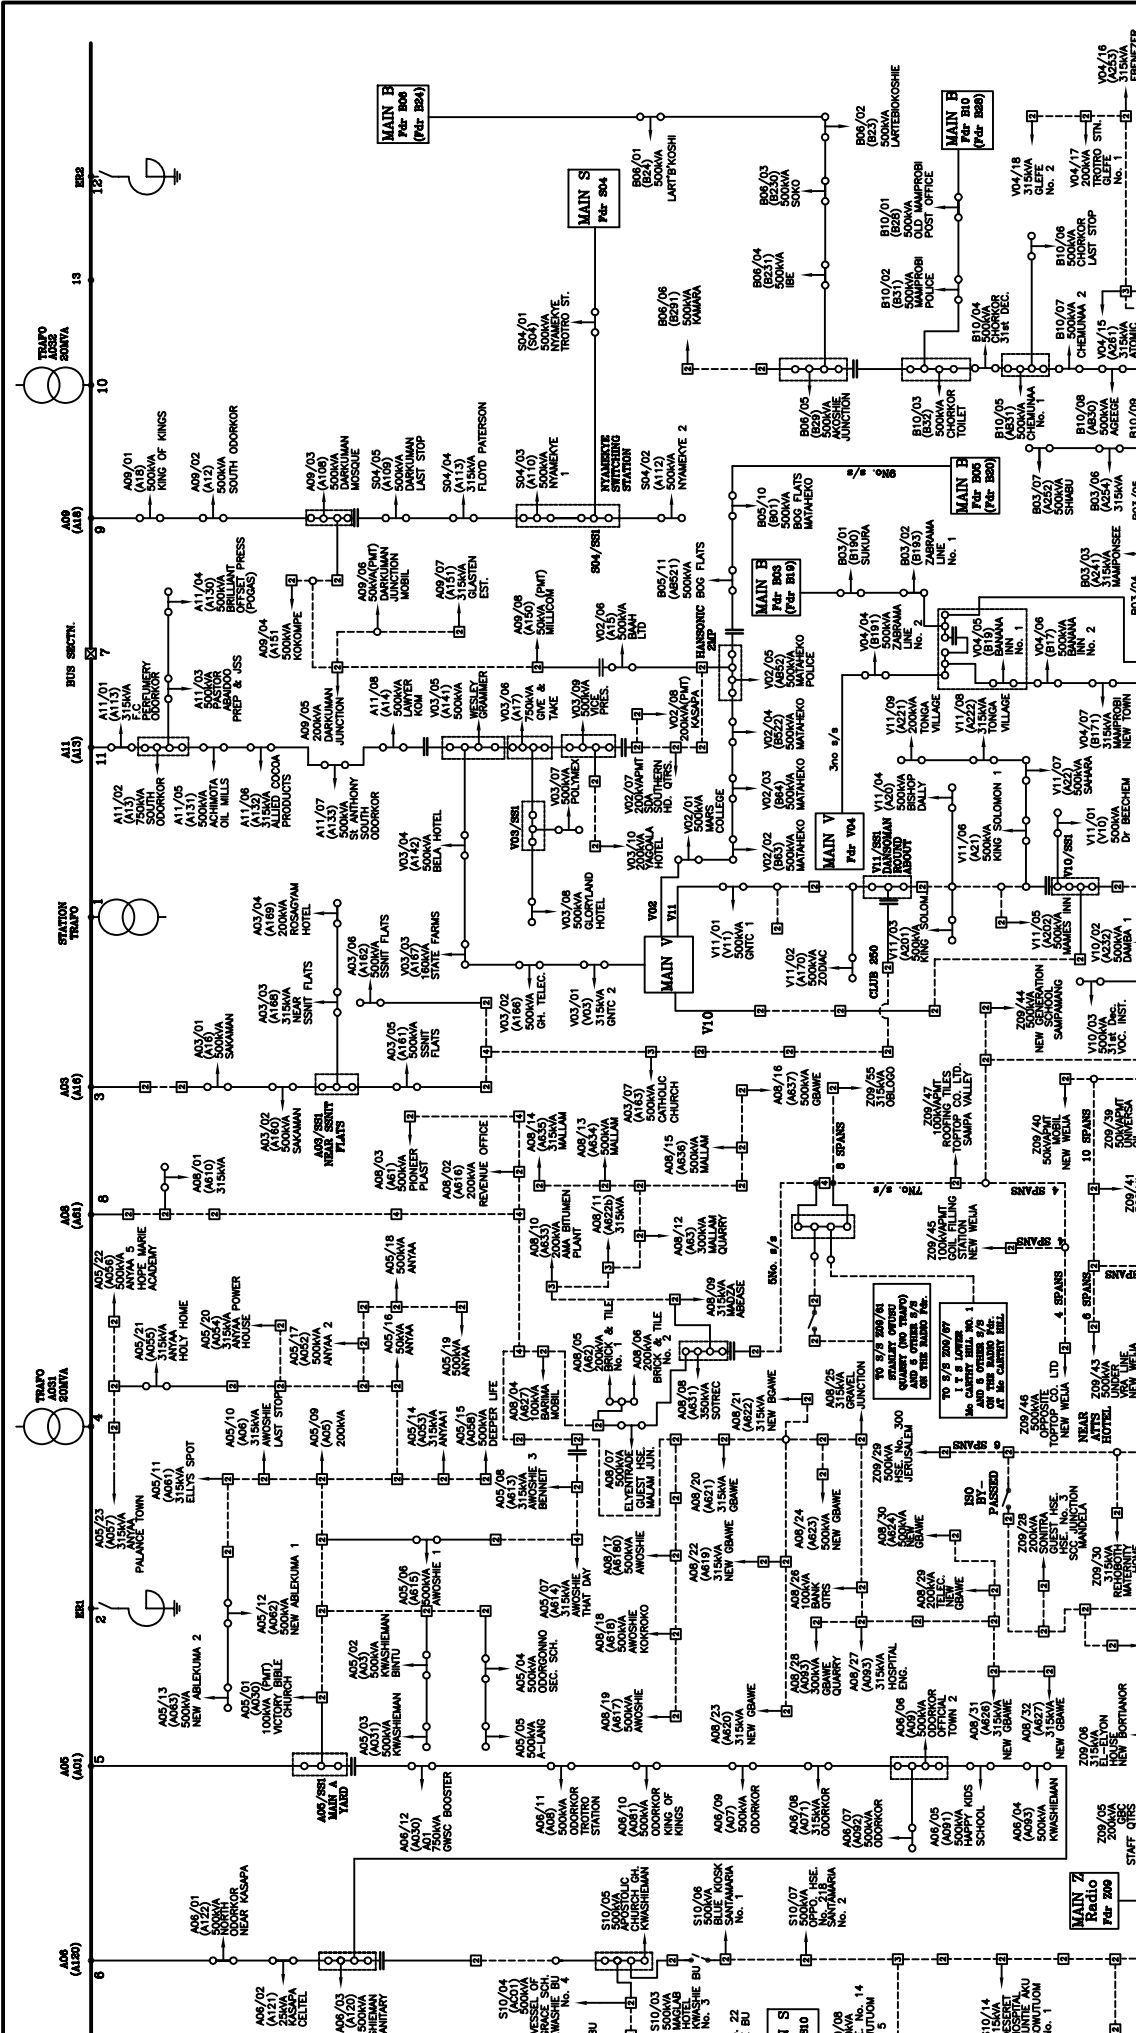

Radio

S10/09	ASSEMBLIES OF GOD, CH. HSE. SOWUTUM No. 6
S10/10	SOWUTUM No. 7
S10/11	PACER COURSE SOWUTUM No. 4
S10/12	RESOLVE POINT SOWUTUM No. 14
S10/13	SOWUTUM No. 12
S10/14	DESERT SOWUTUM No. 1
S10/15	KINGDOM OF GOD, CH. HSE. SOWUTUM No. 2
S10/16	PACER COURSE SOWUTUM No. 4
S10/17	SOWUTUM No. 22
S10/18	SOWUTUM No. 4

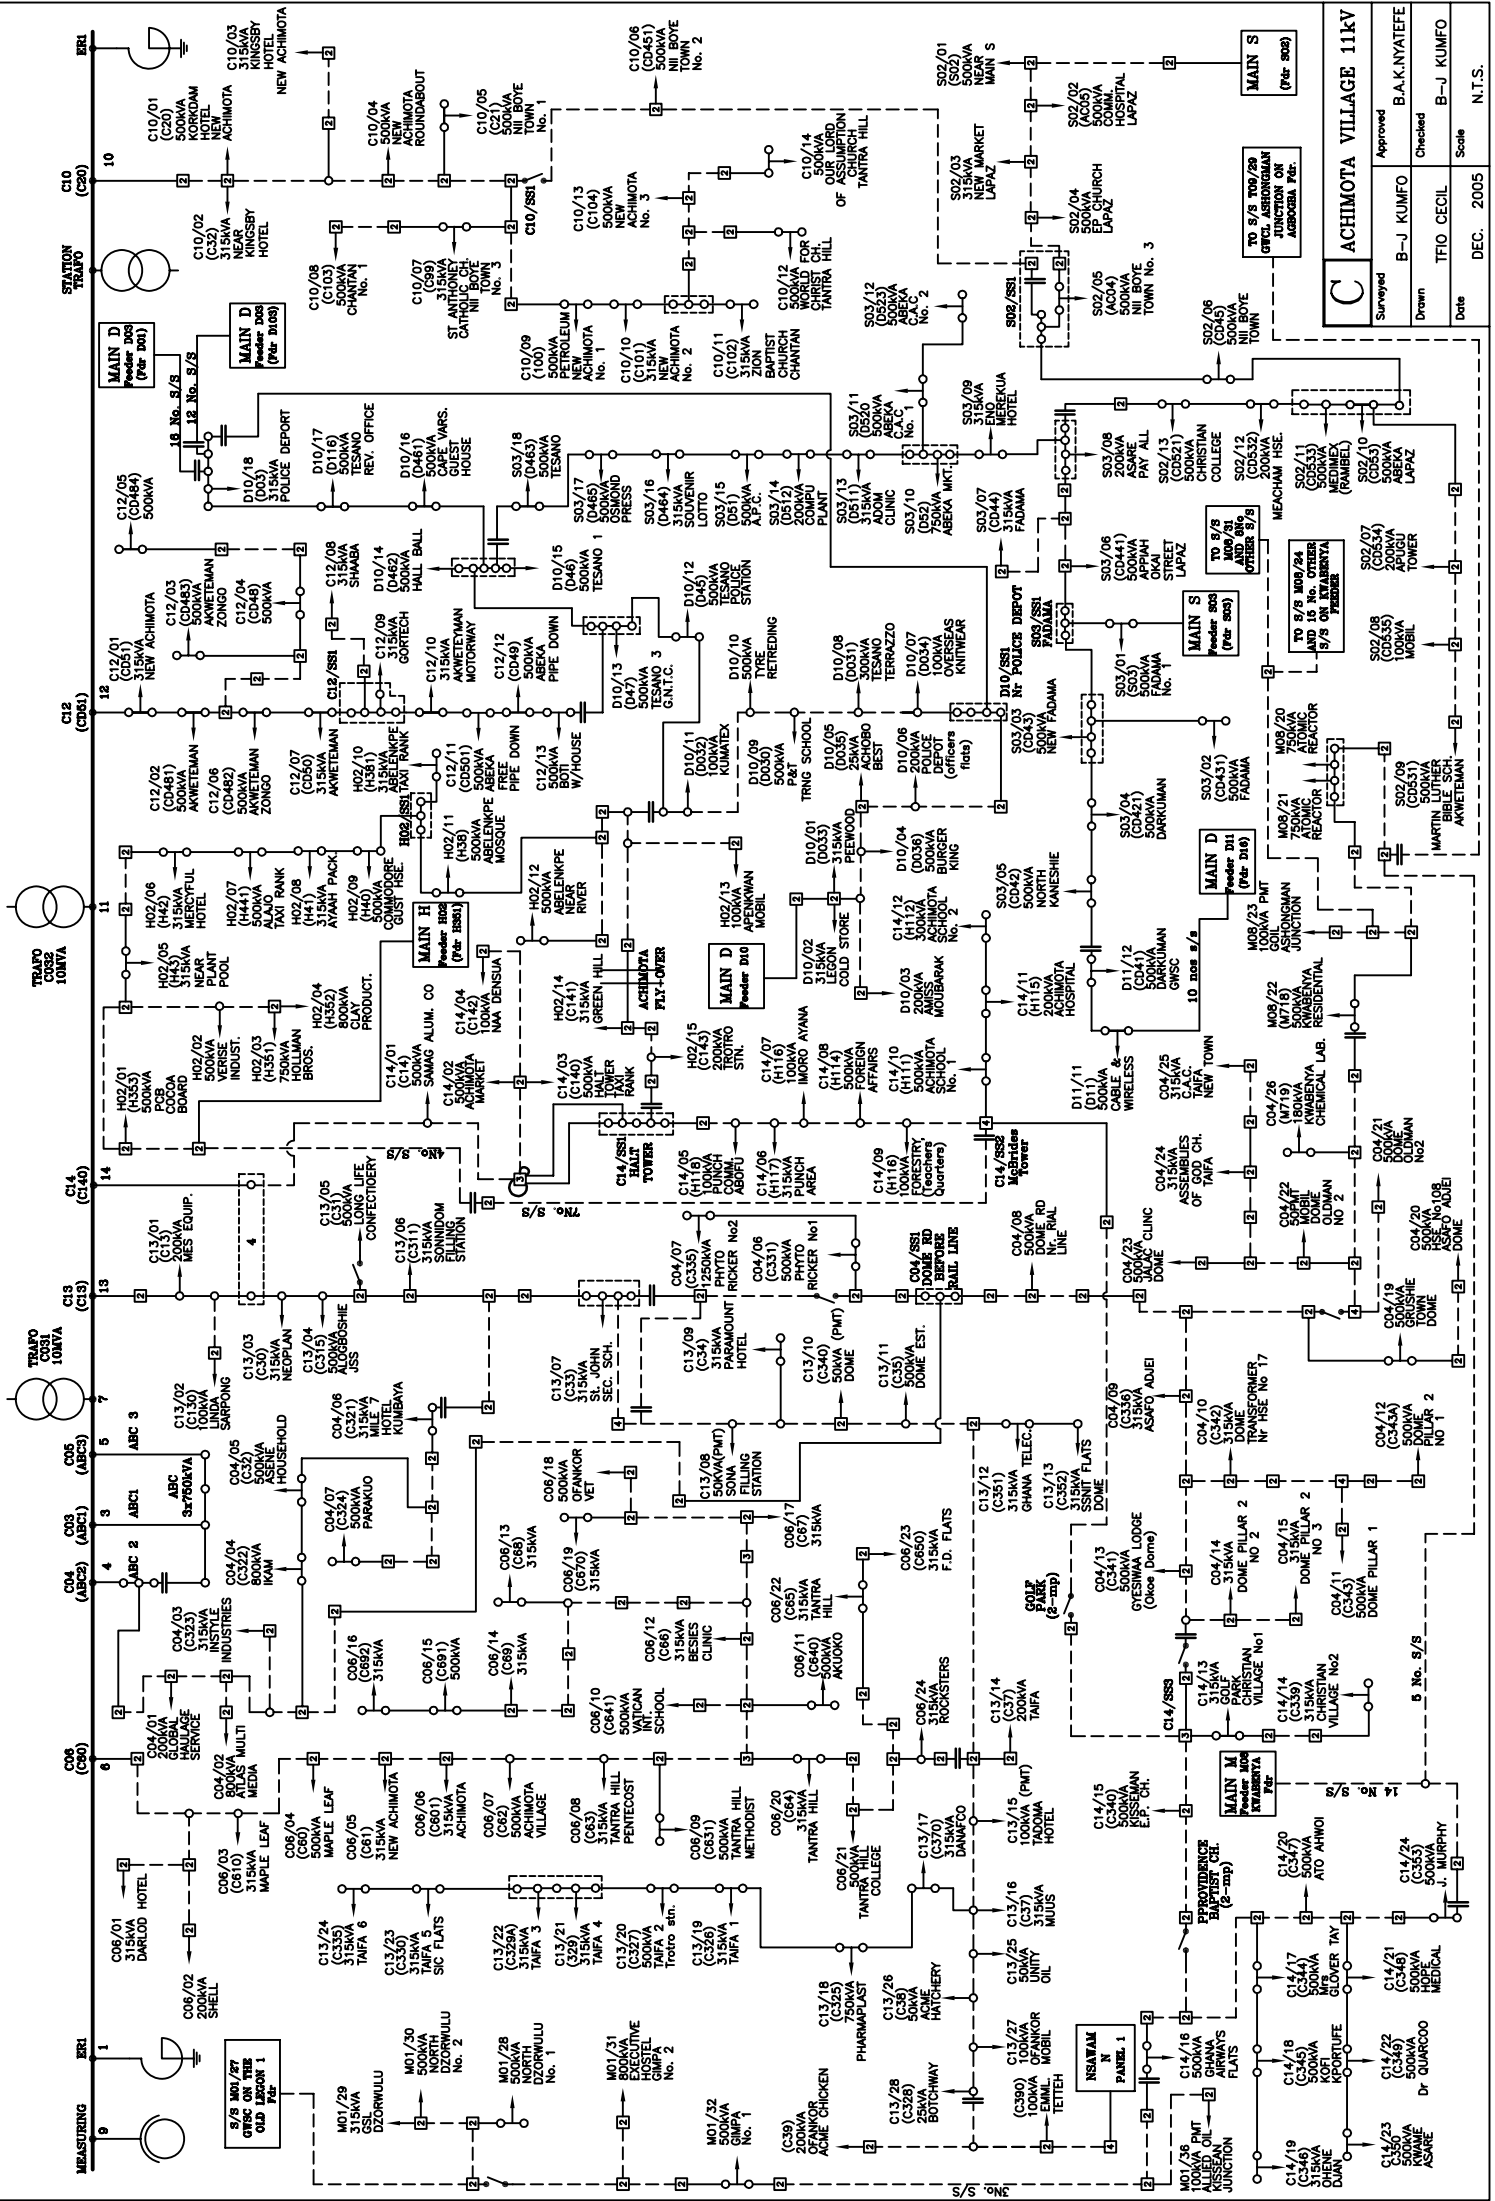

C ACHIMOTA VILLAGE 11KV		Approved	B.A.K. NYATEFE
		Checked	B.-J. KUMFO
Surveyed	T.F.O. CECIL	Date	DEC. 2005
Drawn	B.-J. KUMFO	Scale	N.T.S.

TO 9/5 TOR/09
OFFICE OF THE
MUNICIPAL
AUTHORITY
ACCRA

TO 9/5 TOR/09
OFFICE OF THE
MUNICIPAL
AUTHORITY
ACCRA

TO 9/5 TOR/09
OFFICE OF THE
MUNICIPAL
AUTHORITY
ACCRA


TO 9/5 TOR/09
OFFICE OF THE
MUNICIPAL
AUTHORITY
ACCRA

TO 9/5 TOR/09
OFFICE OF THE
MUNICIPAL
AUTHORITY
ACCRA


TO 9/5 TOR/09
OFFICE OF THE
MUNICIPAL
AUTHORITY
ACCRA

TO 9/5 TOR/09
OFFICE OF THE
MUNICIPAL
AUTHORITY
ACCRA


TO 9/5 TOR/09
OFFICE OF THE
MUNICIPAL
AUTHORITY
ACCRA

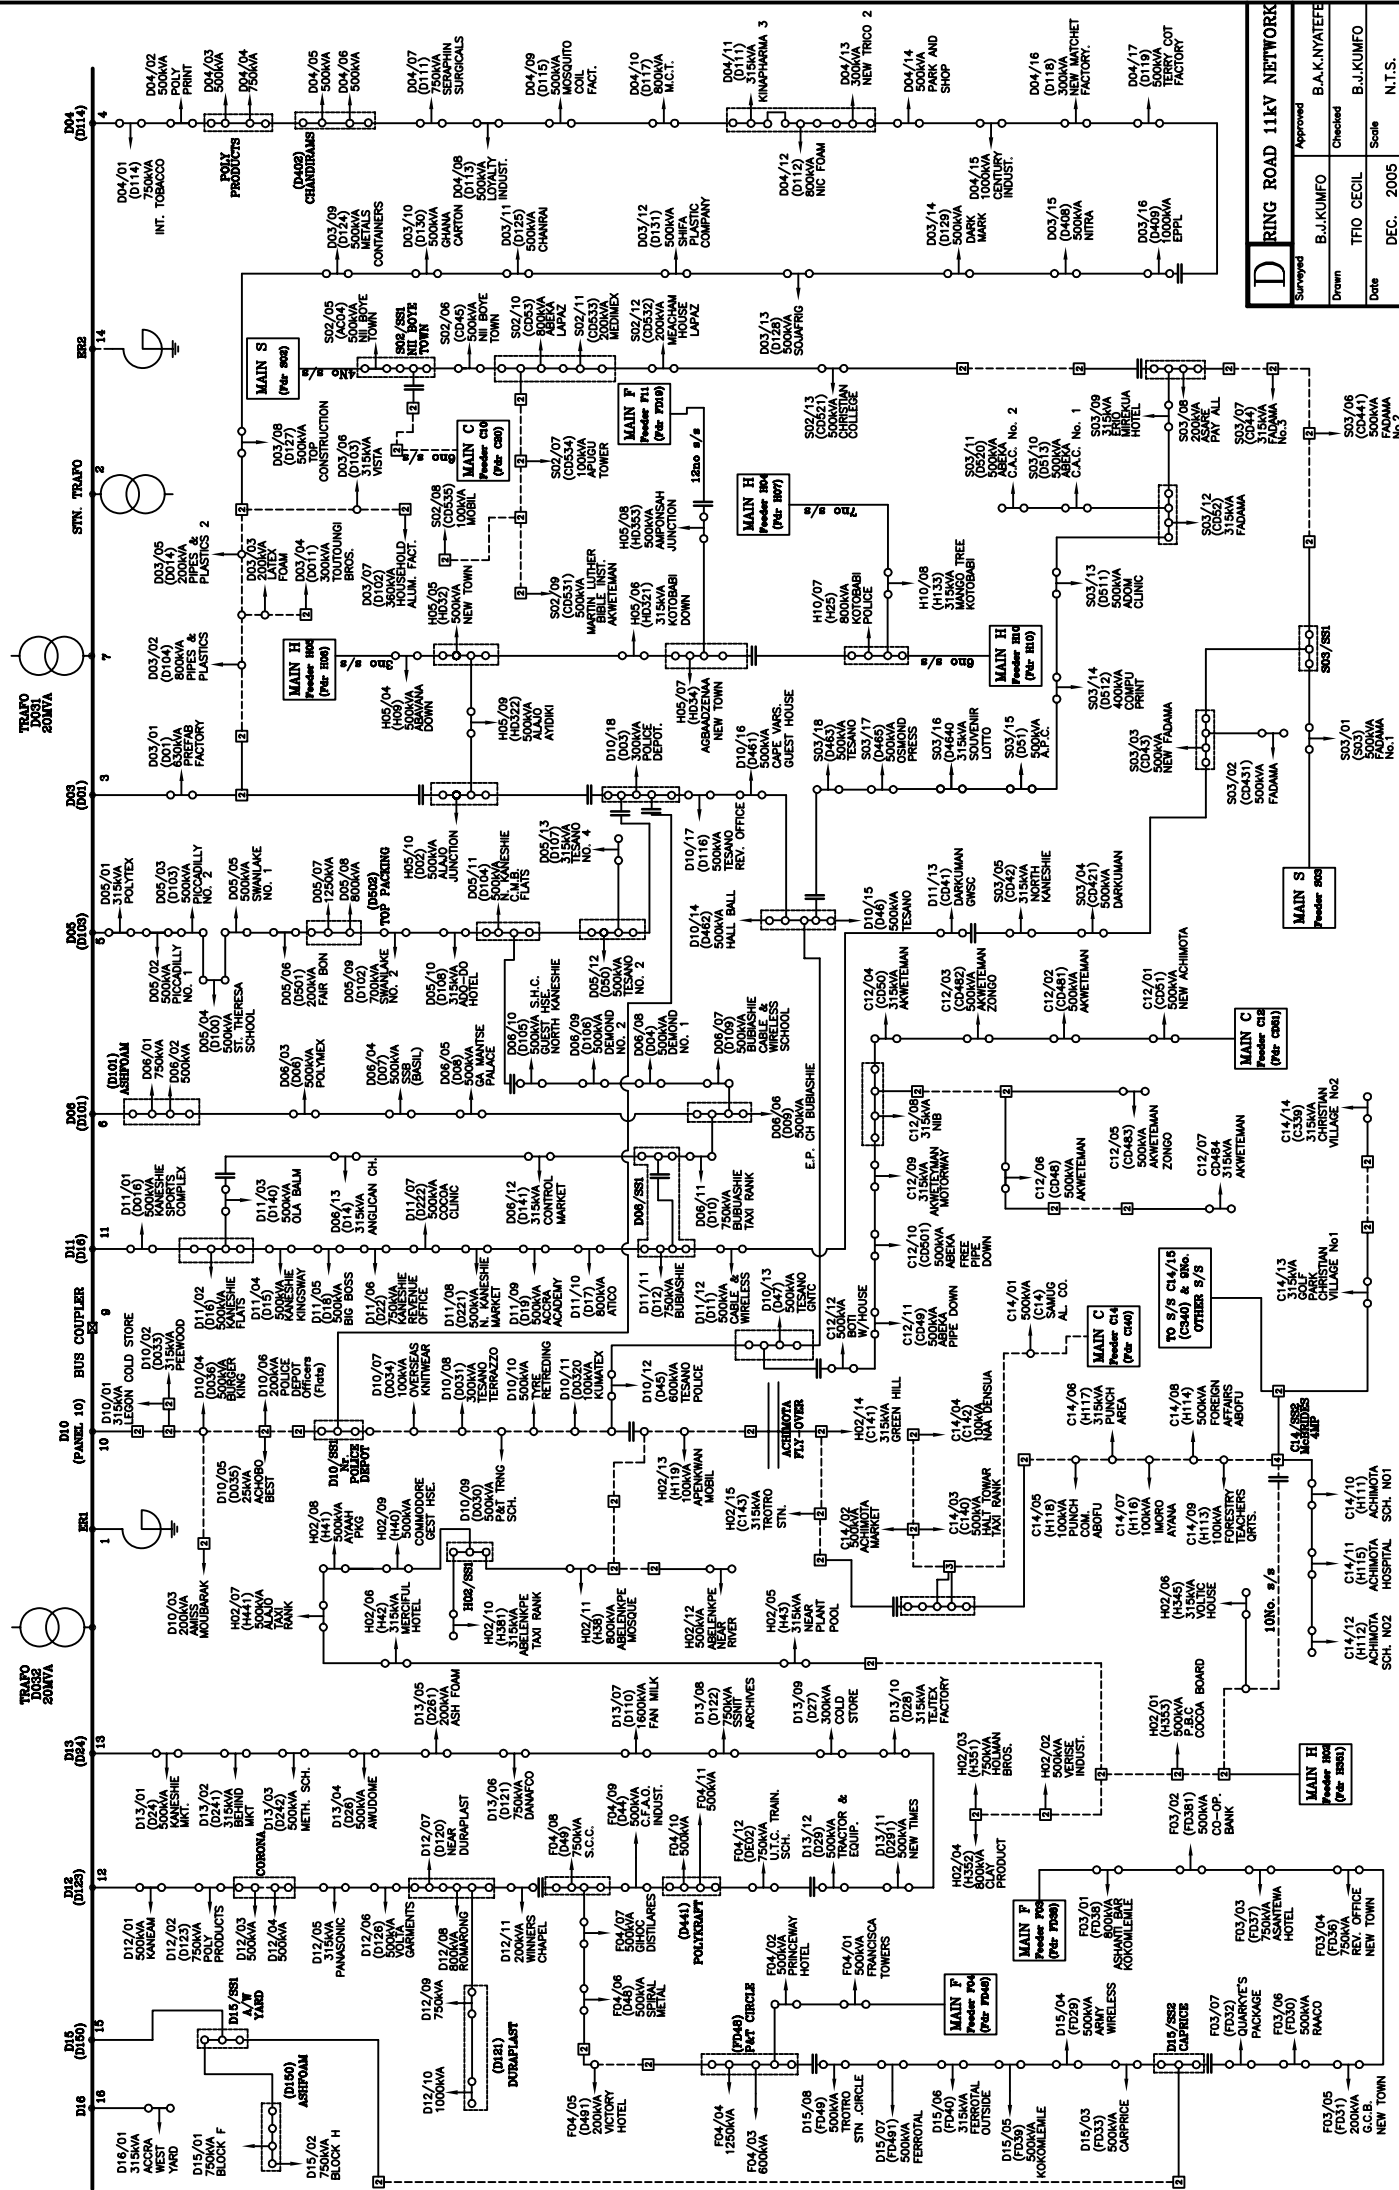

RING ROAD 11KV NETWORK			
Surveyed	Approved	Checked	Score
B.J.KUMFO	B.A.K.NYATEFE	T.FO. CECIL	B.J.KUMFO
Date			
DEC. 2005			N.T.S.

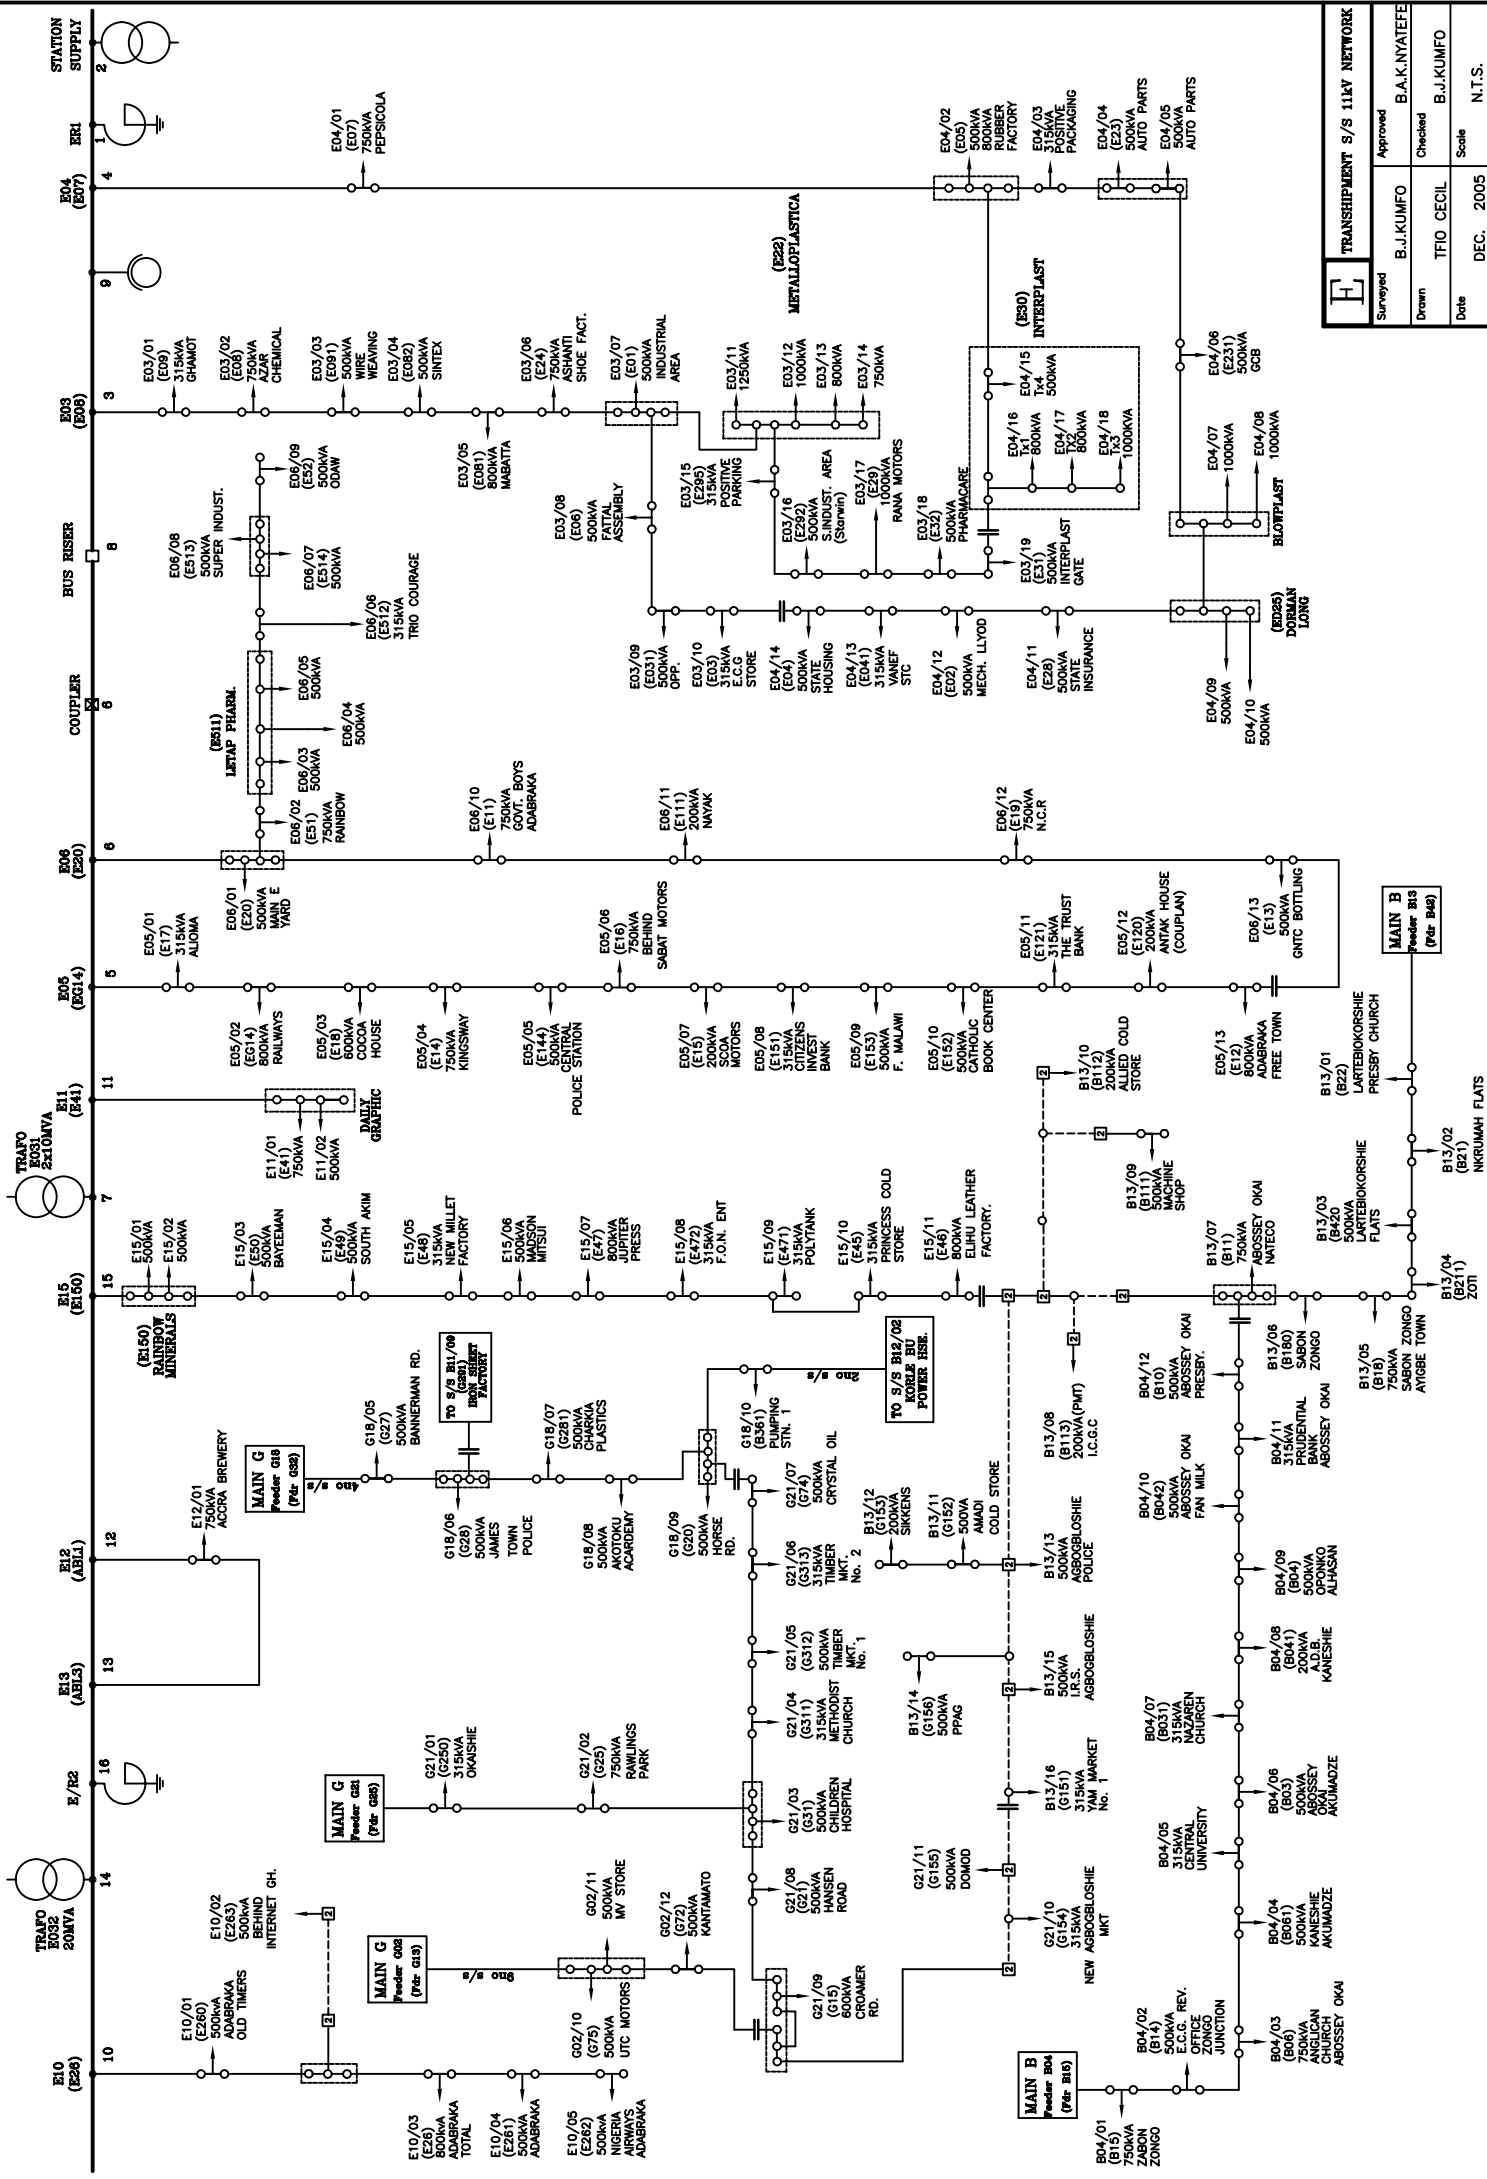


TRANSMISSION S/S 11KV NETWORK			
Surveyed	Approved	Checked	Scale
B.J.KUMFO	B.A.K.NYATEFE	T.FO CECIL	B.J.KUMFO
Date	DEC. 2005	N.T.S.	

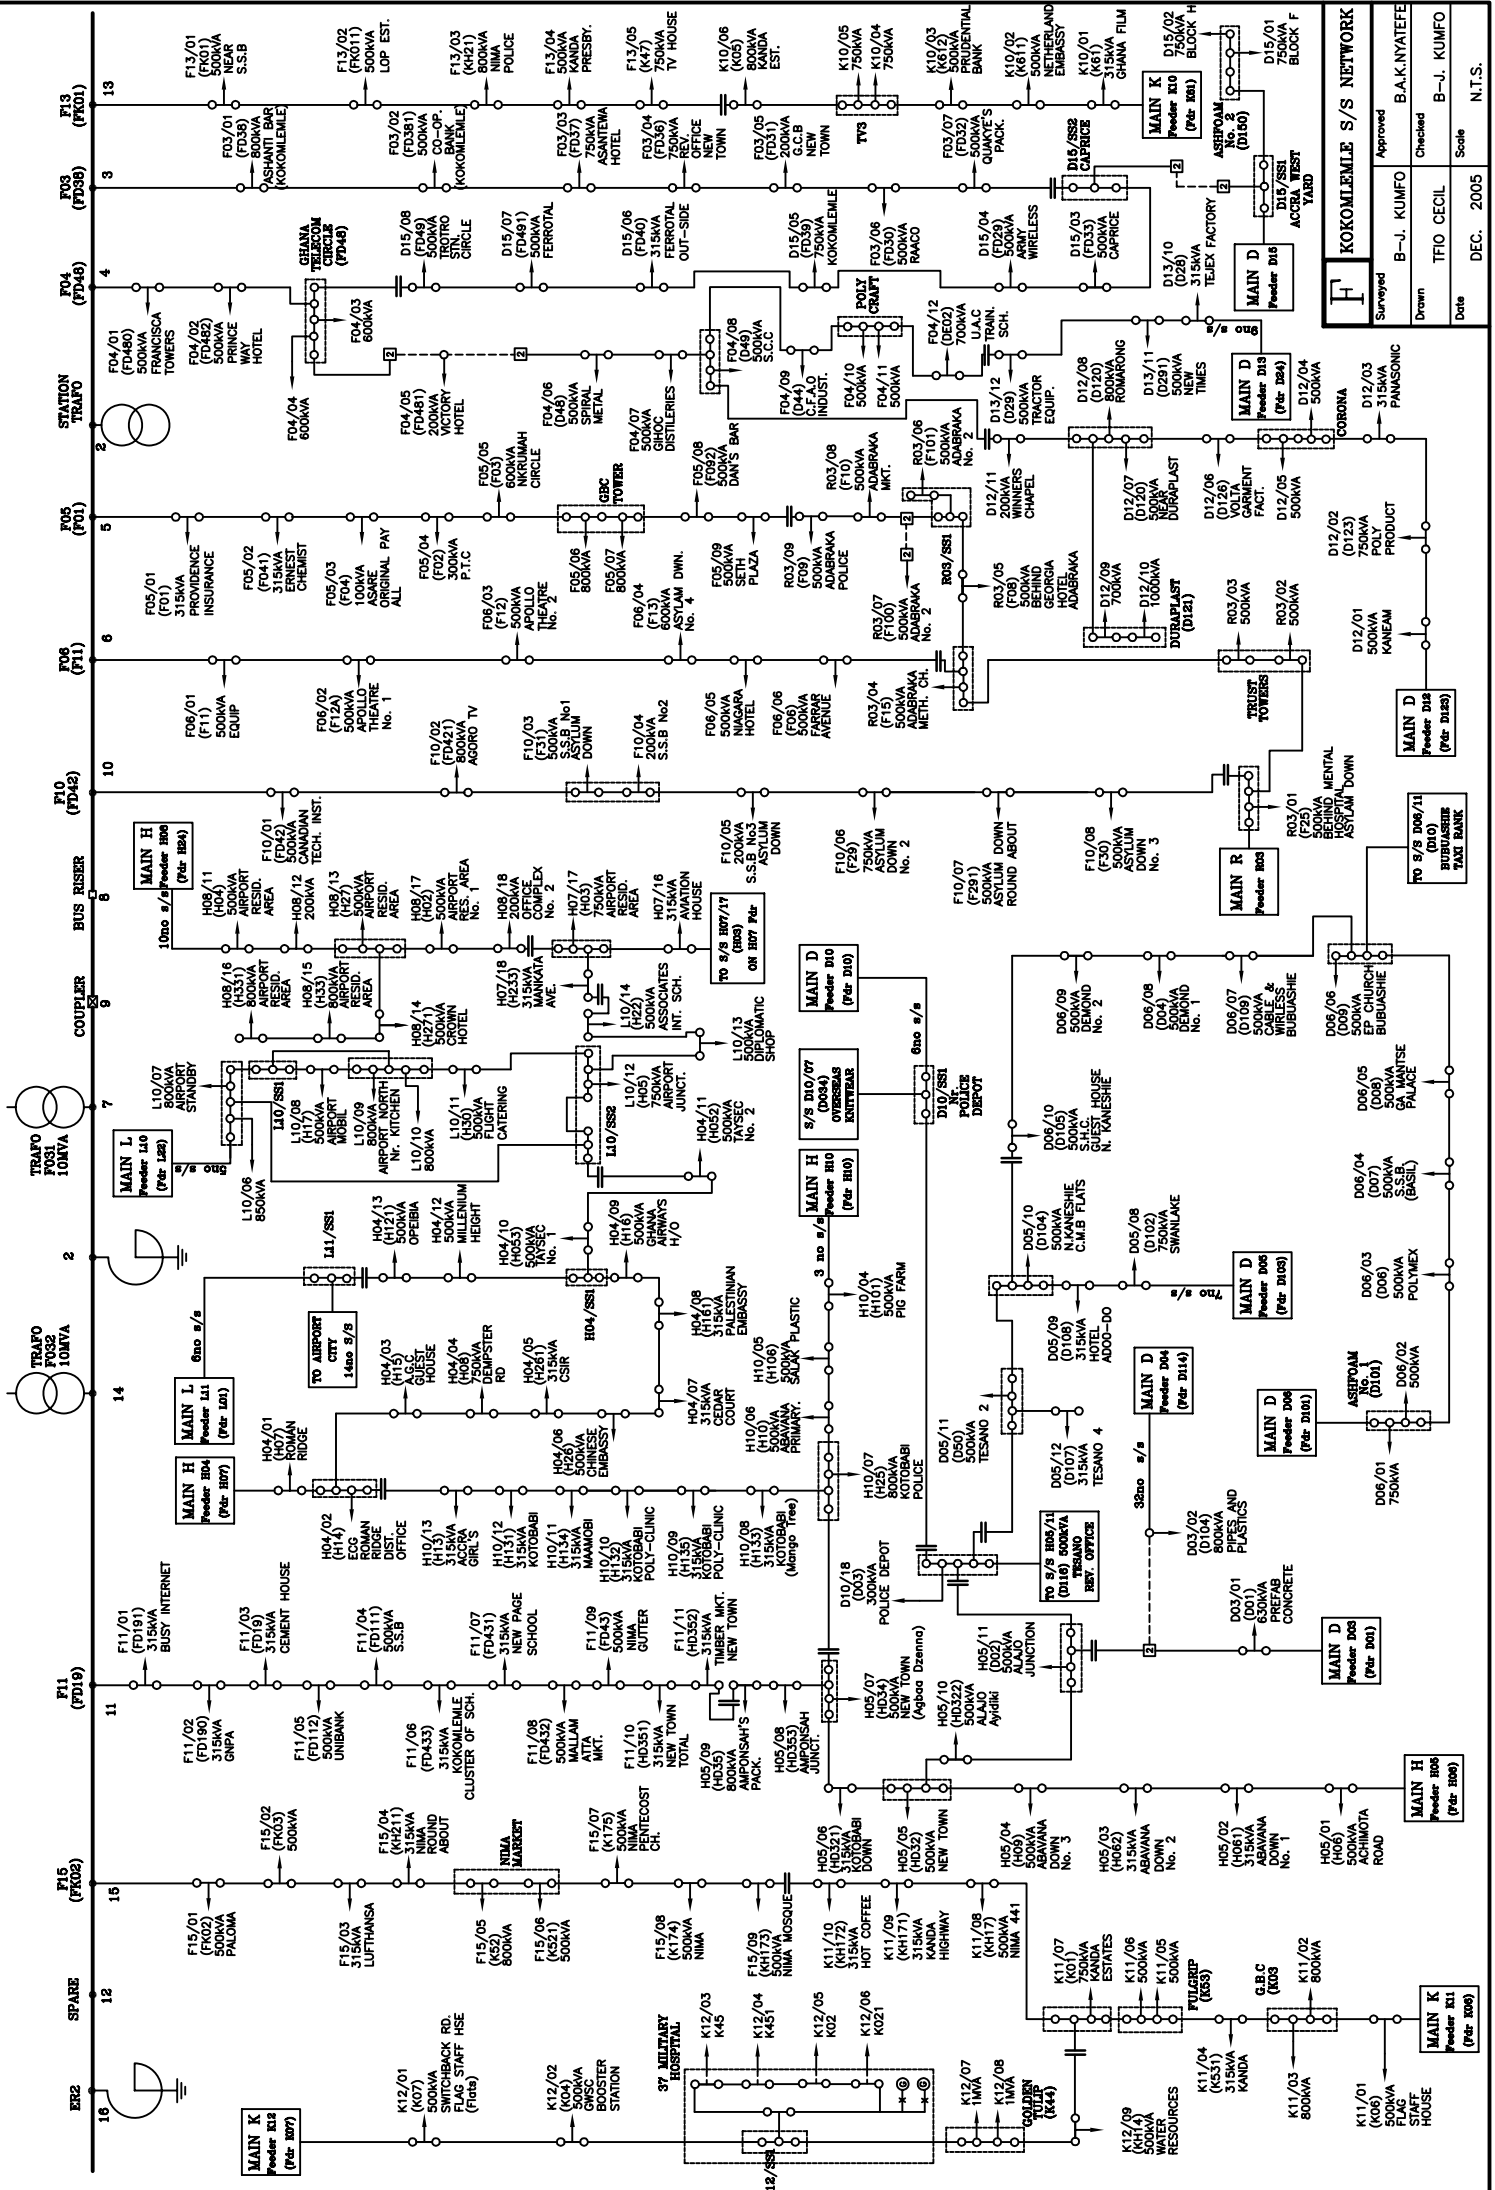



Checked	Approved	Scale
Surveied	B-A.K. NYATEFE	
Drawn	TFO CECIL	
Date	DEC. 2005	

Checked	Approved	Scale
Surveied	B-A.K. NYATEFE	
Drawn	TFO CECIL	
Date	DEC. 2005	

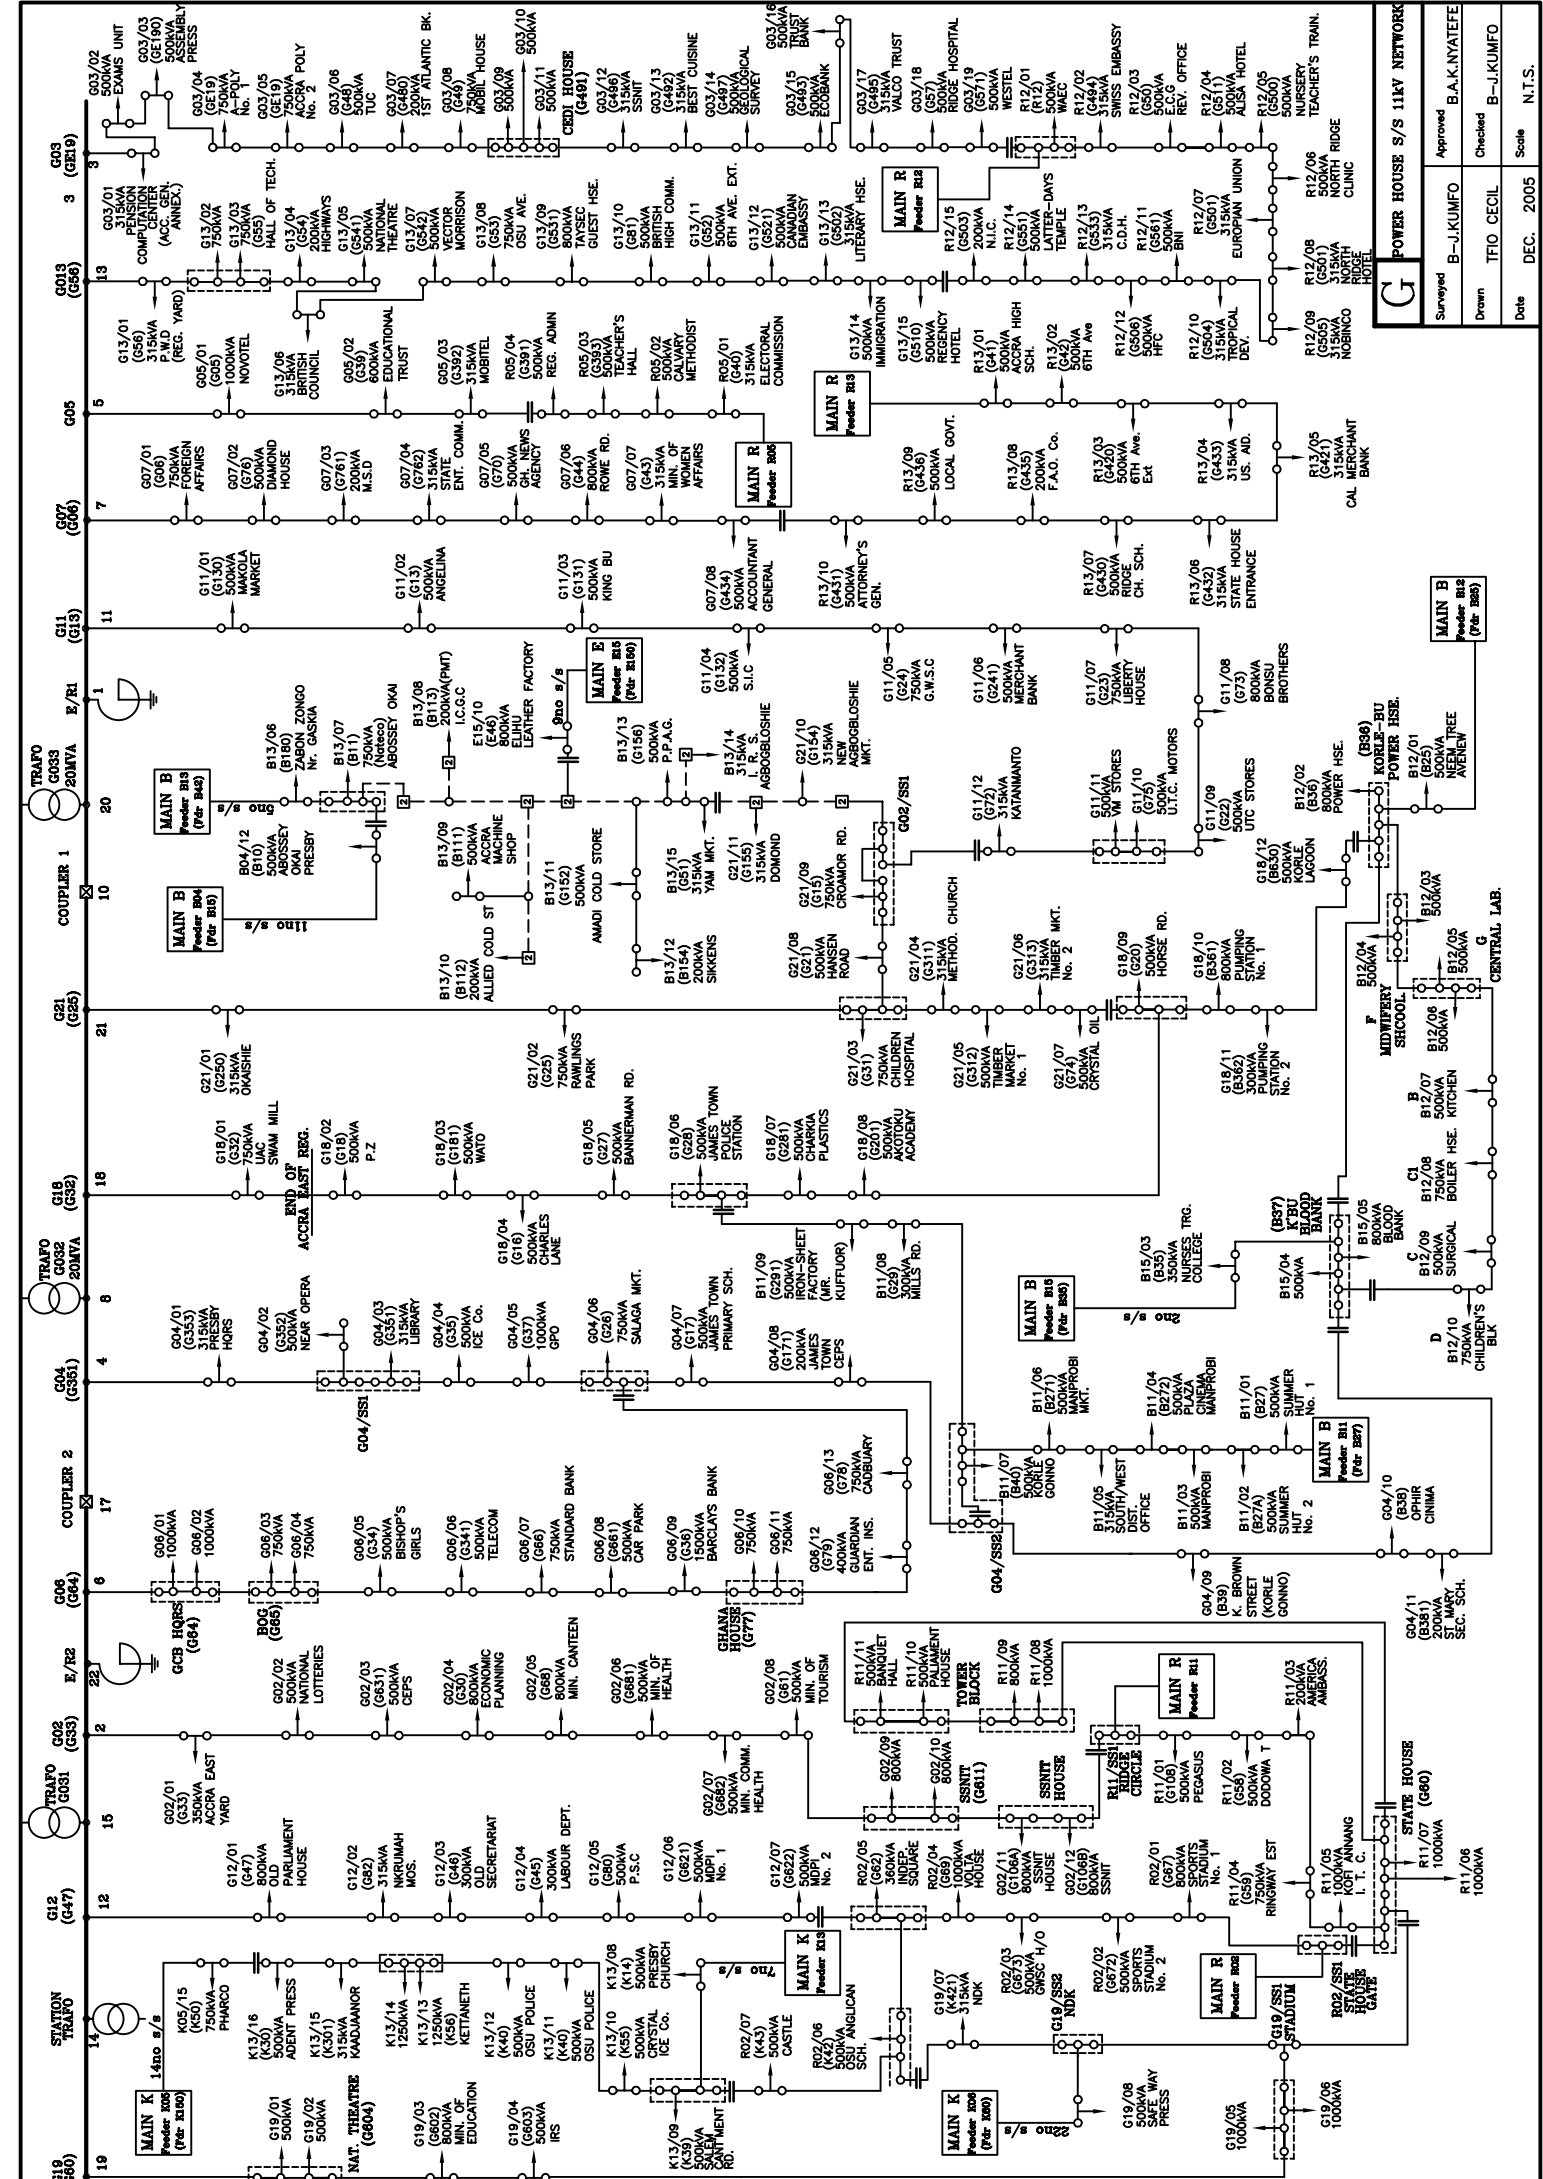

G POWER HOUSE S/S 11KV NETWORK		Approved	B.A.K. NYATEFE
		Surveyed	B.-J.KUMFO
Drawn	T.FIO CECIL	Checked	B.-J.KUMFO
Date	DEC. 2005	Scale	N.T.S.

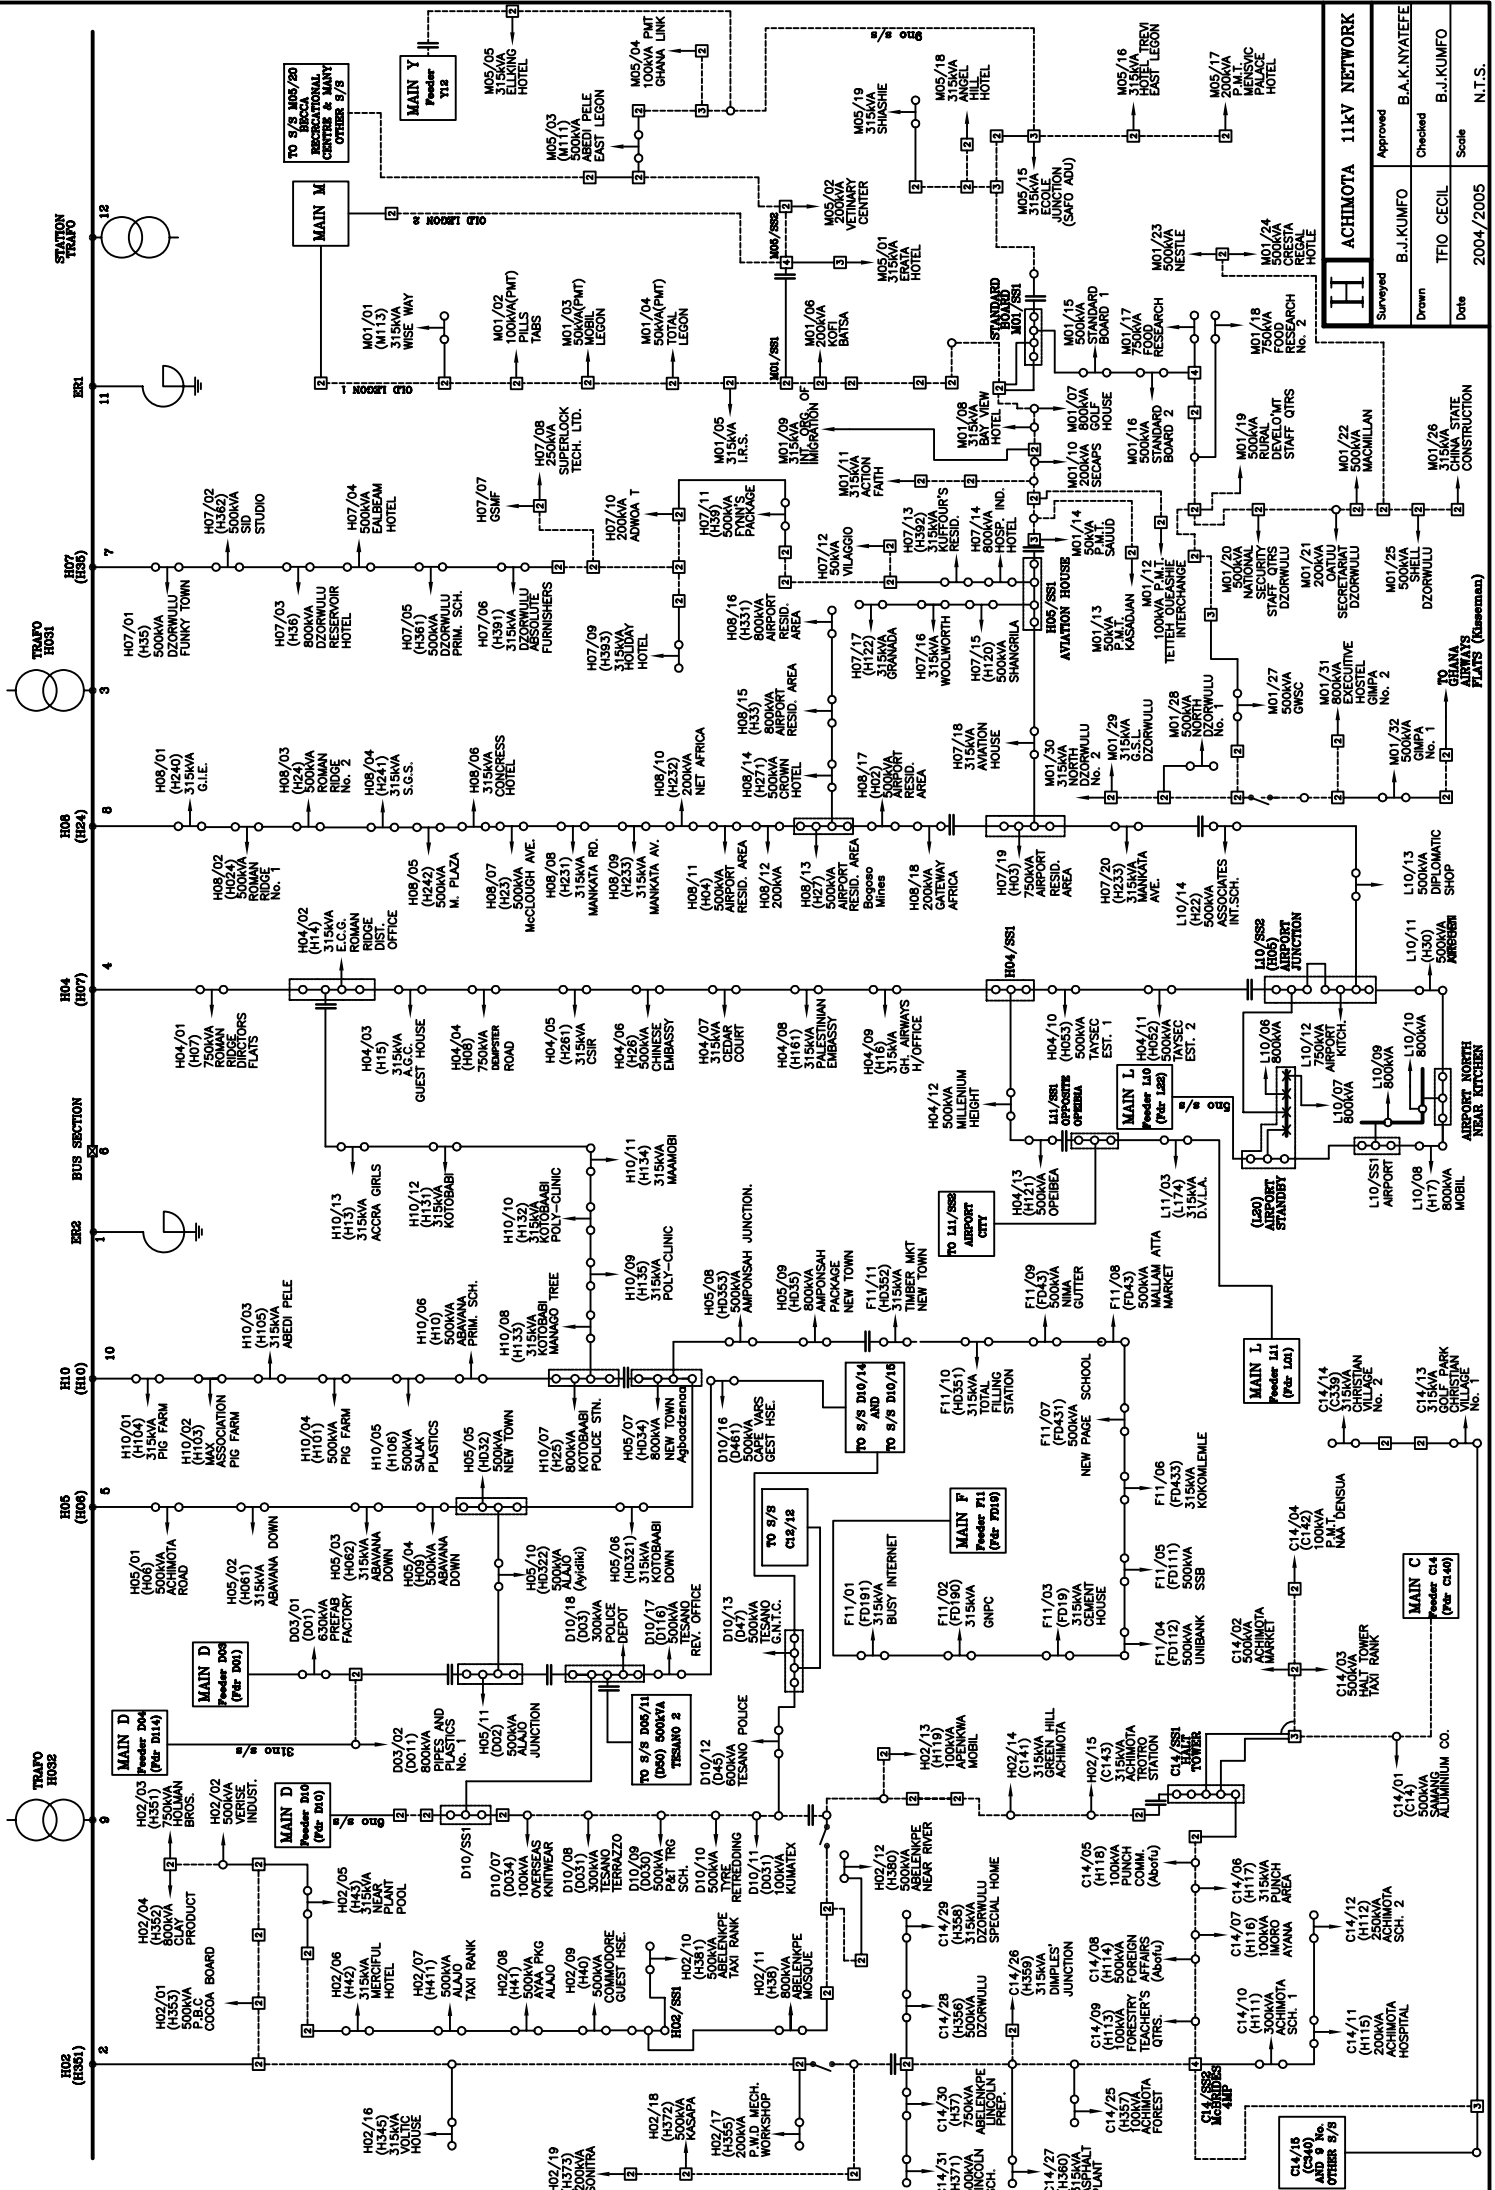

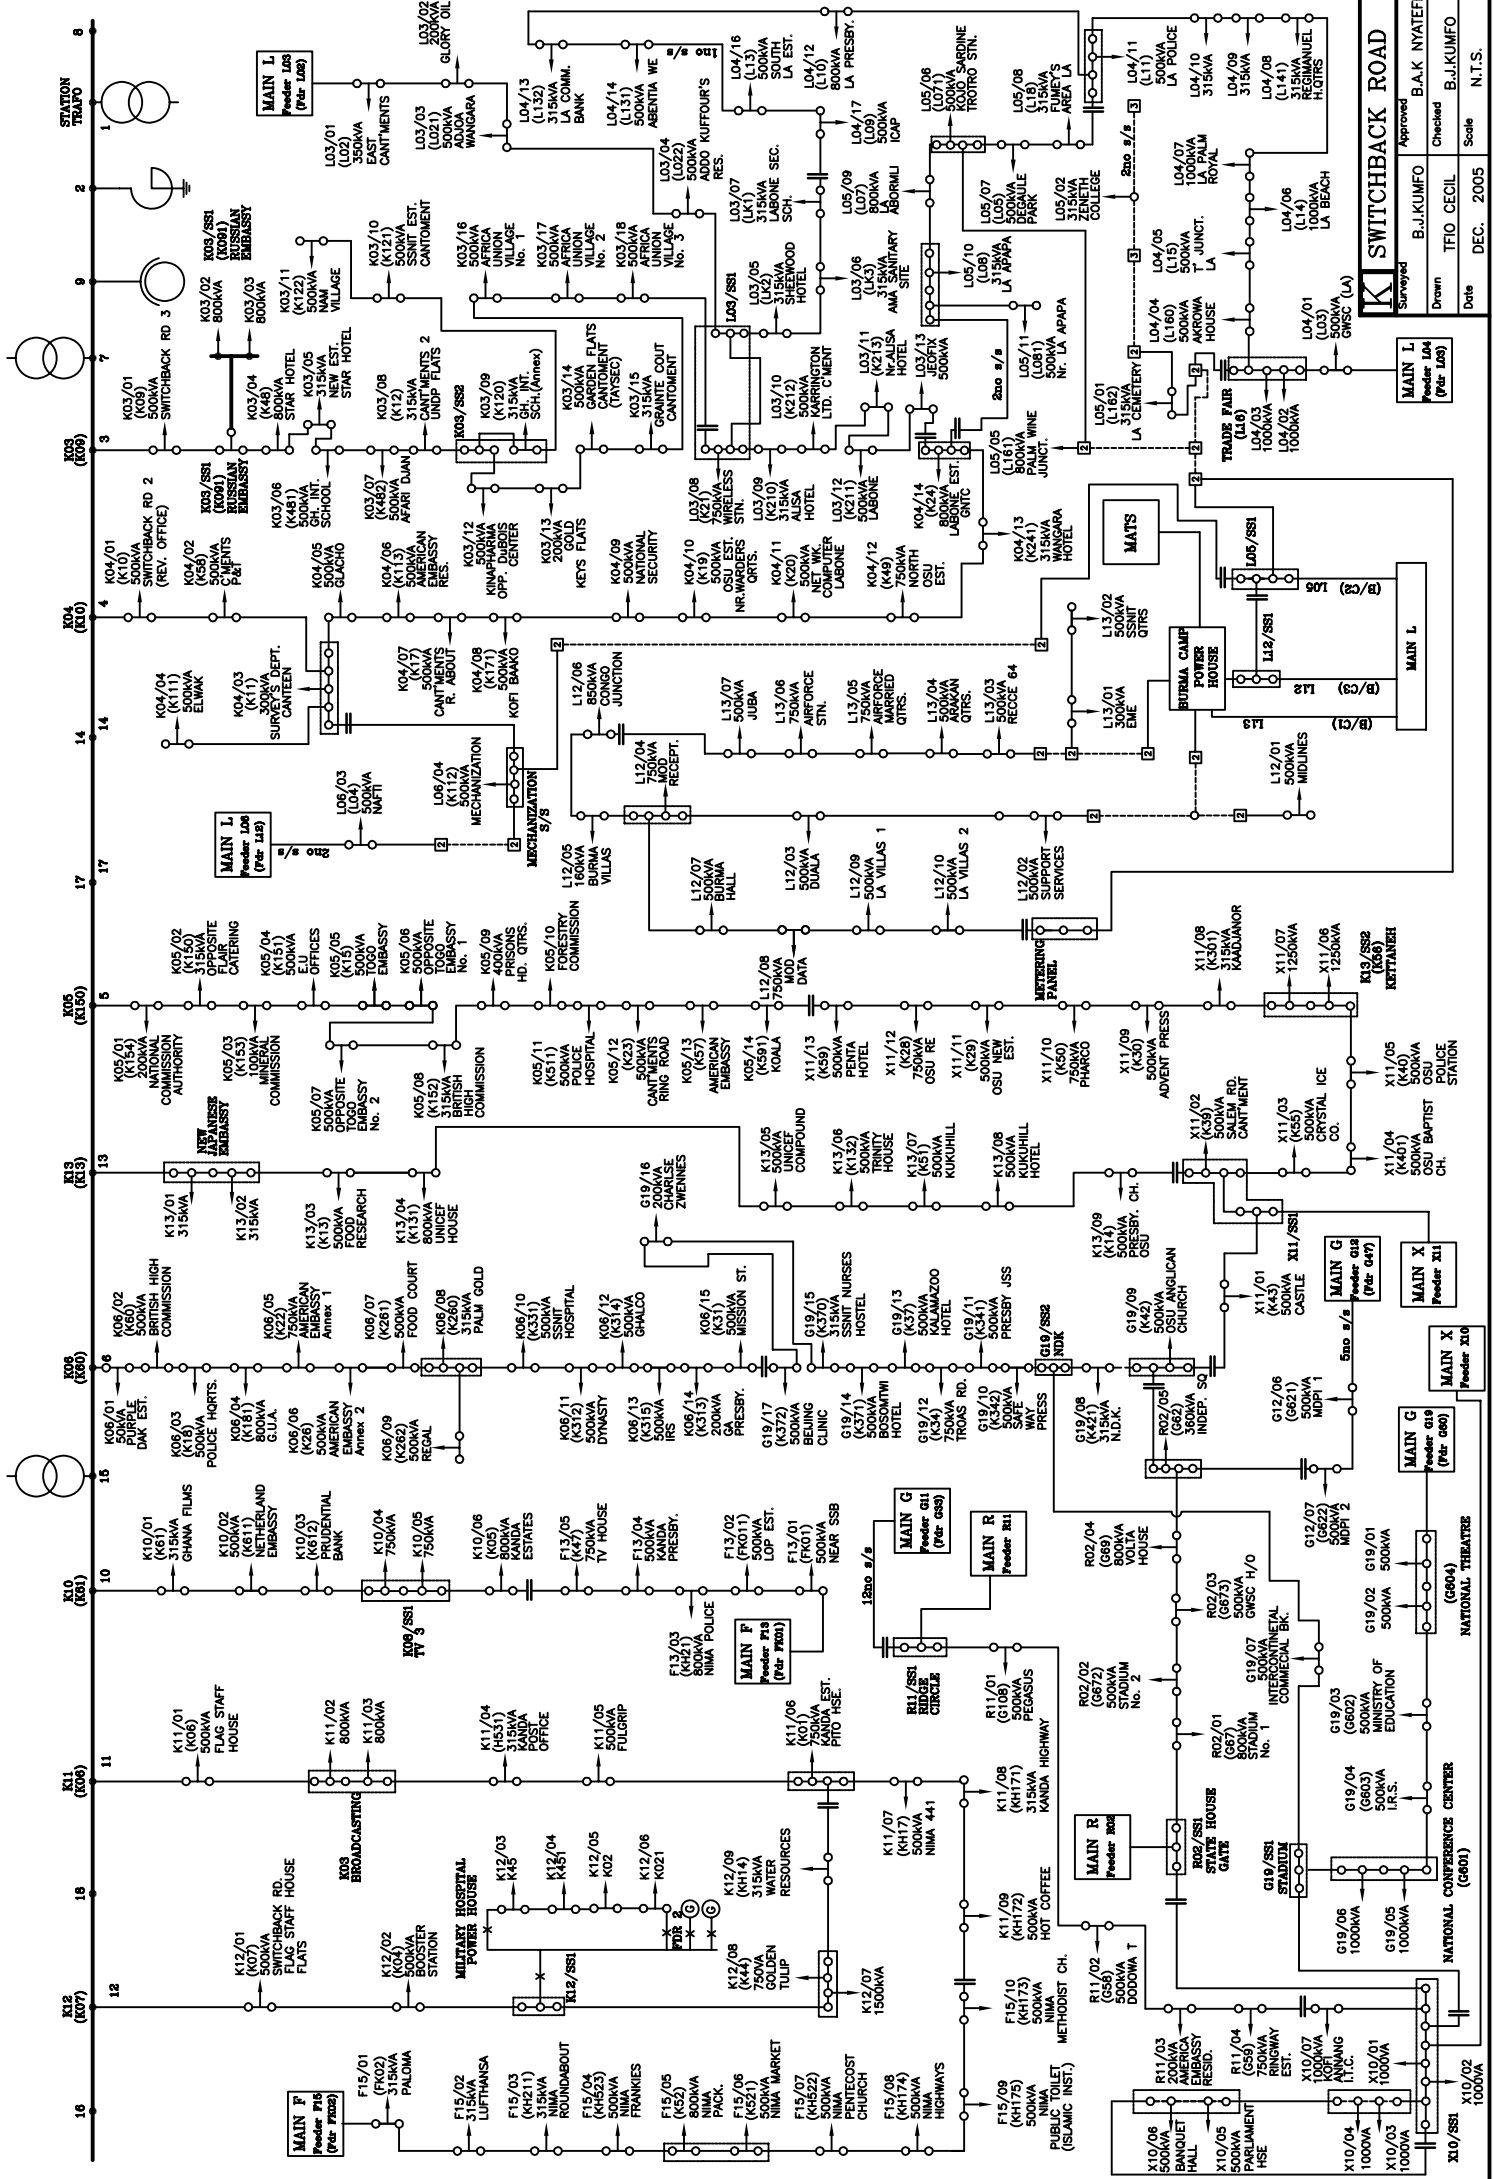

SWITCHBACK ROAD

Approved: B.A.K. NYATEFE
 Drawn: T.F.O. GECIL
 Date: DEC. 2005
 Scale: N.T.S.

Checked: B.J.KUMFO
 Date: DEC. 2005
 Scale: N.T.S.

Checked: B.J.KUMFO
 Date: DEC. 2005
 Scale: N.T.S.