



Single Line Diagram


Ashanti

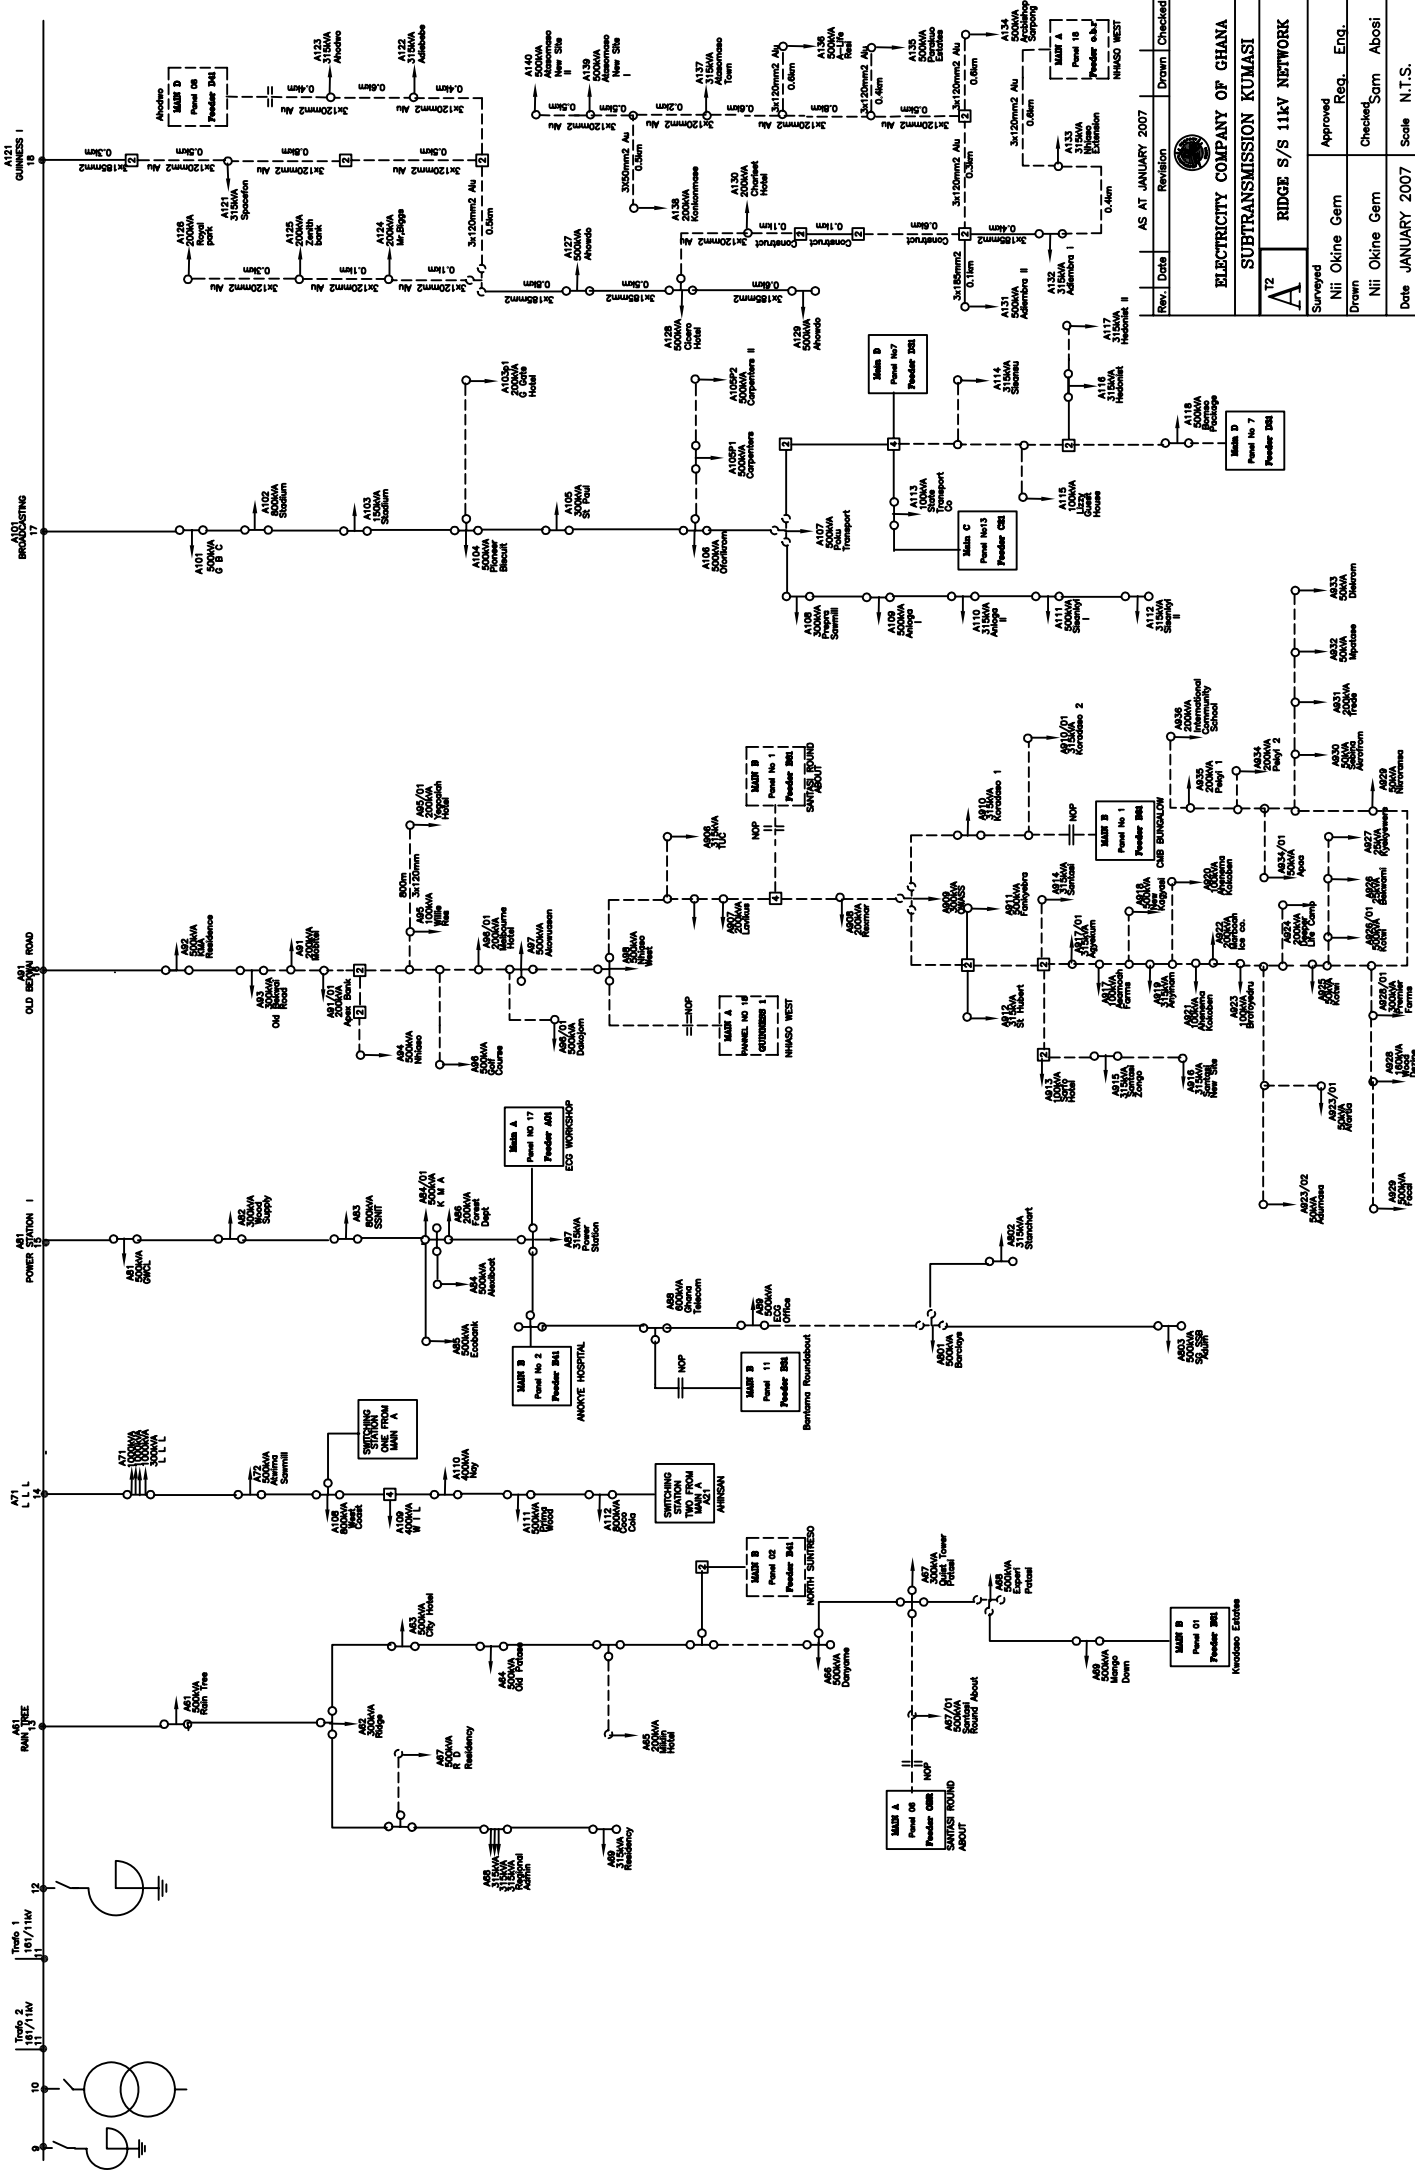

Rev.	Date	AS AT JANUARY 2007	Revision	Checked
ELECTRICITY COMPANY OF GHANA				
SUBTRANSMISSION KUMASI				
RIDGE S/S 11KV NETWORK				
Surveyed		Approved		Reg. Eng.
Drawn		Checked		Sam Abosi
Date		JANUARY 2007		Scale N.T.S.


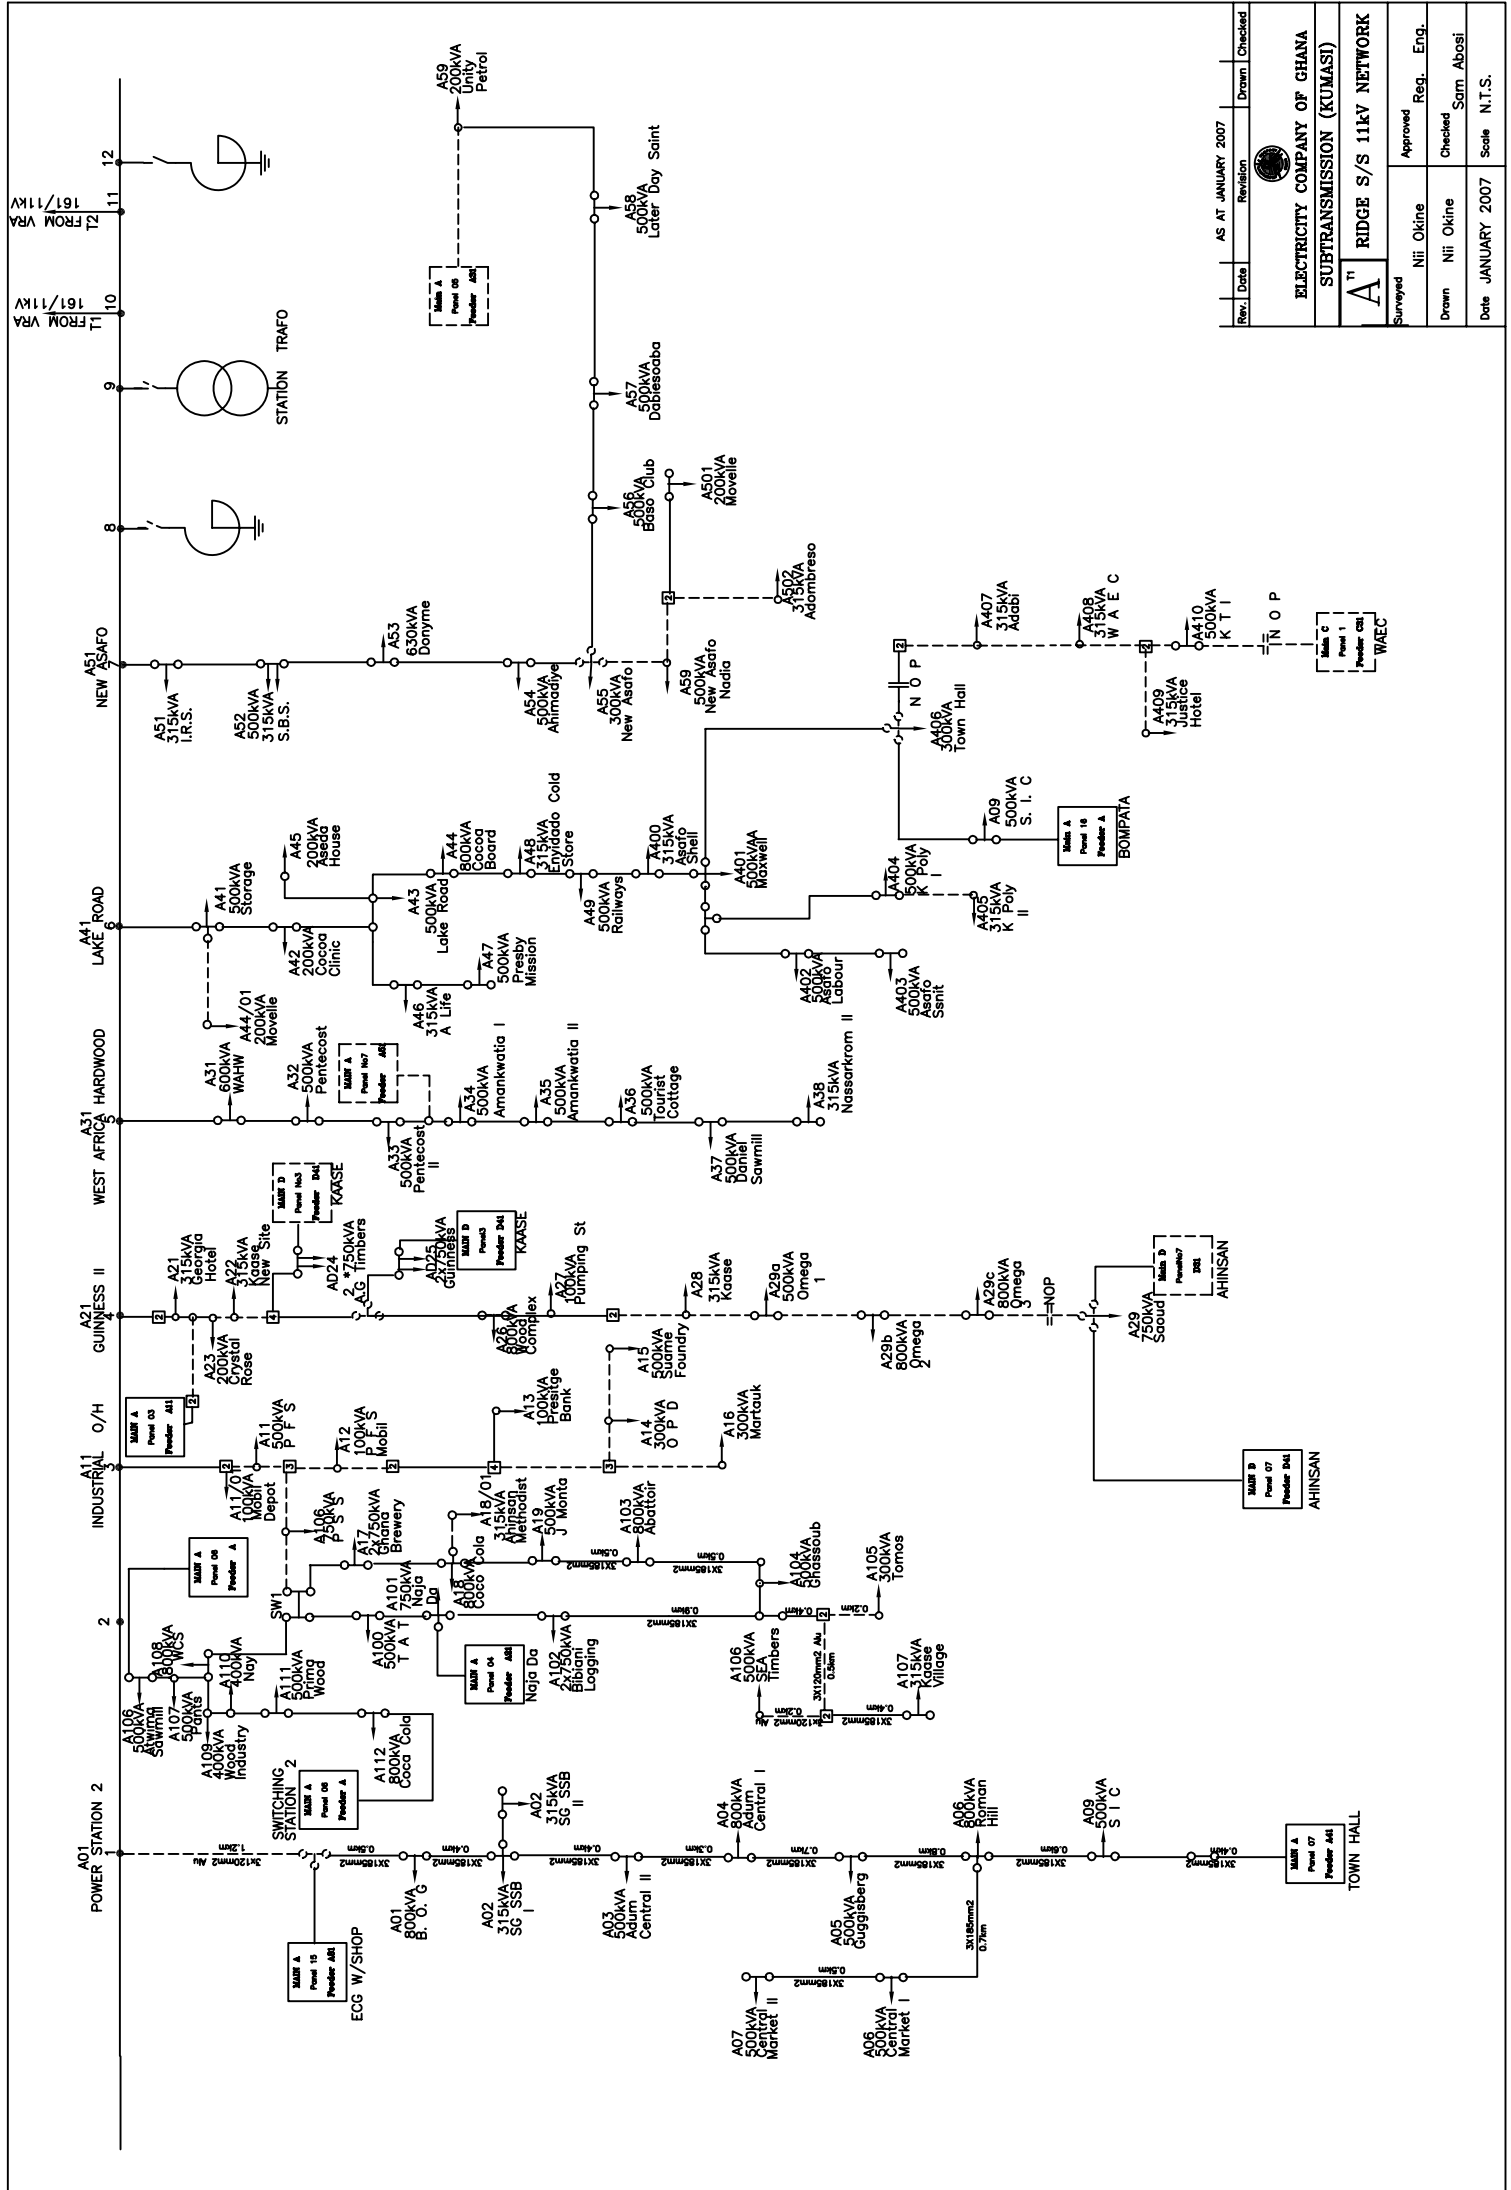


Rev.	Date	Revision	Drawn	Checked
	AS AT JANUARY 2007			
 ELECTRICITY COMPANY OF GHANA SUBTRANSMISSION (KUMASI)				
A¹¹ RIDGE S/S 11kV NETWORK				
Surveyed		Approved		Reg. Eng.
Nii Okine		Checked		Sam Abosi
Drawn		Checked		Sam Abosi
Nii Okine		Checked		Sam Abosi
Date		Scale		N.T.S.
JANUARY 2007				

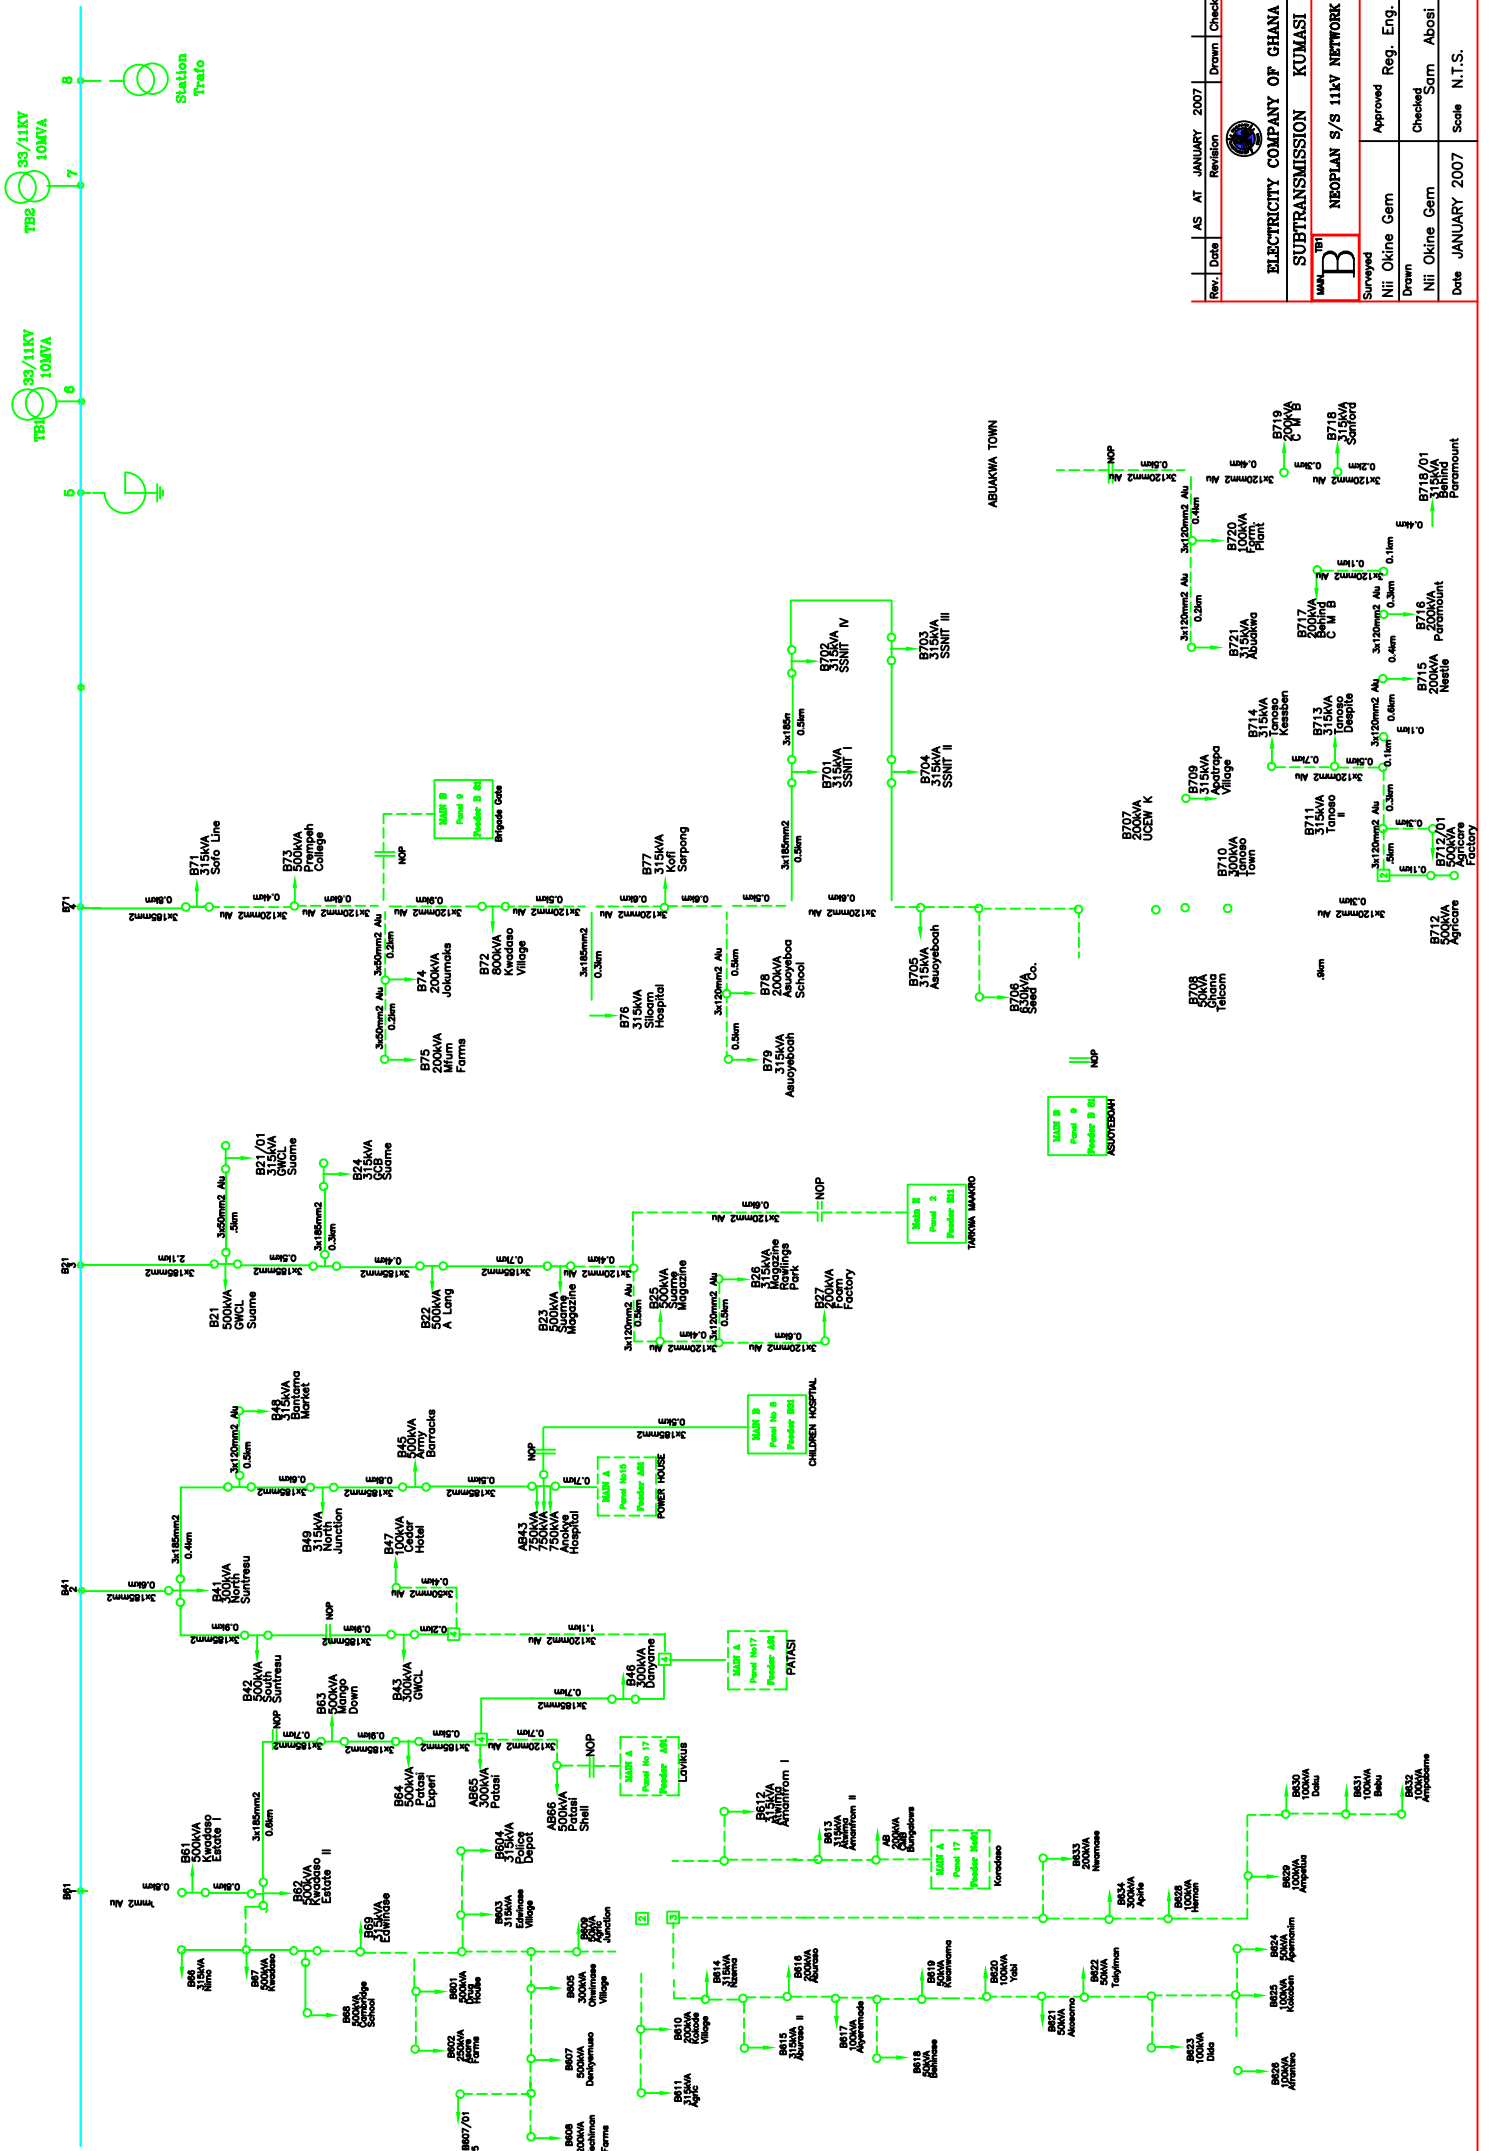

Rev.	Date	AS AT	Revision	Drawn	Checked
		AS AT	JANUARY 2007		


ELECTRICITY COMPANY OF GHANA			
SUBTRANSMISSION KUMASI			
MMN TB1	B		
NEOPLAN S/S 11kV NETWORK			
Surveyed	Nii Okine Gern	Approved	Reg. Eng.
Drawn	Nii Okine Gern	Checked	Sam Abosi
Date JANUARY 2007		Scale N.T.S.	

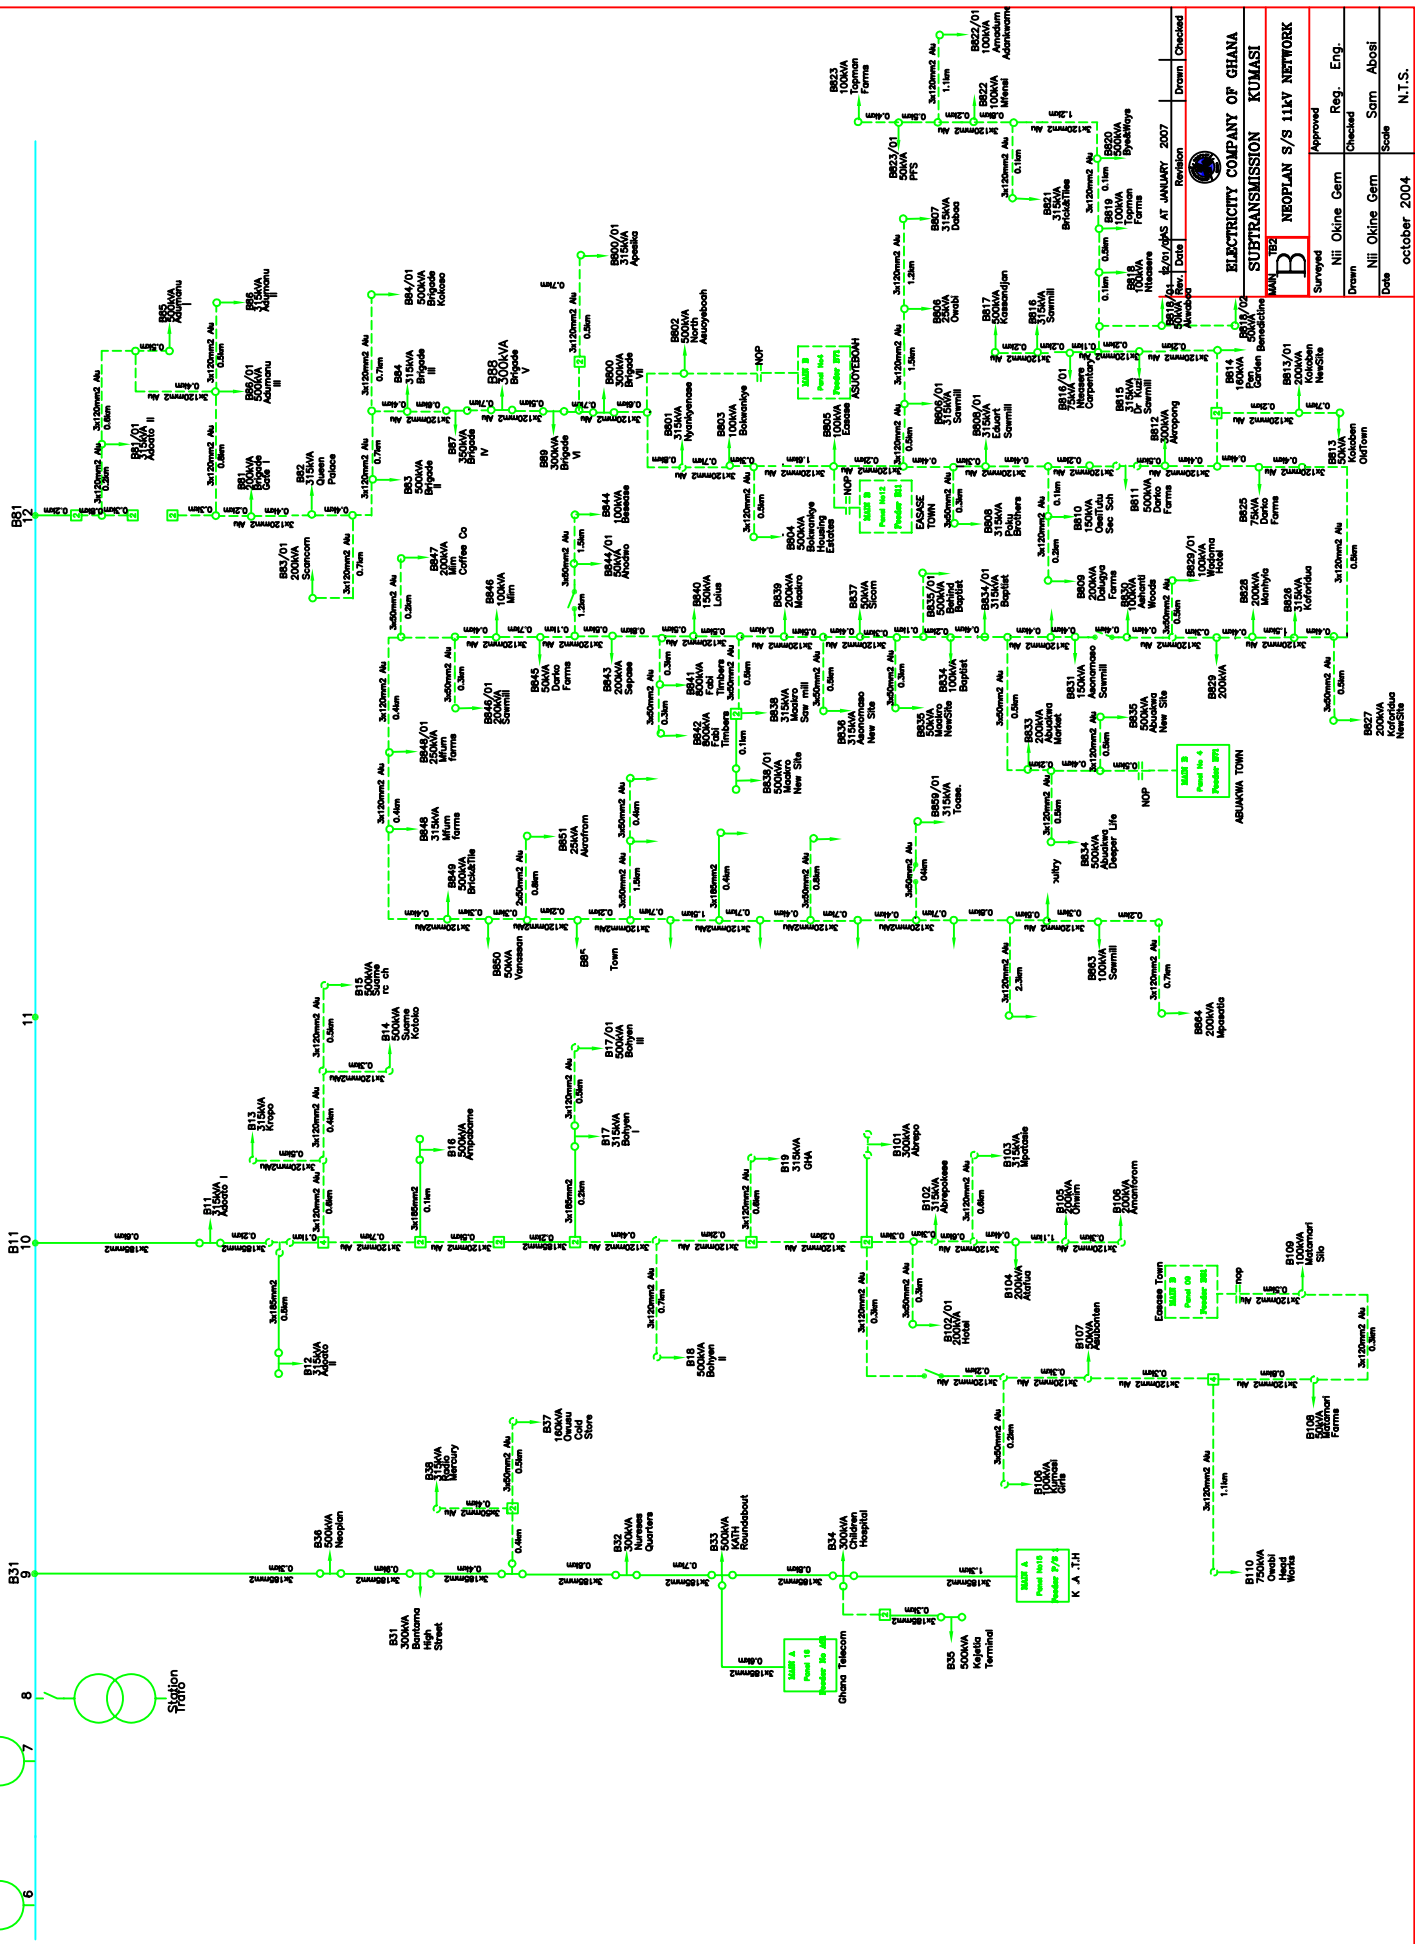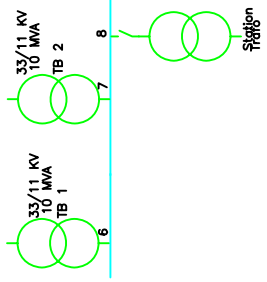


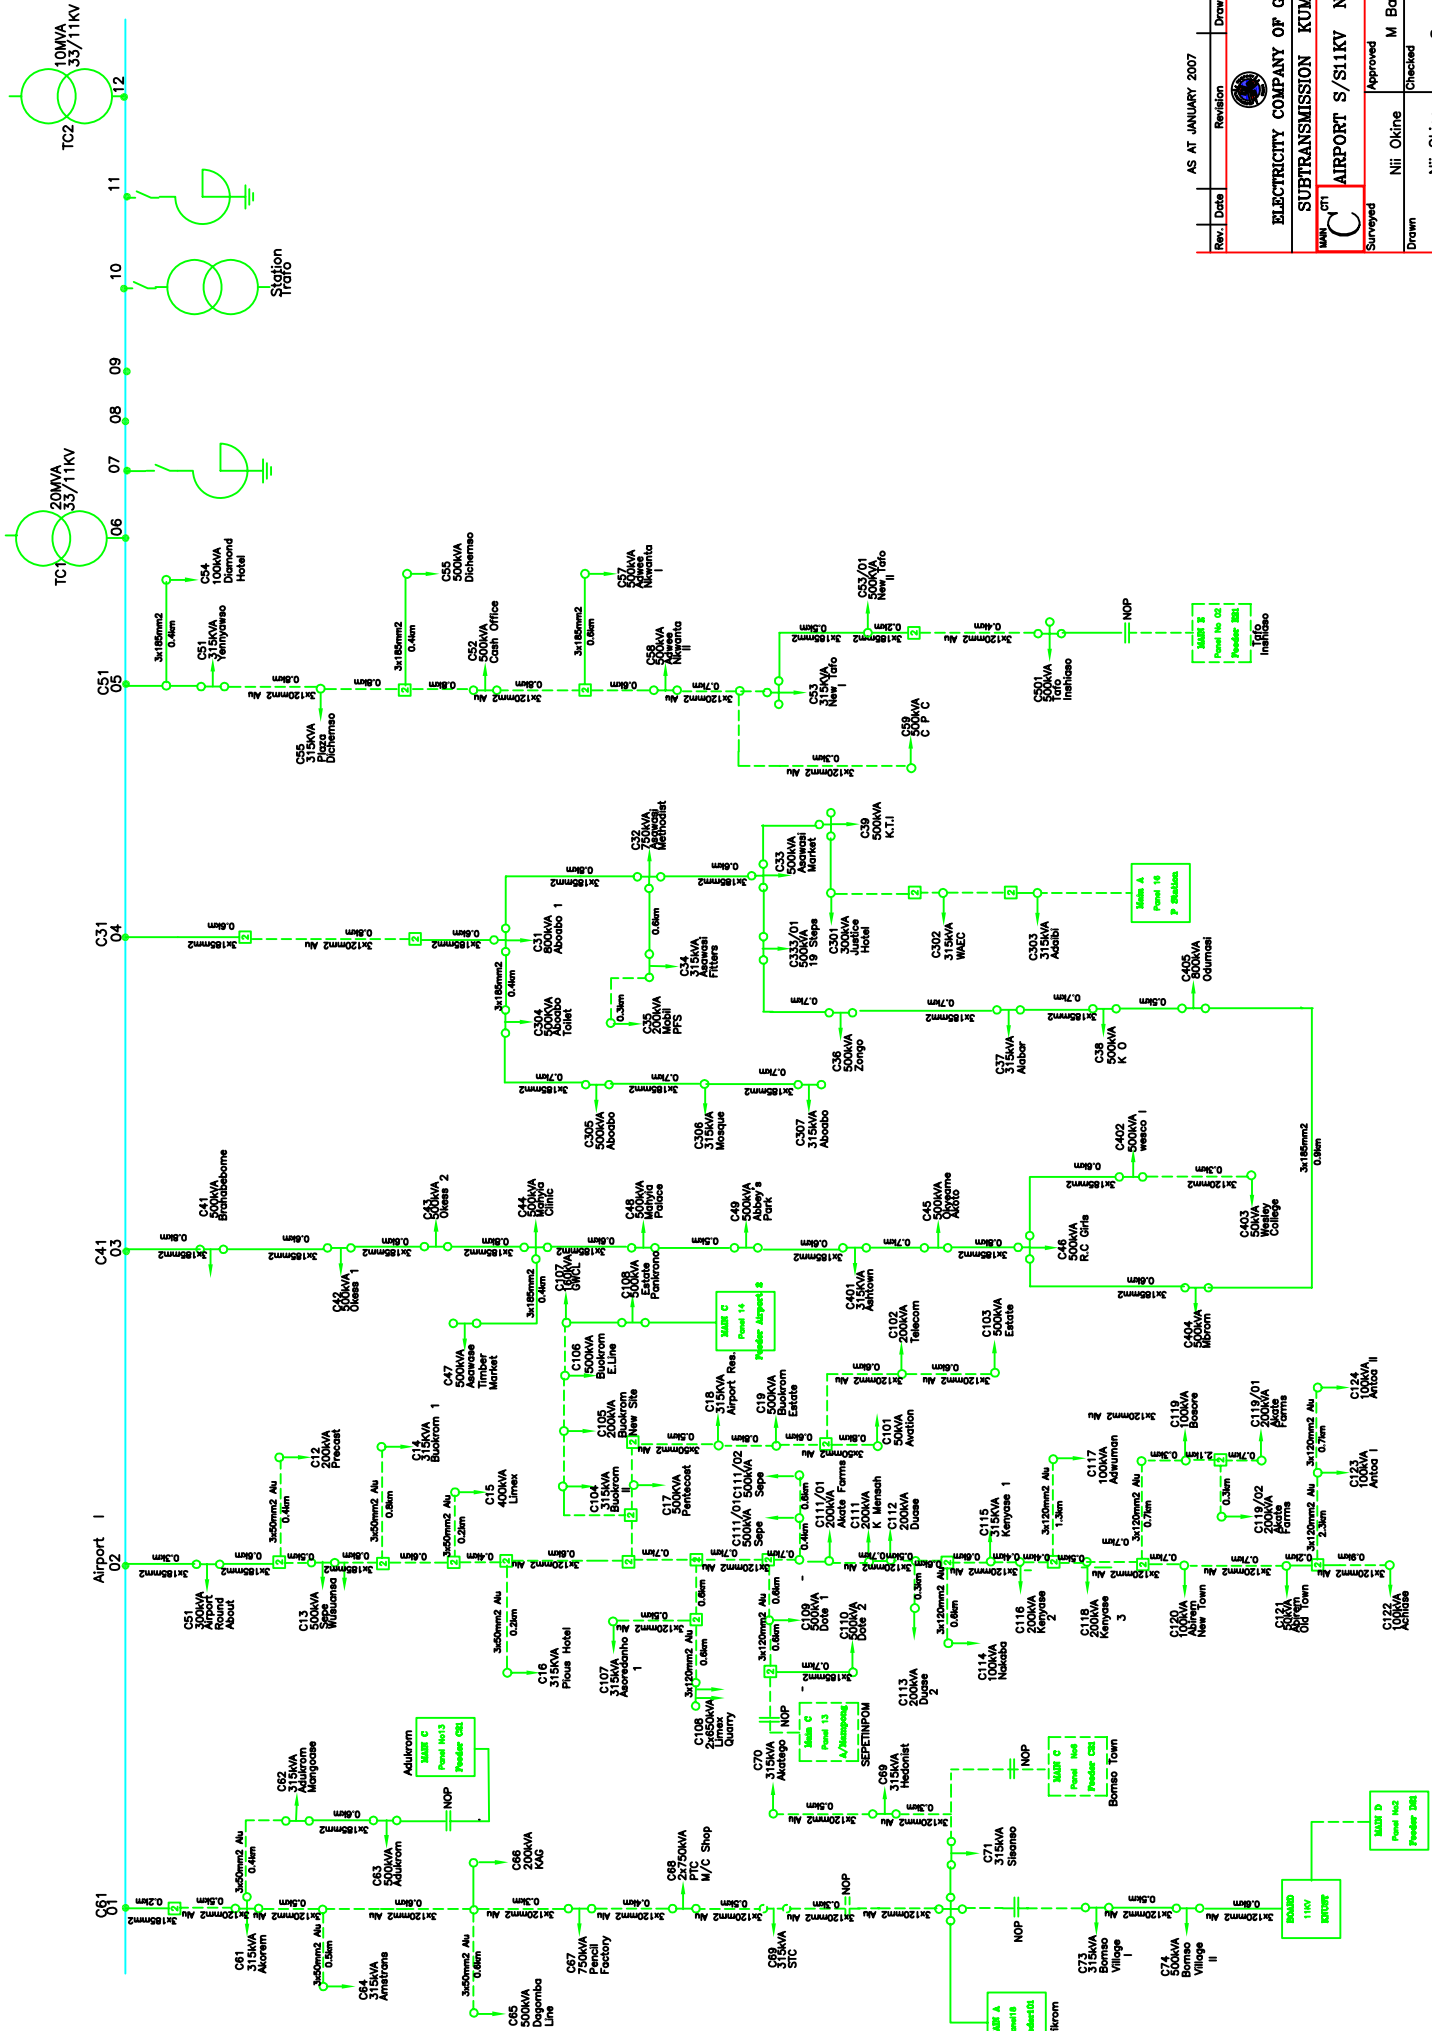
Revision	Drawn	Checked
1	Nii Okine Gern	Reg. Eng.
2	Nii Okine Gern	Scale
3	Nii Okine Gern	Abosi
4	Nii Okine Gern	Scale
5	Nii Okine Gern	N.T.S.

ELECTRICITY COMPANY OF GHANA
SUBTRANSMISSION KUMASI
NEOPLAN S/S 11KV NETWORK


Date: 10/01/2007
 At: KUMASI
 Drawn: Nii Okine Gern
 Checked: Nii Okine Gern
 Reg. Eng.: Nii Okine Gern
 Scale: N.T.S.

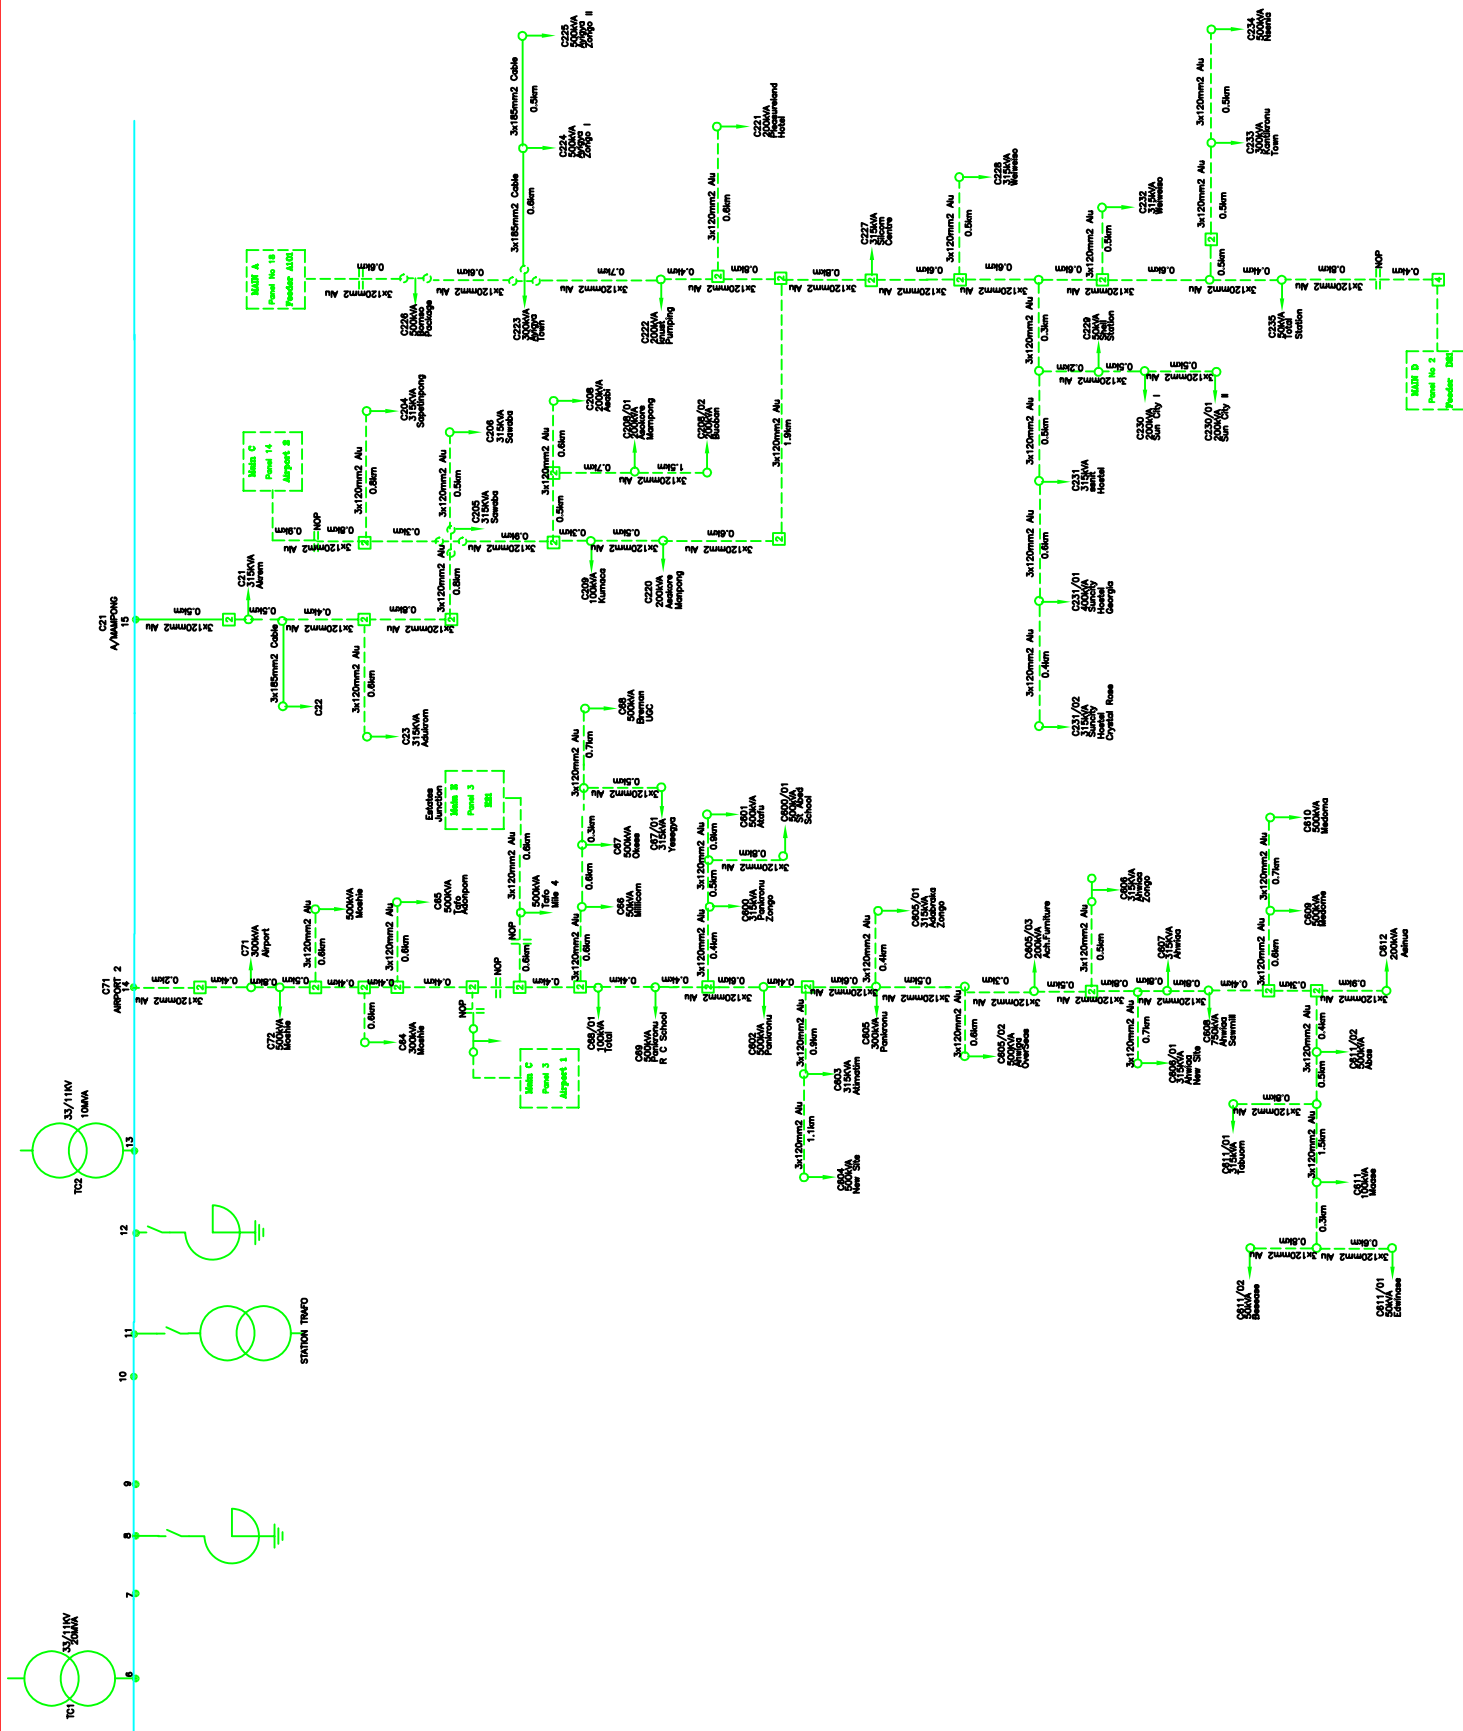


Date	AS AT JANUARY 2007	Revision	Drawn	Checked
 ELECTRICITY COMPANY OF GHANA SUBTRANSMISSION KUMASI				
11KV C¹ AIRPORT S/S 11KV NETWORK				
Surveilled	Nii Okine	Approved	M. Bach	
Drawn	Nii Okine	Checked	Sam Abosti	
Date	January 2007	Scale	N.T.S.	





Rev.	Date	Revision	Drawn	Checked
	AS AT JANUARY 2007			
ELECTRICITY COMPANY OF GHANA				
SUBTRANSMISSION KUMASI				
AIRPORT S/S 11KV NETWORK				
Survised	Nii Okine	Approved	M Baah	
Drawn	Nii Okine	Checked		
Date	January 2007	Scale	Sam Abosi	N.T.S.

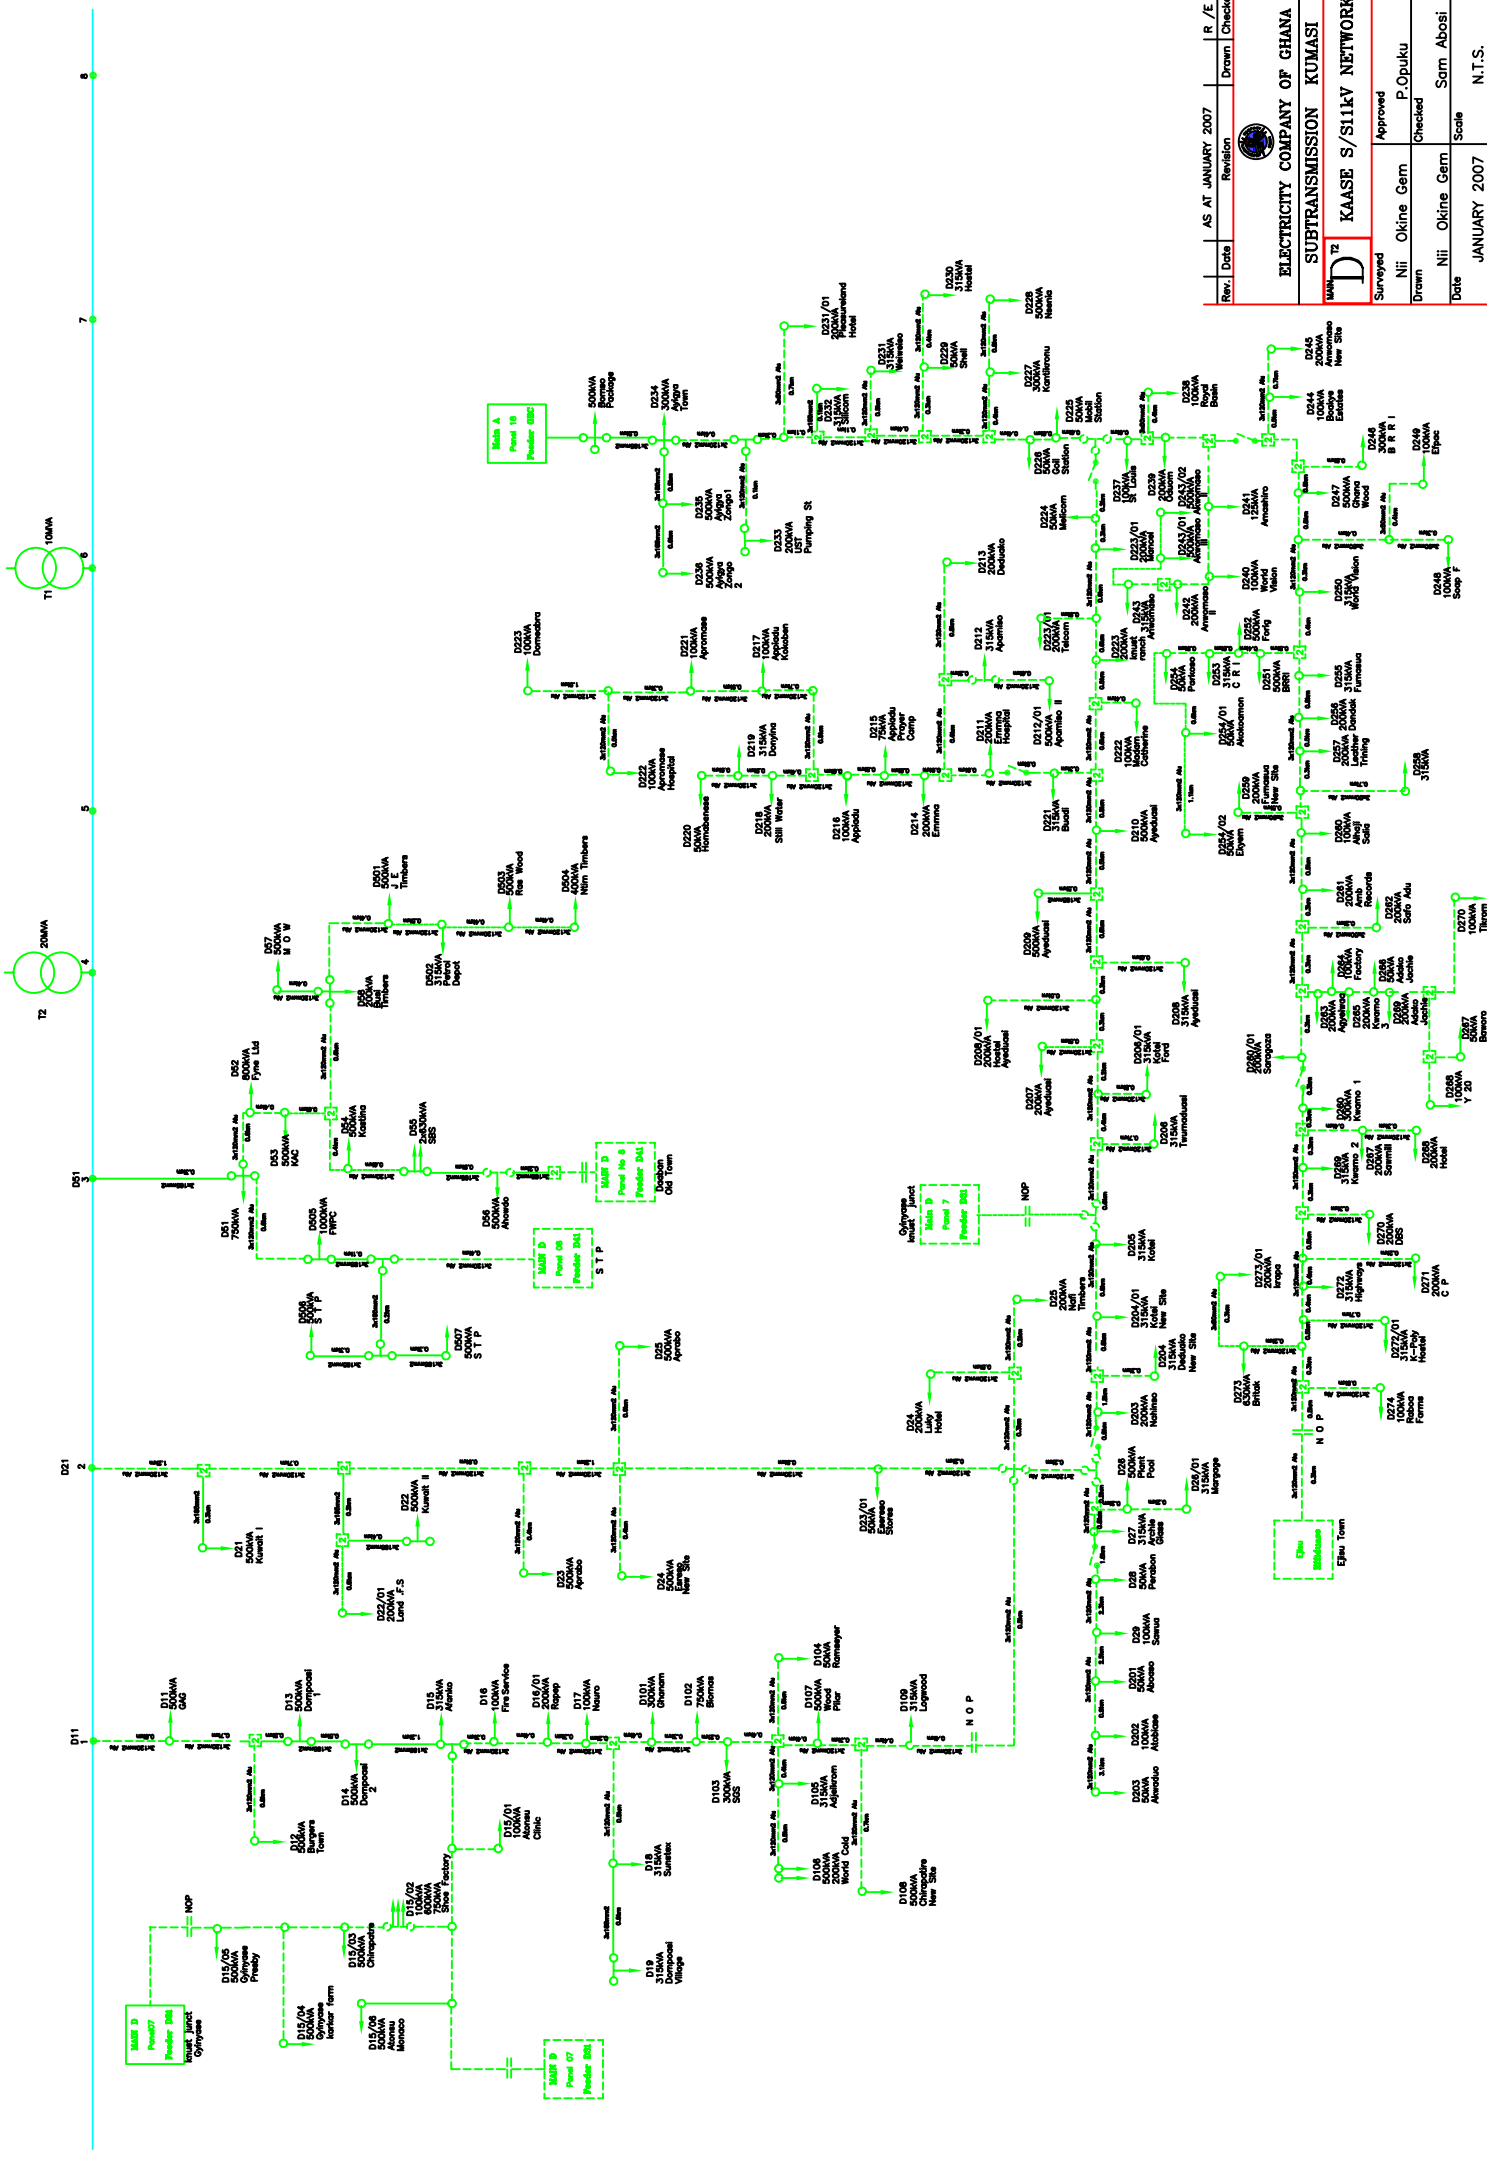


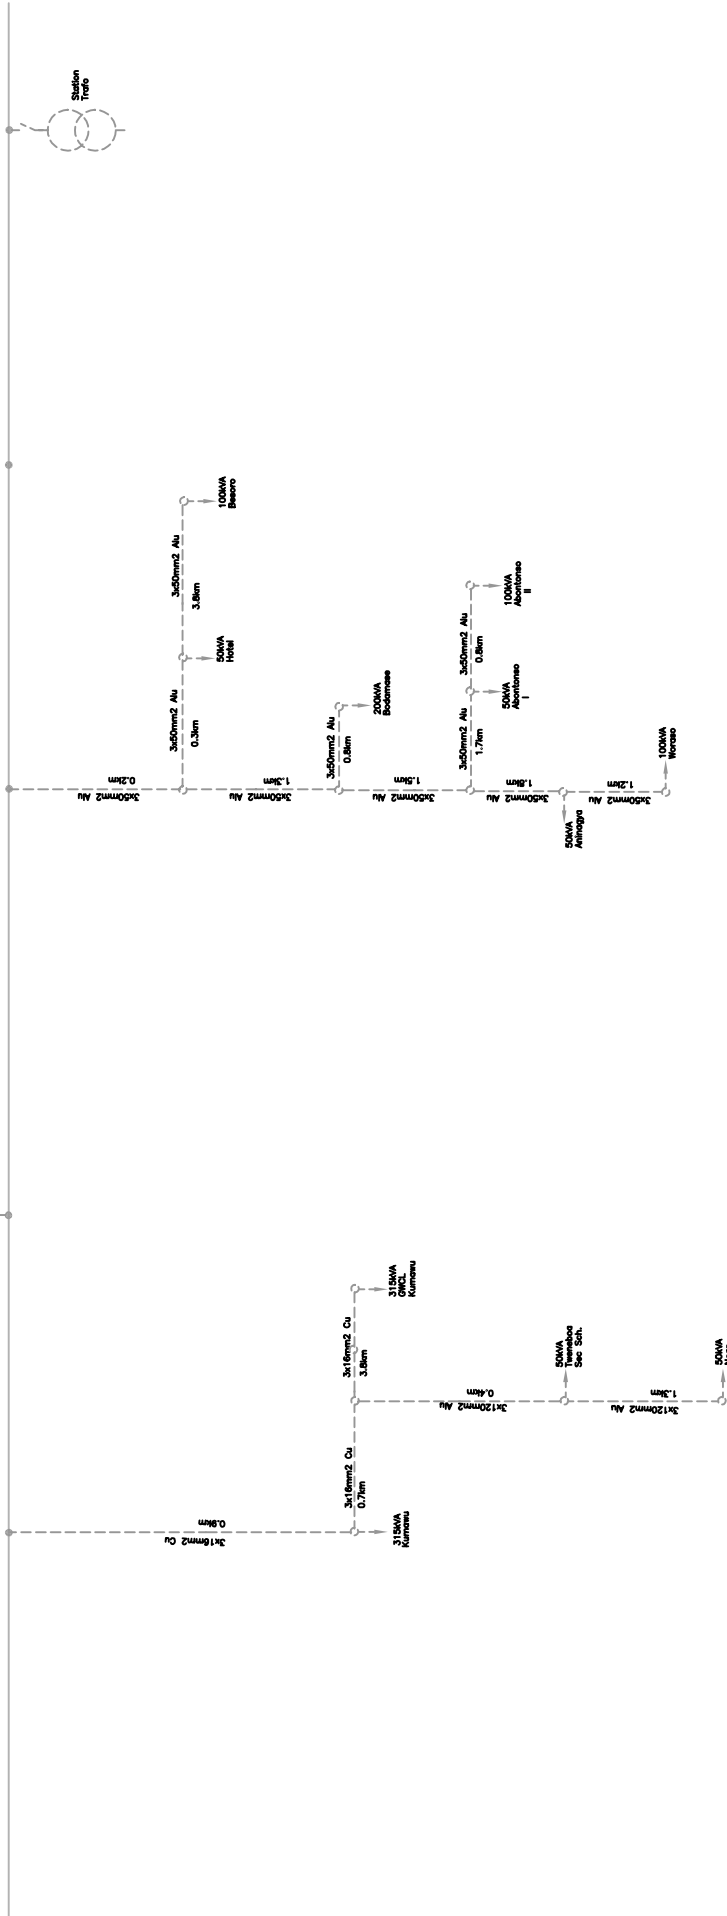


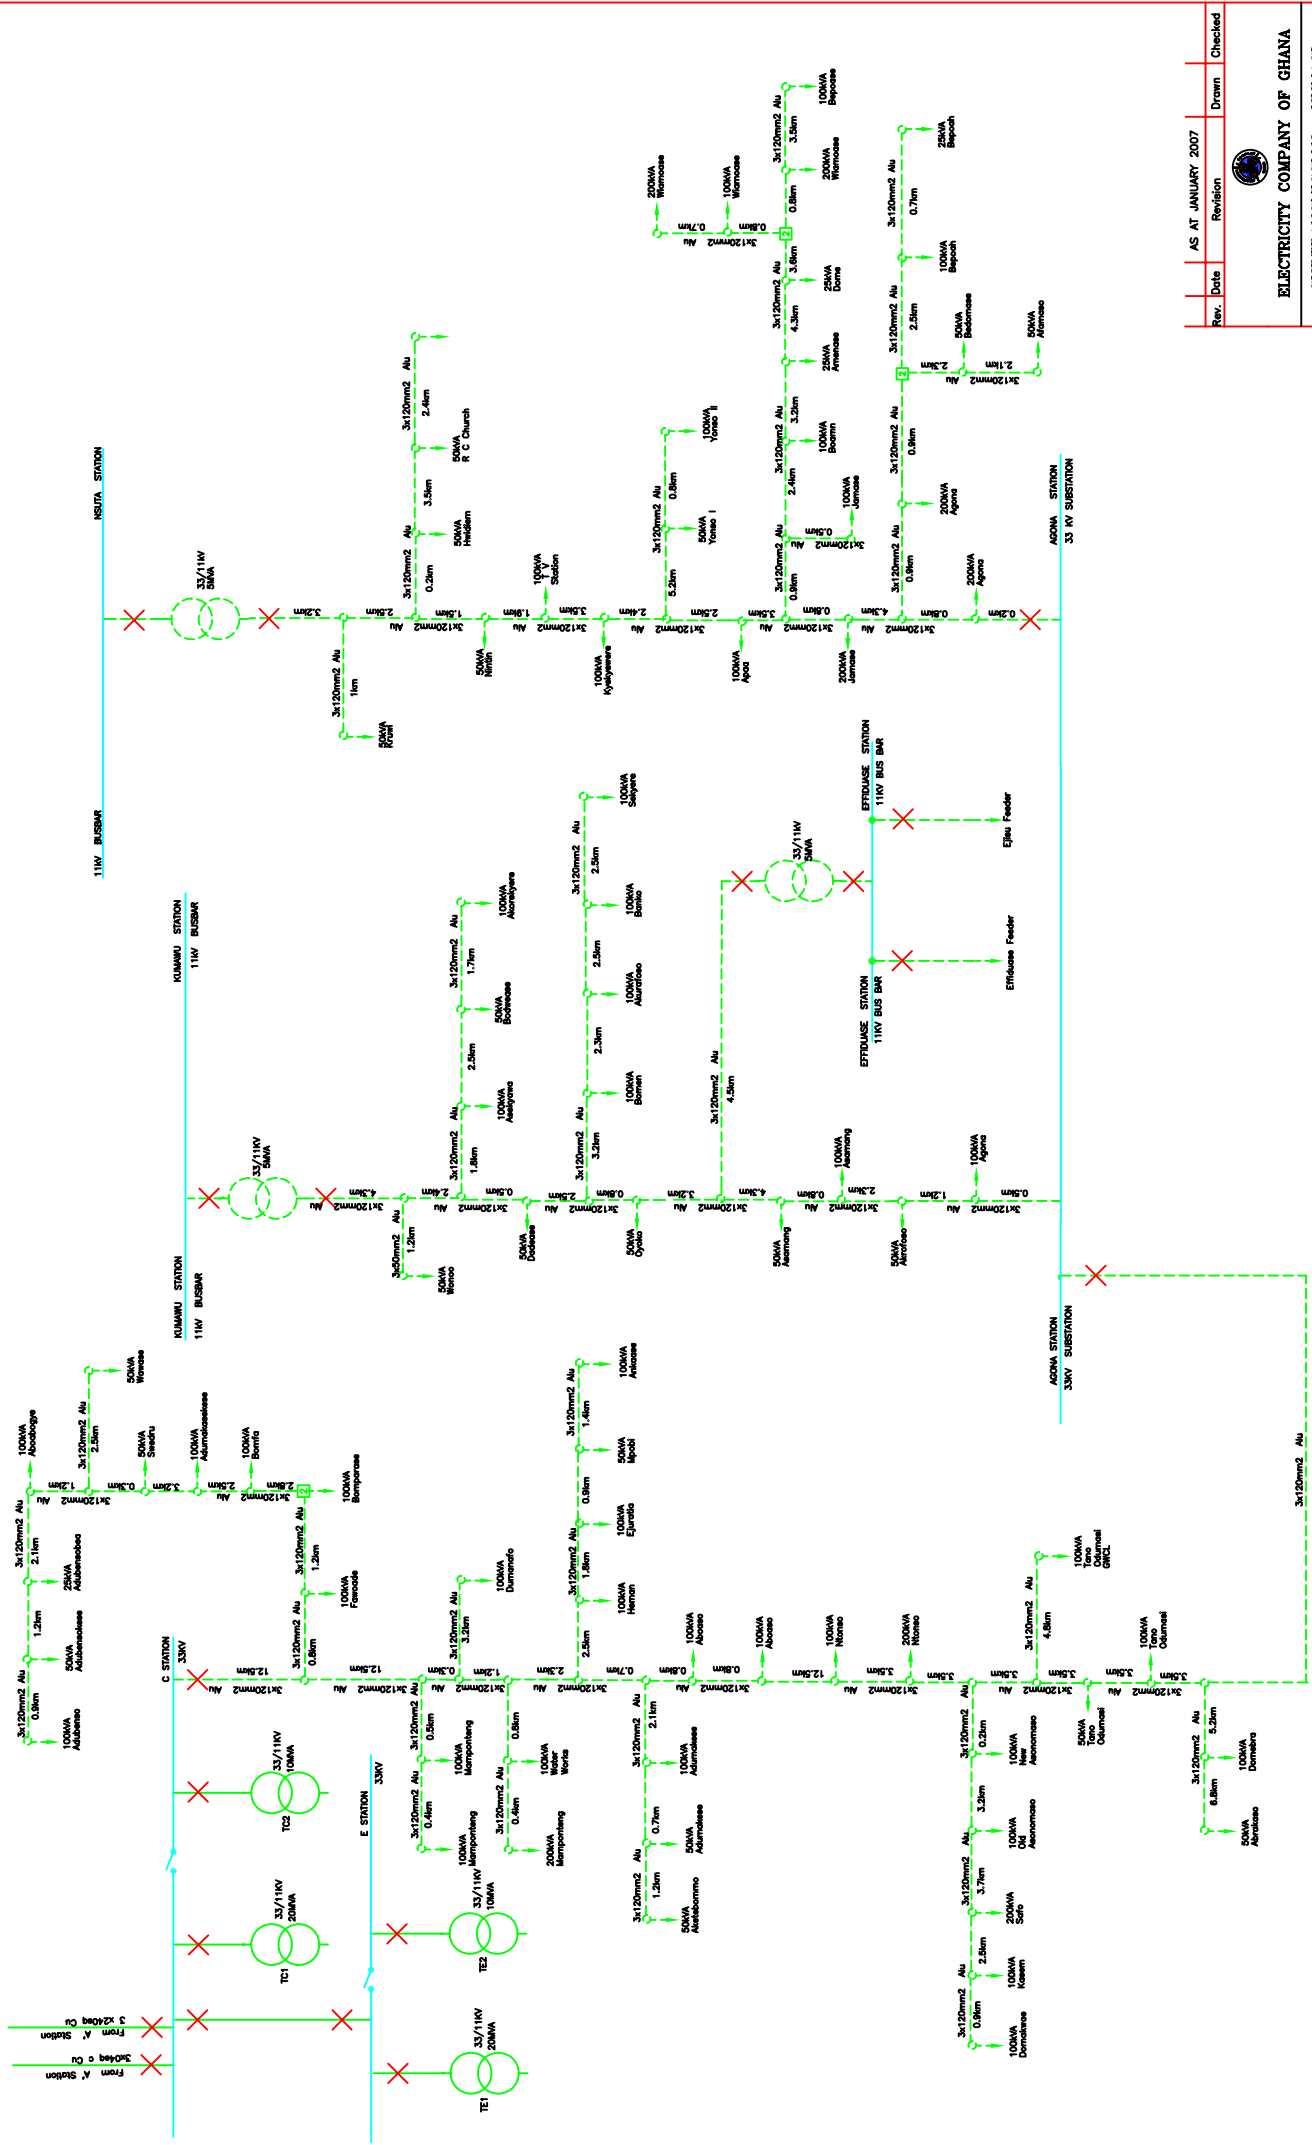
Rev.	Date	Revision	Drawn	Checked
	AS AT JANUARY 2007			
ELECTRICITY COMPANY OF GHANA SUBTRANSMISSION – KUMASI				
MAIN KUMAWU S/S 11KV NETWORK				
Surveyed	Nii Okine	Approved	M Baah	
Drawn	Nii Okine	Checked	Sam Abosti	
Date	January 2007	Scale	N.T.S.	

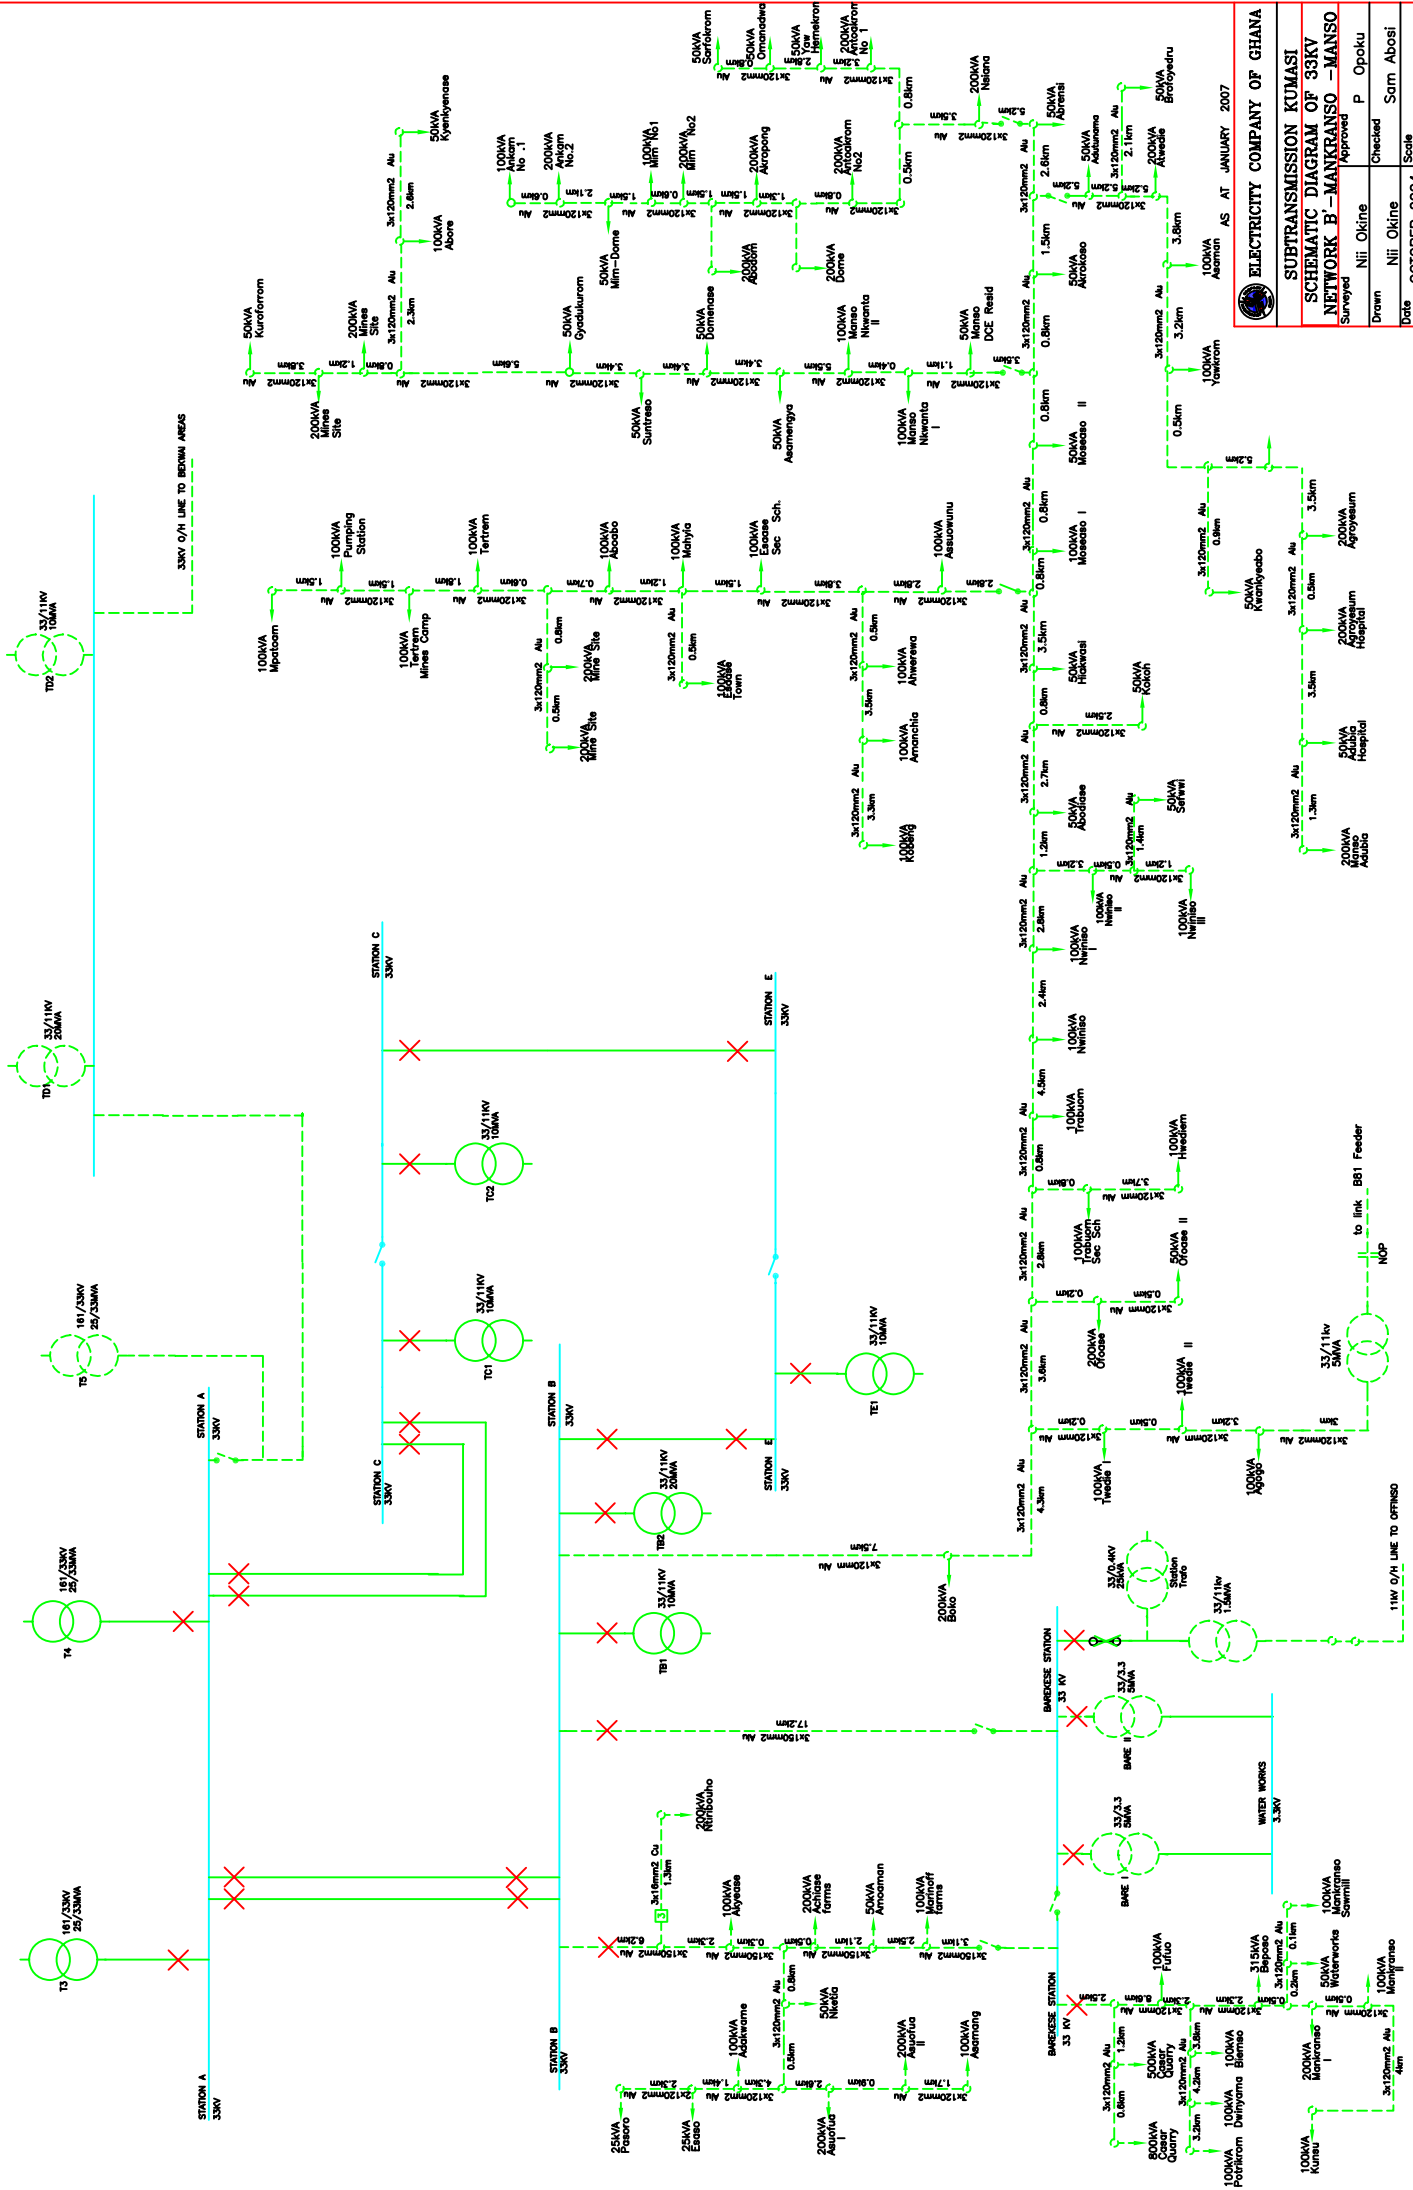


 ELECTRICITY COMPANY OF GHANA AS AT JANUARY 2007	
SUBTRANSMISSION KUMASI SCHEMATIC DIAGRAM OF 33KV NETWORK B' - MANKRANSO - MANSO	
Surveyed	P. Opoku
Drawn	Nii Okine
Checked	Sam Abosi
Date	OCTOBER 2004
Scale	N.T.S.

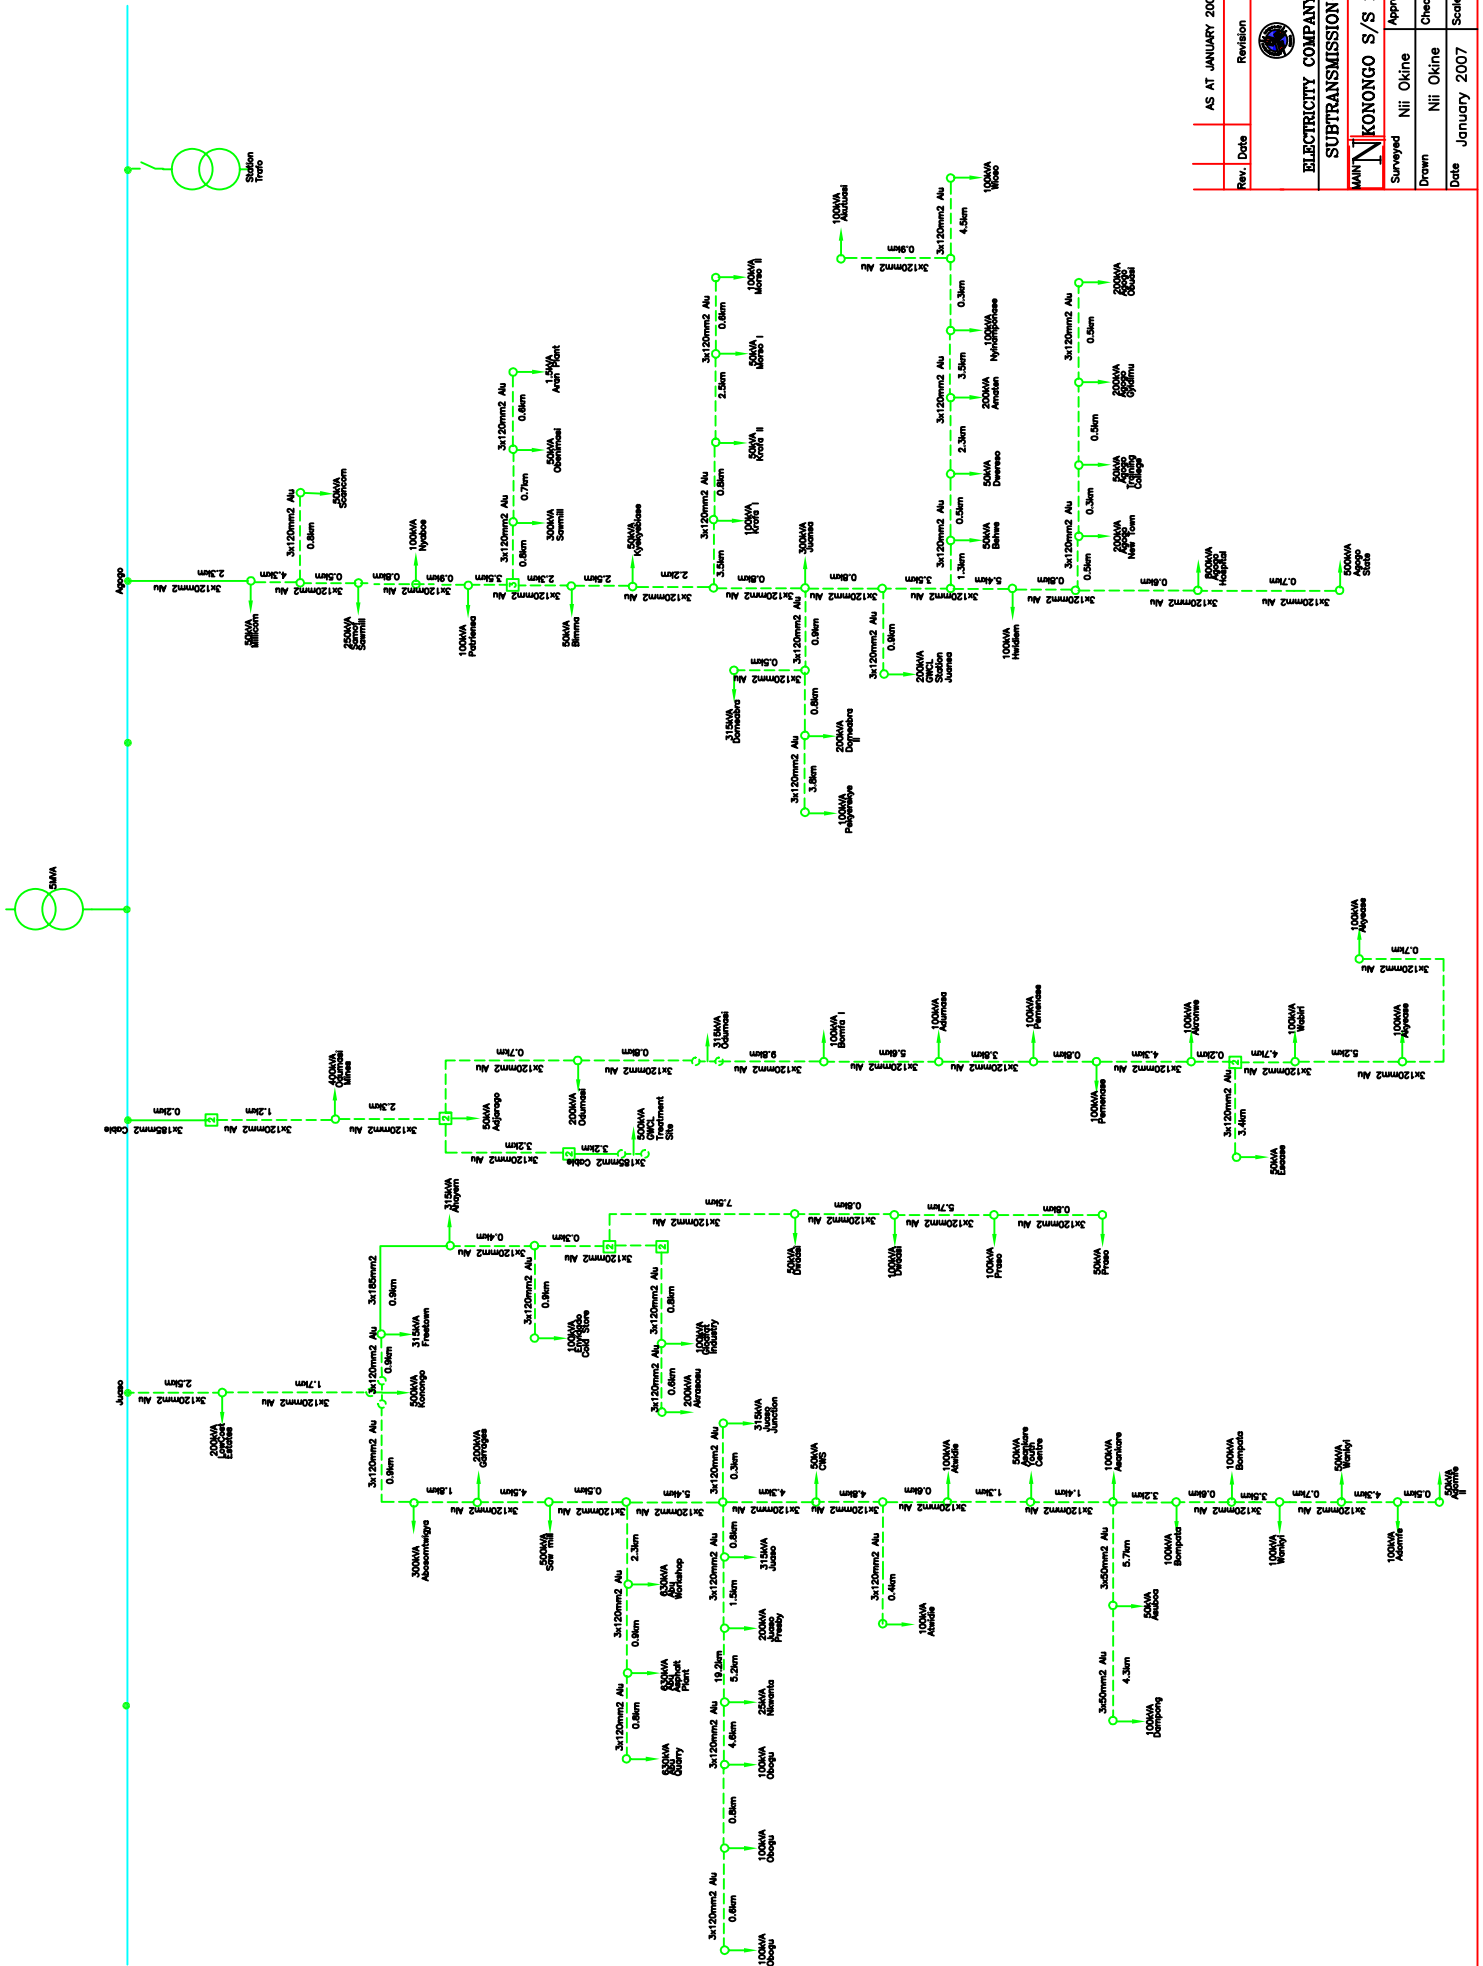


Rev.	Date	Revision	Drawn	Checked
 ELECTRICITY COMPANY OF GHANA SUBTRANSMISSION – KUMASI				
MAIN 11KV KONONGO S/S 11KV NETWORK				
Surveyed	Nii Okine	Approved	M. Boah	
Drawn	Nii Okine	Checked	Sam Abosti	
Date	January 2007	Scale	N.T.S.	



Rev.	Date	Revision	Drawn	Checked
	AS AT JANUARY 2007			

 ELECTRICITY COMPANY OF GHANA	
SUBTRANSMISSION – KUMASI SCHEMATIC DIAGRAM OF 33KV NETWORK C – AGONA – NSUTA	
Surveyed	Nii Okine
Approved	M. Baah
Drawn	Nii Okine
Checked	Sam Abosi
Date	JANUARY 2007
Scale	N.T.S.

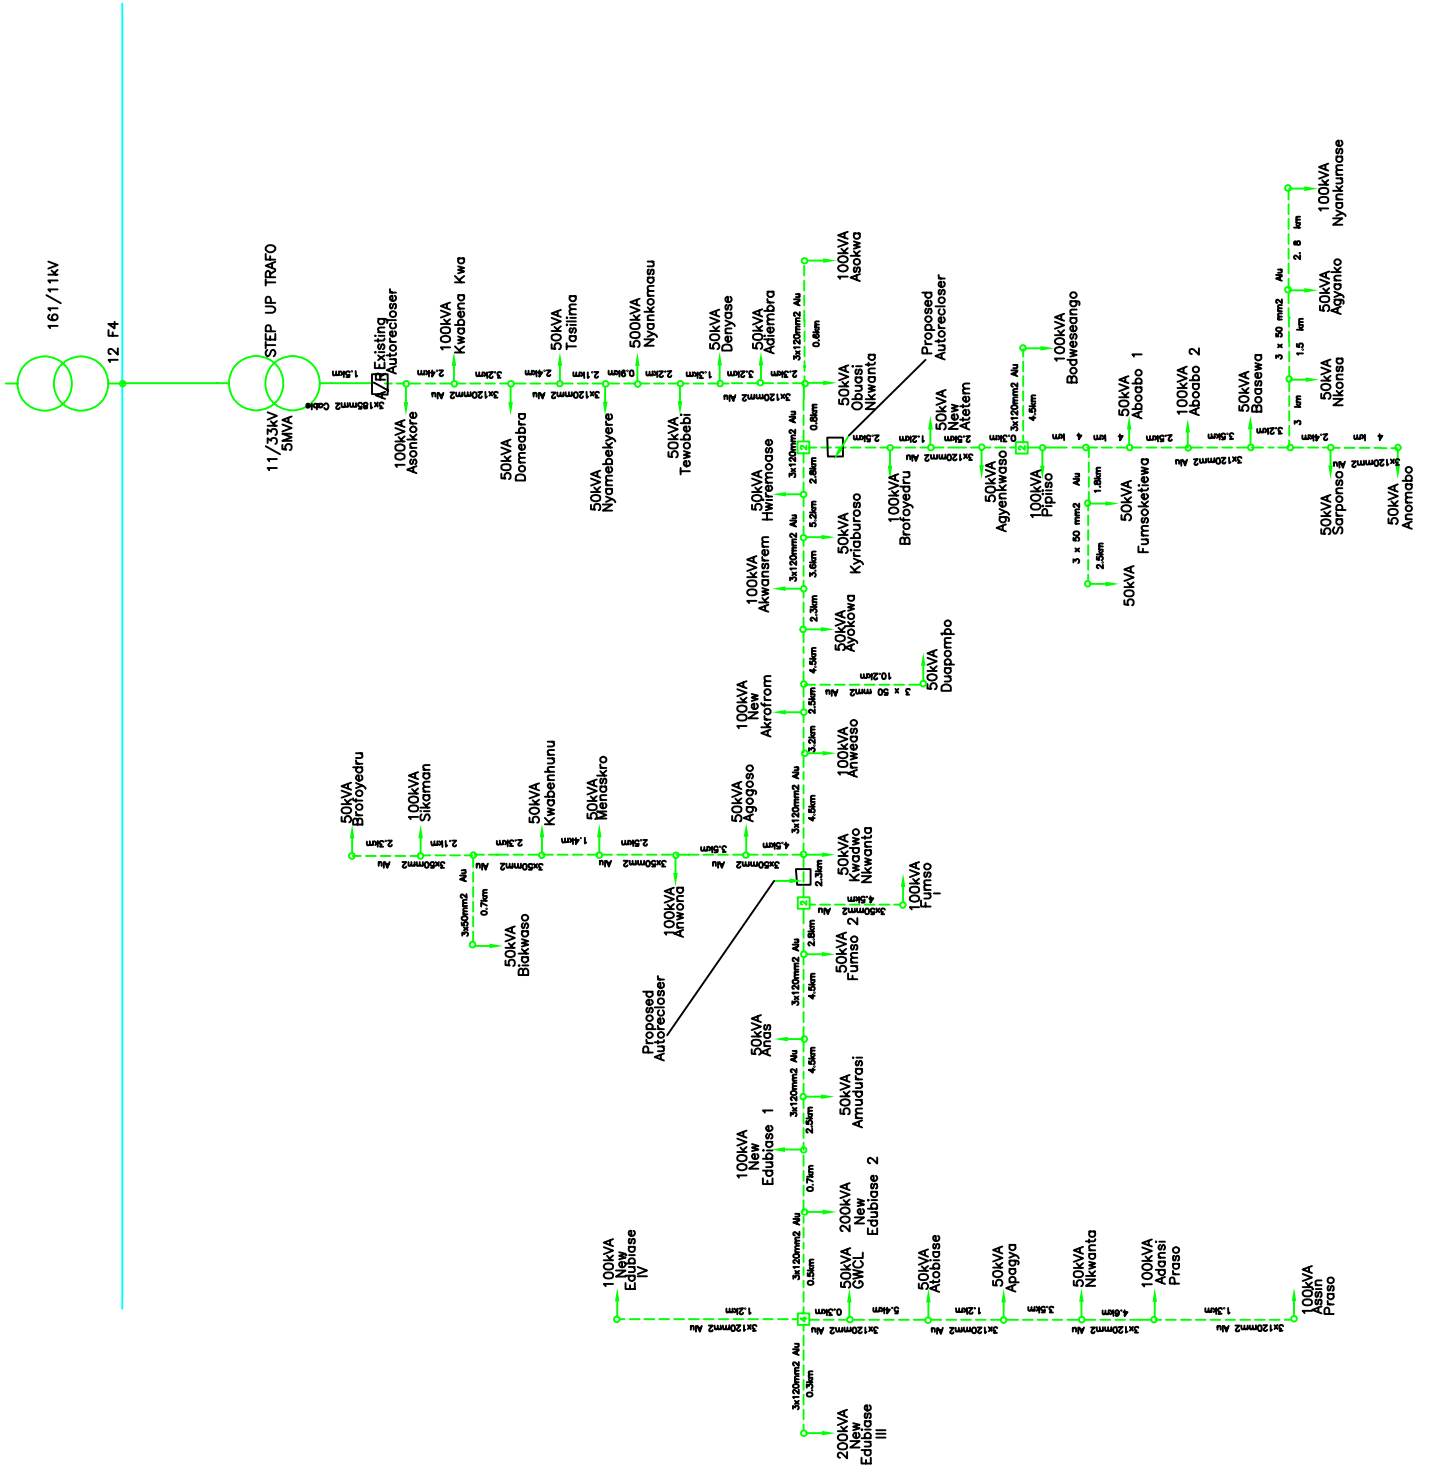


Rev.	Date	Revision	Drawn	Checked


ELECTRICITY COMPANY OF GHANA


SUBTRANSMISSION KUMASI

Obuasi S/S 33KV NETWORK

Surveyed	A. C. BOAKYE	Approved	
Drawn	Nii Okine Gern	Checked	
Date	OCTOBER 2004	Scale	N.T.S.

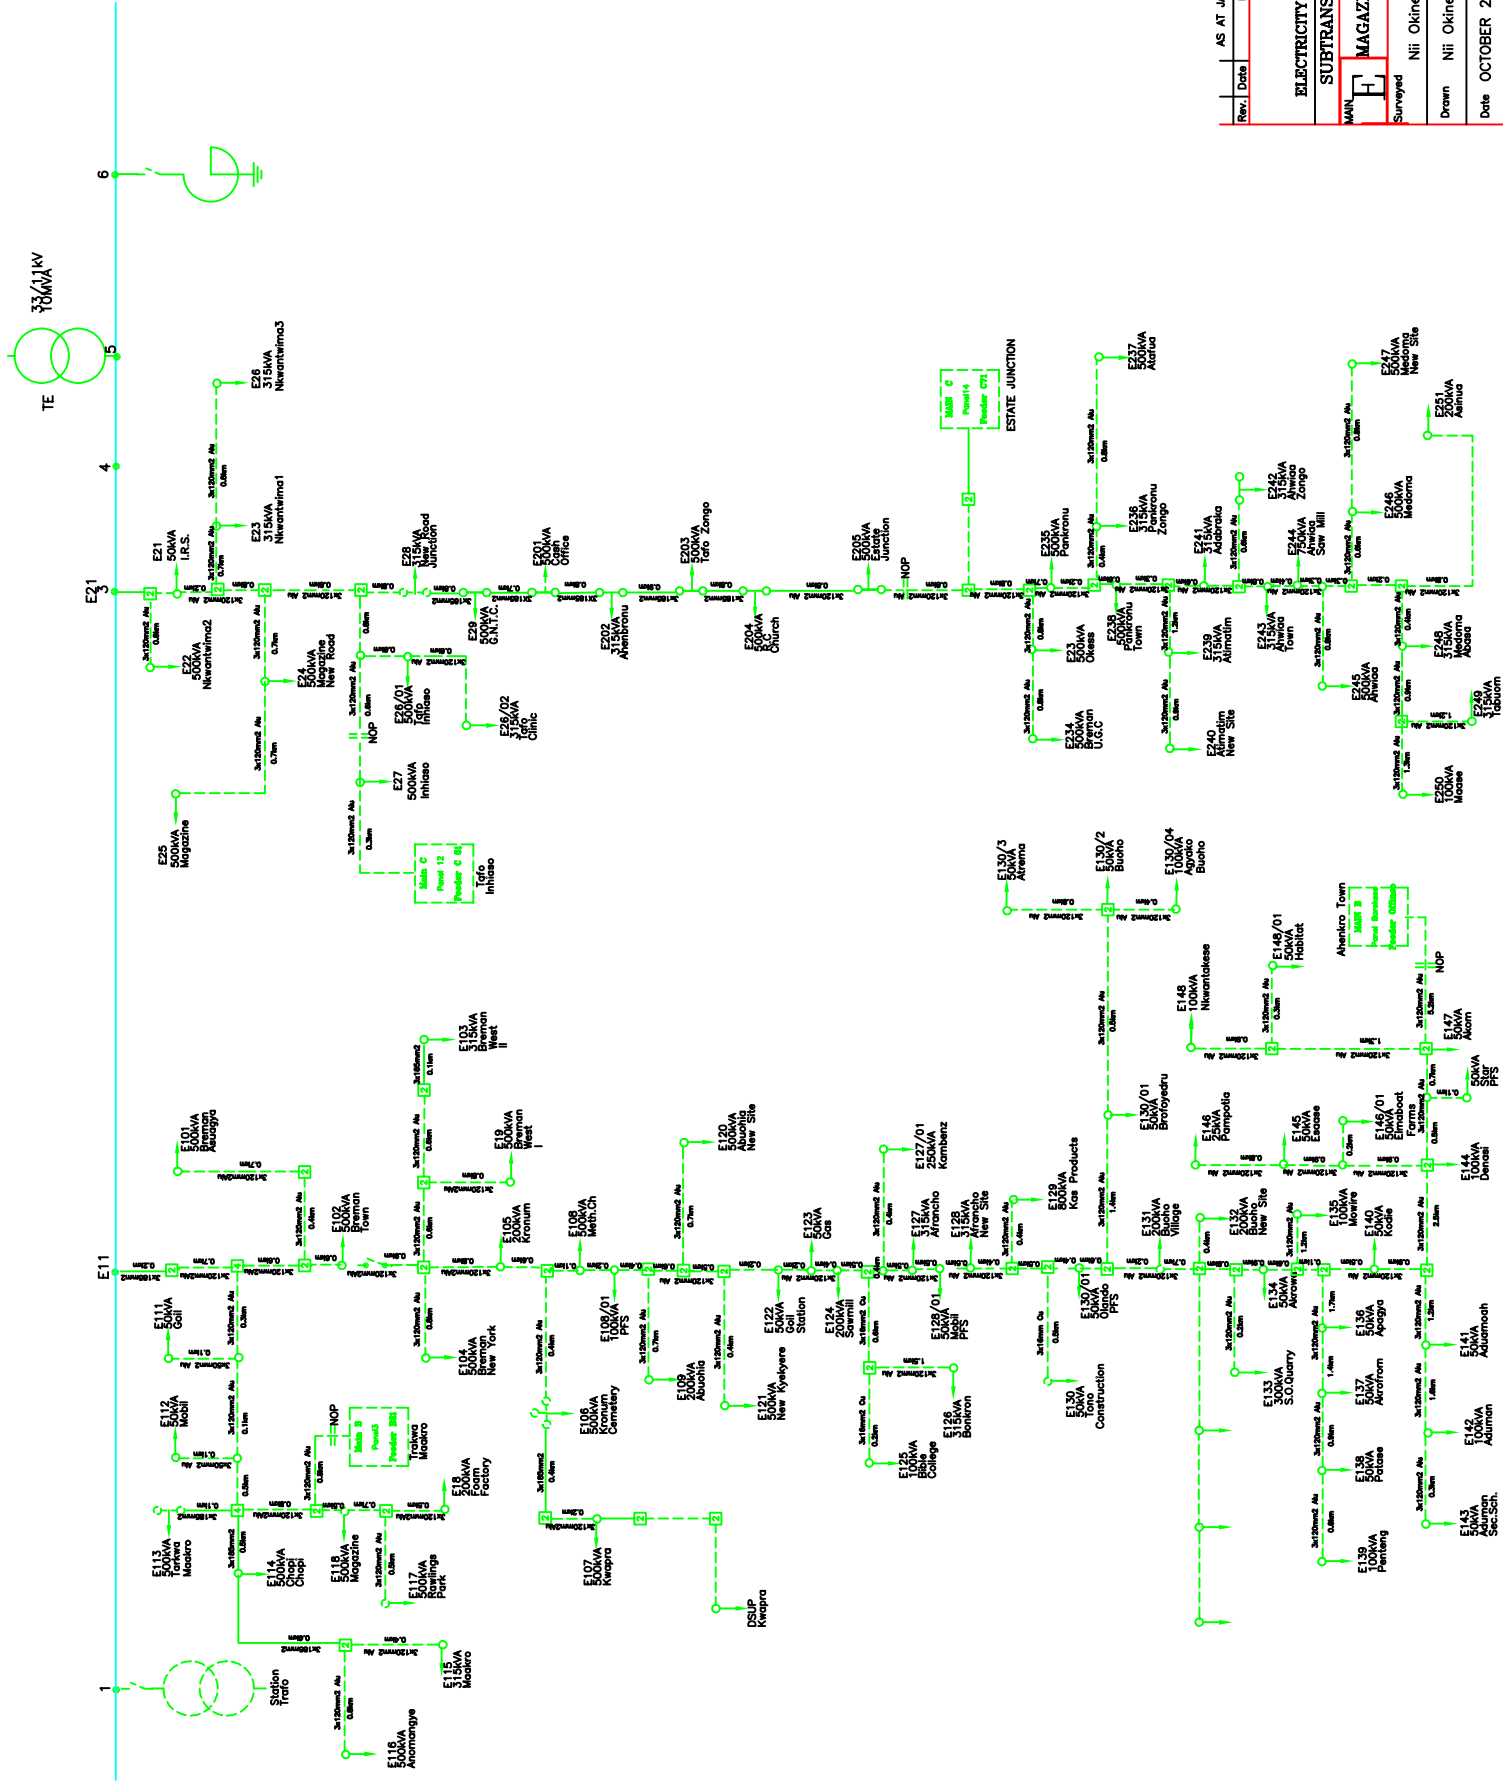

Rev.	Date	Revision	Drawn	Checked
	AS AT JANUARY 2005			
 ELECTRICITY COMPANY OF GHANA SUBTRANSMISSION (KUMASI)				
MAN.	MAGAZINE S/SILK V NETWORK			
Surveyed	Nii Okine	Approved	Reg.	Eng.
Drawn	Nii Okine	Checked	SQM	Abosi
Date	OCTOBER 2004	Scale	N.T.S.	

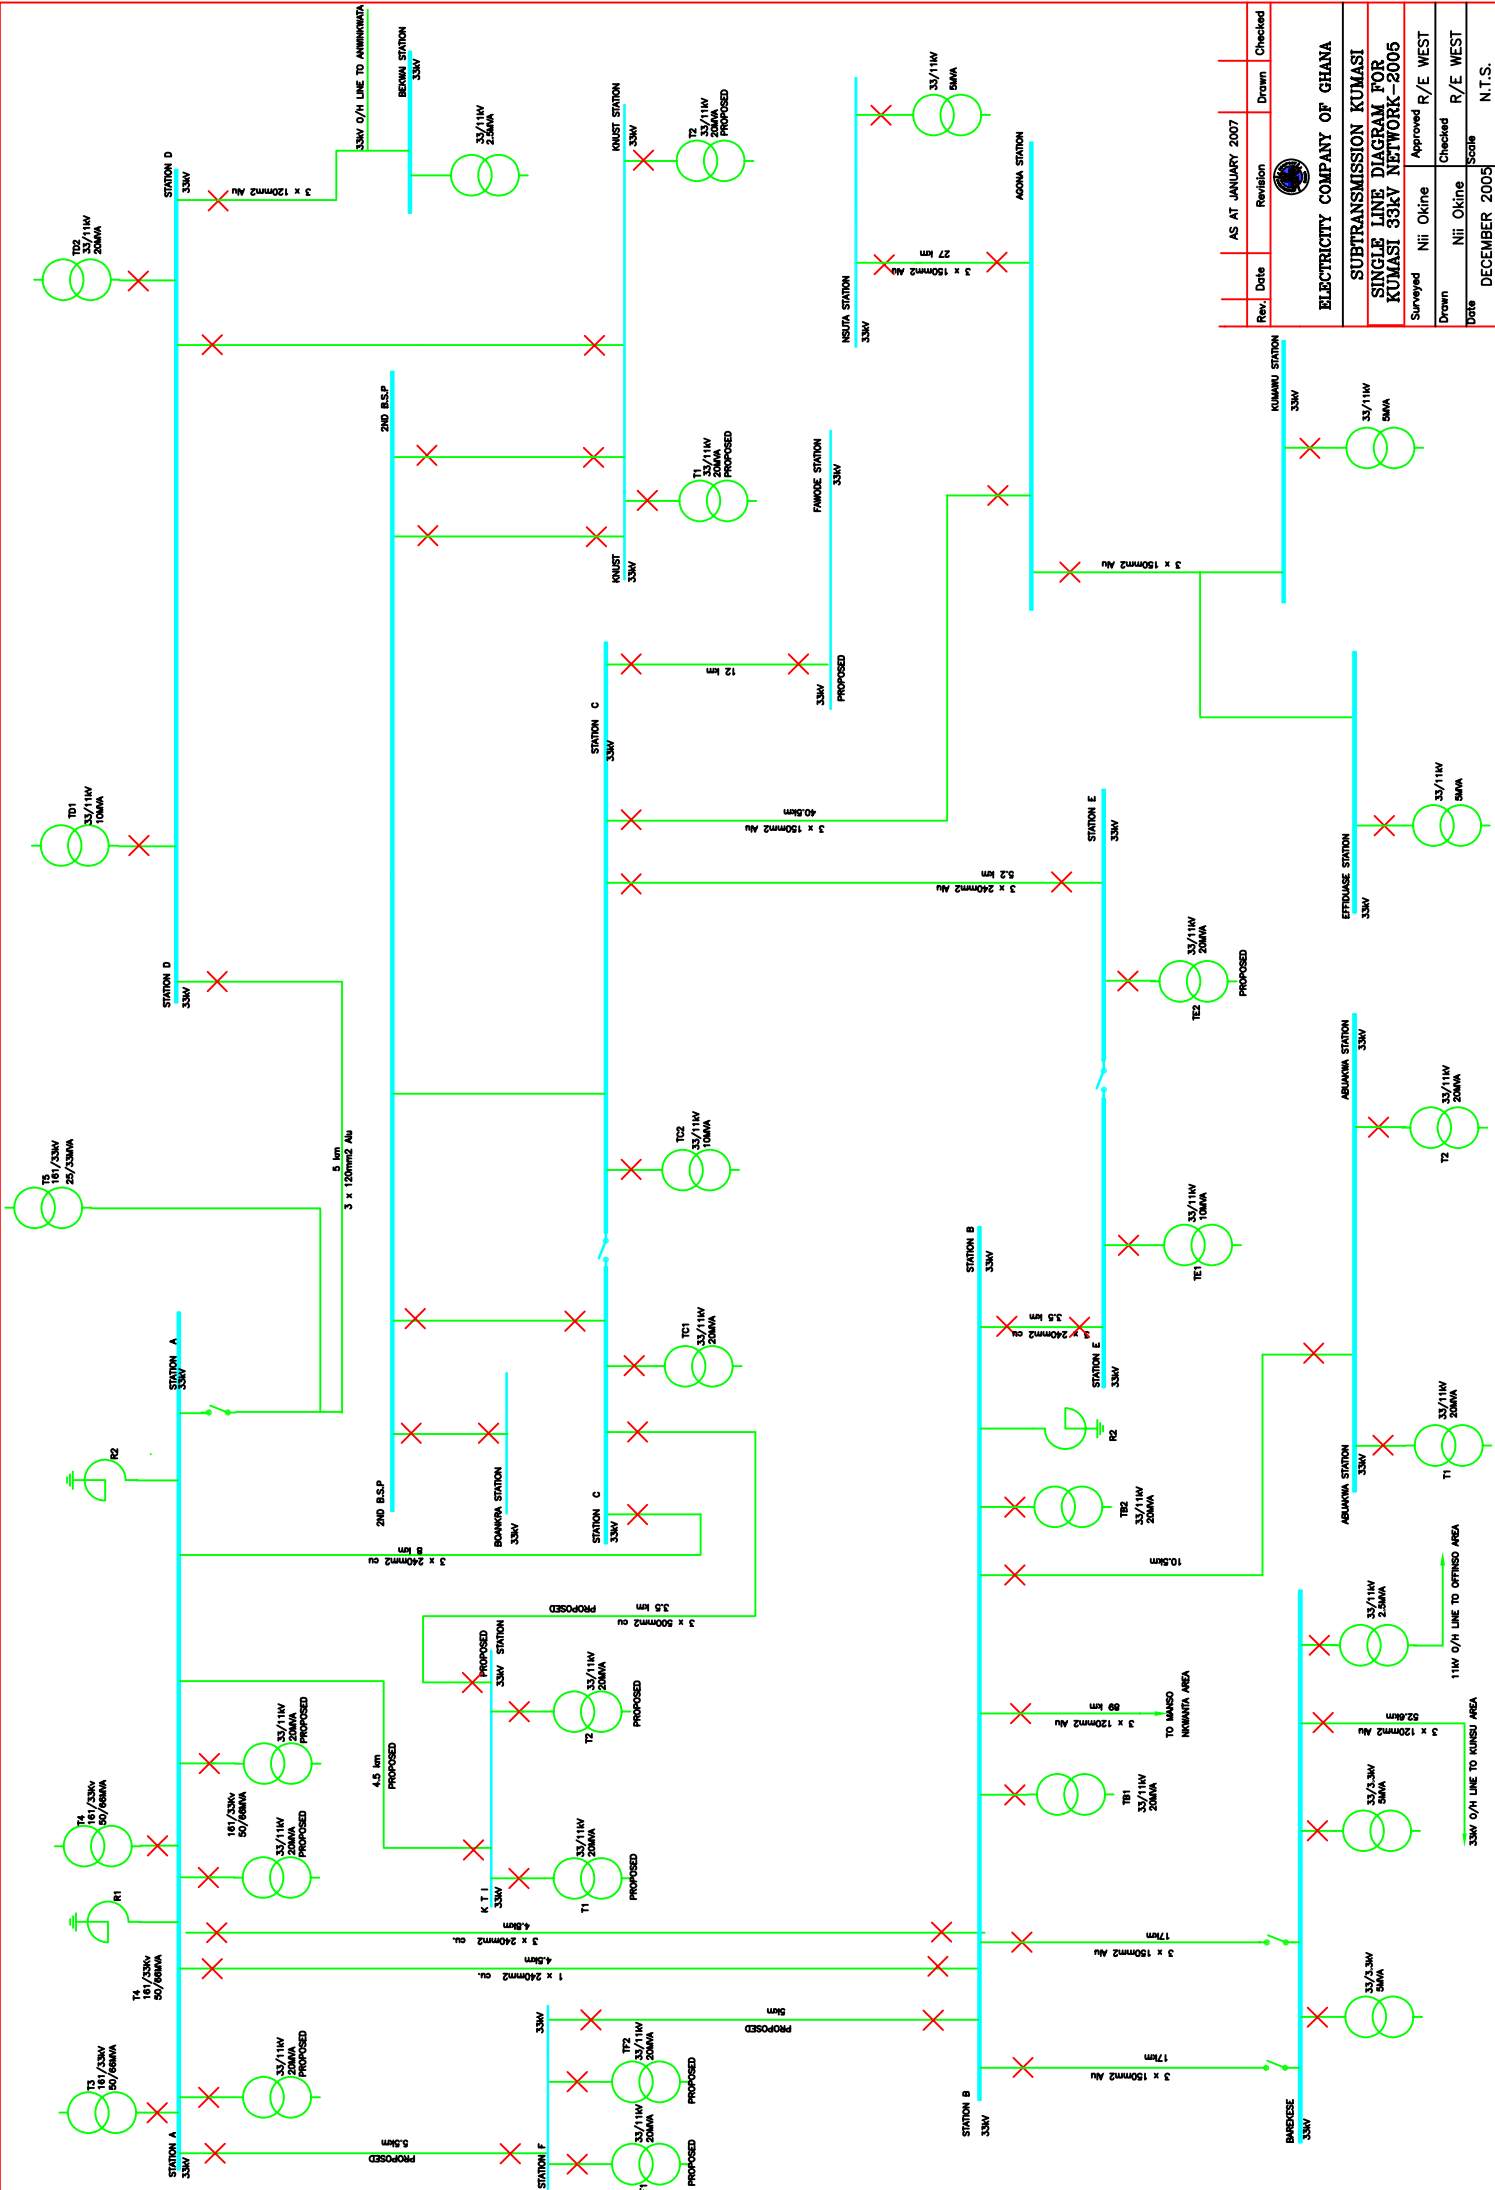

Rev.	Date	Revision	Drawn	Checked
	AS AT JANUARY 2007			



ELECTRICITY COMPANY OF GHANA
SUBTRANSMISSION KUMASI
SINGLE LINE DIAGRAM FOR
KUMASI 33KV NETWORK-2005

Surveyed: Nii Okine
 Approved: R/E WEST
 Drawn: Nii Okine
 Checked: R/E WEST
 Date: DECEMBER 2005
 Score: N.T.S.