



Plan C-C s=1:100

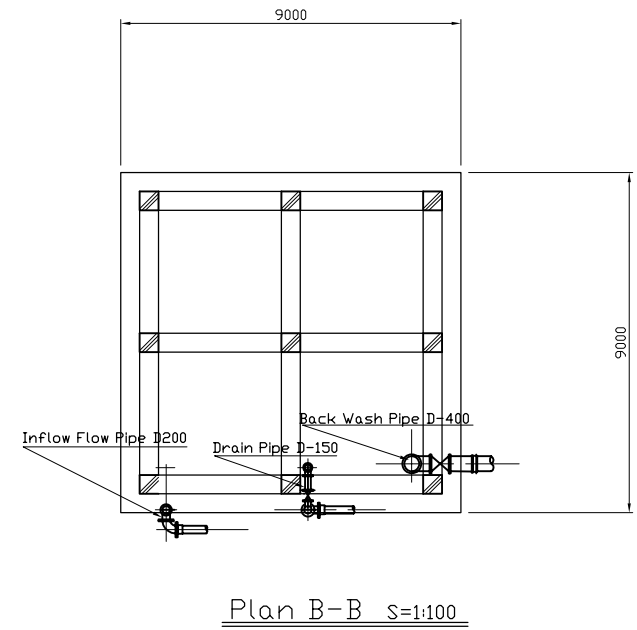


Plan B-B s=1:100


Elevated Tank s=1:100

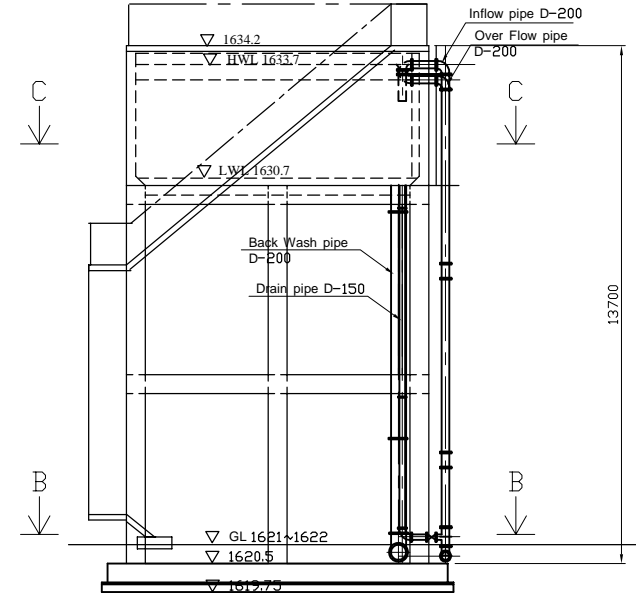

Section A-A s=1:100

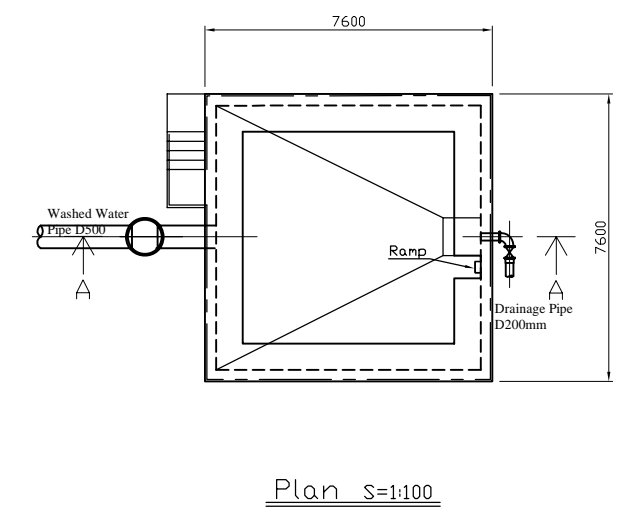

Plan s=1:100

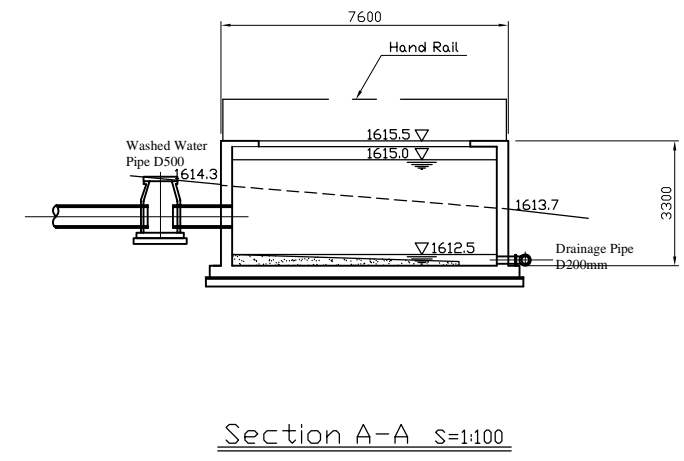


Section A-A s=1:100


Washed Water Tank s=1:100

*Inside of bass and wall encompassing the structure shall be water-proof painting.

Project Name	
The Basic Design Study on the Project for Improvement of Water Supply System in Embu and the Surrounding Areas	
ケニア国エンブ市及び周辺地域給水システム改善計画準備調査	
Drawing Title	Scale: 1/100
Mukangu WTP	Drawing No. 13 of 27
Elevated Tank and Washed Water Drainage Tank Plan and Section	




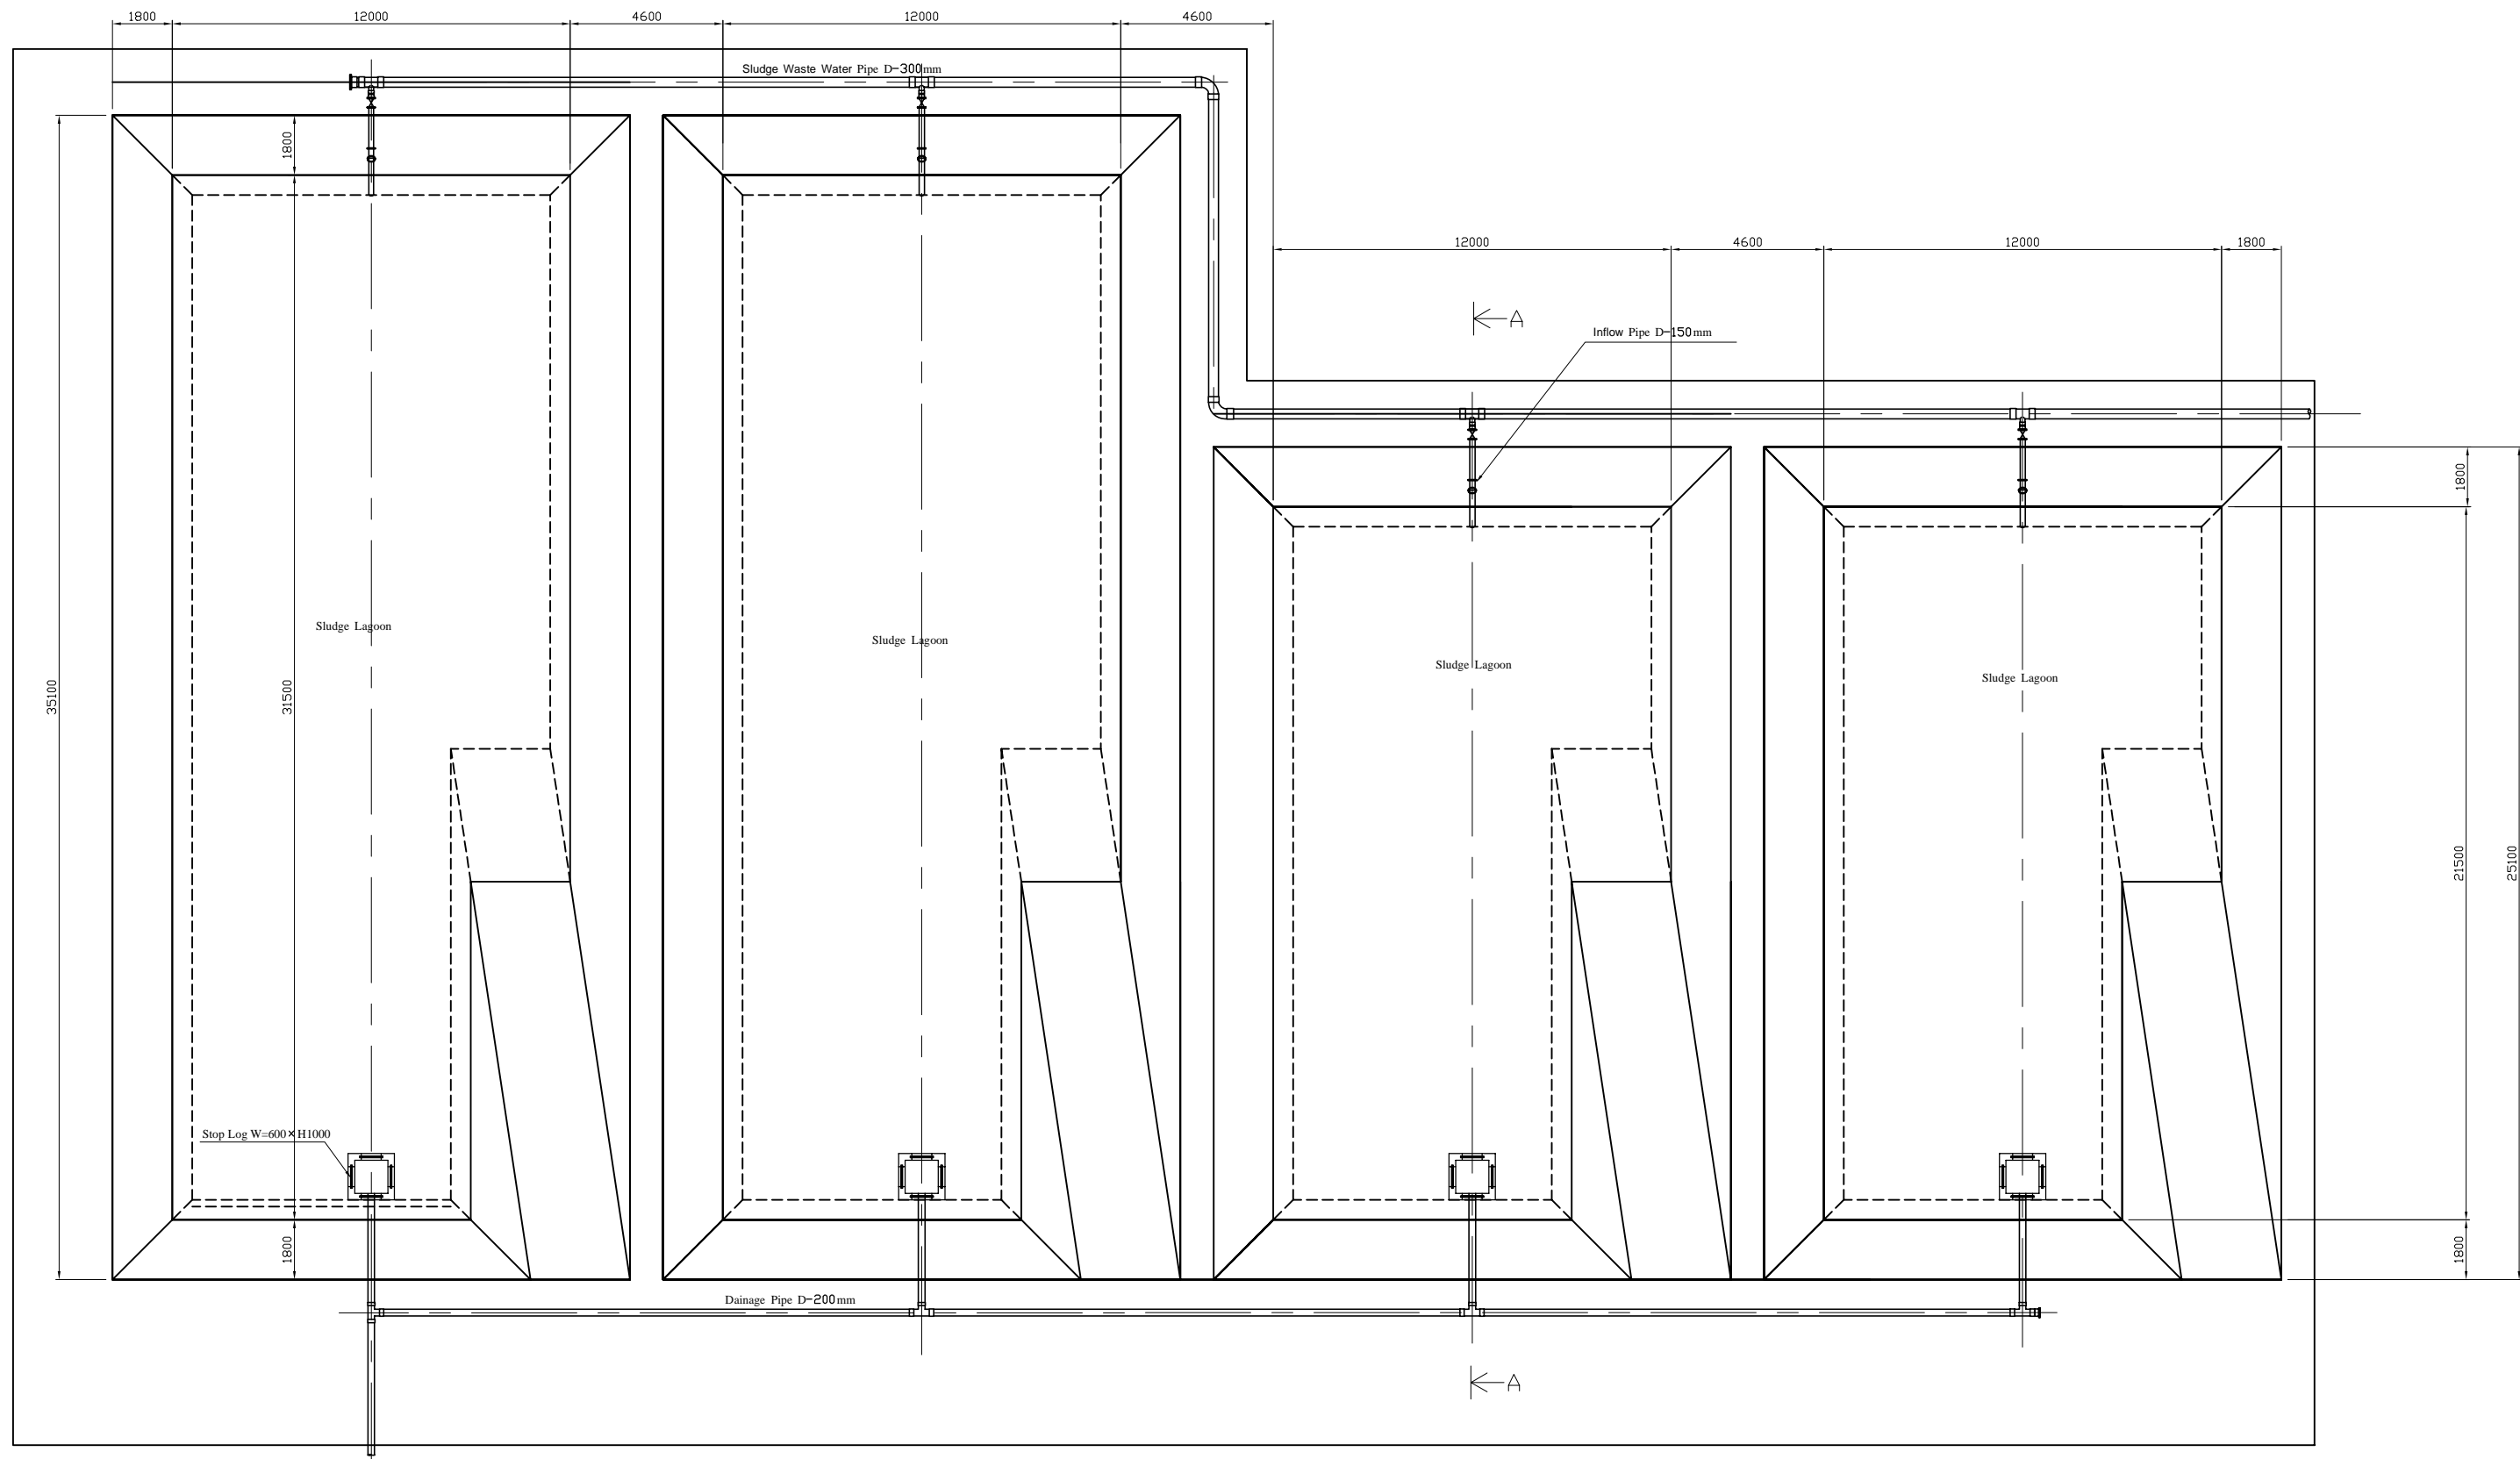


Sludge Lagoon Plan s=1:100

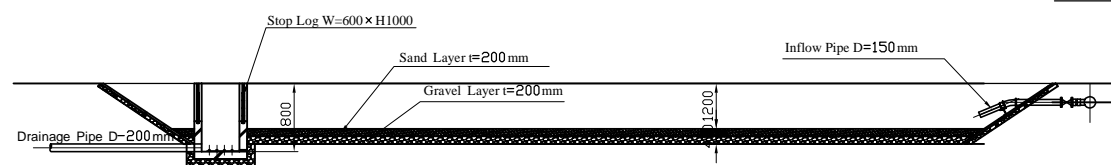


Section A-A s=1:100


Project Name	
The Basic Design Study on the Project for Improvement of Water Supply System in Embu and the Surrounding Areas	
ケニア国エンブ市及び周辺地域給水システム改善計画準備調査	
Drawing Title	
Mukangu WTP	Scale: 1/100
Sludge Lagoon Plan and Section	Drawing No. 14 of 27

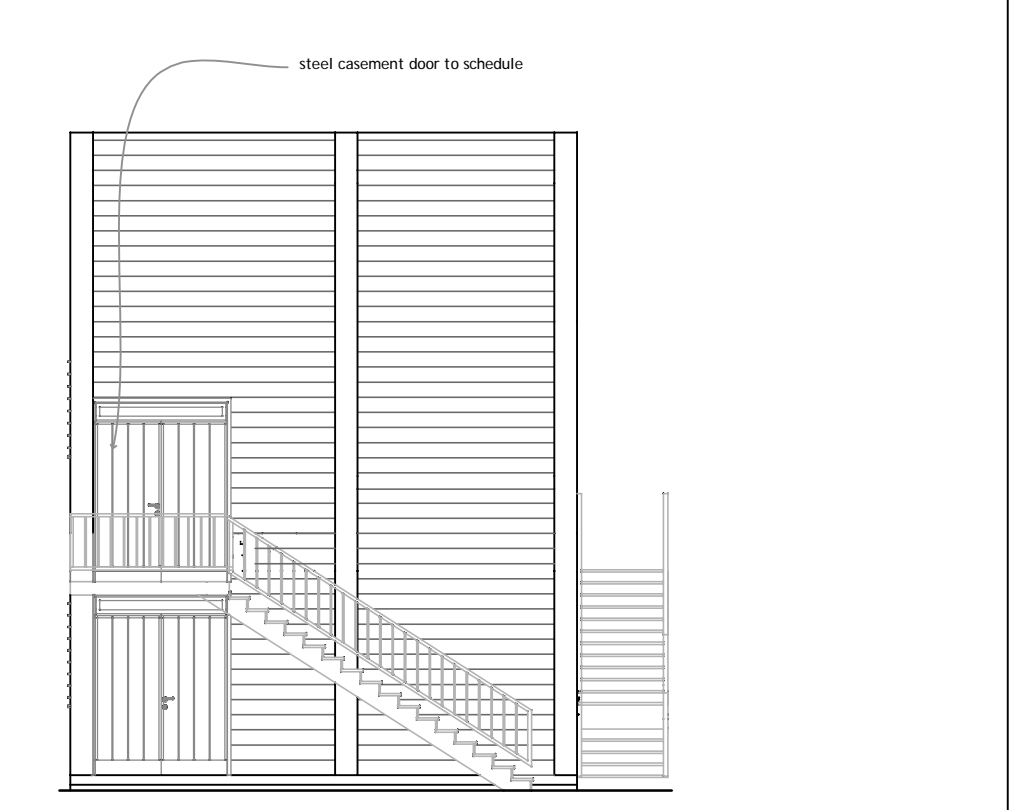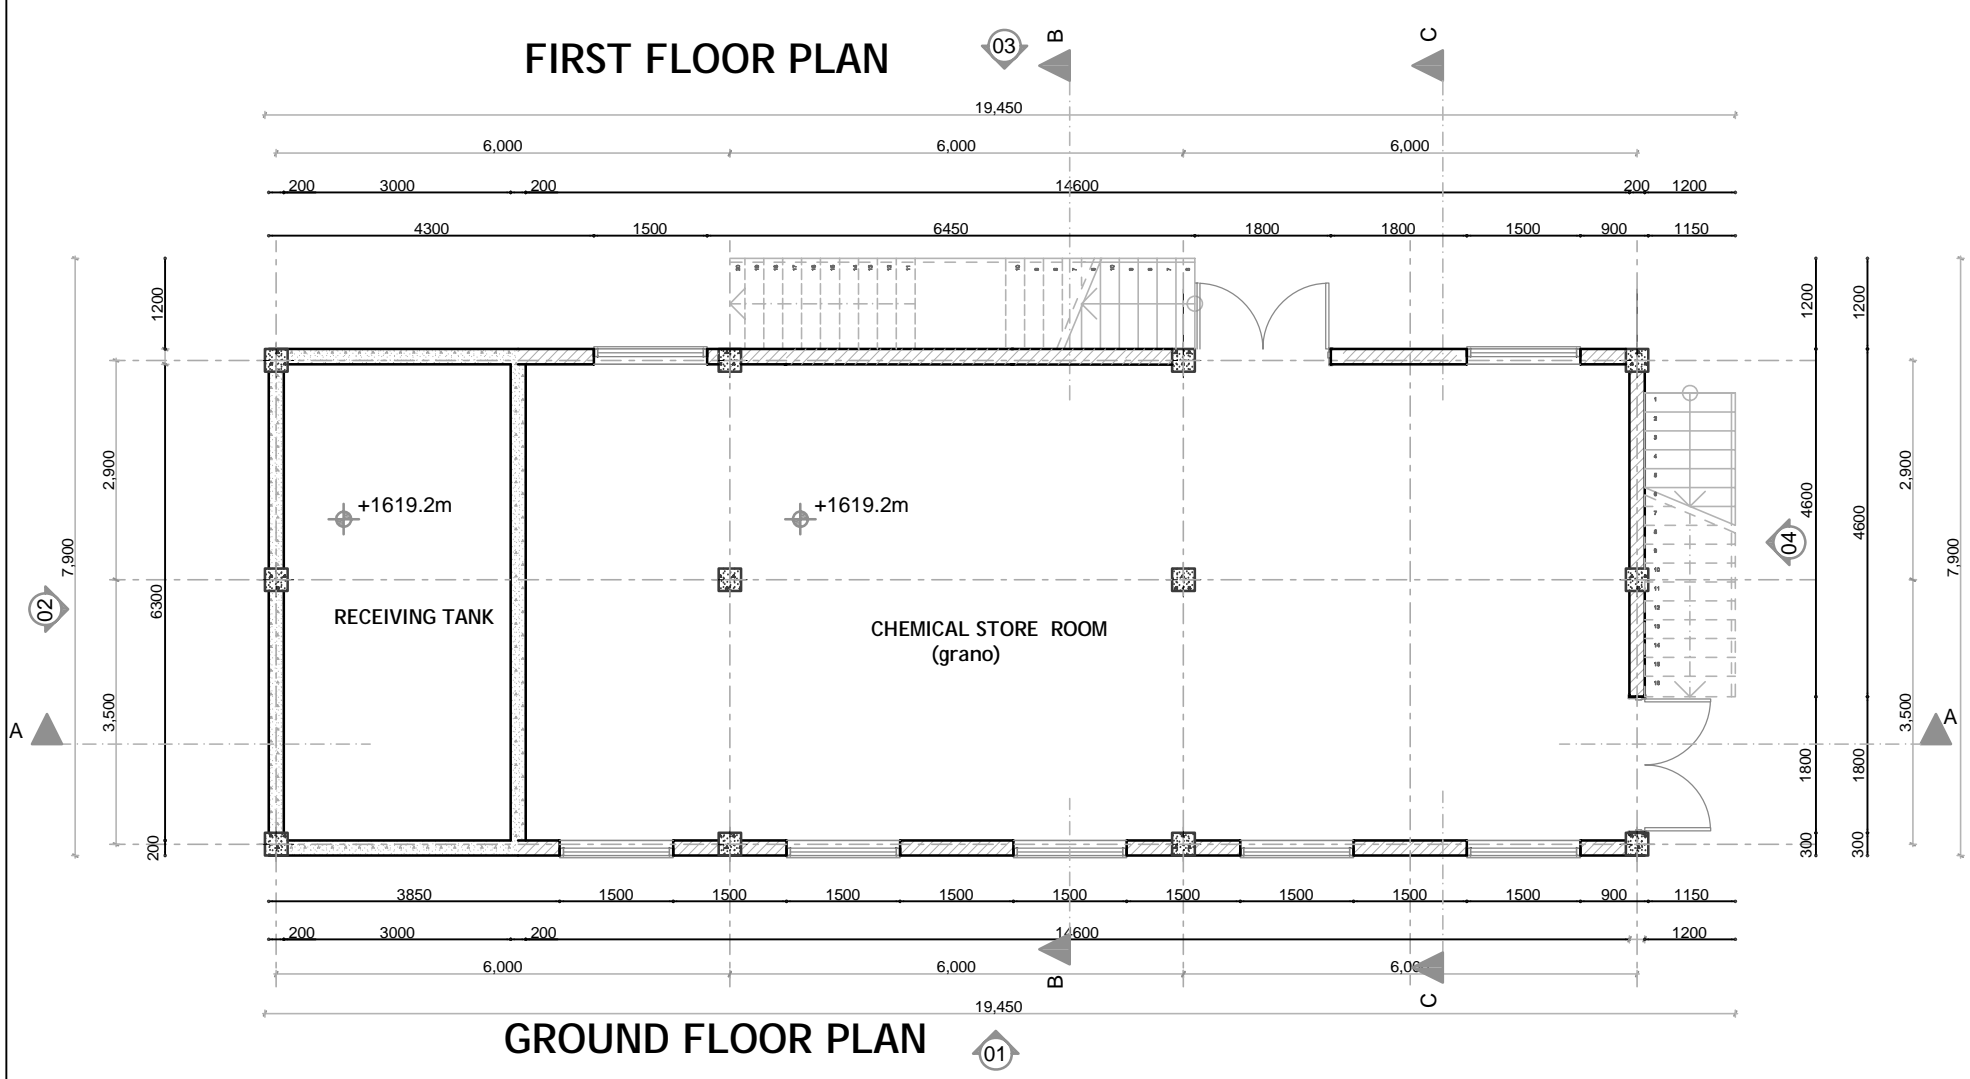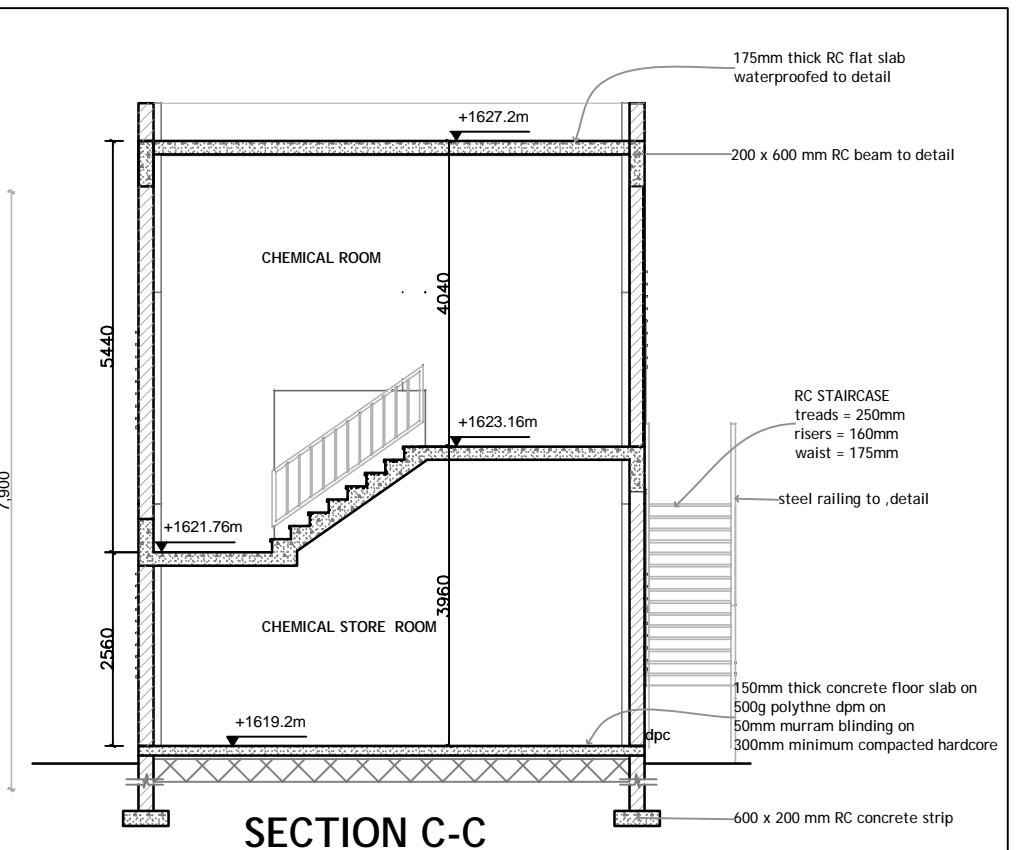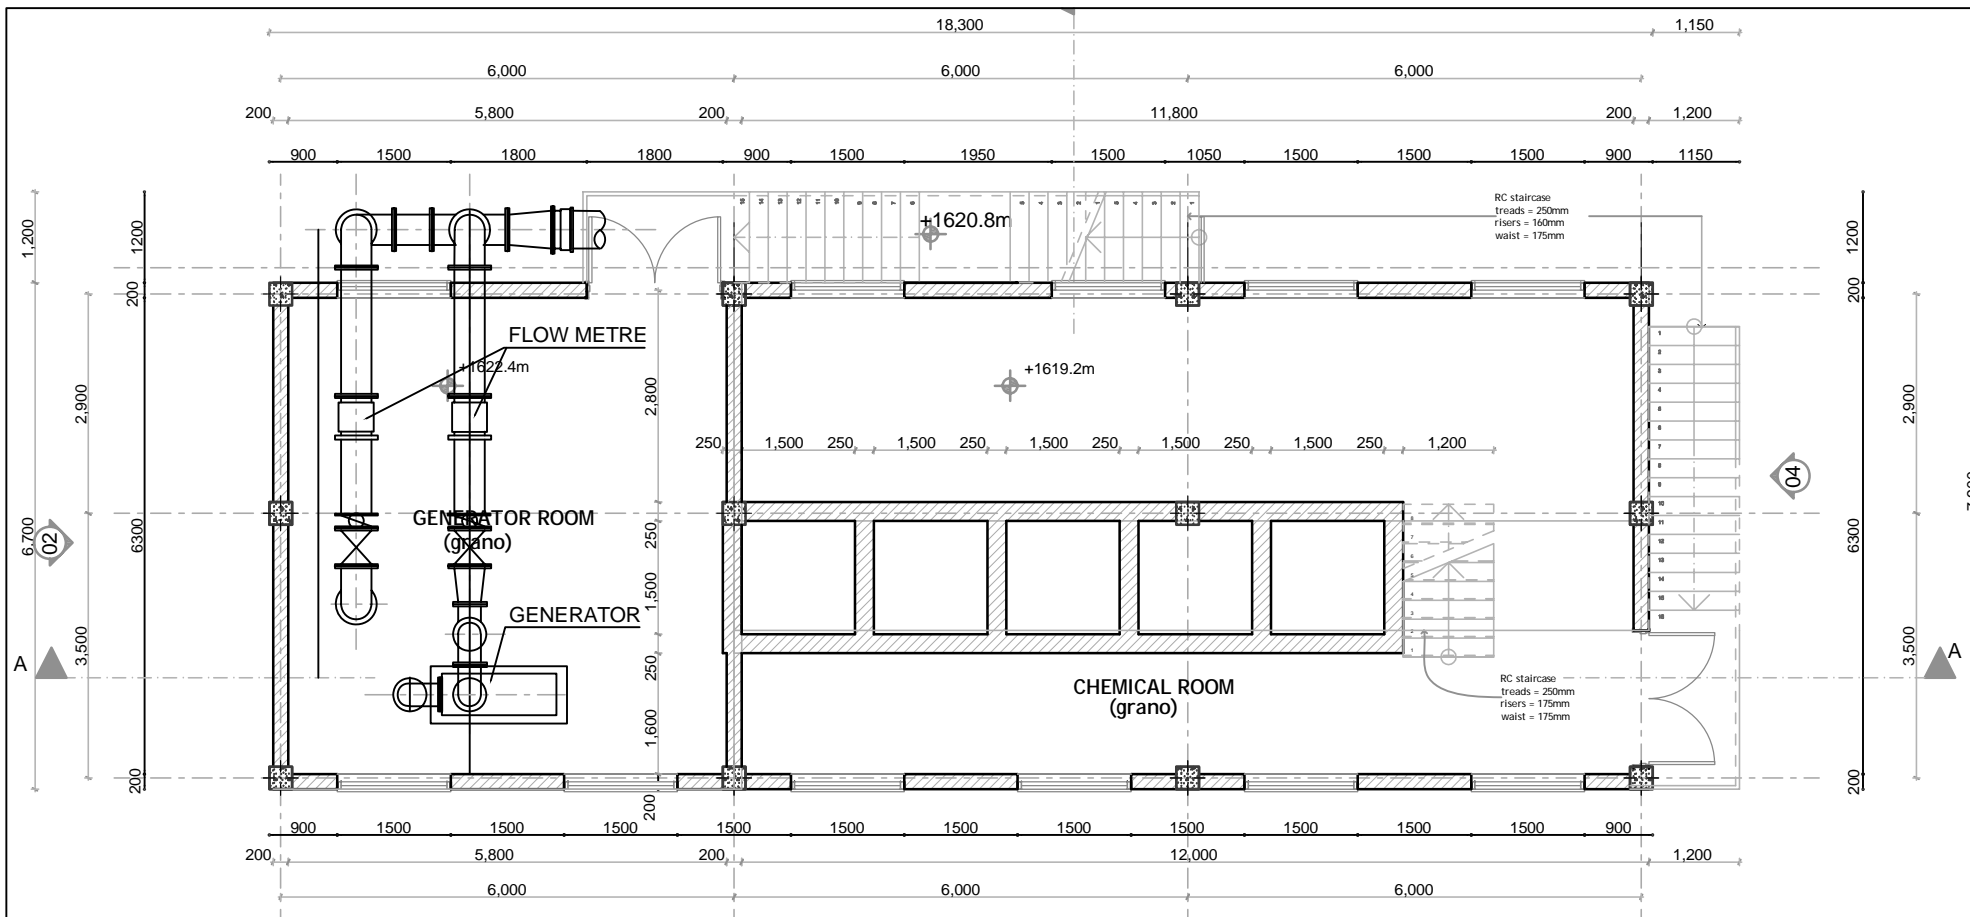


Project Name	
The Basic Design Study on the Project for Improvement of Water Supply System in Embu and the Surrounding Areas	
ケニア国エンブ市及び周辺地域給水システム改善計画準備調査	
Drawing Title	
Mukangu WTP Generator/Electrical Building Plan Section and Elevation	
Scale: 1:100	Drawing No. 15 of 27

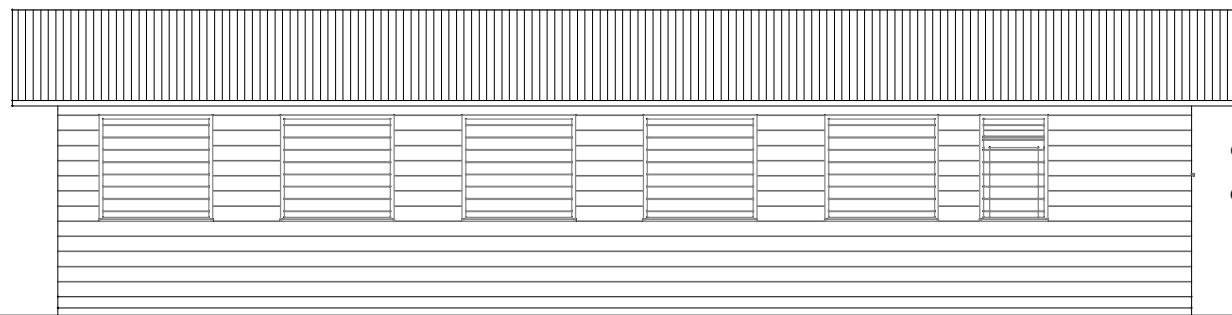


ELEVATION 03

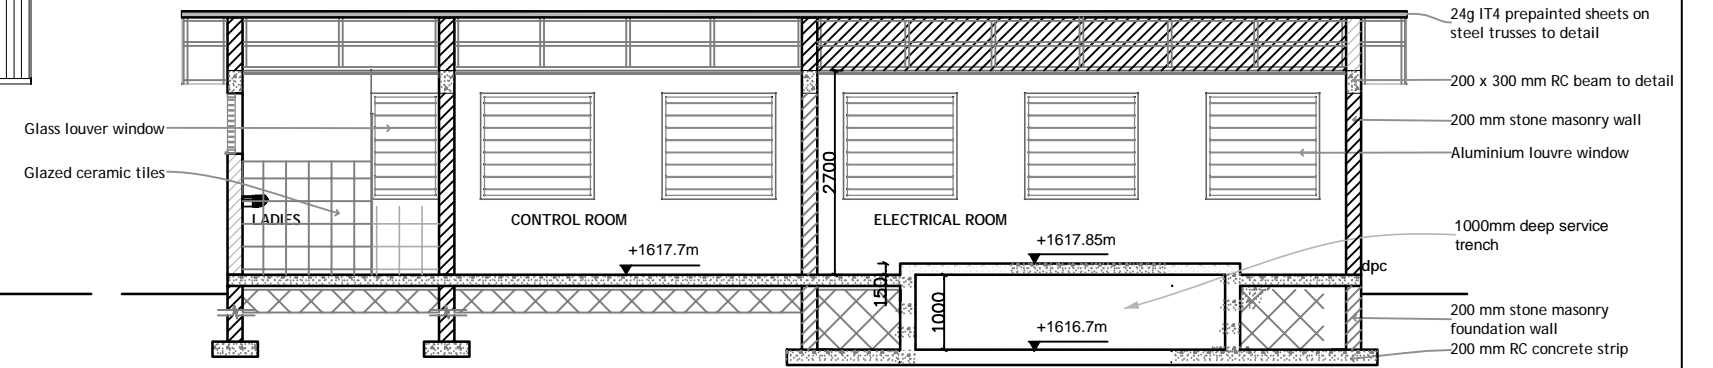

SECTION A-A

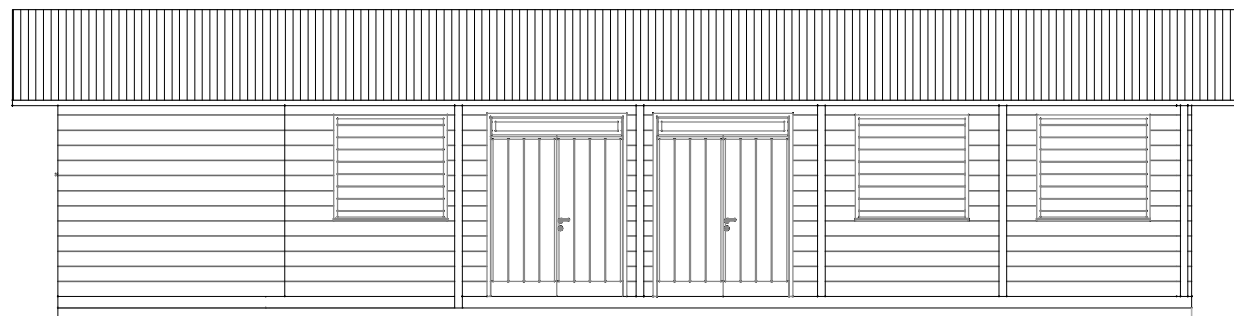


ELEVATION 01

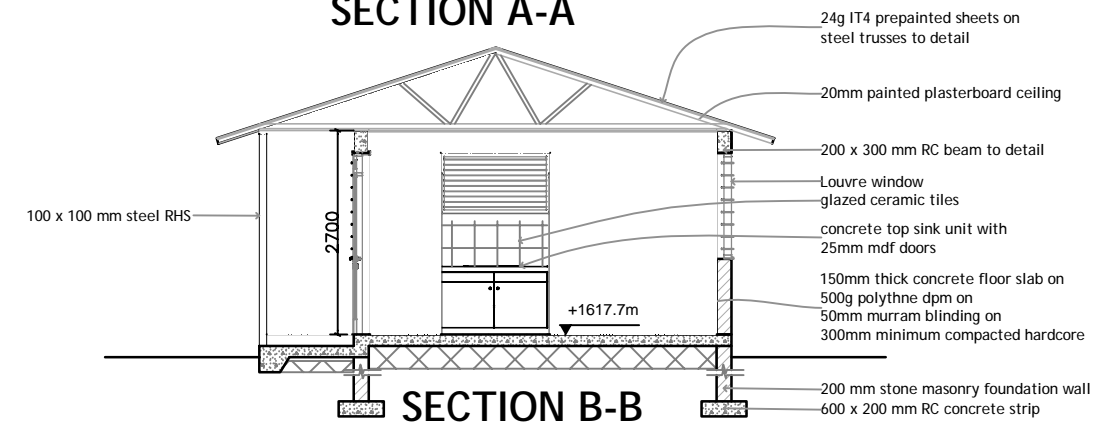

SECTION B-B



ELEVATION 04

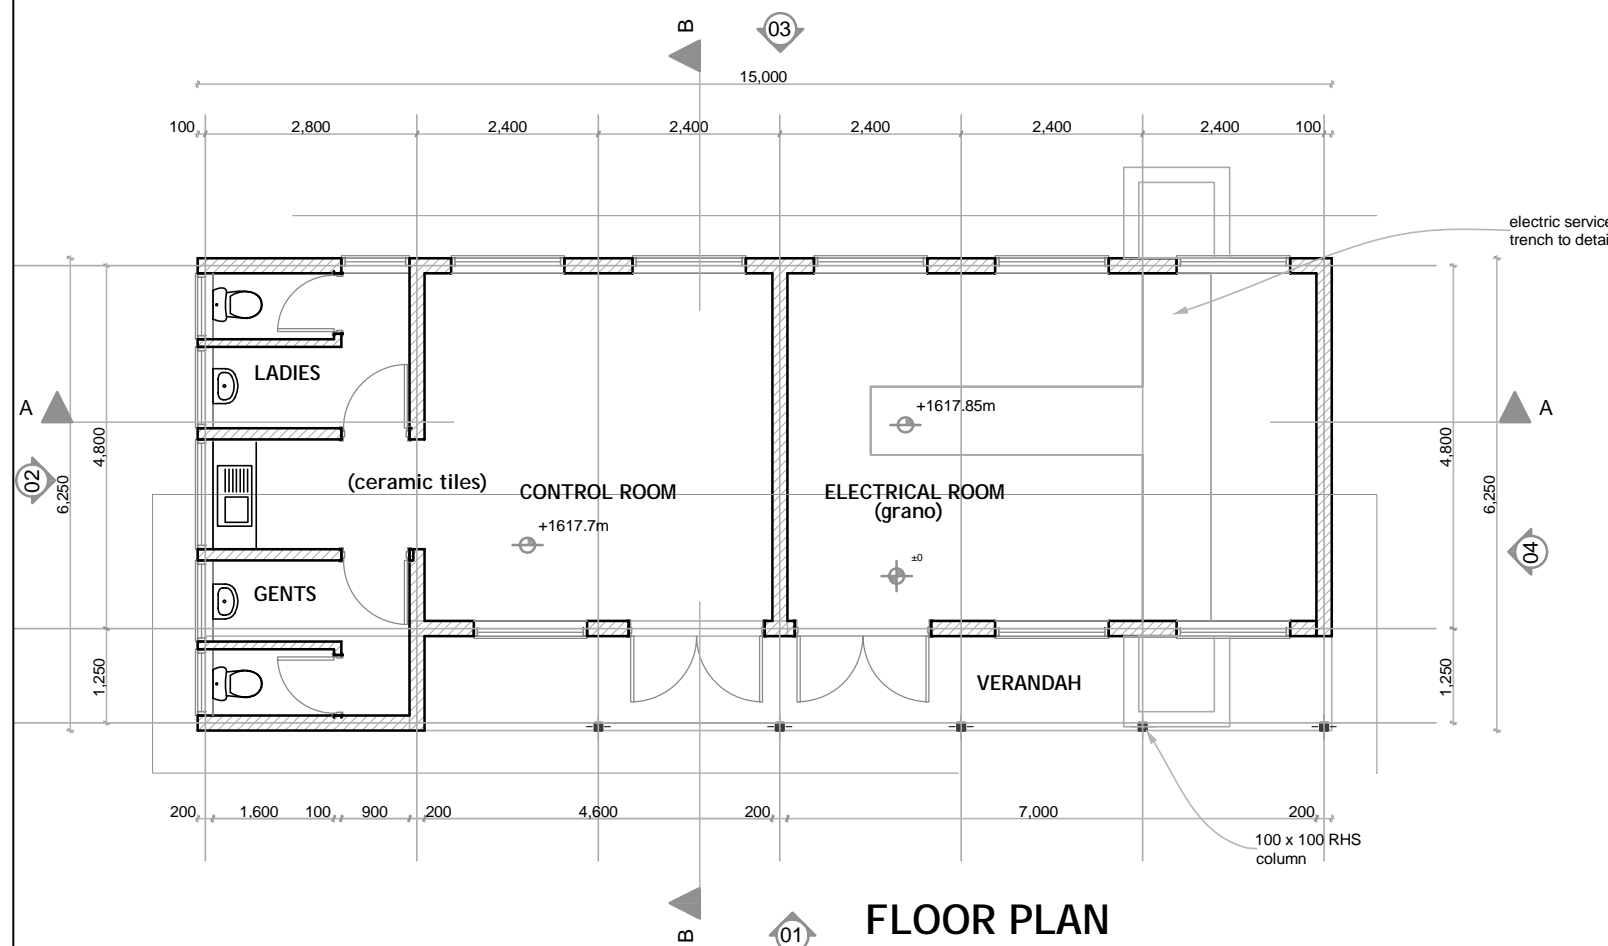


FLOOR PLAN




ELEVATION 02


Project Name	
The Basic Design Study on the Project for Improvement of Water Supply System in Embu and the Surrounding Areas	
ケニア国エンブ市及び周辺地域給水システム改善計画準備調査	
Drawing Title	Scale:
Mukangu WTP Control/Electrical Building Plan and Section	
Drawing No. 16 of 27	

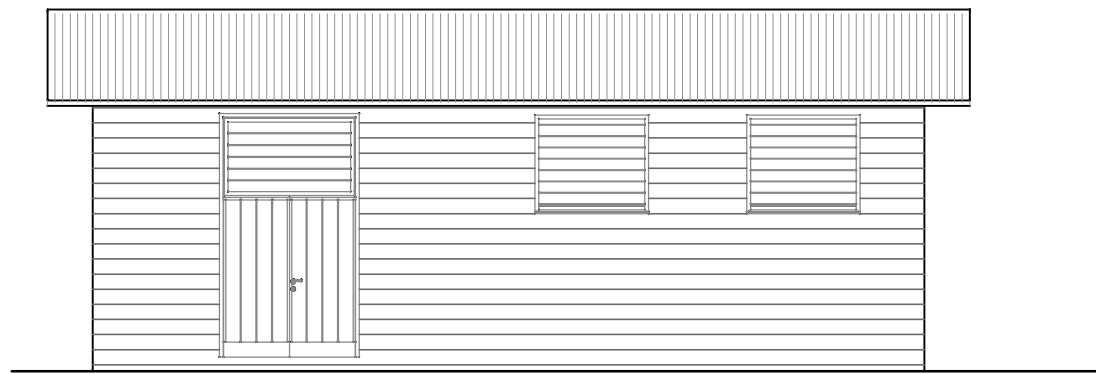

ELEVATION 03

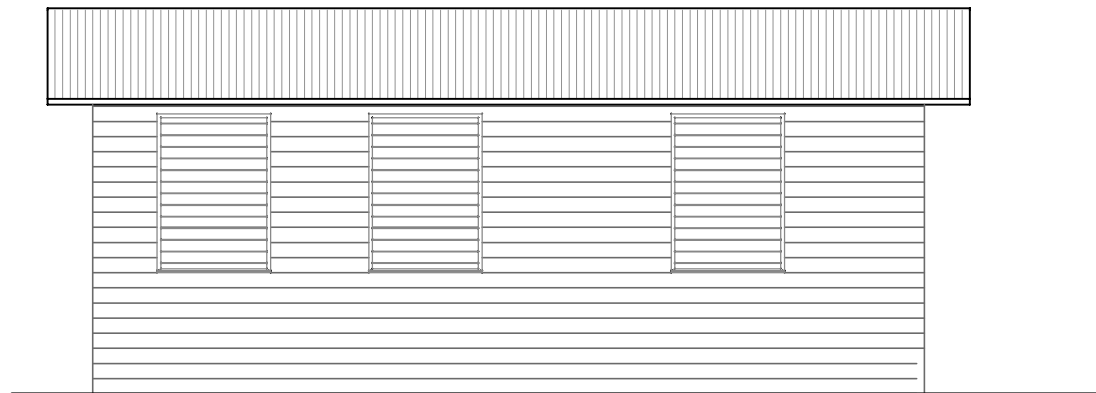


ELEVATION 01

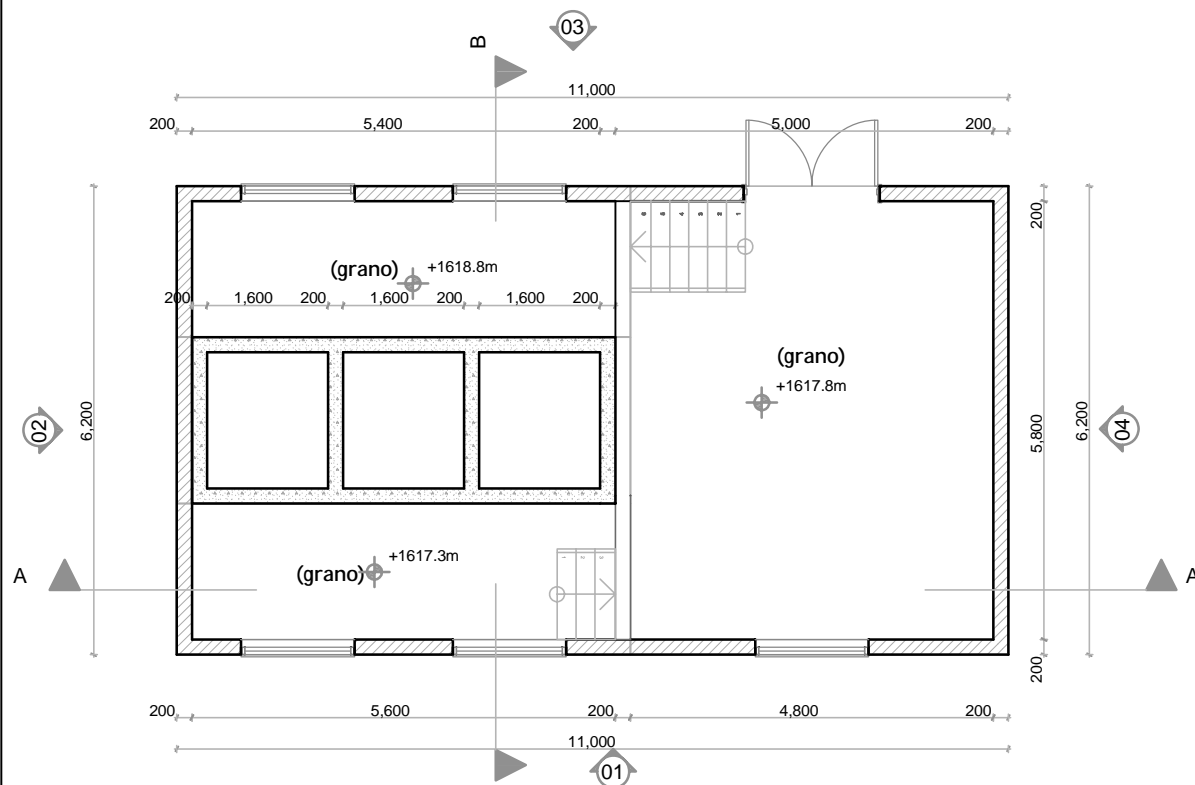


FLOOR PLAN


ELEVATION 04

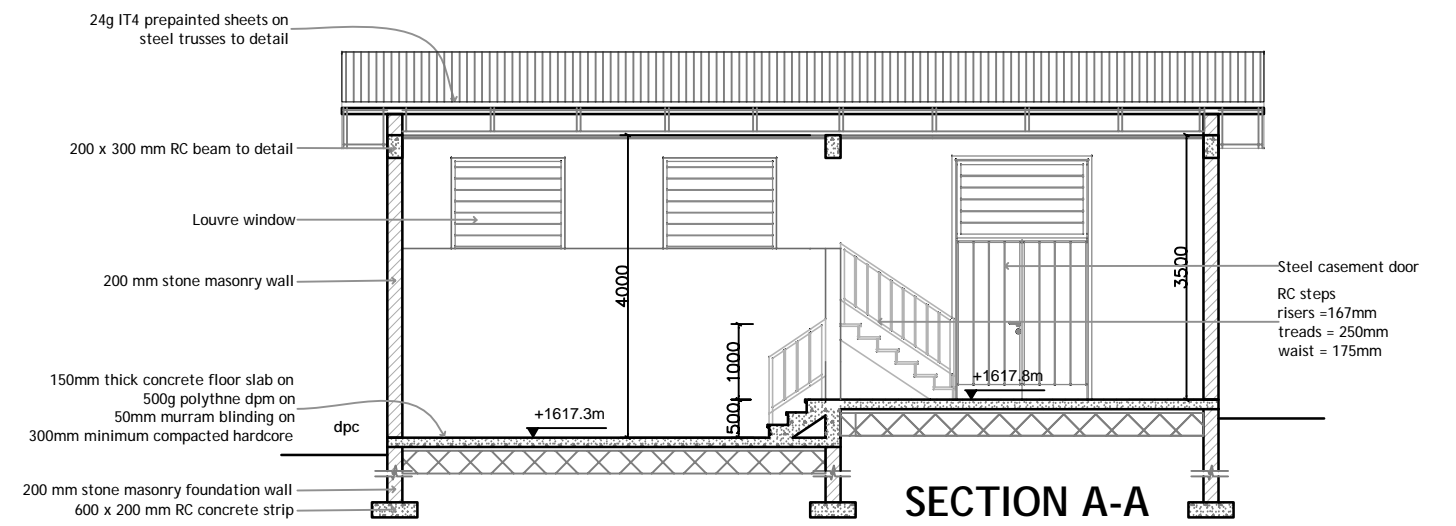


SECTION A-A

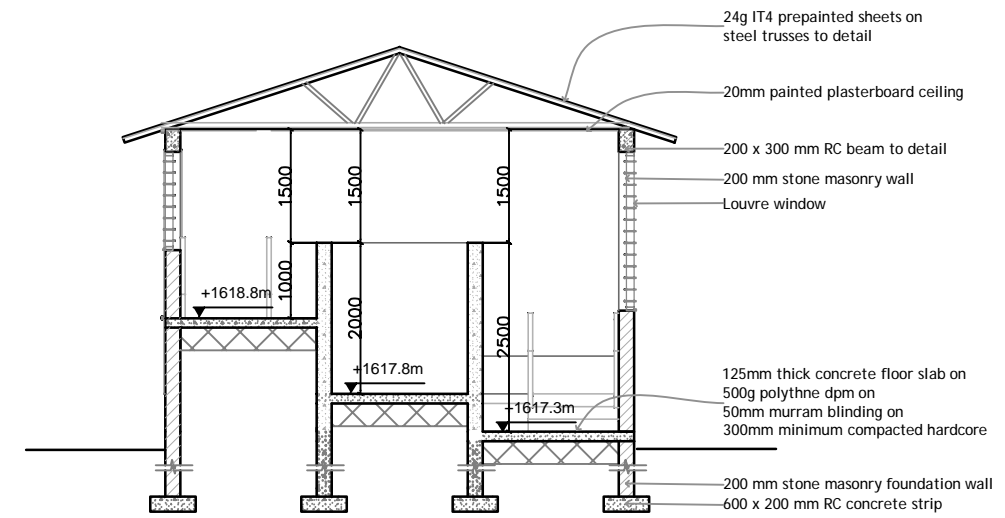


SECTION B-B

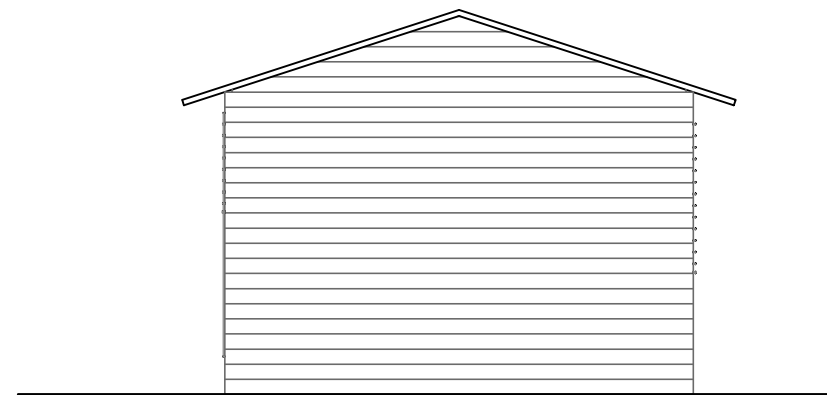


ELEVATION 02

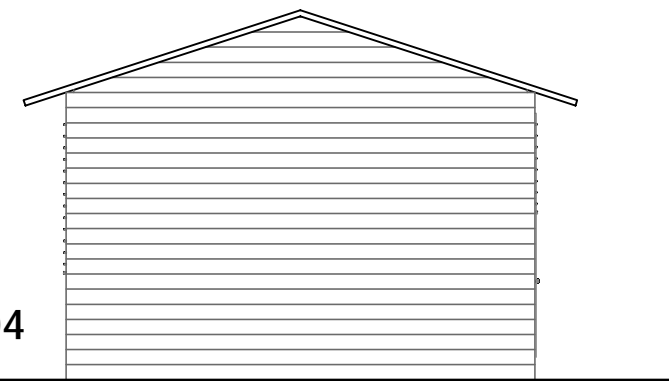


Project Name	
The Basic Design Study on the Project for Improvement of Water Supply System in Embu and the Surrounding Areas	
ケニア国エンブ市及び周辺地域給水システム改善計画準備調査	
Drawing Title	Mukangu WTP Chlorine Dosing House Plan and Section
Scale:	1:100
Drawing No.	17 of 27

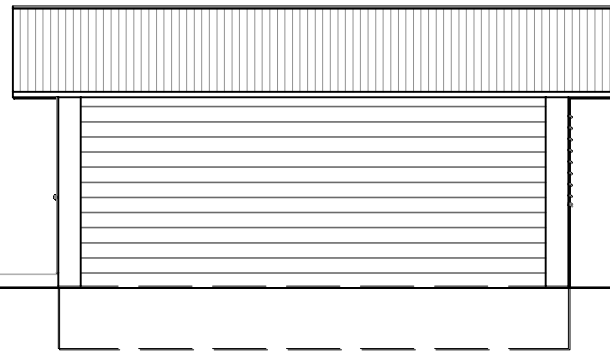


ELEVATION 01

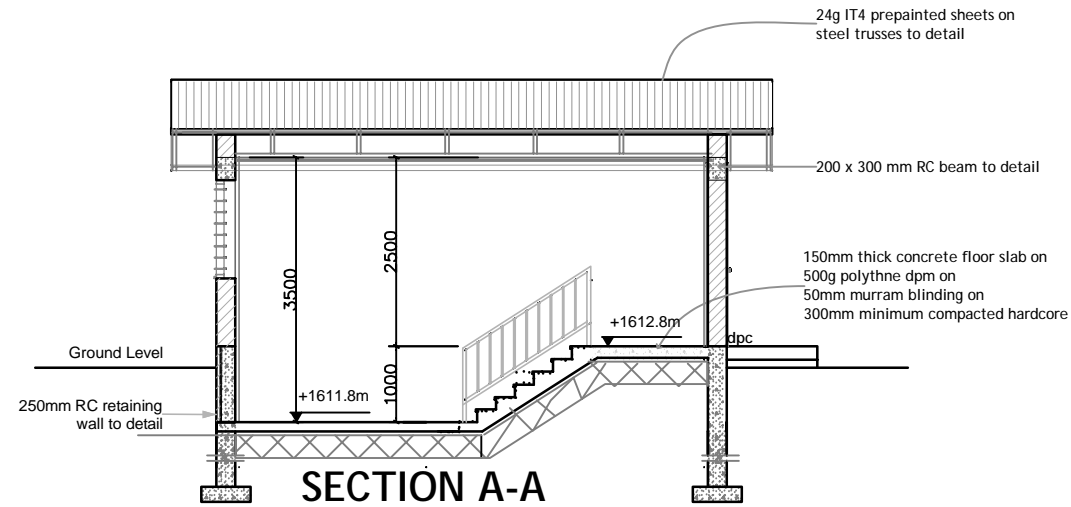


SECTION A-A

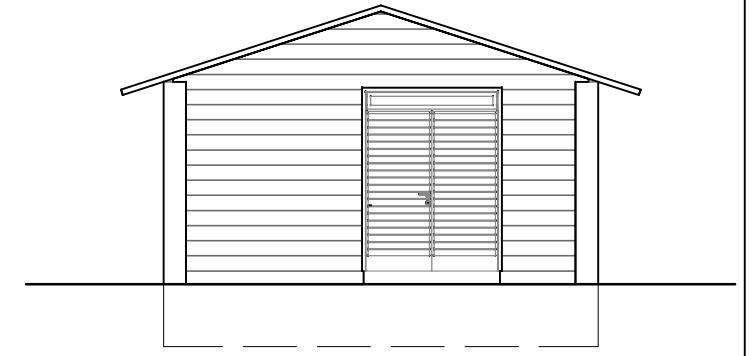


ELEVATION 04

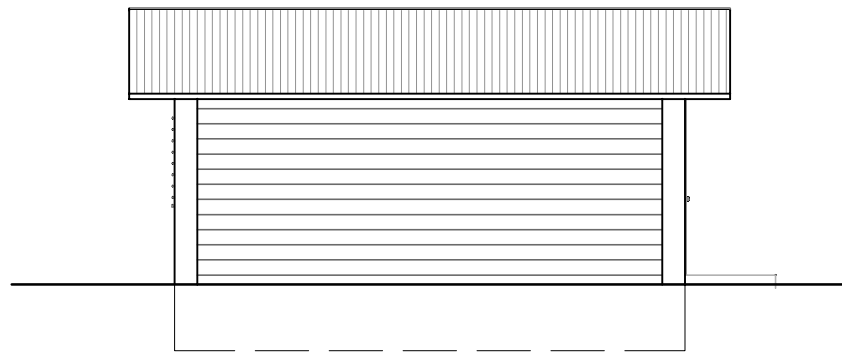


ELEVATION 03

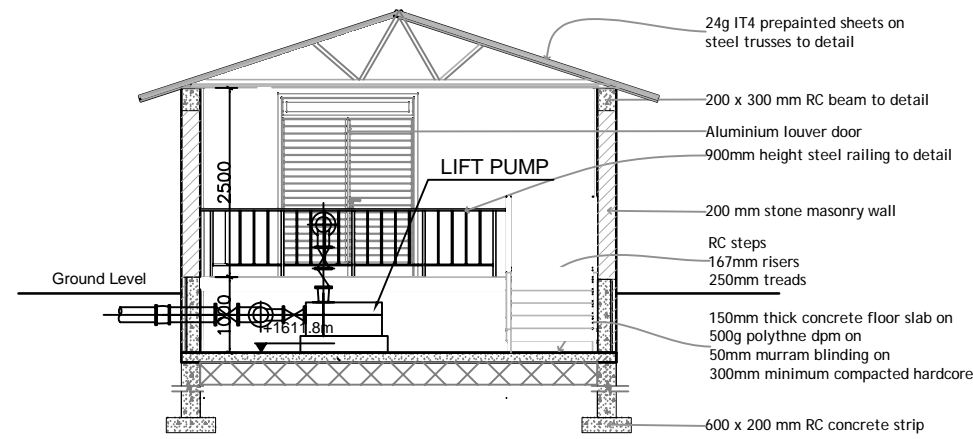

SECTION B-B

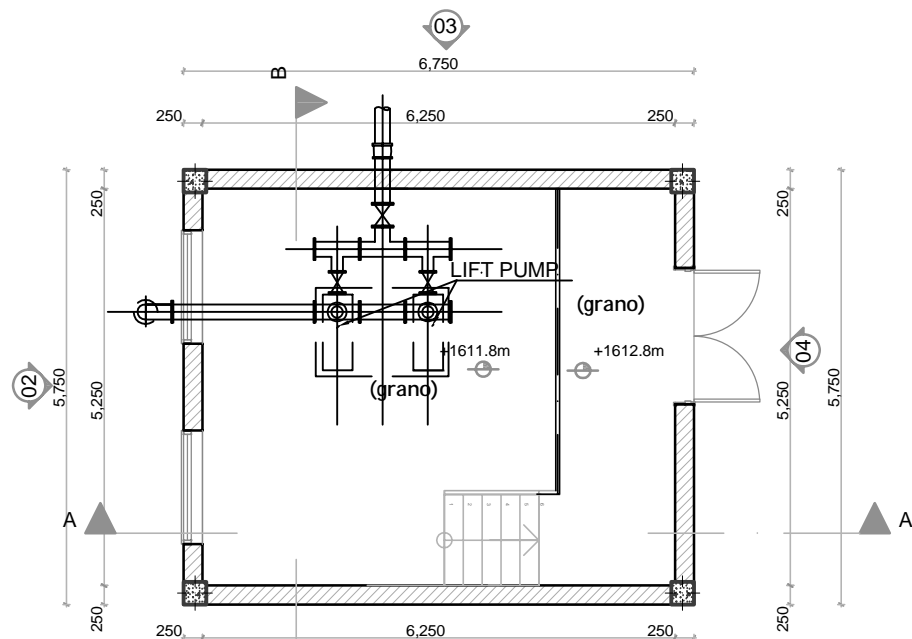

FLOOR PLAN

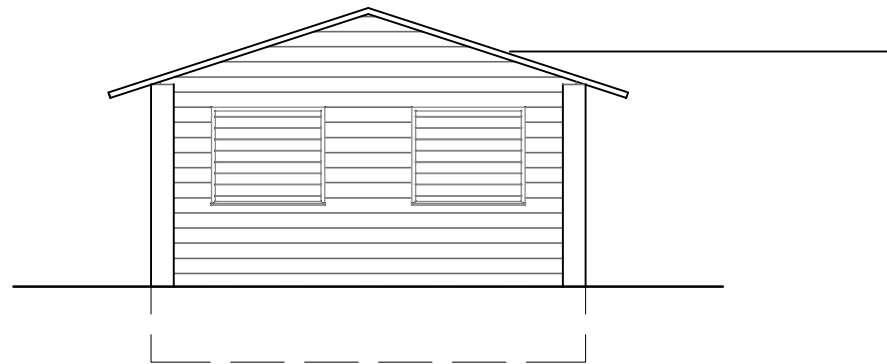

ELEVATION 02

Project Name	
The Basic Design Study on the Project for Improvement of Water Supply System in Embu and the Surrounding Areas	
ケニア国エンブ市及び周辺地域給水システム改善計画準備調査	
Drawing Title	Scale: 1:100
Mukangu WTP Lift Pump Room Plan and Section	Drawing No. 18 Of 26