



DESCRIPTION	PRE-SCREEN CHANNEL LEVEL	POST-SCREEN CHANNEL LEVEL	CHANNEL LEVEL	INFLUENT FLOW	BLOWER FLOW	REACTOR DO	RETURN SLUDGE FLOW
No. OF LOOPS	2	2	1	1	2	2	2
LOGGING	2	2	1	1	2	2	2
MONITOR(OS)	2	2	1	1	2	2	2
CENTRAL MONITORING ROOM	PRESET CYCLE/DURATION TIME SCHEDULE OR PRESET LEVEL DIFFERENCE		PRESET CYCLE/DURATION TIME SCHEDULE		PRESET CYCLE/DURATION TIME SCHEDULE		PRESET DUTY NUMBER IN SERVICE
TRANSMISSION LINE	2	2	1	1	2	2	2

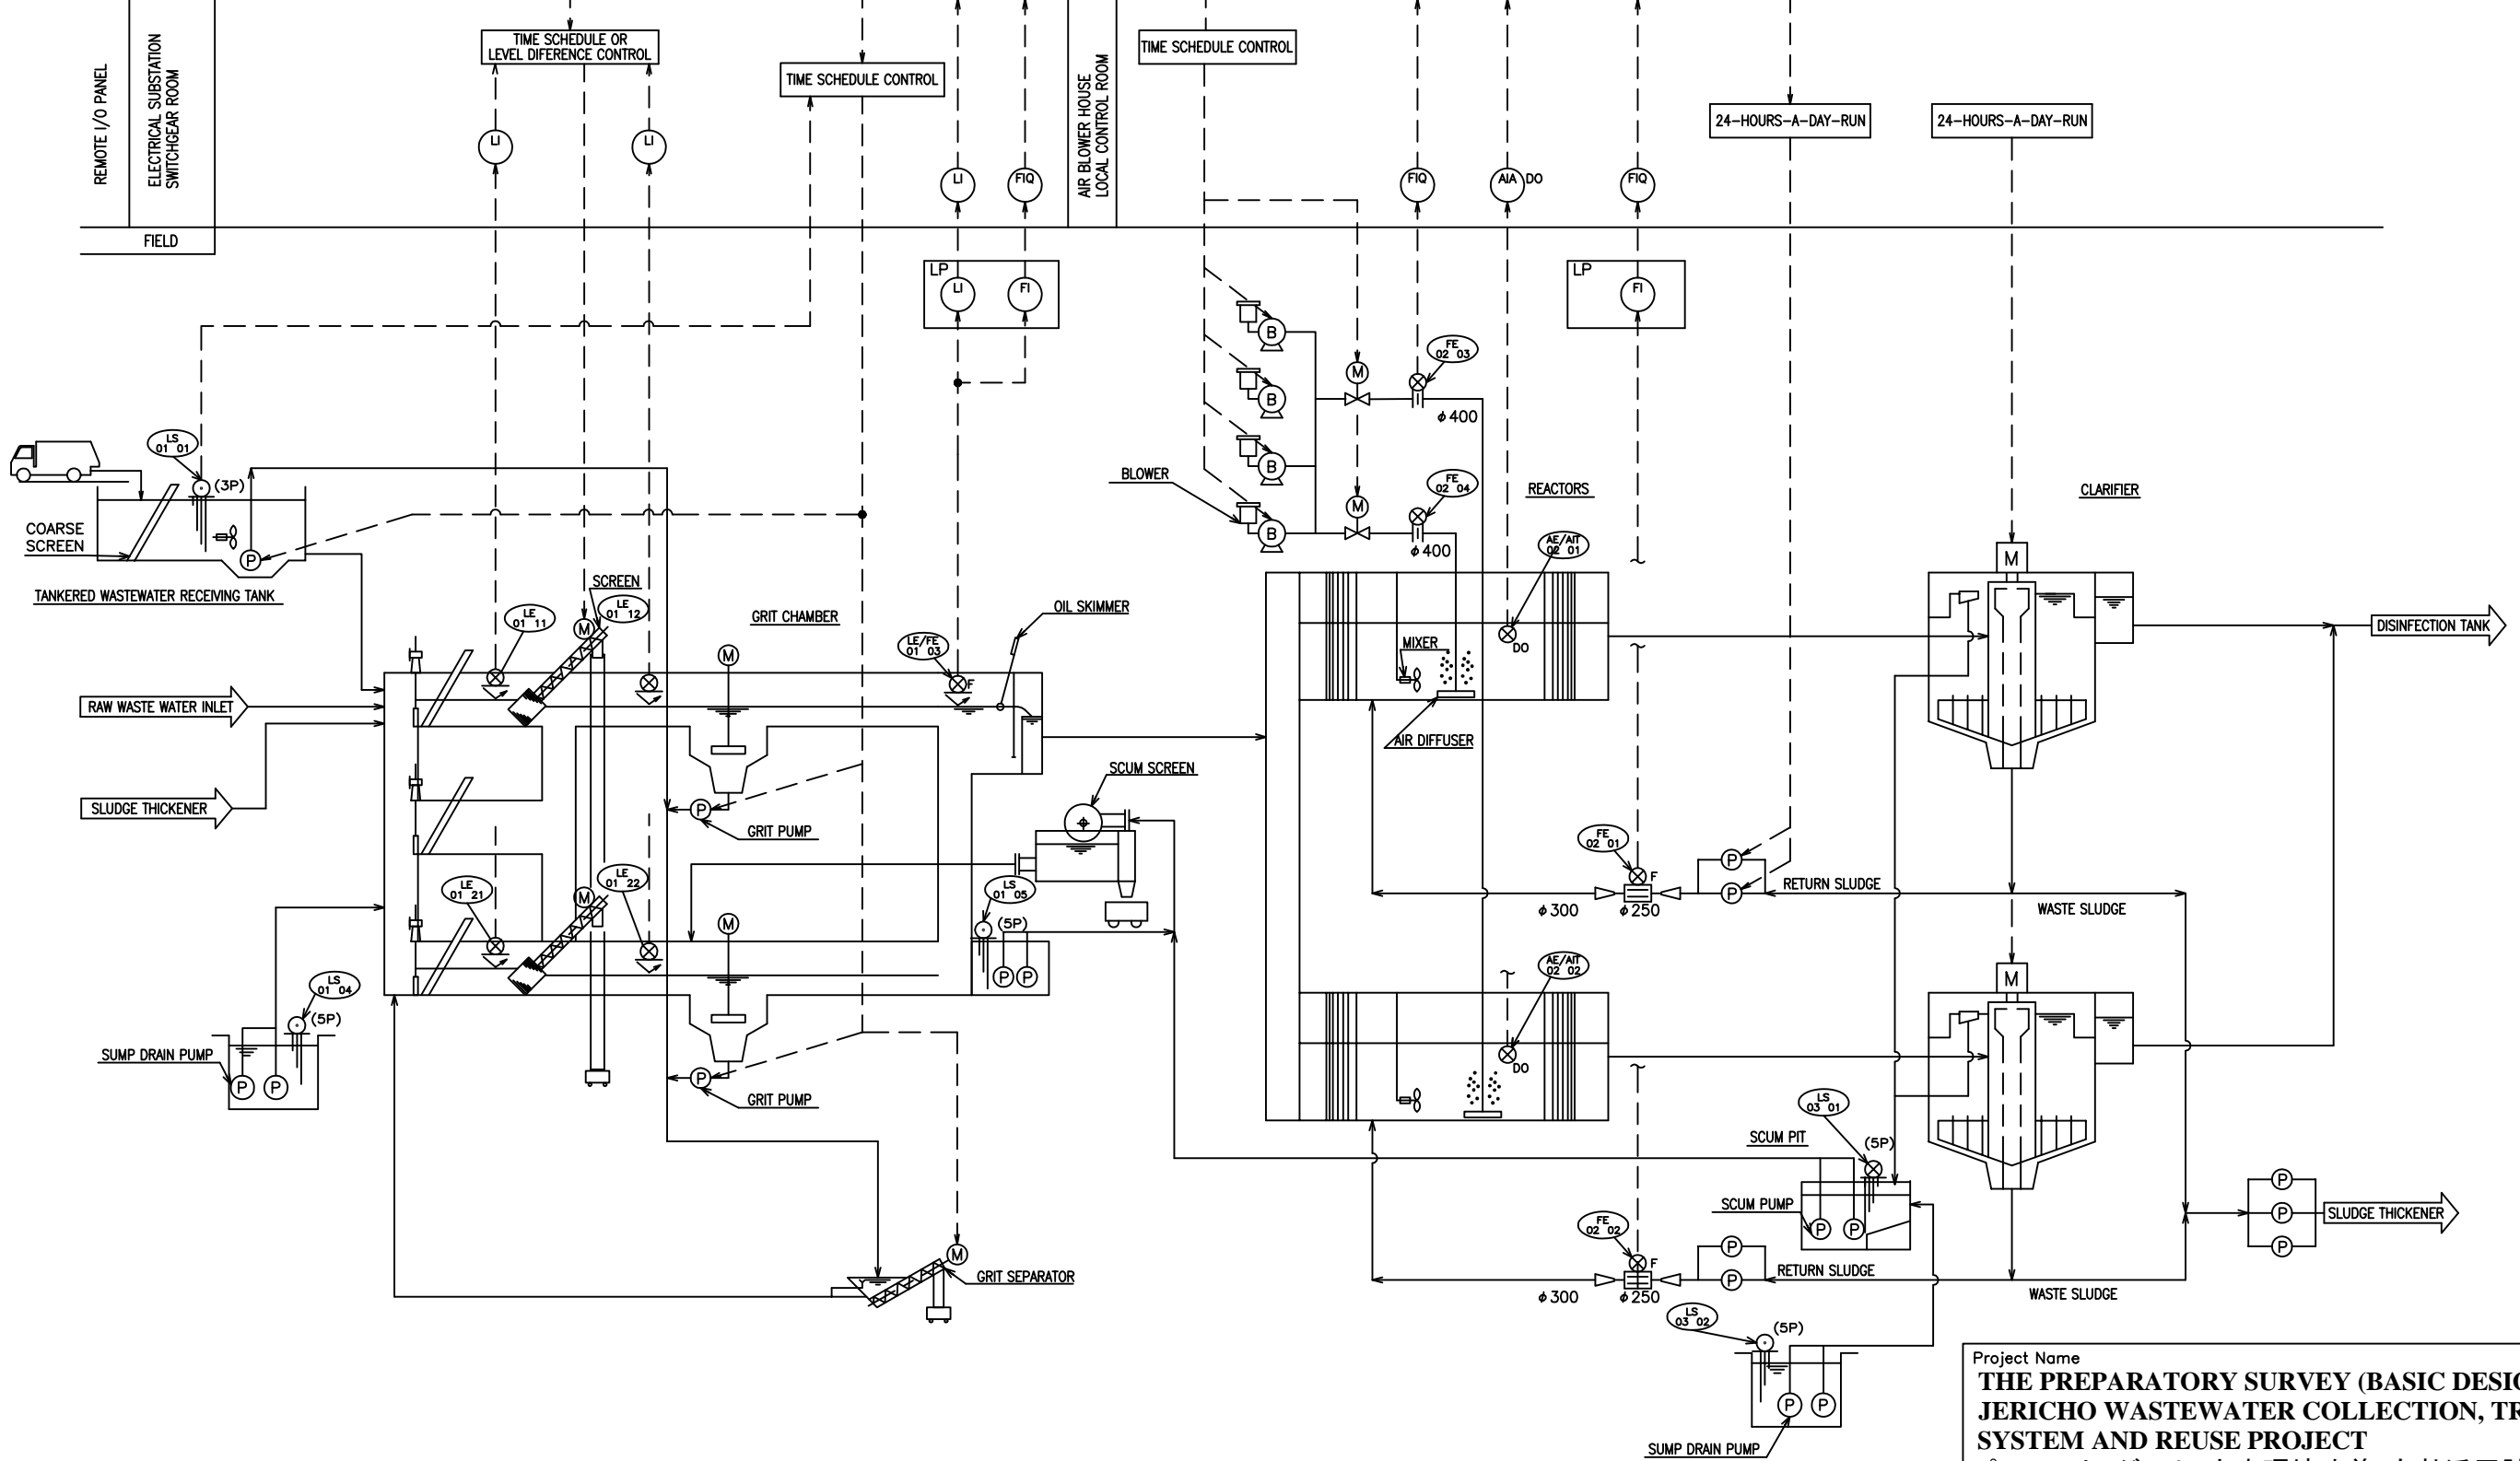


Project Name THE PREPARATORY SURVEY (BASIC DESIGN) ON THE JERICHO WASTEWATER COLLECTION, TREATMENT SYSTEM AND REUSE PROJECT パレスチナ ジェリコ市水環境改善・有効活用計画準備調査	
Drawing Title WWTP INSTRUMENTATION DIAGRAM(1/2) 下水処理場 計装ダイアグラム (1/2)	
Scale: None	Drawing No. 19/30

DESCRIPTION		HYPOCHLORITE TANK LEVEL	EFFLUENT FLOW
No. OF LOOPS		1	1
CENTRAL MONITORING ROOM	LOGGING	1	1
	MONITOR(OS)	1	1
	SET VALUE ON OS	SET PUMP NUMBER TO EFFLUENT FLOW	PRESET CYCLE/DURATION TIME SCHEDULE

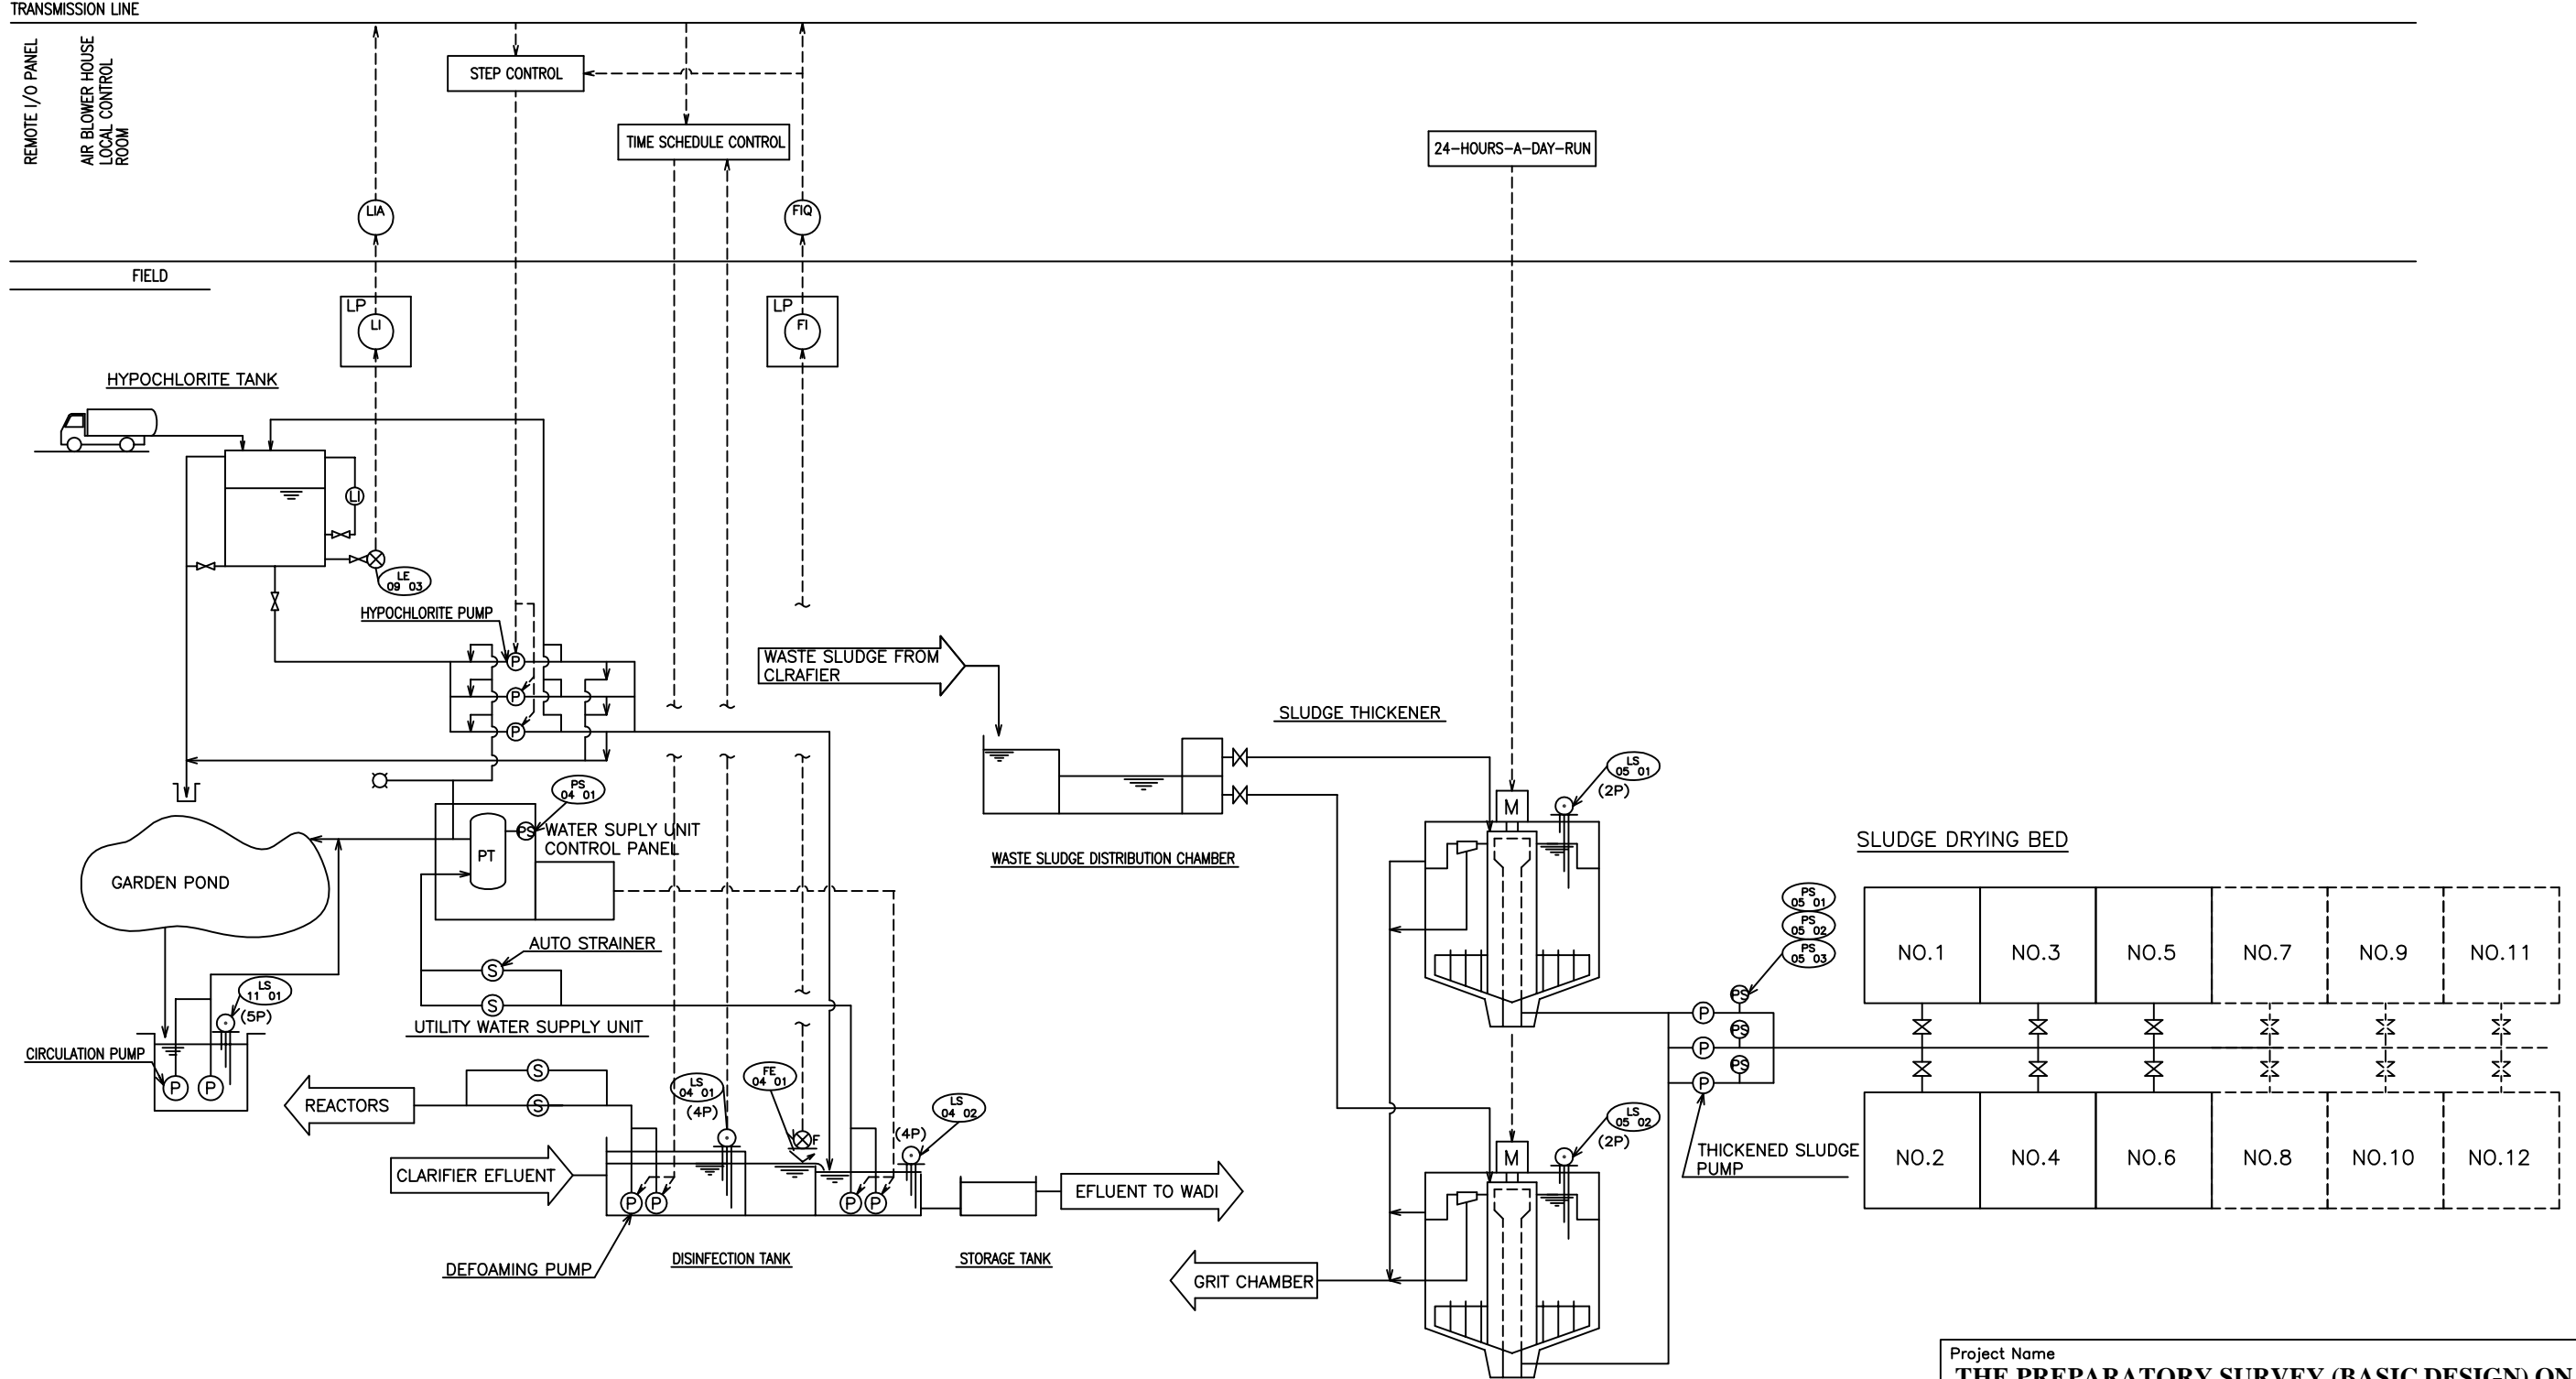

Project Name	
THE PREPARATORY SURVEY (BASIC DESIGN) ON THE JERICHO WASTEWATER COLLECTION, TREATMENT SYSTEM AND REUSE PROJECT	
パレスチナ ジェリコ市水環境改善・有効活用計画準備調査	
Drawing Title	
WWTP INSTRUMENTATION DIAGRAM(2/2)	
下水処理場 計装ダイアグラム (2/2)	
Scale:	None
Drawing No.	20/30

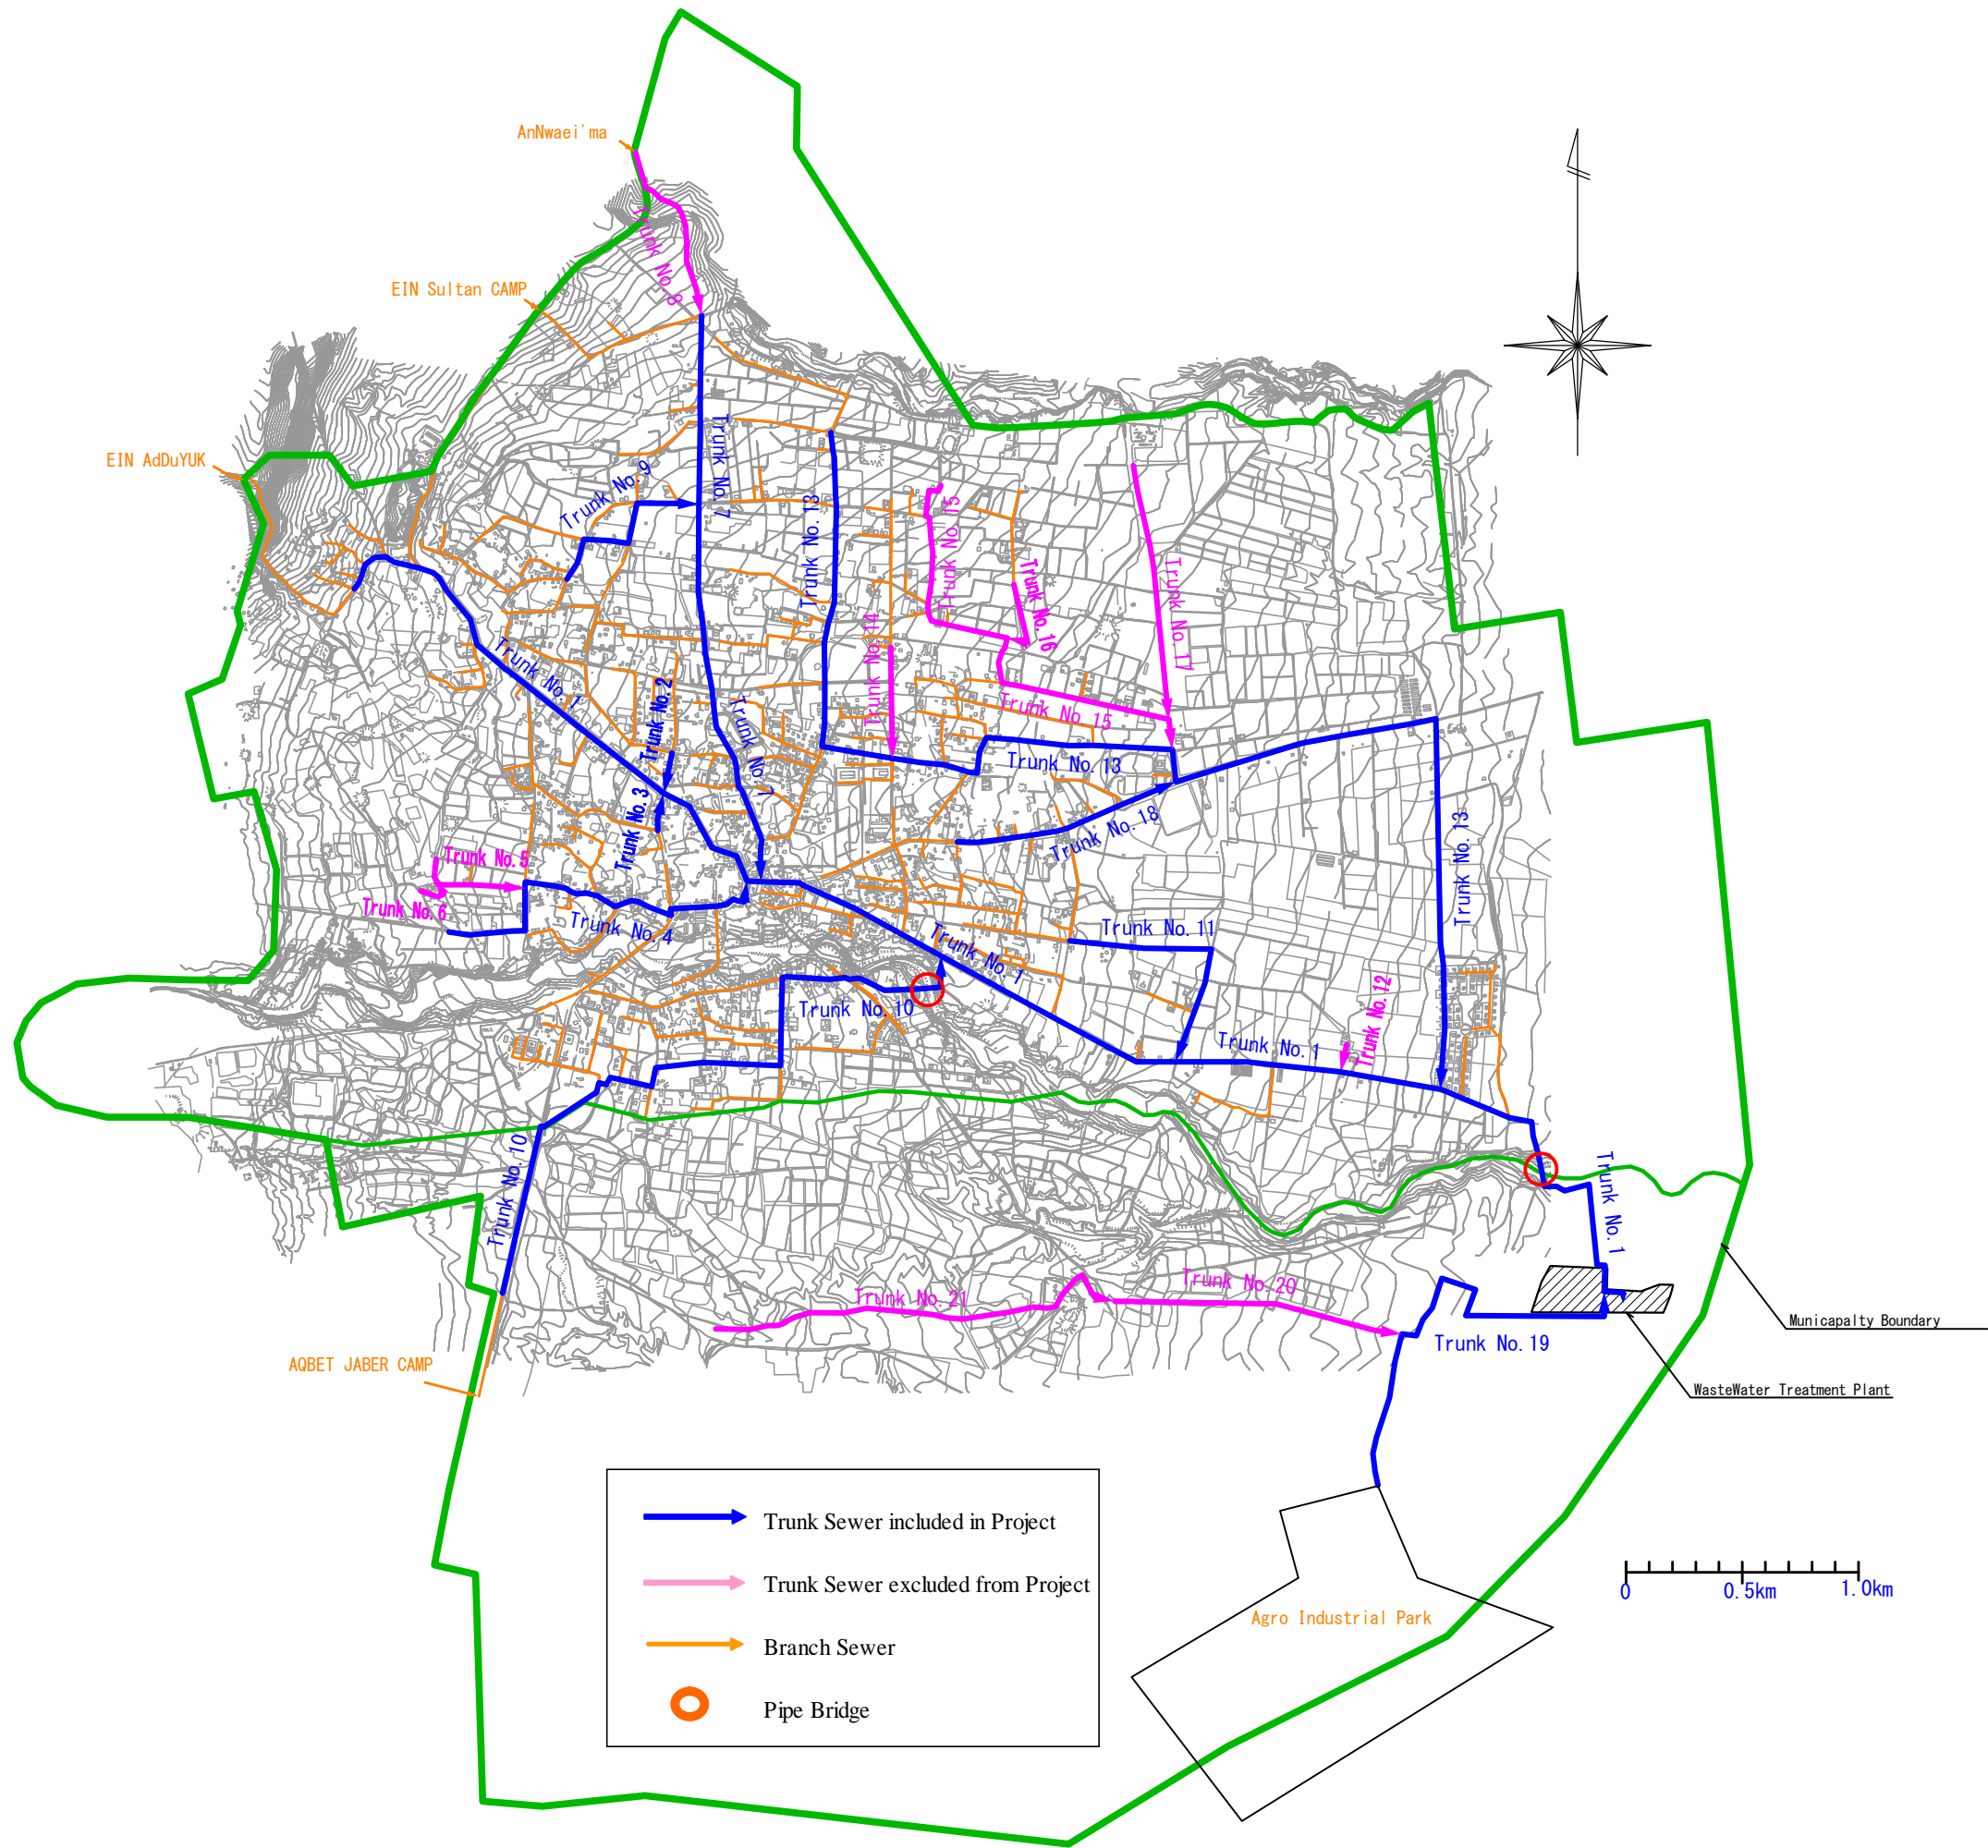

- Trunk Sewer included in Project
- Trunk Sewer excluded from Project
- Branch Sewer
- Pipe Bridge

Project Name THE PREPARATORY SURVEY (BASIC DESIGN) ON THE JERICHO WASTEWATER COLLECTION, TREATMENT SYSTEM AND REUSE PROJECT パレスチナ ジェリコ市水環境改善・有効活用計画準備調査	
Drawing Title GENERAL PLAN FOR SEWER PIPES 下水管渠 全体平面図	Scale: 1:15000 Drawing No. 21/30



EIN AdDuYUK CAMP
EIN Sultan CAMP


AnNwaci' ma CAMP


Legend	
Symbol	Explanation
	Municipality Boundary
	District Boundary
	Trunk Sewer
	Branch Sewer
	Sewer No. Diameter (mm) Slope (%) Length (m)
	Block Area (ha)
	Manhole Pump
	Manhole
	WWTP

SEWER LAYING PLAN
with COLLECTION AREA (NW, 1/4)
下水管渠 区画割平面図(北西、1)

1/6000

Project Name	
THE PREPARATORY SURVEY (BASIC DESIGN) ON THE JERICHO WASTEWATER COLLECTION, TREATMENT SYSTEM AND REUSE PROJECT	
パレスチナ ジェリコ市水環境改善・有効活用計画準備調査	
Drawing Title	
SEWER LAYING PLAN WITH COLLECTION AREA (NW, 1/4)	
下水管渠 区画割平面図 (北西、1)	
Scale:	1:6000
Drawing No.:	22/30

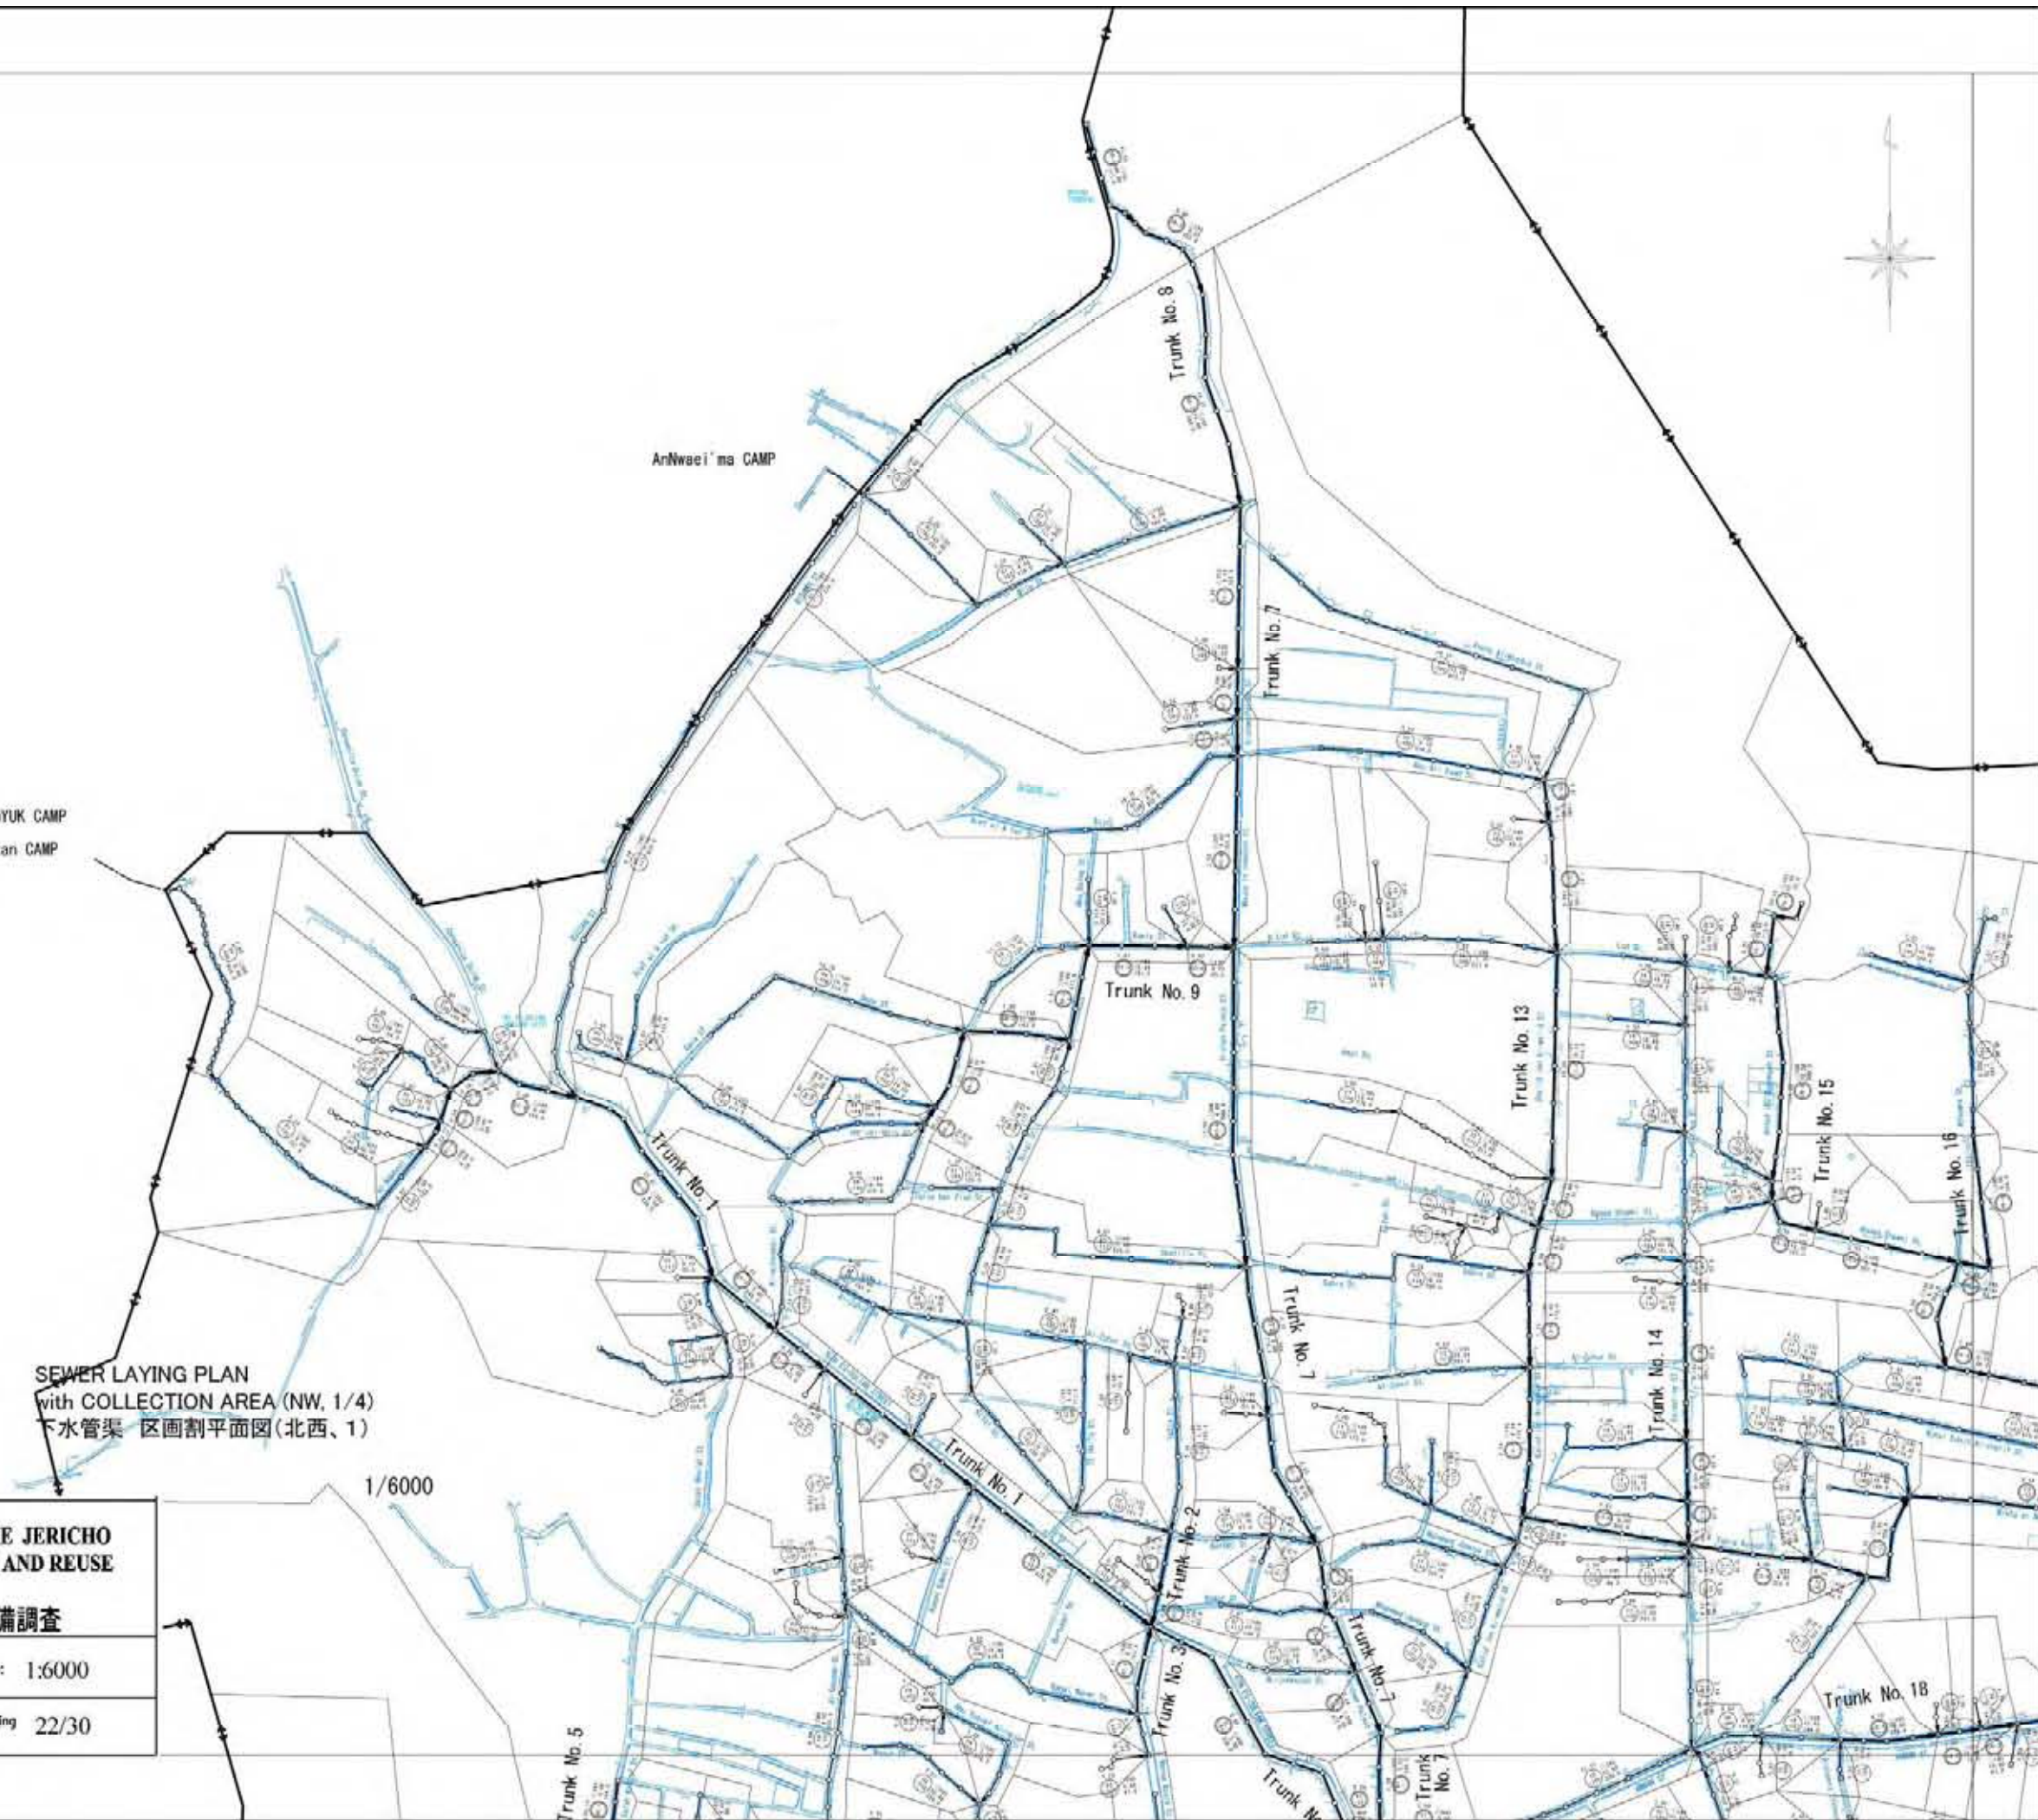


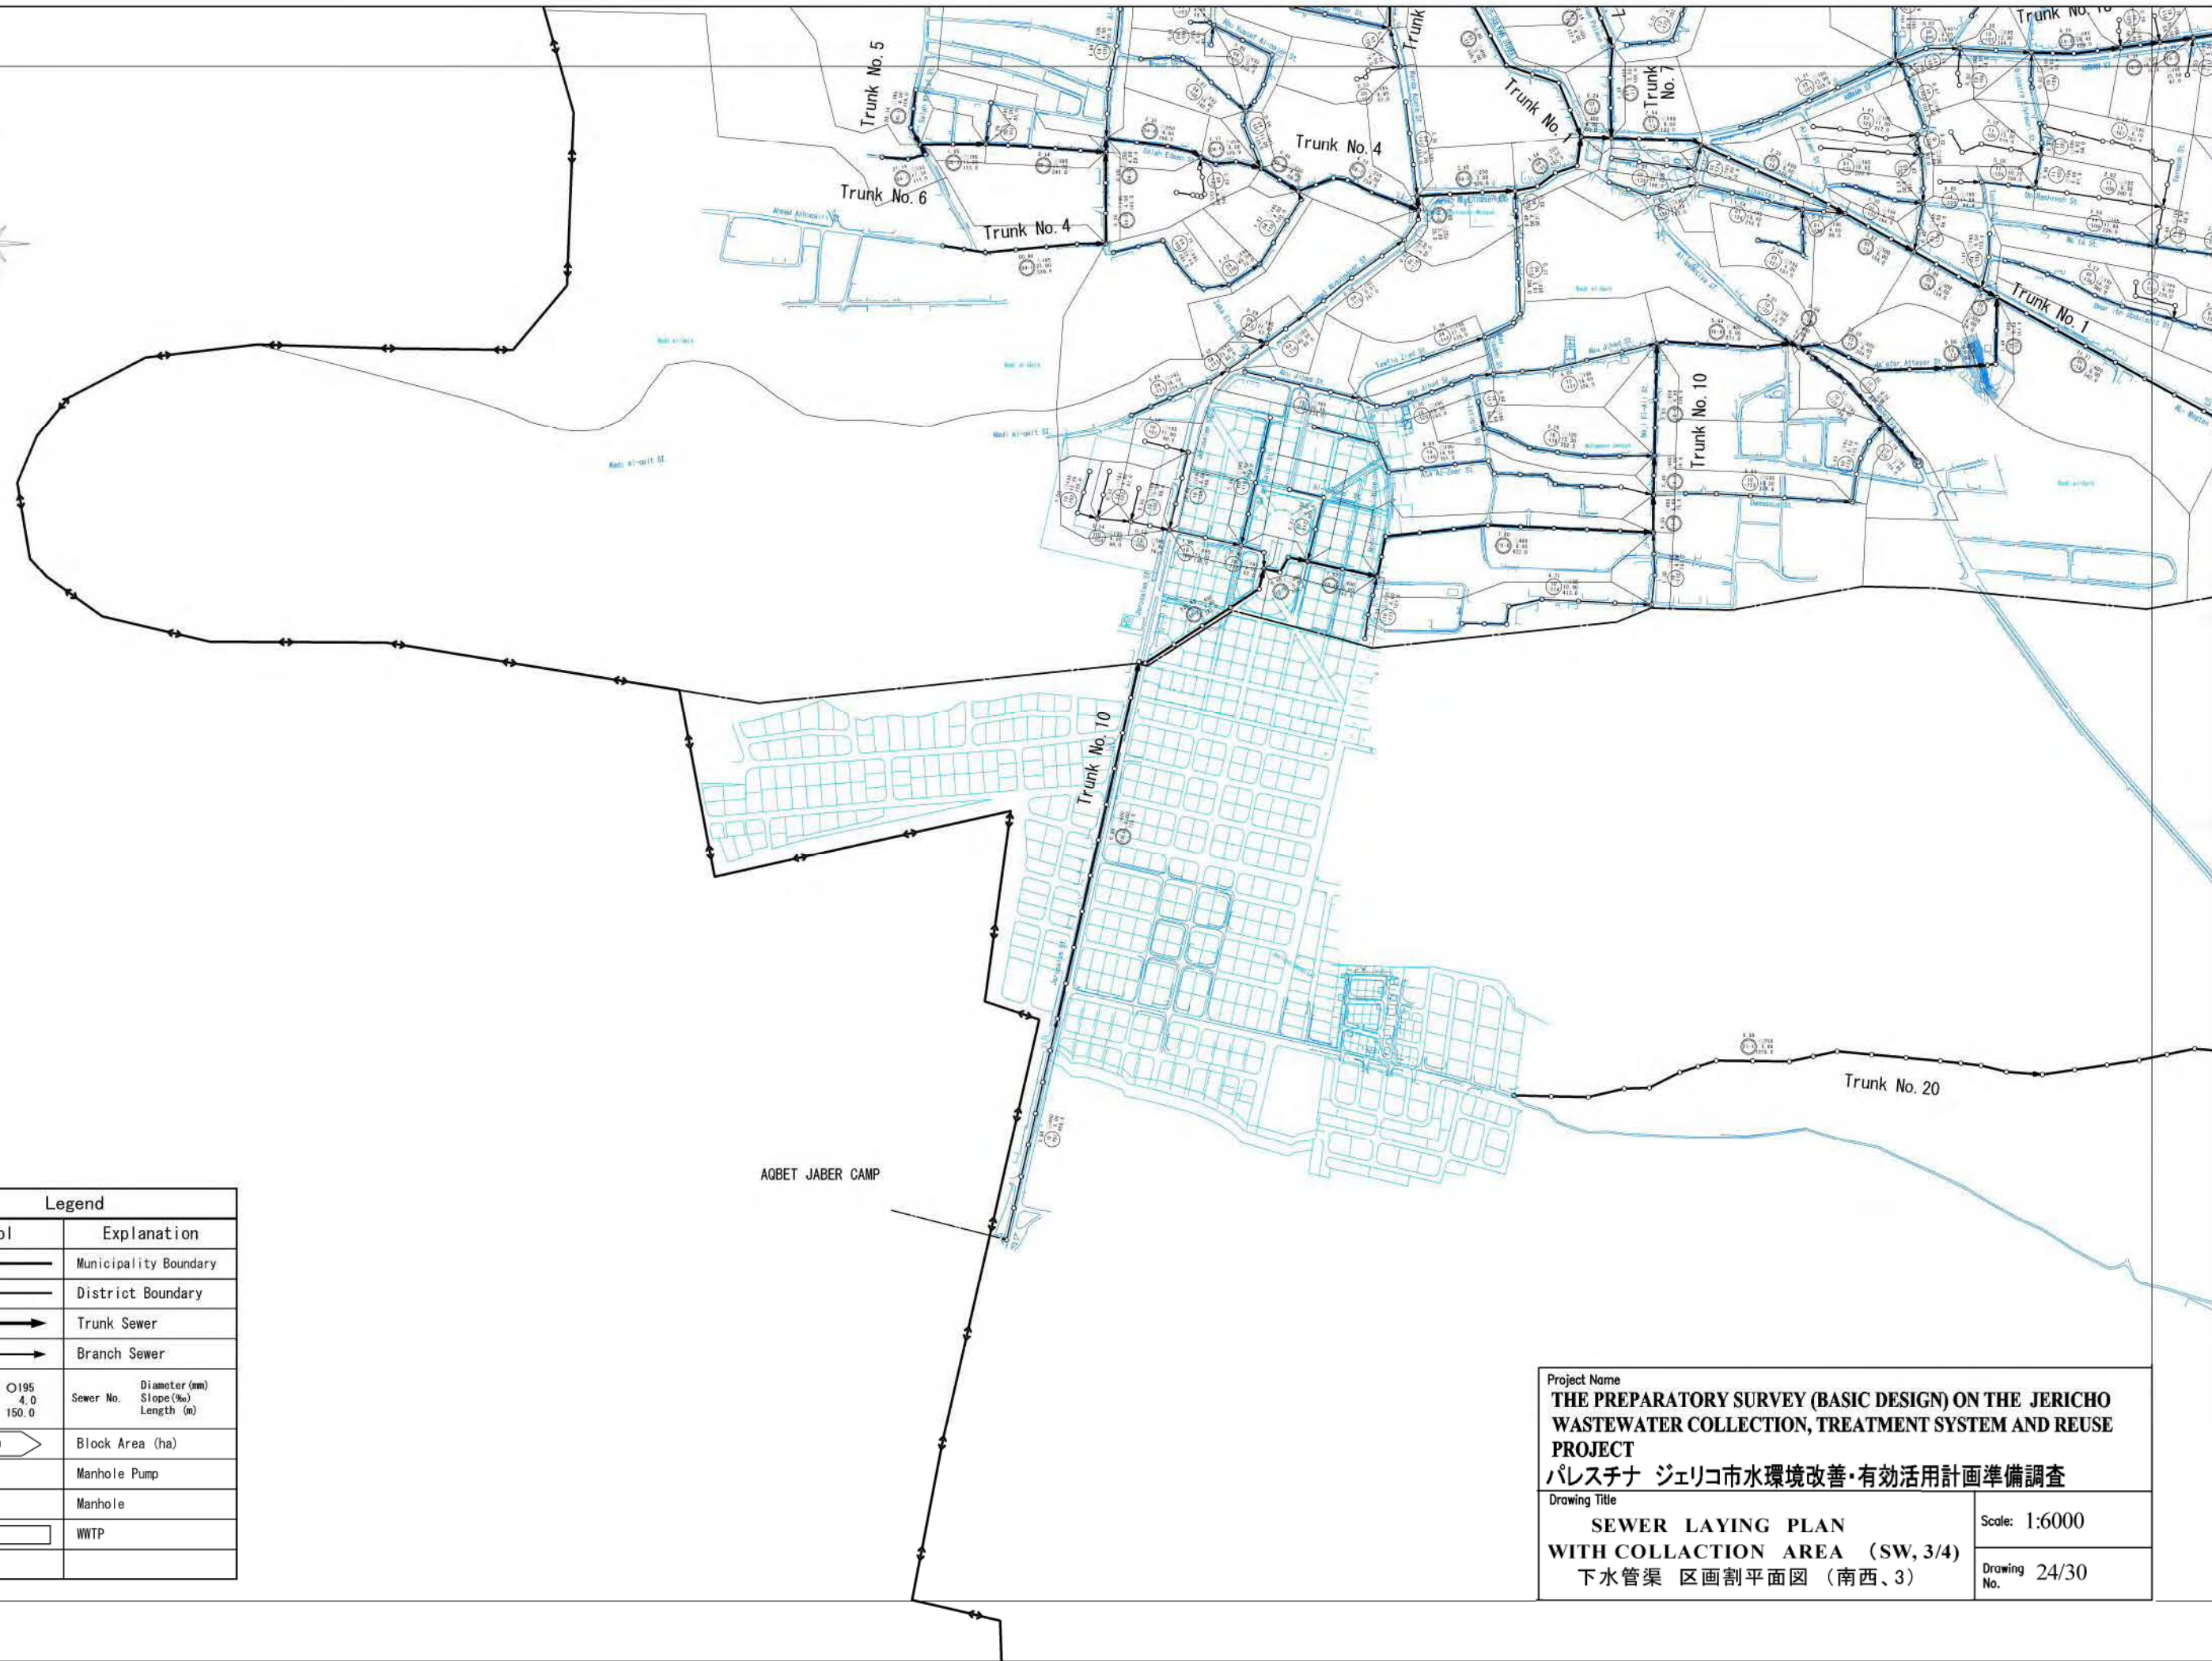

Legend	
Symbol	Explanation
	Municipality Boundary
	District Boundary
	Trunk Sewer
	Branch Sewer
	Sewer No. Diameter (mm) Slope (%) Length (m)
	Block Area (ha)
	Manhole Pump
	Manhole
	WWTP

AQBET JABER CAMP

Project Name	
THE PREPARATORY SURVEY (BASIC DESIGN) ON THE JERICHO WASTEWATER COLLECTION, TREATMENT SYSTEM AND REUSE PROJECT	
パレスチナ ジェリコ市水環境改善・有効活用計画準備調査	
Drawing Title	
SEWER LAYING PLAN WITH COLLECTON AREA (SW, 3/4)	
下水管渠 区画割平面図 (南西、3)	
Scale: 1:6000	Drawing No. 24/30

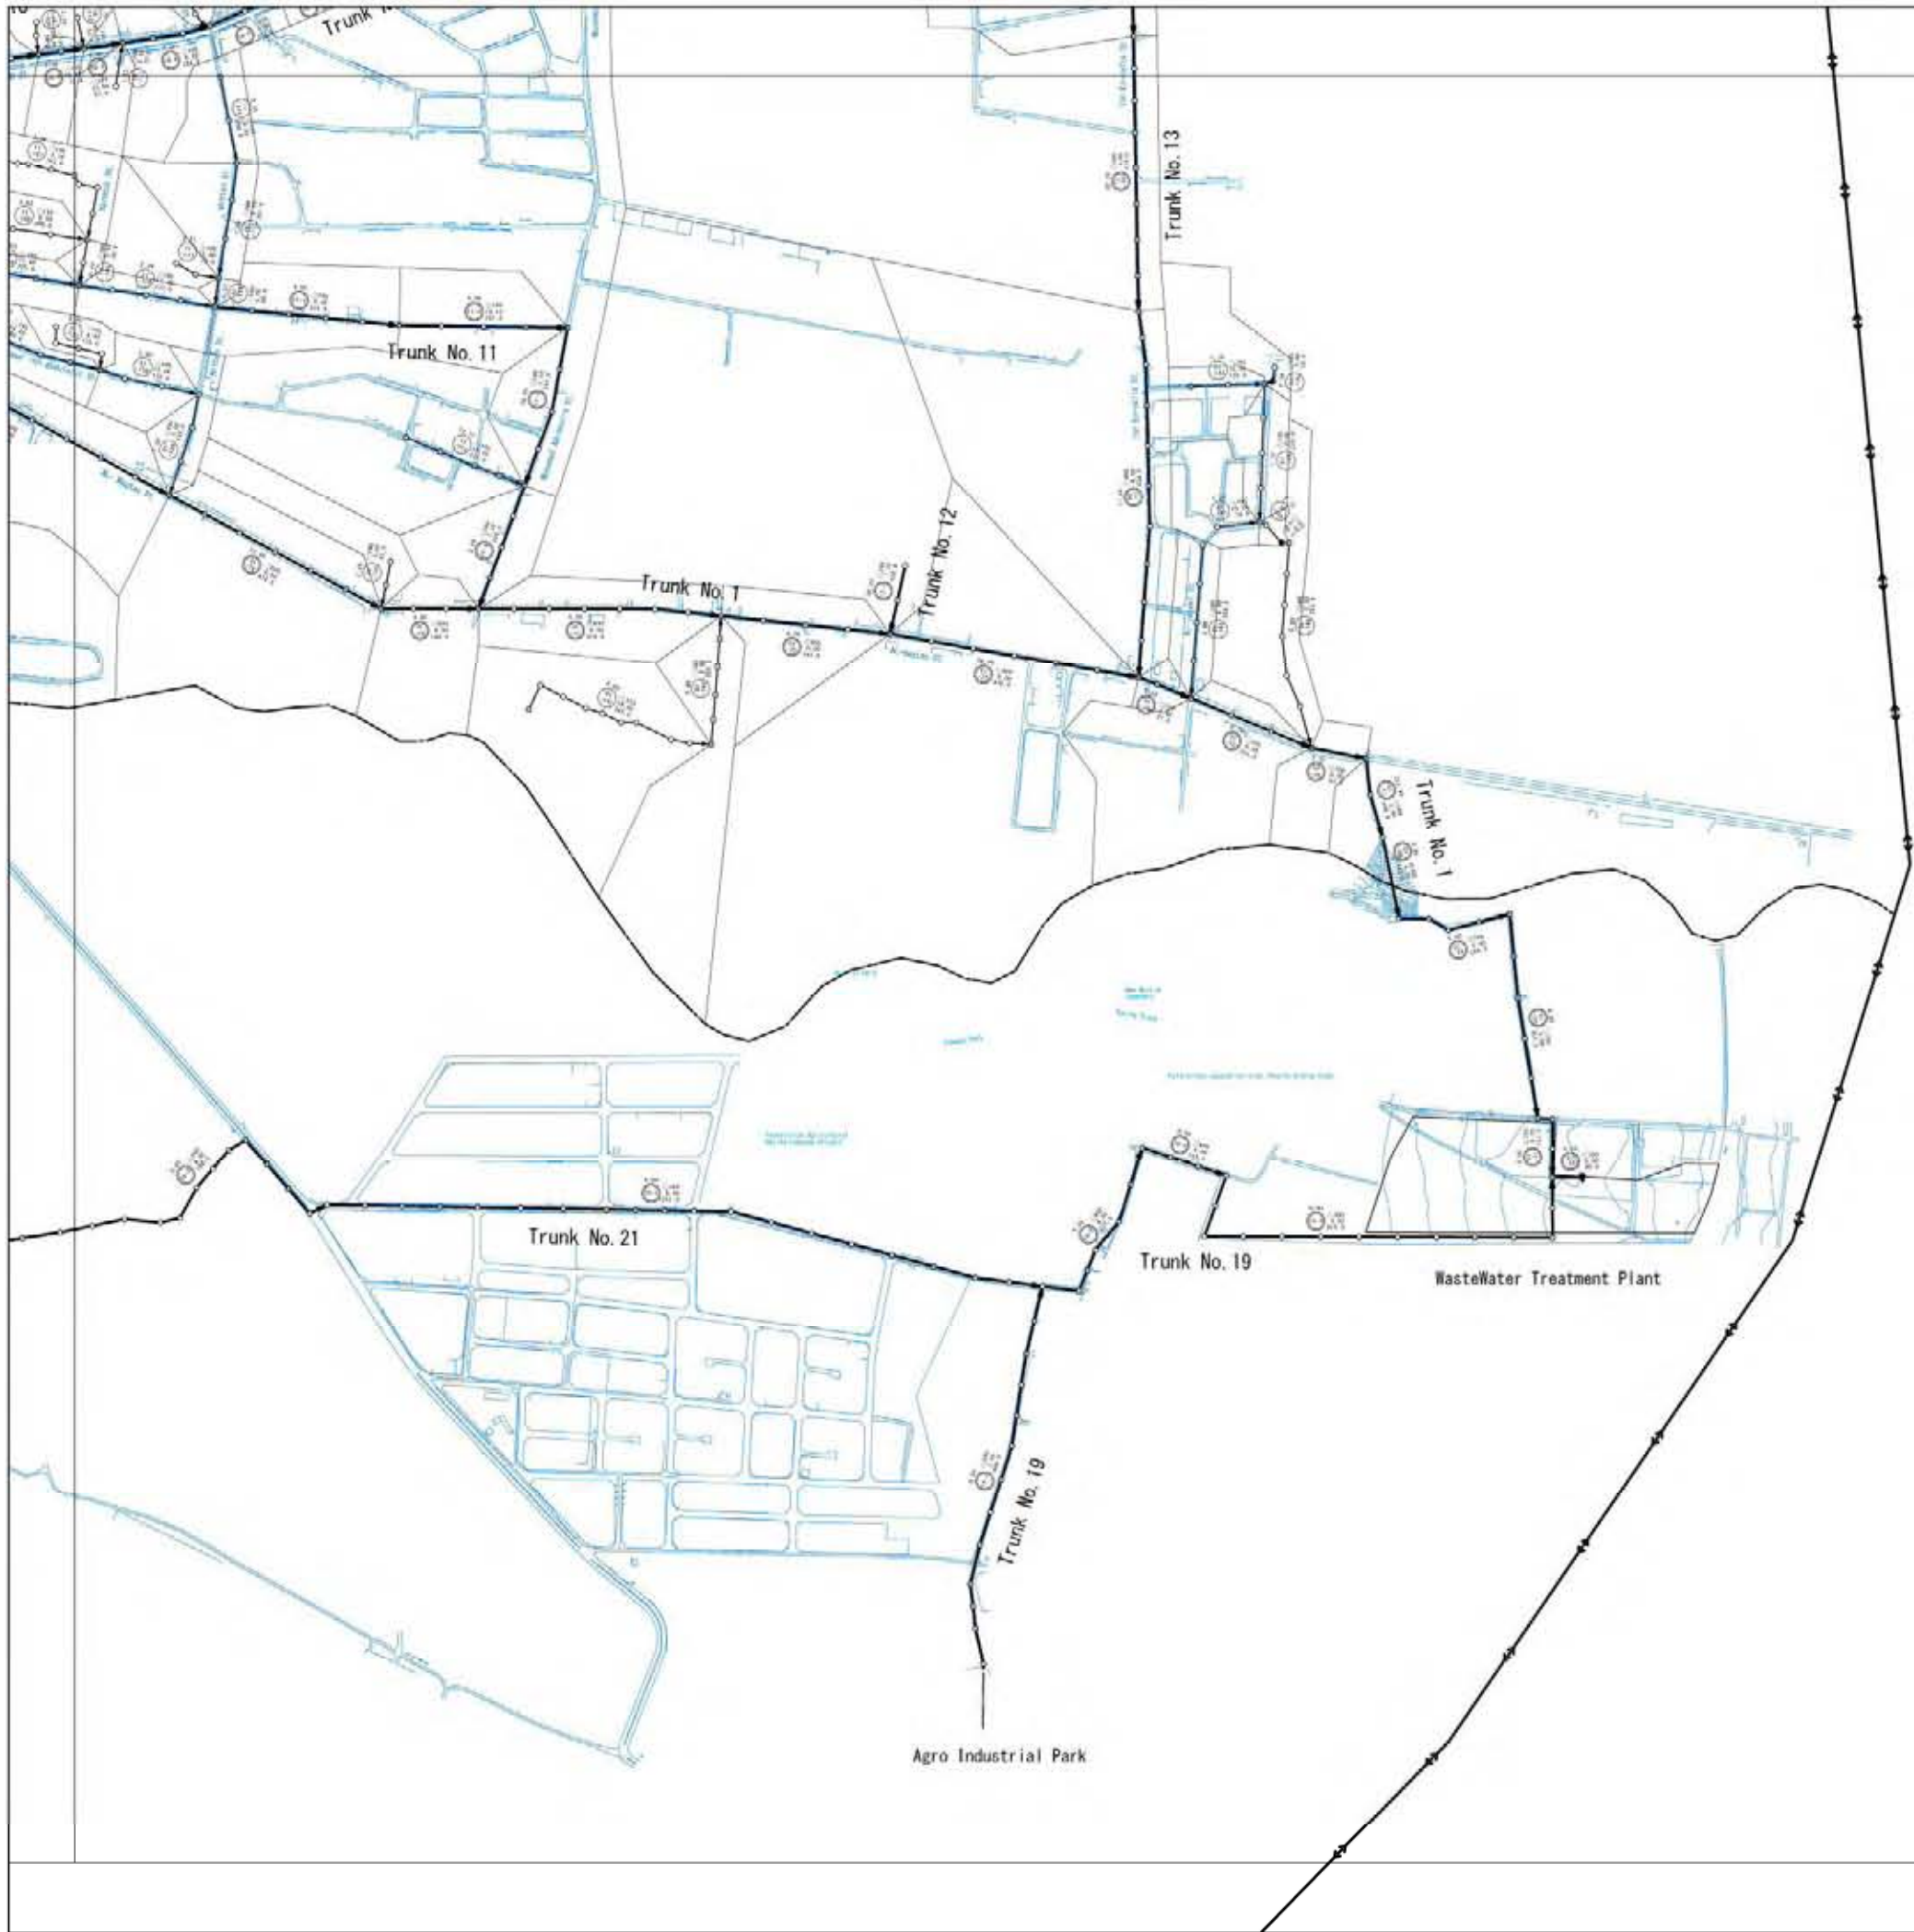


Legend	
Symbol	Explanation
	Municipality Boundary
	District Boundary
	Trunk Sewer
	Branch Sewer
	Sewer No. Diameter (mm) Slope (%) Length (m)
	Block Area (ha)
	Manhole Pump
	Manhole
	WTP

Project Name
THE PREPARATORY SURVEY (BASIC DESIGN) ON THE JERICHO WASTEWATER COLLECTION, TREATMENT SYSTEM AND REUSE PROJECT
 パレスチナ ジェリコ市水環境改善・有効活用計画準備調査


Drawing Title
SEWER LAYING PLAN WITH COLLECTION AREA (SE, 4/4)
 下水管渠 区画割平面図 (南東、4)

Scale: 1:6000
 Drawing No. 25/30

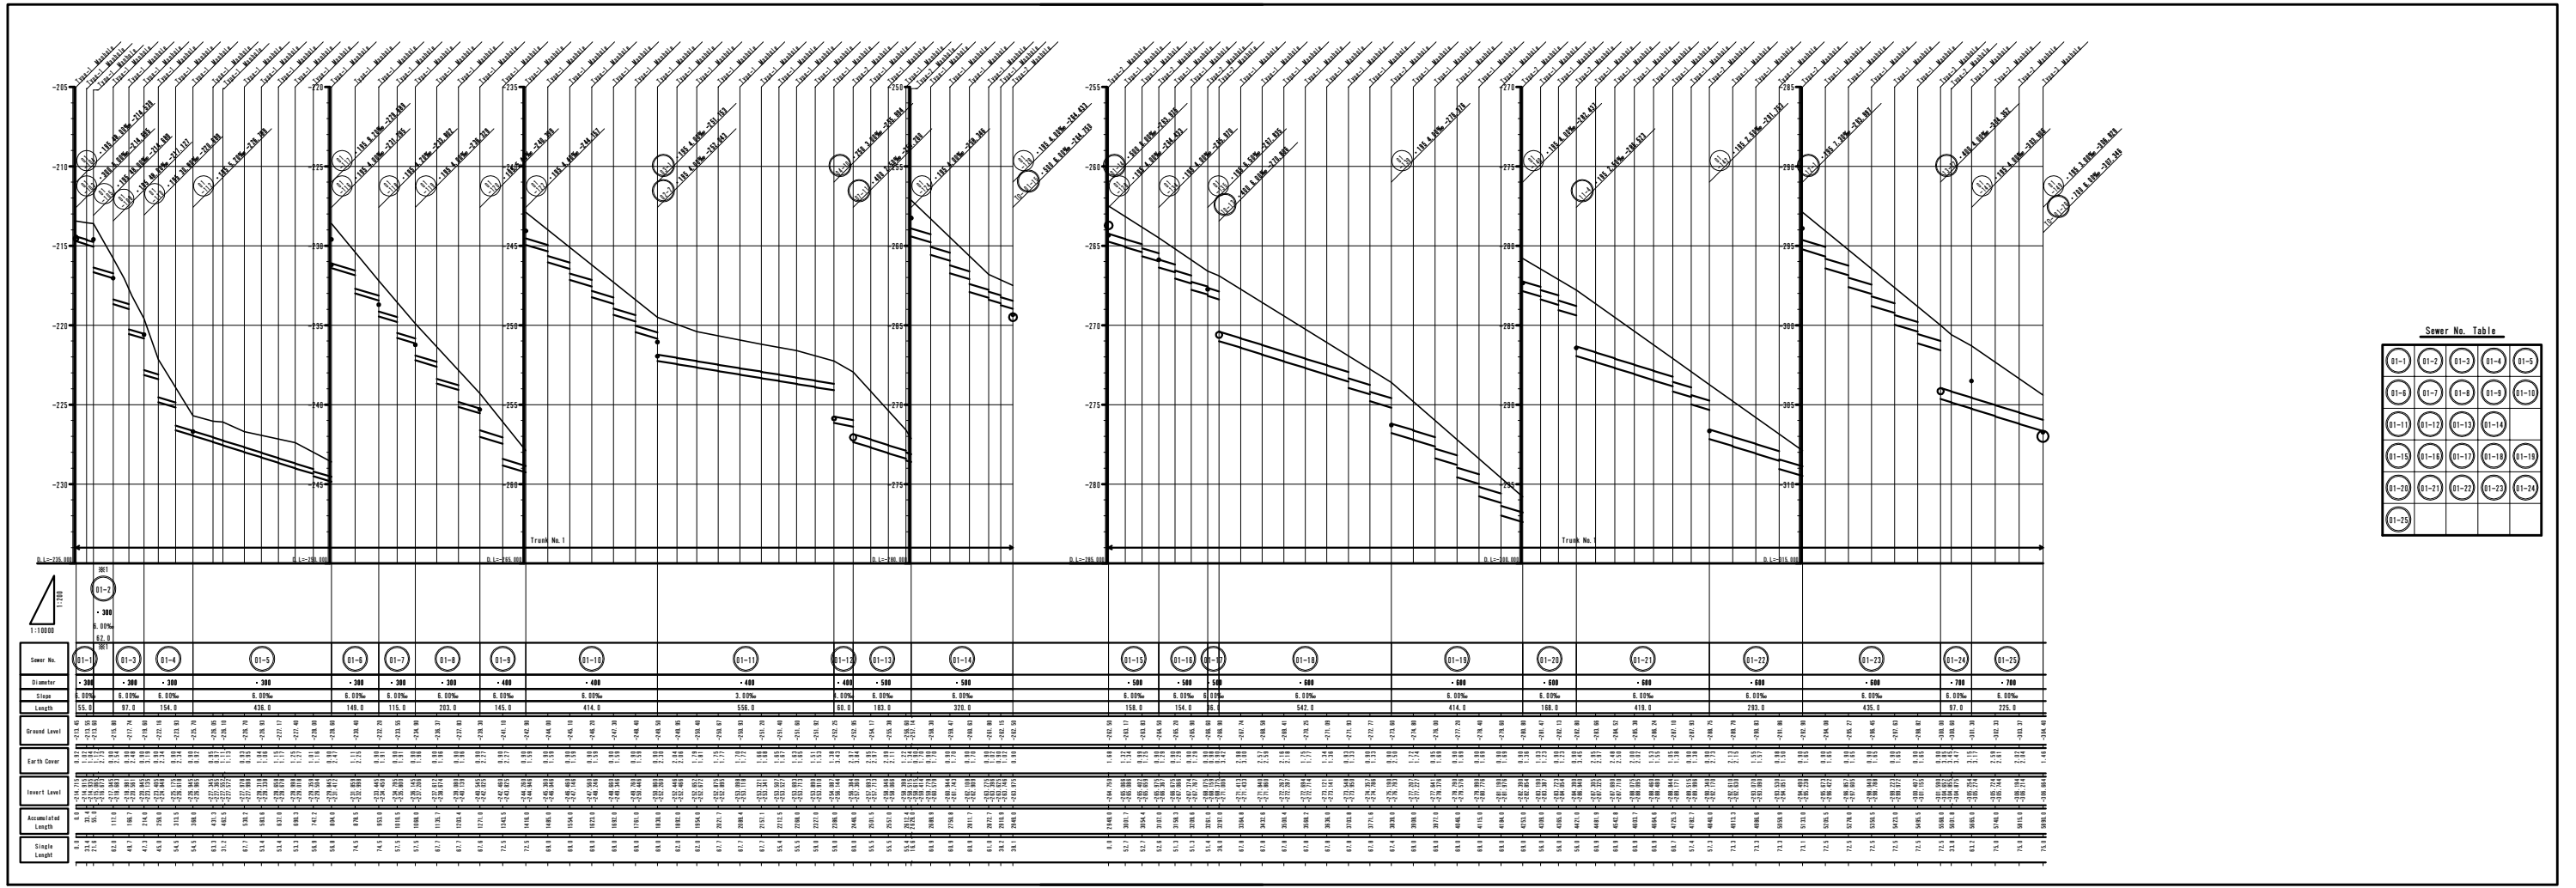

Sewer No. Table

01-1	01-2	01-3	01-4	01-5
01-6	01-7	01-8	01-9	01-10
01-11	01-12	01-13	01-14	01-15
01-16	01-17	01-18	01-19	01-20
01-21	01-22	01-23	01-24	01-25

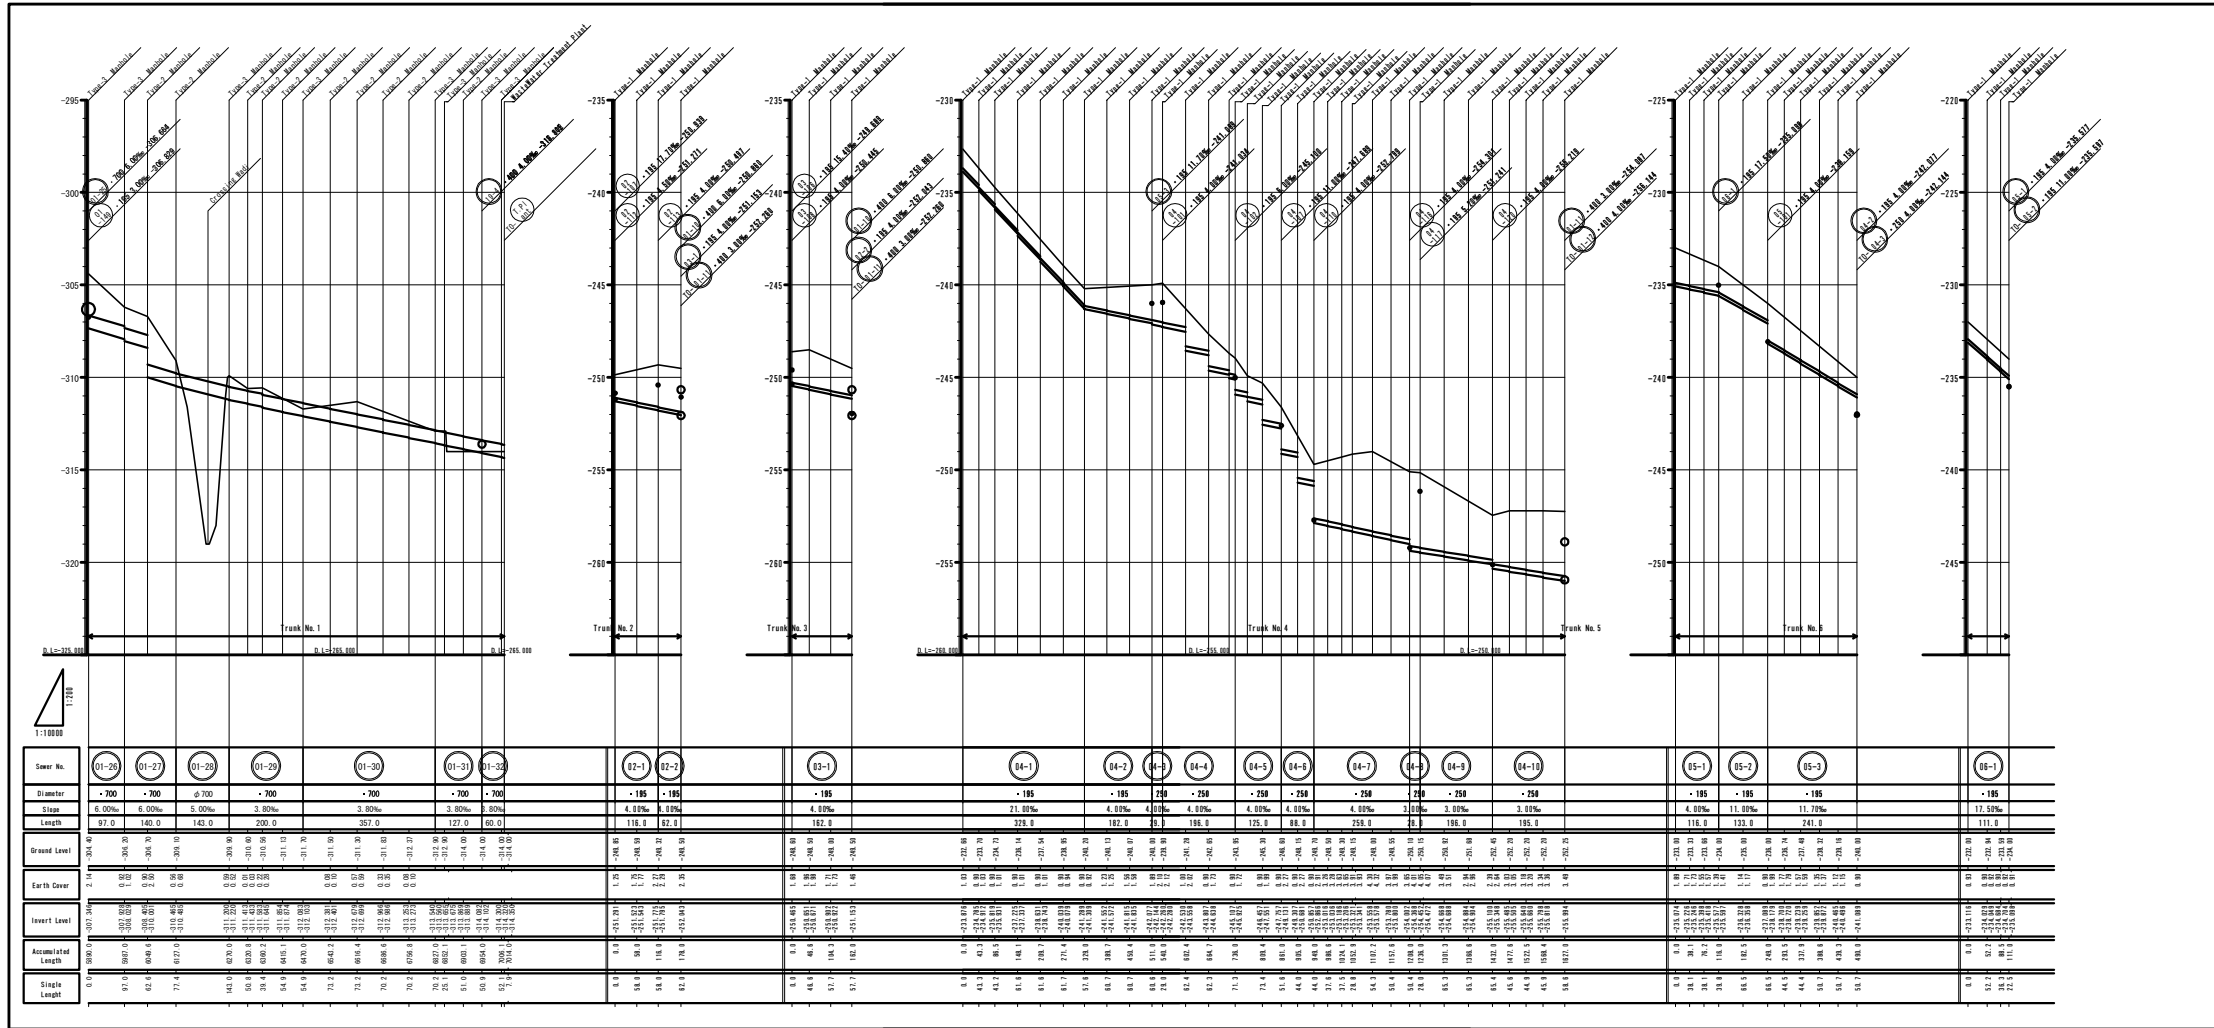

Sewer No. Table



01-26	01-27	01-28	01-29	01-30
01-31	01-32	02-1	02-2	03-1
04-1	04-2	04-3	04-4	04-5
04-6	04-7	04-8	04-9	04-10
05-1	05-2	05-3	06-1	

Project Name
THE PREPARATORY SURVEY (BASIC DESIGN) ON THE JERICHO WASTEWATER COLLECTION, TREATMENT SYSTEM AND REUSE PROJECT
 巴勒斯坦 ジェリコ市水環境改善・有効活用計画準備調査

Drawing Title
PROFILE FOR TRUNK SEWER (1/4)
 下水管渠 幹線縦断面図(1)

Scale: **V:1/10000**
H:1/200

Drawing No. **26/30**

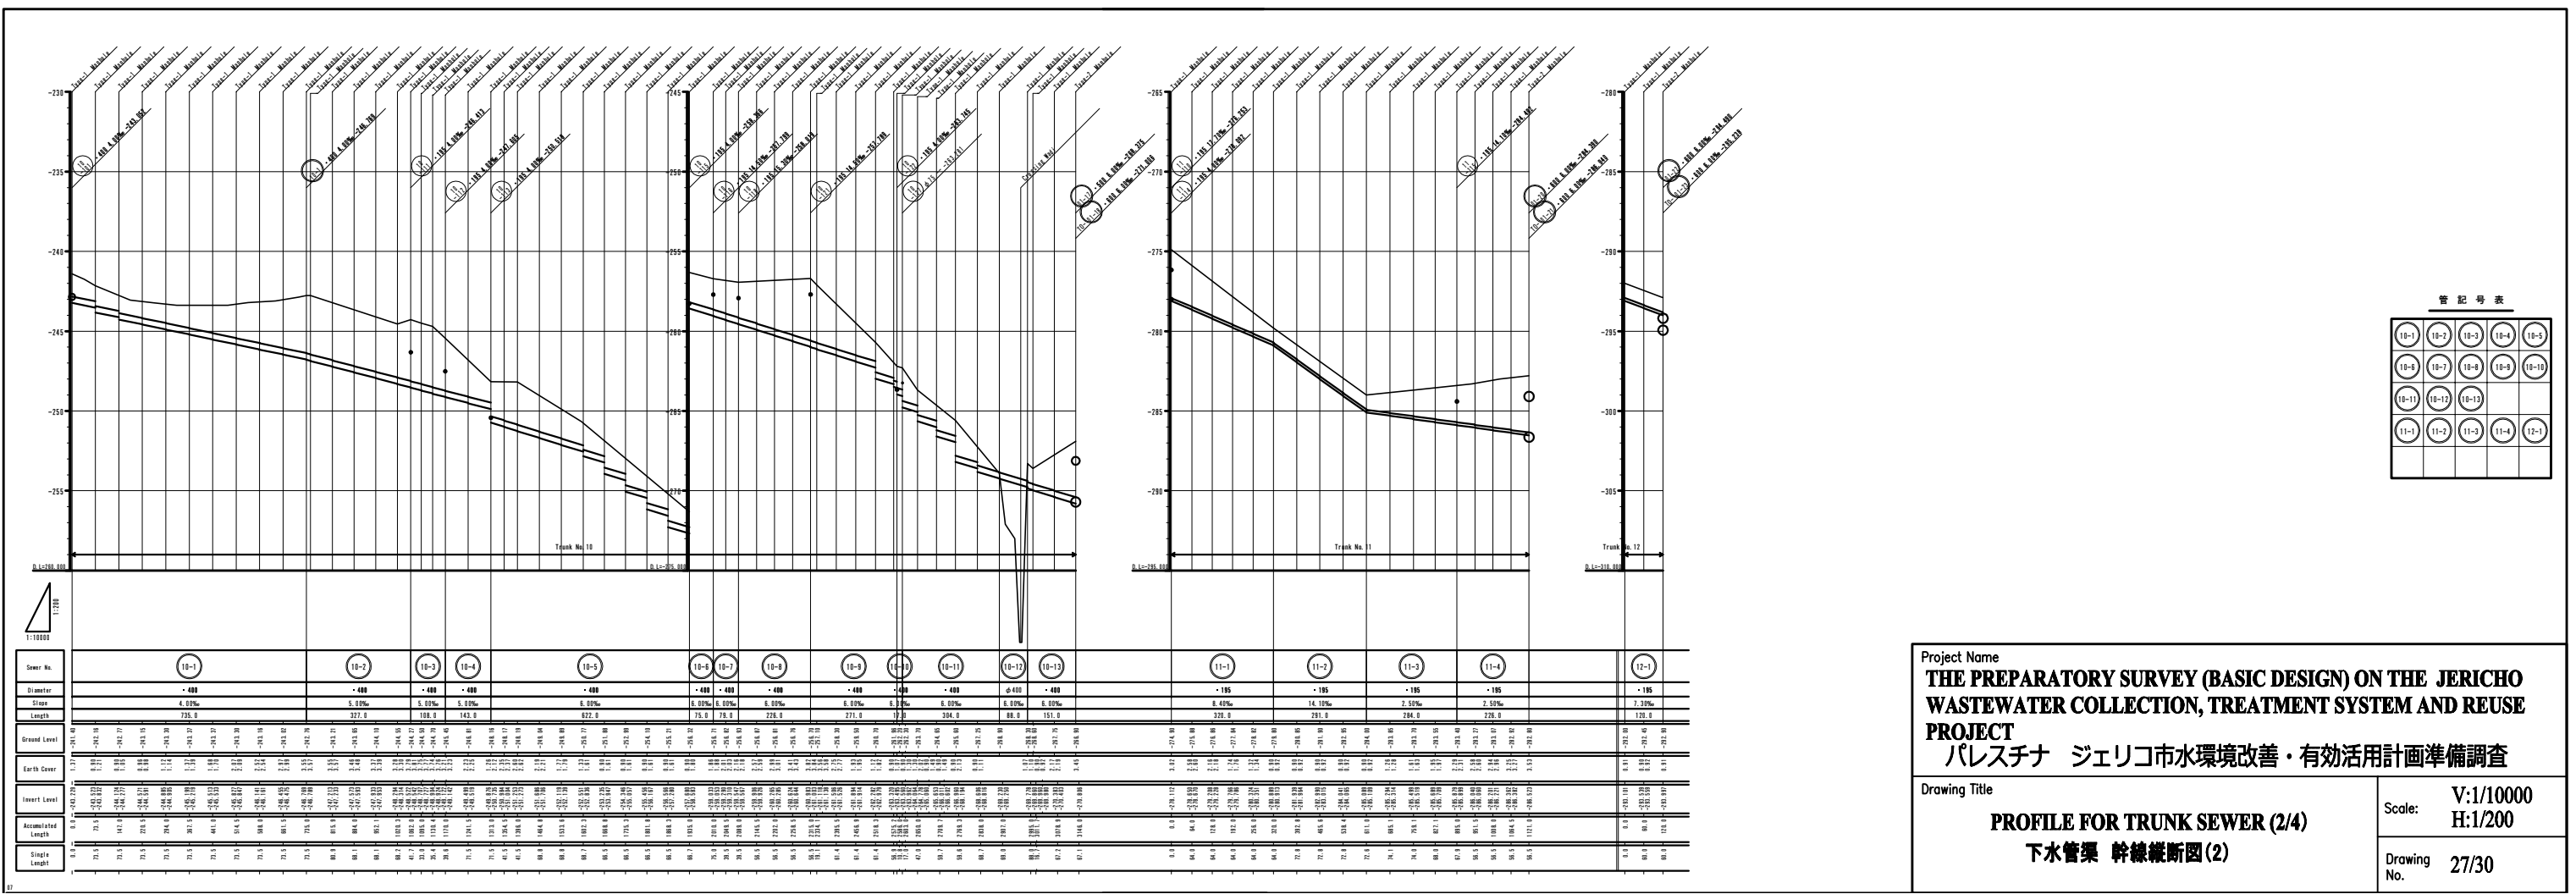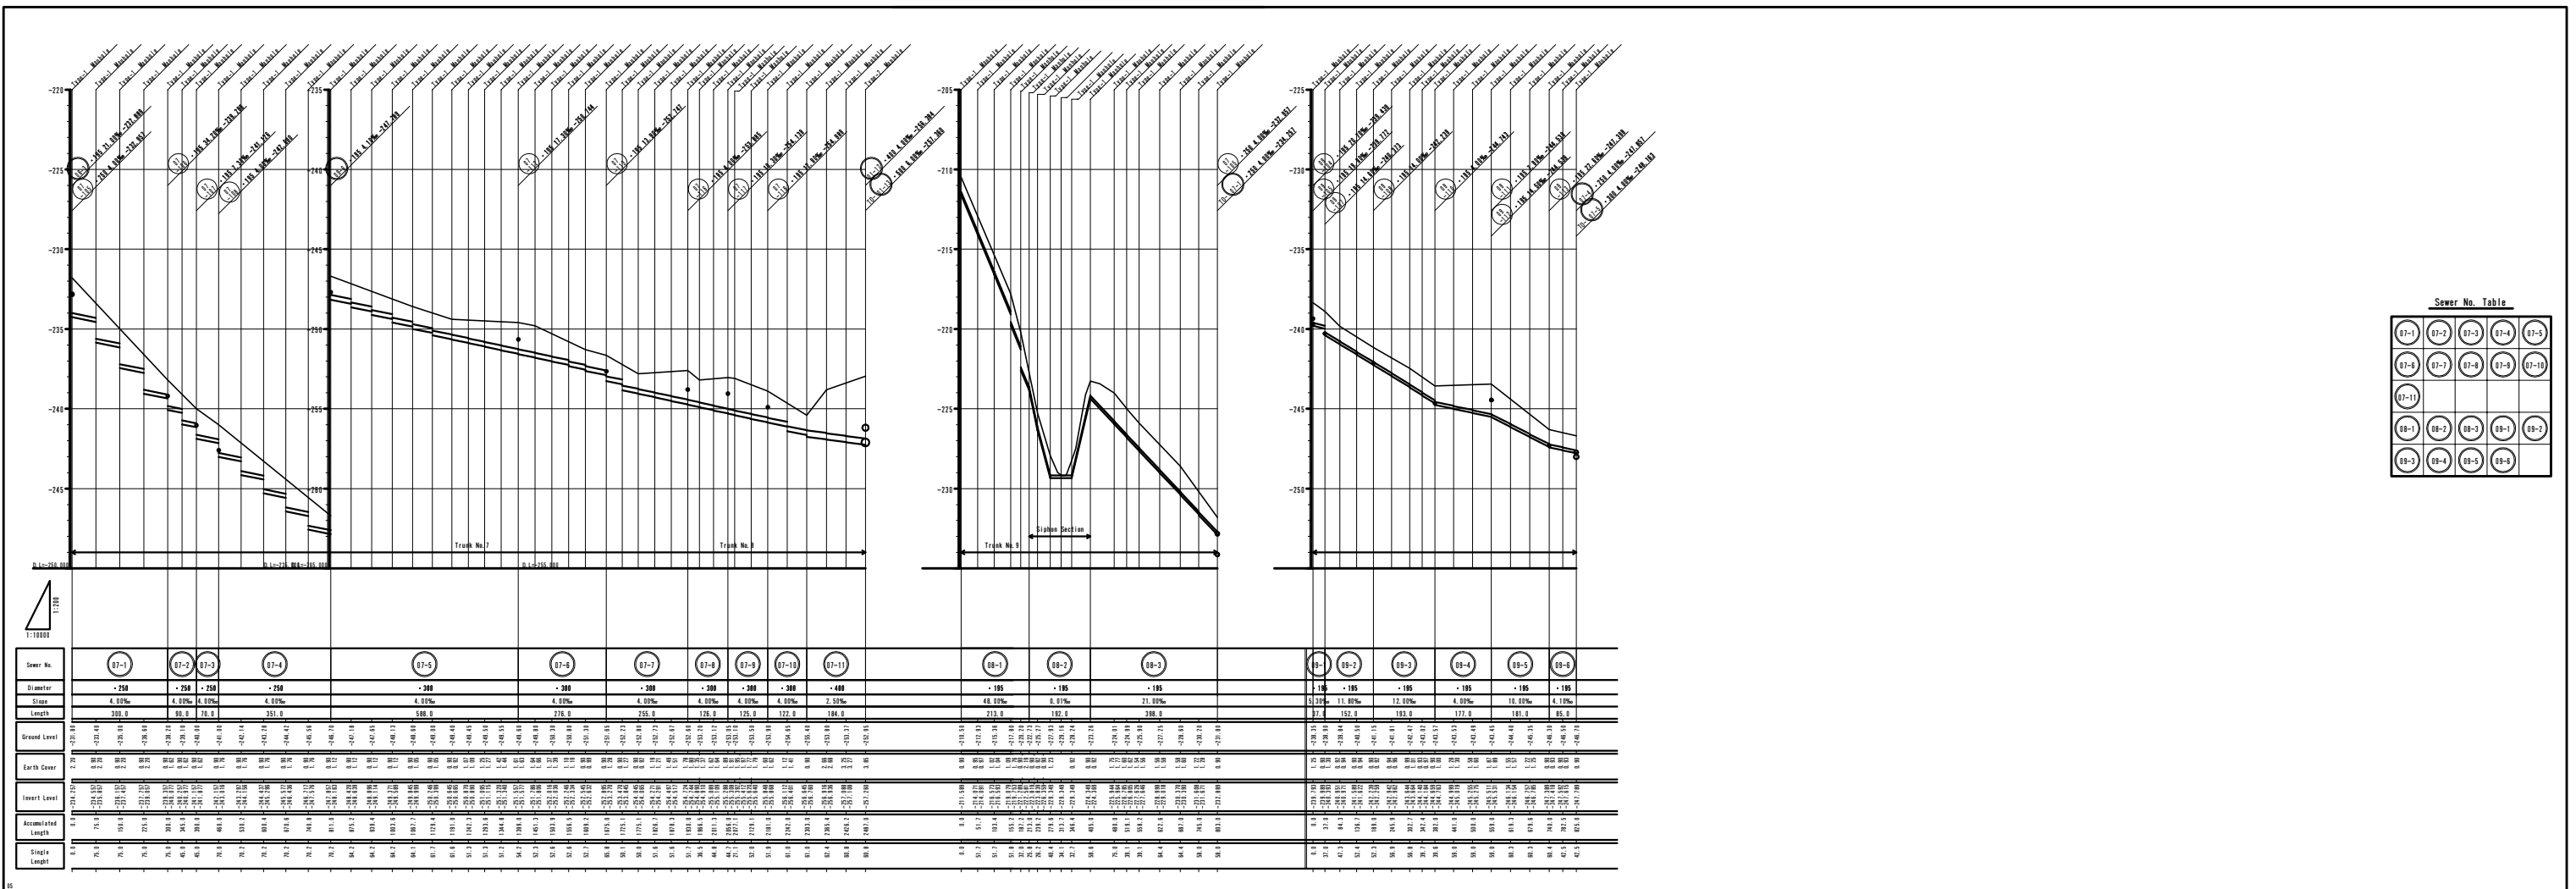


Project Name
THE PREPARATORY SURVEY (BASIC DESIGN) ON THE JERICHO WASTEWATER COLLECTION, TREATMENT SYSTEM AND REUSE PROJECT
 パレスチナ ジェリコ市水環境改善・有効活用計画準備調査


Drawing Title
PROFILE FOR TRUNK SEWER (2/4)
 下水管渠 幹線縦断面(2)

Scale:
 V:1/10000
 H:1/200

Drawing No.
 27/30

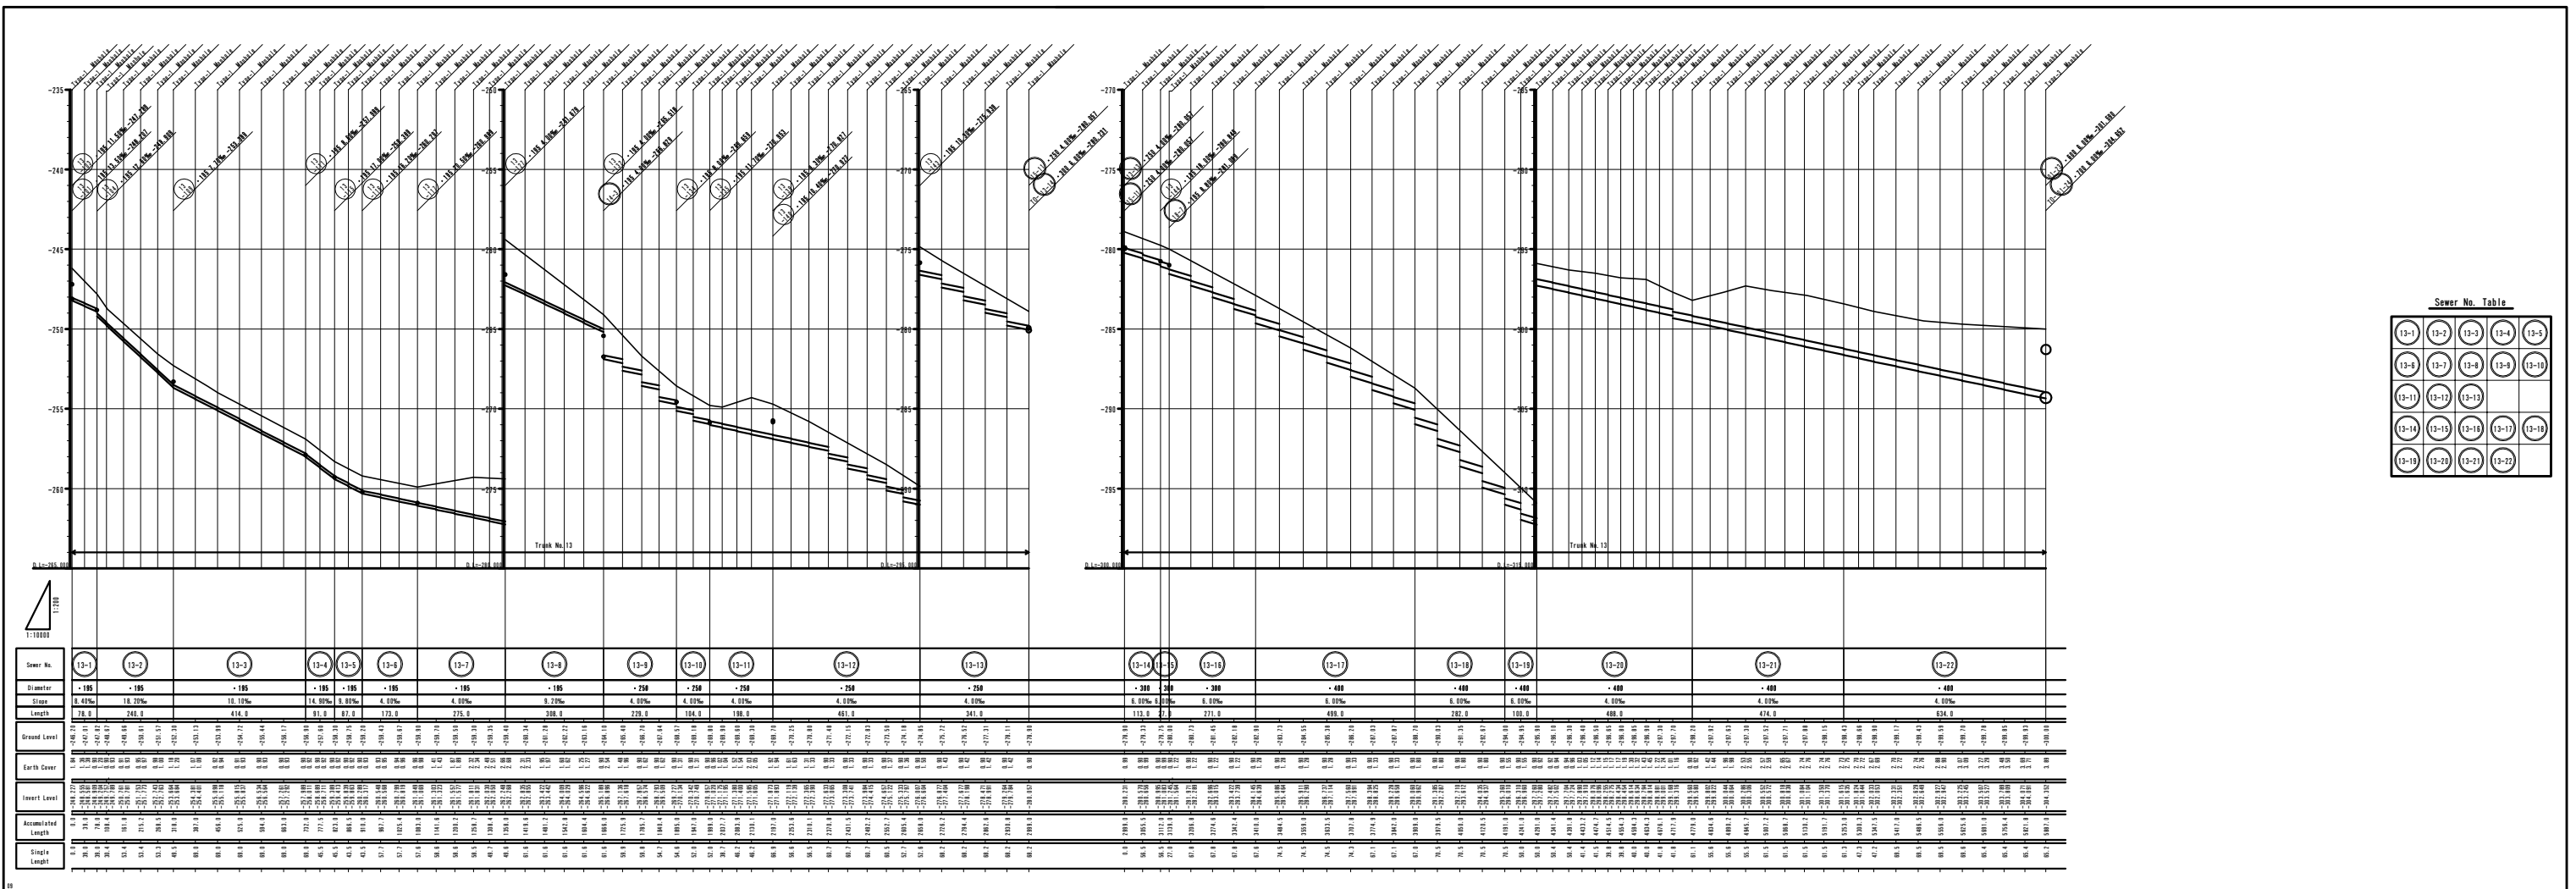

Sewer No. Table				
13-1	13-2	13-3	13-4	13-5
13-6	13-7	13-8	13-9	13-10
13-11	13-12	13-13		
13-14	13-15	13-16	13-17	13-18
13-19	13-20	13-21	13-22	

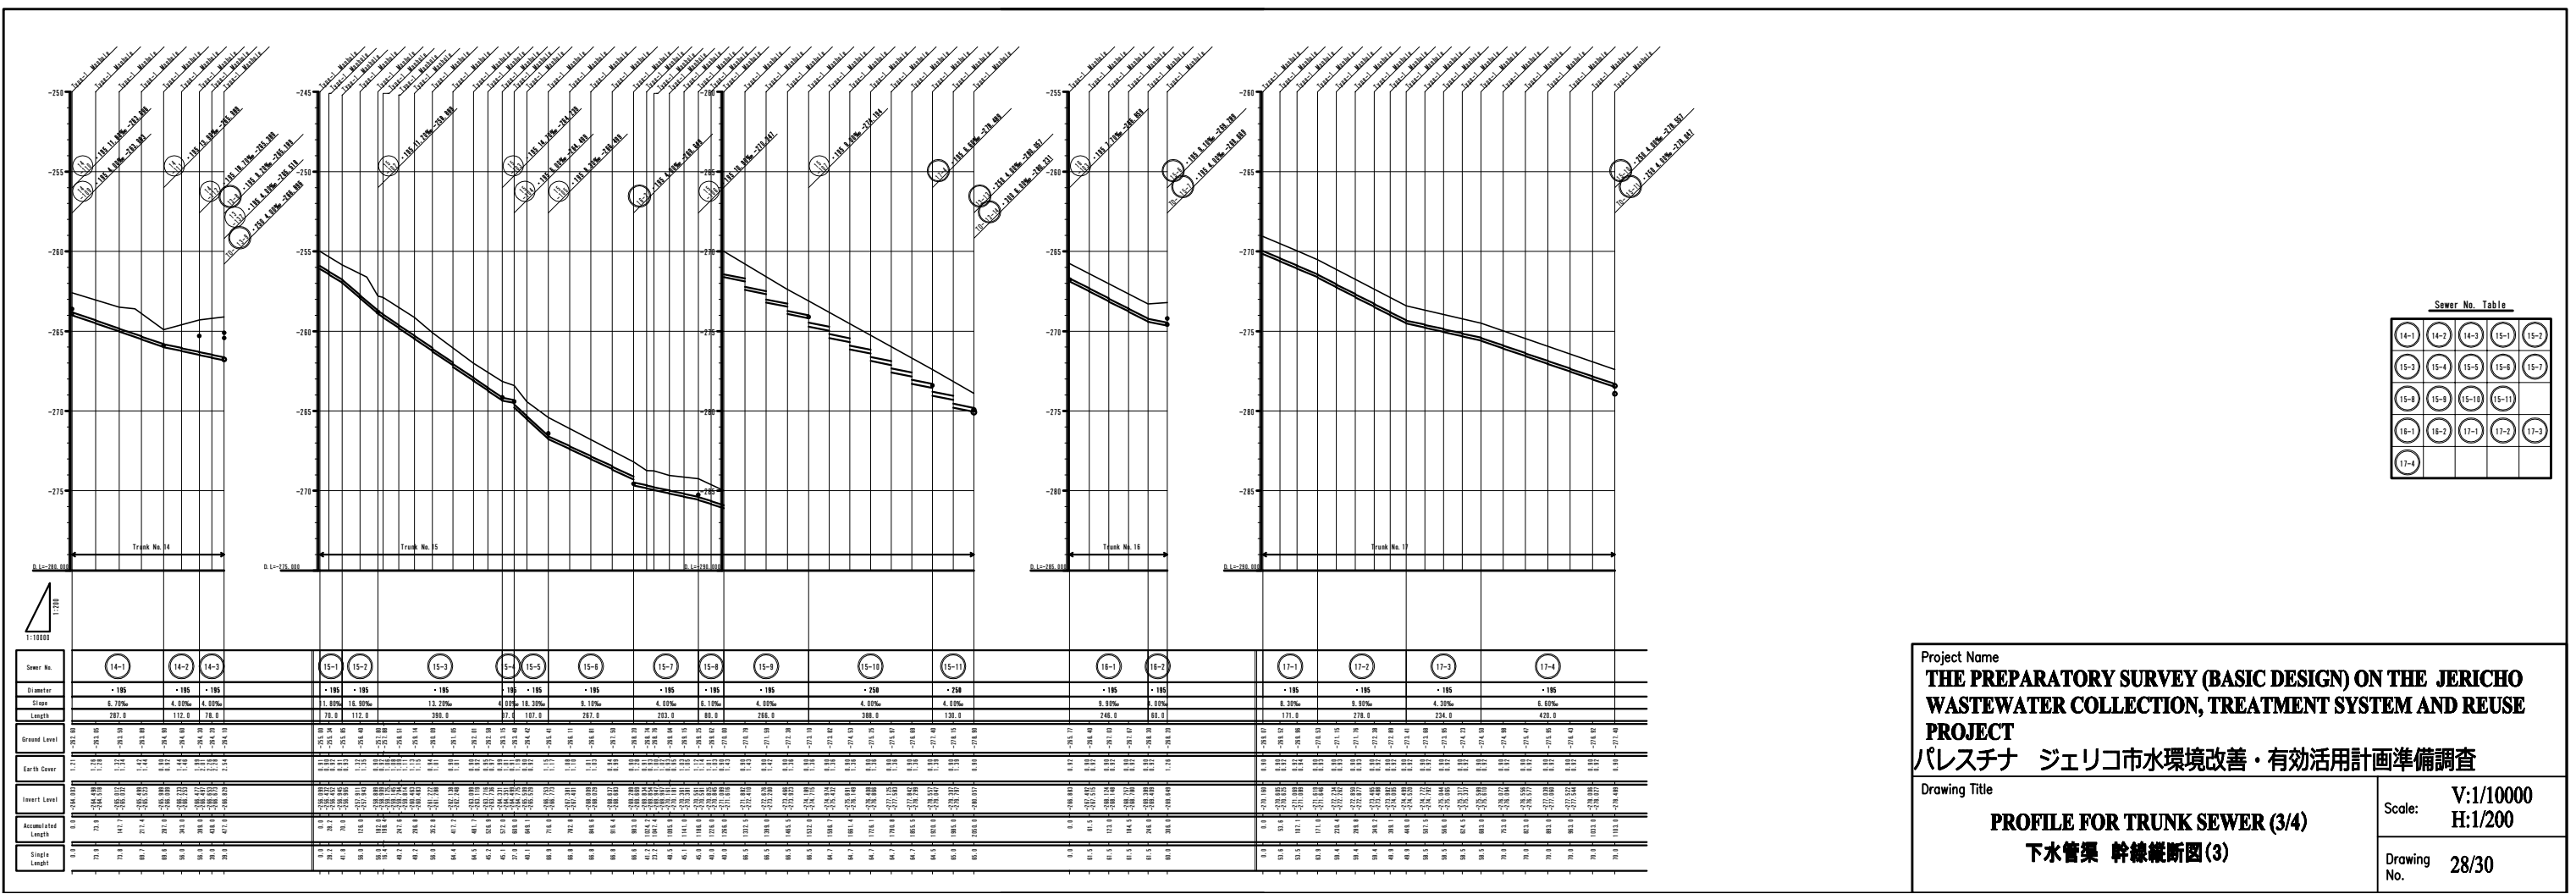


Sewer No. Table				
14-1	14-2	14-3	15-1	15-2
15-3	15-4	15-5	15-6	15-7
15-8	15-9	15-10	15-11	
16-1	16-2	17-1	17-2	17-3
17-4				

Project Name
THE PREPARATORY SURVEY (BASIC DESIGN) ON THE JERICHO WASTEWATER COLLECTION, TREATMENT SYSTEM AND REUSE PROJECT
 パレスチナ ジェリコ市水環境改善・有効活用計画準備調査


Drawing Title
PROFILE FOR TRUNK SEWER (3/4)
 下水管渠 幹線縦断面図(3)

Scale:
 V:1/10000
 H:1/200


Drawing No.
 28/30

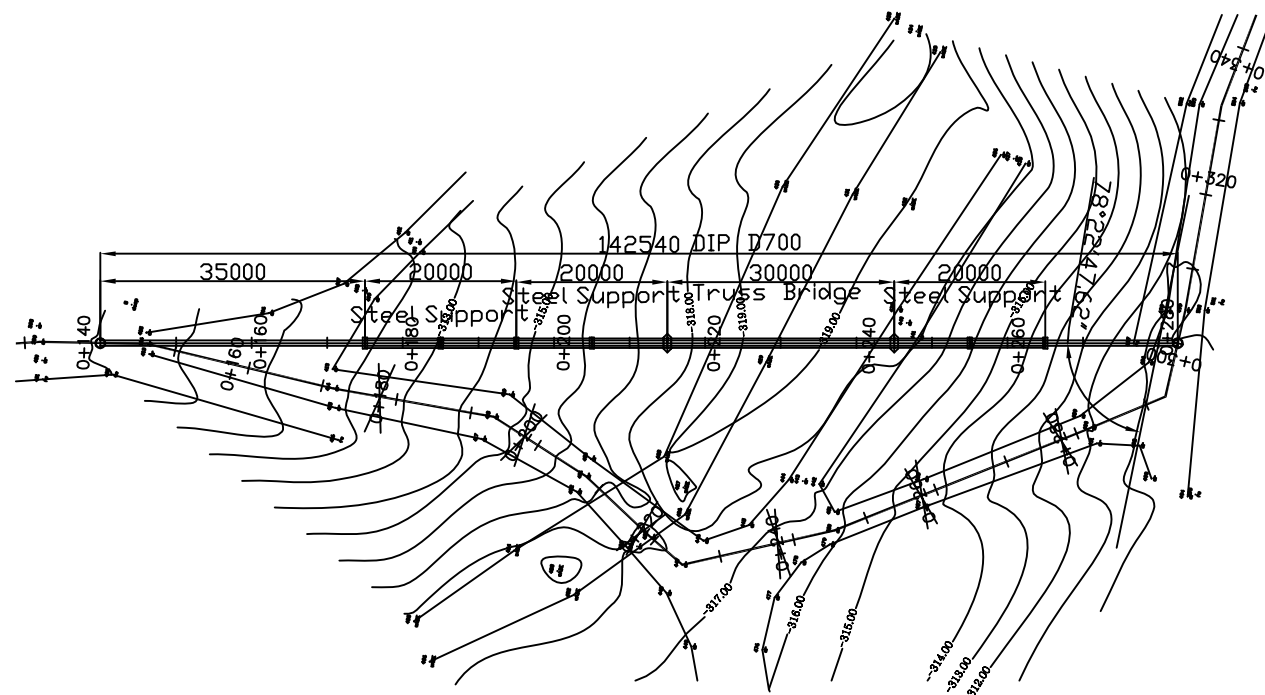

PIPE CROSSING PLAN

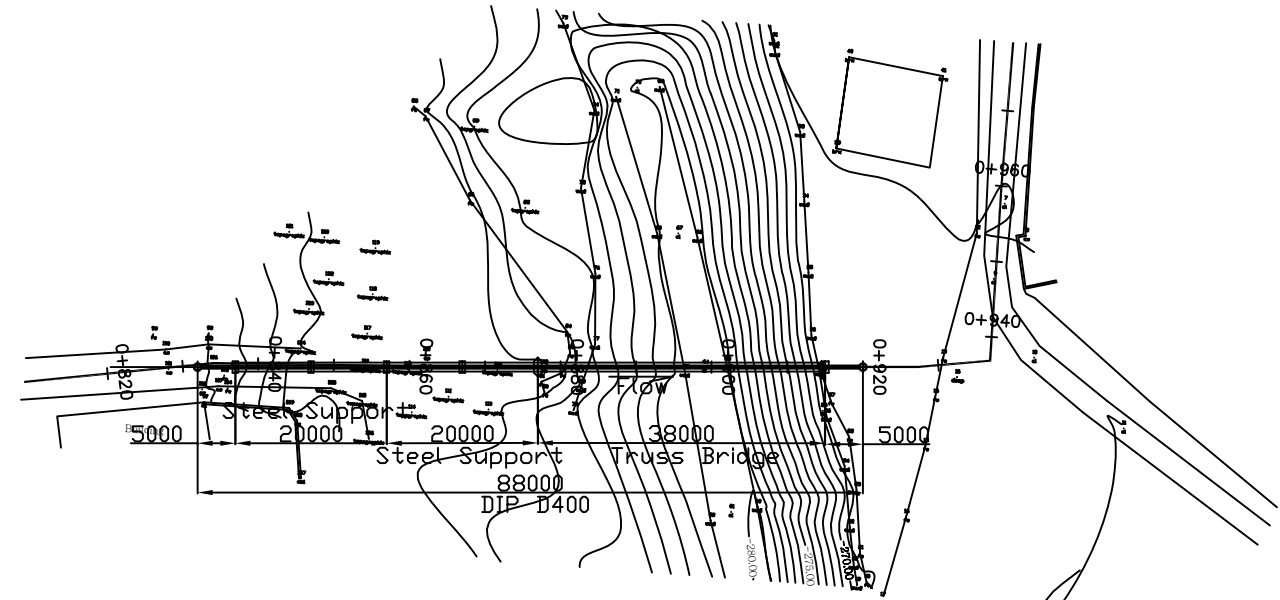


PIPE CROSSING PLAN

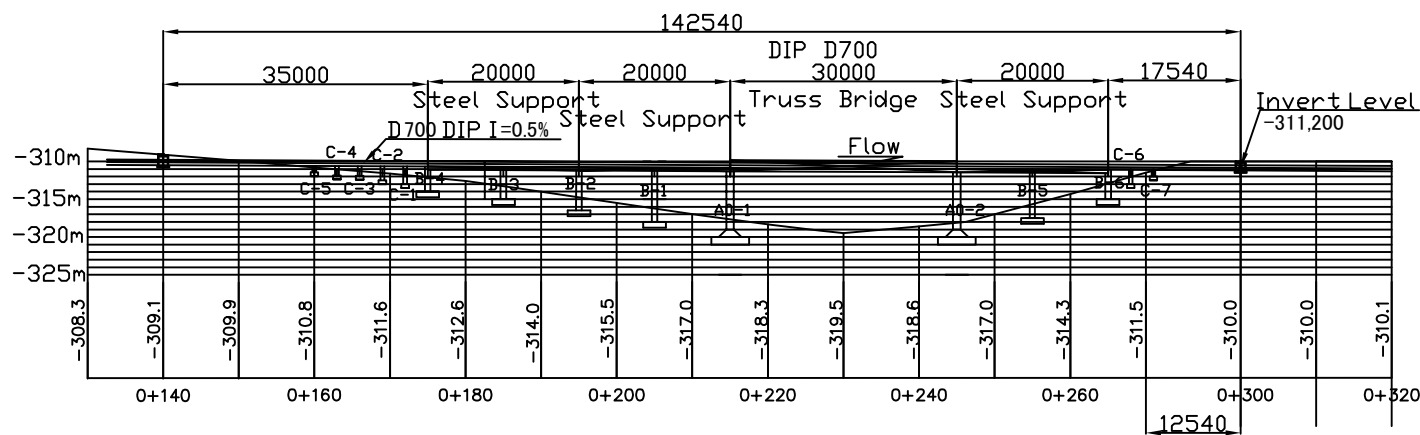

PIPE CROSSING PROFILE

PIPE CROSSING FOR D700

Scale 1:500

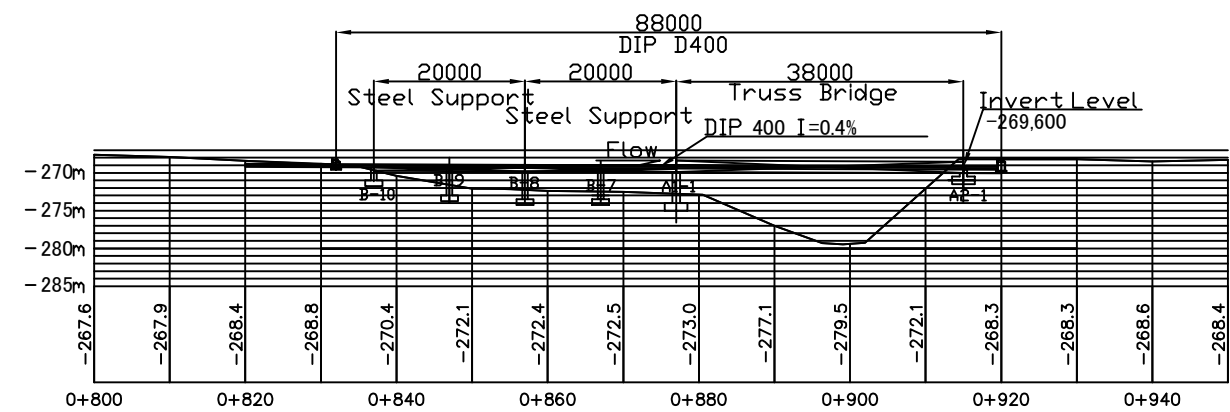

PIPE CROSSING PROFILE

PIPE CROSSING FOR D400

Scale 1:500

Project Name	
THE PREPARATORY SURVEY (BASIC DESIGN) ON THE JERICHO WASTEWATER COLLECTION, TREATMENT SYSTEM AND REUSE PROJECT	
パレスチナ ジェリコ市水環境改善・有効活用計画準備調査	
Drawing Title	Scale: 1:500
SEWER PIPE WADI CROSSING PLAN AND PROFILE 下水管渠 ワジ横断面 平面及び縦断面図	Drawing No. 30/30