



概略設計図

概略設計図リスト (List of Outline Design Drawings)



No.	Drawing No.	Title	図面名称
1	BLC-001	Single Line Diagram	主回路単線接続図
2	BLC-002	Power Station System Diagram	所内単線結線図
3	BLC-003	Plan of Baluchaung No.2 HPS	発電所発電機フロア平面図
4	BLC-004	Sectional View of Baluchaung No.2 HPS	発電所横断面図
5	BLC-005	Section of Baluchaung No.2 HPS	発電所縦断面図
6	BLC-006	Water and Air Piping System for Unit No.1- No.3	1-3号冷却水及び圧縮空気配管系統図
7	BLC-007	Water and Air Piping System for Unit No.4- No.6	4-6号冷却水及び圧縮空気配管系統図
8	BLC-008	Oil Piping System for Unit No.1- No.3	1-3号圧油配管系統図
9	BLC-009	Oil Piping System for Unit No.4- No.6	4-6号圧油配管系統図
10	BLC-010	Layout Drawing of Control Room	配電盤室平面図
11	BLC-011	Longitudinal Section of Switch Gear Room and Control Room	配電盤室 開閉器室断面図
12	BLC-012	Front View of Meter Panel, Sloping Panel and Vertical Panel for Unit No.1- No.3	1-3号機計器盤 制御デスク
13	BLC-013	Front View of Meter Panel, Sloping Panel and Vertical Panel for Unit No.4-No.6	4-6号機計器盤 制御デスク
14	BLC-014	Front View of Relay Panel for Unit No.1-No.6	1-6号機保護継電器盤
15	BLC-015	Front View of Automatic Control Panel for Unit No.1-No.6	1-6号機自動制御盤
16	BLC-016	Plan of House Service Transformer and 33kV Cubicle	屋外開閉所平面図
17	BLC-017	Plan of Outdoor Switchyard	所内変圧器周辺平面図

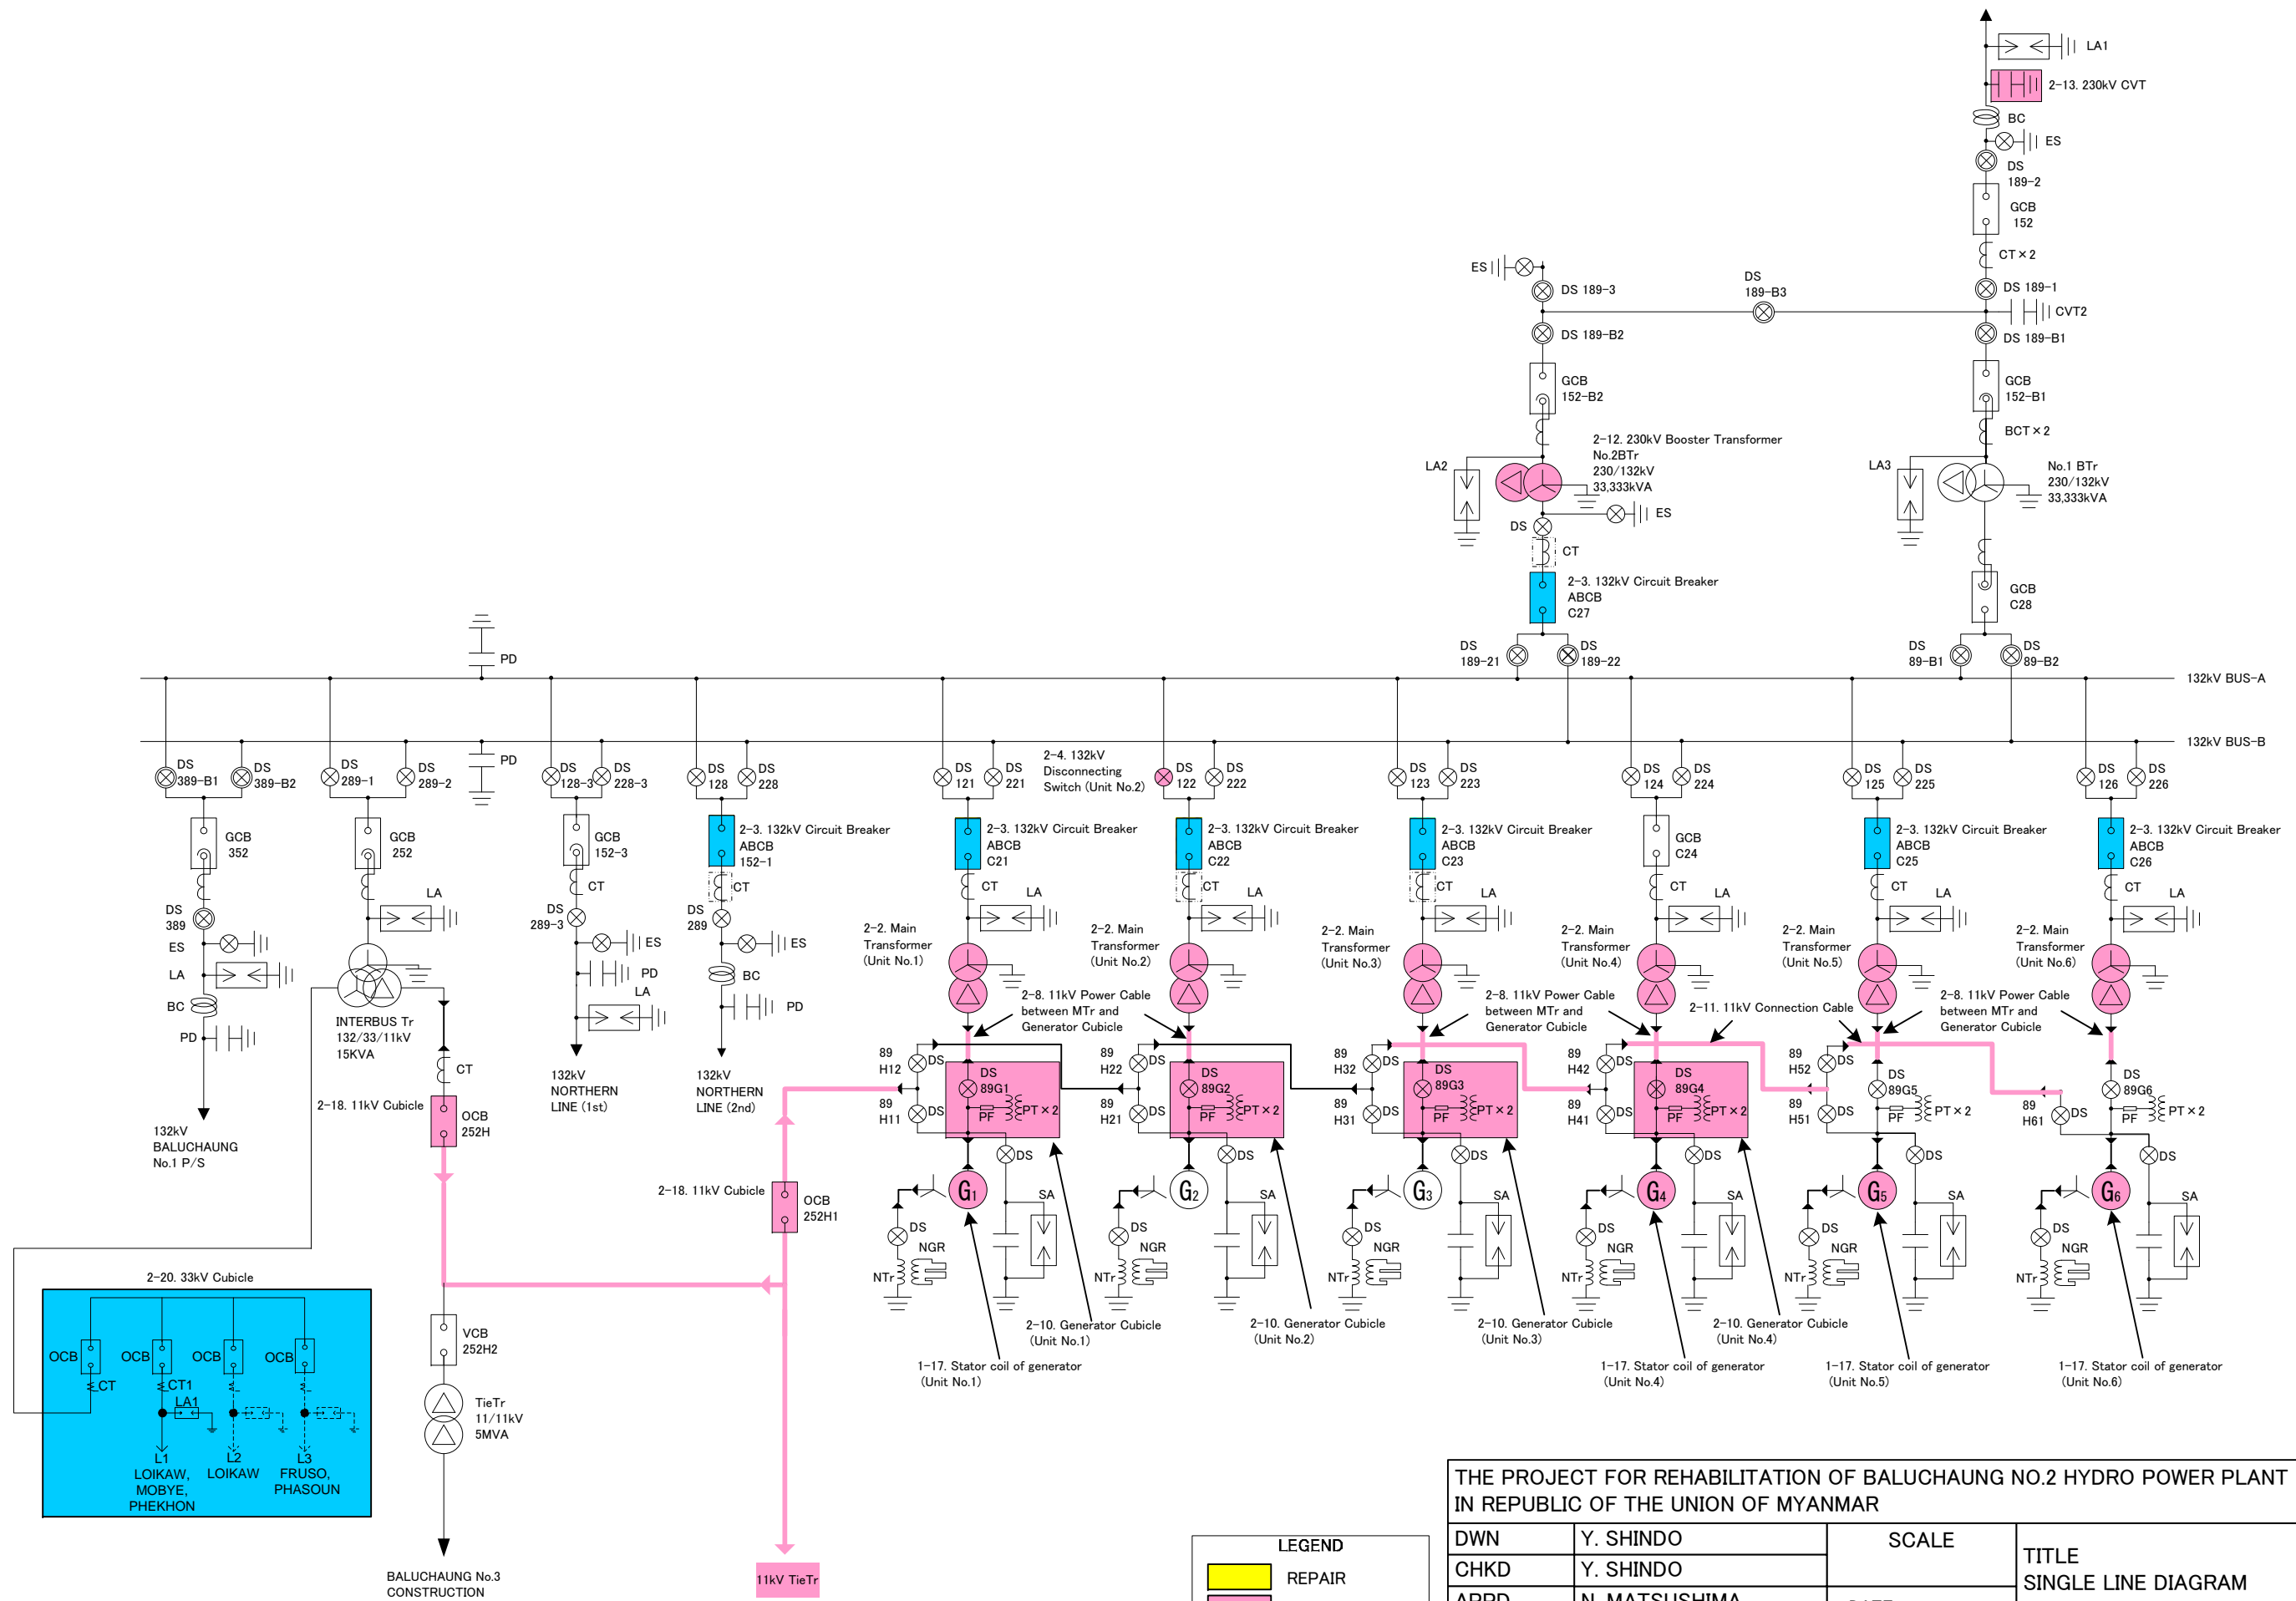

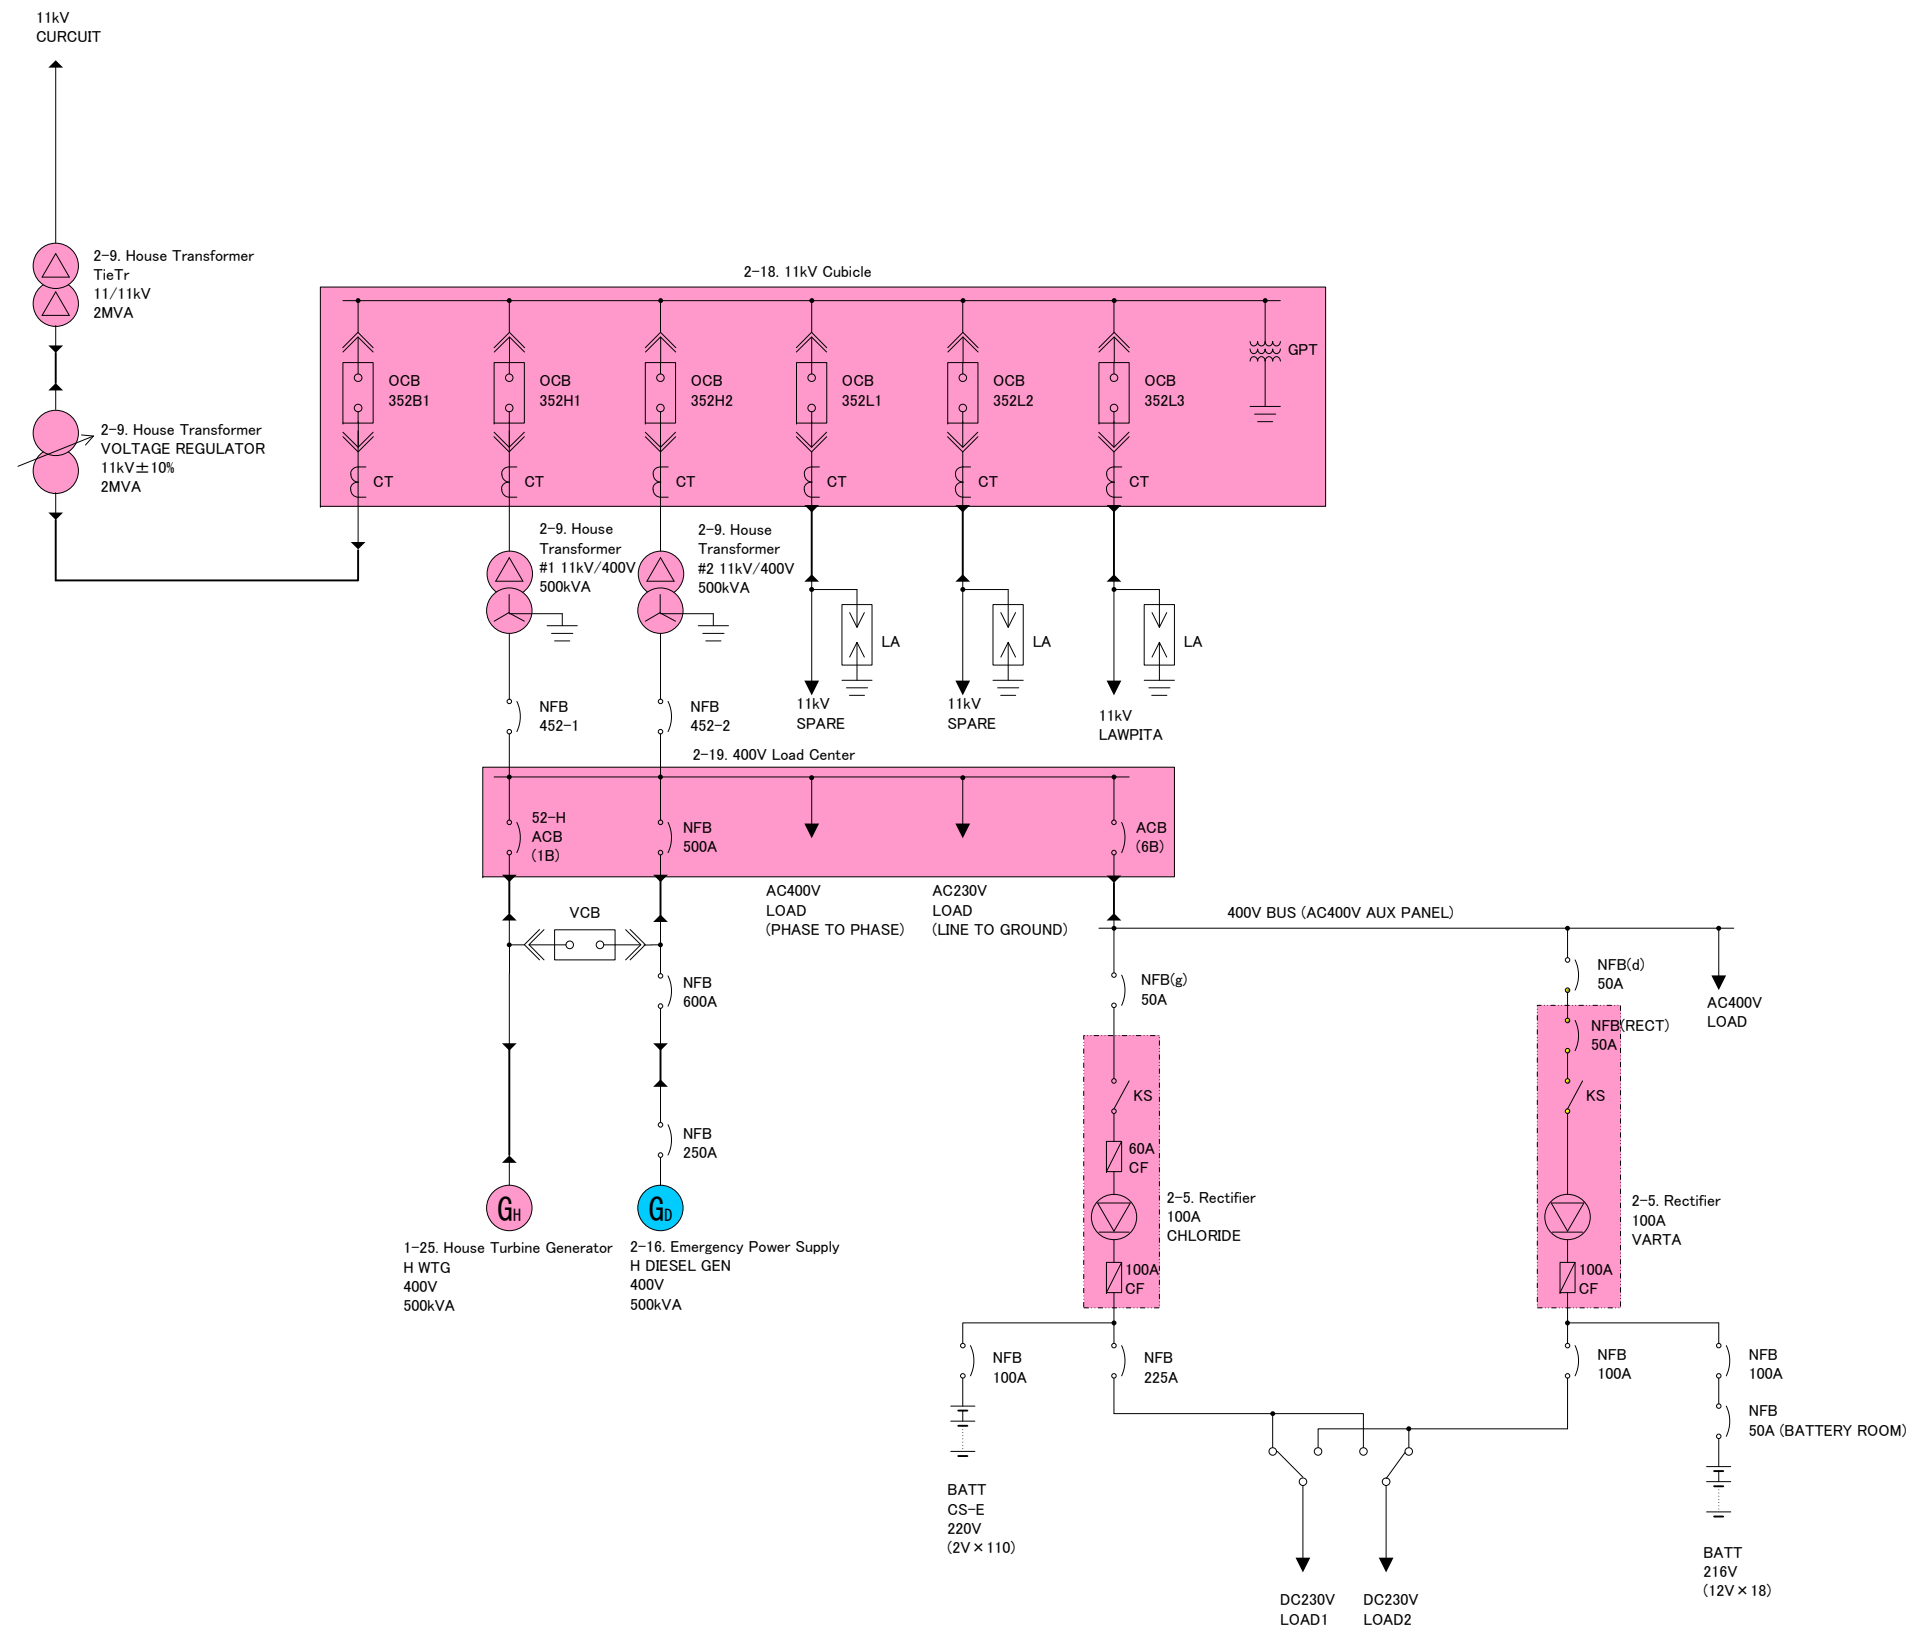



LEGEND	
REPAIR	
REPLACE	
MODIFICATION	

THE PROJECT FOR REHABILITATION OF BALUCHAUNG NO.2 HYDRO POWER PLANT IN REPUBLIC OF THE UNION OF MYANMAR			
DWN	Y. SHINDO	SCALE	TITLE POWER STATION SYSTEM DIAGRAM
CHKD	Y. SHINDO		
APPD	N. MATSUSHIMA	DATE December 2012	DWG NO BLC-002
NIPPON KOEI CO.,LTD. TOKYO ELECTRIC POWER COMPANY			

 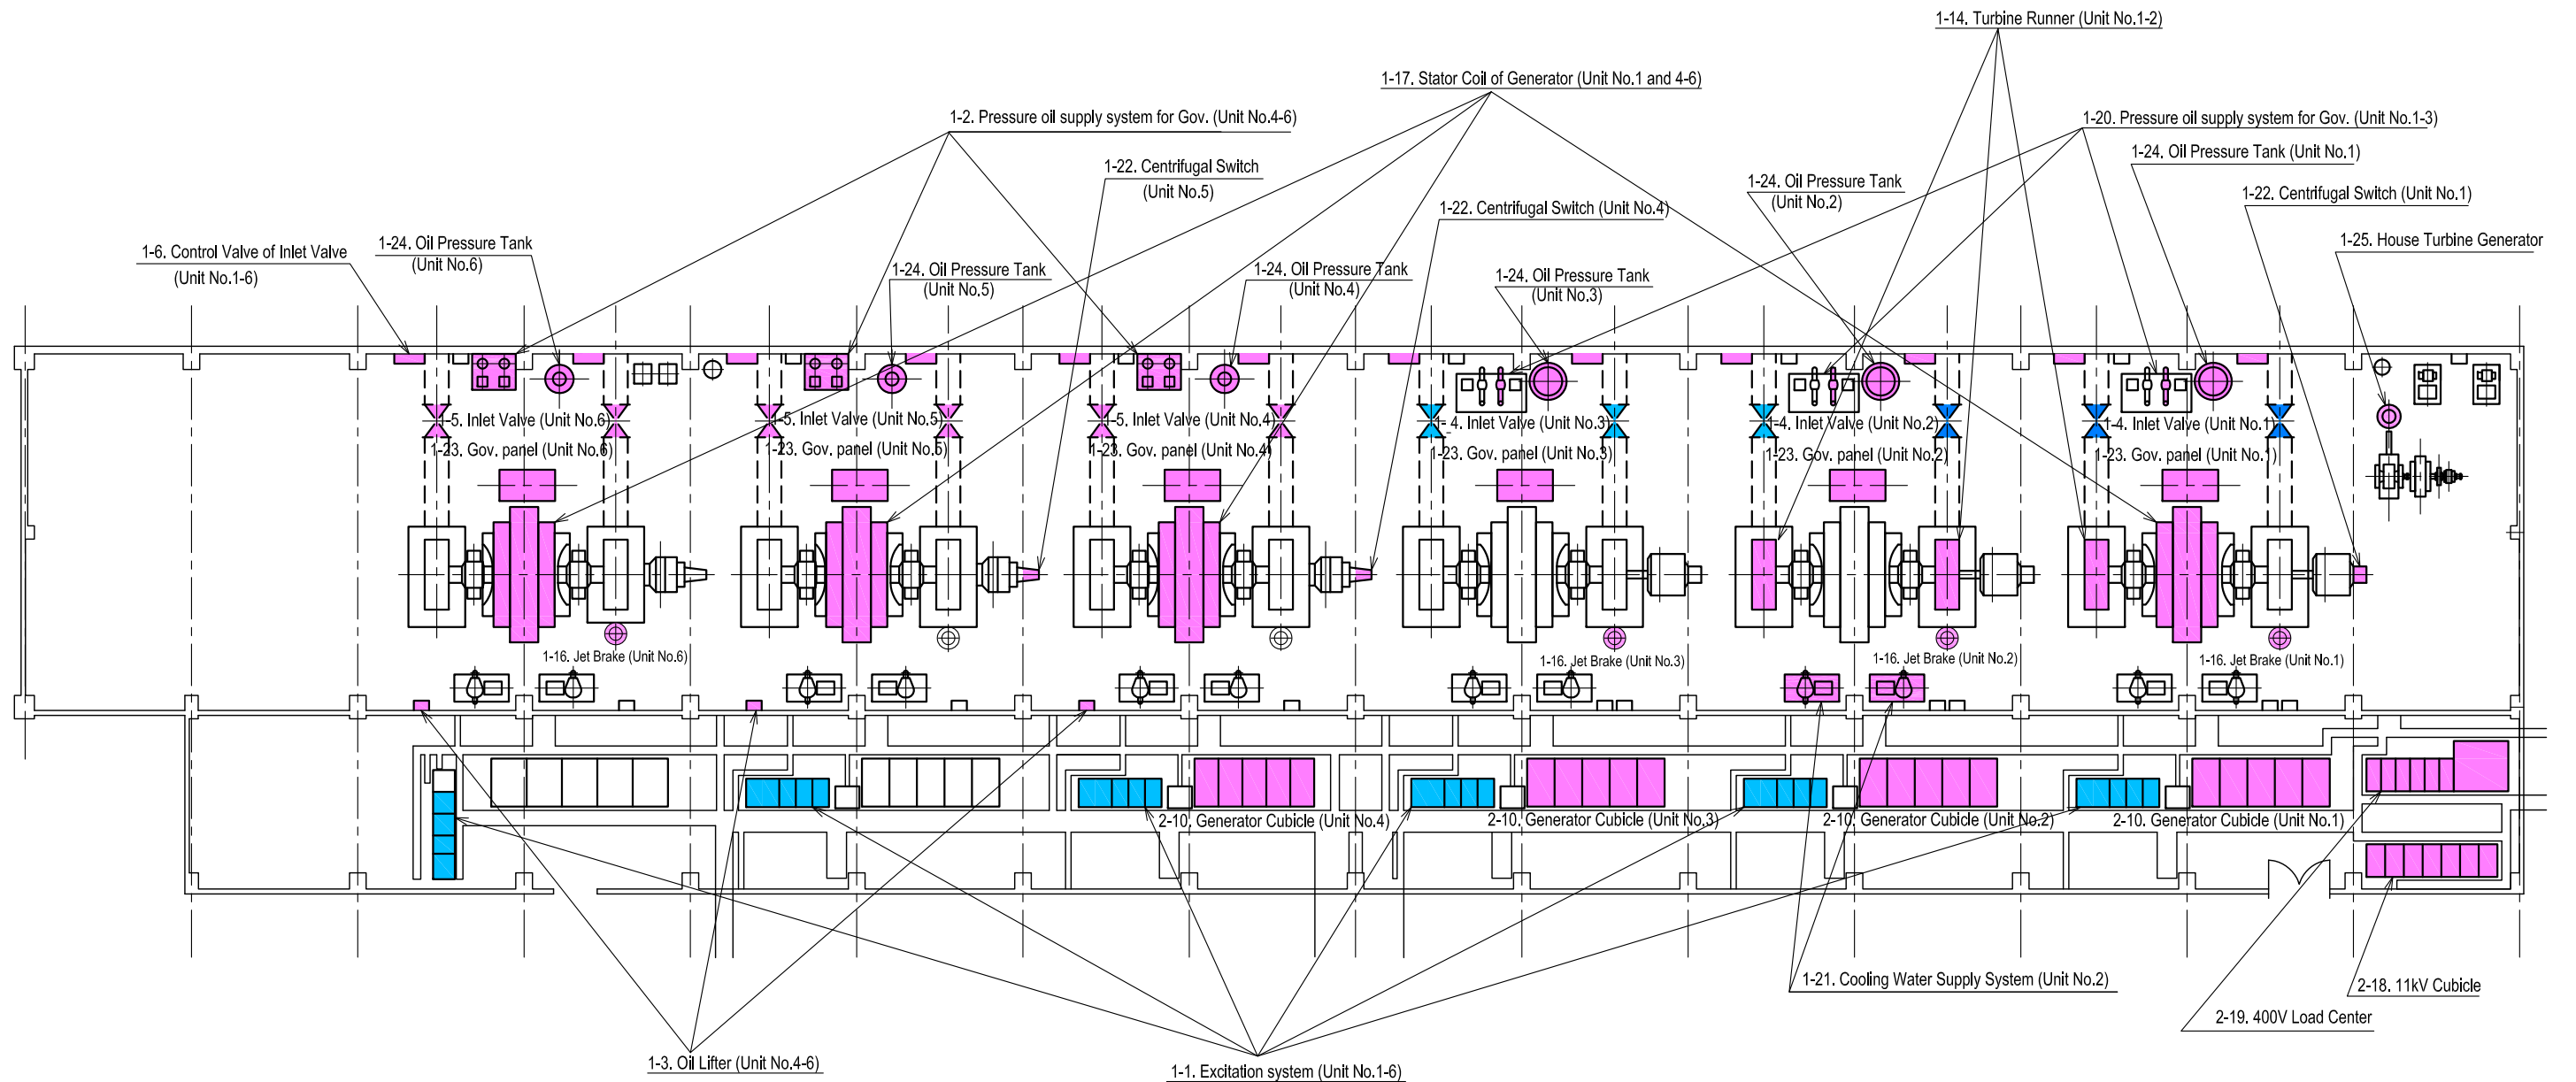

LEGEND	
	REPAIR
	REPLACE
	MODIFICATION

THE PROJECT FOR REHABILITATION OF BALUCHAUNG NO.2 HYDRO POWER PLANT IN REPUBLIC OF THE UNION OF MYANMAR			
DWN	C. JOZAKI	SCALE	TITLE
CHKD	C. JOZAKI		
APPD	N. MATSUSHIMA	DATE	PLAN OF BALUCHAUNG No2 HPS
NIPPON KOEI CO.,LTD. TOKYO ELECTRIC POWER COMPANY			
DWG NO	BLC-003		

 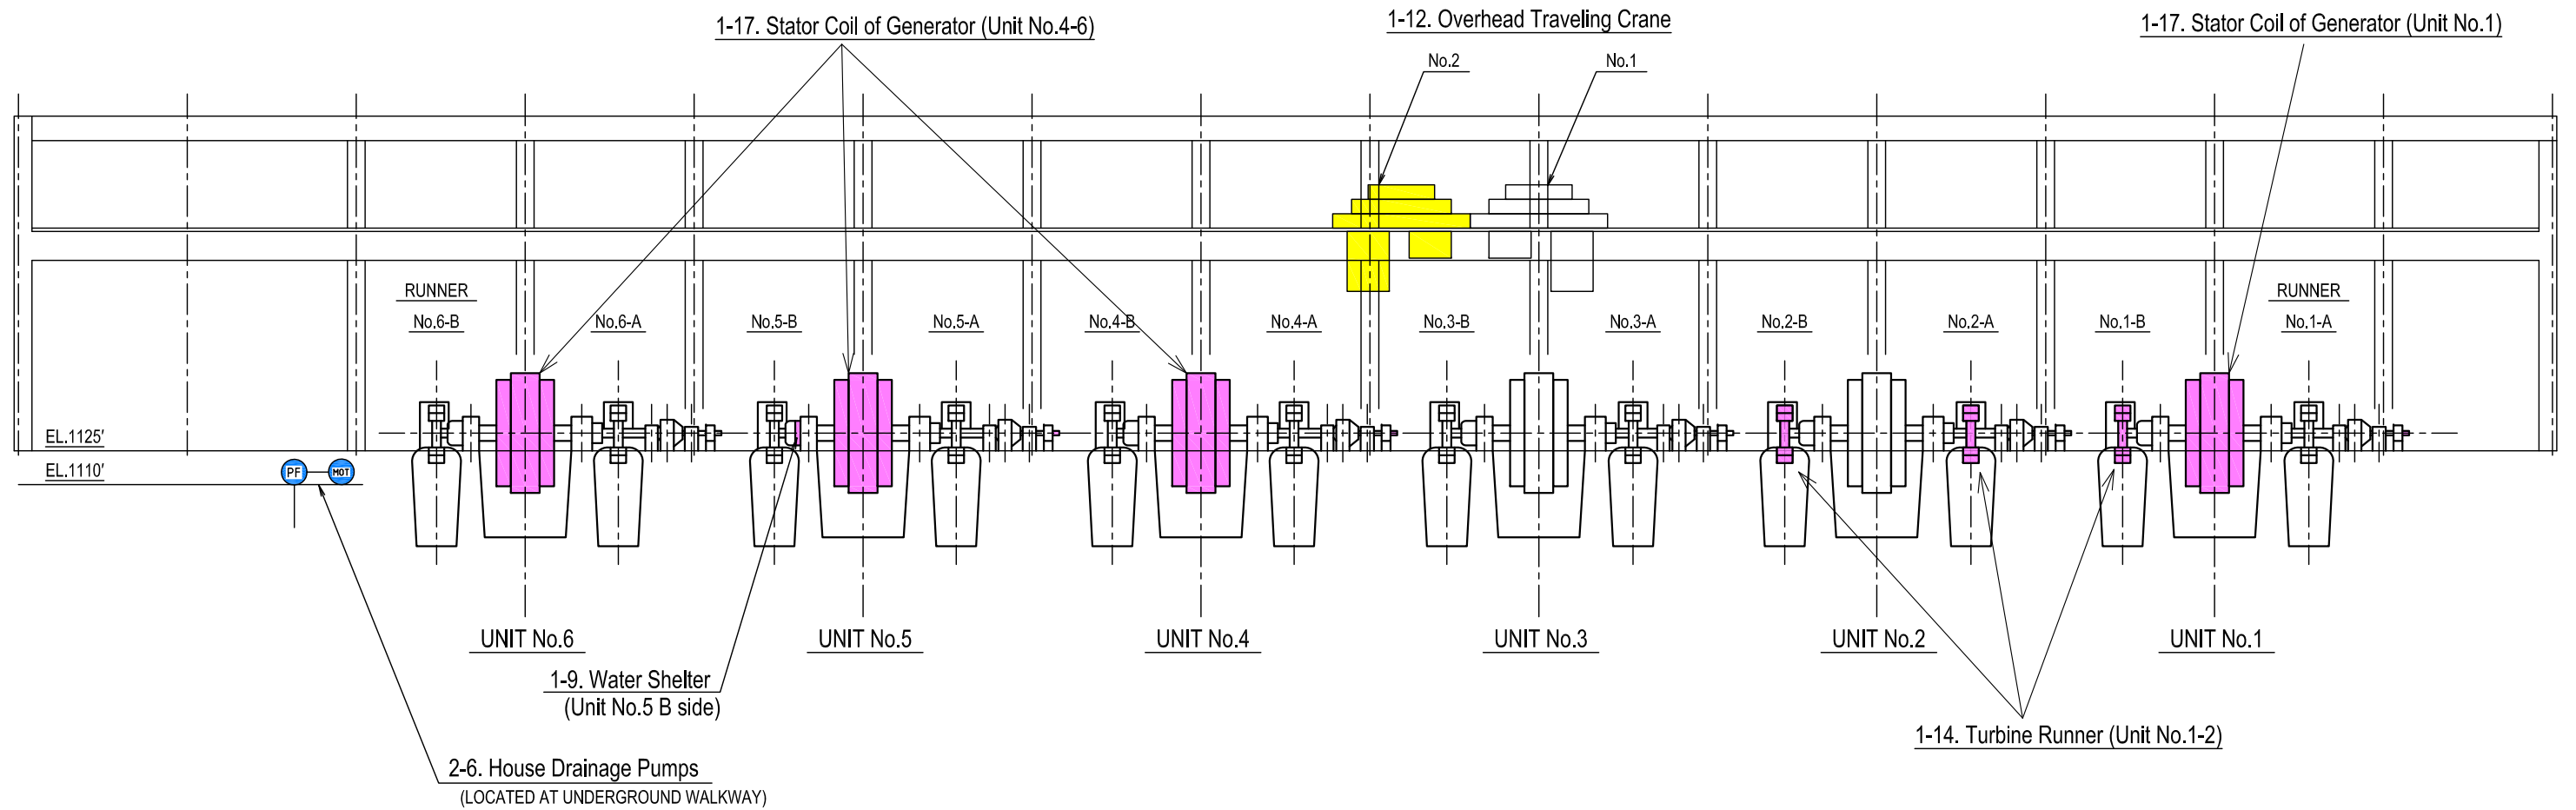

LEGEND	
	REPAIR
	REPLACE
	MODIFICATION

THE PROJECT FOR REHABILITATION OF BALUCHAUNG NO.2 HYDRO POWER PLANT IN REPUBLIC OF THE UNION OF MYANMAR			
DWN	C. JOZAKI	SCALE	TITLE
CHKD	C. JOZAKI		SECTIONAL VIEW OF BALUCHAUNG NO.2 HPS
APPD	N. MATSUSHIMA	DATE	DWG NO
NIPPON KOEI CO.,LTD. TOKYO ELECTRIC POWER COMPANY			December 2012