




B - 3

パッケージ別配電系統図：
既設変電所からの延伸



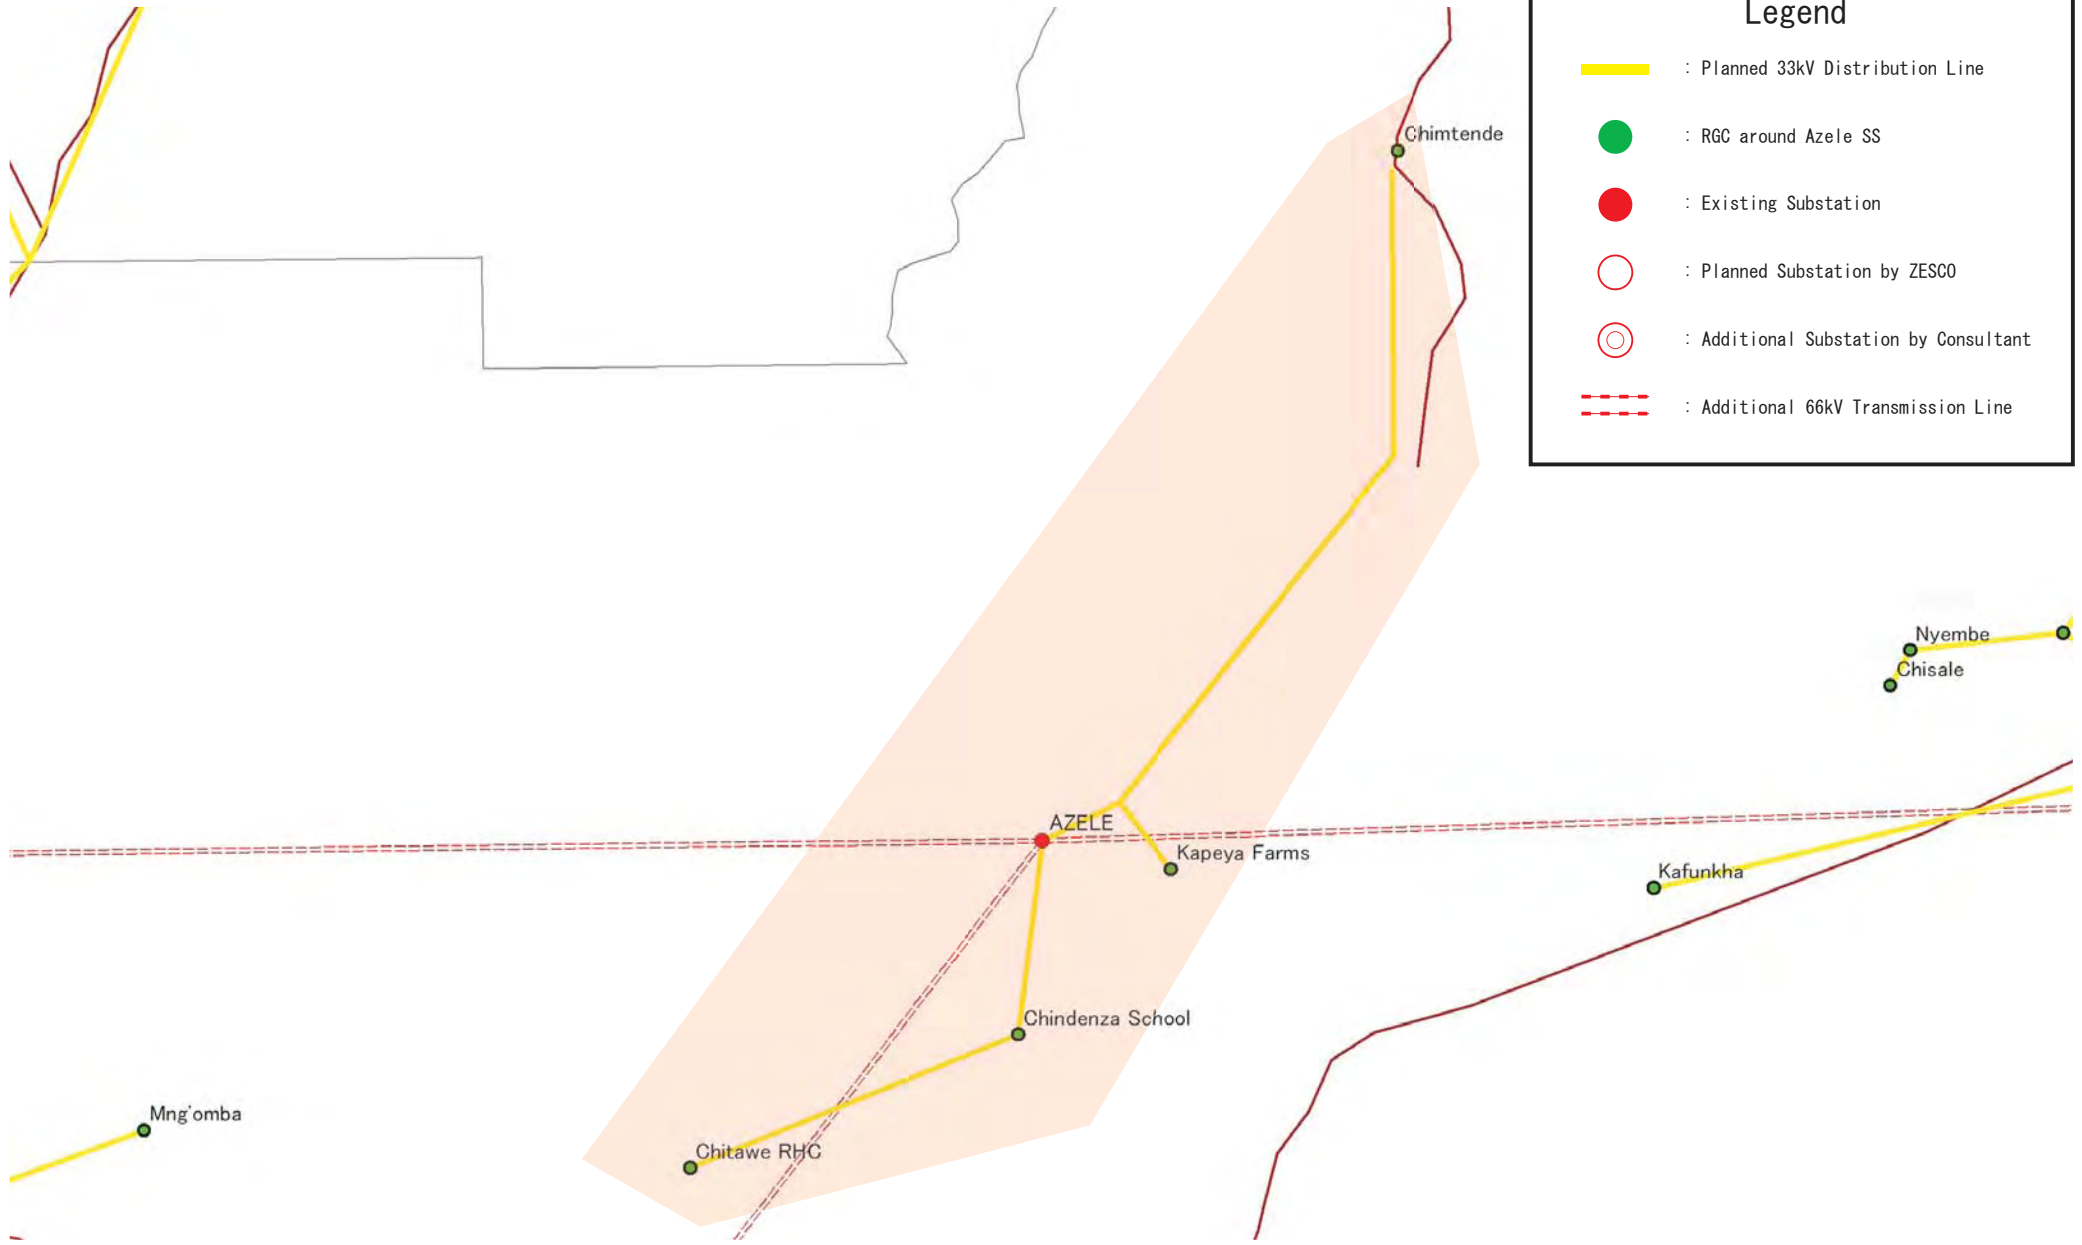

Legend

- : Planned 33kV Distribution Line
- : RGC around Azele SS
- : Existing Substation
- : Planned Substation by ZESCO
- : Additional Substation by Consultant
- : Additional 66kV Transmission Line


 ZESCO	The Study for Development of the Rural Electrification Master Plan in Zambia	Drawing No.
	 TEPCO	Tokyo Electric Power Company

Legend


 : Planned 33kV Distribution Line


 : RGC around Chilundu SS

 : Existing Substation

 : Planned Substation by ZESCO

 : Additional Substation by Consultant

 : Additional 66kV Transmission Line

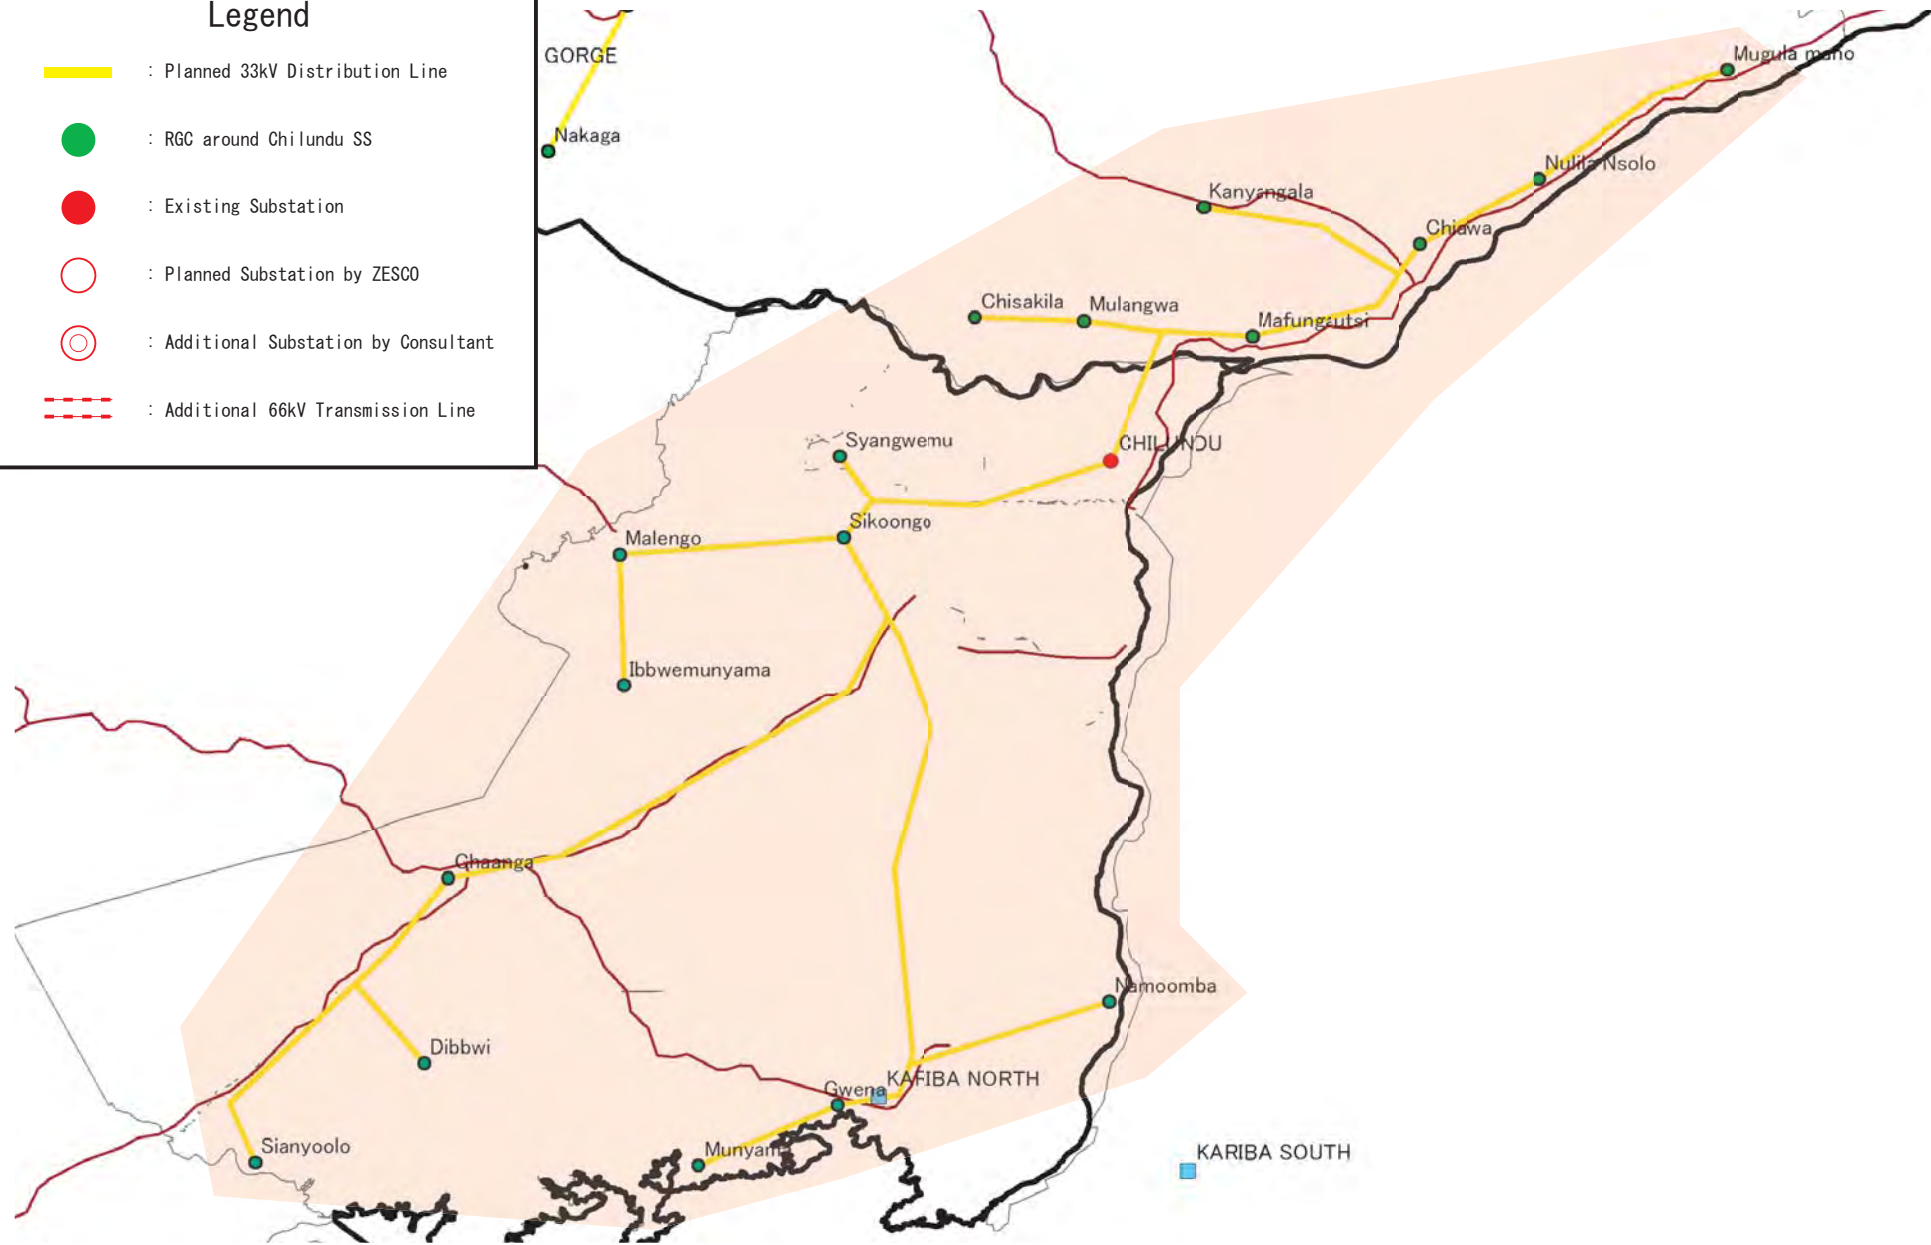

The Study for Development of
the Rural Electrification Master Plan in Zambia




Tokyo Electric Power Company

Drawing No.

Title


DL System at Chilundu SS

Legend

 : Planned 33kV Distribution Line


 : RGC around Chinsali SS

 : Existing Substation

 : Planned Substation by ZESCO

 : Additional Substation by Consultant

 : Additional 66kV Transmission Line

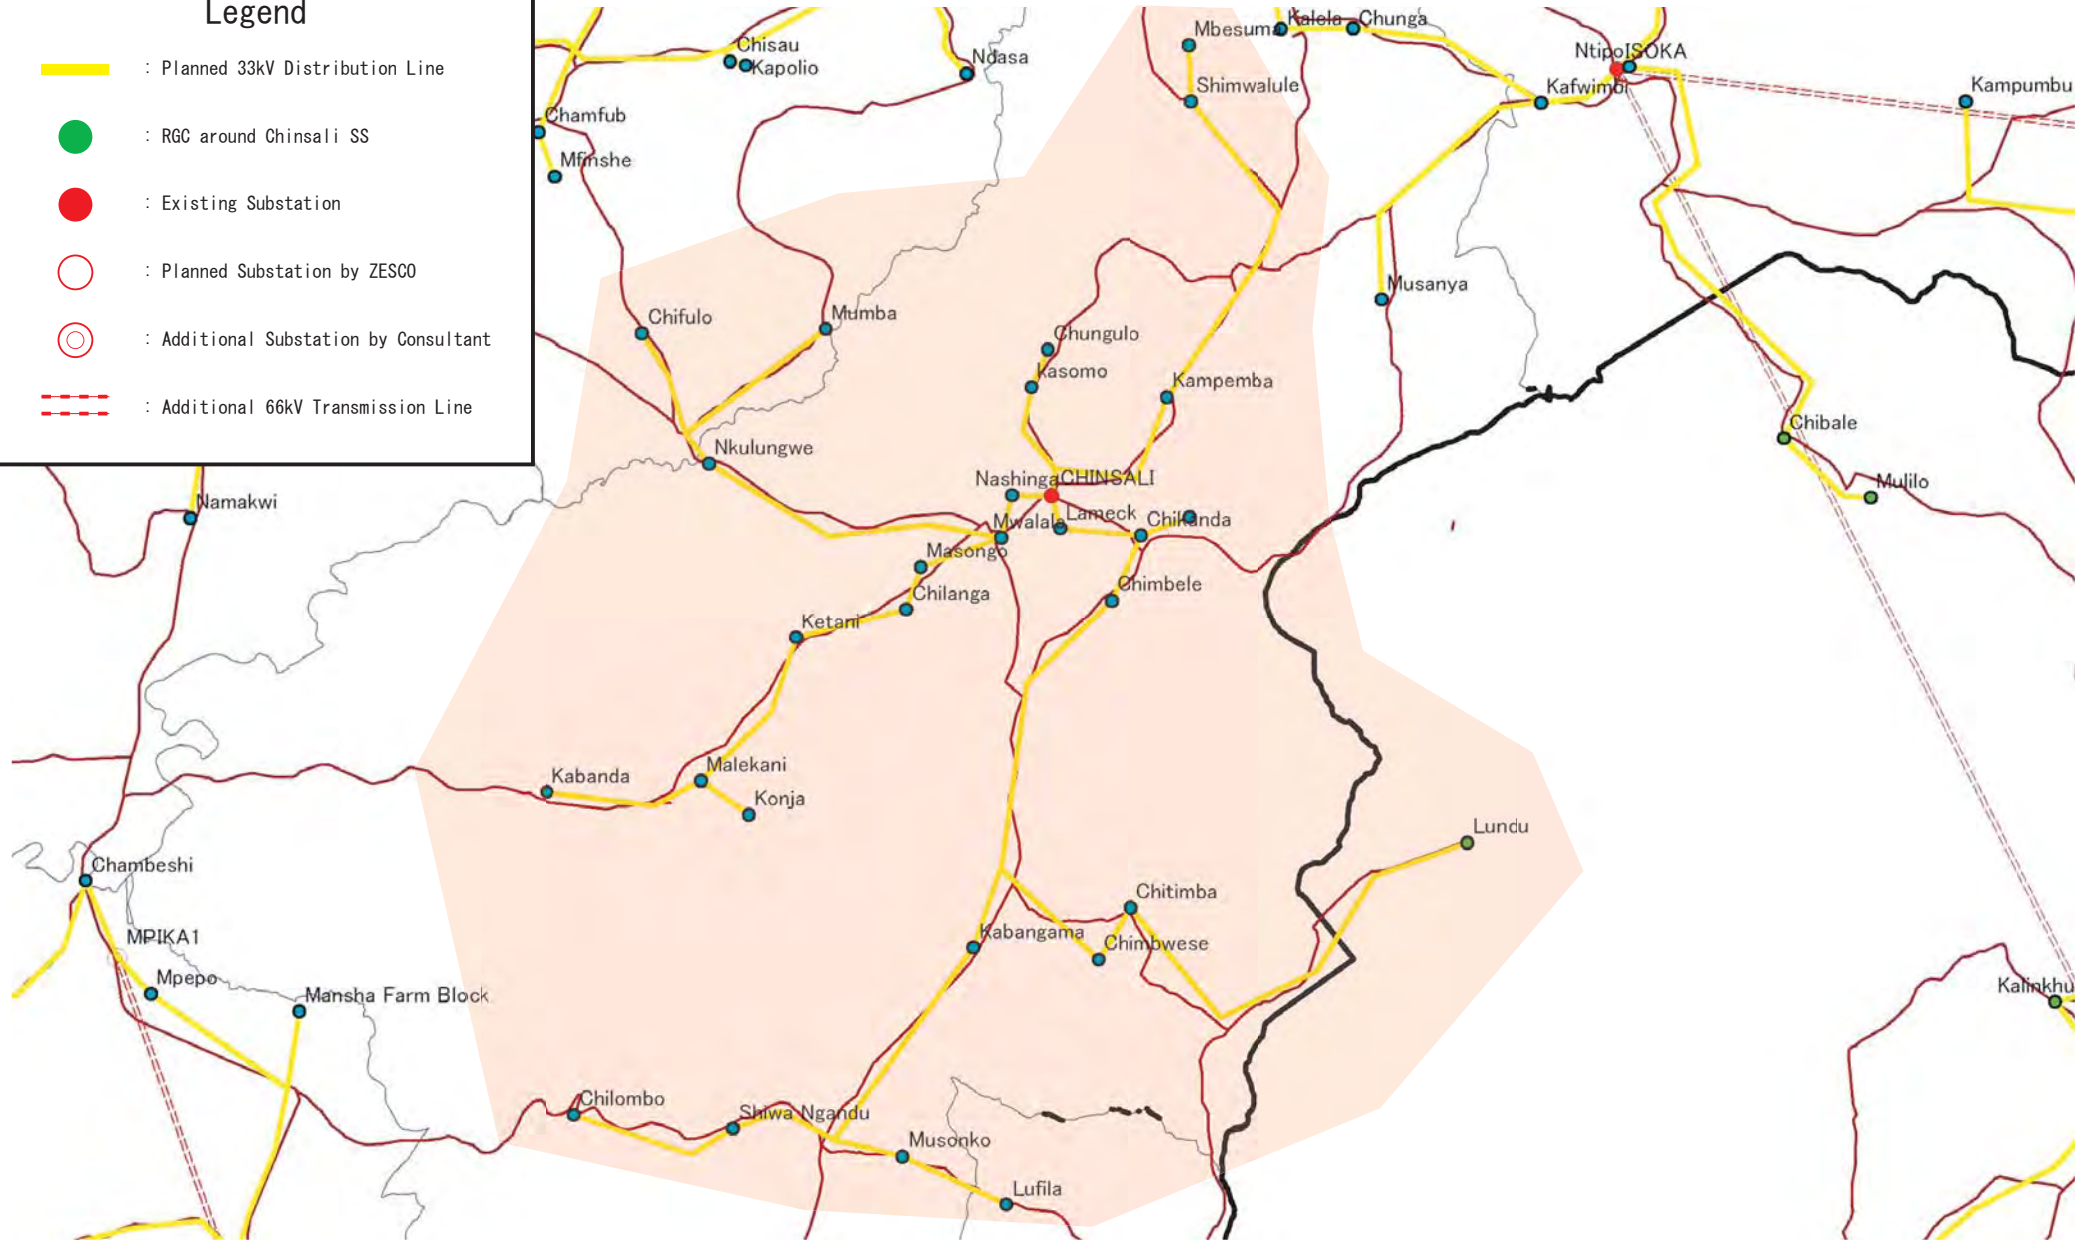

The Study for Development of
the Rural Electrification Master Plan in Zambia




Tokyo Electric Power Company

Drawing No.


Title

DL System at Chinsali SS

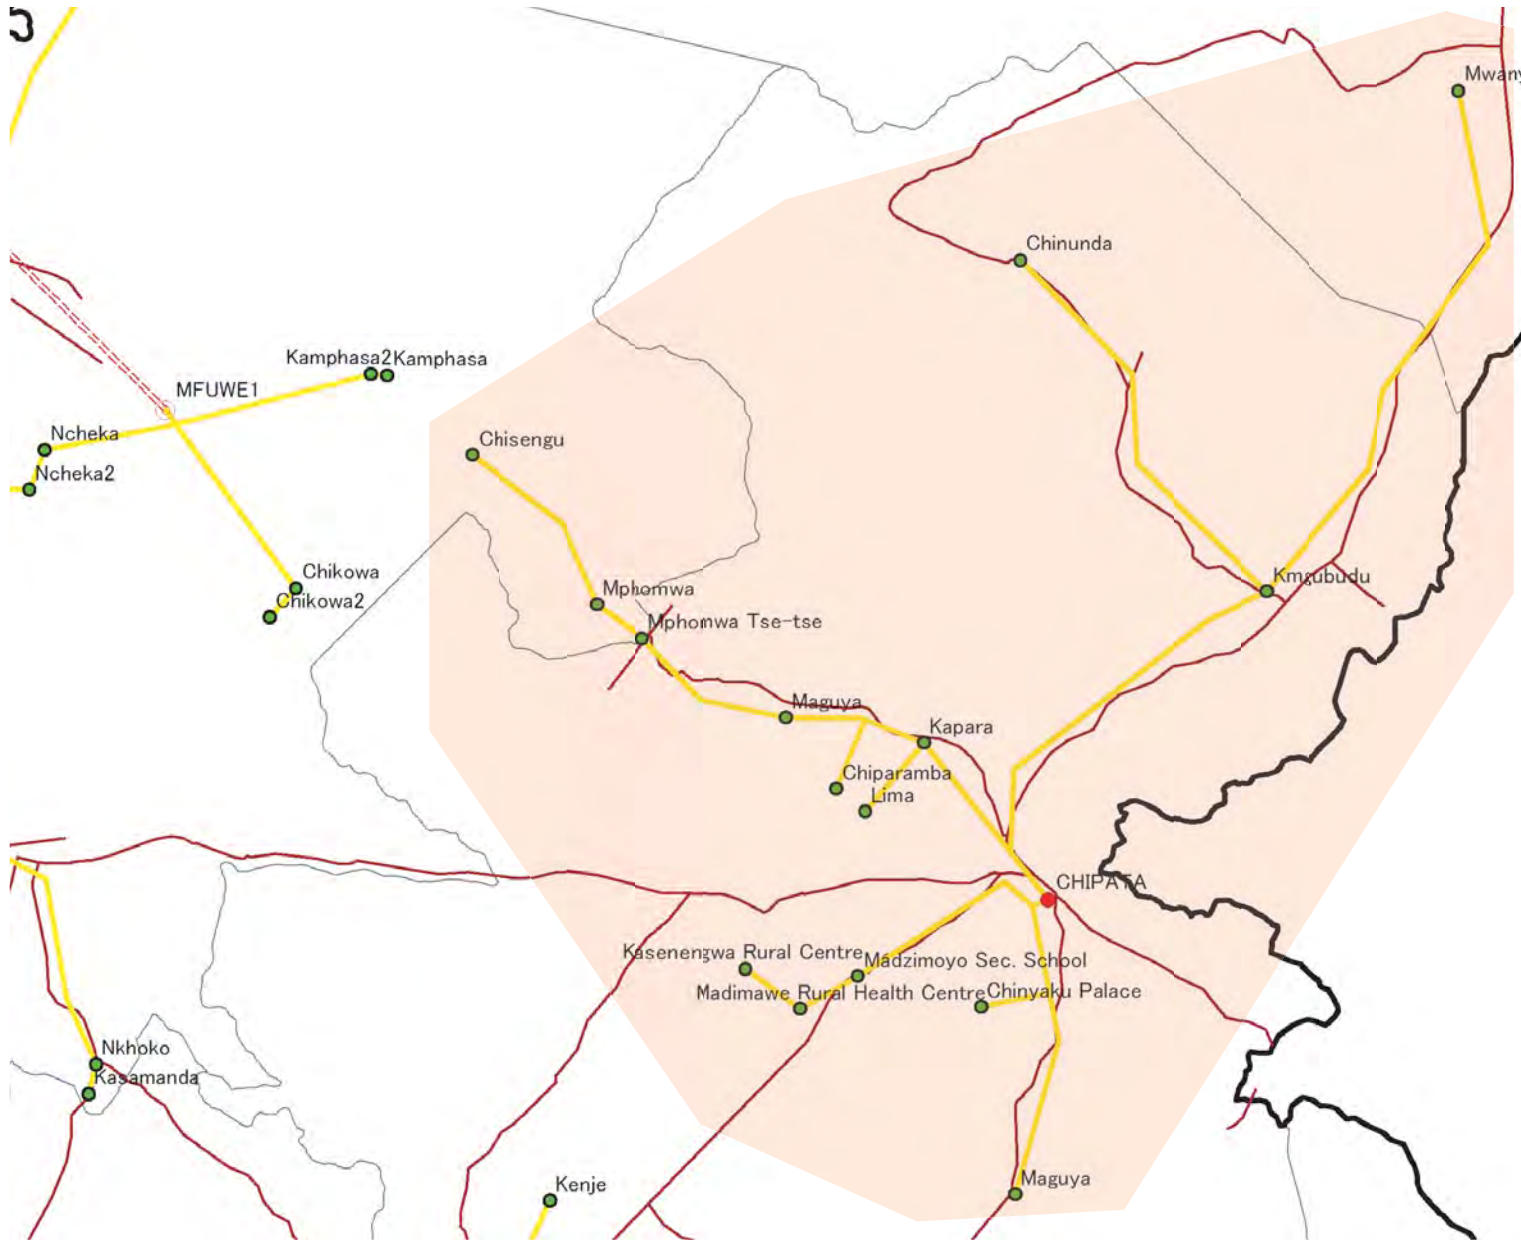



Legend

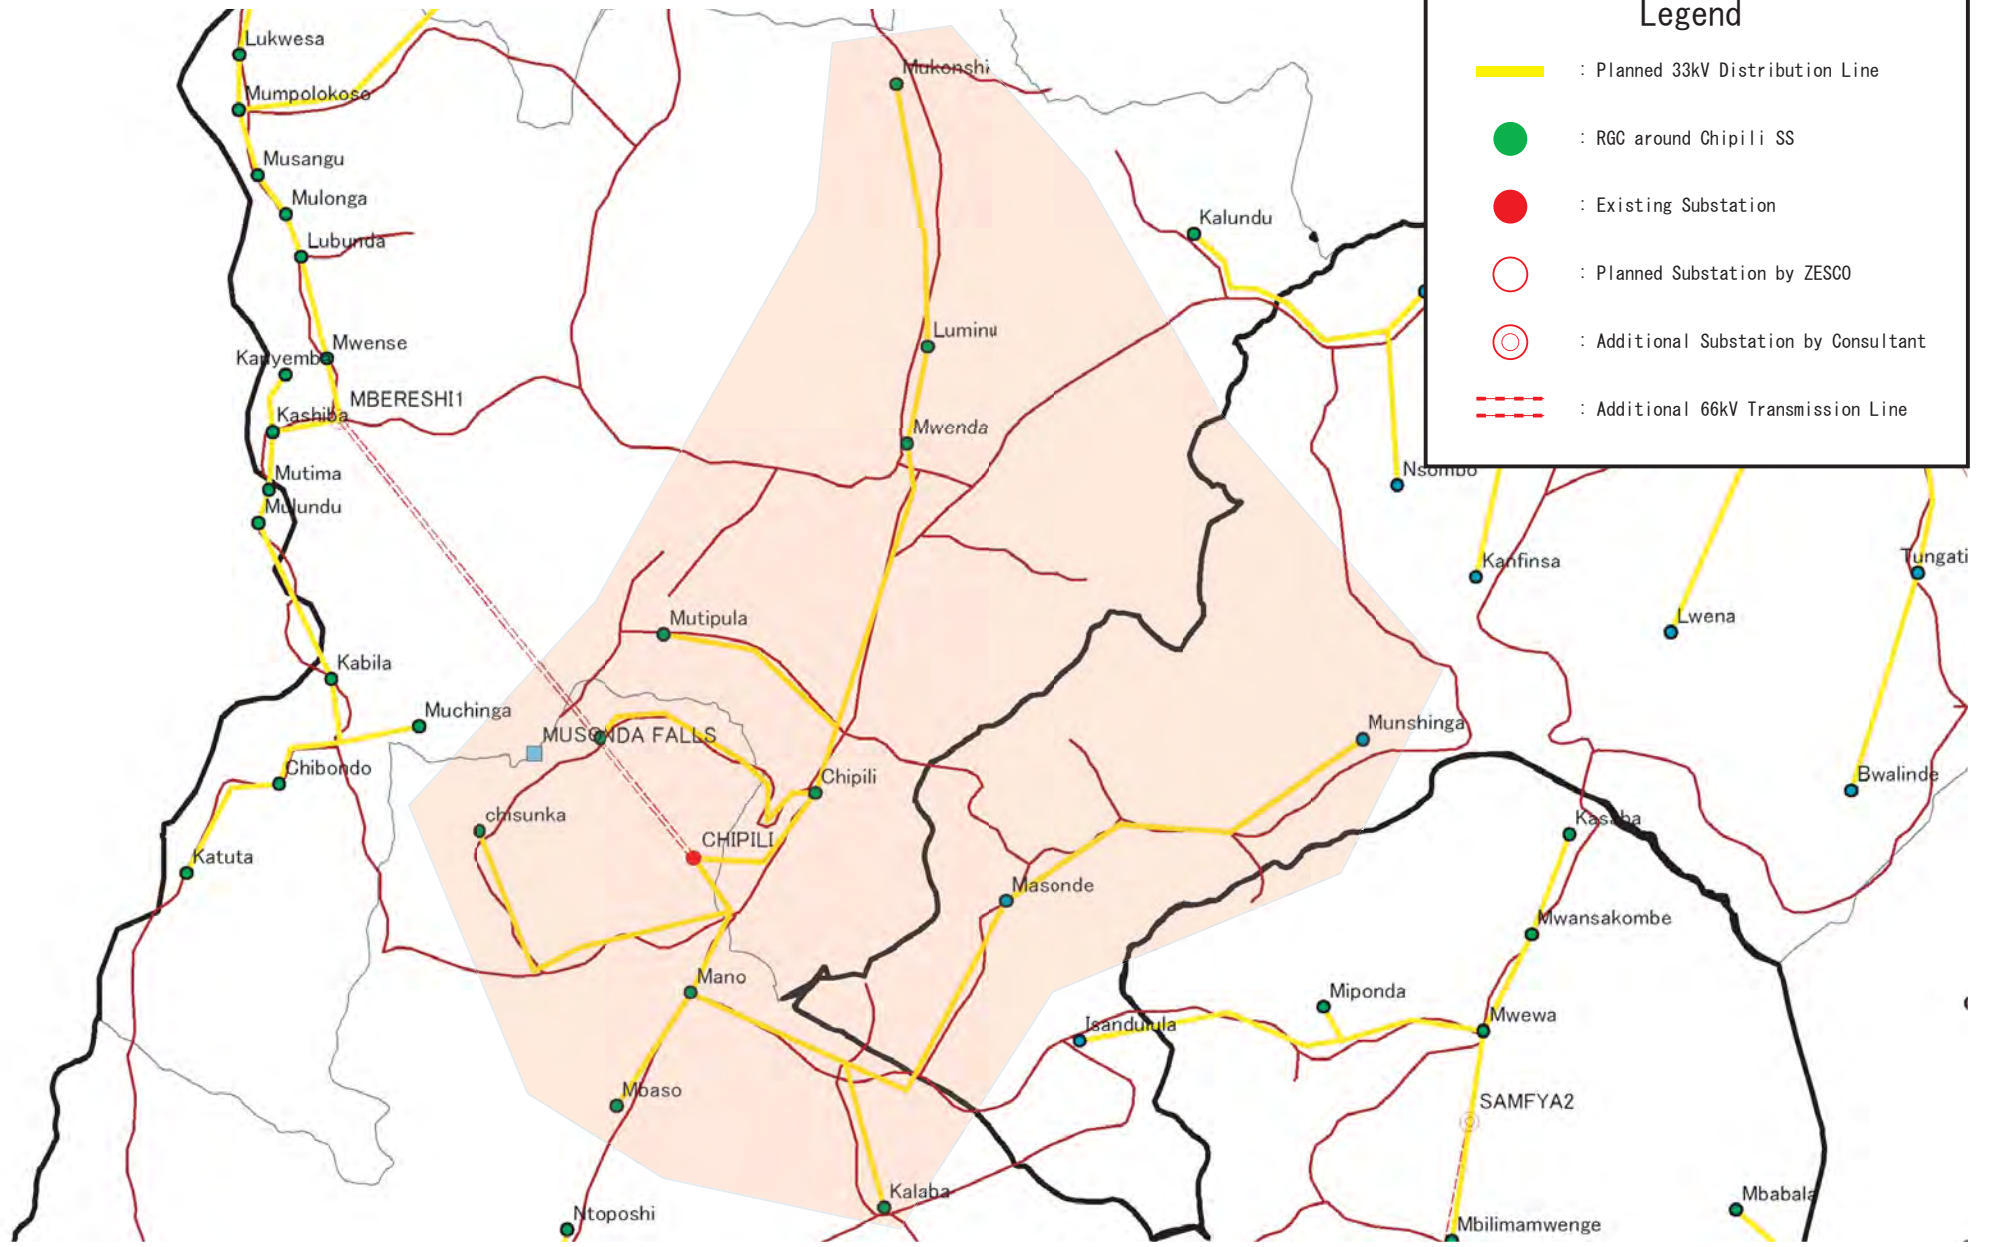
- : Planned 33kV Distribution Line
- : RGC around Chipata SS
- : Existing Substation
- : Planned Substation by ZESCO
- : Additional Substation by Consultant
- : Additional 66kV Transmission Line






Legend

- : Planned 33kV Distribution Line
- : RGC around Chipili SS
- : Existing Substation
- : Planned Substation by ZESCO
- : Additional Substation by Consultant
- : Additional 66kV Transmission Line

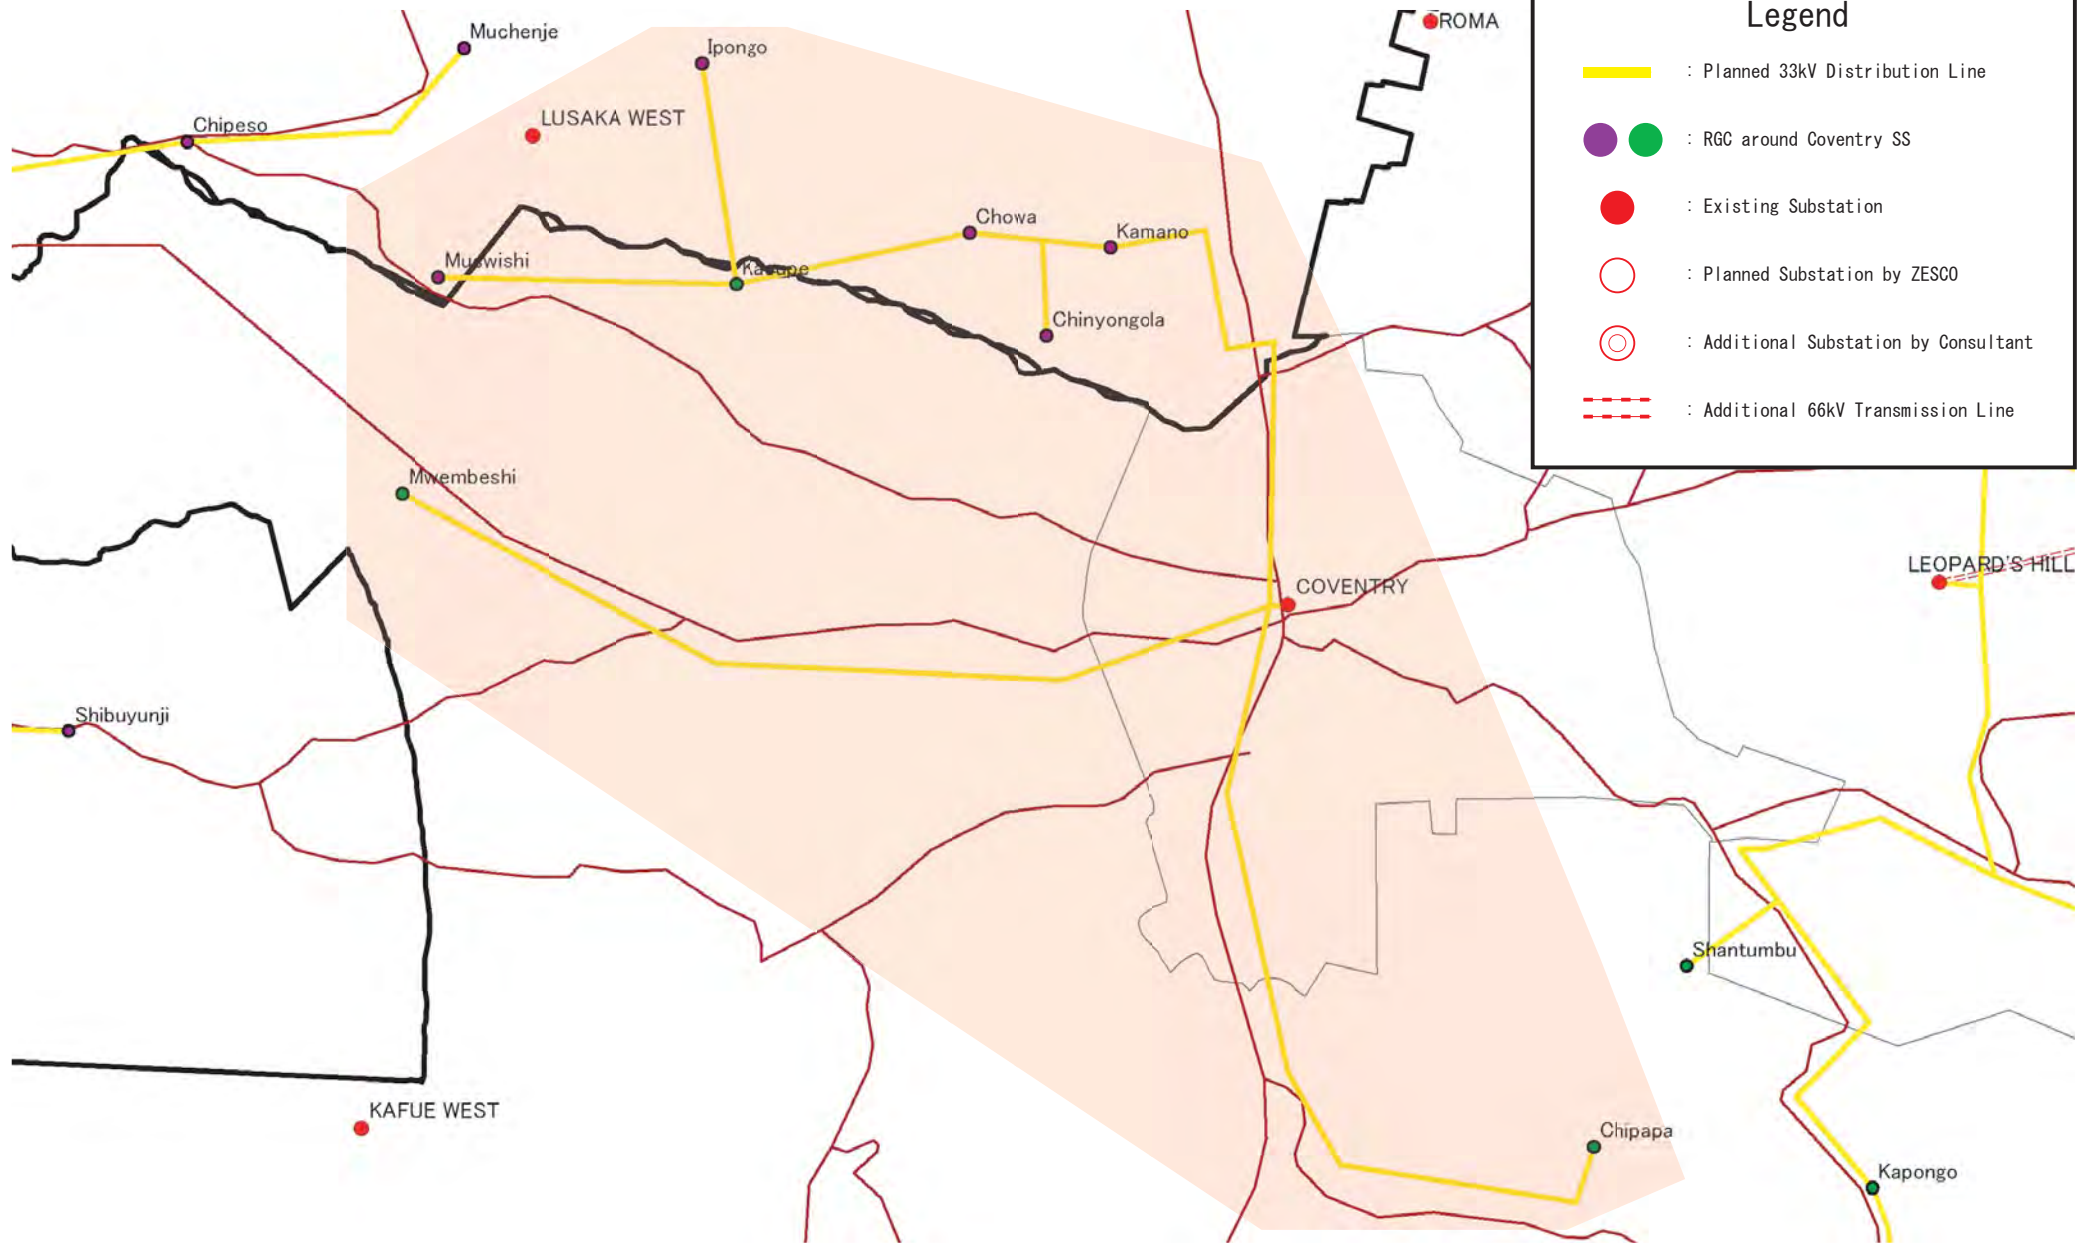 ZESCO	The Study for Development of the Rural Electrification Master Plan in Zambia	Drawing No.
	 Tokyo Electric Power Company	Title DL System at Chipili SS



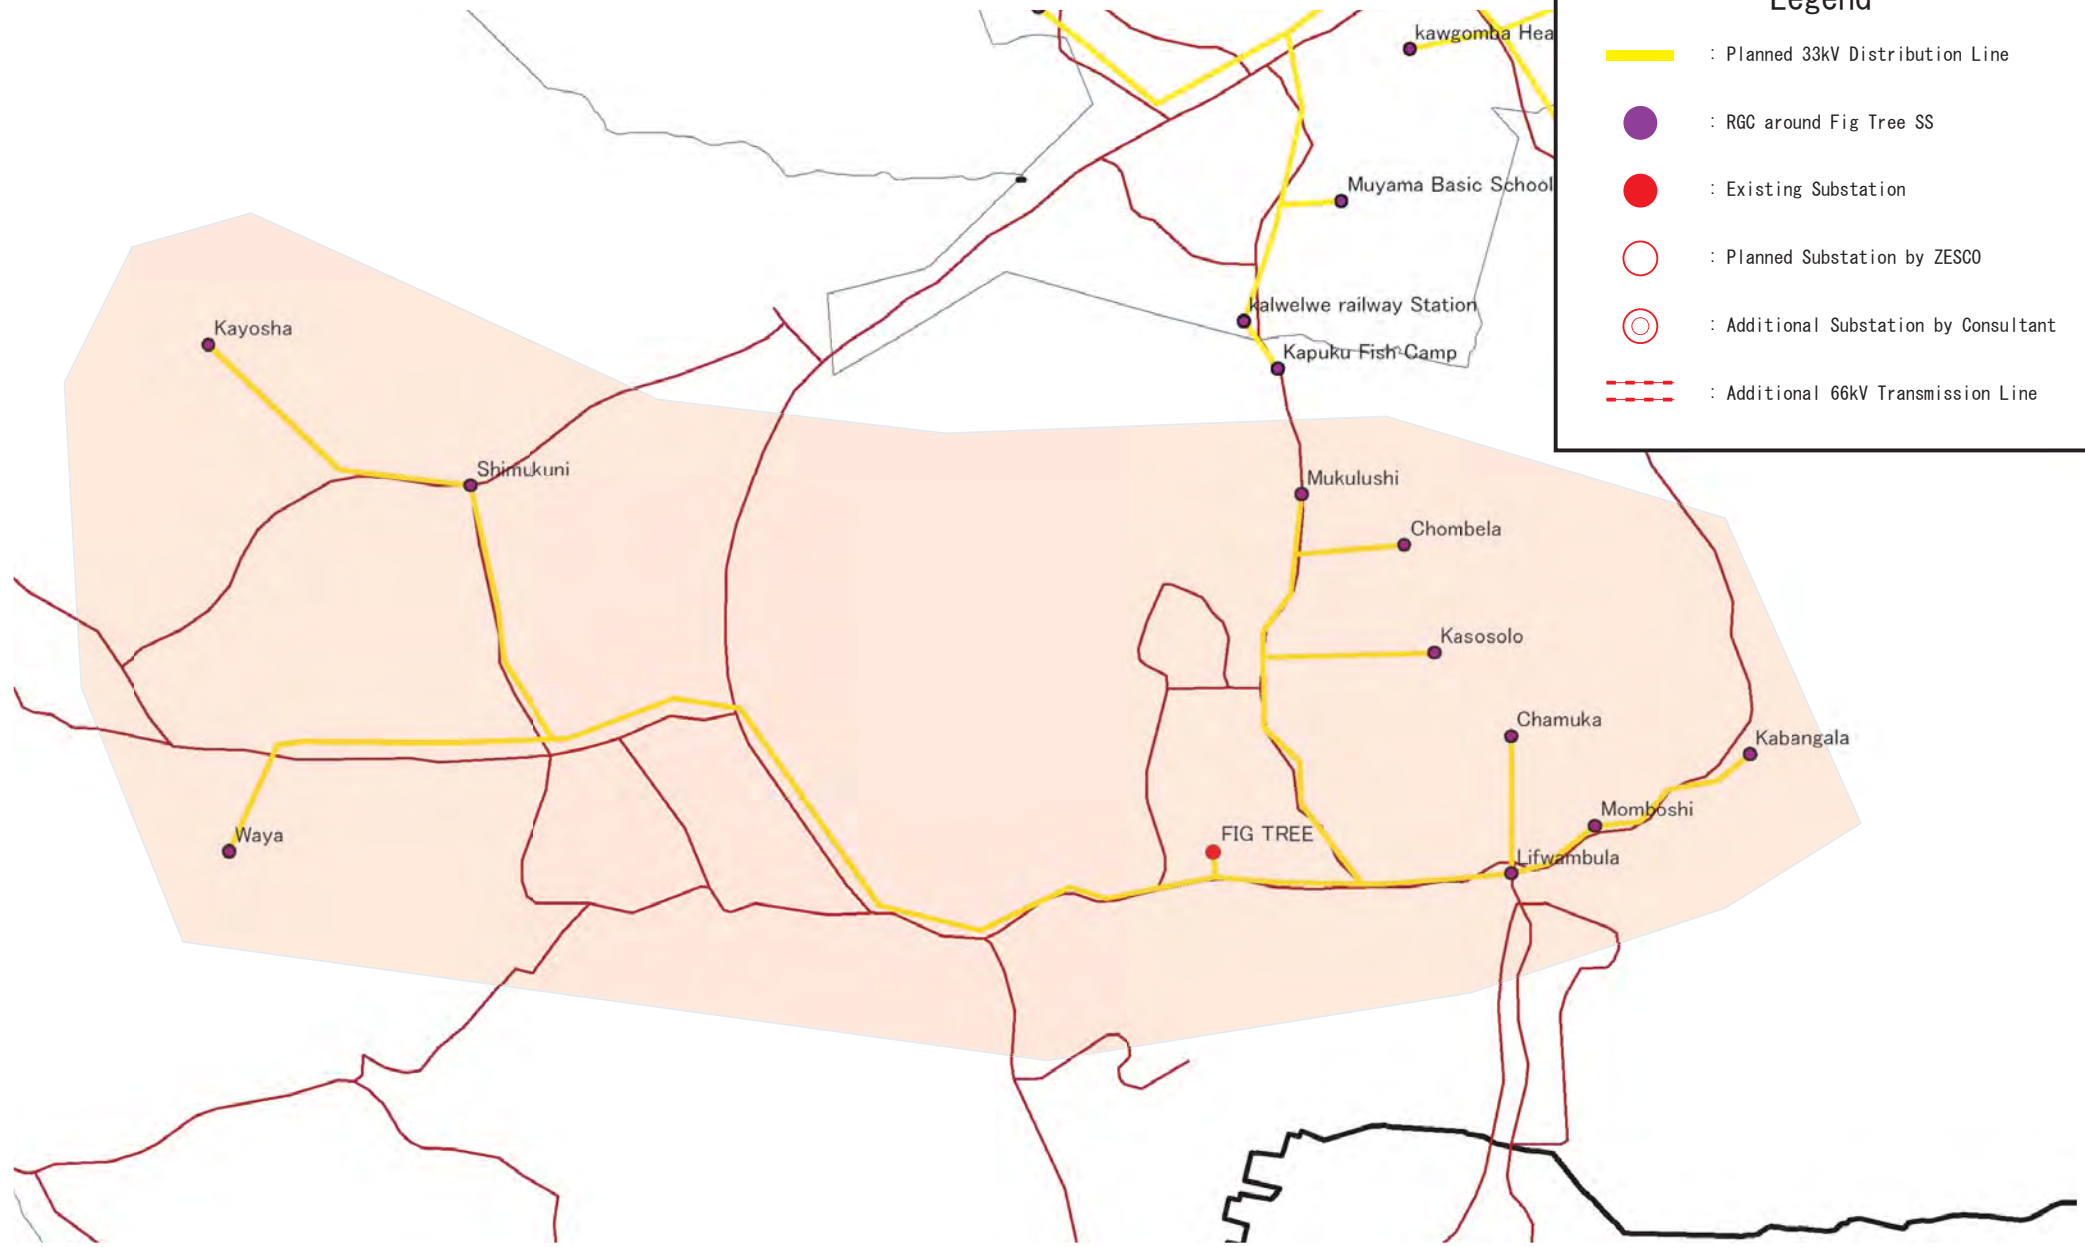


 ZESCO	The Study for Development of the Rural Electrification Master Plan in Zambia	Drawing No.
	 Tokyo Electric Power Company	Title DL System at Coventry SS





Legend

- : Planned 33kV Distribution Line
- : RGC around Fig Tree SS
- : Existing Substation
- : Planned Substation by ZESCO
- : Additional Substation by Consultant
- : Additional 66kV Transmission Line

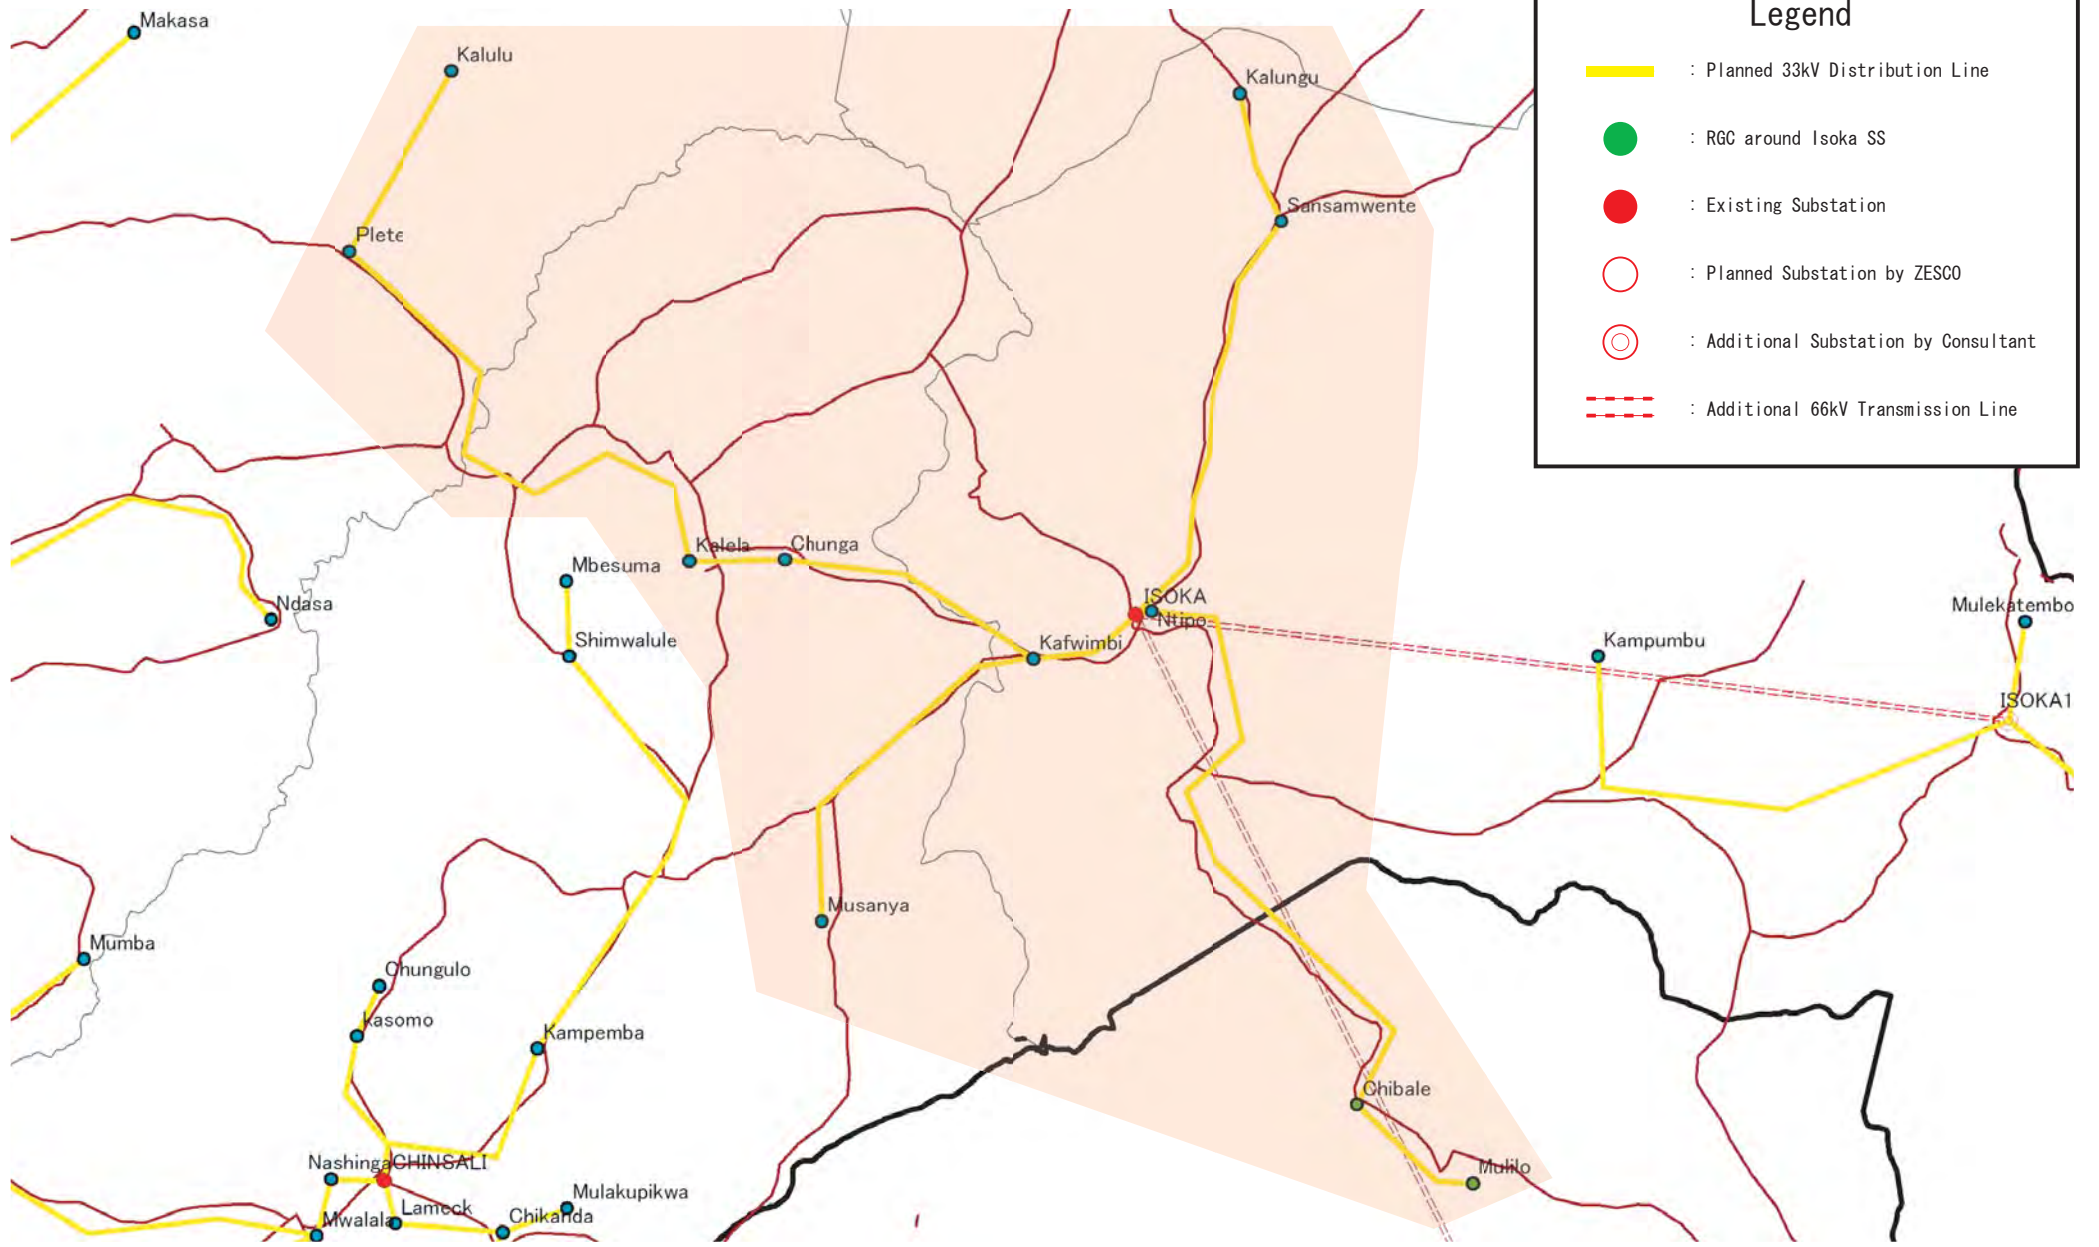 ZESCO	The Study for Development of the Rural Electrification Master Plan in Zambia	Drawing No.
	 Tokyo Electric Power Company	Title DL System at Fig Tree SS




 ZESCO	The Study for Development of the Rural Electrification Master Plan in Zambia	Drawing No.
	 Tokyo Electric Power Company	Title DL System at Isoka SS



Legend



- : Planned 33kV Distribution Line
- : RGC around Kabwe SS
- : Existing Substation
- : Planned Substation by ZESCO
- : Additional Substation by Consultant
- : Additional 66kV Transmission Line

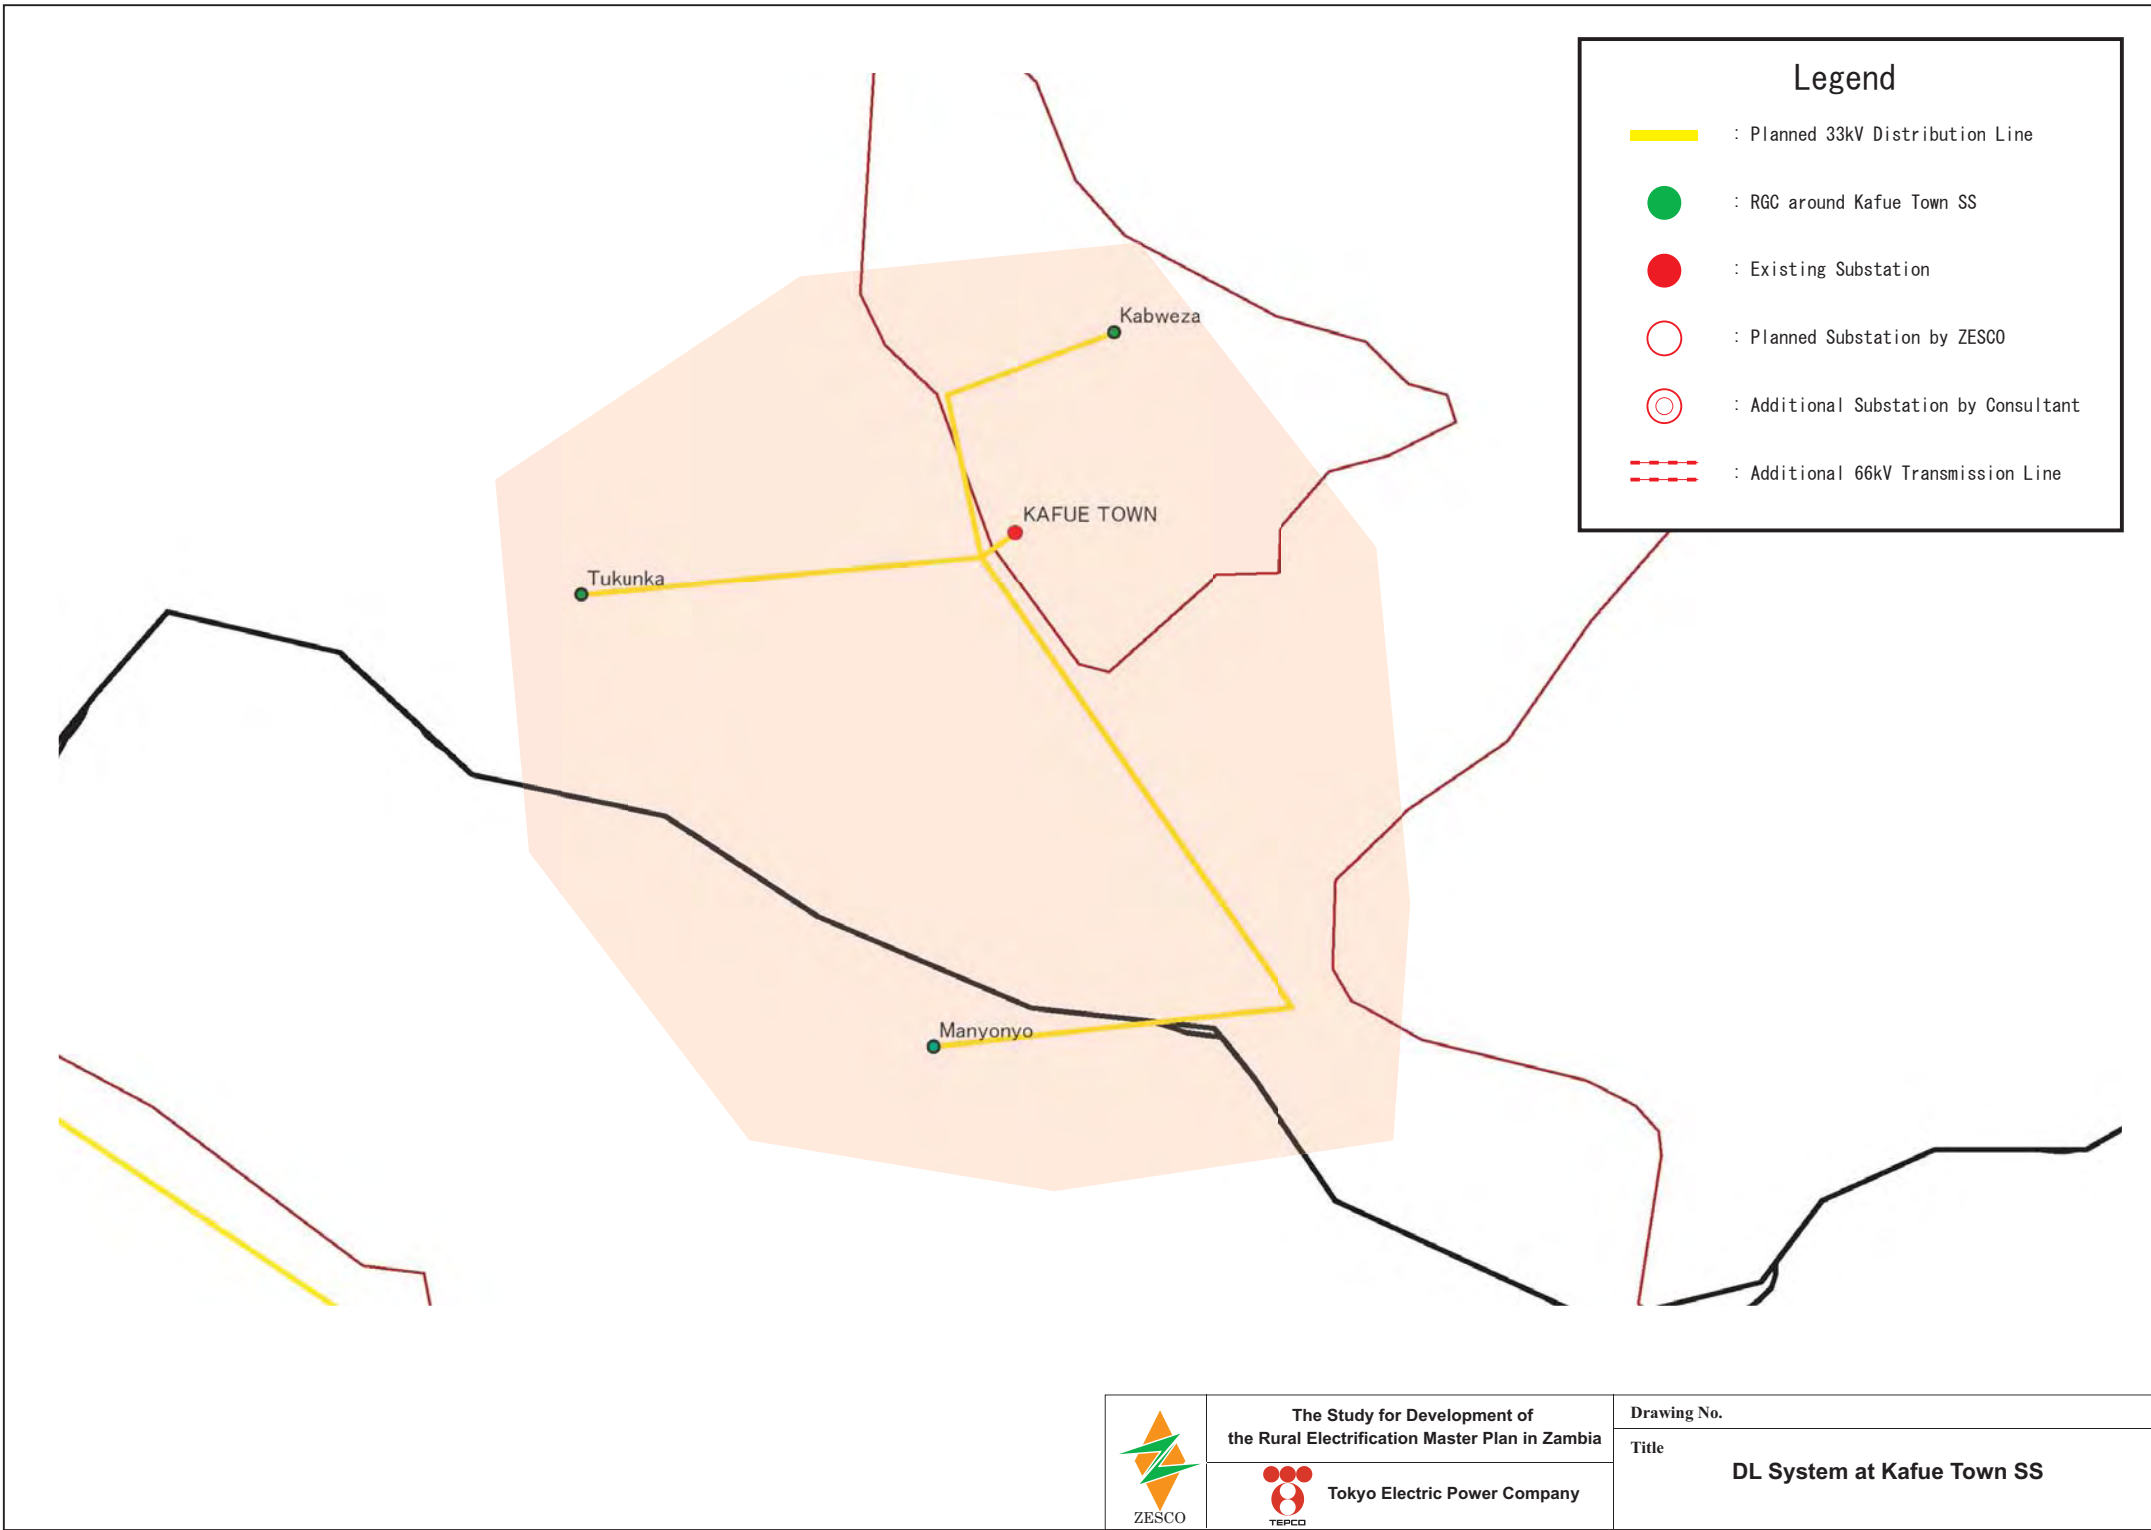
 ZESCO	The Study for Development of the Rural Electrification Master Plan in Zambia	Drawing No.
	 Tokyo Electric Power Company	Title DL System at Kabwe SS




Legend


- : Planned 33kV Distribution Line
- : RGC around Kafue Town SS
- : Existing Substation
- : Planned Substation by ZESCO
- : Additional Substation by Consultant
- : Additional 66kV Transmission Line

 ZESCO	The Study for Development of the Rural Electrification Master Plan in Zambia	Drawing No.
	 TEPCO	Tokyo Electric Power Company

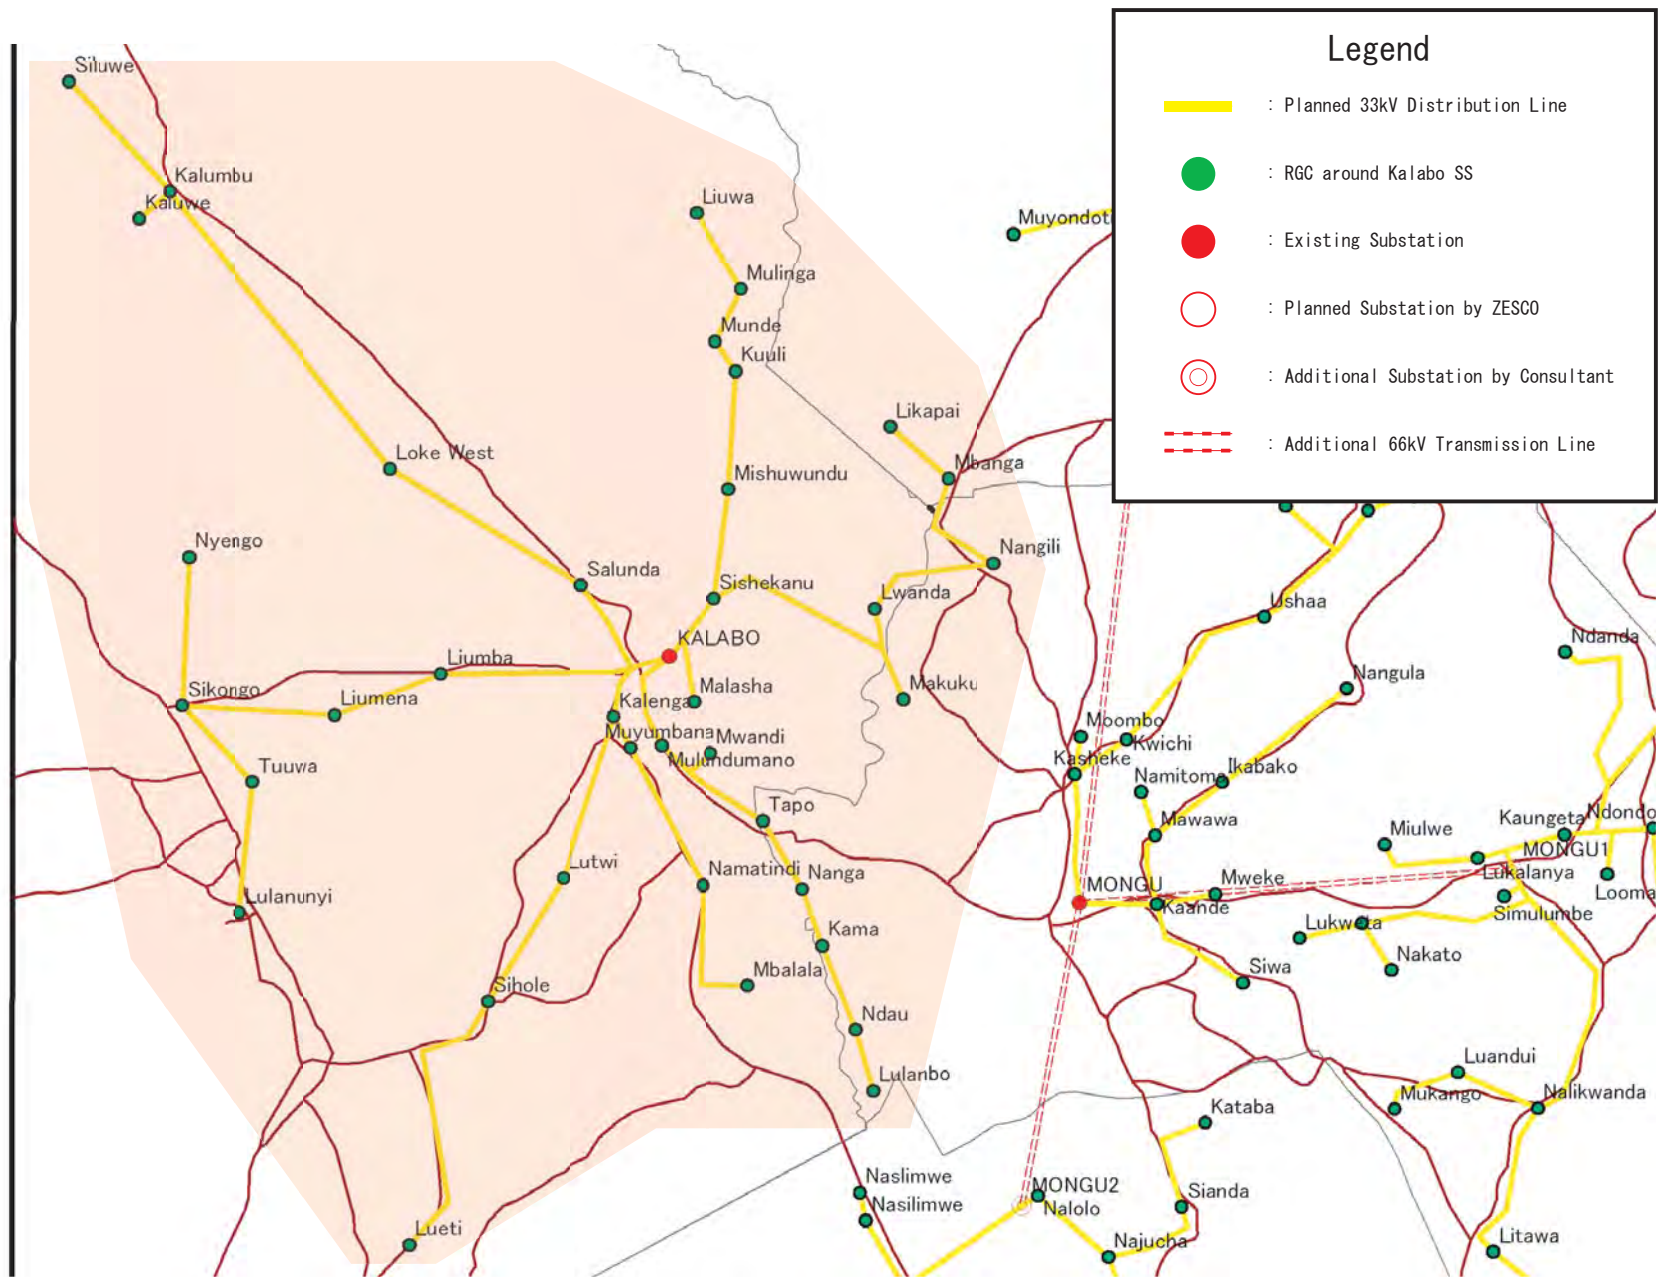


Legend


 : Planned 33kV Distribution Line

 : RGC around Kansunswa SS



 : Existing Substation


 : Planned Substation by ZESCO

 : Additional Substation by Consultant

 : Additional 66kV Transmission Line



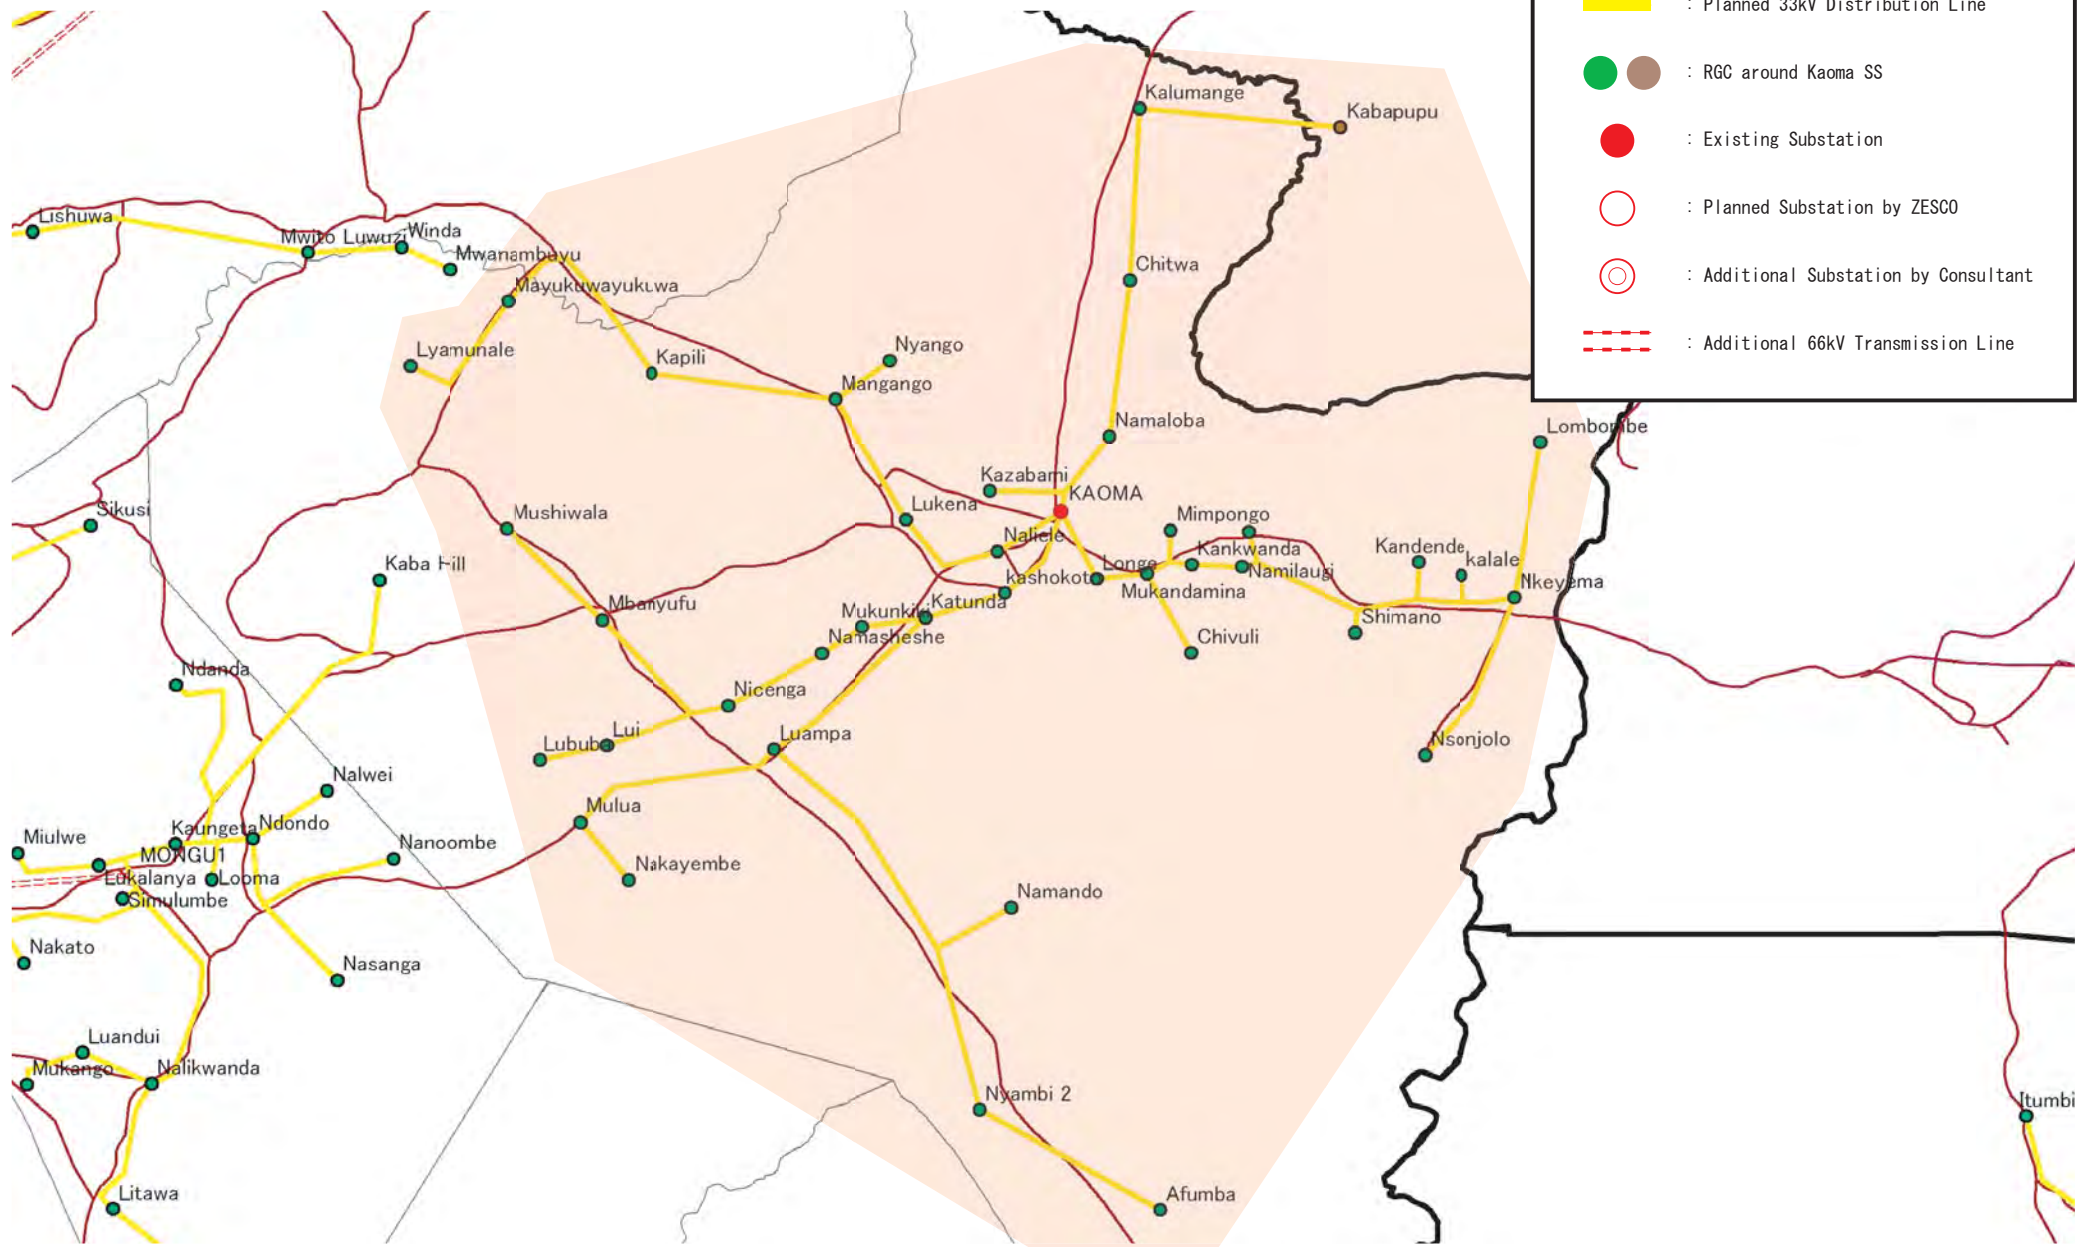


 ZESCO	The Study for Development of the Rural Electrification Master Plan in Zambia	Drawing No.
	 Tokyo Electric Power Company	Title DL System at Kansunswa SS



Legend



- : Planned 33kV Distribution Line
- : RGC around Kaoma SS
- : Existing Substation
- : Planned Substation by ZESCO
- : Additional Substation by Consultant
- : Additional 66kV Transmission Line

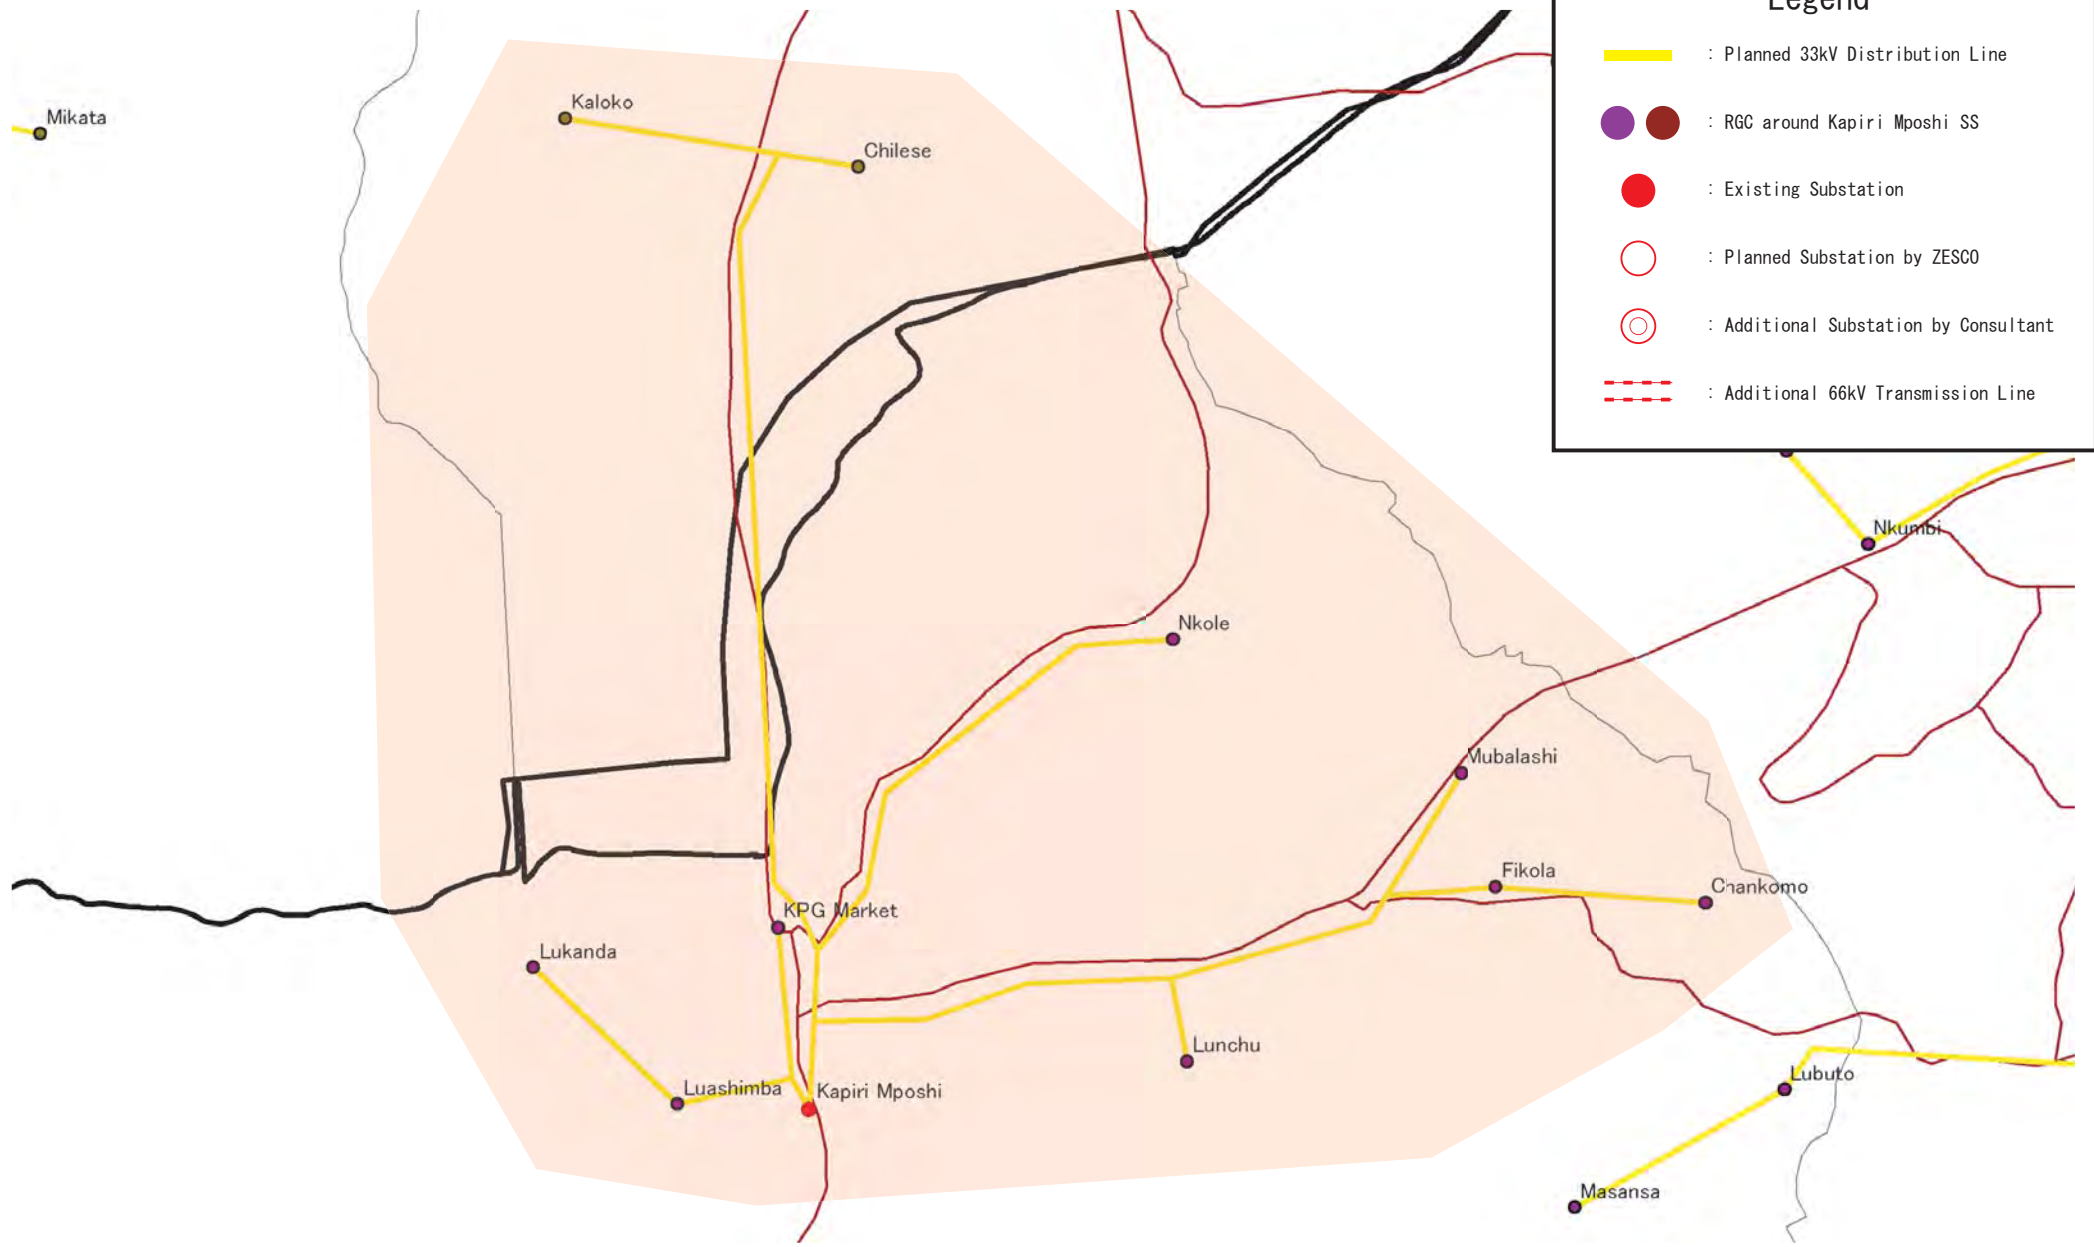 ZESCO	The Study for Development of the Rural Electrification Master Plan in Zambia	Drawing No.
	 Tokyo Electric Power Company	Title DL System at Kaoma SS










Legend



- : Planned 33kV Distribution Line
- : RGC around Kapiri Mposhi SS
- : Existing Substation
- : Planned Substation by ZESCO
- : Additional Substation by Consultant
- : Additional 66kV Transmission Line

 ZESCO	The Study for Development of the Rural Electrification Master Plan in Zambia	Drawing No.
	 Tokyo Electric Power Company	Title DL System at Kapiri Mposhi SS


Legend

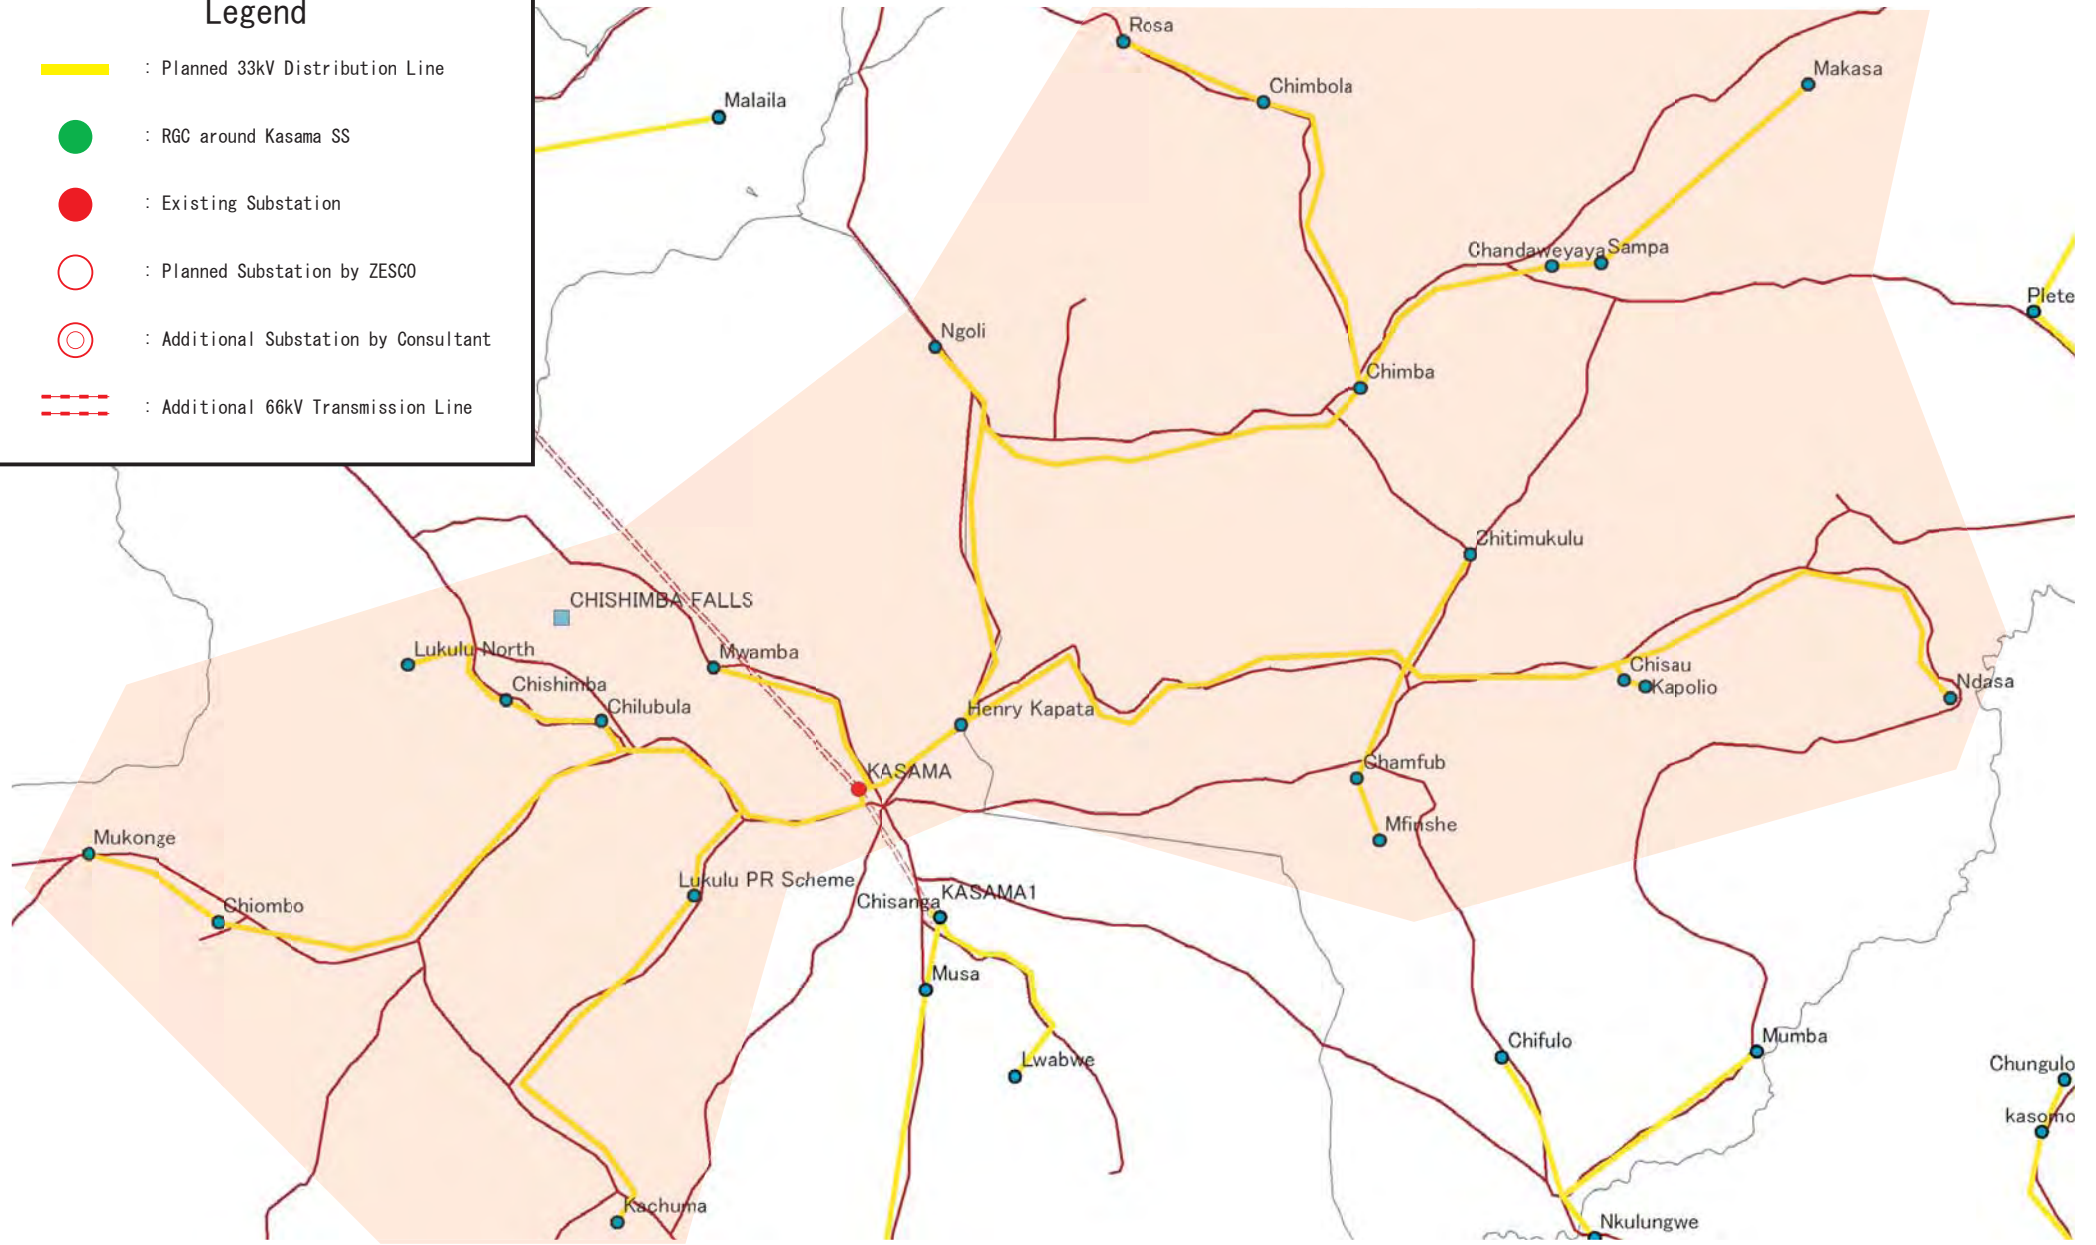
-  : Planned 33kV Distribution Line
-  : RGC around Kasama SS
-  : Existing Substation
-  : Planned Substation by ZESCO
-  : Additional Substation by Consultant
-  : Additional 66kV Transmission Line




 ZESCO	The Study for Development of the Rural Electrification Master Plan in Zambia	Drawing No.
	 Tokyo Electric Power Company	Title DL System at Kasama SS

Legend


 : Planned 33kV Distribution Line


 : RGC around Kasempa SS



 : Existing Substation


 : Planned Substation by ZESCO

 : Additional Substation by Consultant

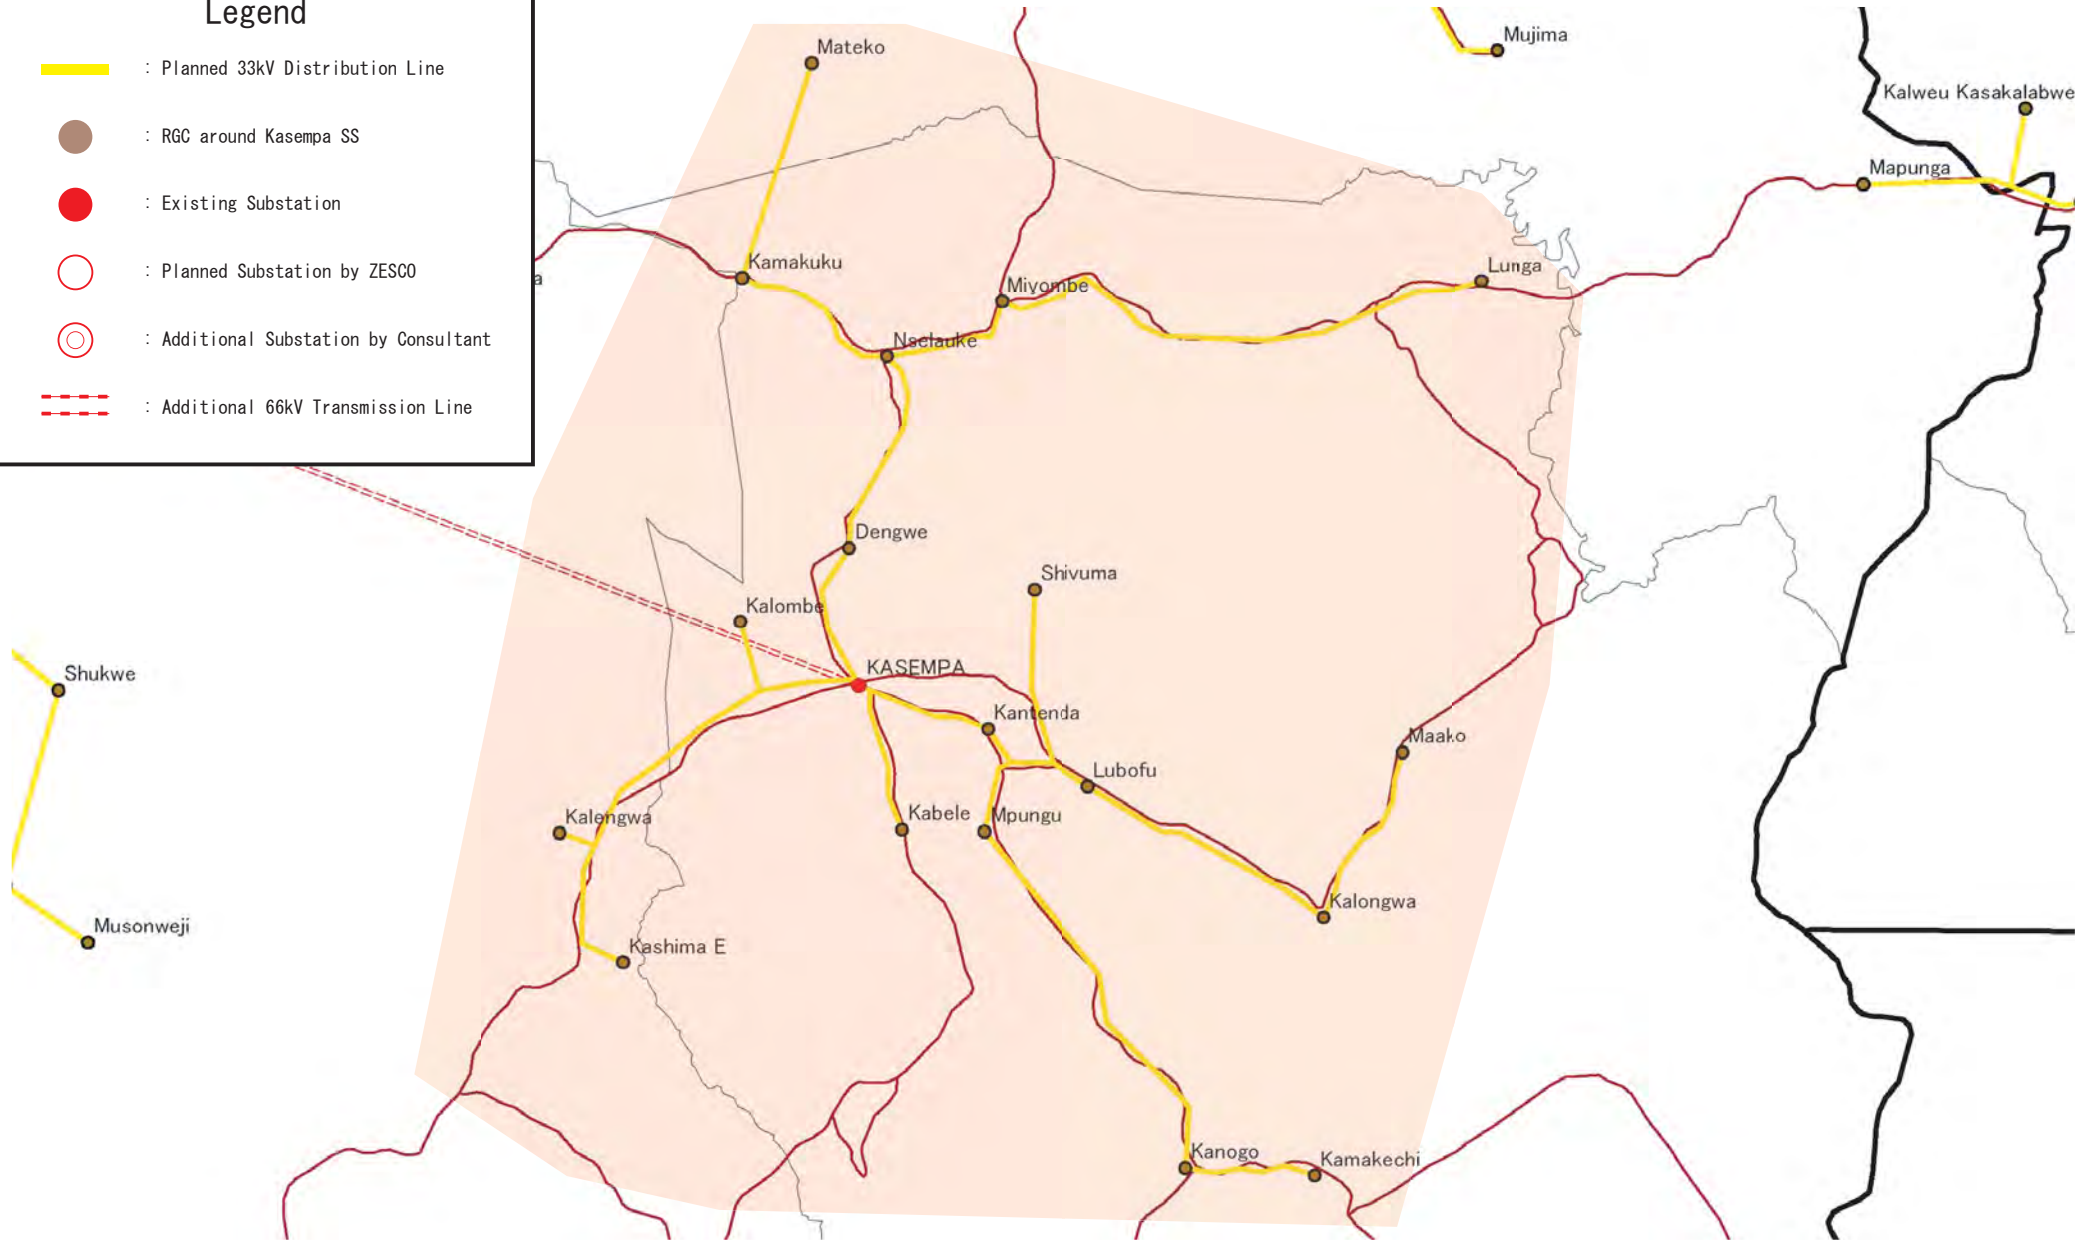 : Additional 66kV Transmission Line



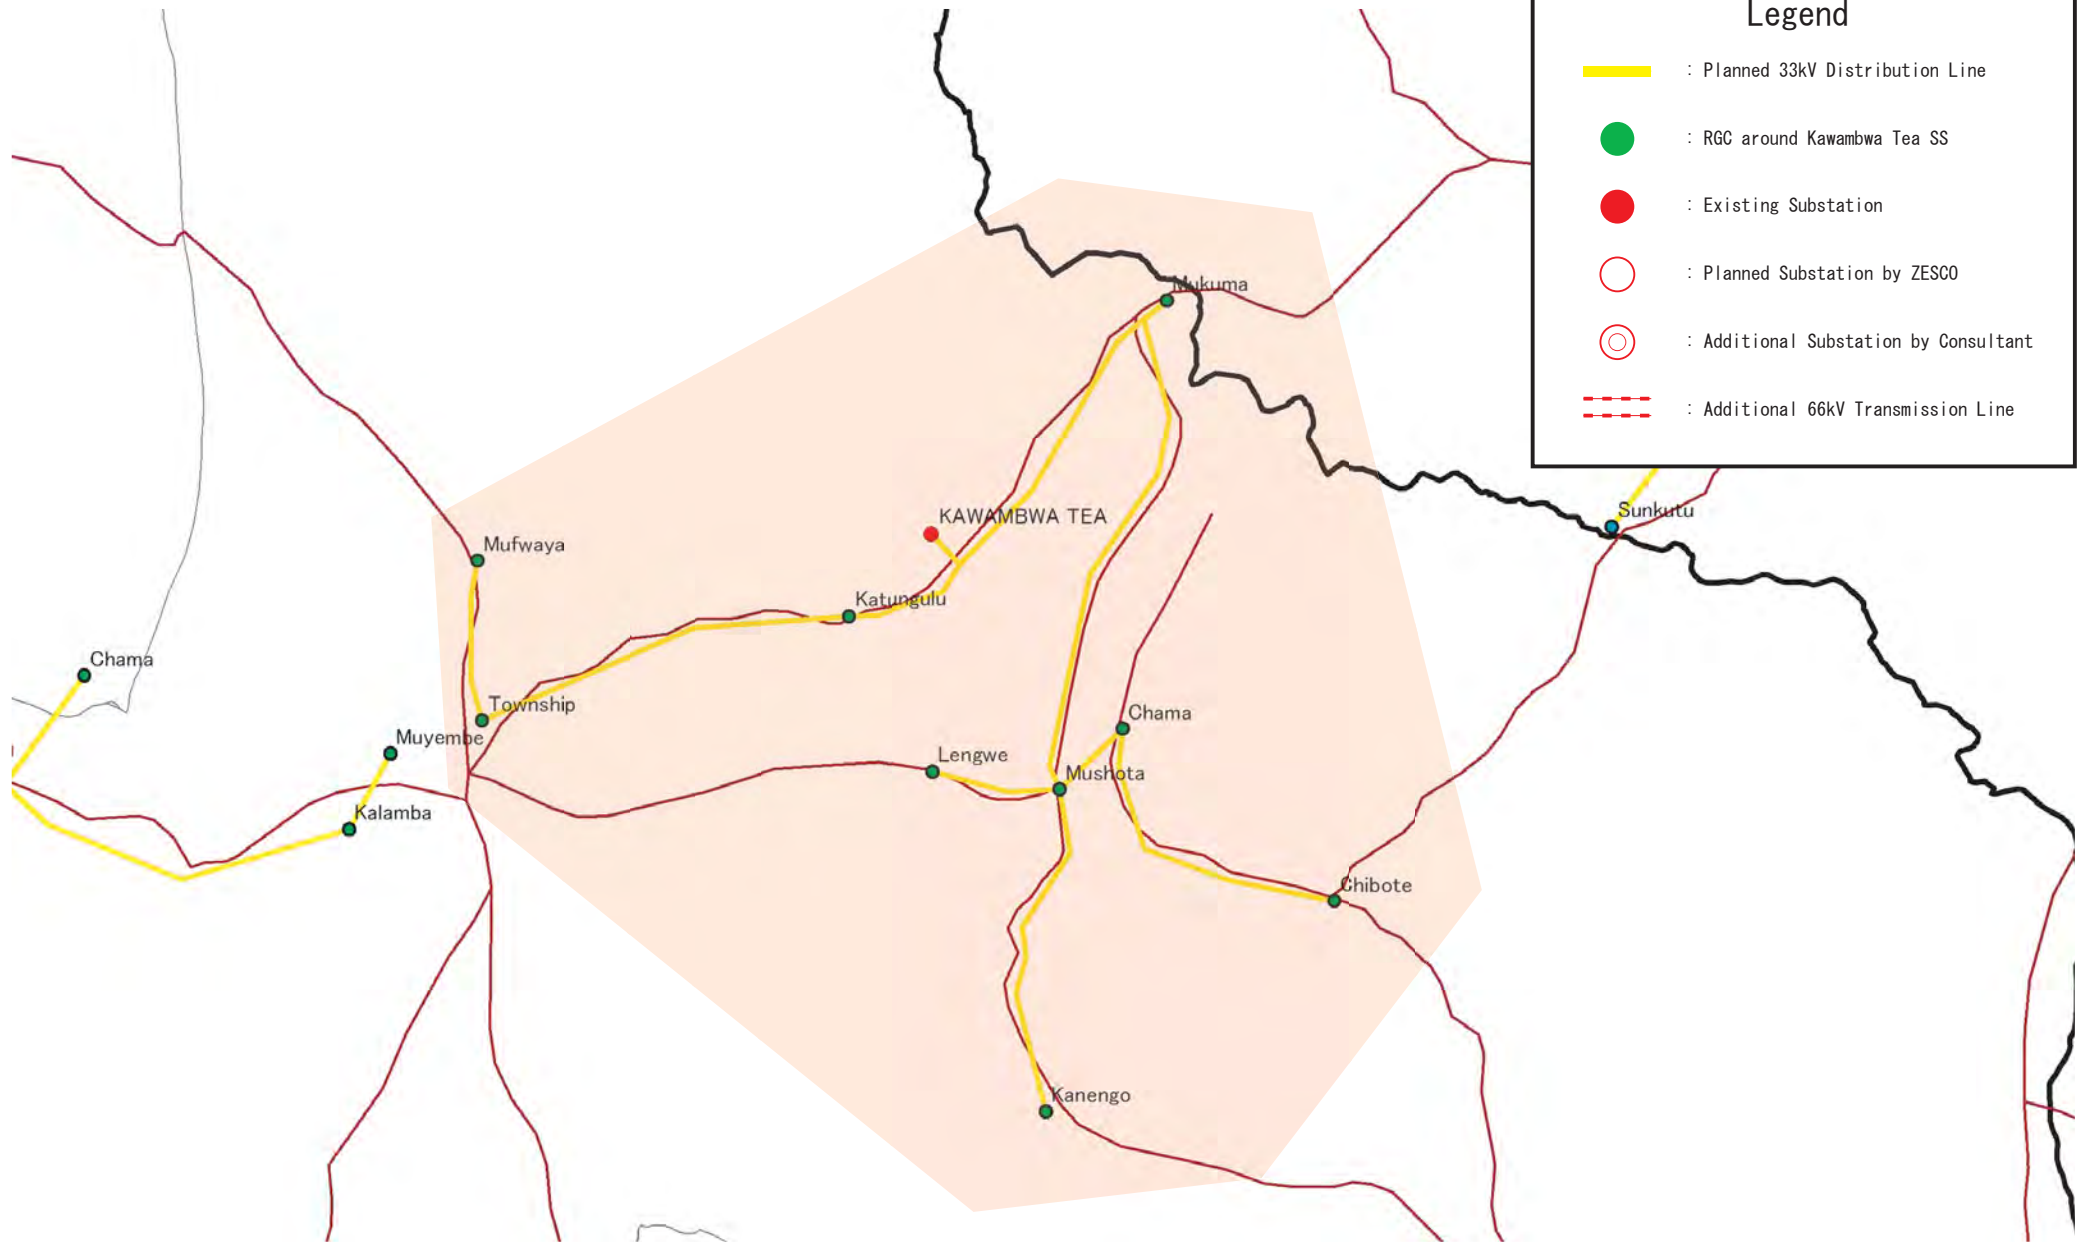

	The Study for Development of the Rural Electrification Master Plan in Zambia	Drawing No.
	 Tokyo Electric Power Company	Title DL System at Kasempa SS





Legend

- : Planned 33kV Distribution Line
- : RGC around Kawambwa Tea SS
- : Existing Substation
- : Planned Substation by ZESCO
- : Additional Substation by Consultant
- : Additional 66kV Transmission Line


 ZESCO	The Study for Development of the Rural Electrification Master Plan in Zambia	Drawing No.
	 TEPCO	Tokyo Electric Power Company


Legend


 : Planned 33kV Distribution Line


 : RGC around Kitwe SS



 : Existing Substation


 : Planned Substation by ZESCO

 : Additional Substation by Consultant

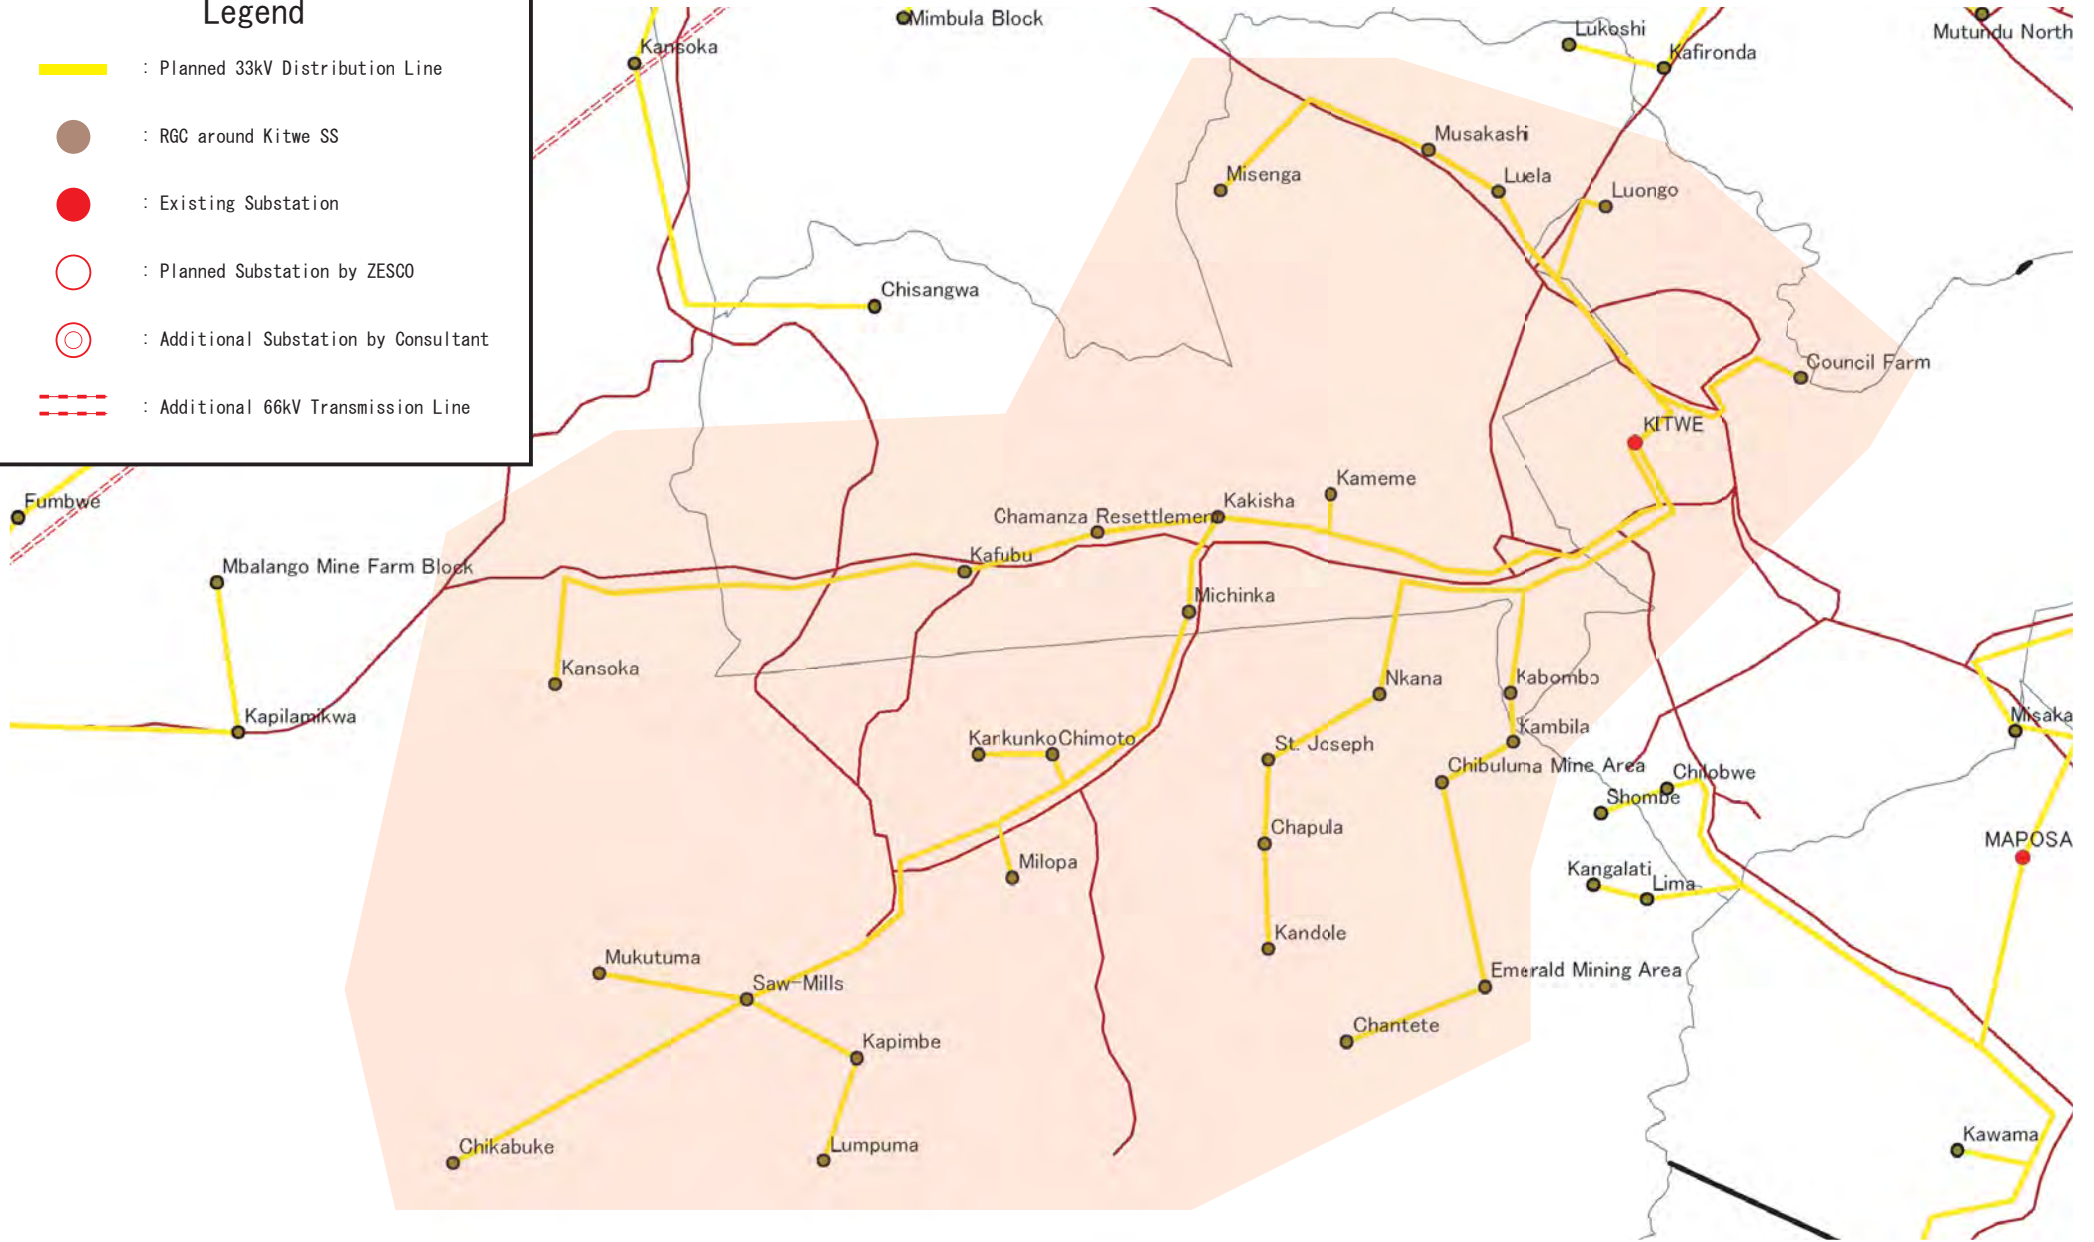 : Additional 66kV Transmission Line




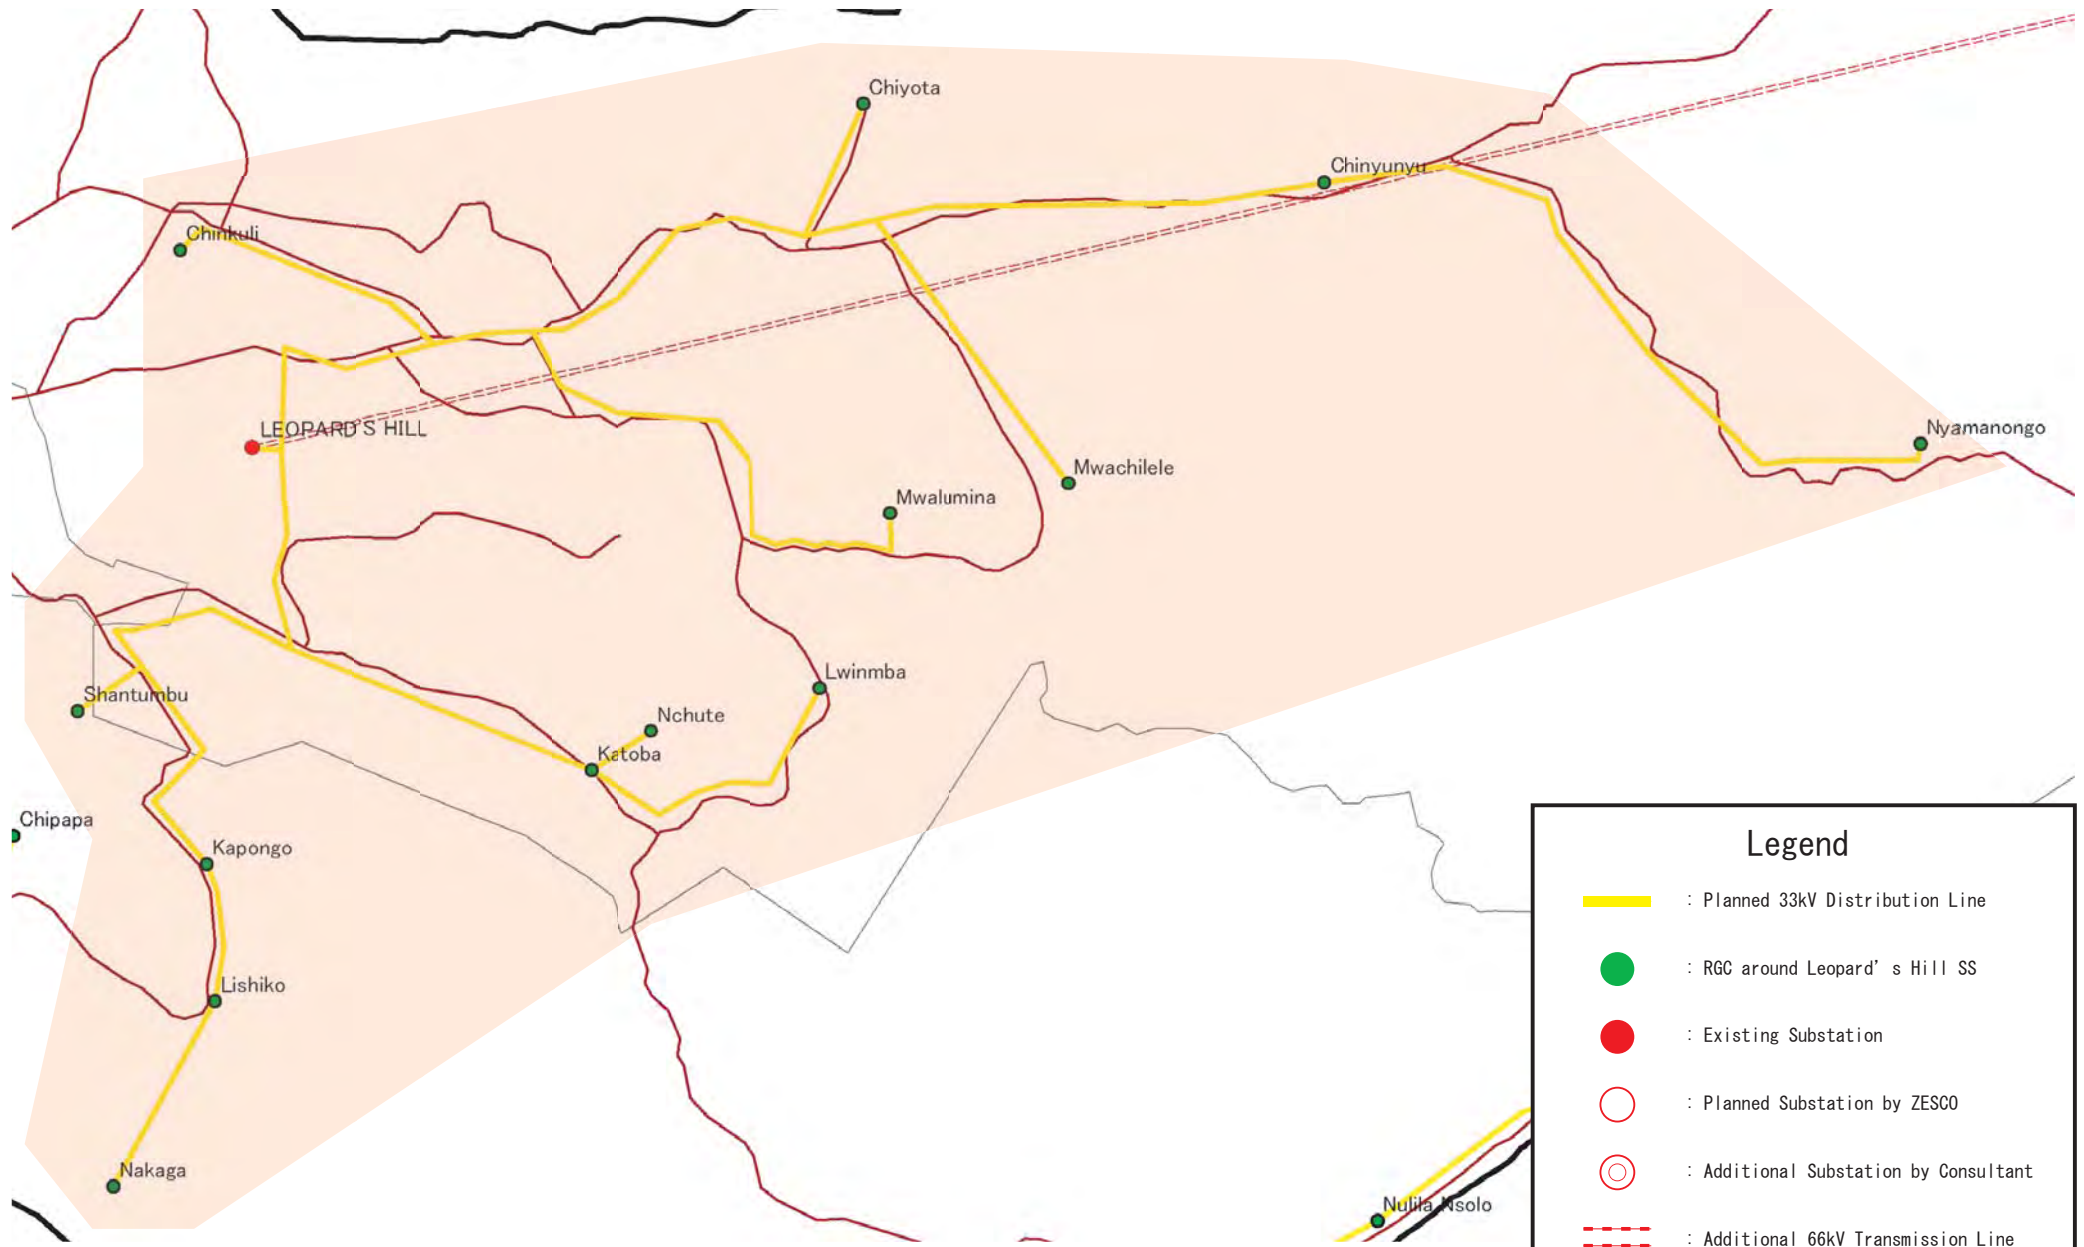

	<p>The Study for Development of the Rural Electrification Master Plan in Zambia</p>	Drawing No.
	 Tokyo Electric Power Company	Title
		DL System at Kitwe SS



Legend

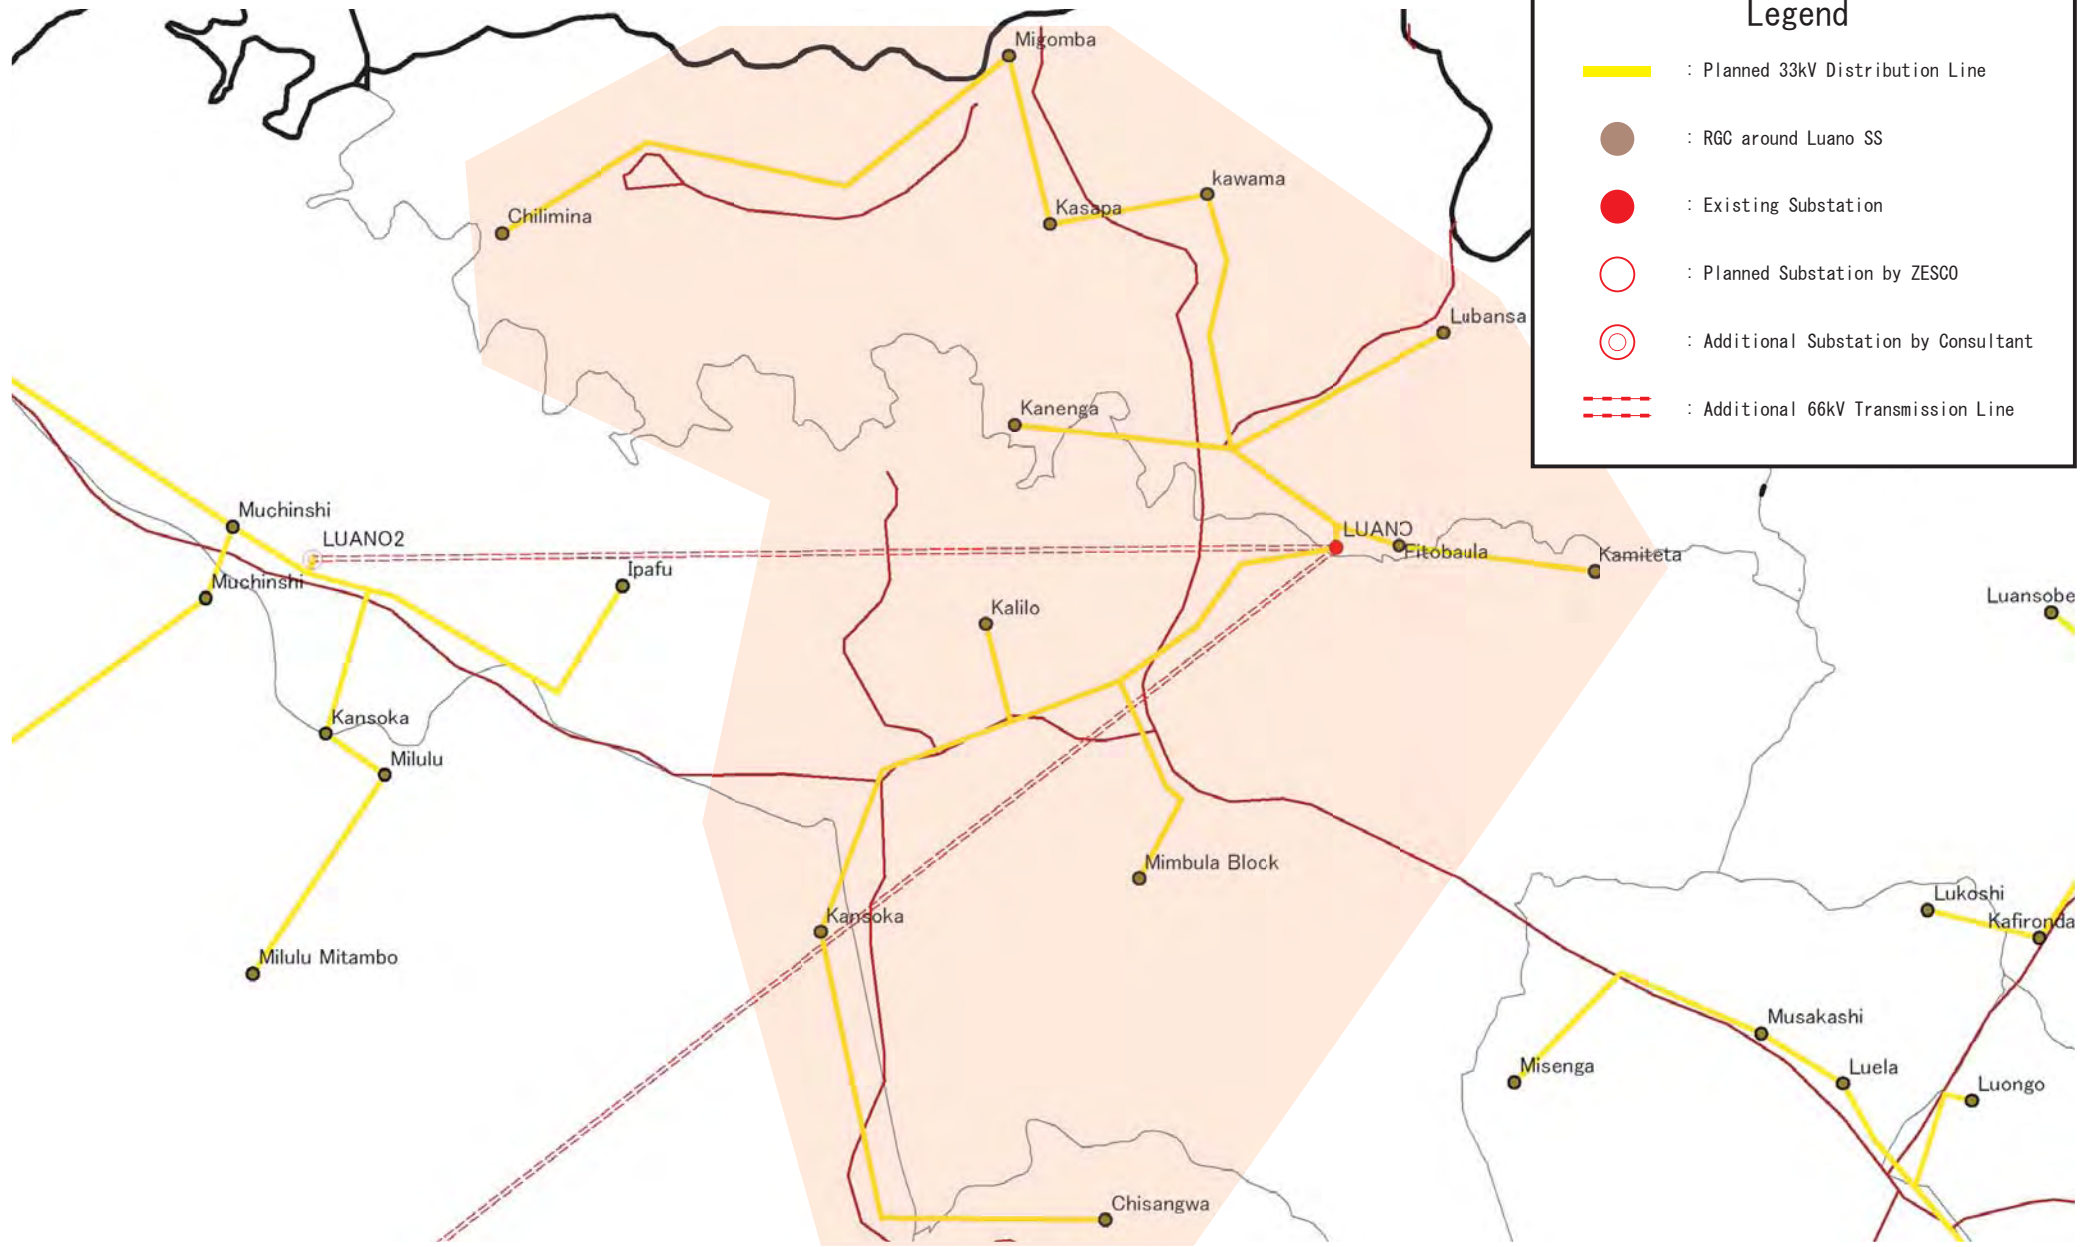
- : Planned 33kV Distribution Line
- : RGC around Leopard' s Hill SS
- : Existing Substation
- : Planned Substation by ZESCO
- : Additional Substation by Consultant
- : Additional 66kV Transmission Line




 ZESCO	The Study for Development of the Rural Electrification Master Plan in Zambia	Drawing No.
	 Tokyo Electric Power Company	Title
		DL System at Luano SS

Legend


 : Planned 33kV Distribution Line


 : RGC around Lundazi SS

 : Existing Substation

 : Planned Substation by ZESCO

 : Additional Substation by Consultant

 : Additional 66kV Transmission Line

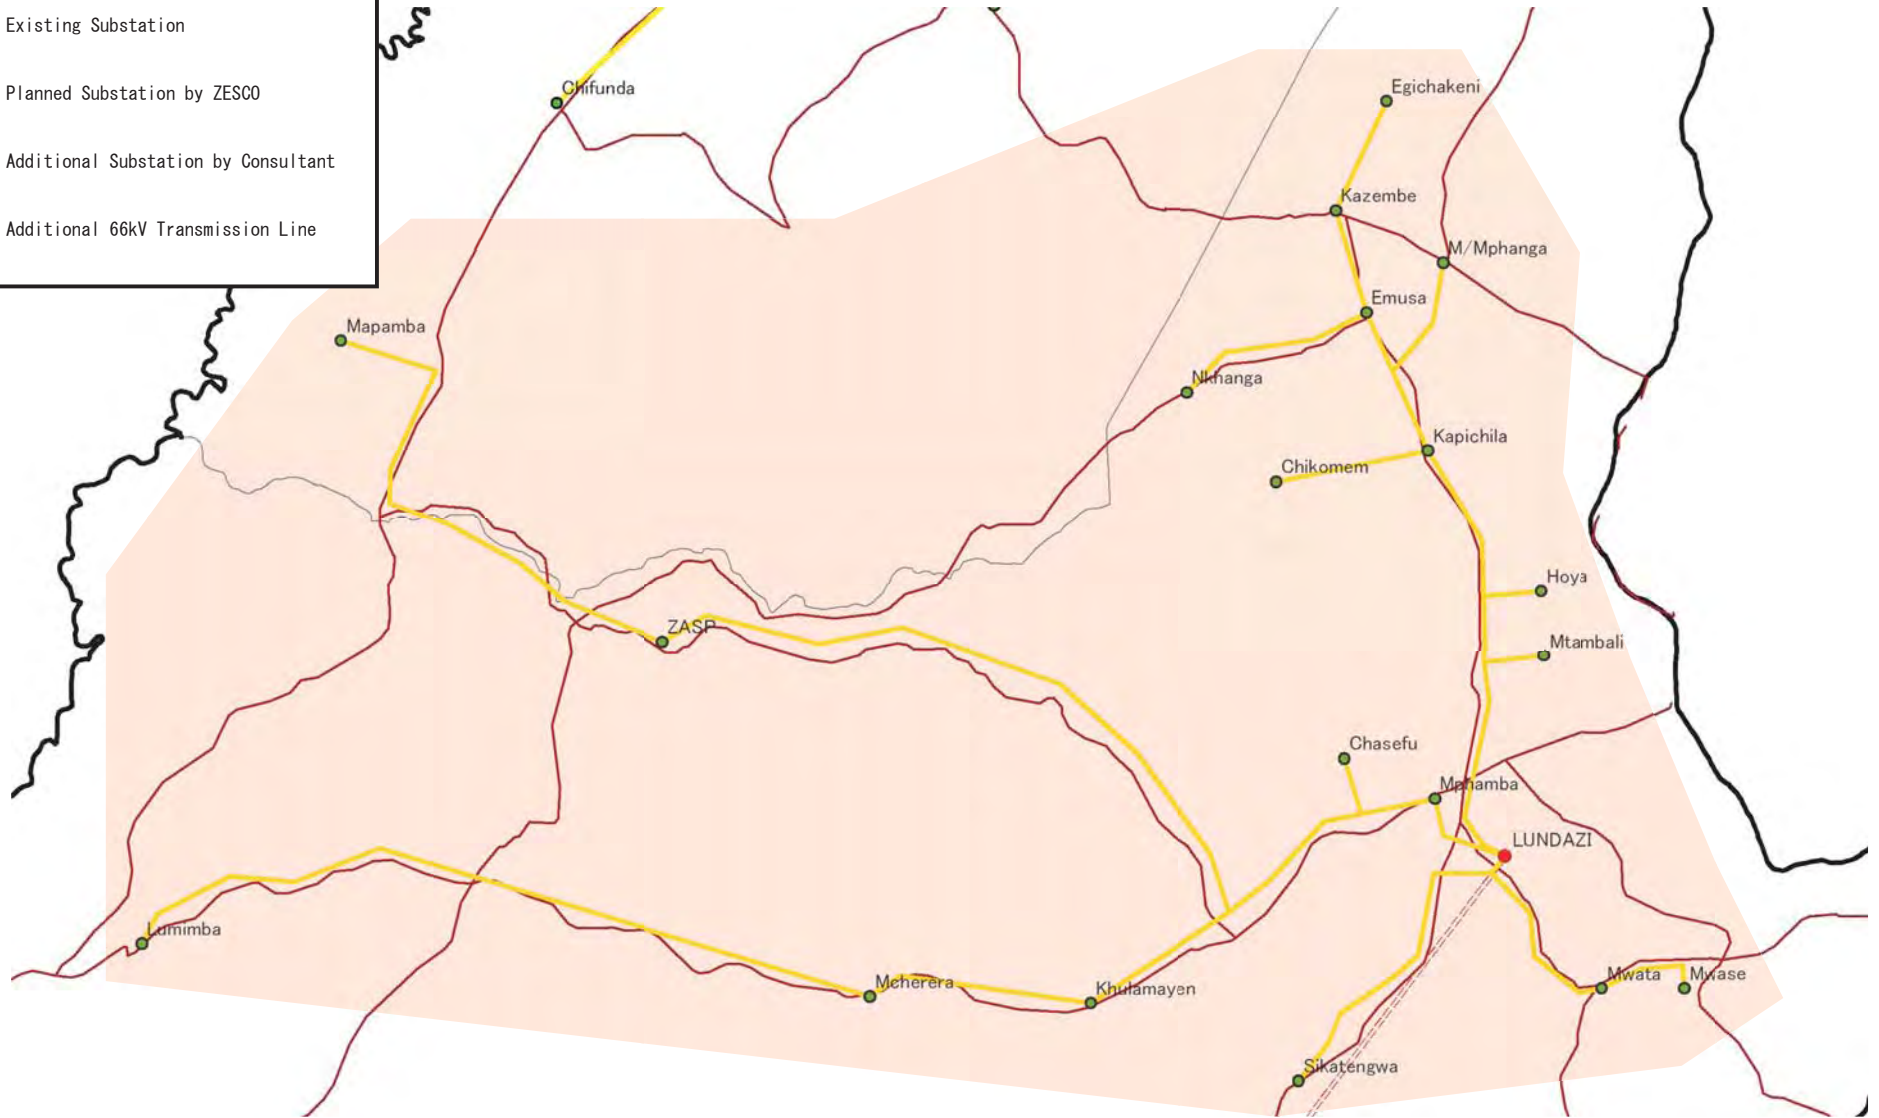

The Study for Development of
the Rural Electrification Master Plan in Zambia




Tokyo Electric Power Company

Drawing No.



Title

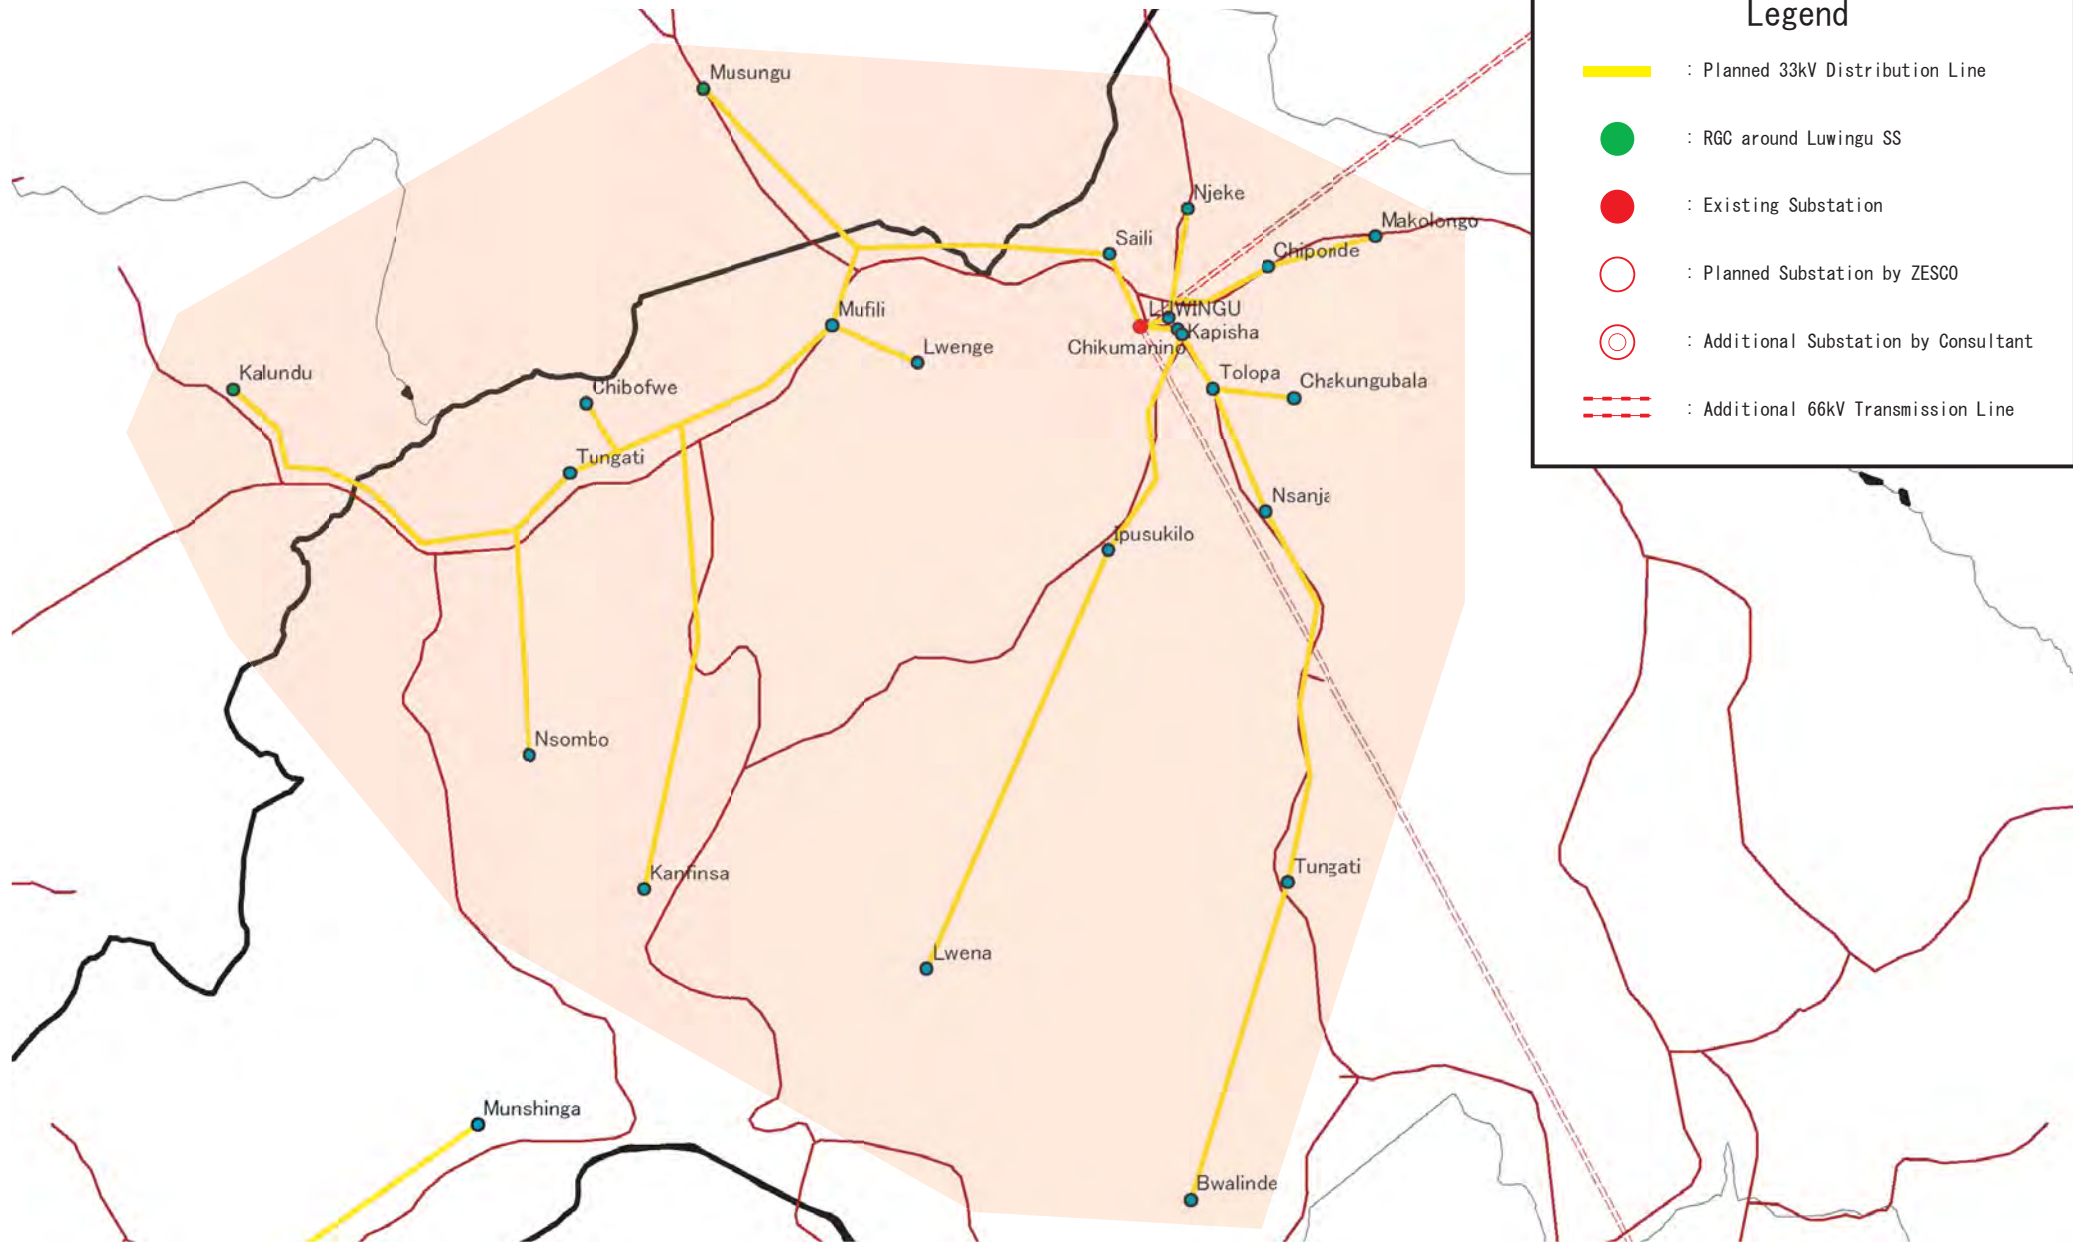DL System at Lundazi SS




Legend

- : Planned 33kV Distribution Line
- : RGC around Luwingu SS
- : Existing Substation
- : Planned Substation by ZESCO
- : Additional Substation by Consultant
- : Additional 66kV Transmission Line


 ZESCO	The Study for Development of the Rural Electrification Master Plan in Zambia	Drawing No.
	 Tokyo Electric Power Company	Title DL System at Luwingu SS

Legend

 : Planned 33kV Distribution Line


 : RGC around Maamba SS

 : Existing Substation

 : Planned Substation by ZESCO

 : Additional Substation by Consultant

 : Additional 66kV Transmission Line

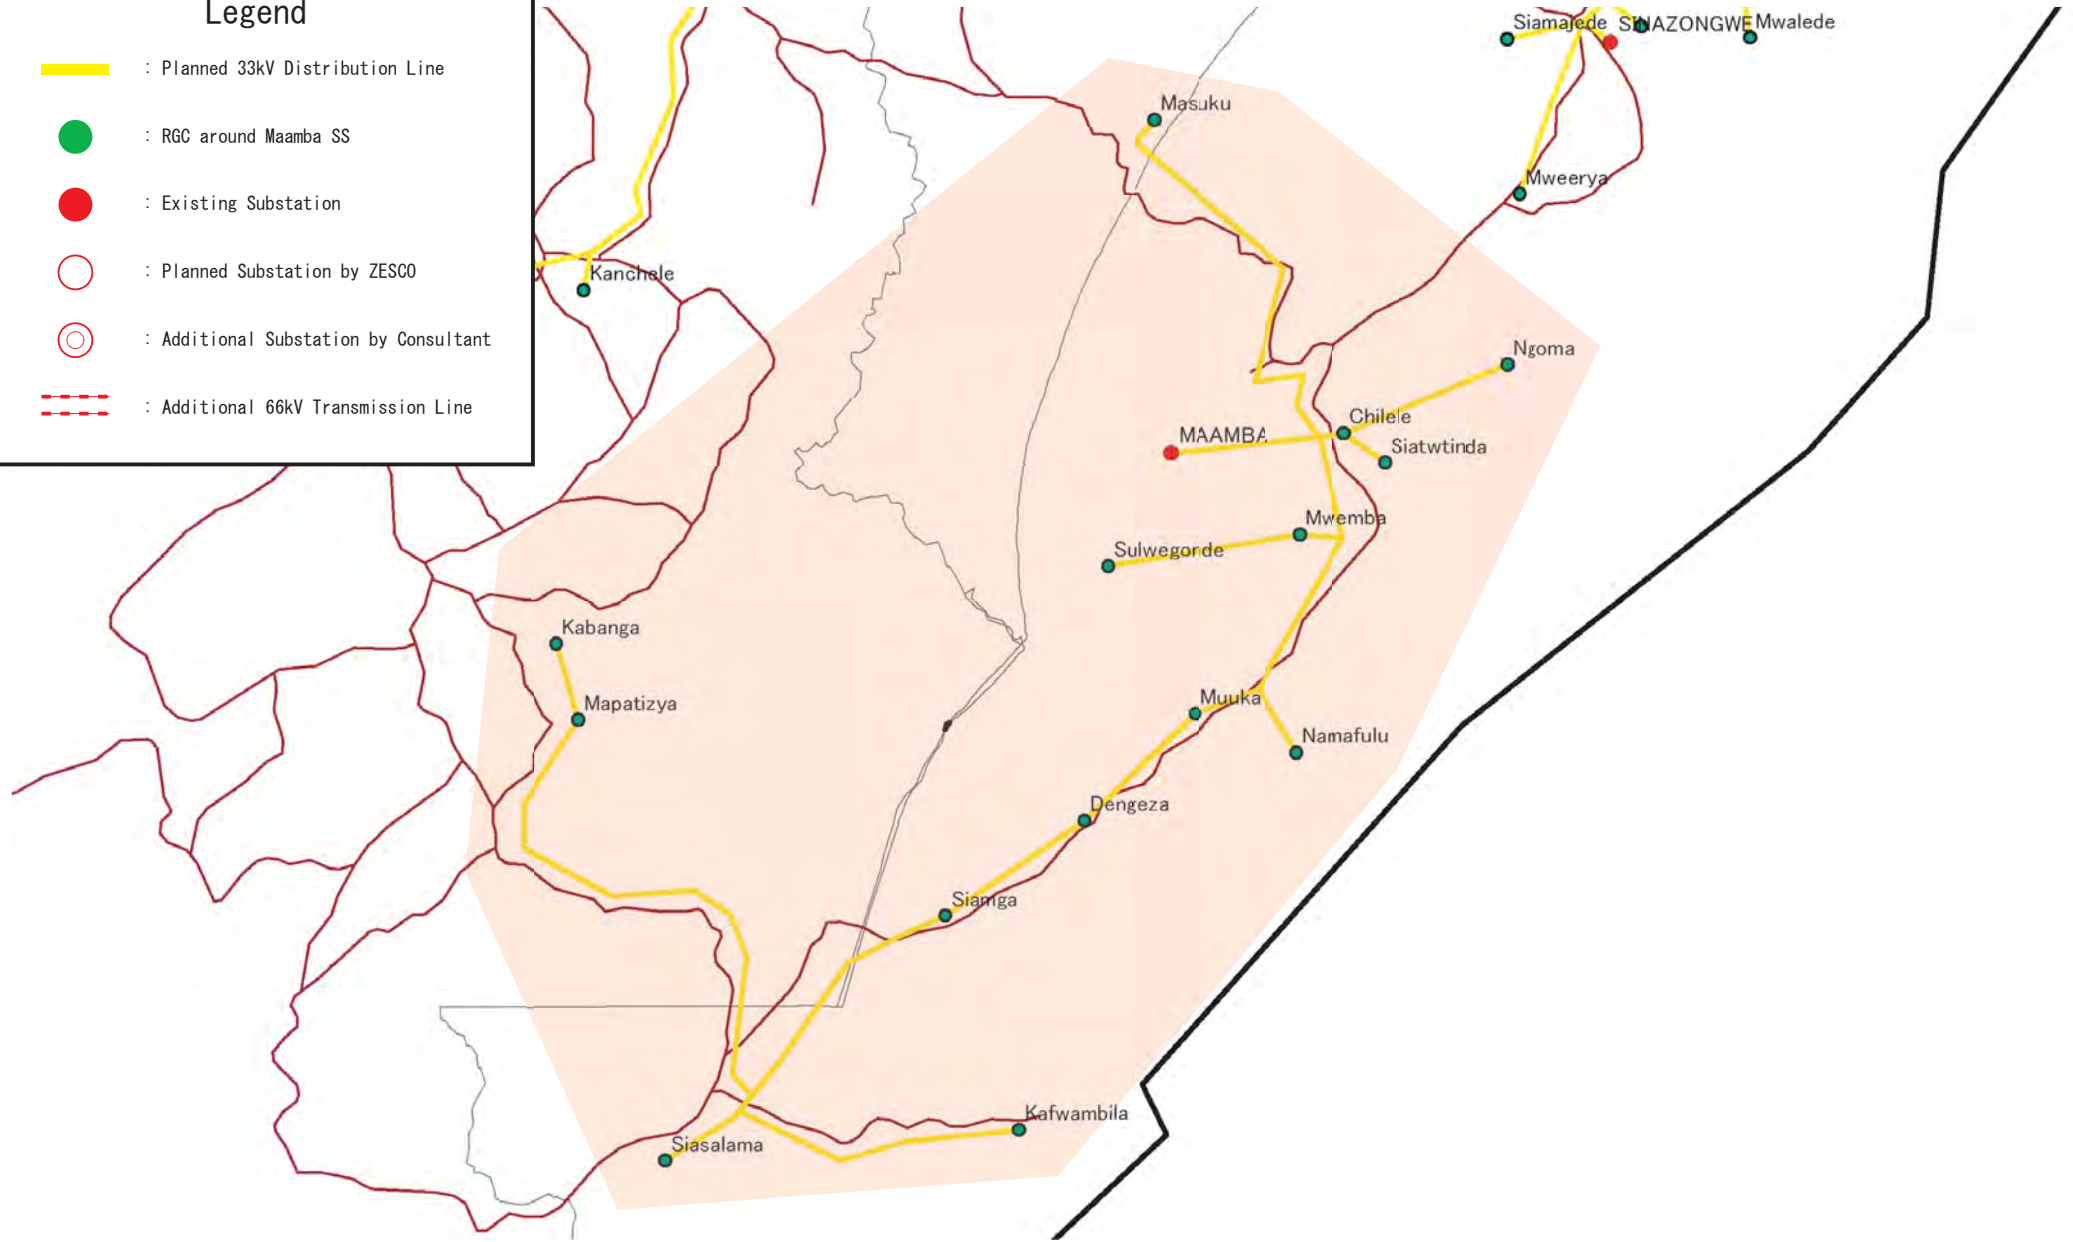

The Study for Development of
the Rural Electrification Master Plan in Zambia




Tokyo Electric Power Company

Drawing No.

Title

DL System at Maamba SS

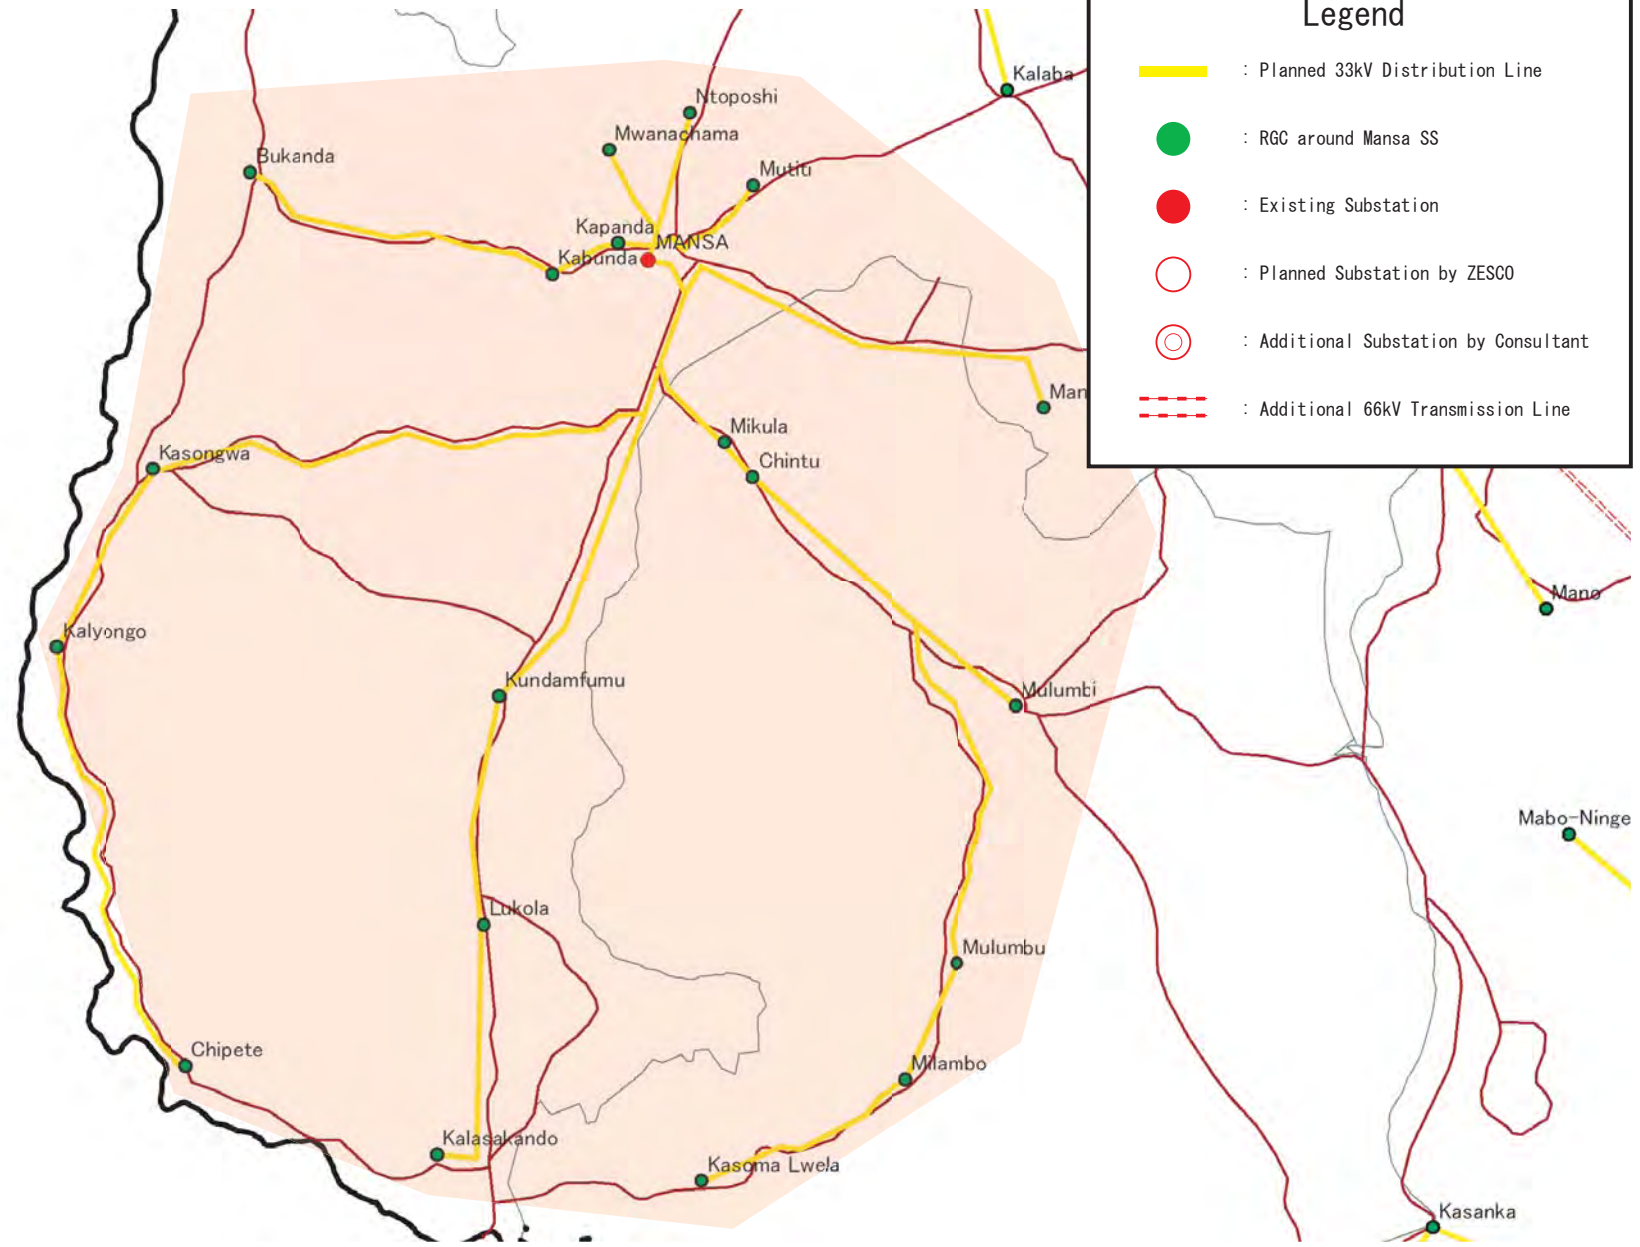

Legend

- : Planned 33kV Distribution Line
- : RGC around Mansa SS
- : Existing Substation
- : Planned Substation by ZESCO
- : Additional Substation by Consultant
- : Additional 66kV Transmission Line